


SHEET NO:1


PLAN SHOWING THE PROPOSED CONSTRUCTION OF R.C.C.ROOF RESIDENTIAL BUILDING IN

PATTA NO :1139 AT SANJEEVE NAGAR ,PLOT NO:2,UDR.S.NO: 31/5 ,R.S.NO: 31/1C ,MADURAI NORTH TALUK

,MELAPANANGADI VILLAGE ,PETCHIKULAM PANCHAYAT,MADURAI DISTRICT.

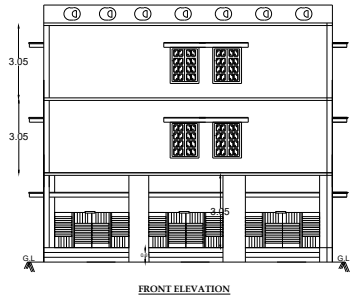


FRONT ELEVATION

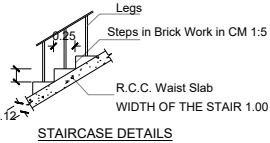


STAIRCASE DETAILS


WATER\_TANK\_CAPACITY\_L=5000LTRS

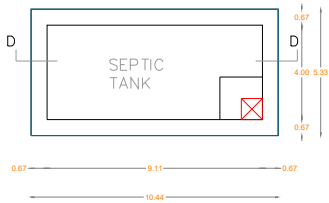


PLAN OF SEPTIC TANK  
SCALE 1"=2'0"

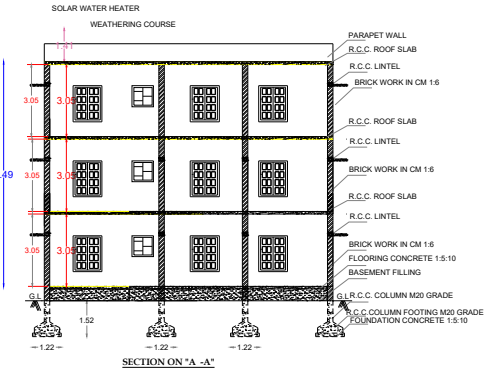


SECTION ON "A-A"

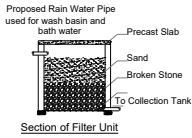


Section of Filter Unit

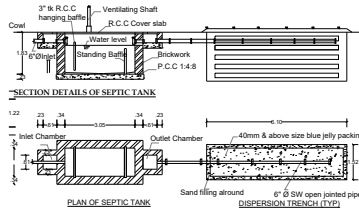


DETAILS OF SEPTIC TANK & DISPERSION TRENCH

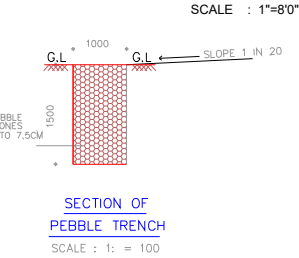


SECTION OF  
PEBBLE TRENCH  
SCALE : 1: = 100

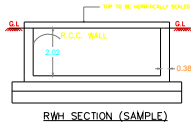

RWH\_CAPACITY\_L = 2000LTRS

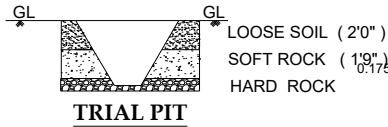

TRIAL PIT

 

SOLAR WATER HEATER  
(NOT TO SCALE)

DTCP APPROVAL NO:  
3165/2023/THI5  
11/10/2023

NO.OF TWO WHEELER PARKING PROVIDED: 1NO  
FSI = TOTAL BUILDUP AREA AS PER FSI RULES  
SITE AREA  
446.52/ 232.34 = 1.92>2

REFERENCE :-

- SITE BOUNDARY
- PROPOSED BUILDING
- ROAD

SCALE:-


PLAN,SECTION & ELEVATION 1" = 1:100  
SITE PLAN 1" = 1:200

| AREA DETAILS                  | SQ.FT     | SQ.MT    |
|-------------------------------|-----------|----------|
| AREA OF THE SITE              | - 2500.00 | - 232.26 |
| AREA OF THE PRO. GROUND FLOOR | - 1601.52 | - 148.84 |
| AREA OF THE PRO. FIRST FLOOR  | - 1601.52 | - 148.84 |
| AREA OF THE PRO. AECOND FLOOR | - 1601.52 | - 148.84 |
| NET OPEN SPACE                | - 898.48  | - 83.50  |

Mr.R.RAMASUNDARAM  
W/O Mr.RAMASAMY  
APPLICANT

KEY PLAN  
NON SCHEME AREA

SITE PLAN

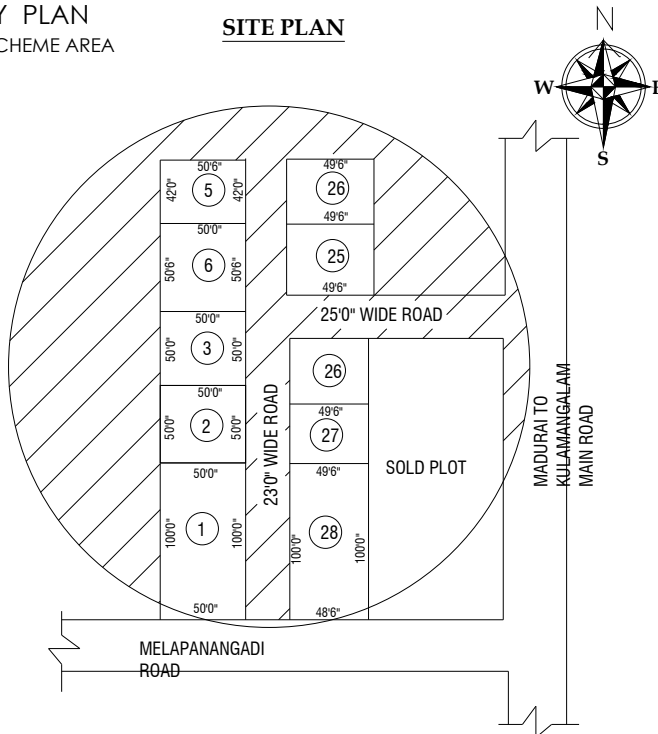


JOINERY DETAILS:-


|                    |               |               |
|--------------------|---------------|---------------|
| ED - ENTRANCE DOOR | - 1.52 x 2.13 | - 5'-0"x7'-0" |
| D - DOOR           | - 0.91x 2.13  | - 3'-0"x7'-0" |
| D1 - DOOR          | - 0.76 x 2.13 | - 2'-6"x7'-0" |
| O - OPEN           | - 0.91 x 2.13 | - 3'-0"x7'-0" |
| W - WINDOW         | - 1.22 x 1.52 | - 4'-0"x5'-0" |
| KW - WINDOW        | - 1.22 x 0.76 | - 4'-0"x2'-6" |
| V VENTILATOR       | - 0.91 x 0.61 | - 3'-0"x2'-0" |

வ.க.செகர்  
தலைவர்  
பேச்சிதளம் ஊராட்சி  
மதுரை மேற்கு ஒன்றியம்


Er.V.GUNA SEKAR M.E STRUCTURAL  
REGISTERED STRUCTURAL ENGINEER GRADE -TWO  
ETERNAL DESIGN AND CONSTRUCTION  
NO.65, NORTH STREET , FIRST FLOOR  
UNION OFFICE ROAD, ALANGANALLUR  
MADURAI ., PH.NO: 90924 37594  
LICENSED ENGINEER

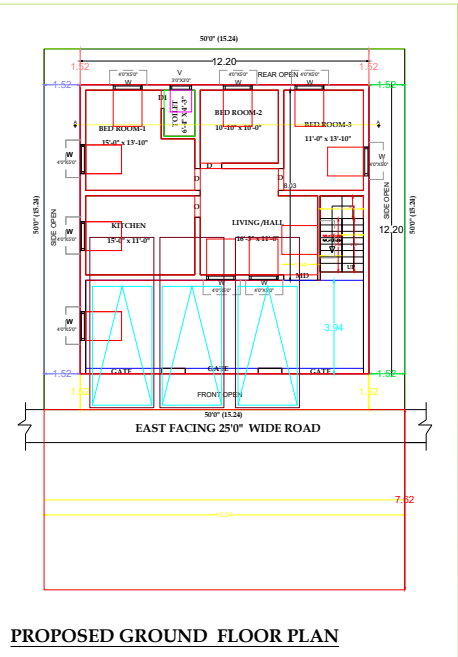

PROPOSED GROUND FLOOR PLAN

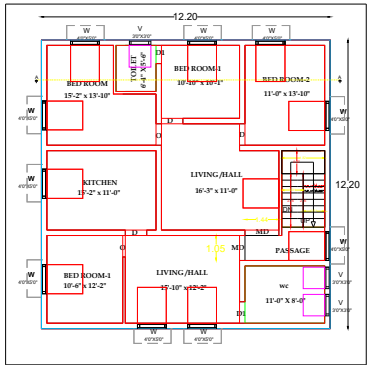

PROPOSED FIRST FLOOR

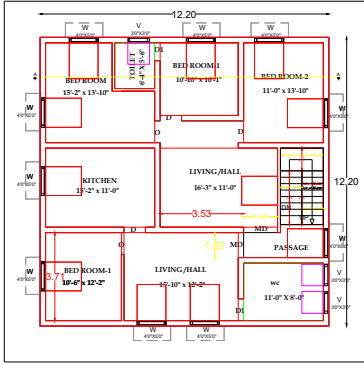

PROPOSED SECOND FLOOR