



PLAN SHOWING THE PROPOSED CONSTRUCTION OF R.C.C TERRACED GROUND FLOOR COMMERCIAL HALL BUILDING IN R.S NOS:101/13A, 101/13B, 101/13C,101/13D AT THIRUMARUGAL VILLAGE AND PANCHAYAT, NAGAPATTINAM TALUK, NAGAPATTINAM DISTRICT.



NAME OF THE OWNER:Mrs.S.RAGAVAISHNAVI,
D/O:SANTHOSH

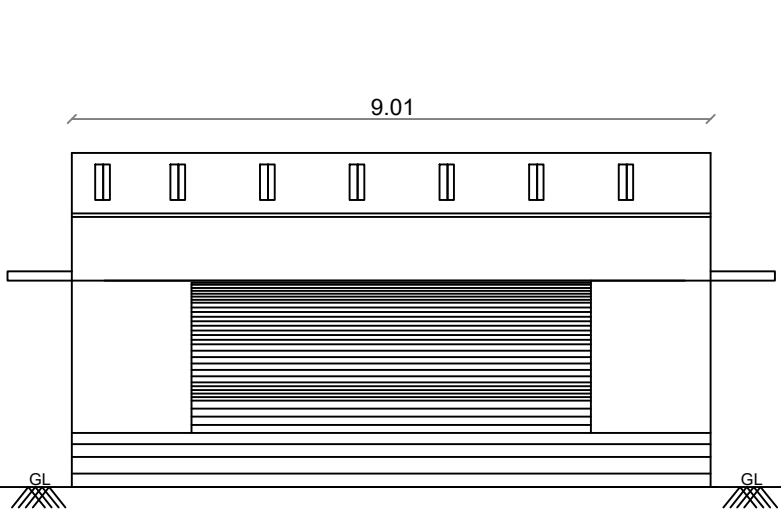


ELEVATION

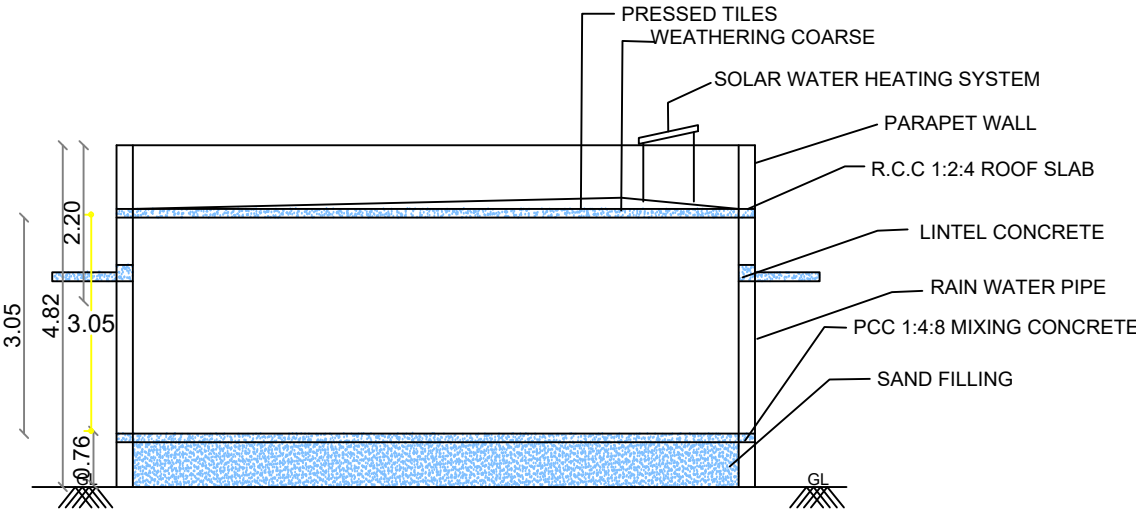


SECTIONON AB

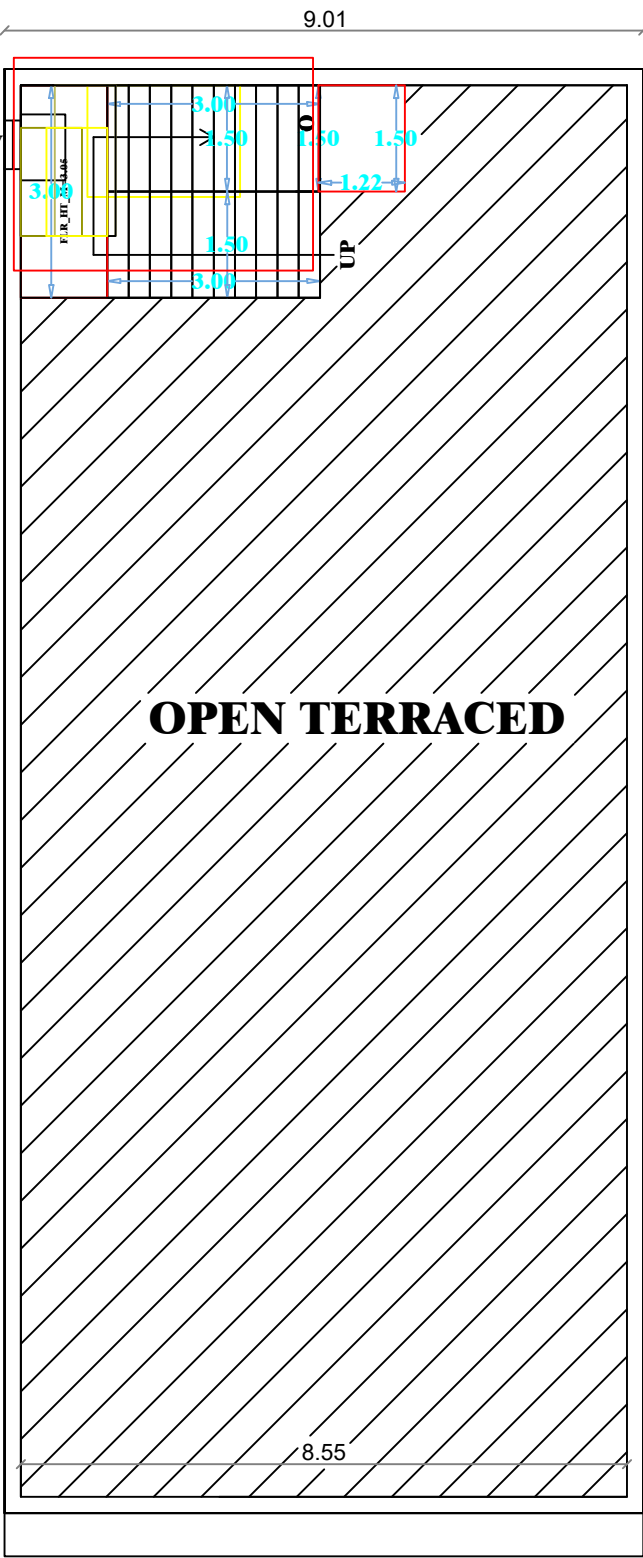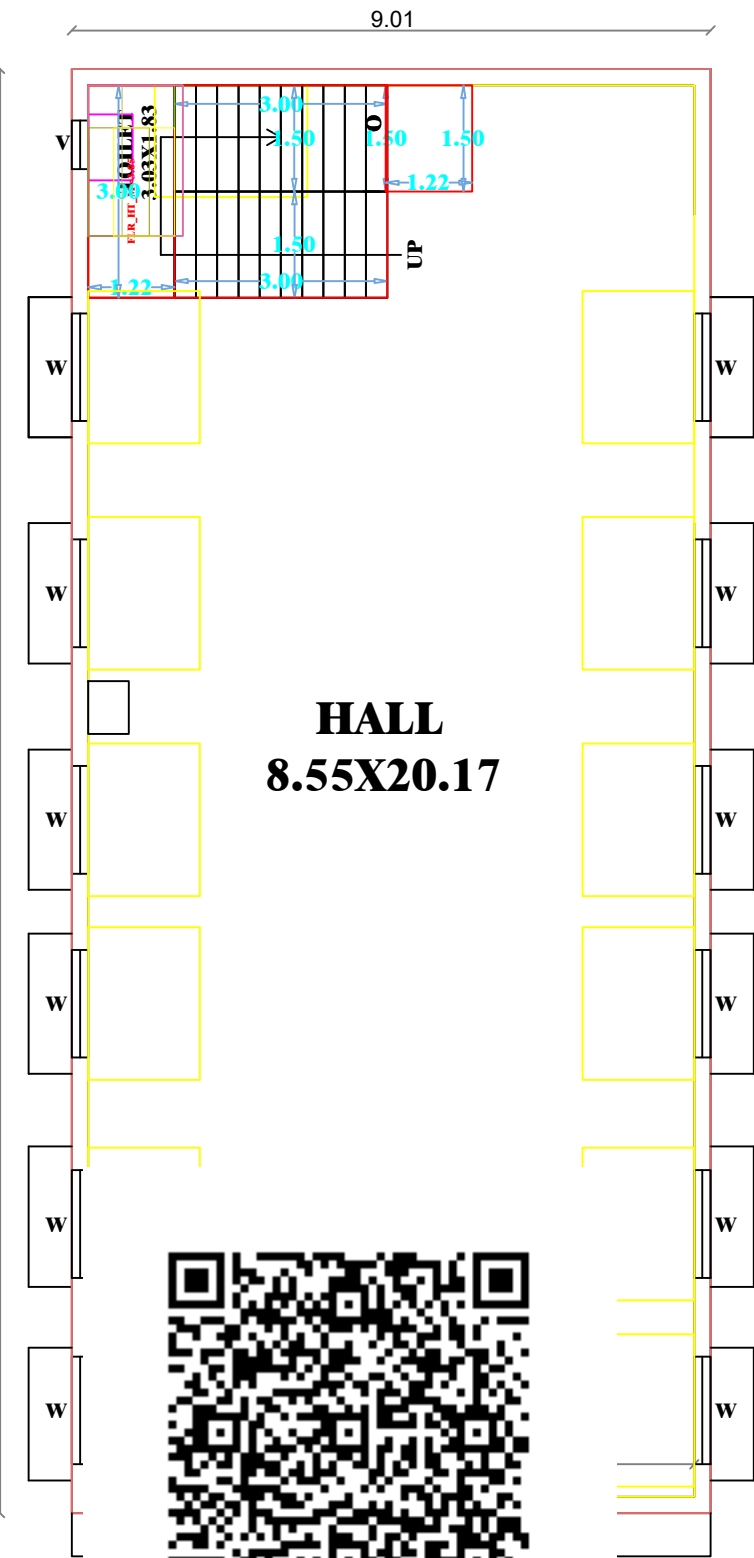


OPEN TERRACED FLOOR PLAN

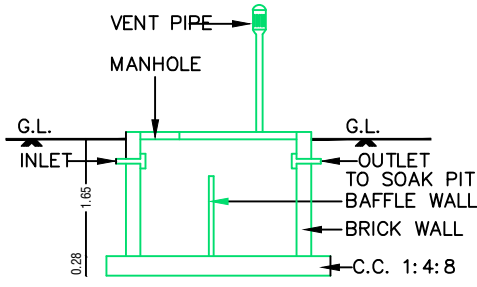

SECTION OF SEP.TANK

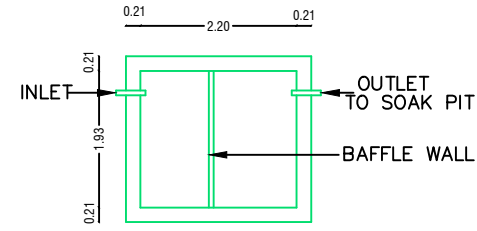


PLAN SEPTIC. TANK

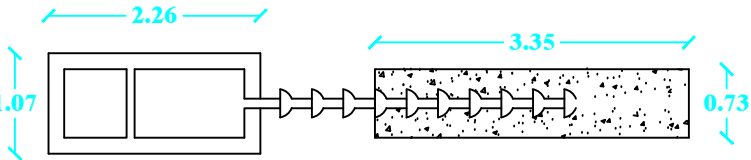


PLAN OF SEPTIC TANK

SCALE 1:100

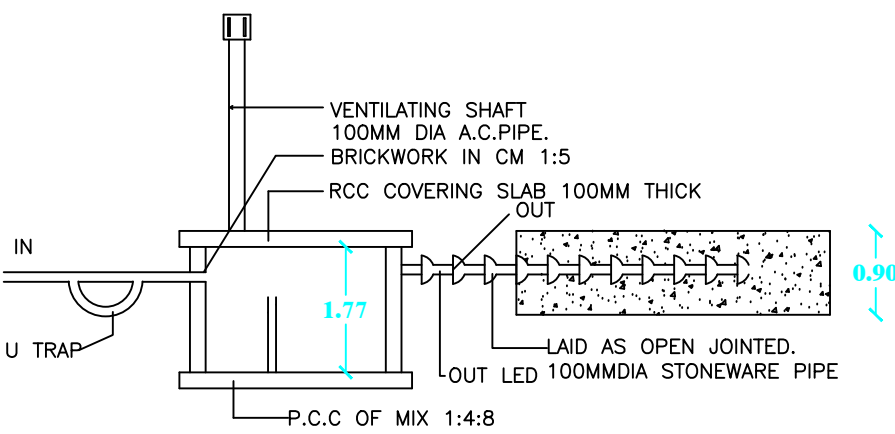

SECTION OF SEPTIC TANK

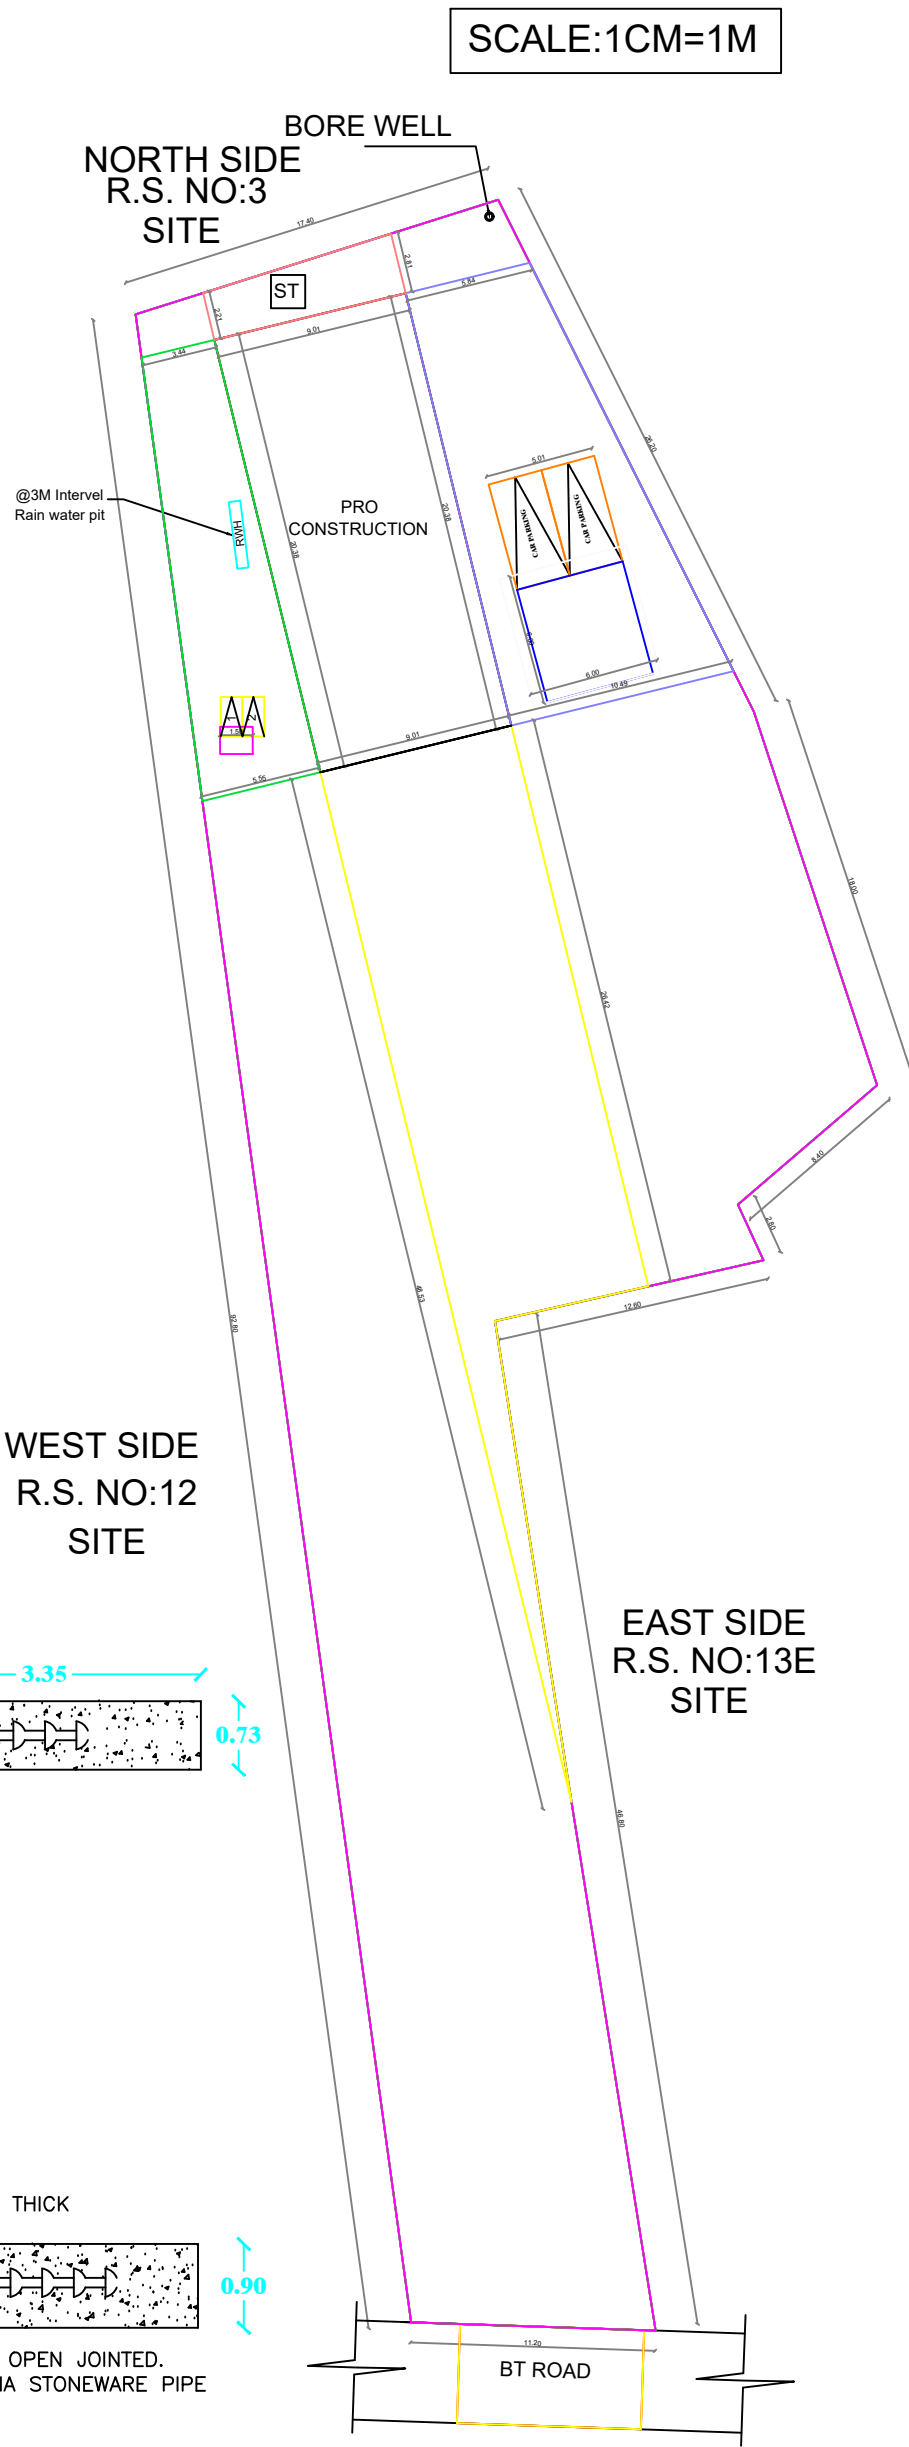

AREA DETAILS	IN SQ. FT.	IN SQ. M.
Area of the Site	17216	1600.00
PRO.RCC ROOF GROUND FLOOR BUILDING		
Ground Floor Plinth Area	1976	183.64
OPEN SPACE	15240	1416.36
TOILET-1 NO, BOREWELL- 1 NO.		
CAR PARKING -2NOS,TWO WHEELER -2NOS.		
JOINERY DETAILS		
DESCRIPTION	IN FEET	IN METER
ROLLING SHUTTER	11' 0" X 7' 0"	3.35 X 2.13
DOOR	3' 0" X 7' 0"	0.91 X 2.13
DOOR 1	2' 6" X 7' 0"	0.76 X 2.13
WINDOW	4' 0" X 4' 0"	1.22 X 1.22
VENTILATOR	2' 0" X 2' 0"	0.61 X 0.61
CERTIFICATE		
1.WAST WATER WILL BE USED FOR GARDEN PURPOSE IN THE SAME SITE		
2. ALL HABITATION ROOMS ARE FITTED WITH 42" CEILLING FAN		
3. SOALR WATER HEATER SYSTEM SHOULD BE FITTED IN KITCHEN AND BATHROOM		
4.I SHALL NOT ALLOW SANITARY WORKERS TO ENTER INTO THE SEWERAGE SYSTEM/SEPTIC TANK		
COLOUR INDEX		
SITE BOUNDARY		
PROPOSED BUILDING		
EX.ROAD		
OWNER		
REGISTERED ENGINEER		