








PLAN SHOWING THE PROPOSED CONSTRUCTION OF R.C.C. ROOF GROUND FLOOR RESIDENTIAL BUILDING

IN S.F.NO:66/13B,PLOT NO:16,PATTA NO:7104,AT THURAIMANGALAM, PERIYAR NAGAR EAST,KAVULPALAYAM VILLAGE



& PANCHAYAT,PERAMBALUR TALUK & DISTRICT.

APPLICANT:- Mr.M.CHANDRASEKAR S/o. Mr.MUTHUSAMY

ALL DIMENSIONS ARE IN METRE

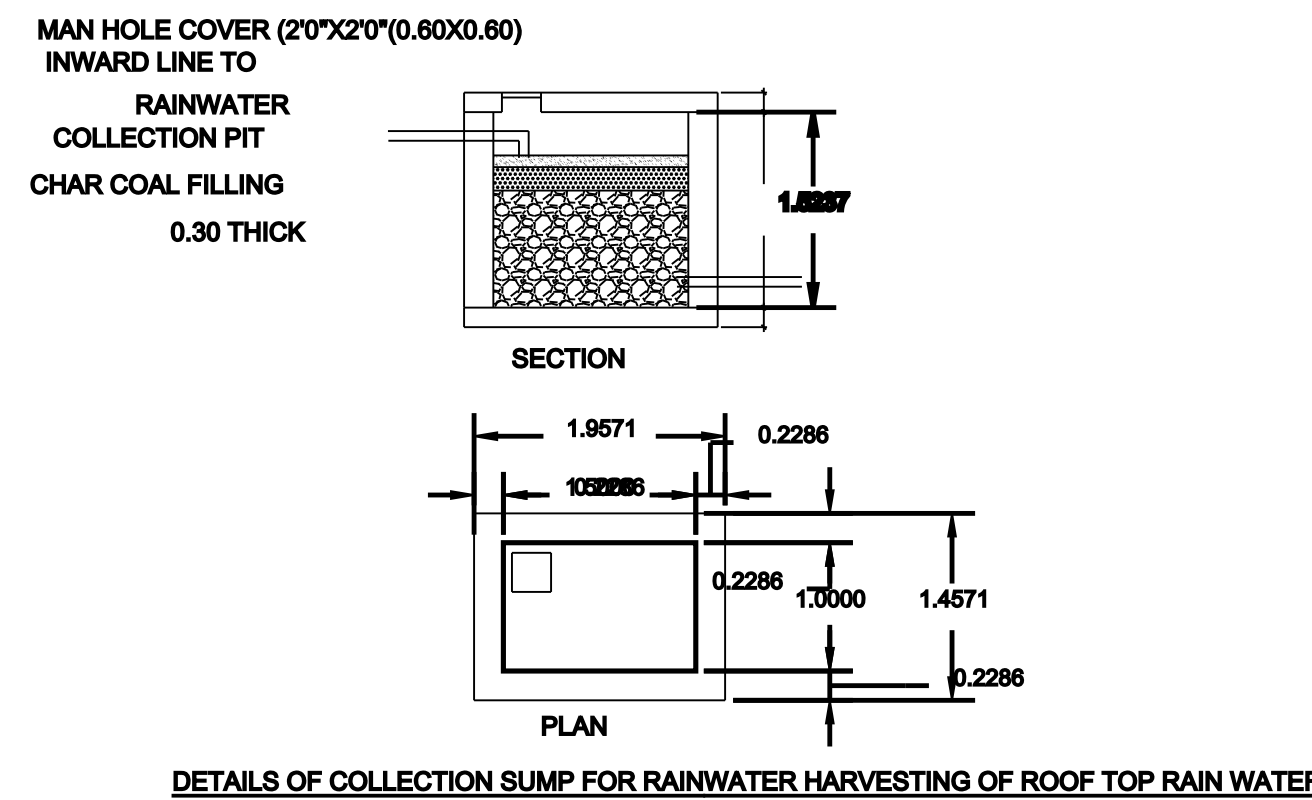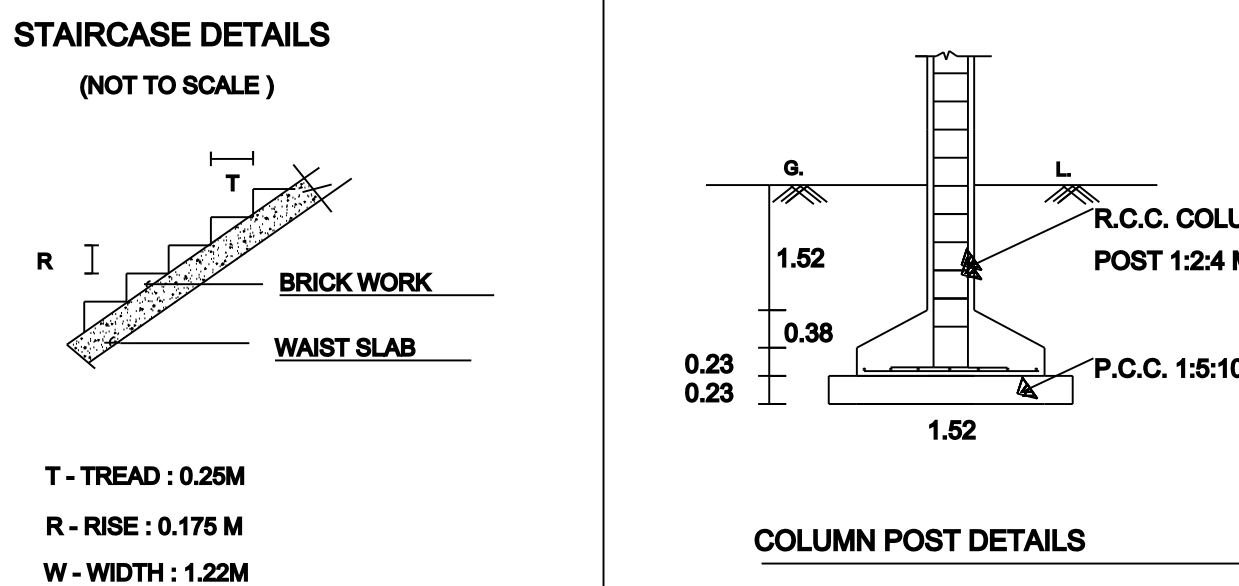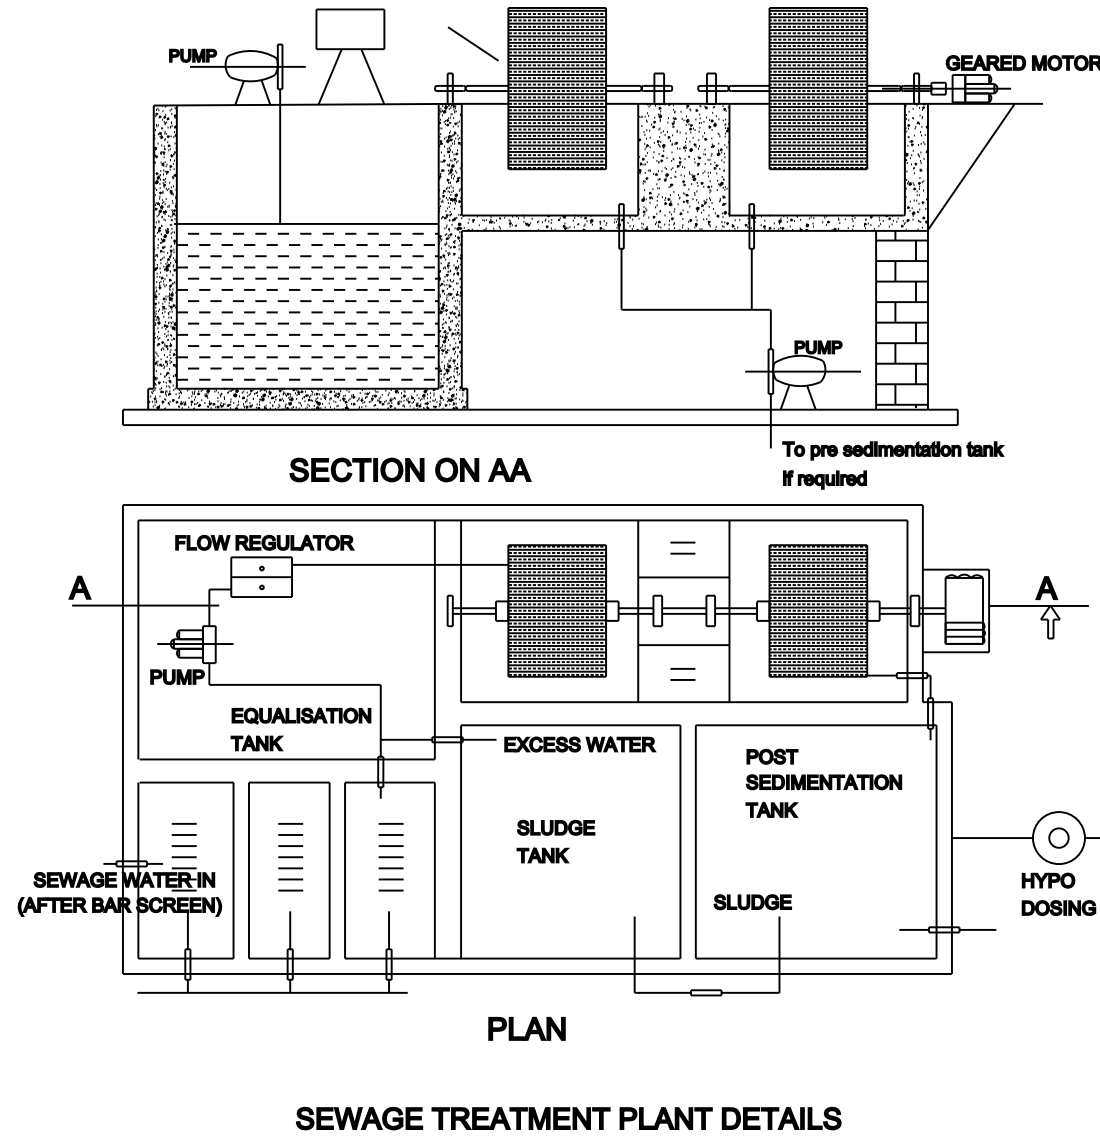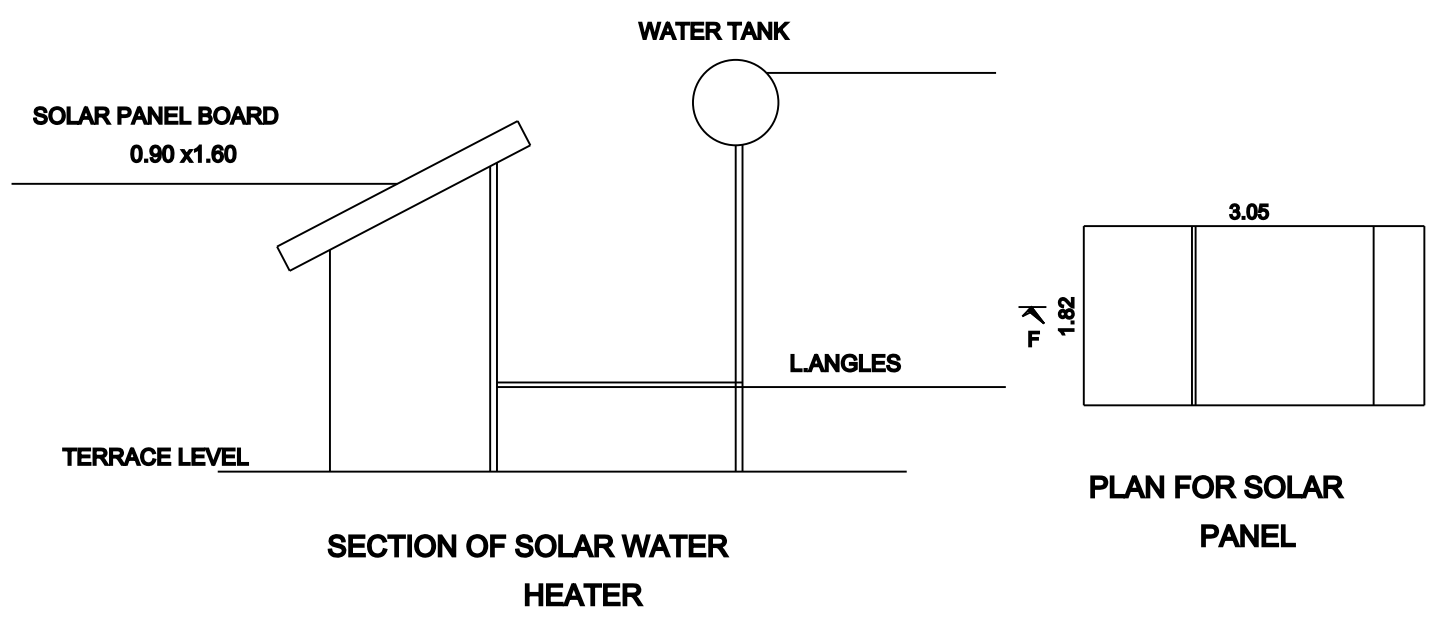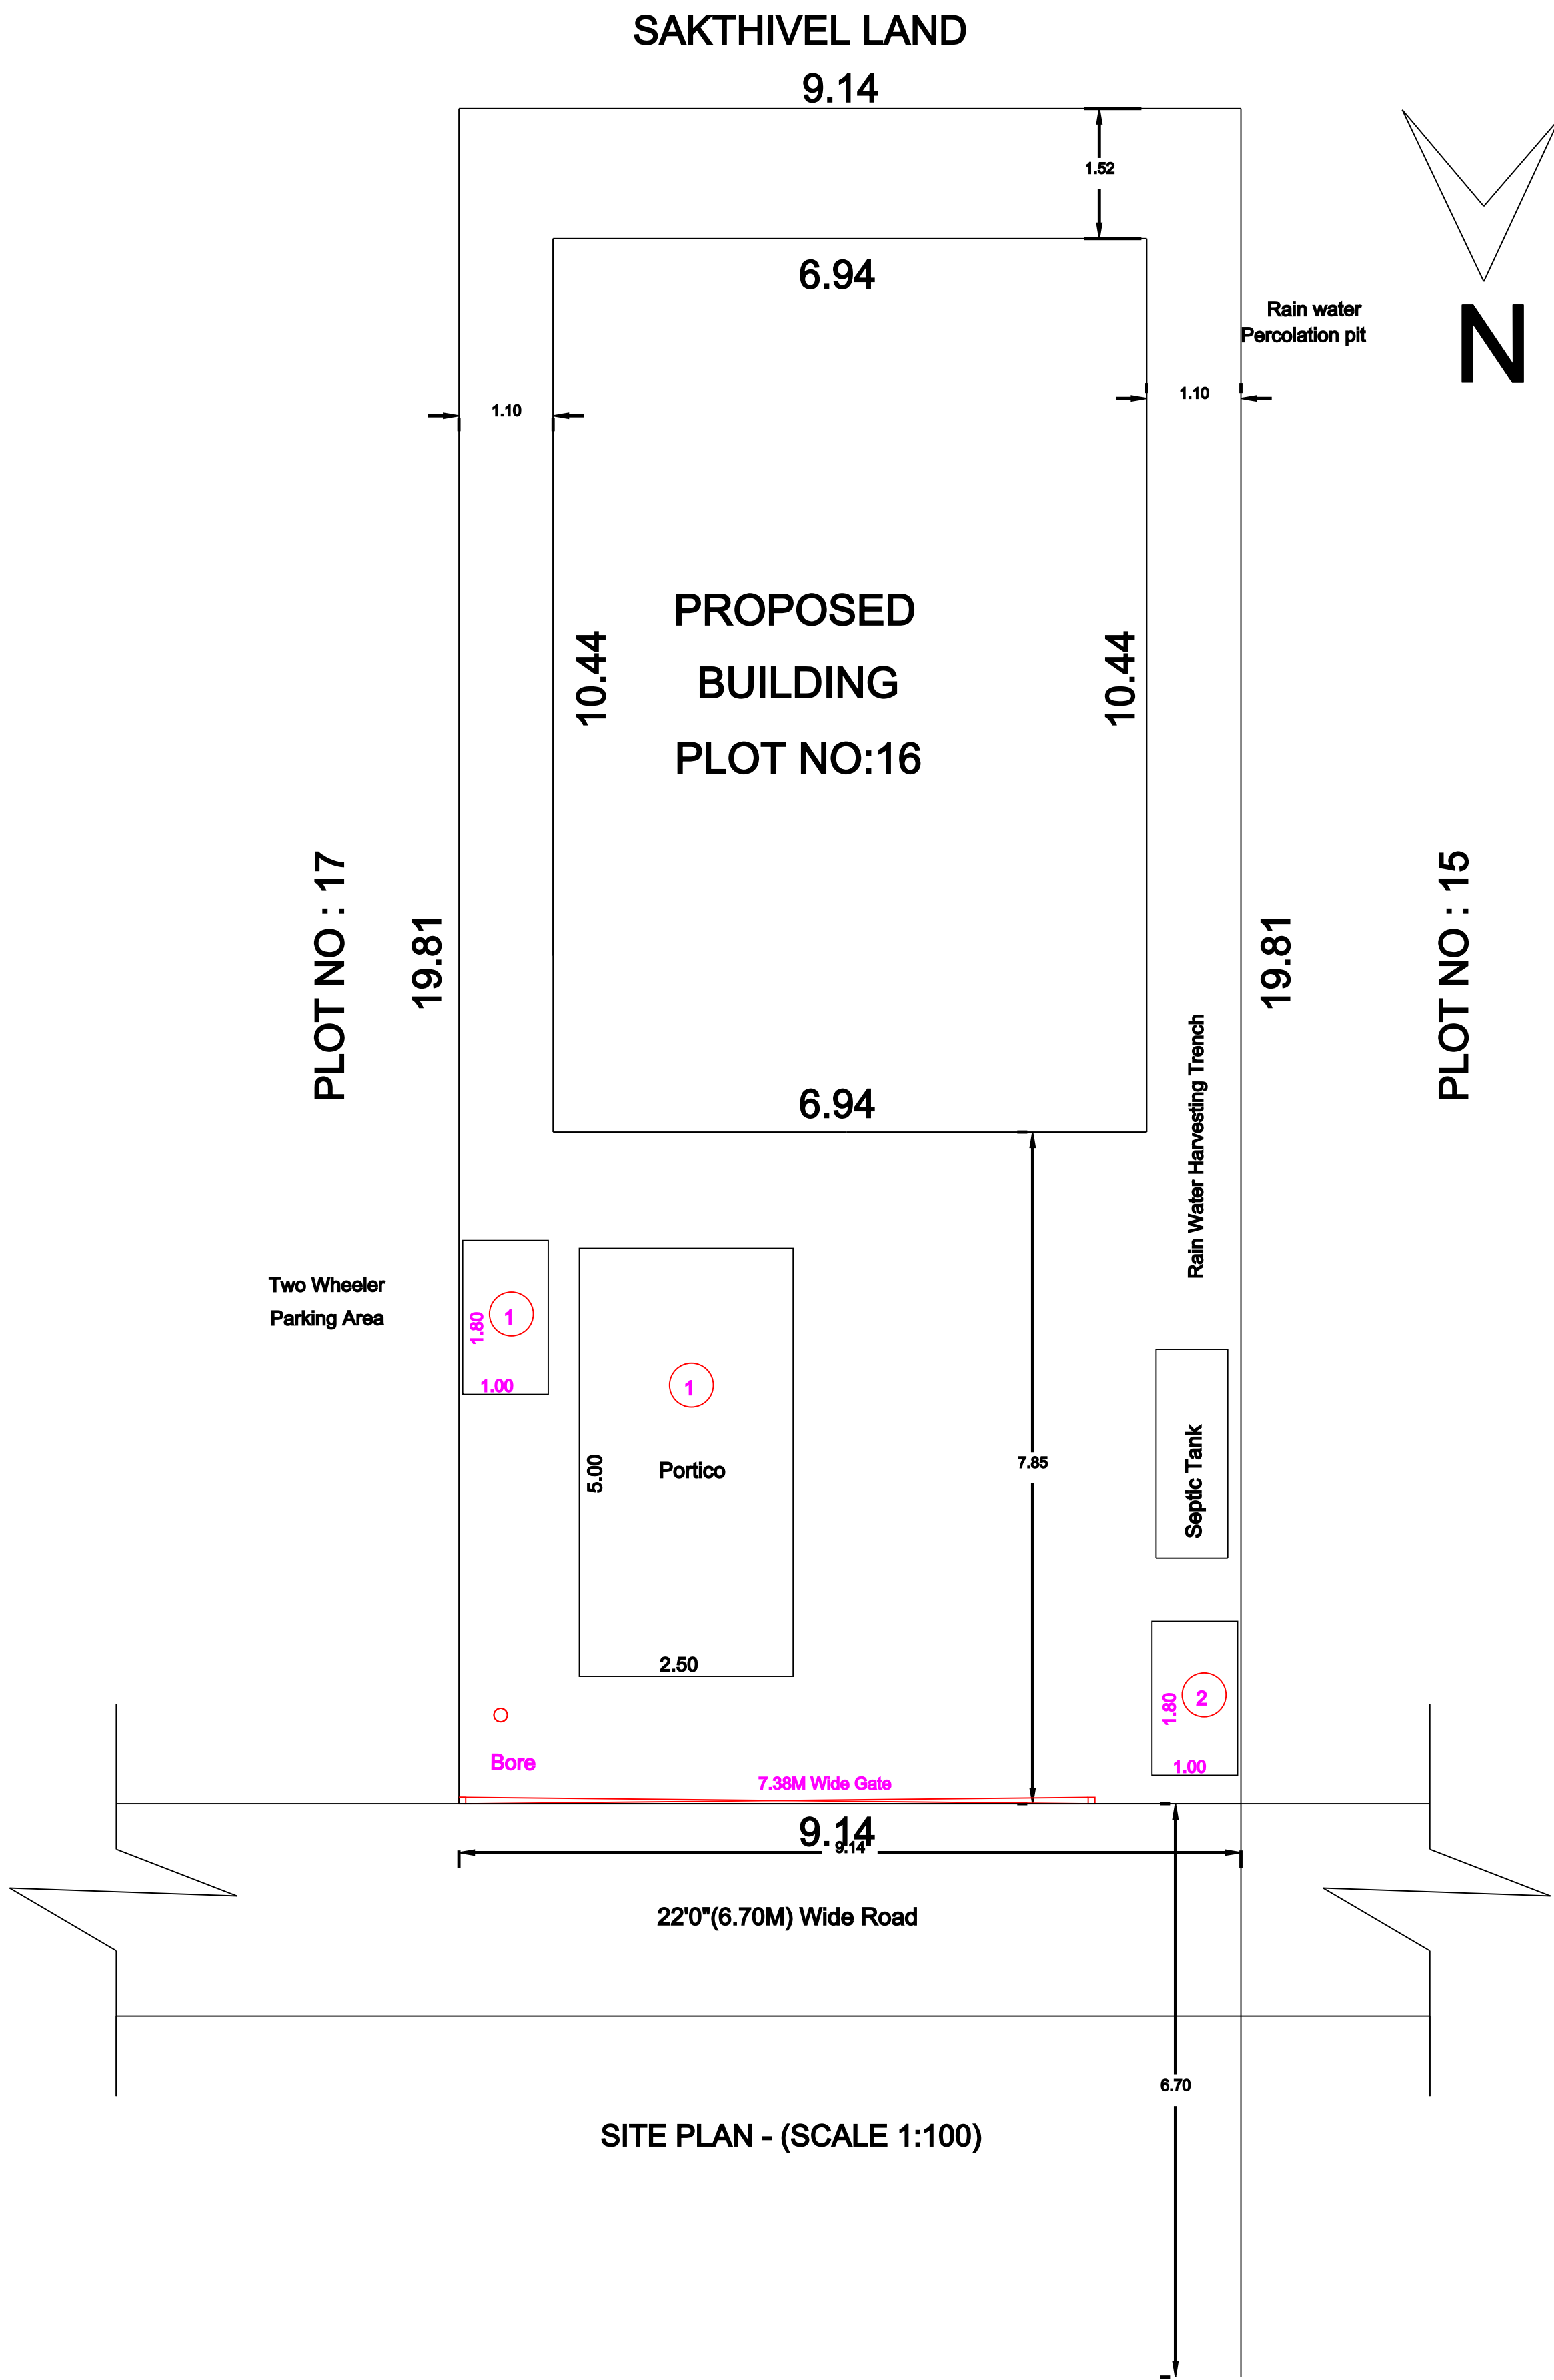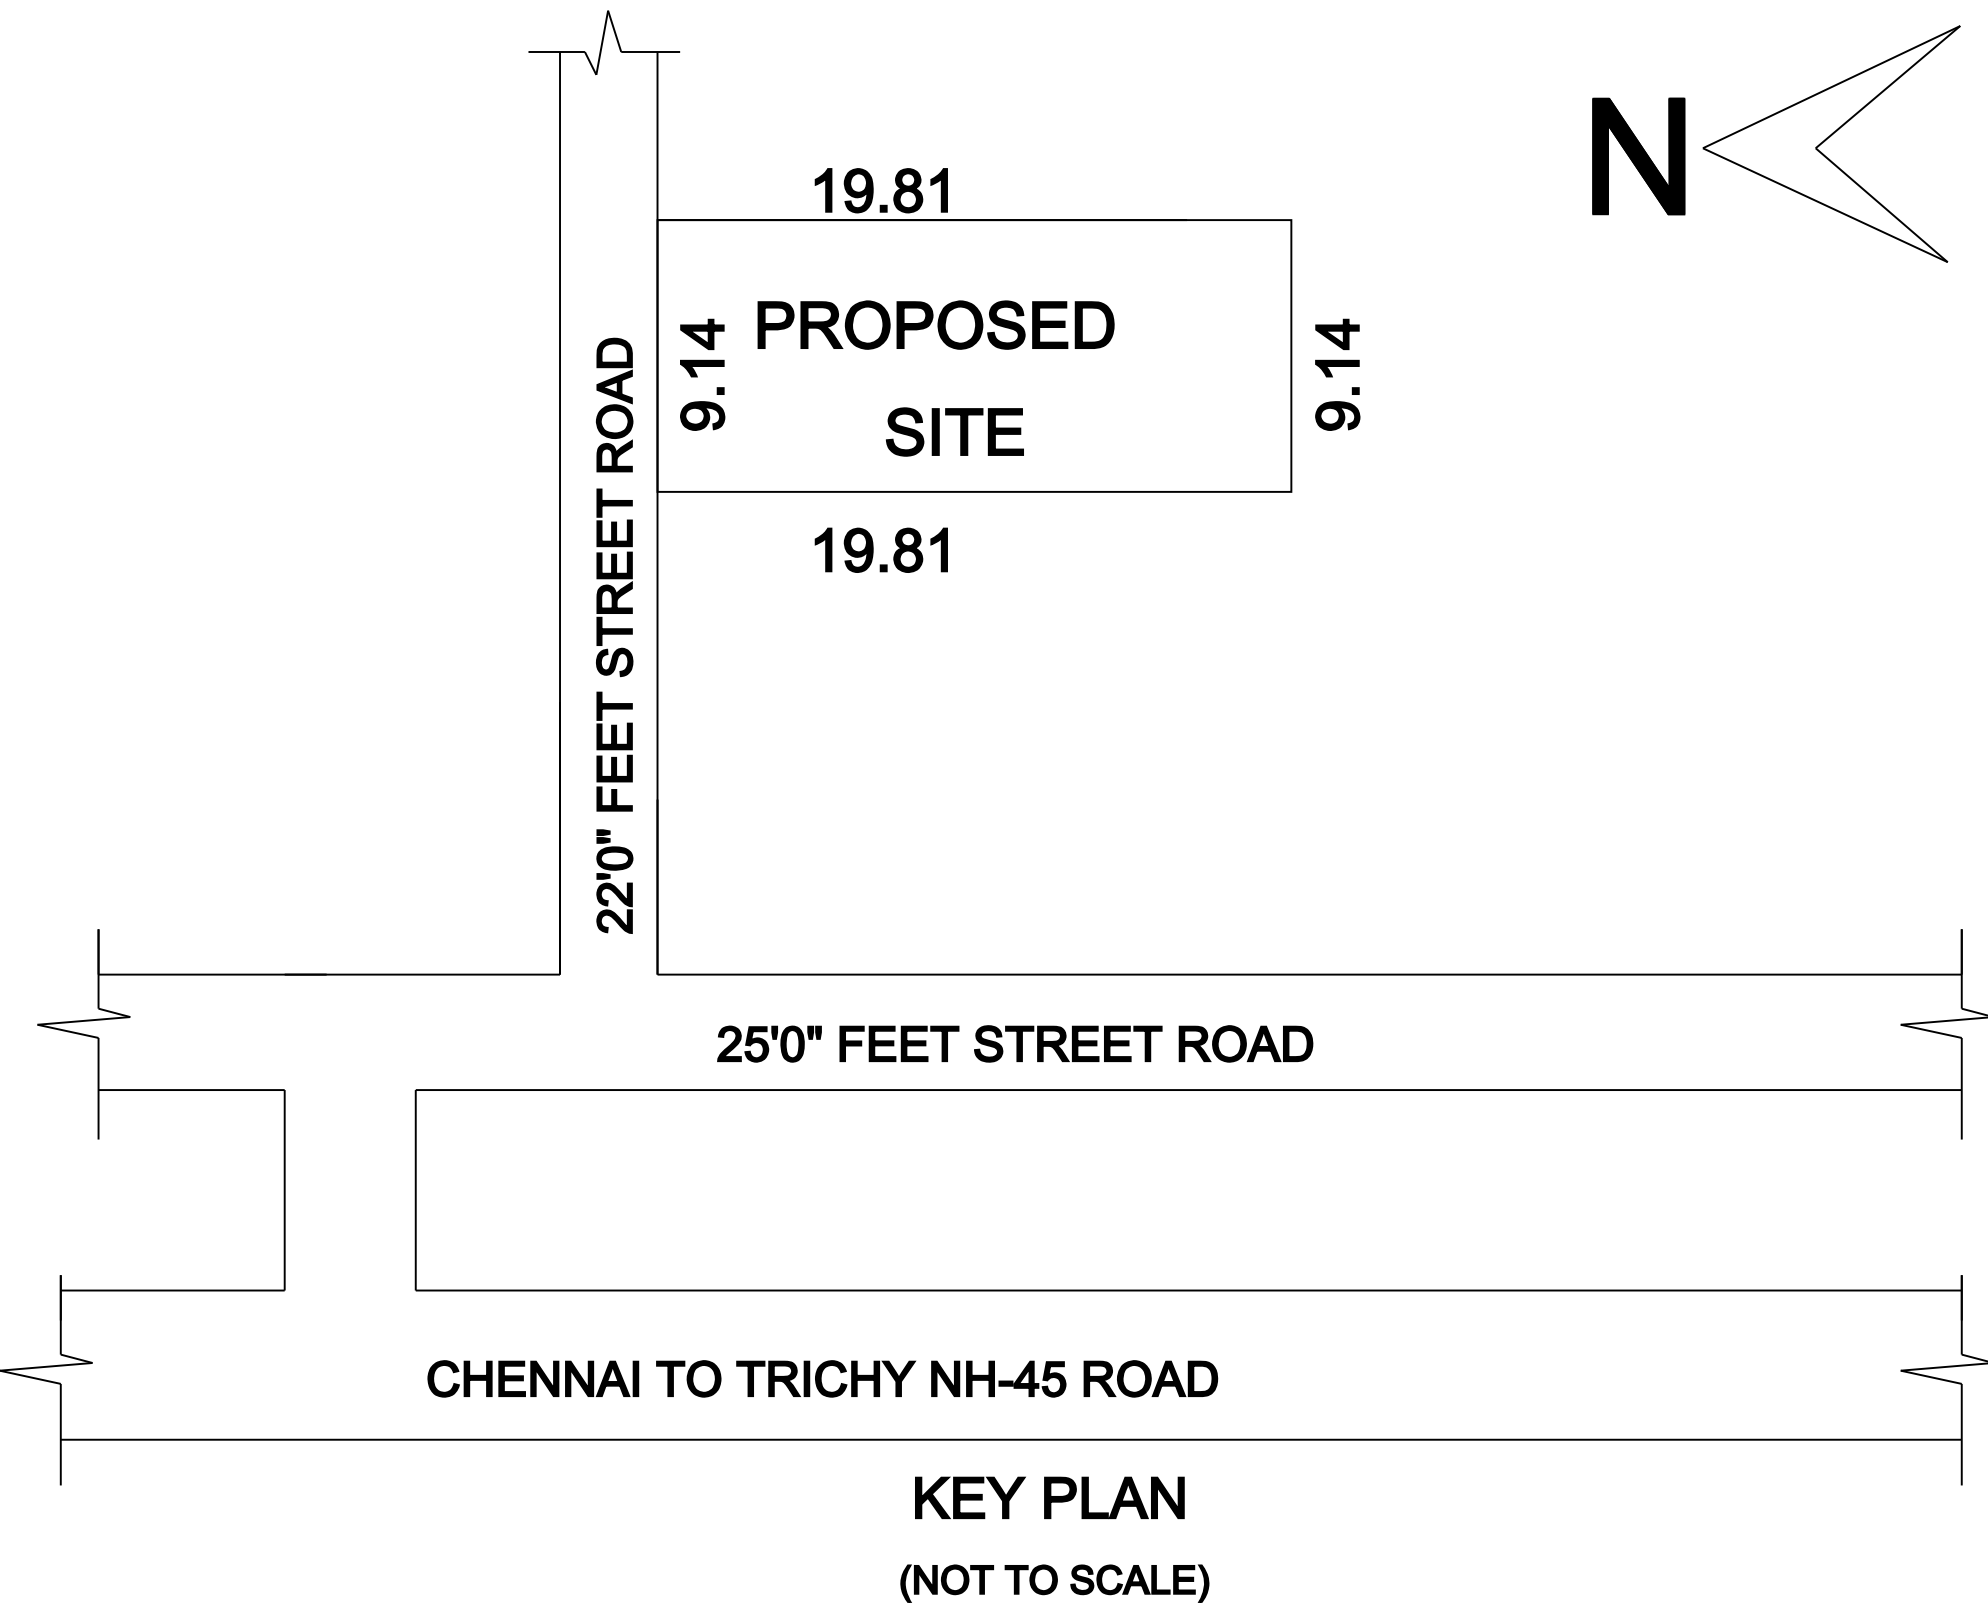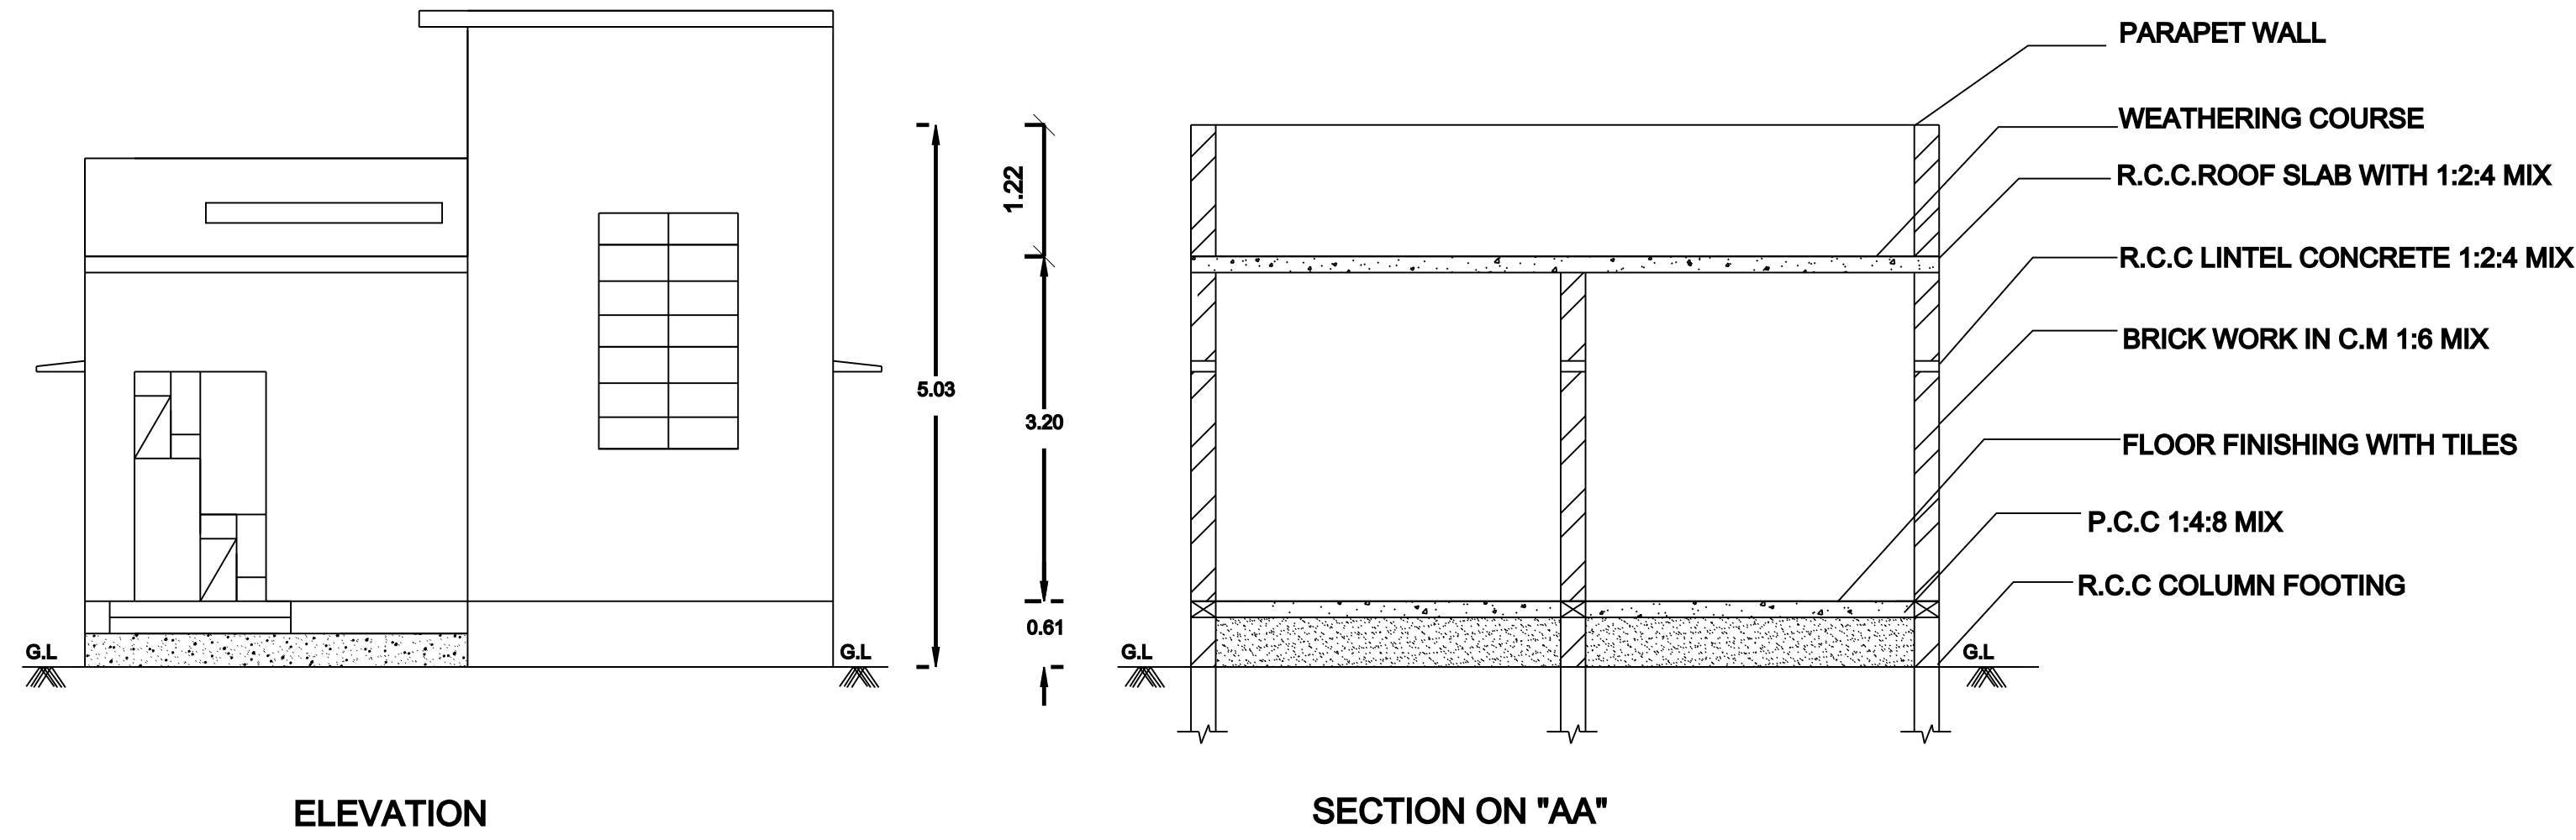

DETAILED DRAWING FOR SEPTIC TANK WITH DISPERSION TRENCH 225 GALLONS CAPACITY OF 1000 LITRES

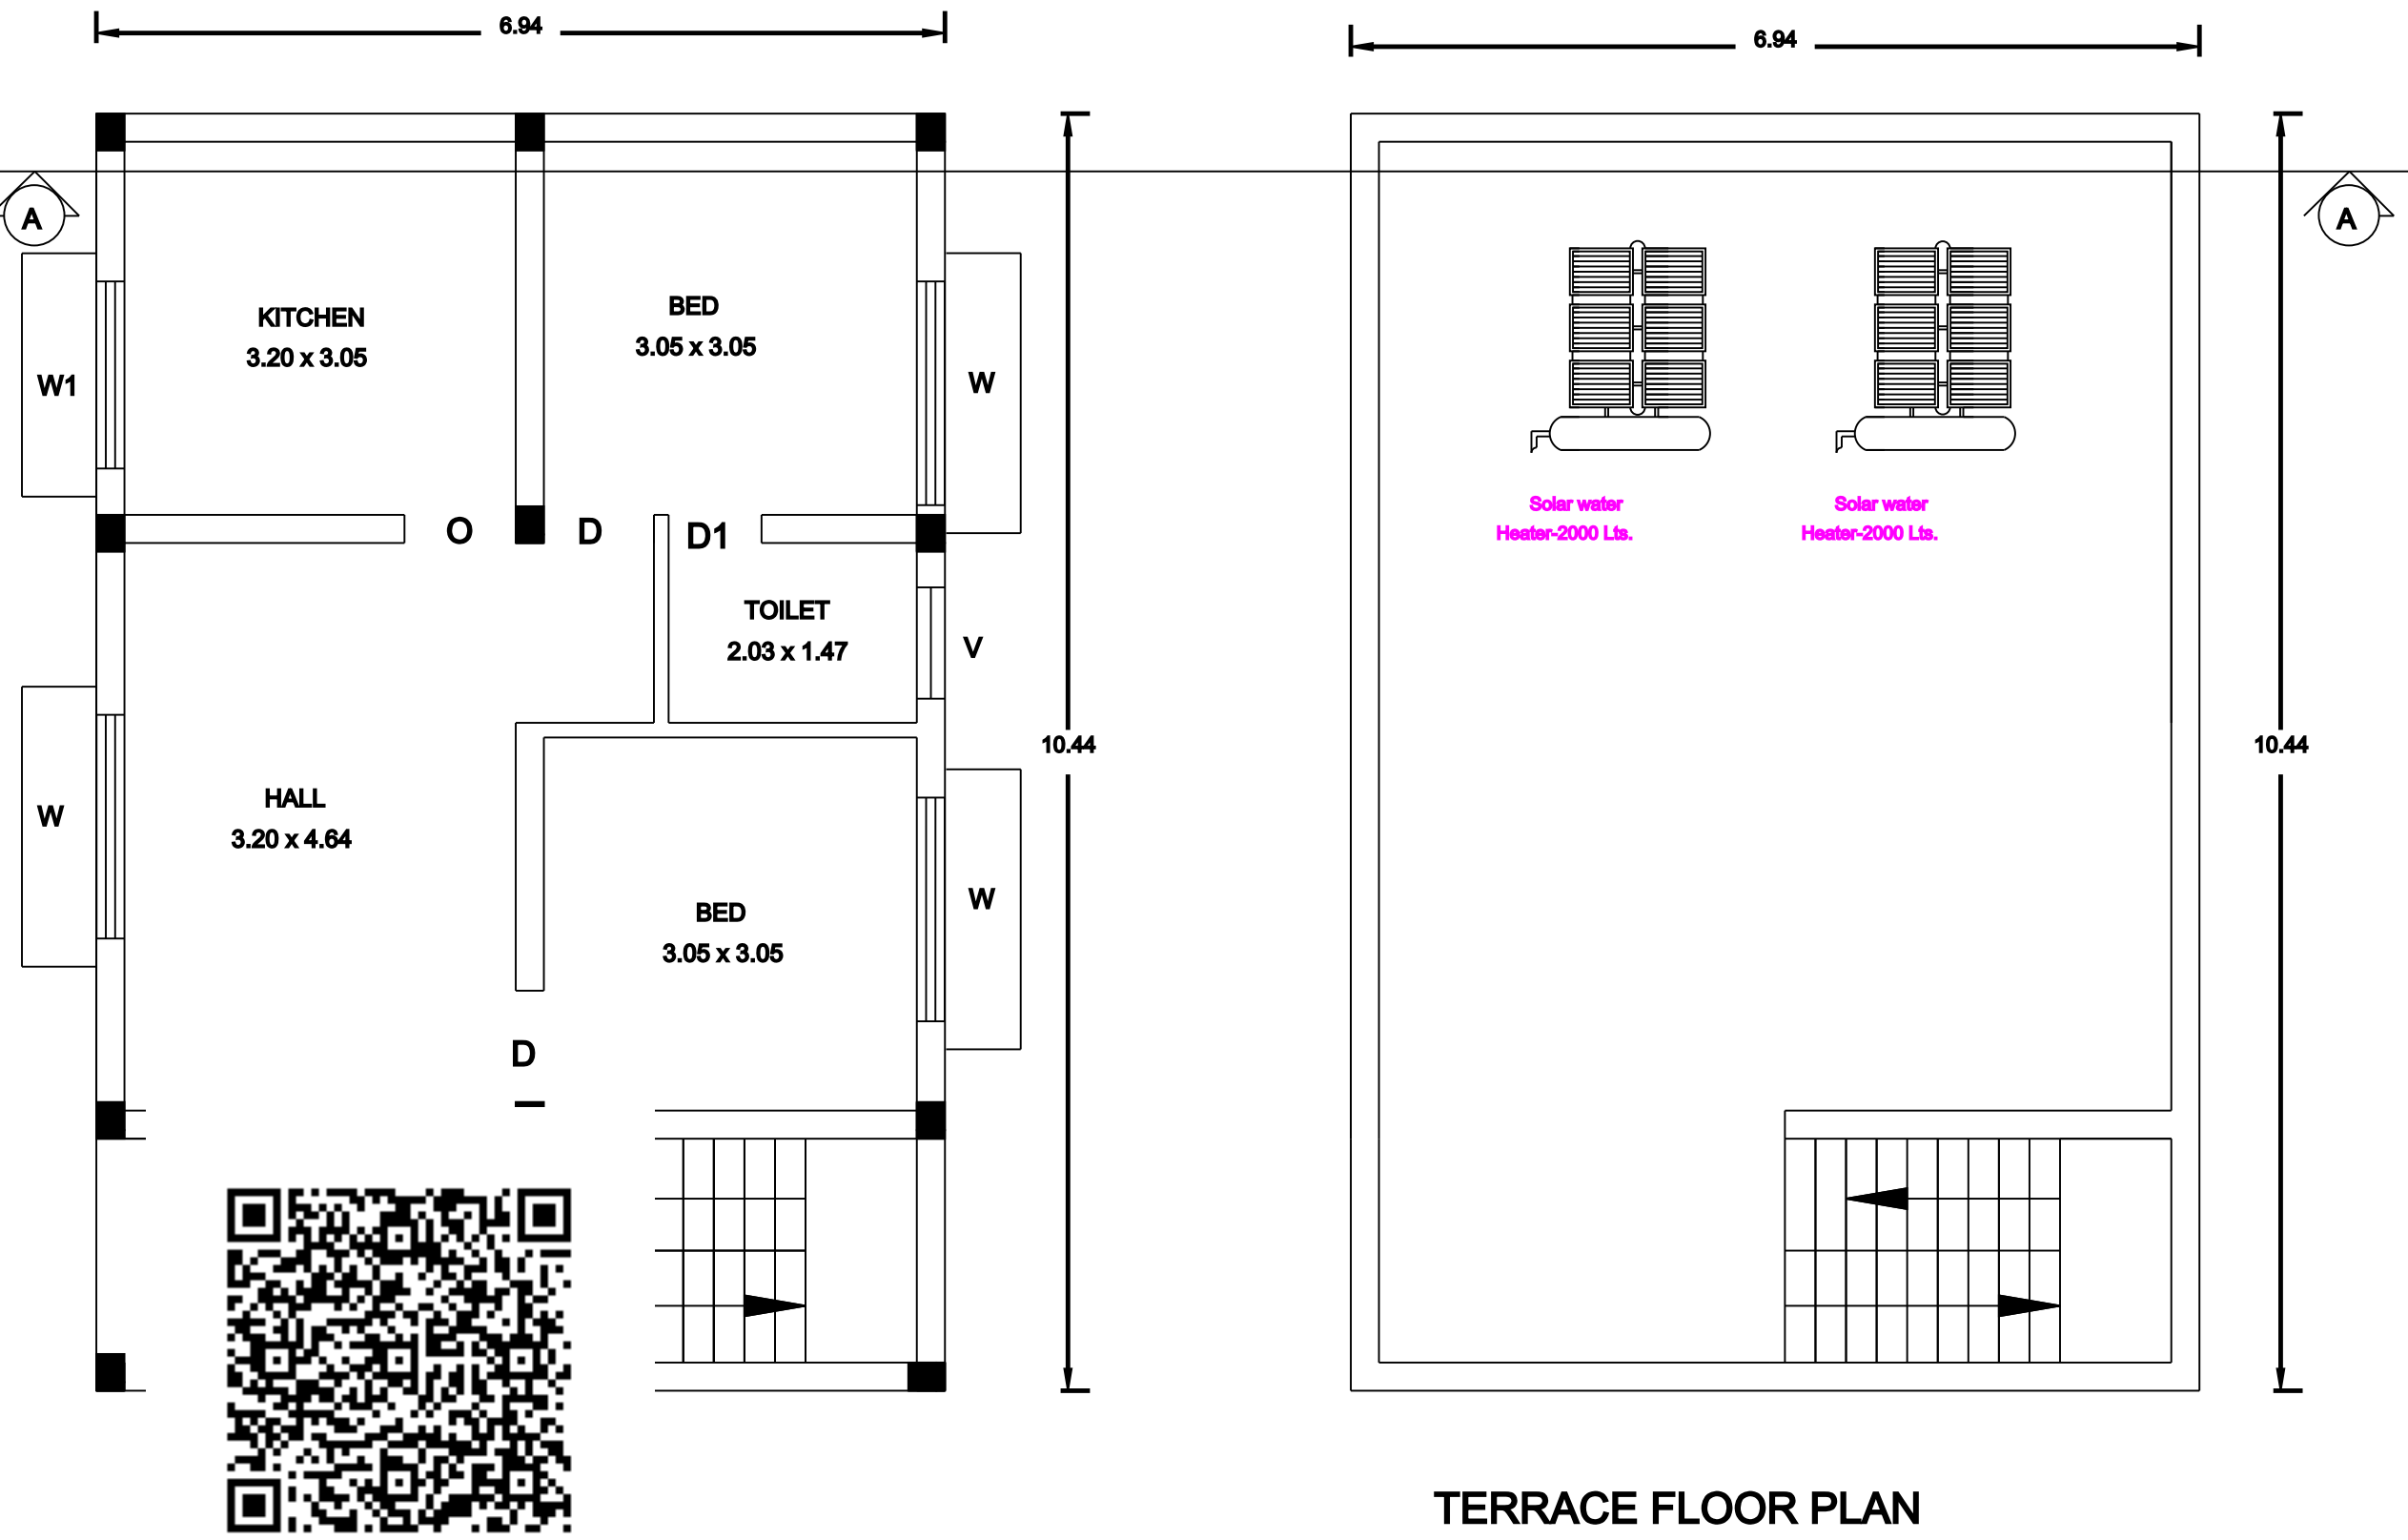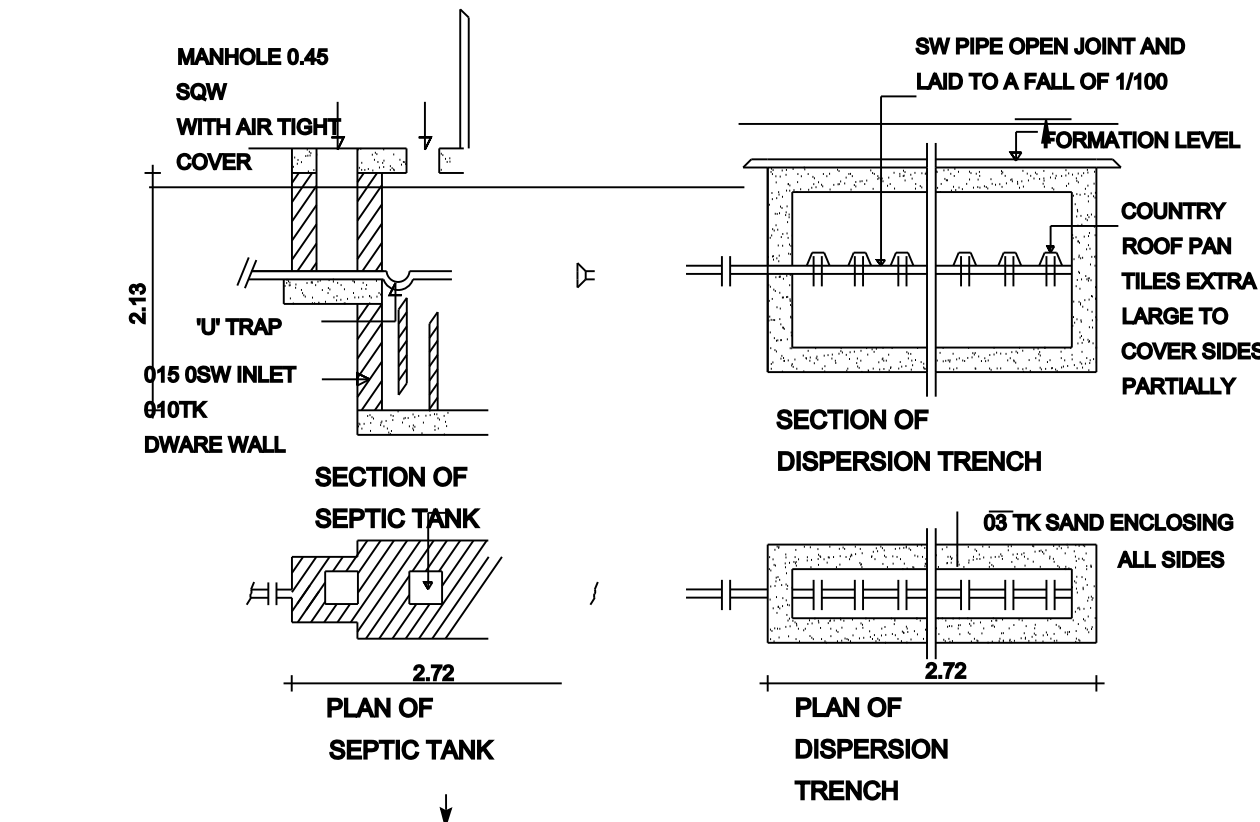

TERRACE FLOOR PLAN

APPROVAL AUTHORITY

JOINERY DETAILS :-

SYM	JOINERY	SIZE (FT)	SIZE (M)
M.D	MAIN DOOR	4'-0" x 7'-0"	1.22 x 2.10
D	DOOR	3'-0" x 7'-0"	0.91 x 2.10
D1	DOOR	2'-6" x 7'-0"	0.76 x 2.10
W	WINDOW	6'-0" x 4'-0"	1.83 x 1.22
FW	WINDOW	6'-0" x 6'-0"	1.83 x 1.83
W1	WINDOW	4'-0" x 4'-0"	1.22 x 1.22
V	VENTILATOR	3'-0" x 2'-0"	0.91 x 0.61

AREA DETAILS

DESCRIPTION	IN SQ.FT	IN SQ. MT
PLOT AREA (AS PER TSLR)	1950.00	181.16
SUPERIMPOSED PLOT AREA	1950.00	181.16
GROUND FLOOR AREA	779.56	72.45
HEAD ROOM AREA	83.49	7.76
OPEN SPACE LEFT	1170.44	108.71
CAR PARKING	REQUIRED	PROVIDED
	1	1
TWO WHEELER PARKING	2 Nos	2 Nos

SCALE :- 1:100
ALL DIMENSIONS AREA IN METER
WASTE WATER FROM TOILET AND KITCHEN
WILL BE CONNECTED TO UNDER GROUND DRAINAGE SCHEME.
PROPOSED SITE BOUNDARY SHOWN IN
PROPOSED BUILDING SHOWN IN
ROAD SHOWN IN

Mr.M.CHANDRASEKAR
S/o.MUTHUSAMY

REGISTERED ENGINEER

ONLY DRAWN BY,
SVT CONSTRUCTIONS
MCV COMPLEX,
KAMARAJAR ARCH,
PERAMBALUR,
MOBILE-9199249135,8600484655
Email: Vengal880@gmail.com
MEMBER OF PERAMBALUR CIVIL ENGINEERS ASSOCIATION

