



PLAN SHOWING THE PROPOSED CONSTRUCTION OF A GROUND FLOOR RCC ROOF RESIDENTIAL BUILDING IN
NEW S.F NO-222/9A2 & PATTA NO-3435, AT MANAKATTU STREET, ASUR REVENUE VILLAGE, AND ASUR PANCHAYAT
KUNNAM TALUK & PERAMBALUR DISTRICT-621 708

APPLICANT NAME: Mr.KARTHIK S/o Mr.RAVICHANDRAN

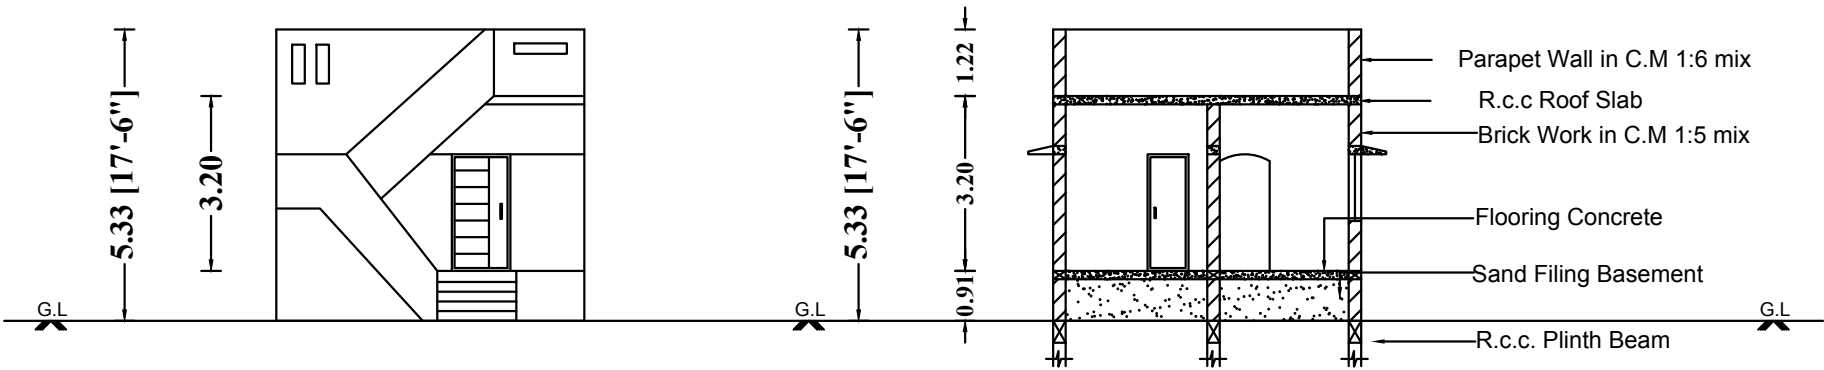


FRONT ELEVATION


SECTION A-A

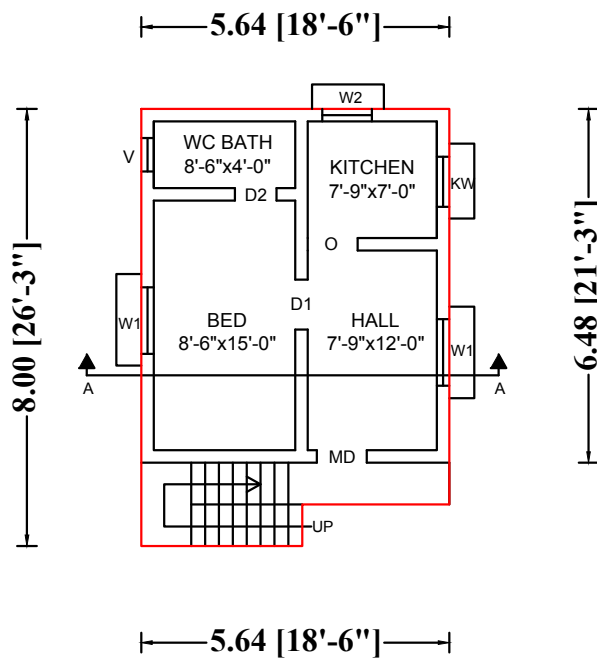


GROUND FLOOR PLAN

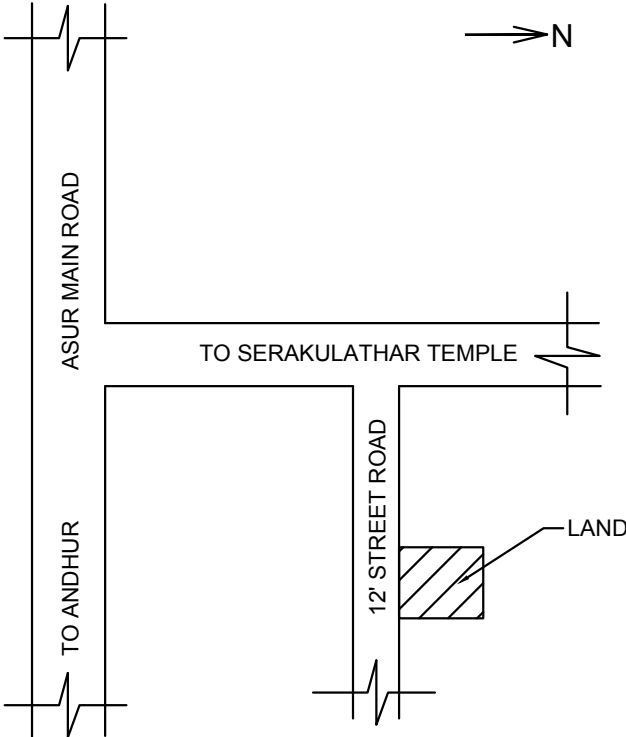

LOCATION PLAN (NOT TO SCALE)

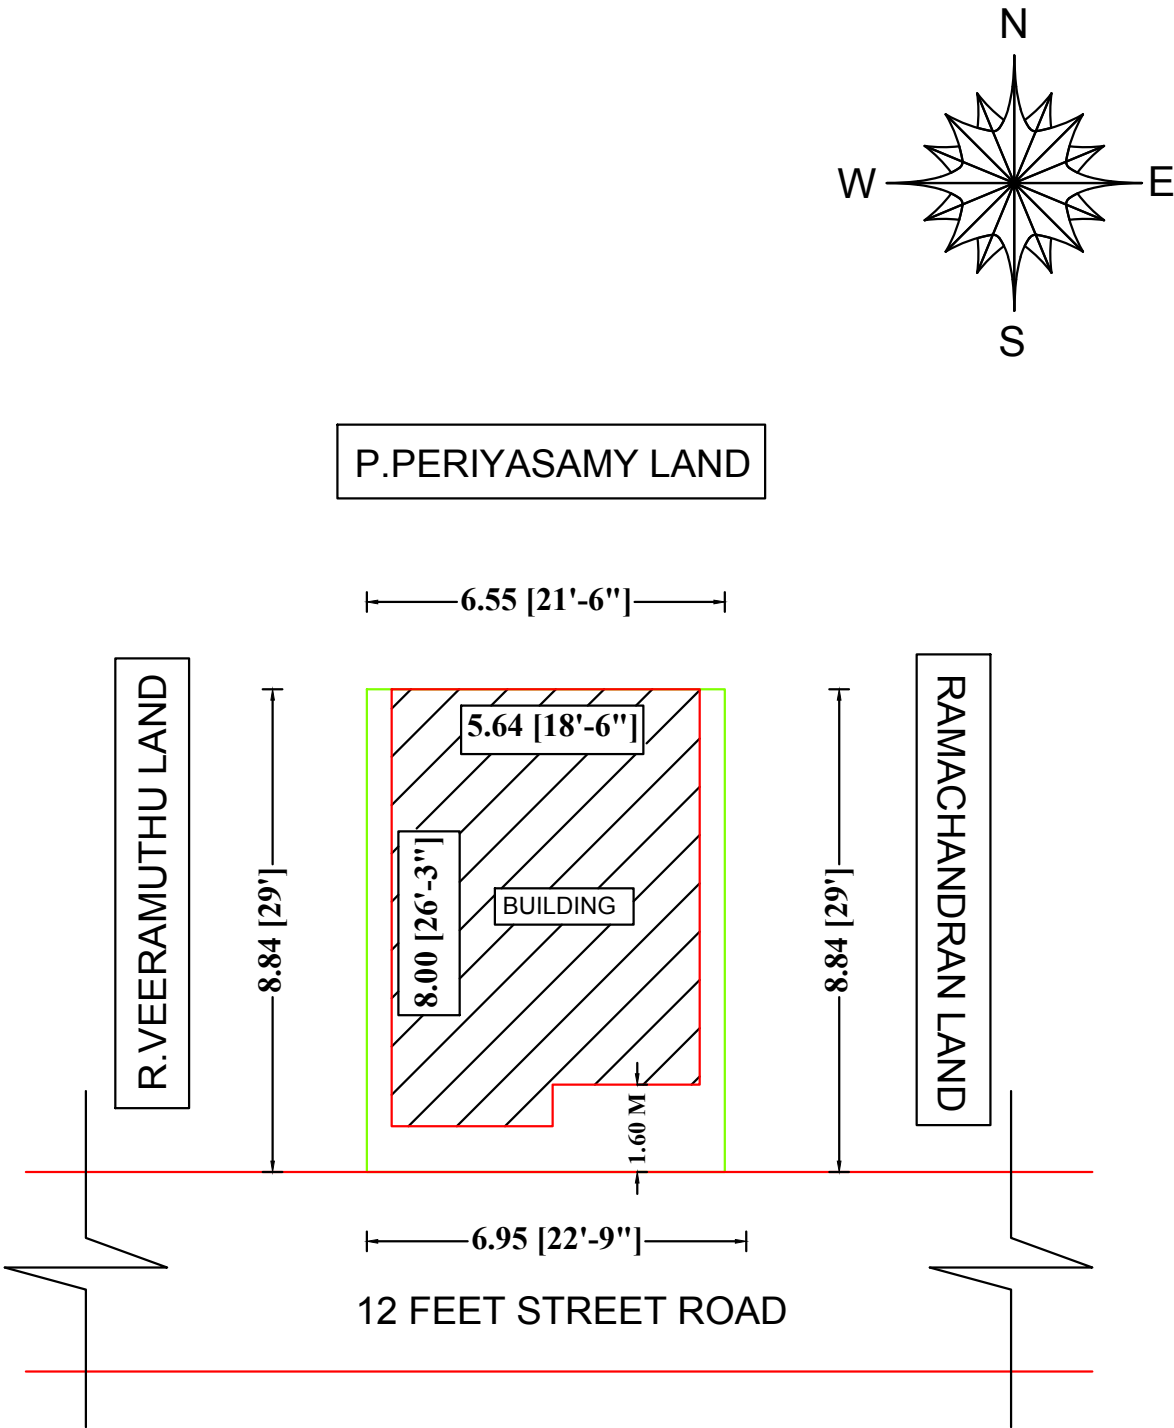

SITE PLAN (SCALE 1:100)

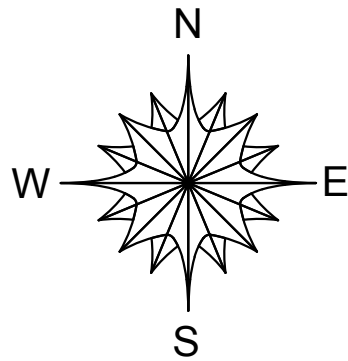

(THIS DRAWING IS DIGITALLY SIGNED)

COLOR INDEX		
	SITE BOUNDRY	
	R.C.C ROOF RESIDENTIAL BUILDING	
	ROAD DETAILS	
PARKING STALL DETAILS		
CAR SPACE	0	0
BIKE SPACE	0	1
SCALE =(1:100)	All Dimensions Are In Meters	
SCHEDULE OF JOINERIES		
DESCRIPTION	SIZE IN FEET	SIZE IN M
Main Door - MD	3'6" x 7'0"	1.06 x 2.13
Door - D1	3'0" x 7'0"	0.91 x 2.13
Door - D2	2'6" x 7'0"	0.76 x 2.13
Window - W1	4'0" x 4'0"	1.22 x 1.22
Window - W2	3'0" x 4'0"	0.91 x 1.22
Kitchen Window - KW	3'0" x 3'0"	0.91 x 0.91
Ventilator - V	2'0" x 3'0"	0.61 x 0.91
AREA OF THE PROPOSED CONSTRUCTION DETAILS		
DESCRIPTION	SQ.FT	SQ.M
Total Site Area (as per Document)	623.50	57.92
Proposed Ground Floor	463.49	43.06
Area of the Open Space	160.01	14.86
Total Builtup Area=43.06 Sqm / 463.49 Sft		
FSI = Total Builtup Area / Total Site Area =0.743		


R. Karthik

Mr.KARTHIK S/o Mr.RAVICHANDRAN


APPLICANT NAME & SIGNATURE




QR CODE

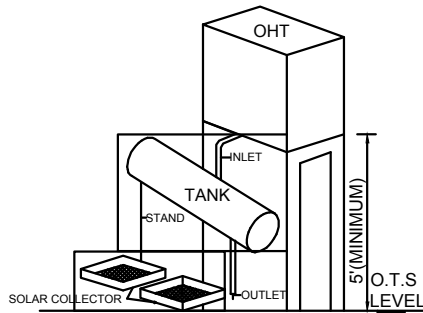


SOLAR WATER HEATING SYSTEM

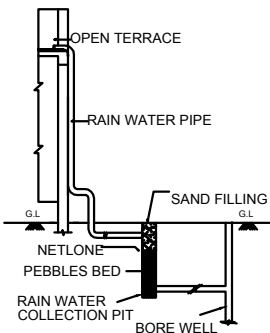


RAIN WATER HARVESTING SYSTEM

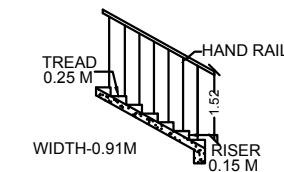


STAIRCASE DETAILS

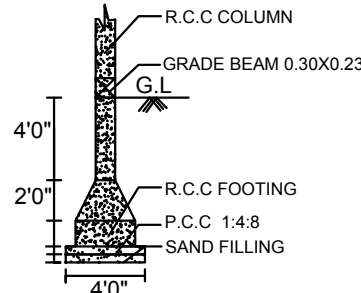

COLOUMN FOUNDATION DETAILS

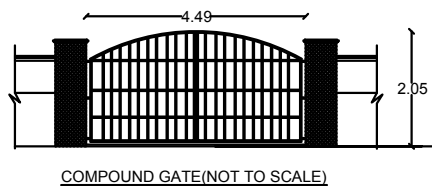

MAIN GATE WICKET GATE

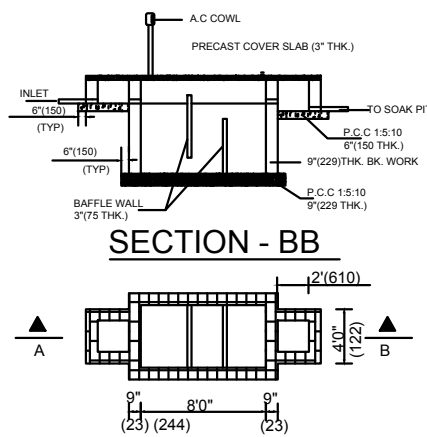

PLAN OF SEPTIC TANK

Er. S. SILAMBARASAN, B.E.,
REGISTERED ENGINEER
Reg.No.089/LS/2024/00001
SS CONSTRUCTION
71, M.K Complex, Opp Darling Show Room
Vengadesapuram, Perambalur - 621212
PH: 9597500575

ENGINEER / L.B.S