
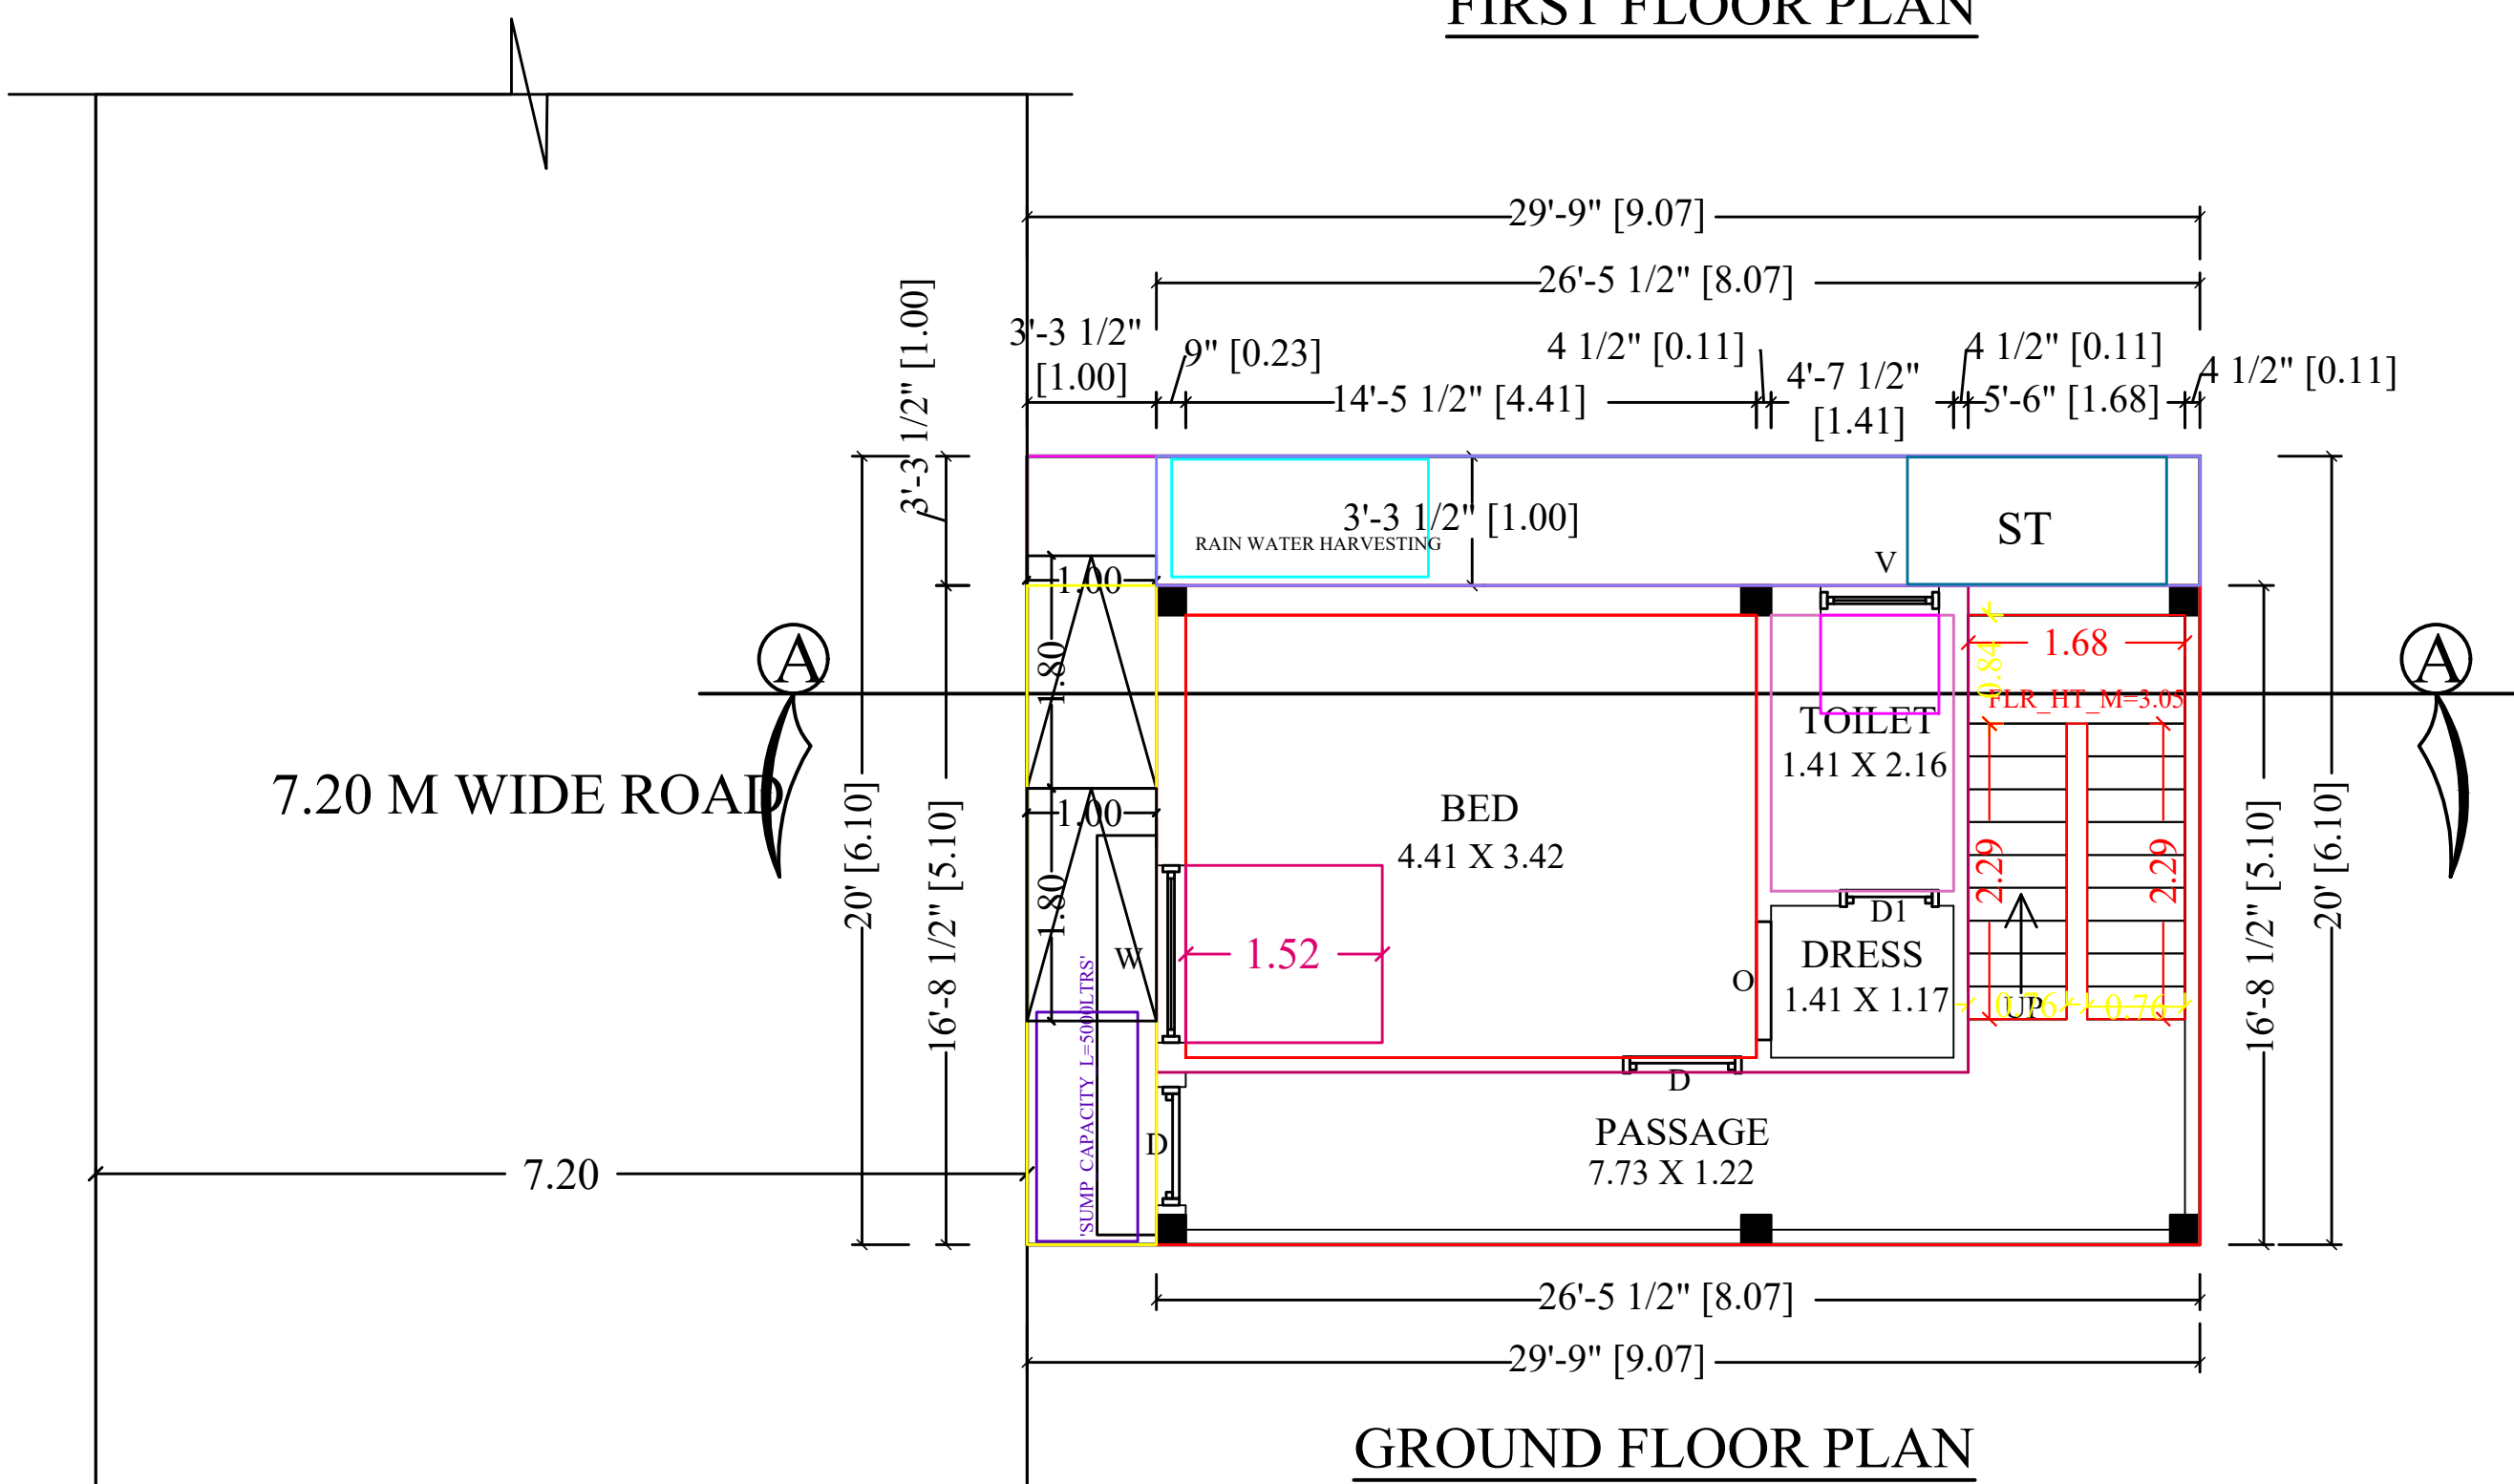
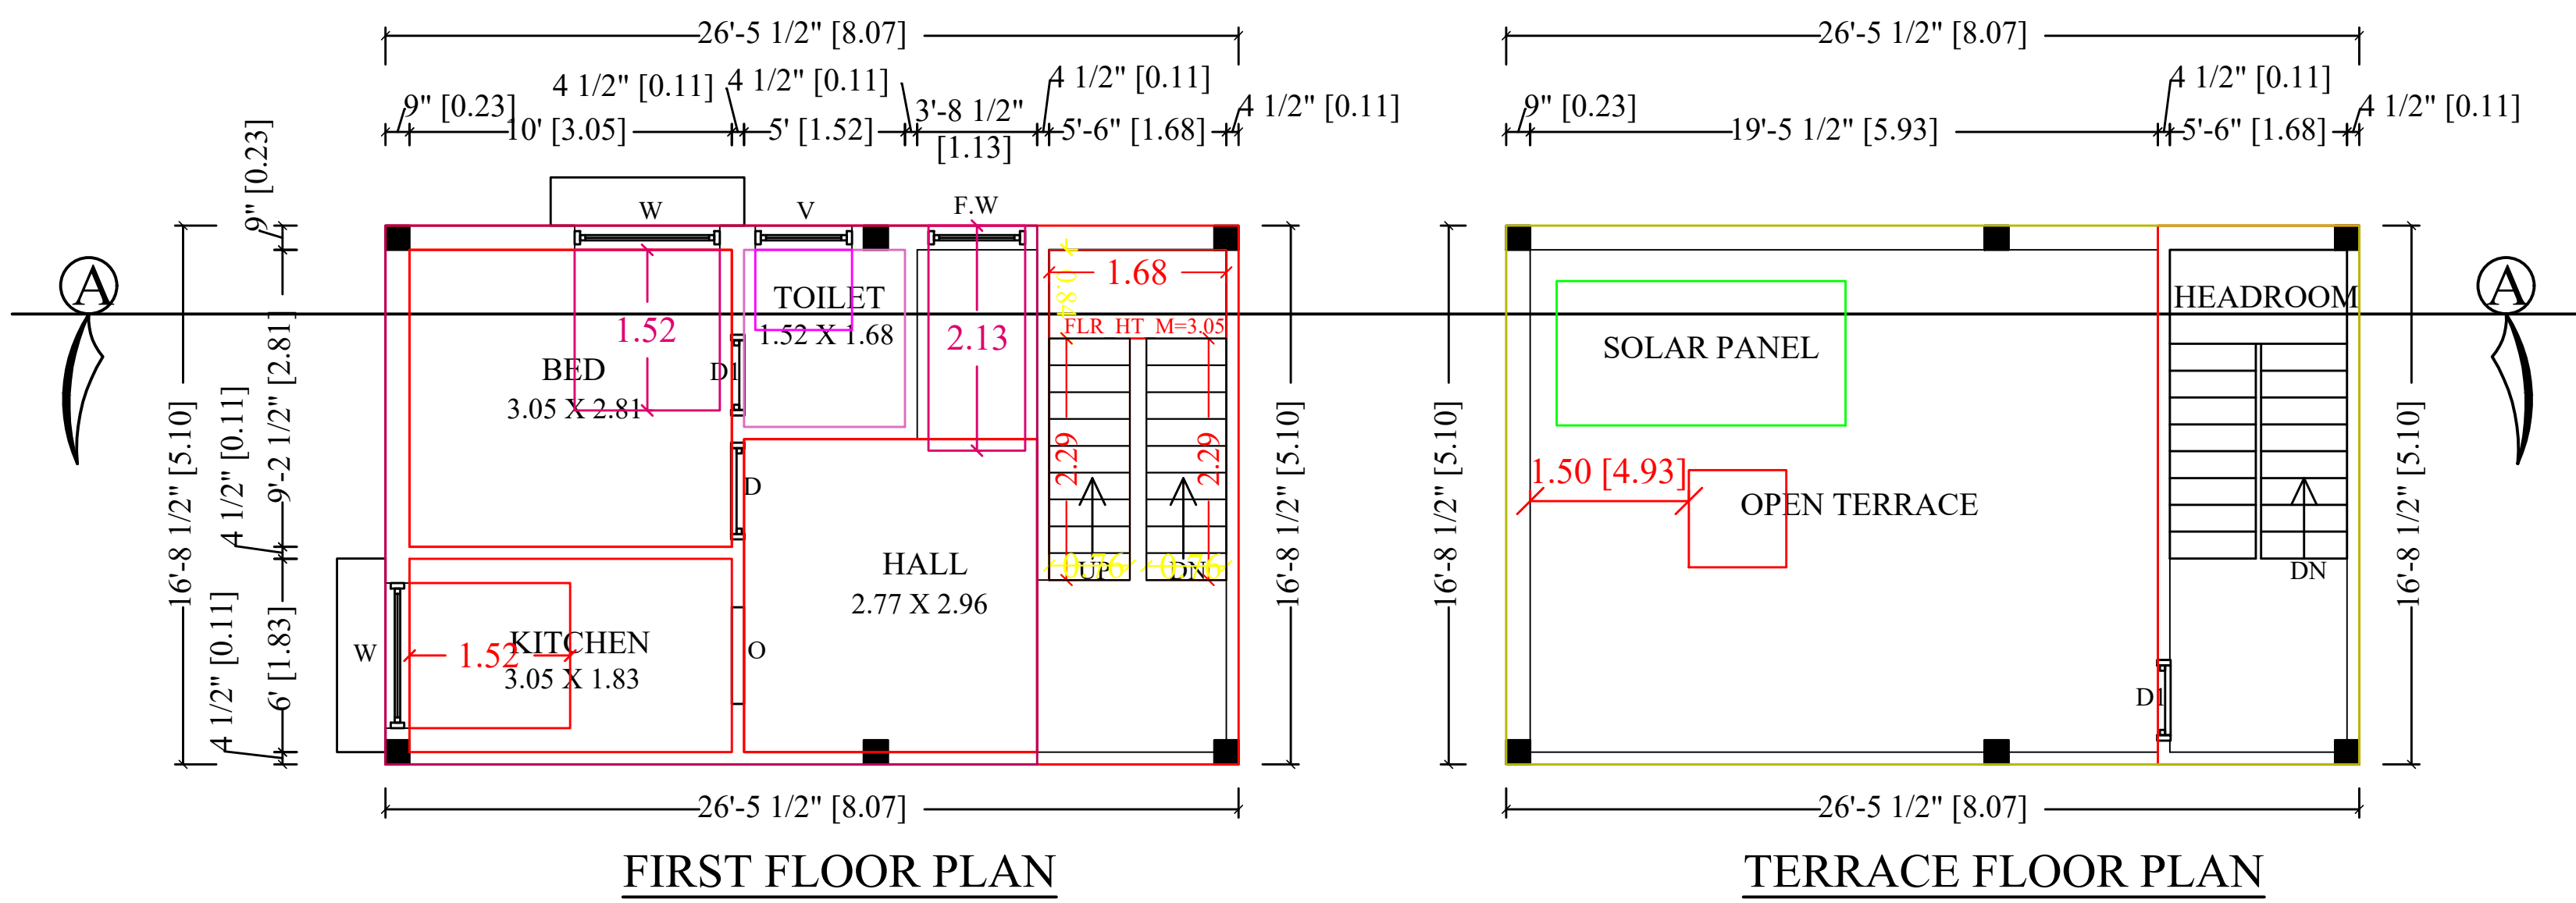
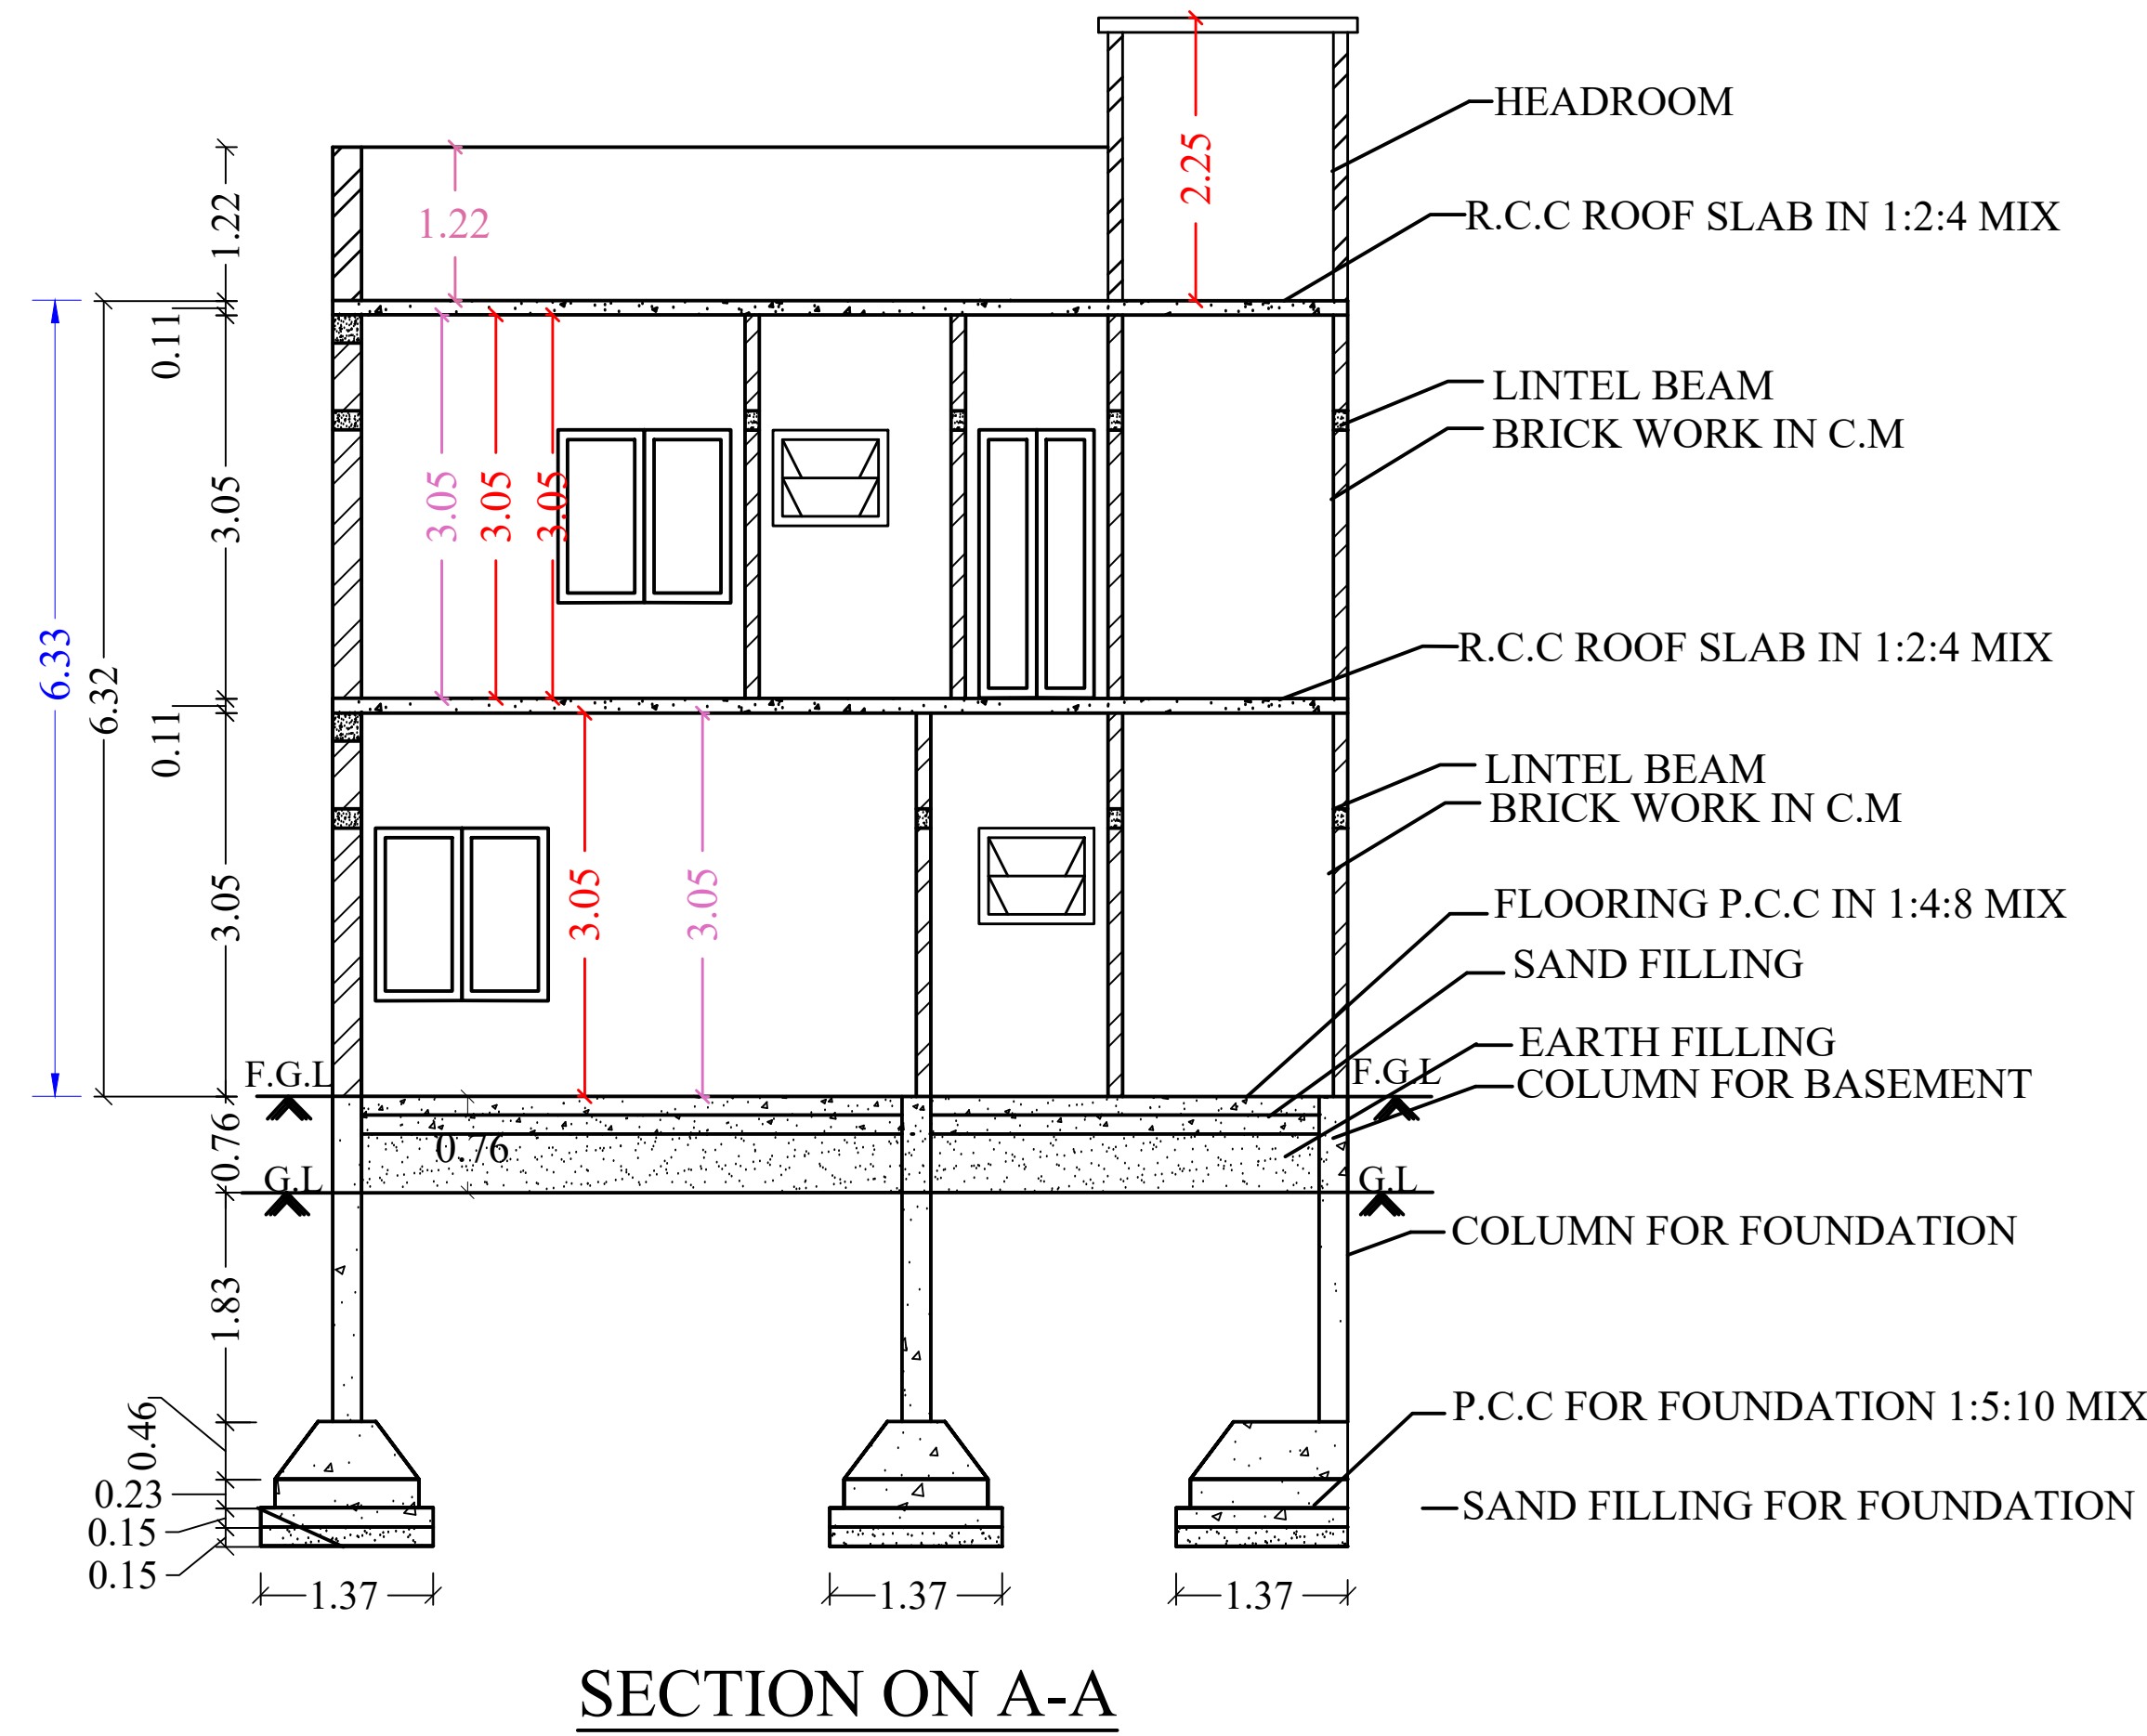




PLAN SHOWING THE PROPOSED CONSTRUCTION OF R.C.C TERRACED ROOF GROUND & FIRST FLOOR RESIDENTIAL BUILDING
IN S.NO: 93/1D67, PLOT NO : EWS 73, J.S.K. GARDEN, KARIPATTI VILLAGE PANCHAYAT, VALAPADY TALUK, AYOTHIYAPATTINAM
UNION, SALEM EAST REG DT., SALEM DISTRICT.

NAME OF THE APPLICANT: Mrs.S.P.AGILA, W/O. Mr.TAMILALAGAN.


APPROVED LAYOUT NO : SWP/DTCP/SALEM/LAYOUT NO. 002/2022.

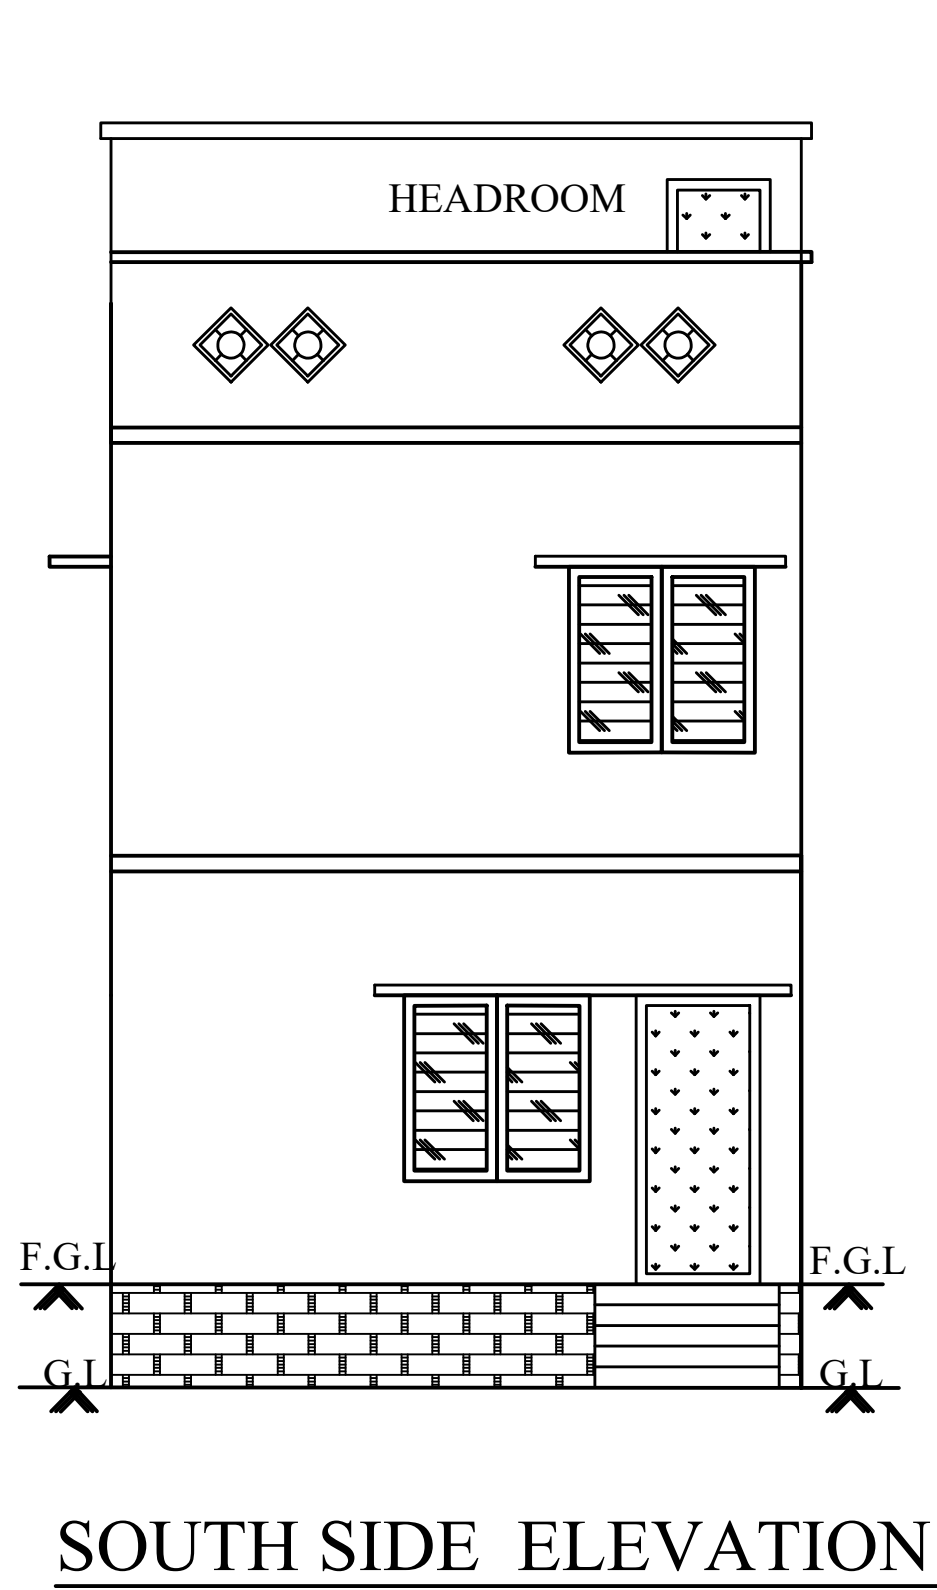


SITE PLAN :
SCALE 1: 200

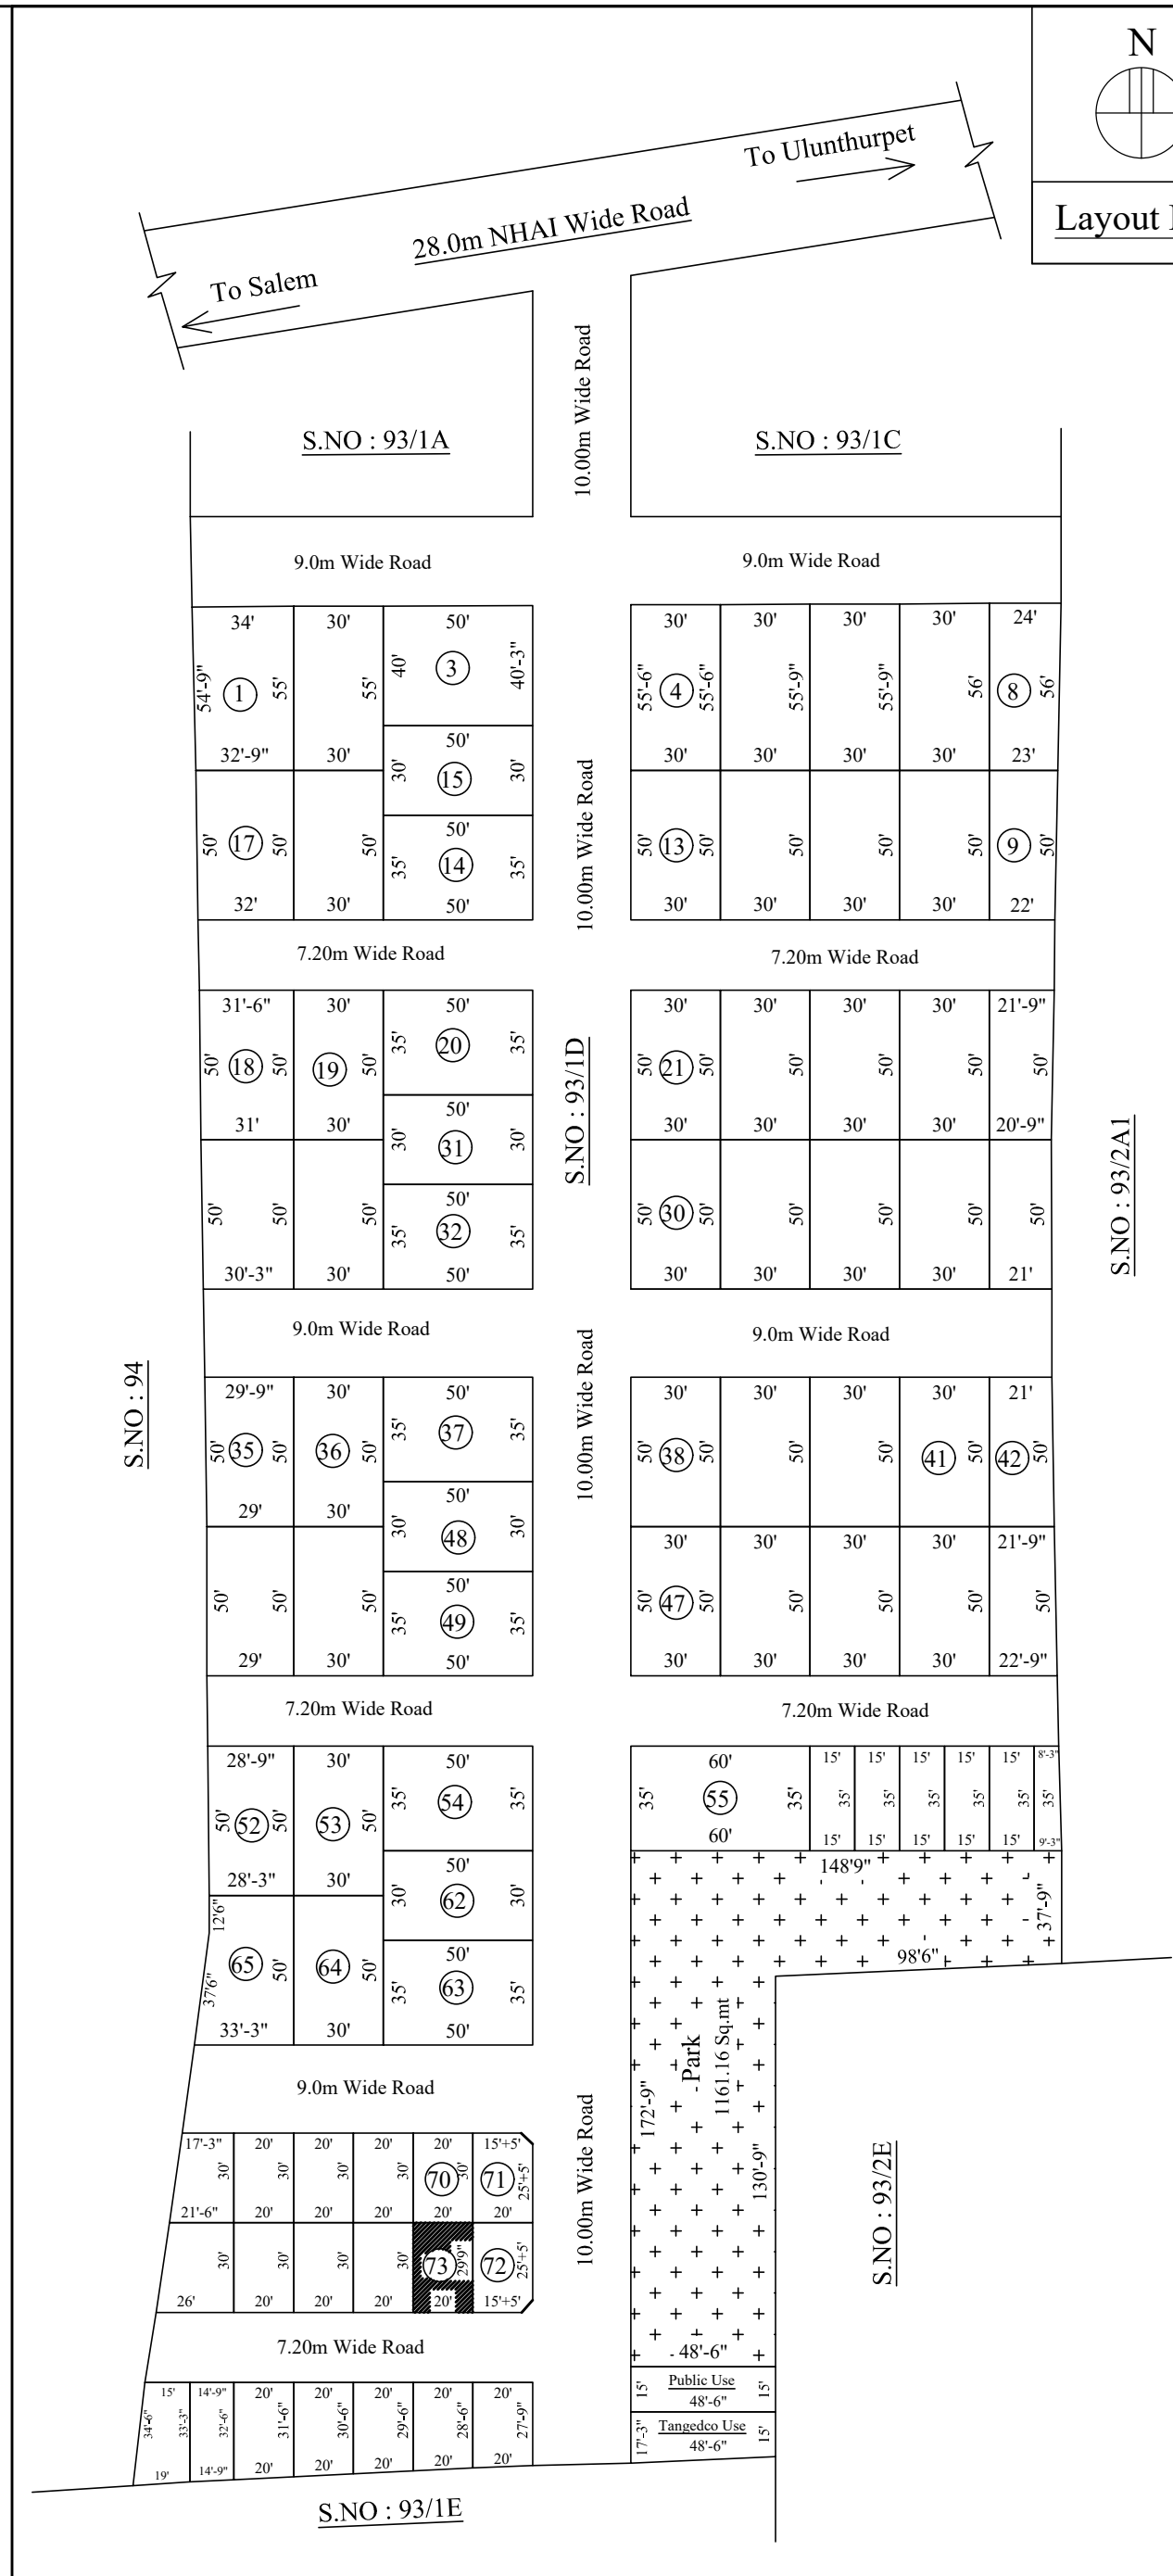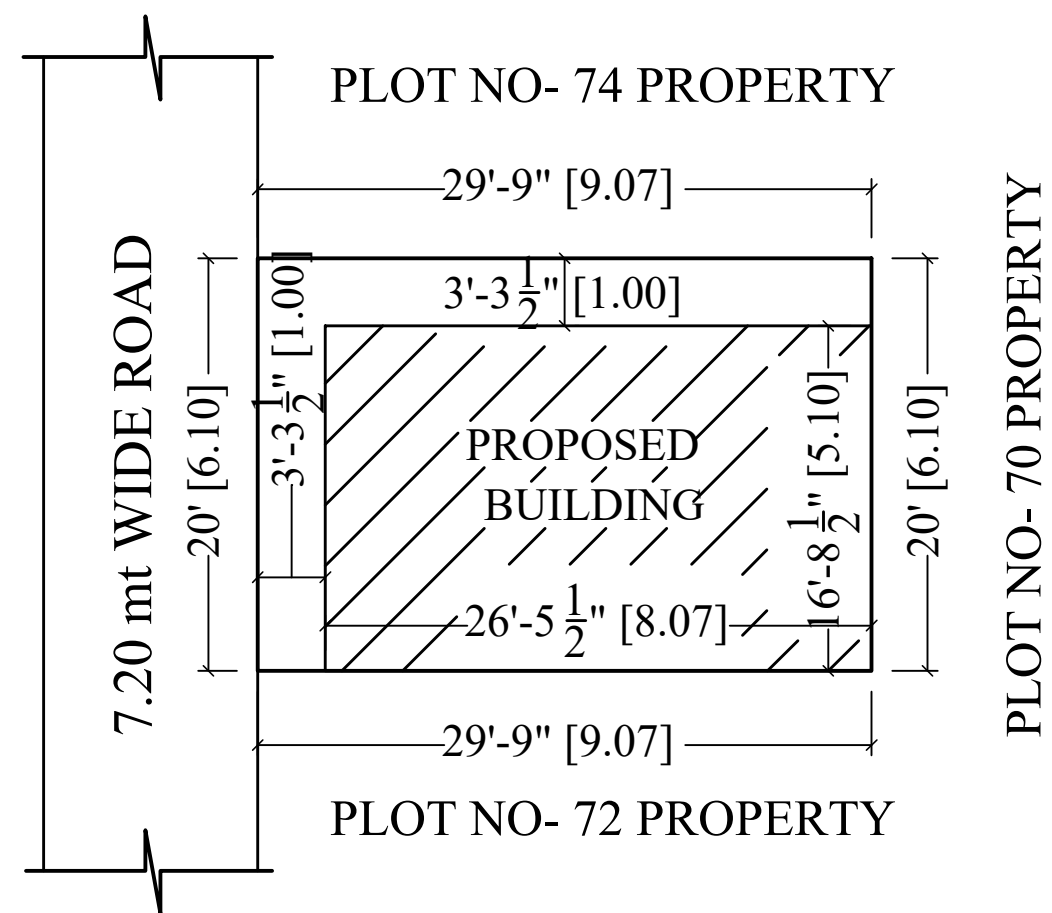



STAIR CASE DETAILS:

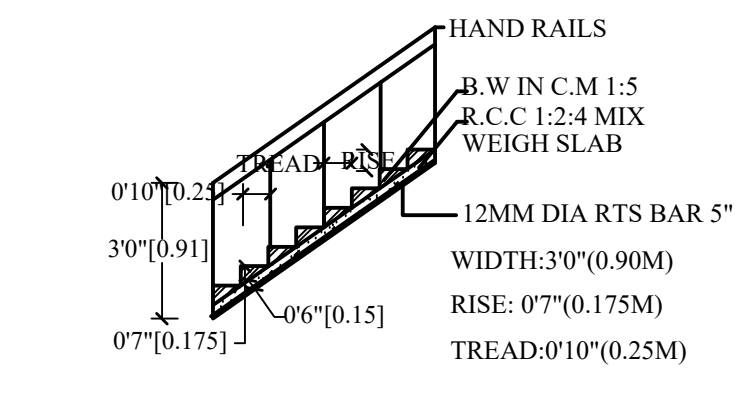

RAIN WATER HARVESTING:

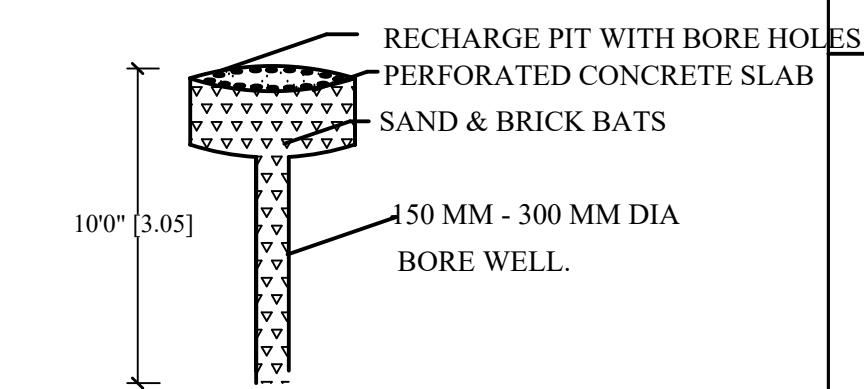

SEPTIC TANK:

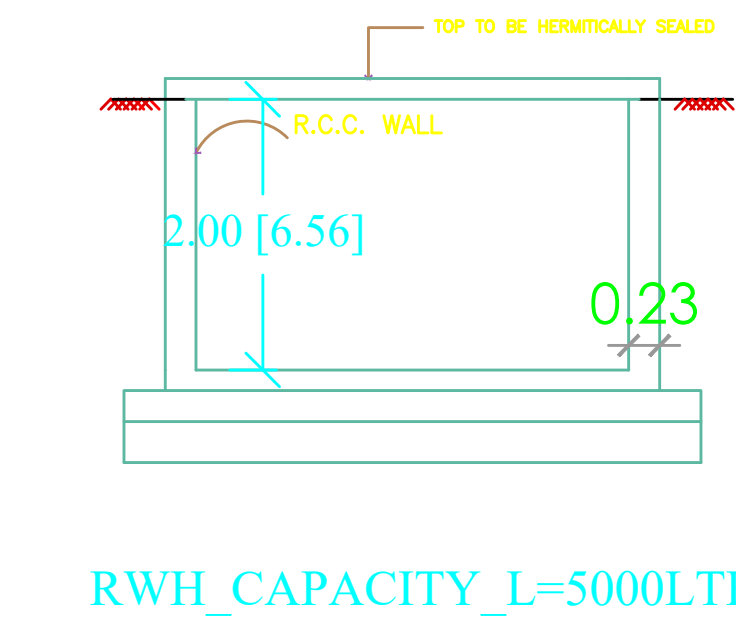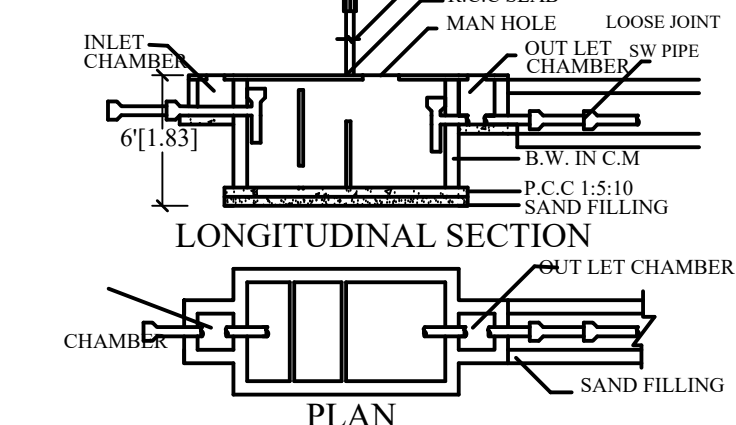

AREA DETAILS:-

1.	AREA OF THE SITE	594.40 S.FT	55.22 S.M
2.	GROUND FLOOR AREA	443.00 S.FT	41.16 S.M
3.	FIRST FLOOR AREA	443.00 S.FT	41.16 S.M
4.	HEADROOM AREA	105.00 S.FT	9.75 S.M
5.	TOTAL AREA	991.00 S.FT	92.07 S.M
6.	VACANT AREA	151.40 S.FT	14.06 S.M

JOINERY DETAILS :-

S.NO	DESCRIPTION	SIZE IN FT	SIZE IN M
1.	DOOR - D	3'0" X 7'0"	0.91 X 2.14
2.	DOOR - D1	2'6" X 7'0"	0.76 X 2.14
3.	OPEN - O	3'0" X 7'0"	0.91 X 2.14
4.	WINDOW - W	4'6" X 4'6"	1.37 X 1.37
5.	FRENCH WINDOW FW	3'0" X 7'0"	0.91 X 2.14
6.	VENTILATOR - V	3'0" X 2'6"	0.91 X 0.76

LEGEND:-

BOUNDRY SHOWN IN - ☐
PROPOSED SHOWN IN - ☐
ROAD SHOWN IN - ☐

SCALE :-

ALL DIMENSIONS ARE IN FEET & METER
SCALE 1 : 100 OR 1" = 8'0"

APPLICANT:-

S.P. Agila

ENGINEER:-

Dr. J. SANKAR, P.E., M.E., M.S.T.E.,
SURRYA BUILDERS
Reg. Engineer (Grade II), Reg. Structural Engineer (Grade II),
Reg. Construction Engineer, Reg. Quality Auditor & Developer,
Consulting Civil Engineer, Vastu Consultant, Architectural
Designer, Total Station Land Surveyor, Interior Decorator & Valuer,
53B/12-C, Neelajai Nagar, Near Pillayar Temple,
Central Jail Roadside, Near Hosurpattinam Water Tank,
HASTHAMPRATTY, SALEM - 636 007.
Call: 94432 67765, 94482 67780, Off: 0427-2314705