
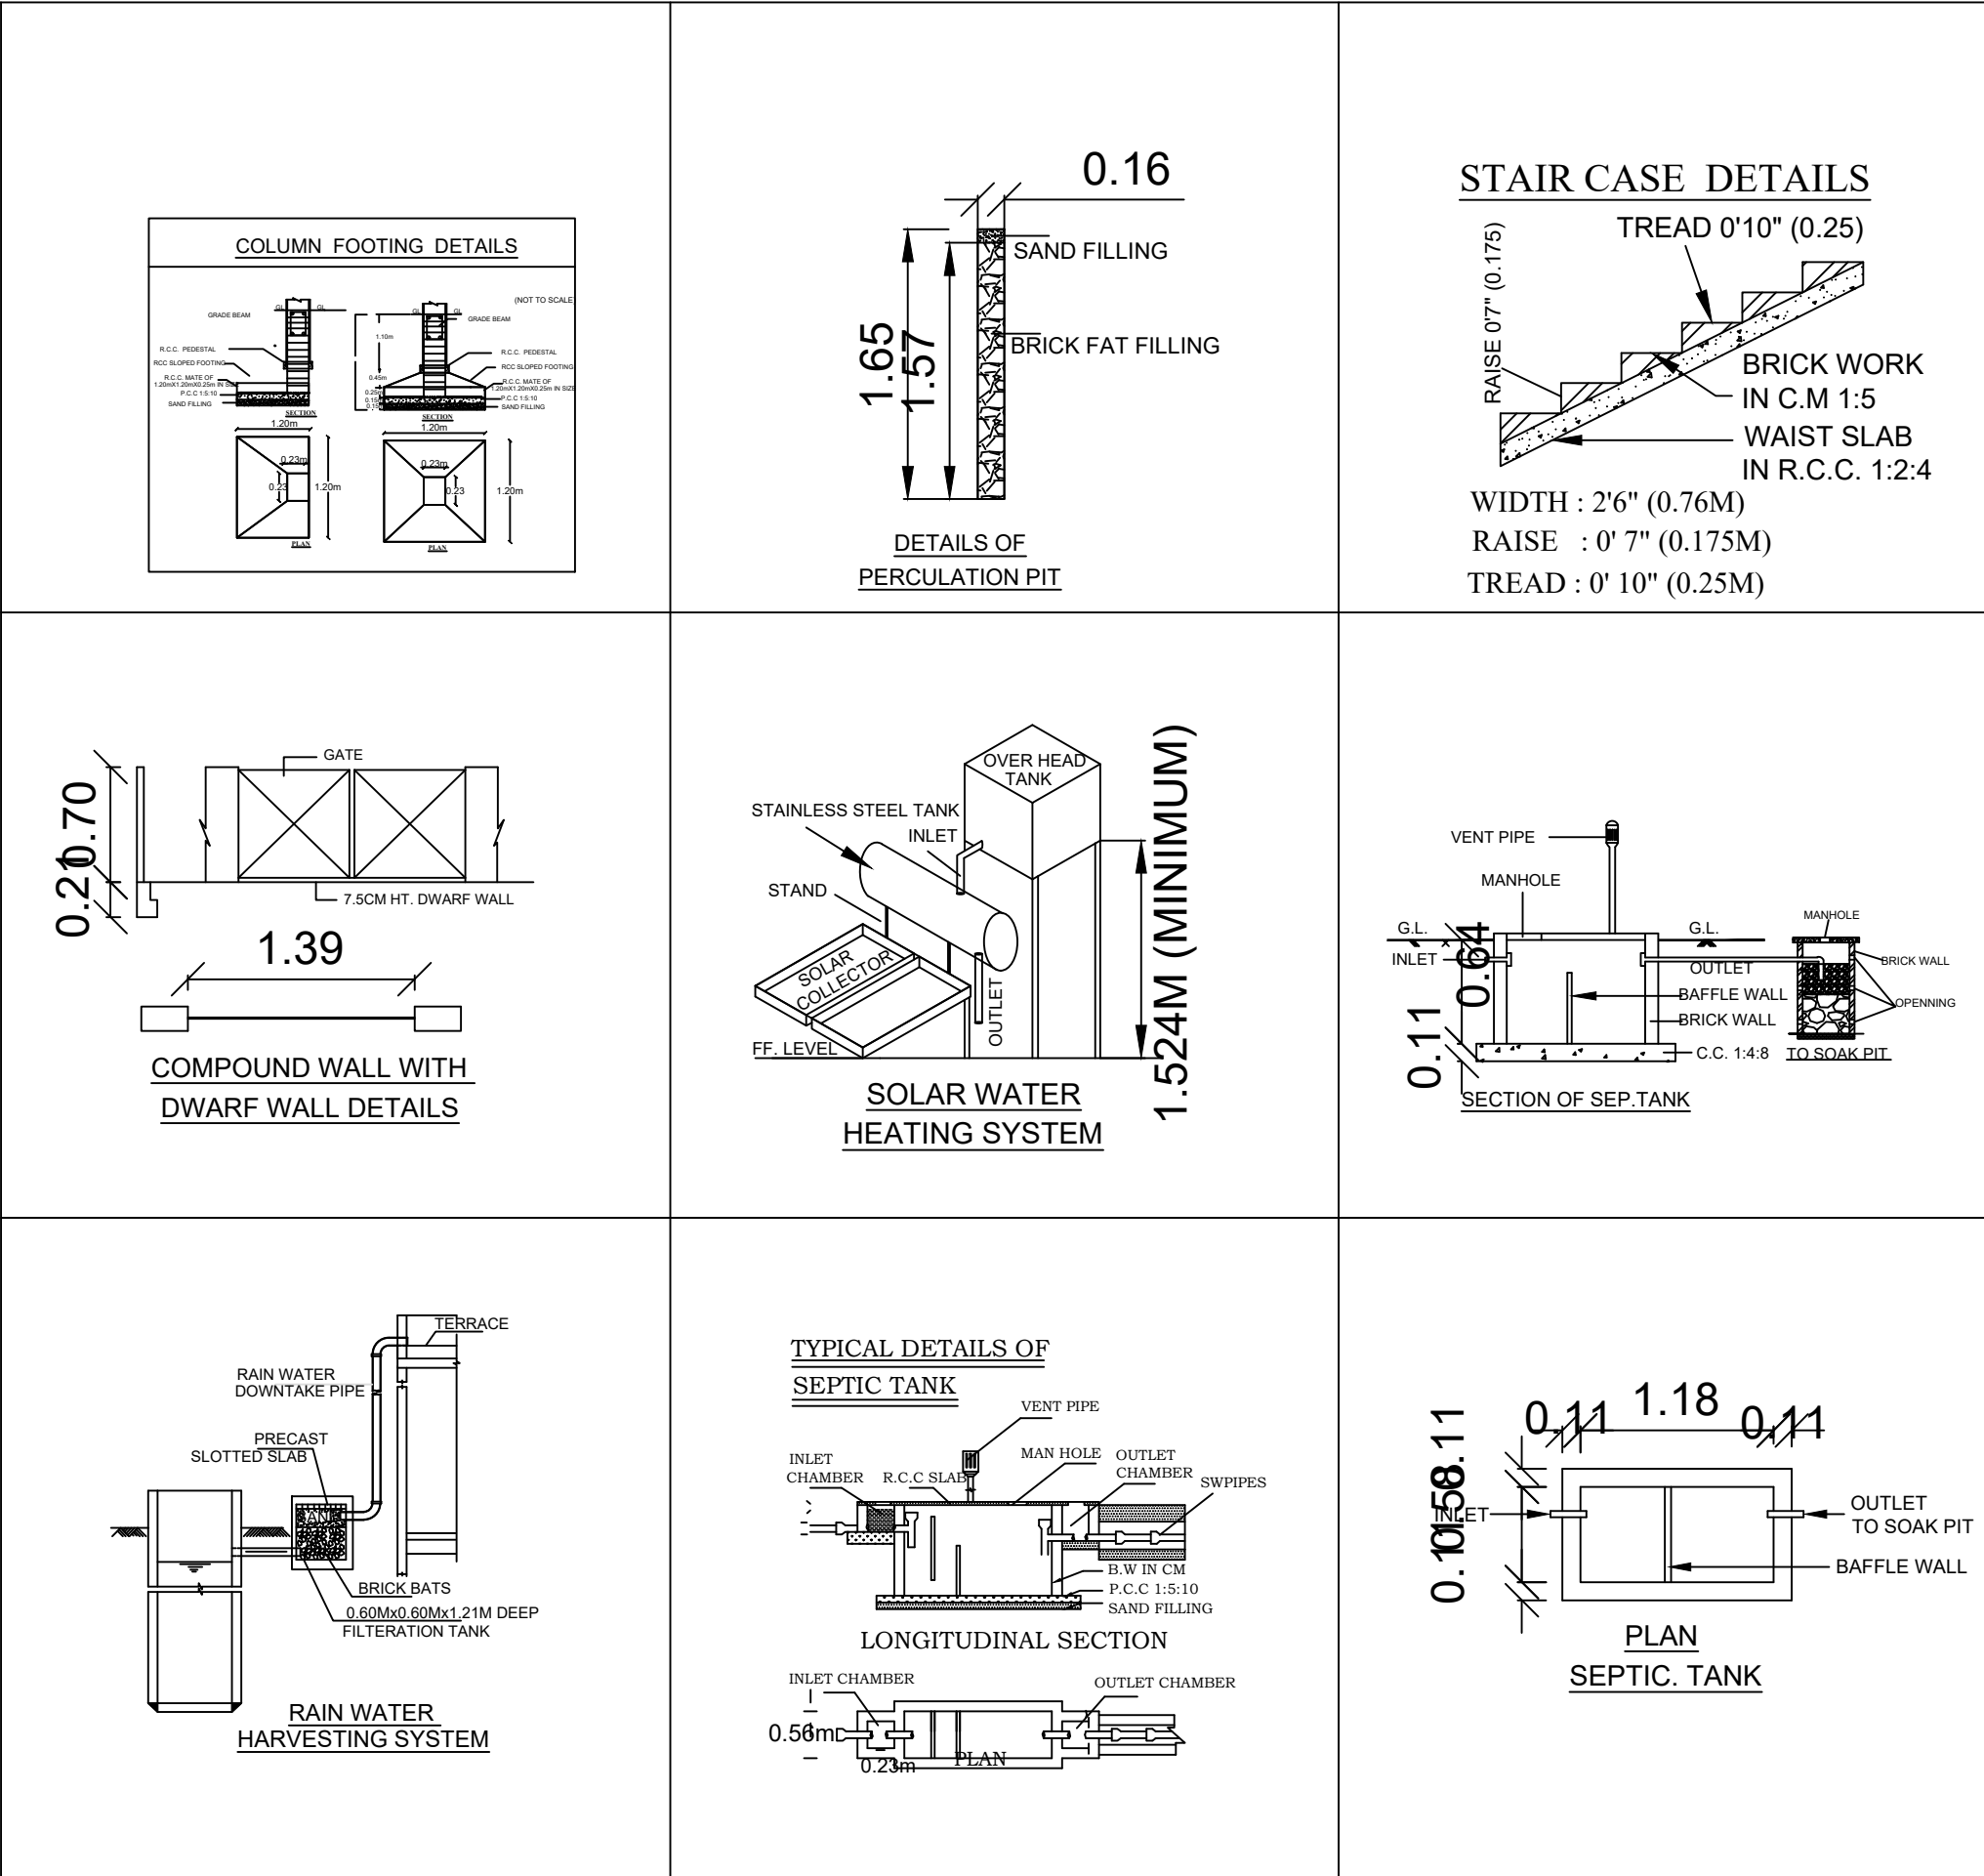


PLAN SHOWING THE PROPOSED CONSTRUCTION OF RCC ROOF COMMERCIAL SHOP BUILDING IN GROUND FLOOR AT S.F.NO:181/9B1B, PATTA NO:6712, WARD:04, SEKKADIPATTI, VELLALAPATTI VILLAGE, PETHANAICKENPALAYAM (TALUK), SALEM (DISTRICT).

SCALE(1:100)

APPLICANT:
Mr.ELAIYARAJA,
S/o.PERIYASAMY.

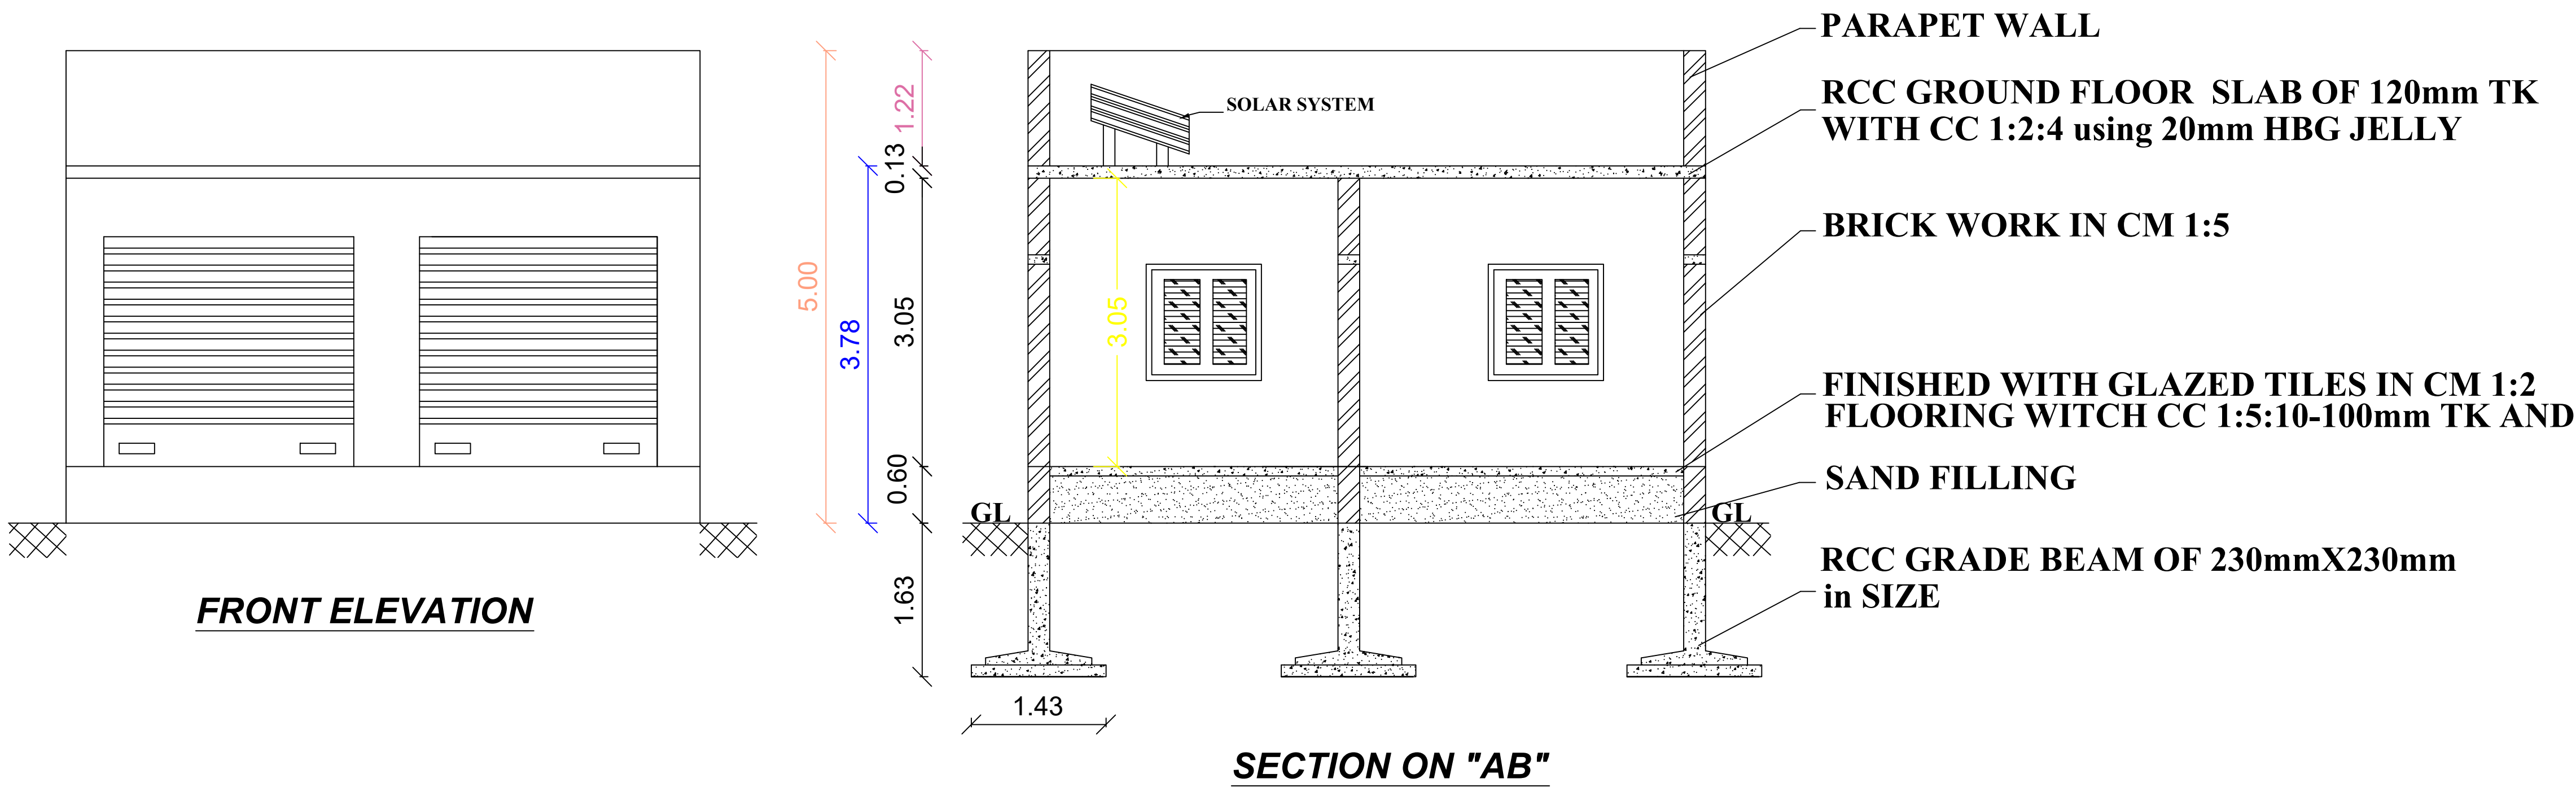

SCHEDULE OF JOINERIES :-		
MD	DOOR	1.06X2.13
D	DOOR	0.91X2.13
D1	DOOR	0.76X2.13
W1	WINDOW	2.05X1.21
W	WINDOW	1.53X1.21
KW	WINDOW	1.21X1.22
V	VENTILATOR	0.60X0.60

AREA STATEMENT		
	SQ.MT	S.FT
TOTAL AREA	144.92	1560.00

PROPOSED BUILDING		
-------------------	--	--

GROUND FLOOR	37.81	407.00
--------------	-------	--------

CARPET AREA	30.25	325.61
-------------	-------	--------

AREA OF OPEN SPACE	107.11	1153.00
--------------------	--------	---------



NO. OF CAR PARKING (2.50 X 5.00) - 1 NO.		
NO. OF TWO WHEELER PARKING (2.50 X 5.00) - 1 NO.		

COLOR INDEX		
-------------	--	--

OWNER BOUNDARY		
PRO. CONSTRUCTION		

- 1.L.P.GAS WILL BE USED FOR KITCHEN
- 2.BORE WELL WITH MOTAR,WATER TANK AND MUNICIPAL WATER SUPPLY WILL BE PROVIDED
- 3.SULLAGE WASTE FROM TOILET WILL BE CONNECTED INTO SEPTIC TANK
- 4.RAIN WATER TAKEN PERCOLATION BED 1.0m WIDE PROVIDED AS PER GO(MS) MO.138 WITH DATE:11.02.02.
- 5.RAIN WATER TAKEN TO THE BORE WELL THROUGH 150mm DIA PIPE.
- 6.SOLAR WATER HEATER WILL BE PROVIDED.
- 7.ALL DIMENSION ARE IN METER.
- 8.AT KITCHEN EXHAUST FAN TO BE PROVIDED.

SITE PLAN :-
(SCALE 1:100)

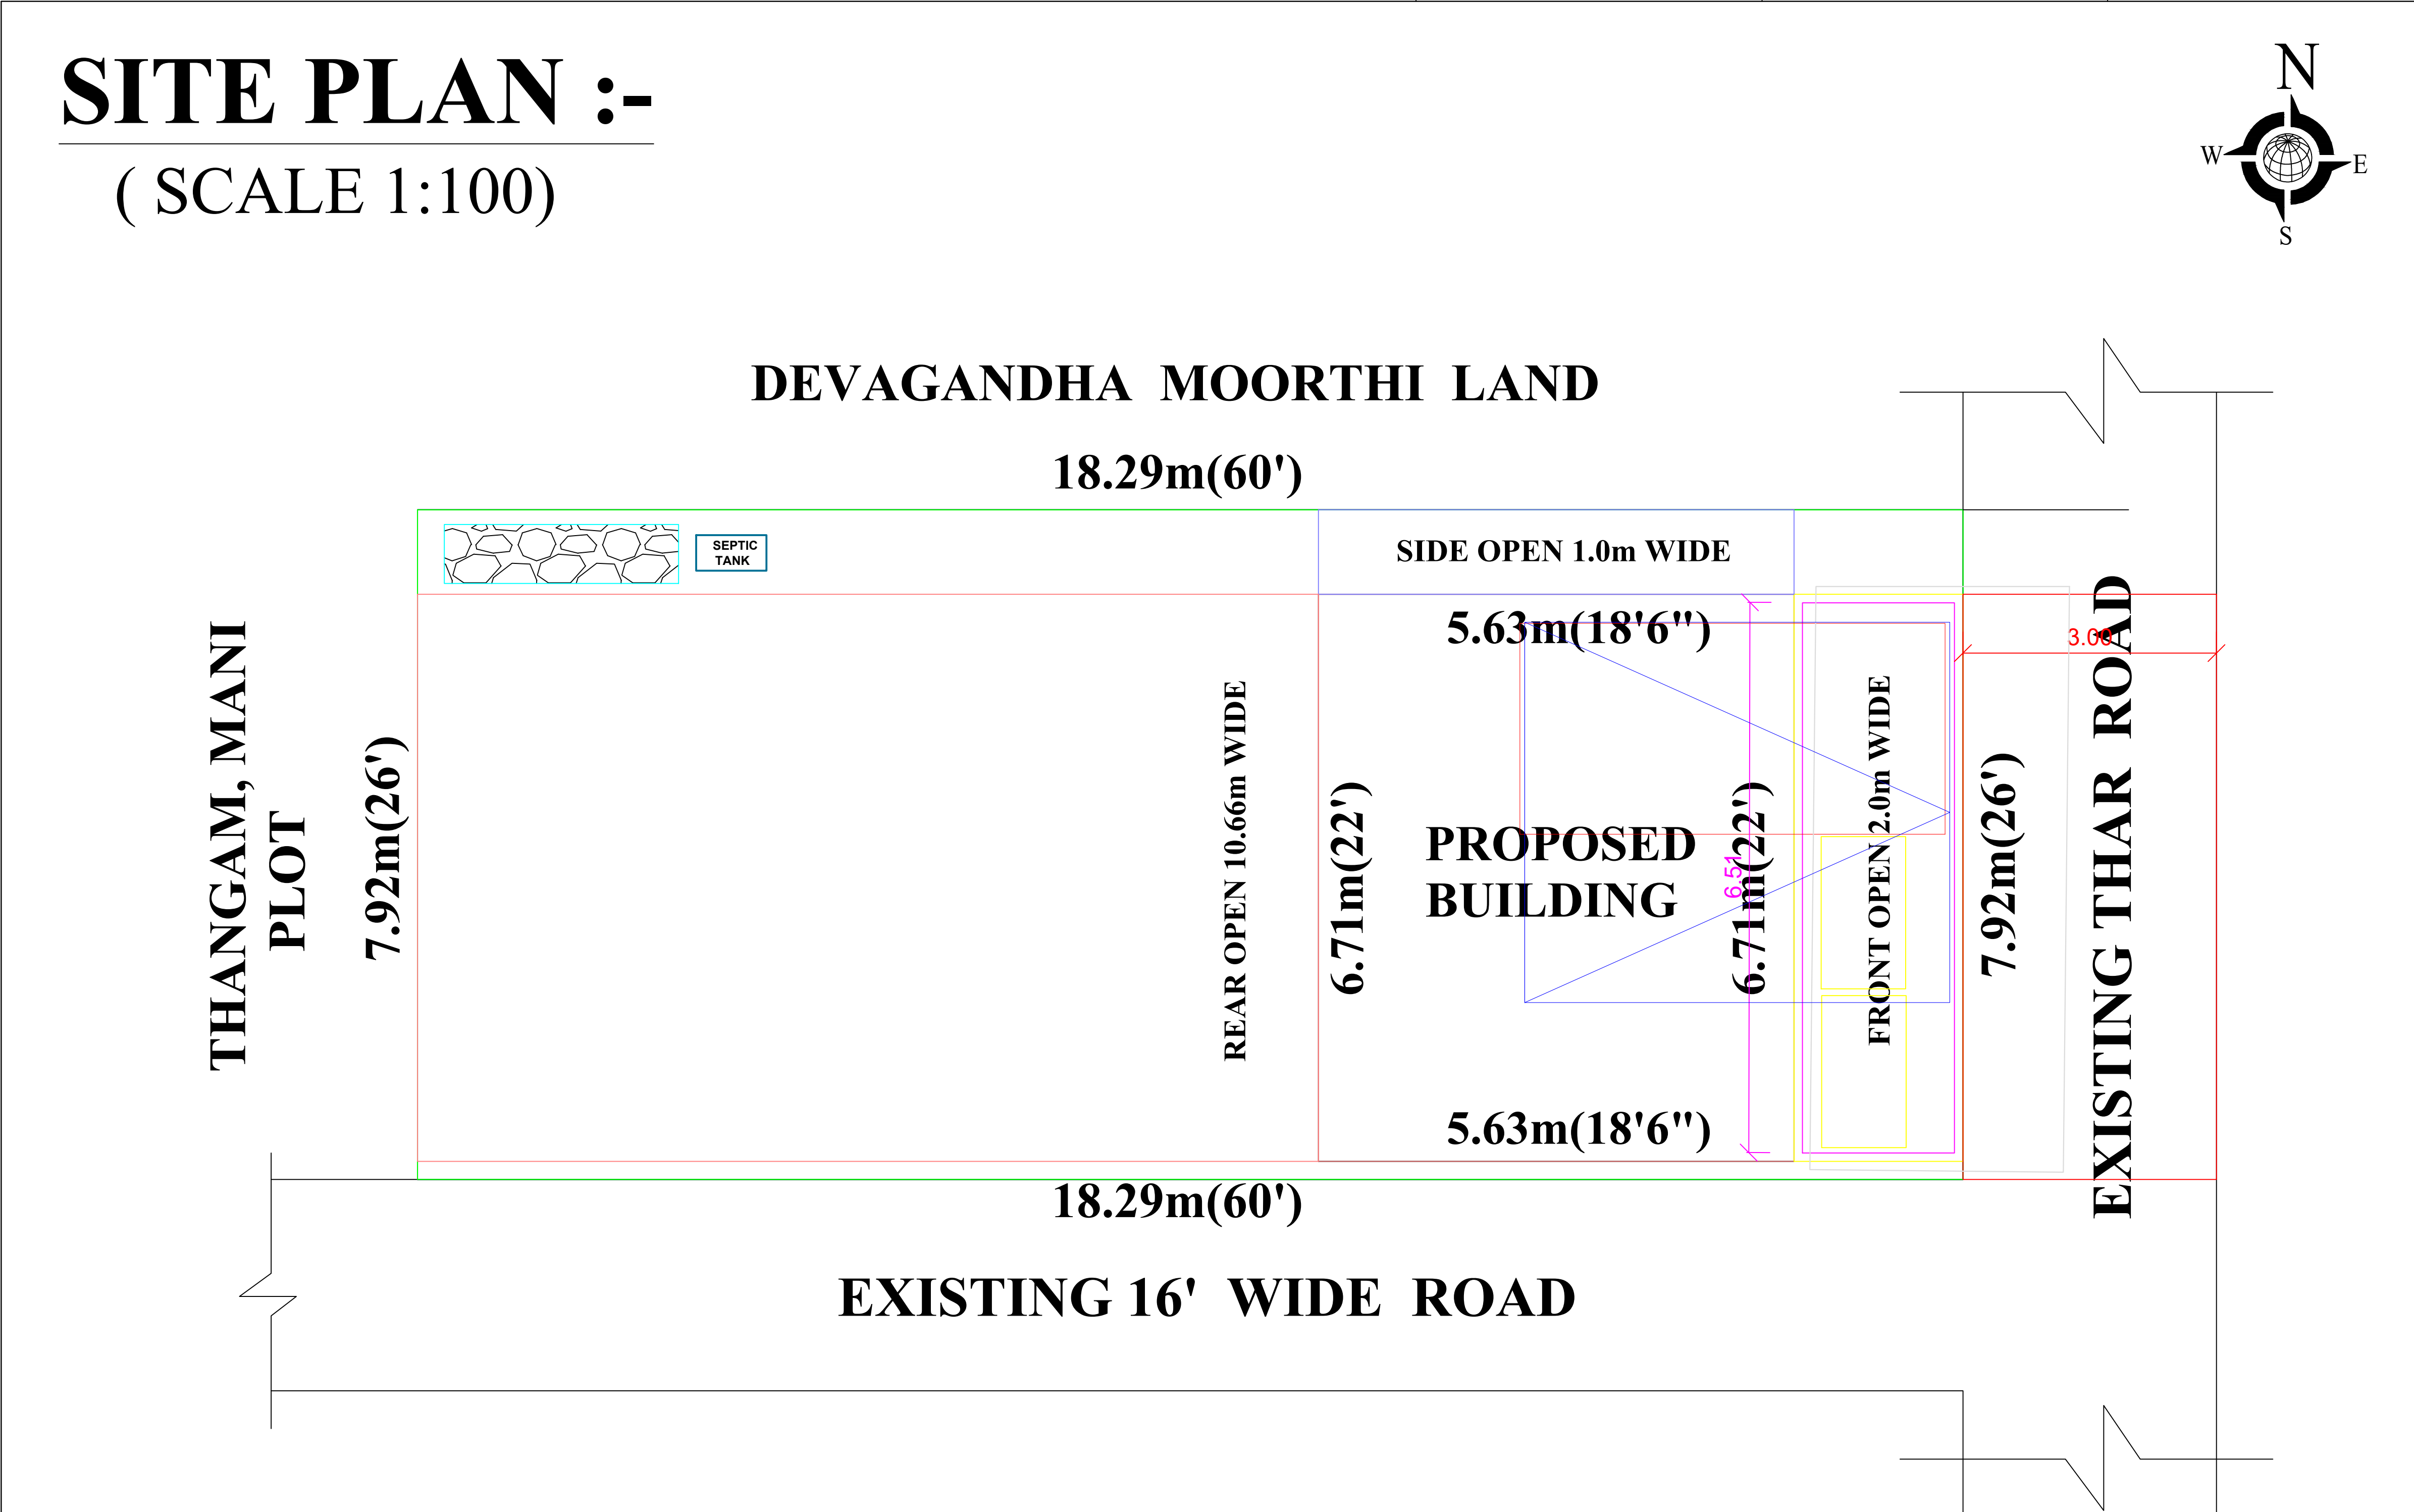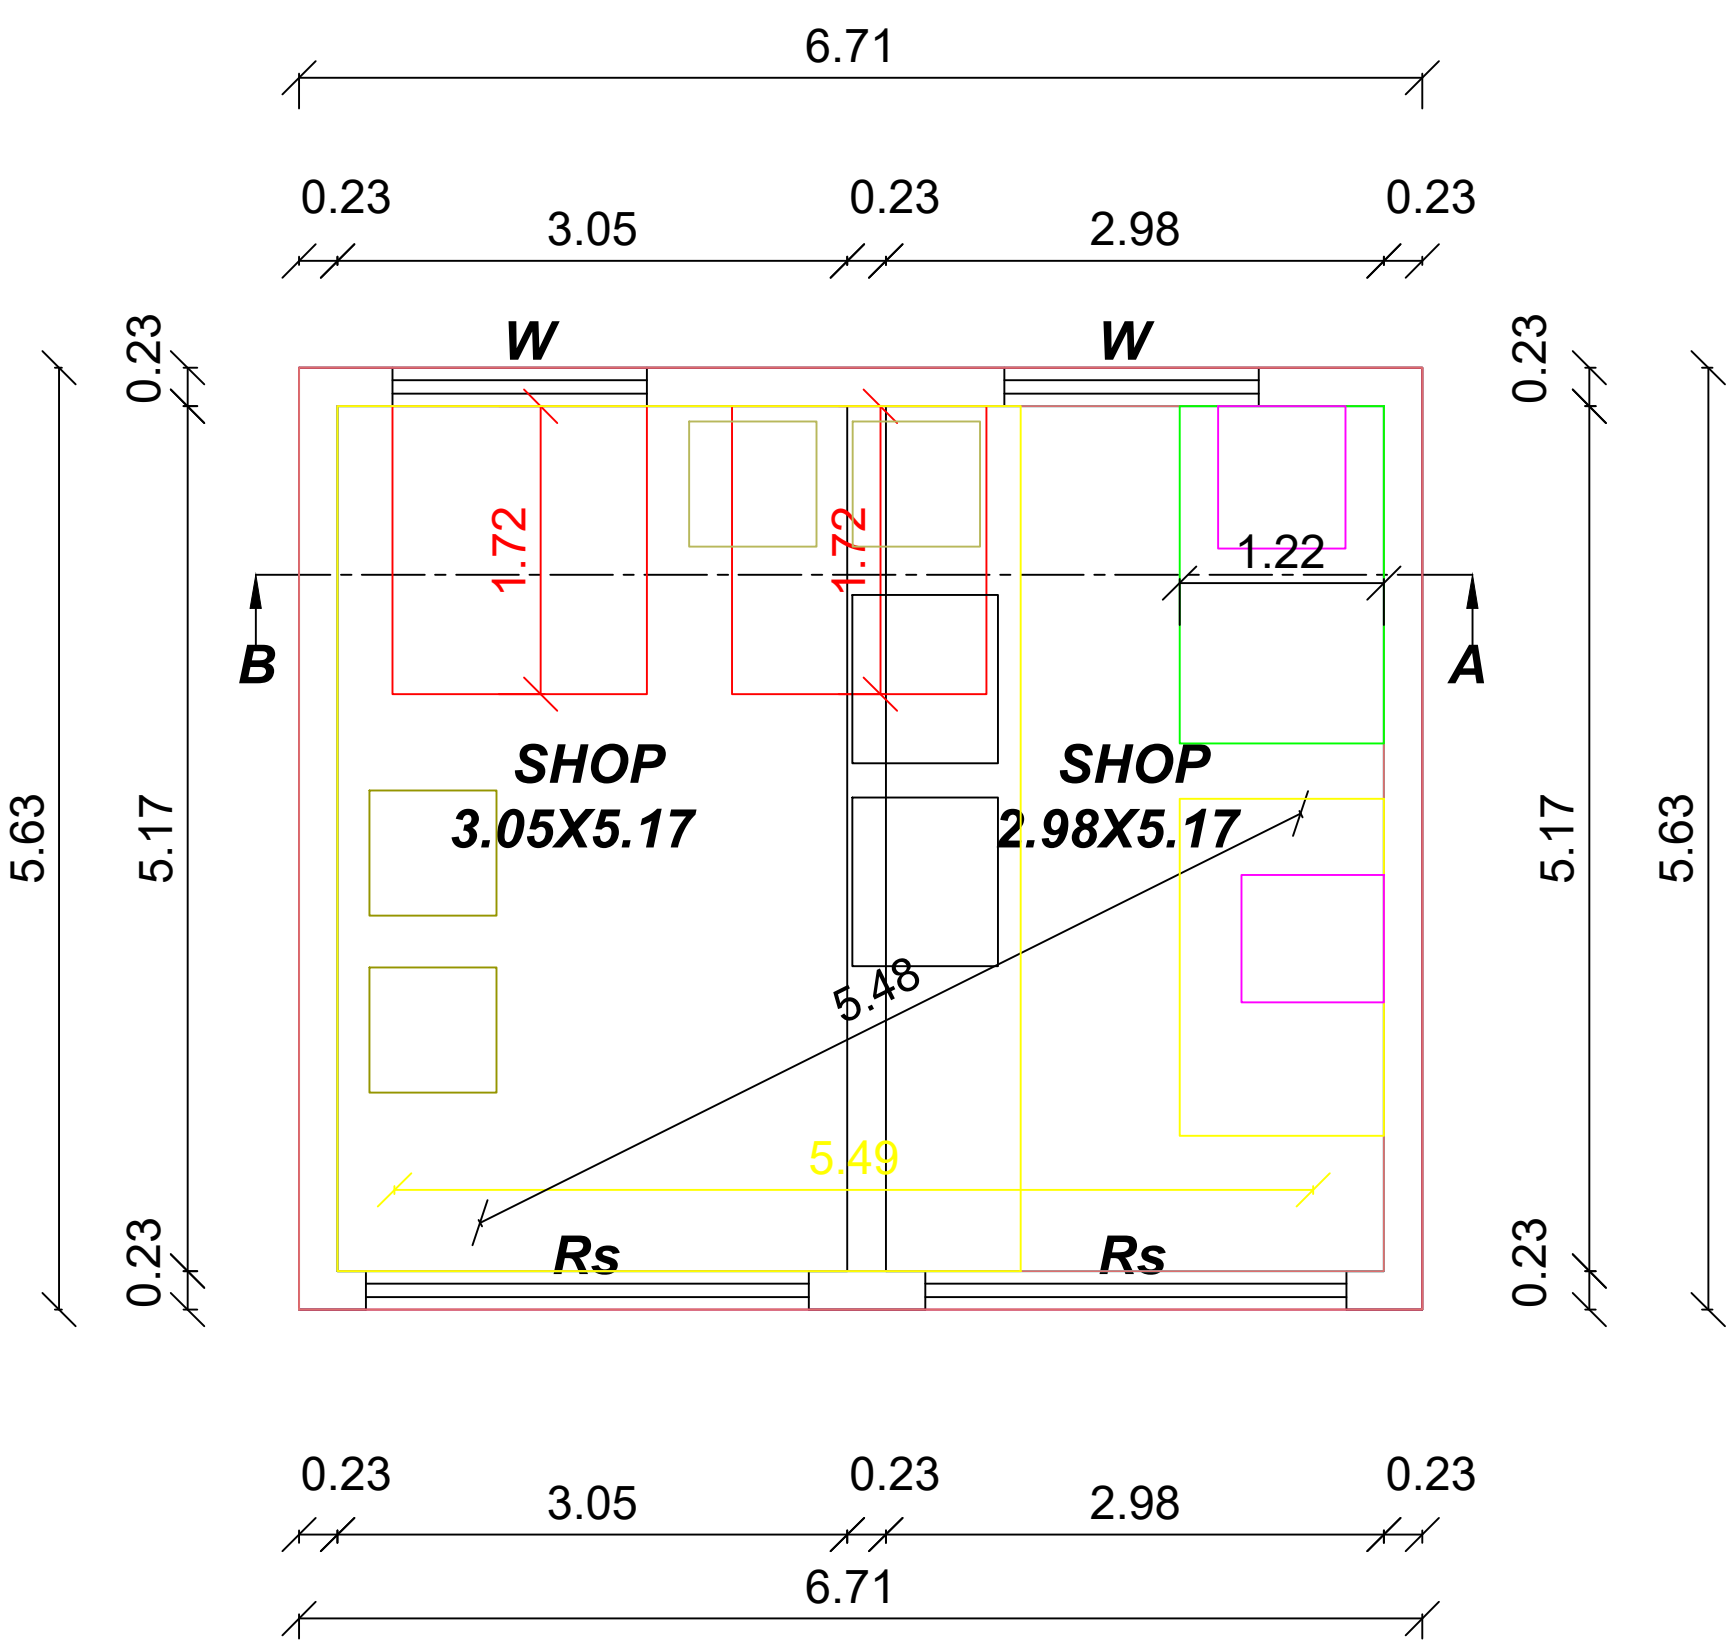

APPLICANT SIGN

MURUGAN BUILDERS
Er.M.MOORTHY,BE.,AMIE.,
Register Engineer & Consulting Engineer
License Building Surveyor
Kadai Veedhi,Viswanath Theatre Complex
Attur(Tk),Salem(Dt)-636102
Cell:8098282722,9787419995

ENGINEER