



PLAN SHOWING THE PROPOSED CONSTRUCTION OF R.C.C TERRACED ROOF GROUND FLOOR RESIDENTIAL BUILDING IN S.NO :5/11J2B, ATTAVANAI POOLAVARI VILLAGE, UTHAMASOLAPURAM VILLAGE PANCHAYAT, VEERAPANDI UNION, SALEM SOUTH TALUK., SALEM DISTRICT.


NAME OF THE APPLICANT: Mrs.A.VASANTHI, W/o. Mr. AMMASI.

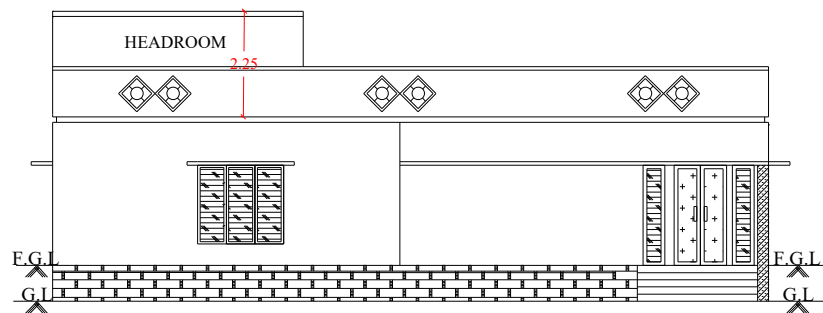


FRONT ELEVATION

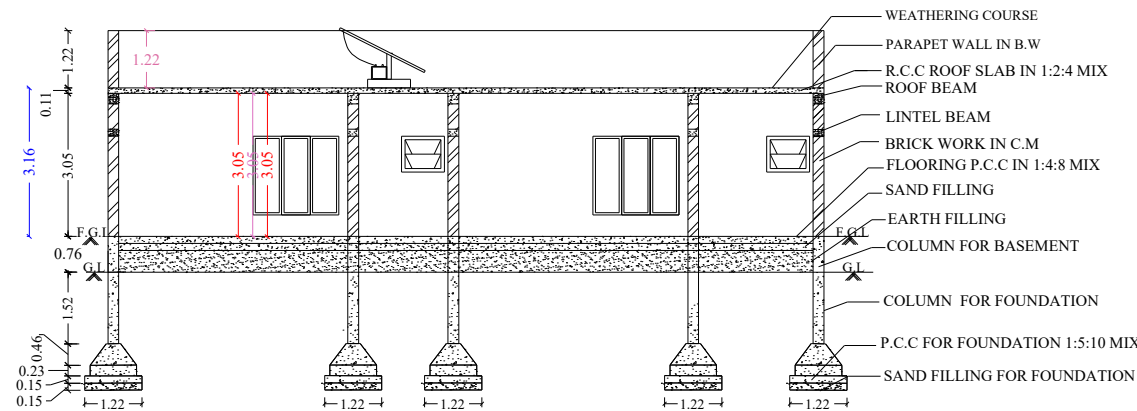

SECTION ON -AA

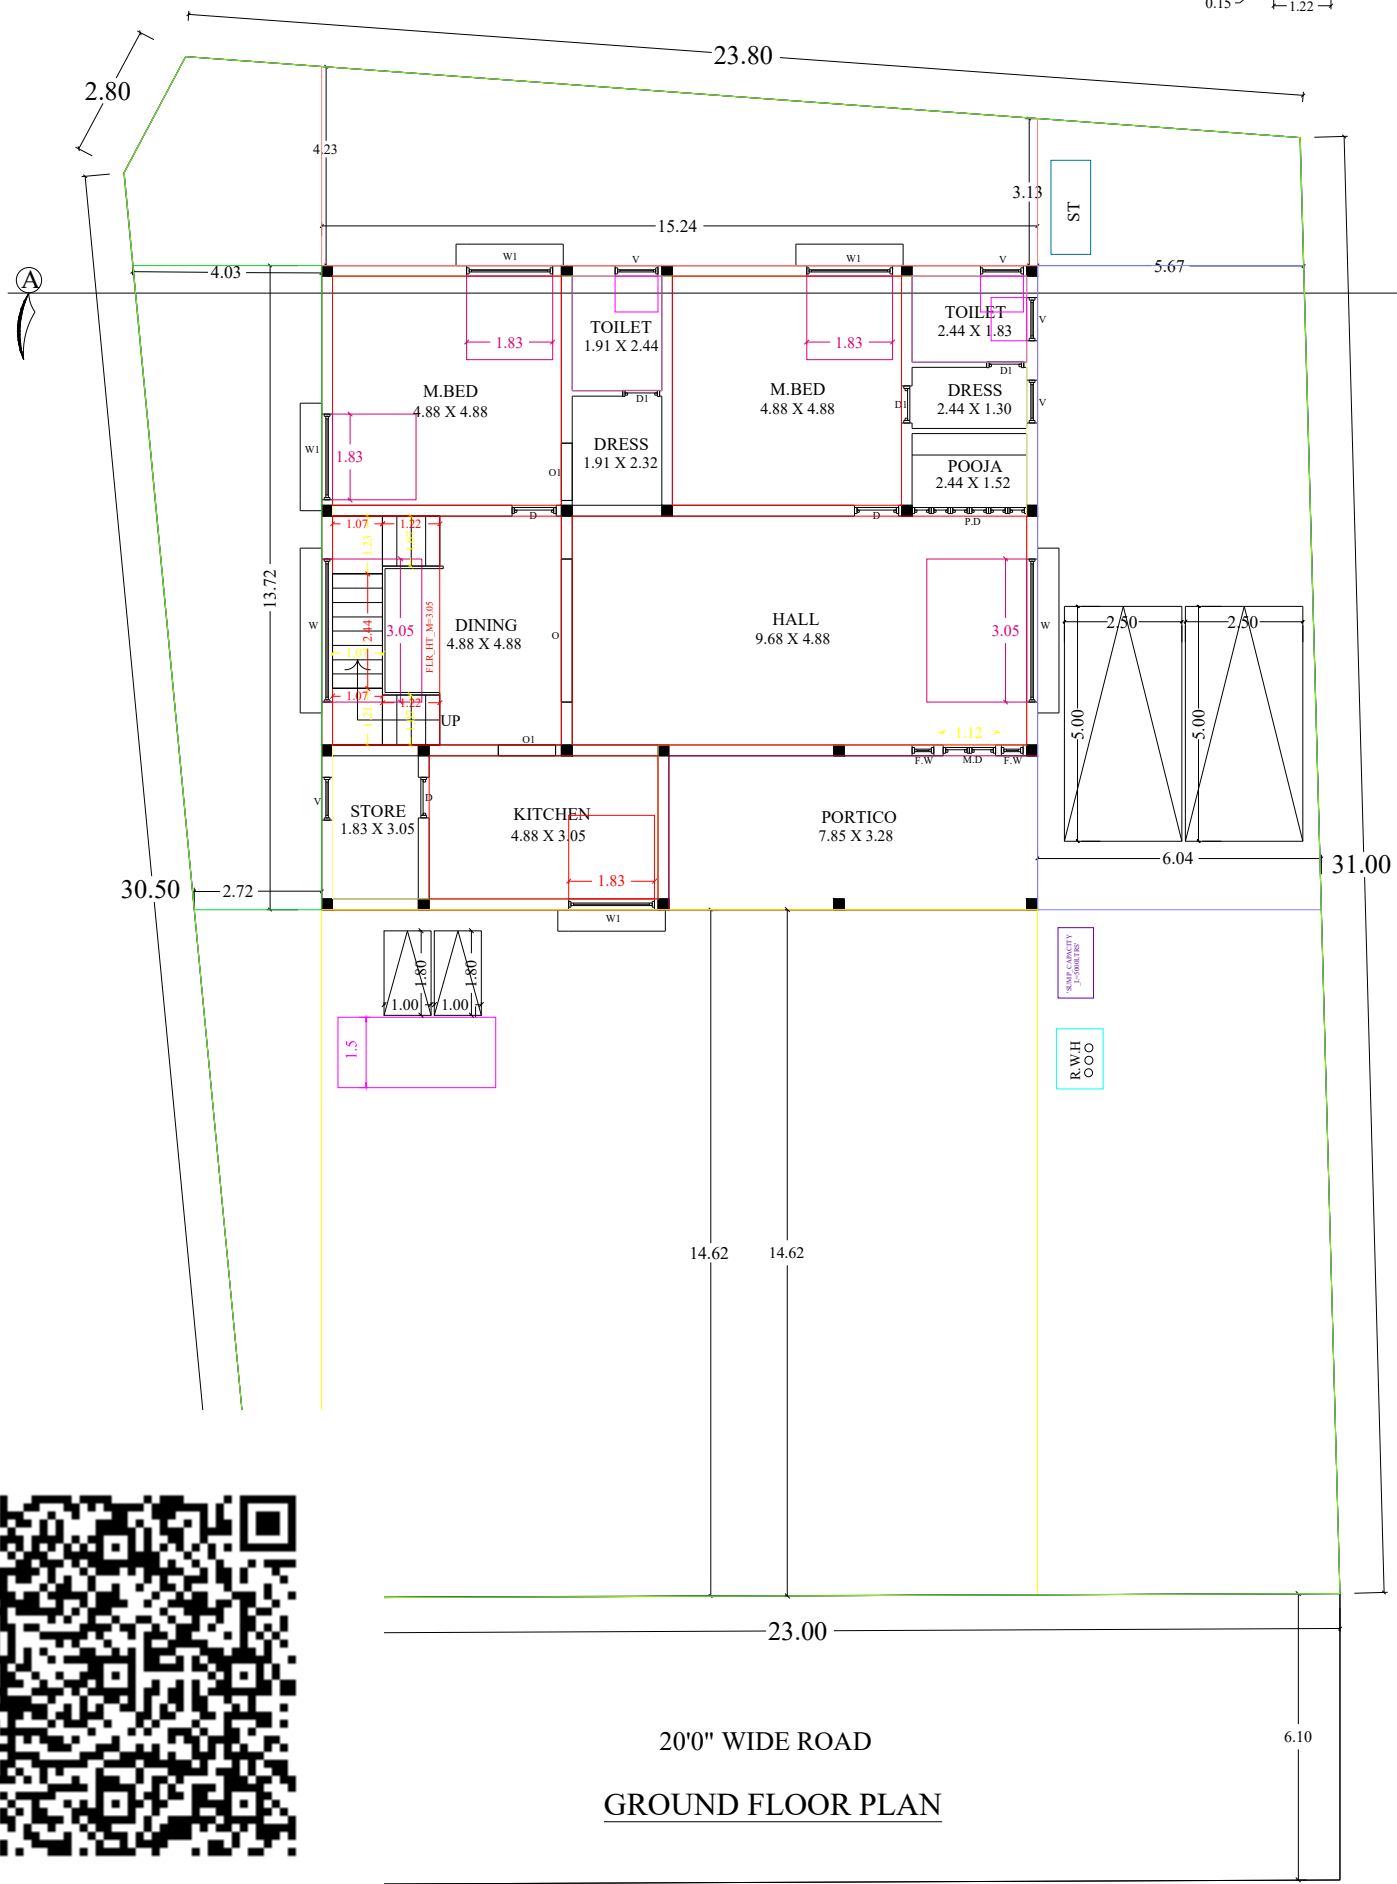


20'0" WIDE ROAD
GROUND FLOOR PLAN

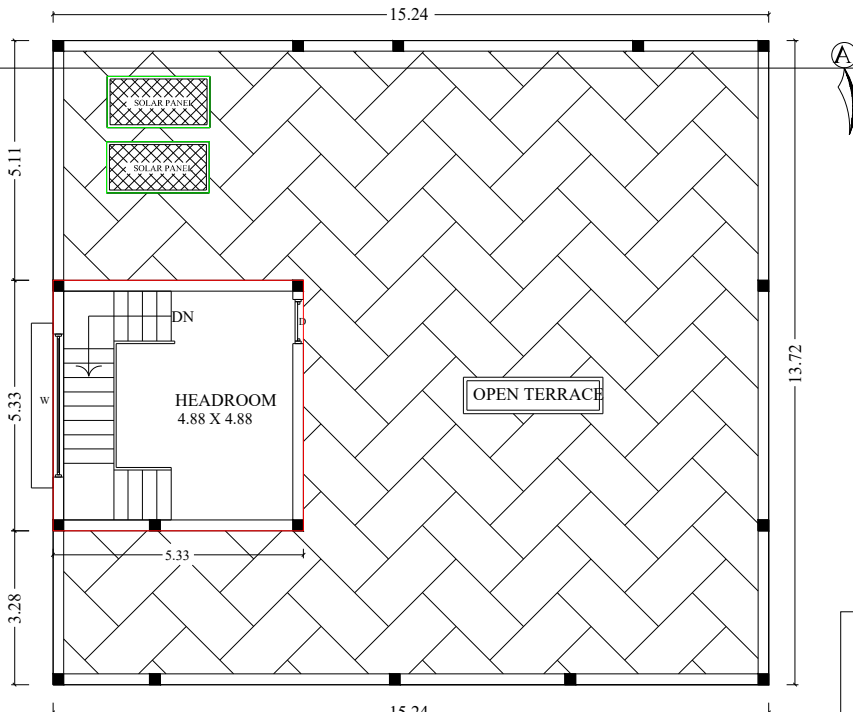

TERRACE FLOOR PLAN

SITE PLAN :
SCALE 1: 200

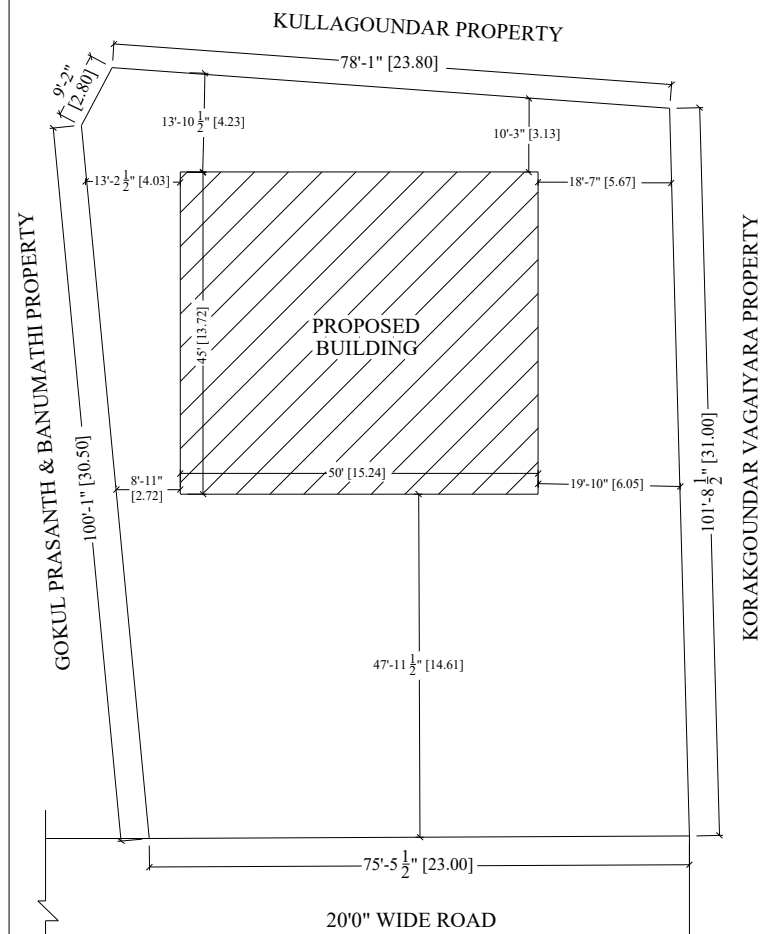

AREA DETAILS :-

		A 0.17.75 CENTS	
1.	AREA OF THE SITE	718.31 S.M	7732.00 S.FT
2.	GROUND FLOOR AREA	209.03 S.M	2250.00 S.FT
3.	HEADROOM AREA	28.43 S.M	306.00 S.FT
4.	TOTAL AREA	237.46 S.M	2556.00 S.FT
5.	VACANT AREA	509.28 S.M	5482.00 S.FT

JOINERY DETAILS :-

S.NO	DESCRIPTION	SIZE IN M
1	MAIN DOOR - M.D	1.22 X 2.14
2	DOOR - D	0.91 X 2.14
3	DOOR - DI	0.76 X 2.14
4	POOJA DOOR - P.D	2.44 X 2.14
5	OPEN - O	3.05 X 2.14
6	OPEN - OI	0.91 X 2.14
7	WINDOW - W	3.05 X 1.83
8	WINDOW-WI	1.83 X 1.83
9	FRENCH WINDOW-FW	0.45 X 2.14
10	VENTILATOR - V	0.91 X 0.76

SCALE :-

ALL DIMENSIONS ARE IN FEET & METER
SCALE 1 : 100 OR 1" = 8'0"

LEGEND :-


BOUNDRY SHOWN IN - 
PROPOSED SHOWN IN - 
ROAD SHOWN IN - 

APPLICANT :-


A. vasanthi

ENGINEER :-


KEY PLAN :
NOT TO SCALE

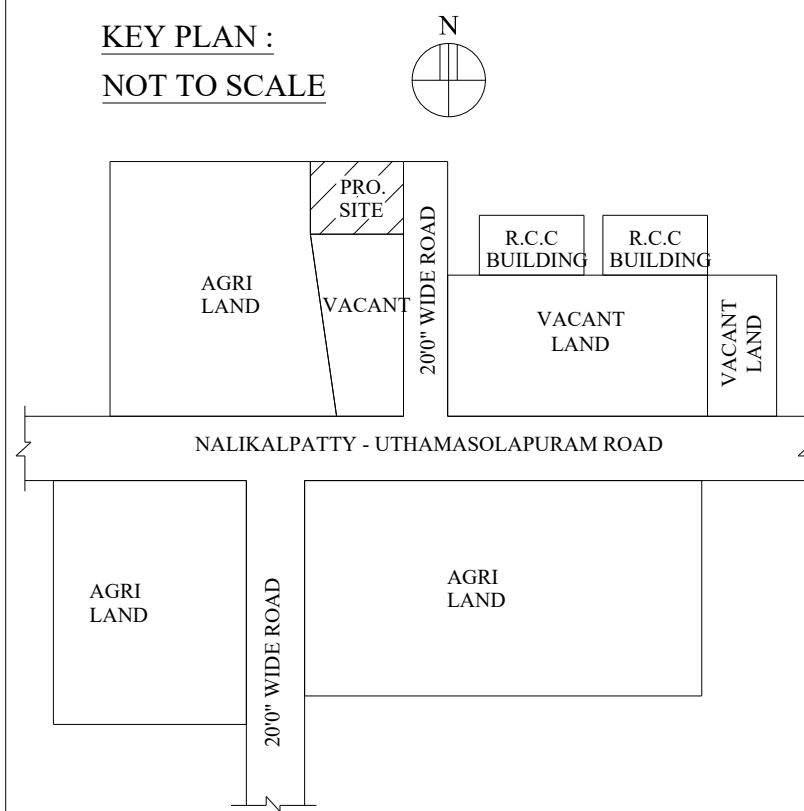


STAIR CASE DETAILS:-

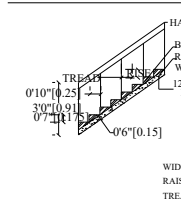


SOLAR SYSTEM

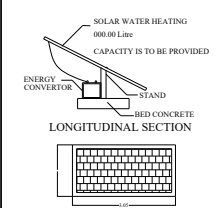

SEPTIC TANK:-

 

RAIN WATER HARVESTING:-

 


Dr. J. SANKAR, P.E., M.E., M.S.E., M.I.S.T.E.,
SURRYA BUILDERS
Reg. Engineer (Grade I), Reg. Structural Engineer (Grade I),
Reg. Construction Engineer, Reg. Quality Auditor & Supervisor,
Consulting Civil Engineer, Vasthu Consultant, Architectural
Designer, Total Station Land Surveyor, Interior Decorator & Planner.
535/2/2-C, Nethaji Nagar, Near Pillayar Temple,
Central Jail Backside, Near Hasthampatty Water Tank,
HASTHAMPTTY, SALEM-636 007.
Call: 94432 07766, 94432 07780, Off: 0427-2314705