



PLAN SHOWING THE PROPOSED CONSTRUCTION OF R.C.C. ROOF RESIDENTIAL GROUND FLOOR AND FIRST FLOOR BUILDING IN OLD S.NO:440, NEW S.NO:440/8, PATTA NO:5378, ERUMAPALAYAM VILLAGE AND SANYASIGUNDU PANCHAYAT , SALEM TALUK, SALEM DISTRICT.

APPLICANT NAME: Mr.S.JOSEPH.,

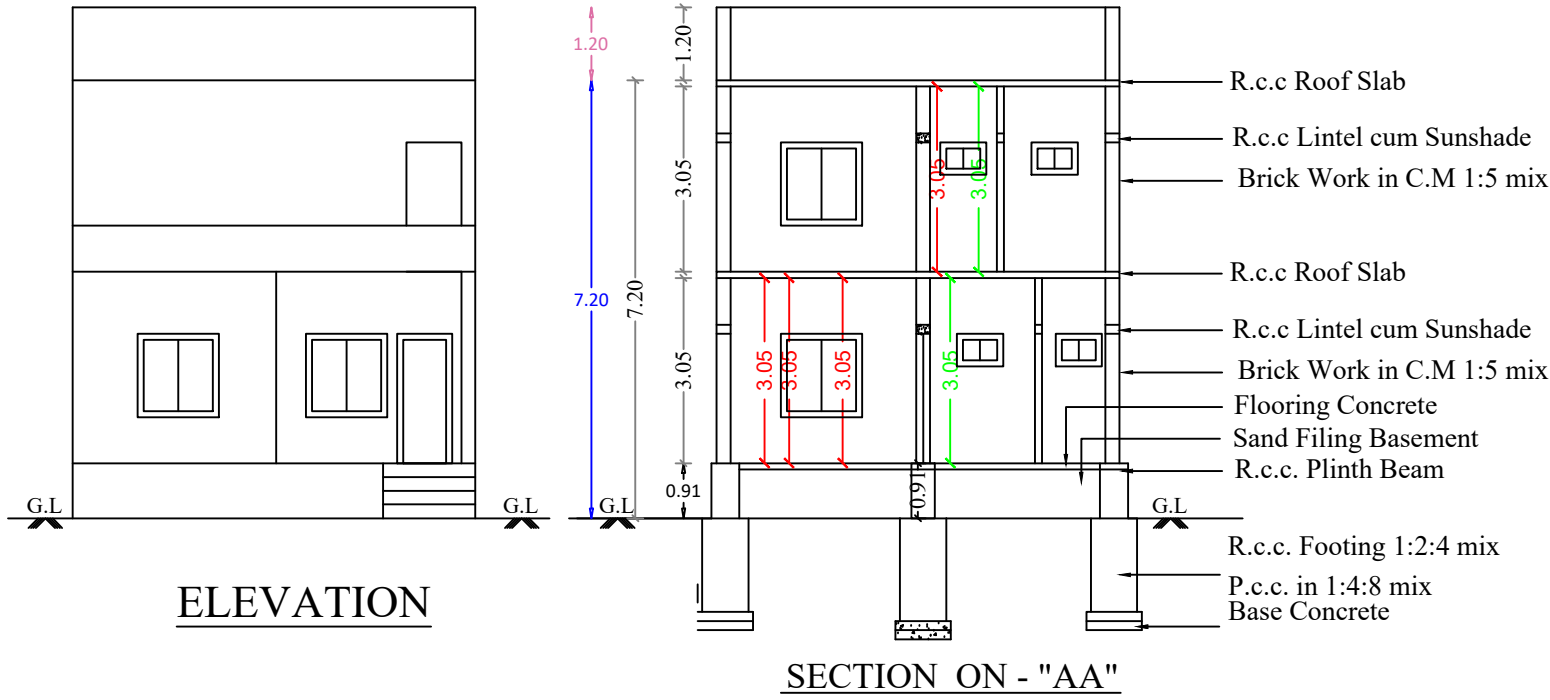

KEY PLAN

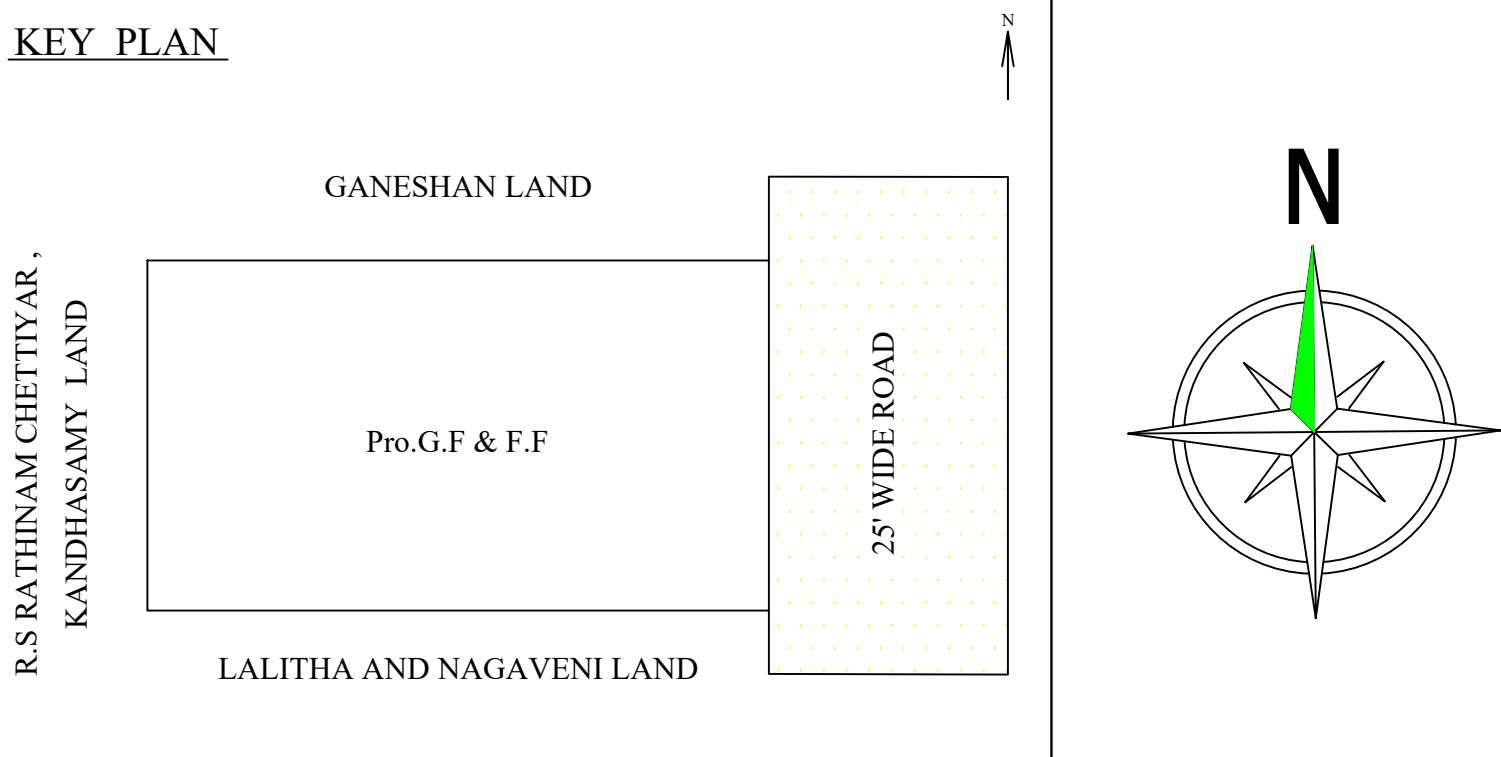

APPROVAL AUTHORITY

COLOR INDEX

	SITE BOUNDRY
	PRO. R.C.C ROOF RESIDENTIAL BUILDING
	ROAD DETAILS

PARKING STALL DETAILS

CAR SPACE	0	1
BIKE SPACE	0	1

SCALE = 1" = 8'-0" (1:100) All Dimensions Are In Meters


SCHEDULE OF JOINERIES

DESCRIPTION	SIZE IN FEET	SIZE IN M
Main Door - MD	3'6" x 7'0"	1.07 x 2.13
Door - D1	3'0" x 7'0"	0.91 x 2.13
Door - D2	2'9" x 7'0"	0.84 x 2.13
Open - O	4'0" x 7'0"	1.22 x 2.13
Window - W1	4'0" x 4'0"	1.22 x 1.22
Kitchen Window - KW	4'0" x 3'6"	1.22 x 1.06
Ventilator - V	2'6" x 2'0"	0.76 x 0.61

AREA OF THE PROPOSED CONSTRUCTION DETAILS


DESCRIPTION	SQ.FT	SQ.M
Area of the Site (as per Document)	1500.00	139.35
Plinth Area of the Ground Floor	1196.31	111.14
Plinth Area of the First Floor	372.97	34.65
Total Floor Area	1569.28	145.79

FSI = Total Builtup Area / Total Site Area = 1.04

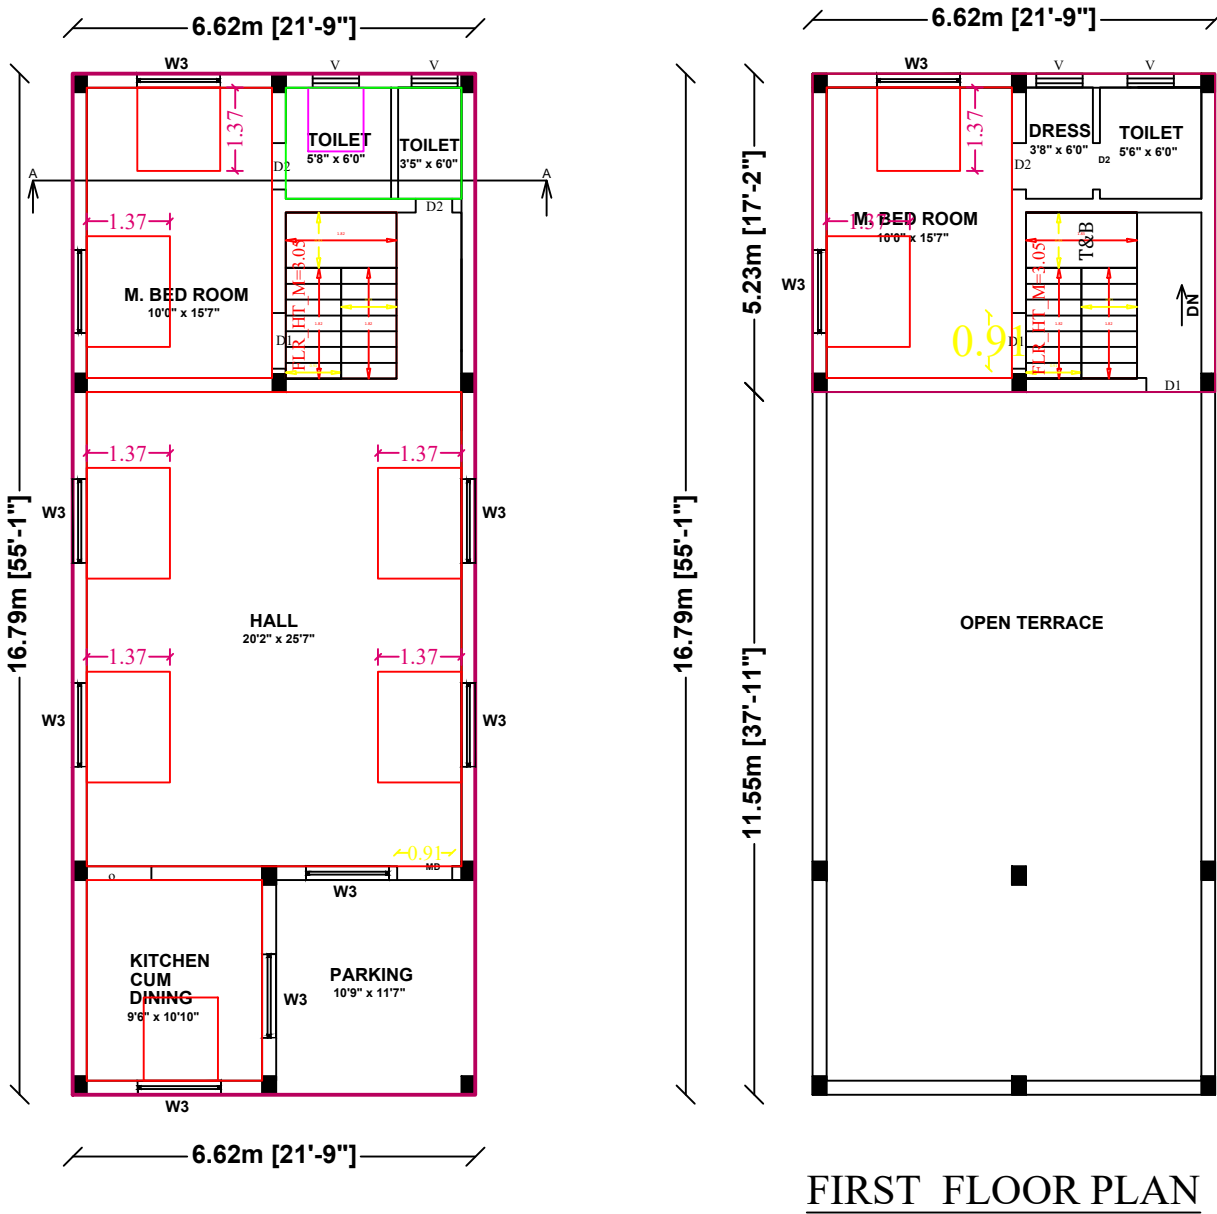

SITE PLAN


SCALE - 1:100

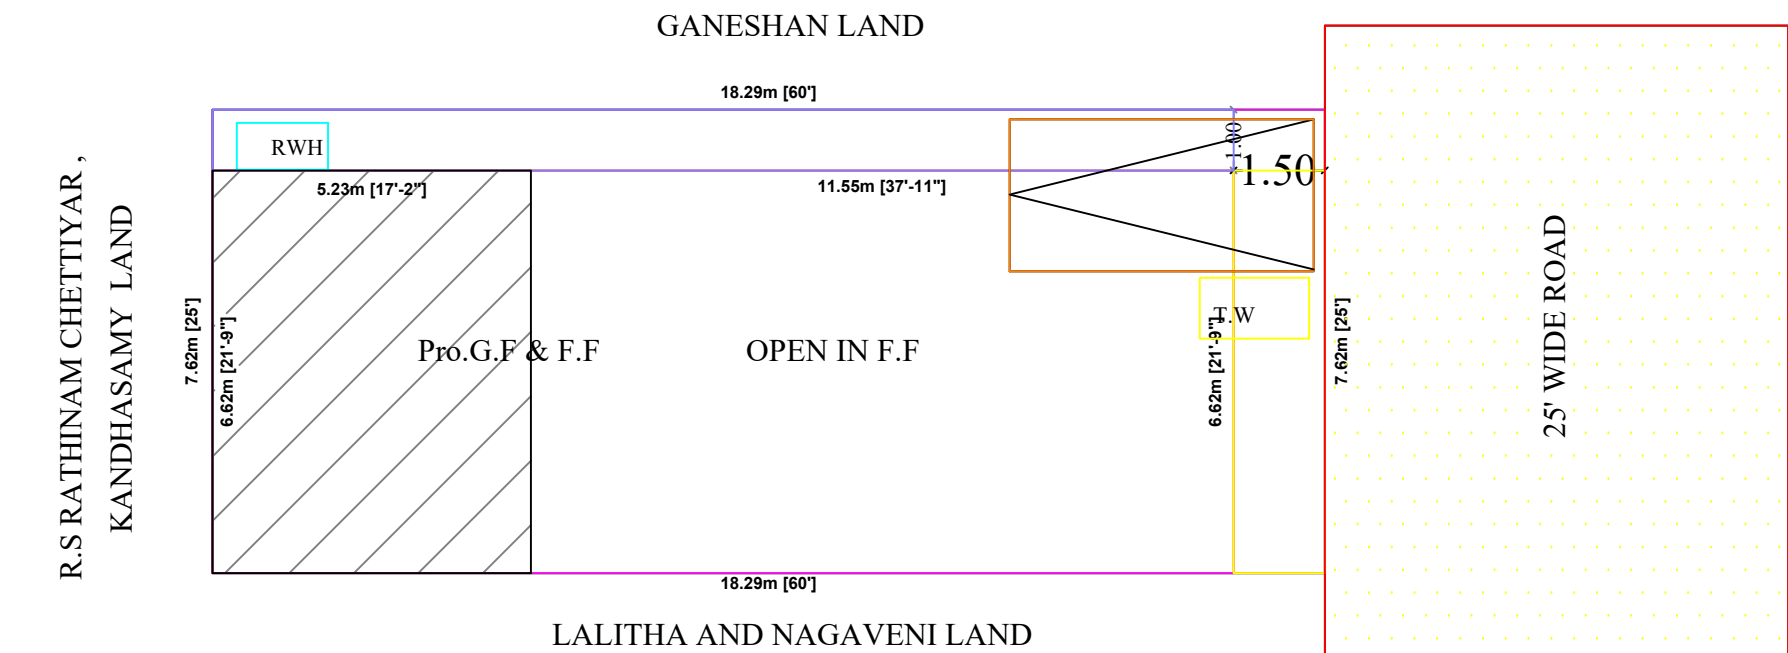

APPLICANT SIGN





P.V.C CASING PIPE
A.P.V.C SUCTION PIPE
P.V.C VENT PIPE

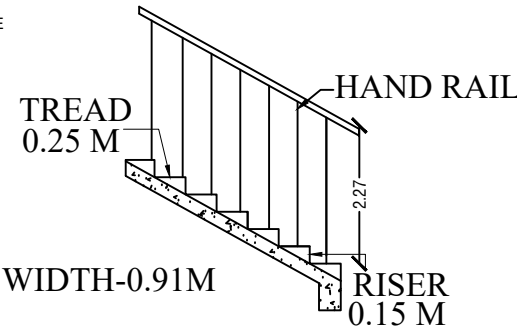


BORE WELL

STAIRCASE DETAILS

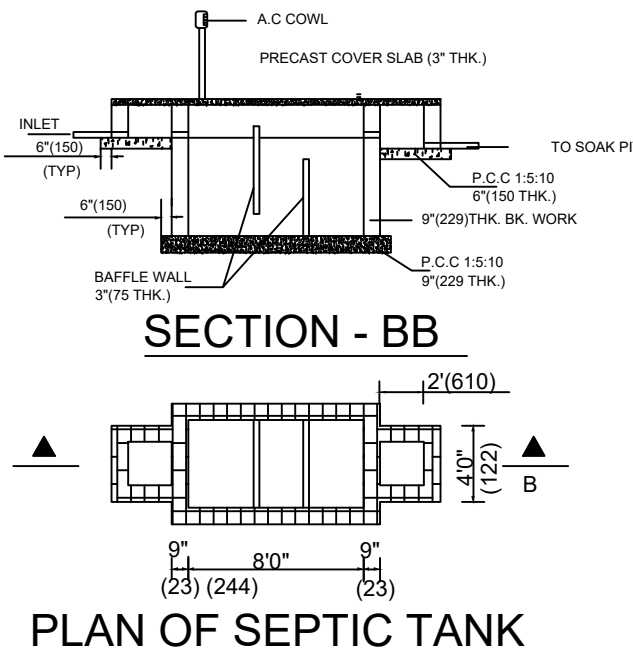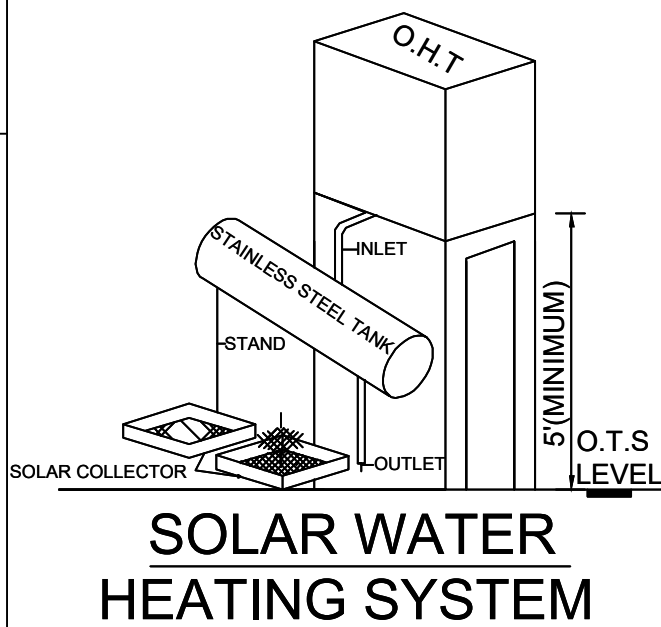

PLAN OF SEPTIC TANK

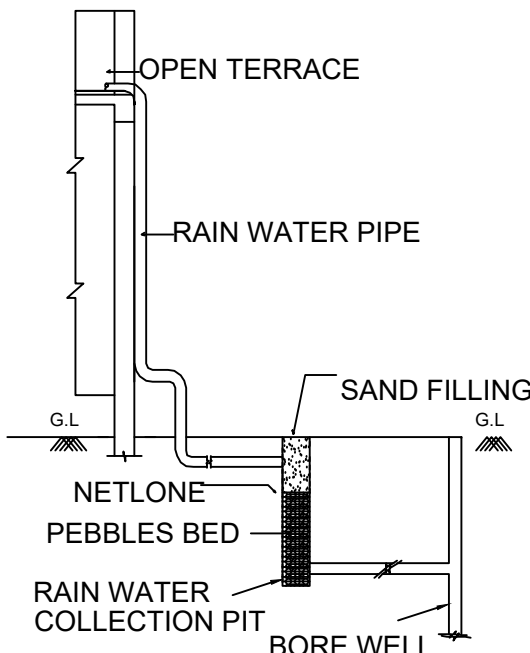

ENGINEER / L.B.S