



PLAN SHOWING THE PROPOSED CONSTRUCTION OF AC SHEET ROOF COMMERCIAL BUILDING IN (OLD) S.NO - 149/5, (NEW) S.NO - 149/5B, PATTA NO - 2012, AT PACHANAMPATTI VILLAGE PANCHAYATH, OMALUR PANCHAYATH UNION, OMALUR TALUK & SALEM DT.


NAME OF THE APPLICANT:- Mr. P. GUNASEKARAN S/o Mr. PALANI MUTHU.

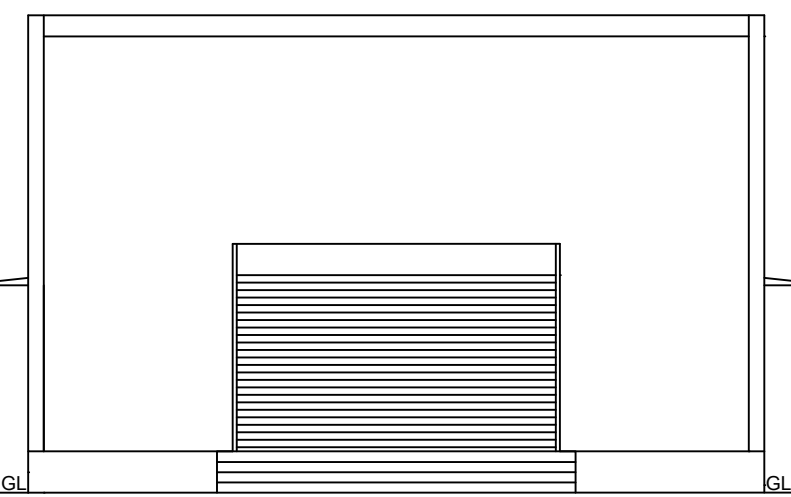


FRONT ELEVATION

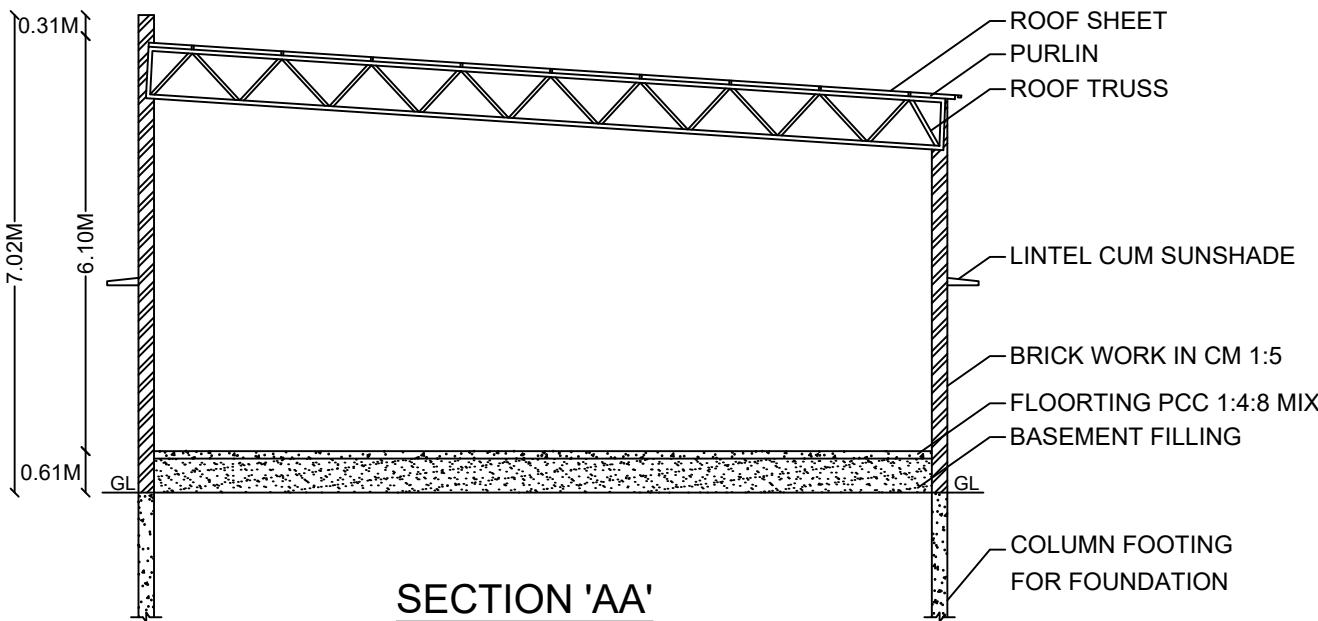

SECTION 'AA'

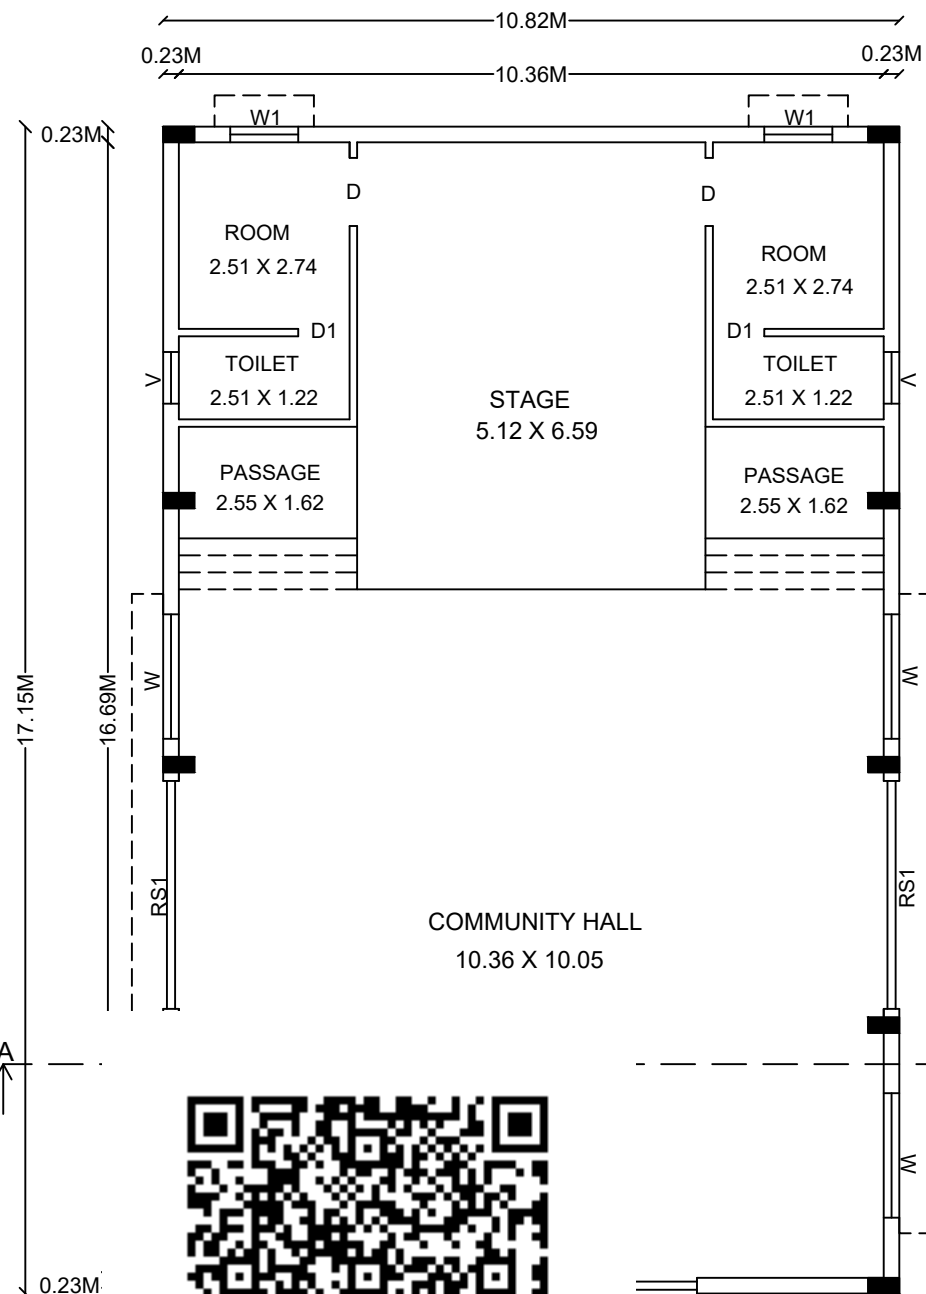


KEY PLAN:-
(NOT TO SCALE)

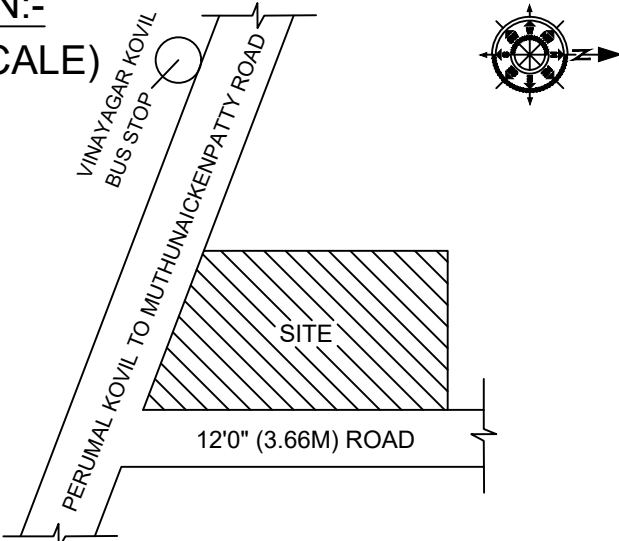

JOINERY DETAILS :-

S.NO	DESCRIPTION	SIZE IN M
1.	ROLLING SHUTTER -RS	4.88 X3.05
2.	ROLLING SHUTTER -RS1	3.35 X3.05
3.	DOOR - D	1.00 X 2.14
4.	DOOR - D1	0.76 X 2.14
5.	WINDOW - W	1.83 X 1.37
6.	WINDOW - W1	1.00 X 1.37
7.	VENTILATOR - V	0.91 X 0.91


SITE PLAN:-
(SCALE 1:500)

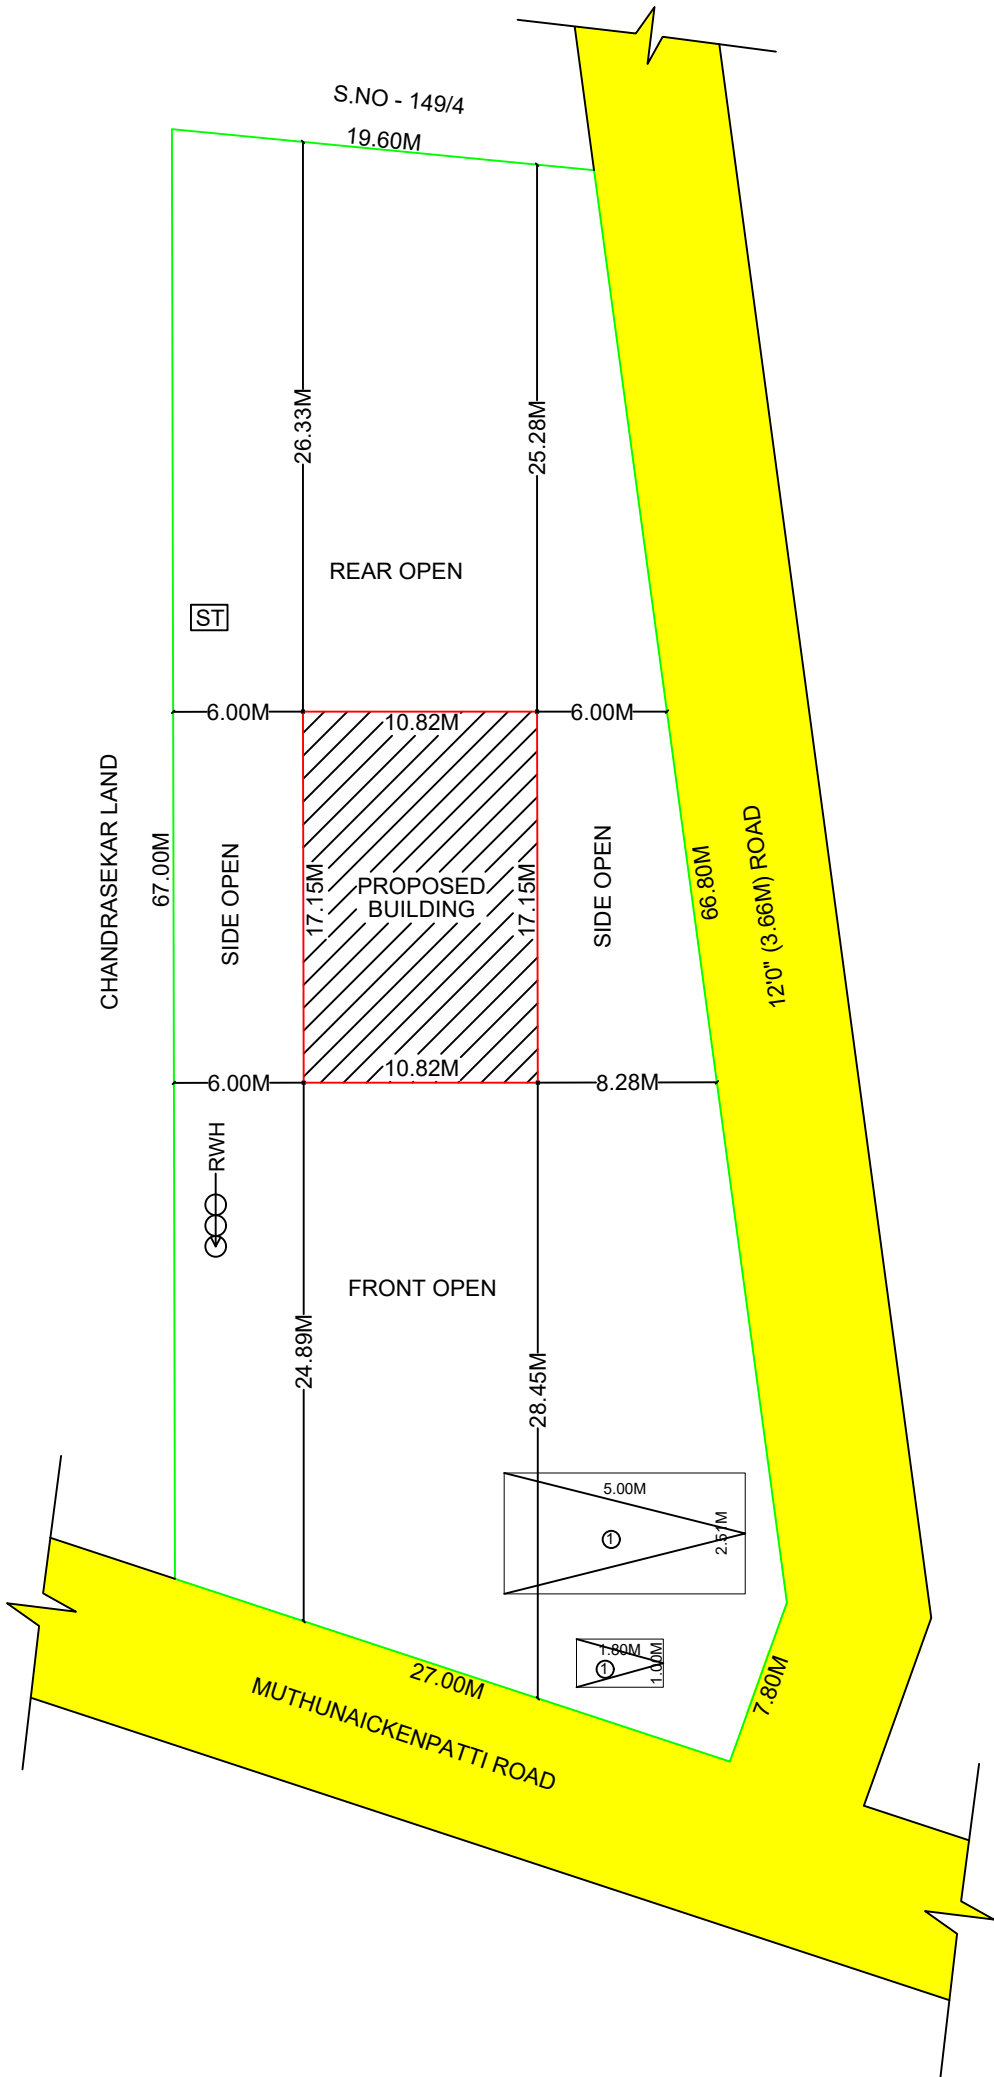


AREA DETAILS :-

		PHASE - I	
S.NO	DESCRIPTION	IN SQ.FT	IN SQ.M
1.	AREA OF THE SITE	18295.20	1699.67
2.	GROUND FLOOR AREA	1997.75	185.59
3.	AREA OF OPEN SPACE	16297.45	1514.07



RAIN WATER HARVESTING:

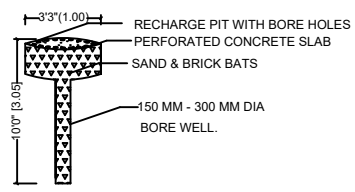


SOLAR SYSTEM (10,000 LT CAPACITY)

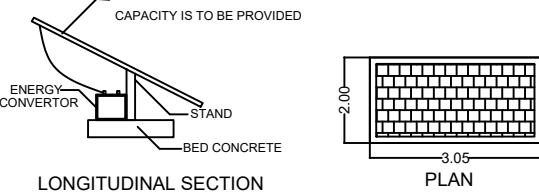

SEWAGE TREATMENT PLANT

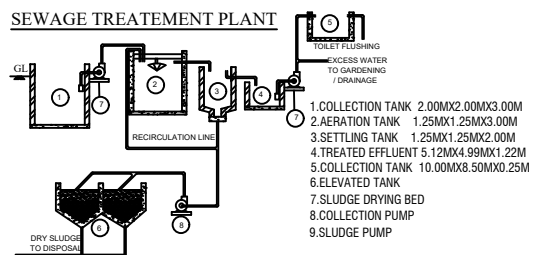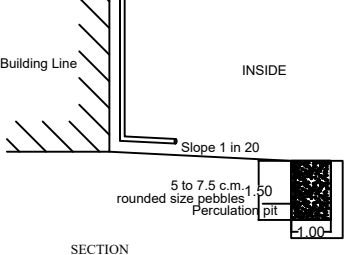

FOUNDATION DETAILS

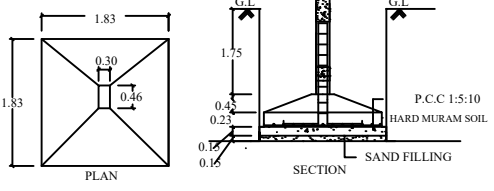

SCALE :-


ALL DIMENSIONS ARE IN METER

SCALE 1 : 100


PARKING DETAILS :-

VEHICLES	REQUIRED	PROVIDED
CAR PARKING	1 Nos.	1 Nos.
TWO WHEELAR	1 Nos.	1 Nos.

SEPTIC TANK

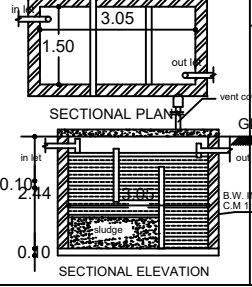

STAIR CASE DETAILS:-

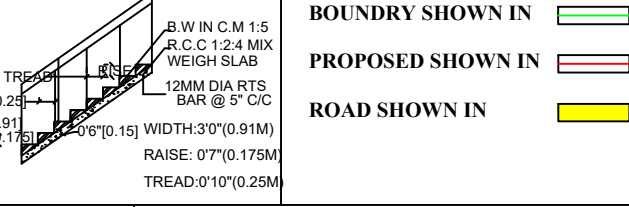

APPLICANT:-

REGISTER ENGINEER:-

P. Gunasekaran

Er. R. VIMALRAJ, B.E.,
R.V.CONSTRUCTION
Register Engineer (Grade - III) Reg.No.229,
16, Seerangapalayam Main Road,
Kumarasampatty, Salem - 7.
Cell : 94452 05401