

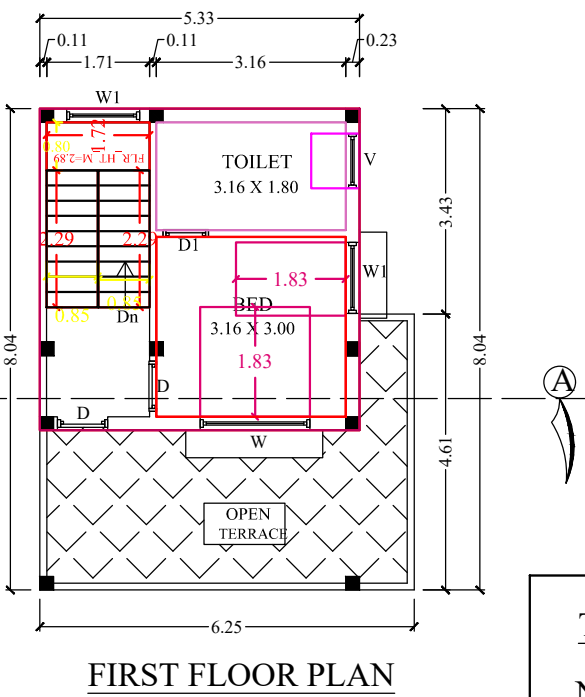


PLAN SHOWING THE PROPOSED CONSTRUCTION OF R.C.C TERRACED ROOF GROUND AND FIRST FLOOR RESIDENTIAL BUILDING IN S.NO- 76/7, VILLA NO : 17, O2 GREENS, PATTIPADI VILLAGE PANCHAYATH, YERCAUD UNION, YERCAUD TALUK, YERCAUD SUB REG DT, SALEM EAST REG DISTRICT, SALEM DISTRICT.

NAME OF THE APPLICANT : Mr.C.S.PUNEETH, S/o. Mr.C.M.SIVAN.

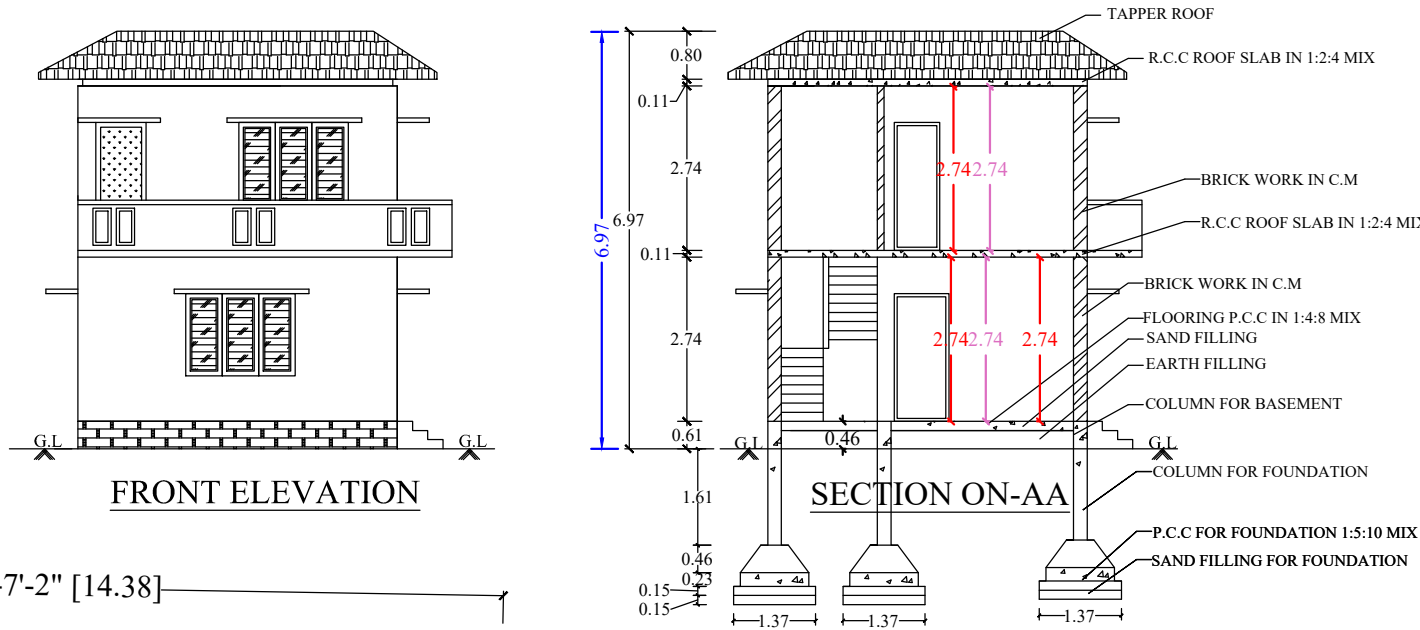

SITE PLAN :
SCALE : 1 : 200

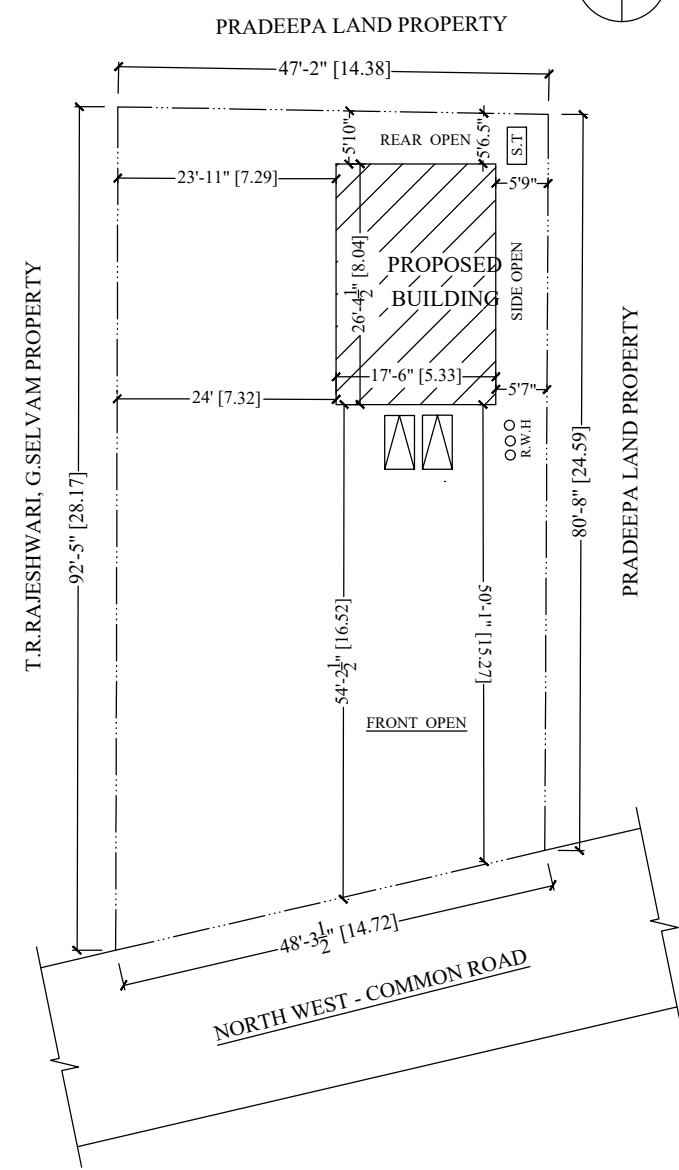


SCALE :-

ALL DIMENSIONS ARE IN FEET & METER
SCALE 1 : 100 OR 1" = 8'0"


LEGEND :-

BOUNDRY SHOWN IN -
PROPOSED SHOWN IN -
ROAD SHOWN IN -


RAIN WATER HARVESTING :-

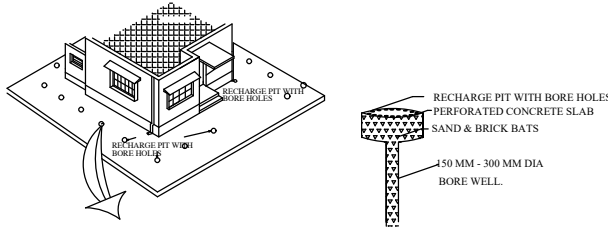

STAIR CASE DETAILS:

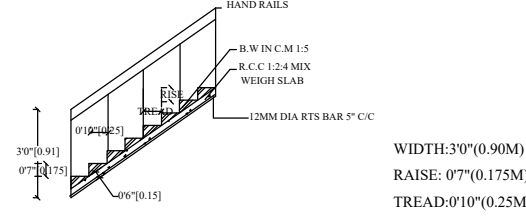

SEPTIC TANK:

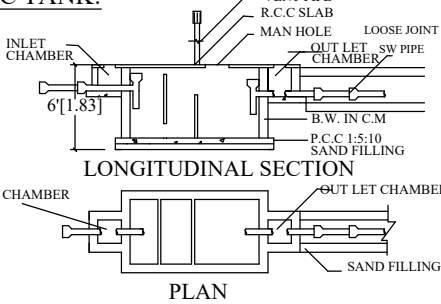

AREA DETAILS:-

		9.25 Cent	
1.	AREA OF THE SITE	4,029.30 S.FT	374.33 S.M
2.	GROUND FLOOR AREA	461.50 S.FT	42.87 S.M
3.	FIRST FLOOR AREA	308.50 S.FT	28.66 S.M
4.	TOTAL BUILDING AREA	770.00 S.FT	71.53 S.M
5.	VACANT AREA	3,567.80 S.FT	331.46 S.M

JOINERY DETAILS :-

S.NO	DESCRIPTION	SIZE IN FT	SIZE IN M
1	MAIN DOOR - M.D	3'6" X 7'0"	1.07 X 2.14
2	DOOR - D	3'0" X 7'0"	0.91 X 2.14
3	DOOR - D1	2'6" X 7'0"	0.76 X 2.14
4	OPEN - O	3'0" X 7'0"	0.91 X 2.14
5	WINDOW - W	6'0" X 4'0"	1.83 X 1.22
6	WINDOW - W1	4'0" X 4'0"	1.22 X 1.22
7	VENTILATOR - V	2'6" X 2'0"	0.76 X 0.61


APPLICANT:-

Puneeth


ENGINEER:-

Dr. J. SANKAR, P.E., M.A.S.T.E.,
SUREYA BUILDERS
Reg. Engineer (Grade I), Reg. Structural Engineer (Grade I),
Reg. Construction Engineer, Reg. Quality Auditor & Developer,
Consulting Civil Engineer, Visually Consultant, Architectural
Designer, Total Station Land Surveyor, Interior Decorator & Valuer,
538/12-C, Hethaji Nagar, Near Pillayar Temple,
Central Rail Bypass, Near Narayanasamy Water Tank,
HASTHAMPATTY, SALEM - 636 007.
Call: 94432 07766, 94432 07766, 095 0427-2314705

SEPTIC TANK:

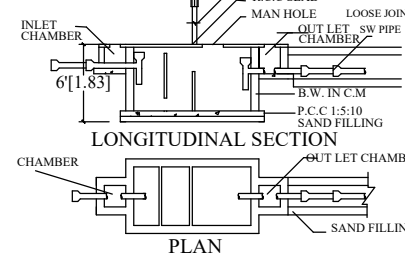

STAIR CASE DETAILS:

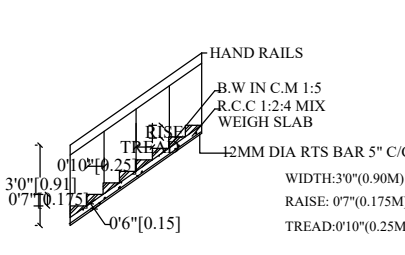

RAIN WATER HARVESTING :-

