


PLAN SHOWING THE PROPOSED CONSTRUCTION OF R.C.C. TERRACED ROOF GROUND FLOOR


RESIDENTIAL BUILDING PURPOSE AT S.F. NO: 150 / 1A, 150 / 3, NEW SUB-DN. S.F. NO: 150 / 1A6E, 150 / 3B3,

PATTA NO: 2168, AT MADATHUR, ERUMAIPATTI VILLAGE & PANCHAYAT, KONGANAPURAM UNION, EDAPPADY TALUK, SALEM DISTRICT,


APPLICANT : Tmt. P. UMAMAHESWARI,
W/O. THIRU. VENKATESAN.

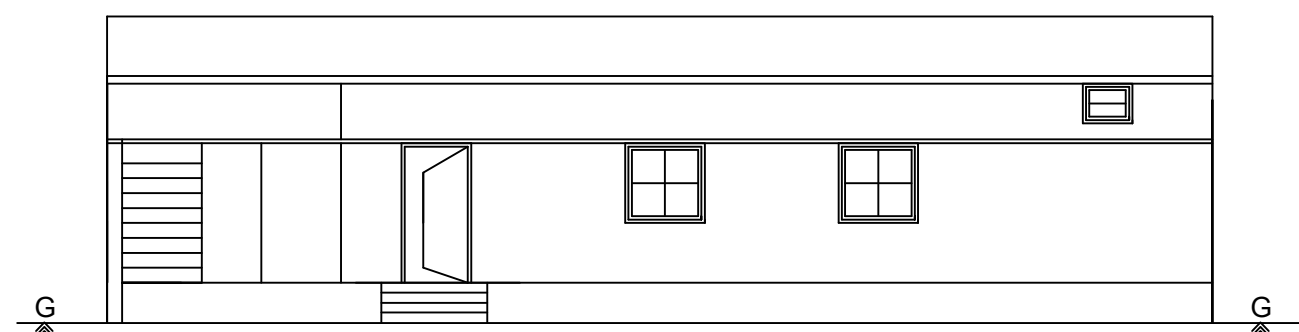


FRONT ELEVATION

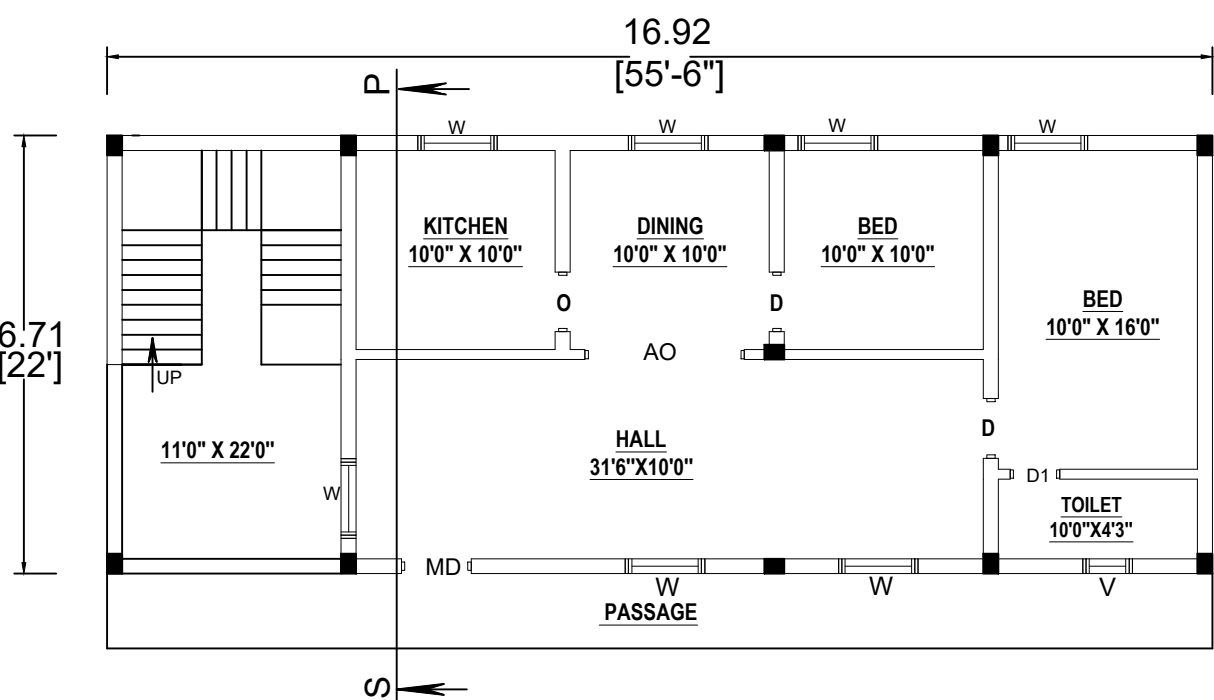


GROUND FLOOR PLAN

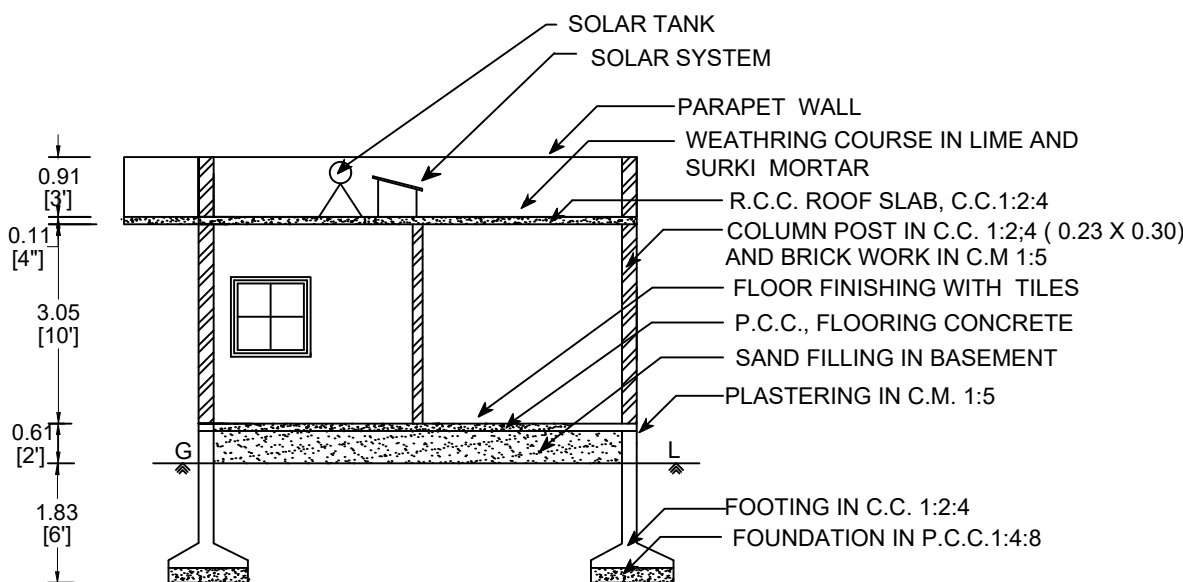


SECTION ON " S P "

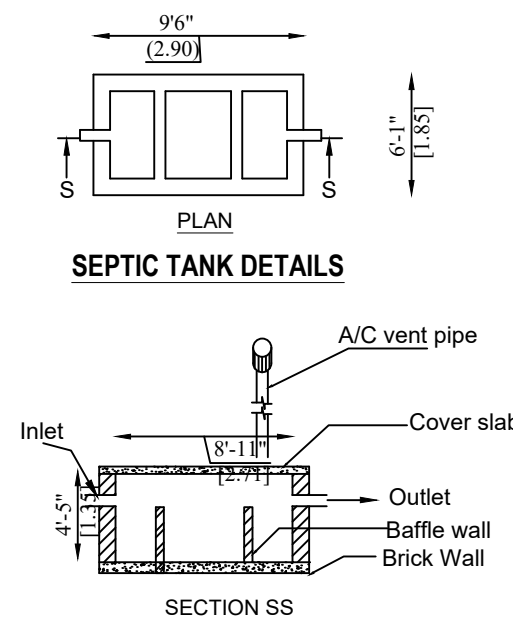


SEPTIC TANK DETAILS

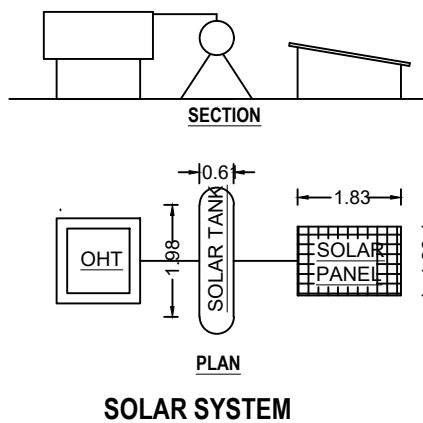

SOLAR SYSTEM

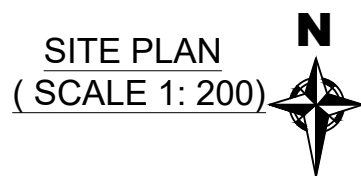

SITE PLAN
(SCALE 1: 200)

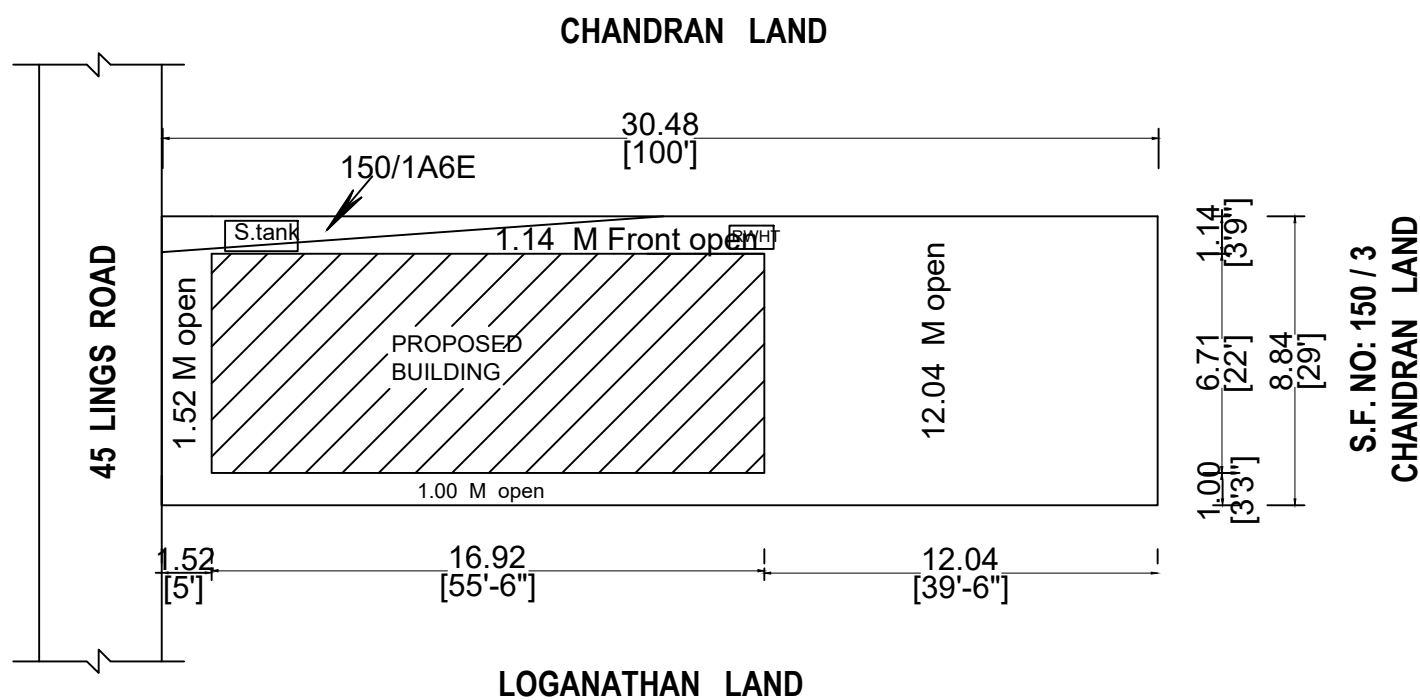



SCALE 1 : 100

ALL MEASUREMENTS ARE IN
" METRE " AND " FEET "

SITE BOUNDARY - ☐
PROPOSED BUILDING - ☐



RAIN WATER HARVESTING TANK

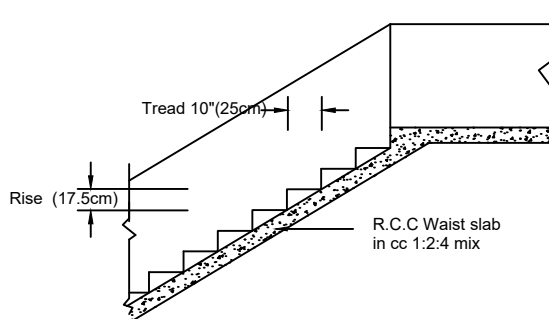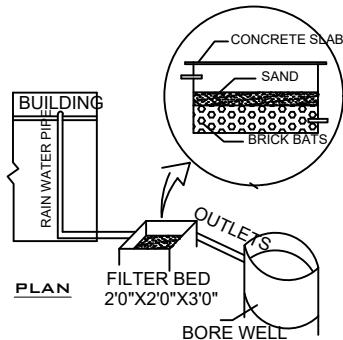

AREA STATEMENT	SQ.M.	SQ.F.T.
SITE AREA (0.06.75 Cent)	273.13	2940.00
PLINTH AREA	113.43	1221.00
OPEN SPACE	159.70	1719.00
CARPET AREA	71.99	775.00

PRO.. SEPTIC TANK , .R.W.H. TANK ,
STAIRCASE, SOLAR SYSTEM, 1 Nos

MD -	MAIN DOOR	-	1.00 X 2.13
D -	DOOR	-	0.91 X 2.13
D1 -	DOOR	-	0.76 X 2.13
O -	OPEN	-	0.91 X 2.13
W -	WINDOW	-	1.22 X 1.22
V -	VENTILATOR	-	0.61 X 0.45

APPLICANT

P. Umamaheswari

ENGINEER

Er. P. Subhashini

Er.P. SUBHASHINI, B.E.,
Namakkal / RE-III / Reg.No.1 / 2021
SARBE GROUPS
Register Engineer & Contractor
Sivasakthi Complex,
Trichy Road, Namakkal-637001
Cell : 97868 29885

98428 66698 , 81441 50070