

NAME OF THE APPLICANT : Mr.M.SEENIVASAN S/O Mr.MANI
LAYOUT APPROVAL NO : 131/2019 DATED 10.07.2019



SCALE :-

ALL DIMENSION ARE IN FEET AND METER
SCALE :- 1:100 (OR) 1" =8"0



SITE PLAN :-

SCALE 1:100

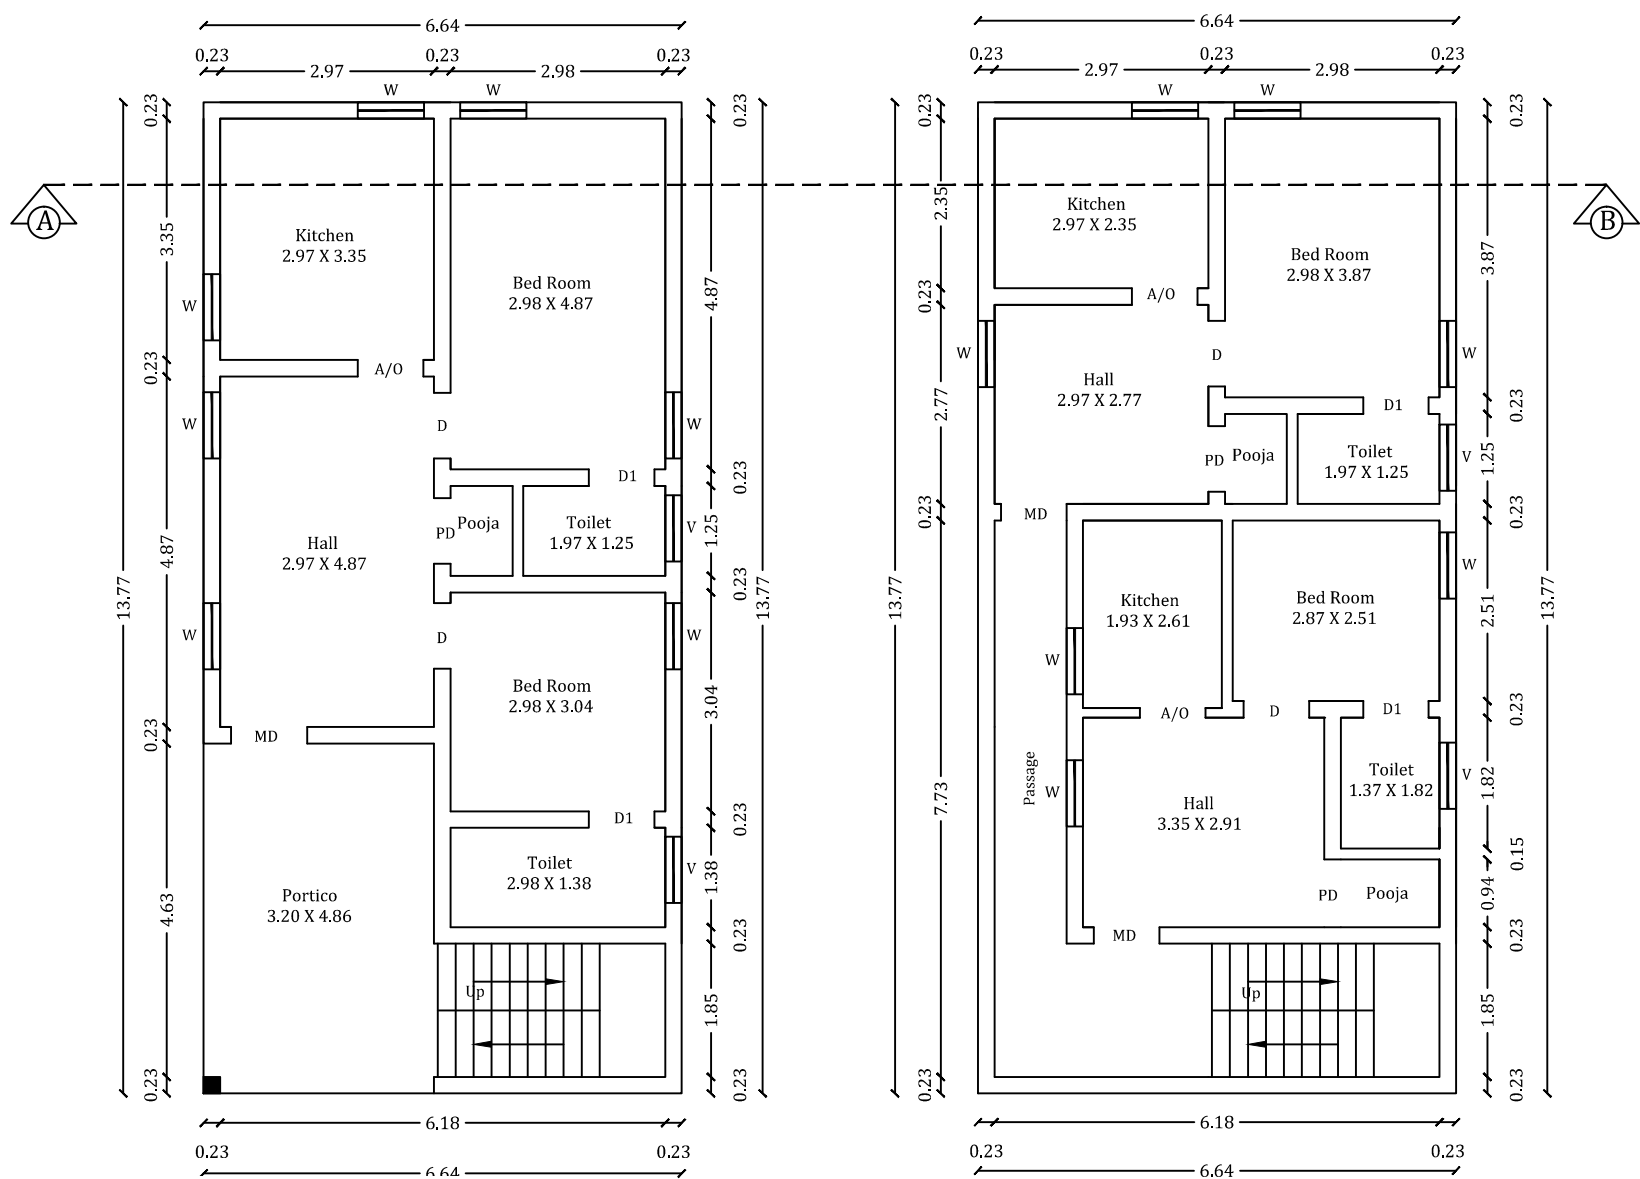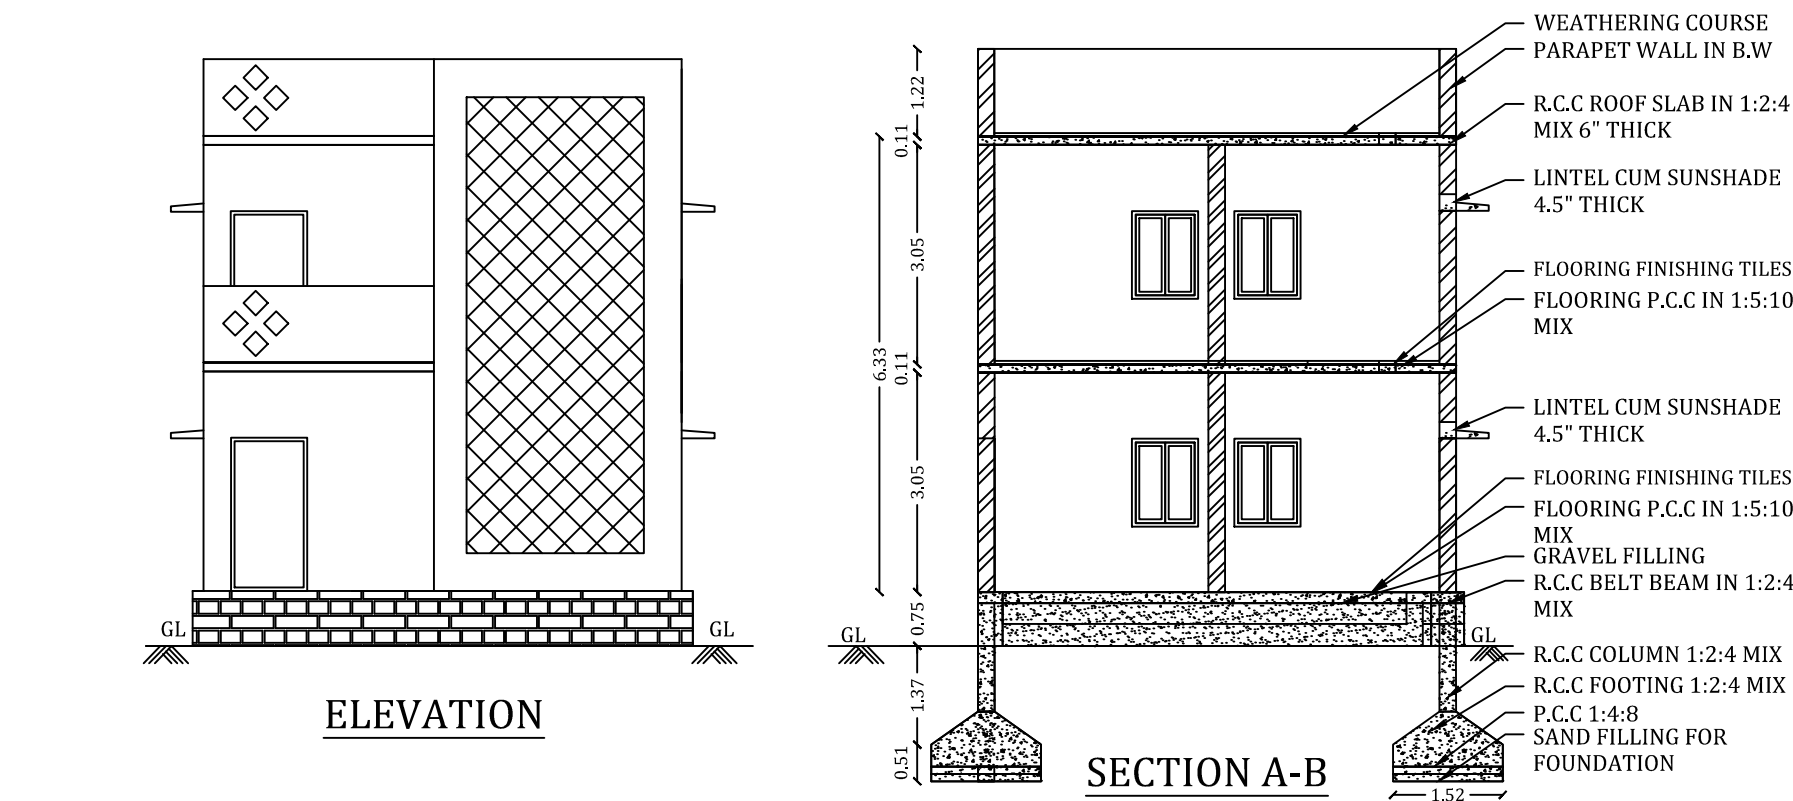


DR PLAN

FIRST FLOOR PLAN




STAIRCASE 1.00M


WATER HARVESTING :-

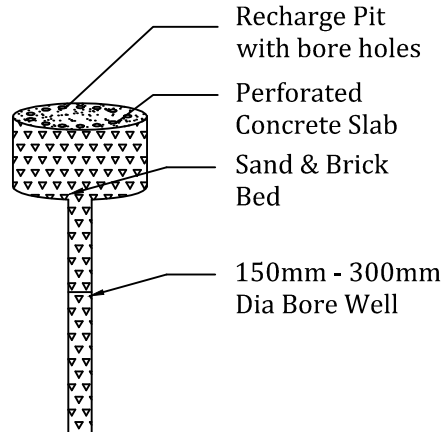

COLUMN DETAILS :-

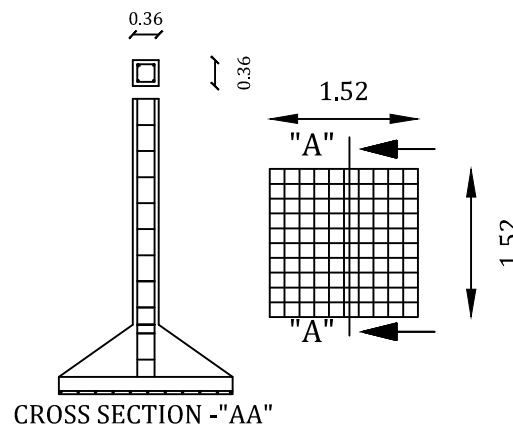

SEPTIC TANK DETAILS :-

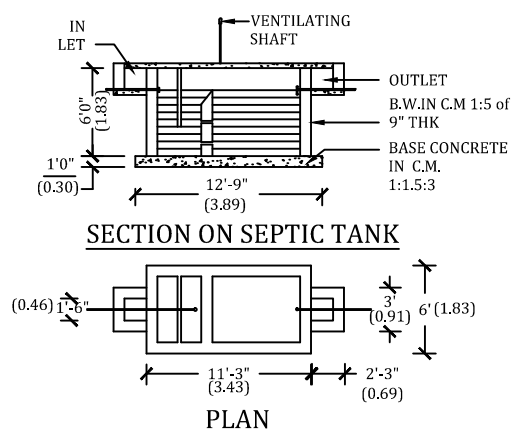

SCHEDULE OF JOINERY :-

S.NO	DESCRIPTION	SIZE IN FT	SIZE IN M
1	DOOR -D	3'3" X 7'0"	1.00 X 2.14
2	DOOR -D1	2'6" X 7'0"	0.76 X 2.14
3	WINDOW - FW	6'0" X 4'0"	1.83 X 1.22
4	WINDOW - W	4'0" X 4'0"	1.22 X 1.22
5	ARCH OPEN -AO	6'0" X 7'0"	1.90 X 2.14
6	VENTILATOR - V	2'0" X 2'0"	0.91 X 0.61

APPLICANT :-

ENGINEER :-

Er. S. MANIVANNAN, M.E., (Struct.),
Registered Engineer GR-III
Registration No: DTCP/SALEM/RE-III/008/2002
KMS CONSTRUCTION
Ariyanoor (Po), Veerapandi,
Salem - 636 308. Cell: 9943378882
Mail Id: maniciv14@gmail.com