 


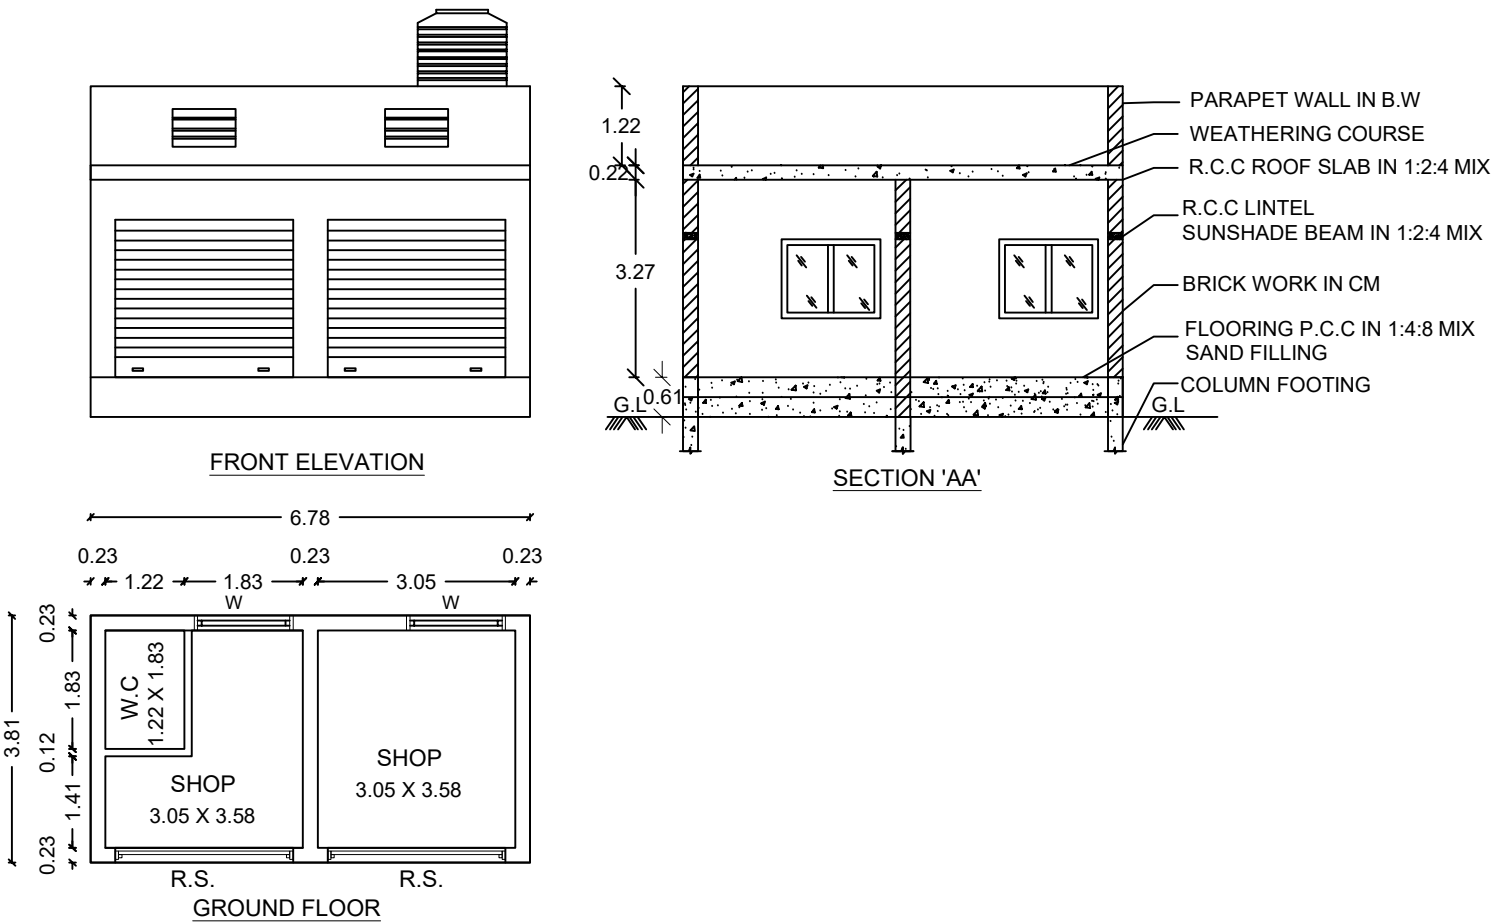


PLAN SHOWING THE PROPOSED GROUND FLOOR IN R.C.C TERRACED ROOF COMMERCIAL BUILDING LOCATED AT SURVEY NO -296/3 Part, SINGIPURAM VILLAGE PANCHAYAT, VALAPPADI UNION & TALUK, SALEM DISTRICT.


NAME OF THE APPLICANT :- Mr.MURUGESAN S/O Mr.SANNASI

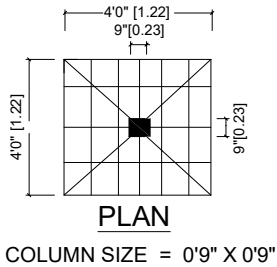


FOUNDATION DETAILS

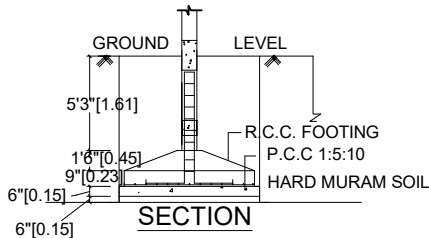

KEY PLAN
NOT TO SCALE :-

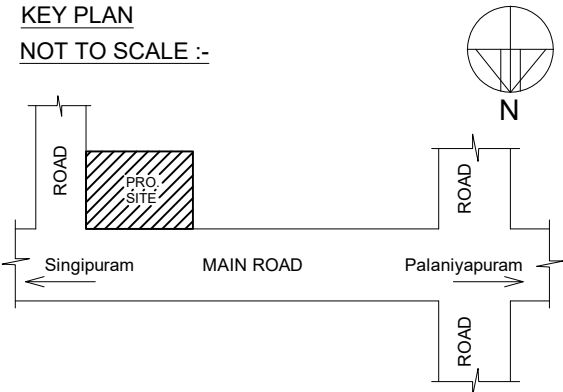


RAIN WATER HARVESTING:

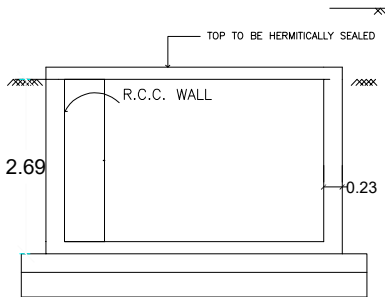


RWH_CAPACITY_L=5000LTRS
RWH_CAPACITY_L=5000LTRS


SOLAR SYSTEM

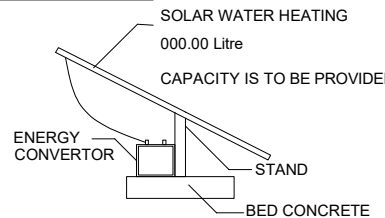

LONGITUDINAL SECTION

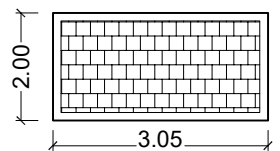

PERCOLATION PIT

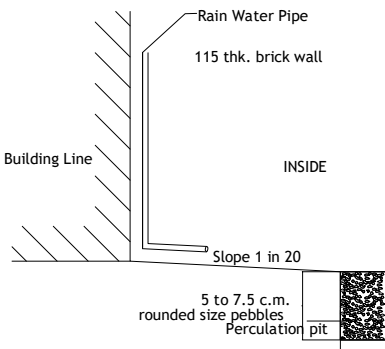

S.NO	DESCRIPTION	SIZE IN M
1	ROLLING SHUTTER-R.S.	2.74 X 2.14
2	DOOR - D	0.91 X 2.14
3	WINDOW - W	1.21 X 1.21
4	VENTILATOR - V	0.60 X 0.60

AREA DETAILS :-

S.No.	DESCRIPTION	Sq.M	Sq.FT
2.	AREA OF THE SITE (Taken)	34.41	370.38
3.	GROUND FLOOR AREA	25.84	278.14
4.	TOTAL BULDUP AREA	25.84	278.14
	OPEN AREA	8.56	92.24


APPLICANT:-

S. D. S. S. S. S. S.


ENGINEER:-

Er. S. SUPRIYA, B.E.,
Registered Engineer,
Registration No:21/2024 (RE-II)
IDEAX DESIGNS
No:544/2G-8, Rathna Complex,
Near Sona College,
Salem-636 005. Cell:97868 61333.

SITE PLAN

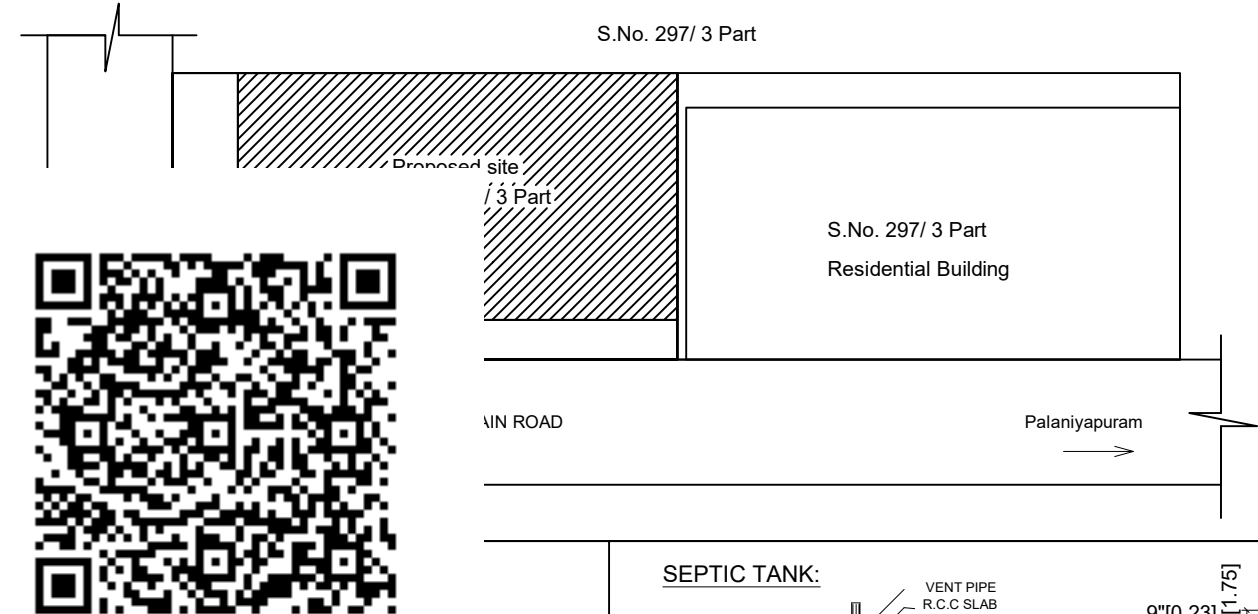

SEPTIC TANK:

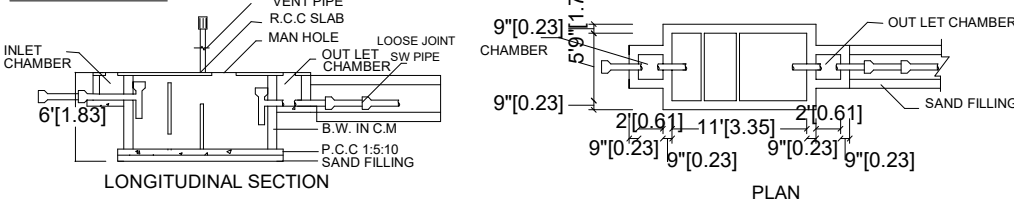

SCALE :-
ALL DIMENSIONS ARE IN METER
SCALE 1 : 100