



PLAN SHOWING THE PROPOSED CONSTRUCTION OF R.C.C. & A.C. SHEET ROOF COMMERCIAL BUILDING PURPOSE IN
S.F. NO:440 / 1A1B , NEW SUB-DN. S.F. NO: 440 /1A1B1, PATTa NO: 3355, AT RAYALUR , SALEM - COCHIN HIGHWAYS ROAD,
CHINNAGOUNDANUR VILLAGE & PANCHAYAT, SANKARI UNION & TALUK, SALEM DISTRICT,


APPLICANT'S : 1.THIRU. V. VEERAKUMAR, S/O. THIRU. P. VELUSAMY.
2.Tmt. R. SARANYA, W/O. THIRU. V. VEERAKUMAR.

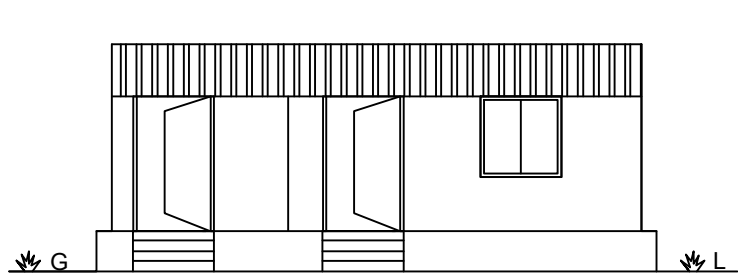


FRONT ELEVATION

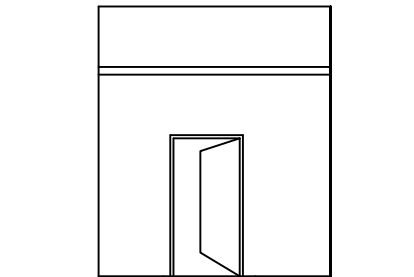


FRONT ELEVATION

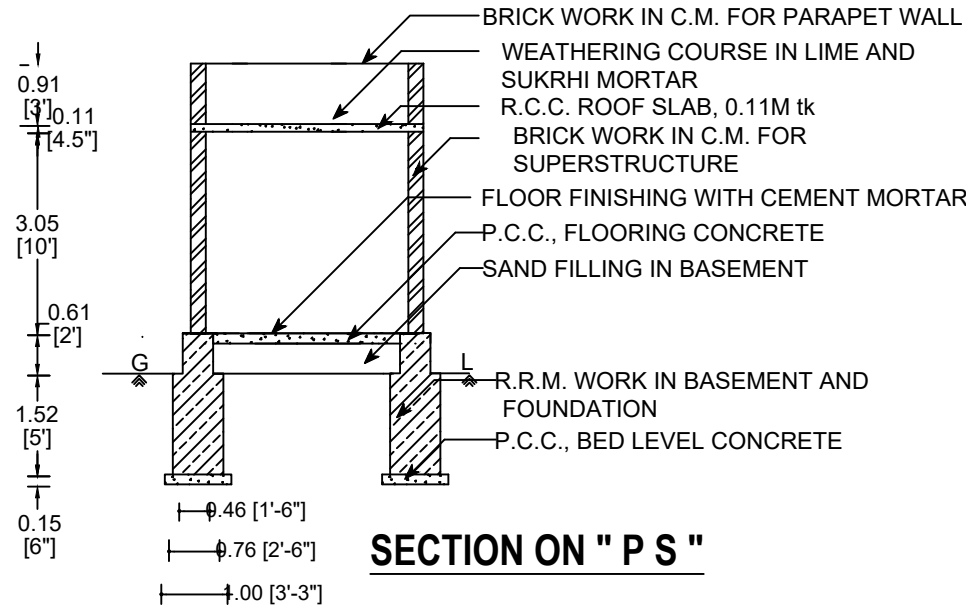

SECTION ON " P S "

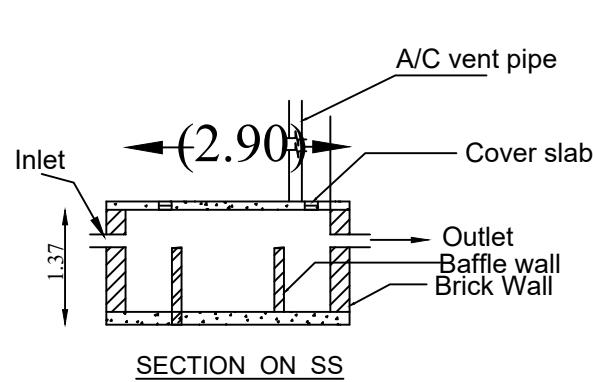


SECTION ON SS

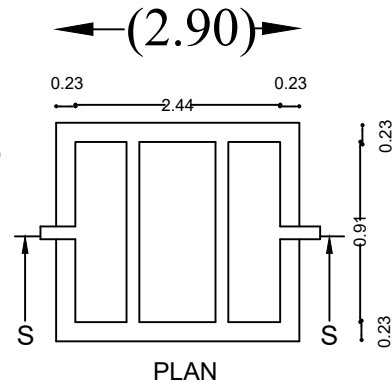


SEPTIC TANK DETAILS


RAIN WATER HARVESTING TANK

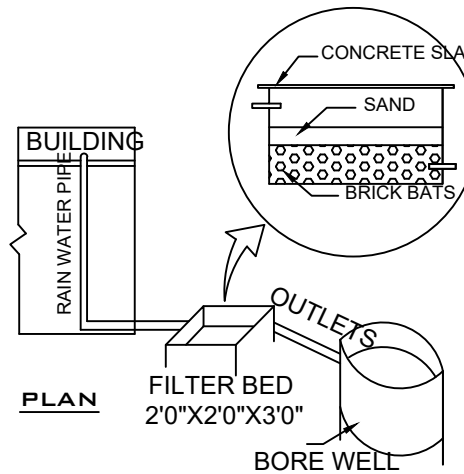


PLAN

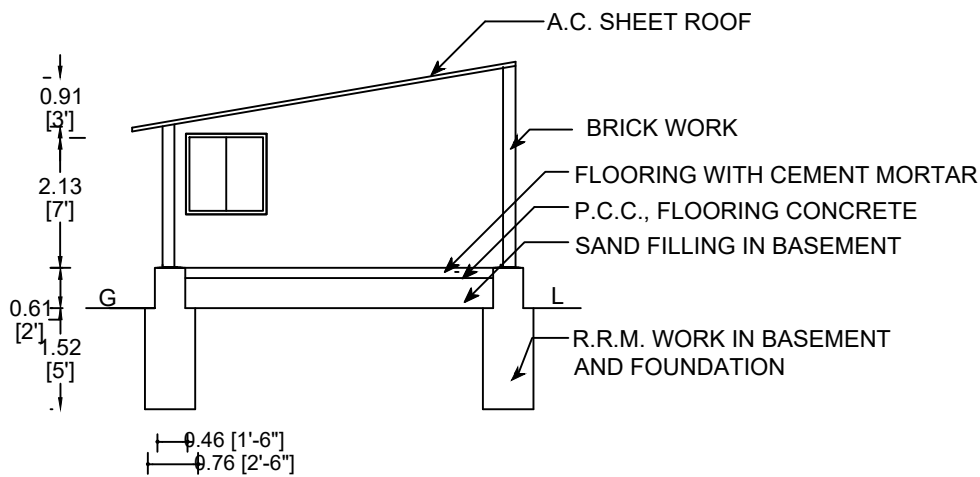


SECTION ON " S P "

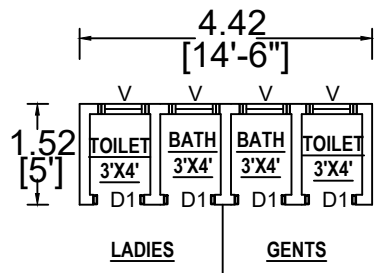

PLAN
(A.C. SHEET ROOF)

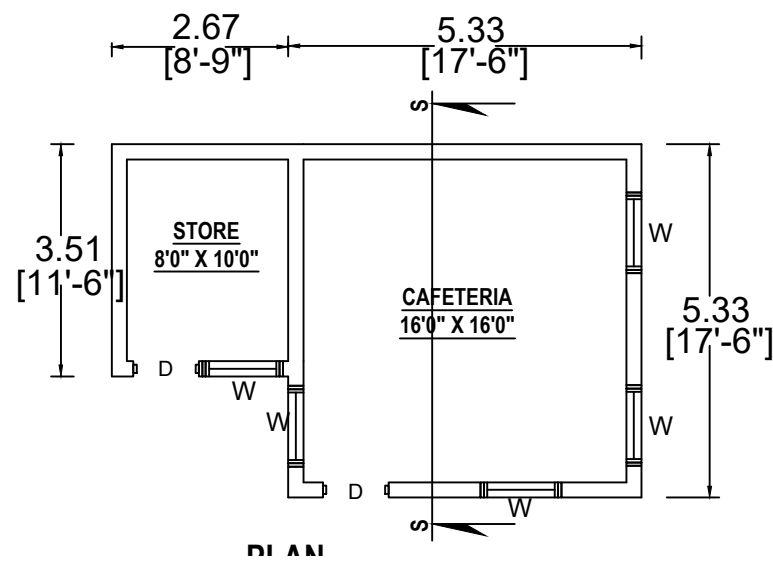


PLAN

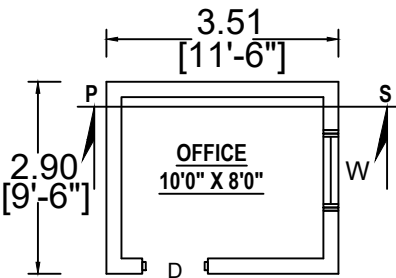

PLAN
(R.C.C. ROOF)

SITE PLAN
(SCALE 1: 200)

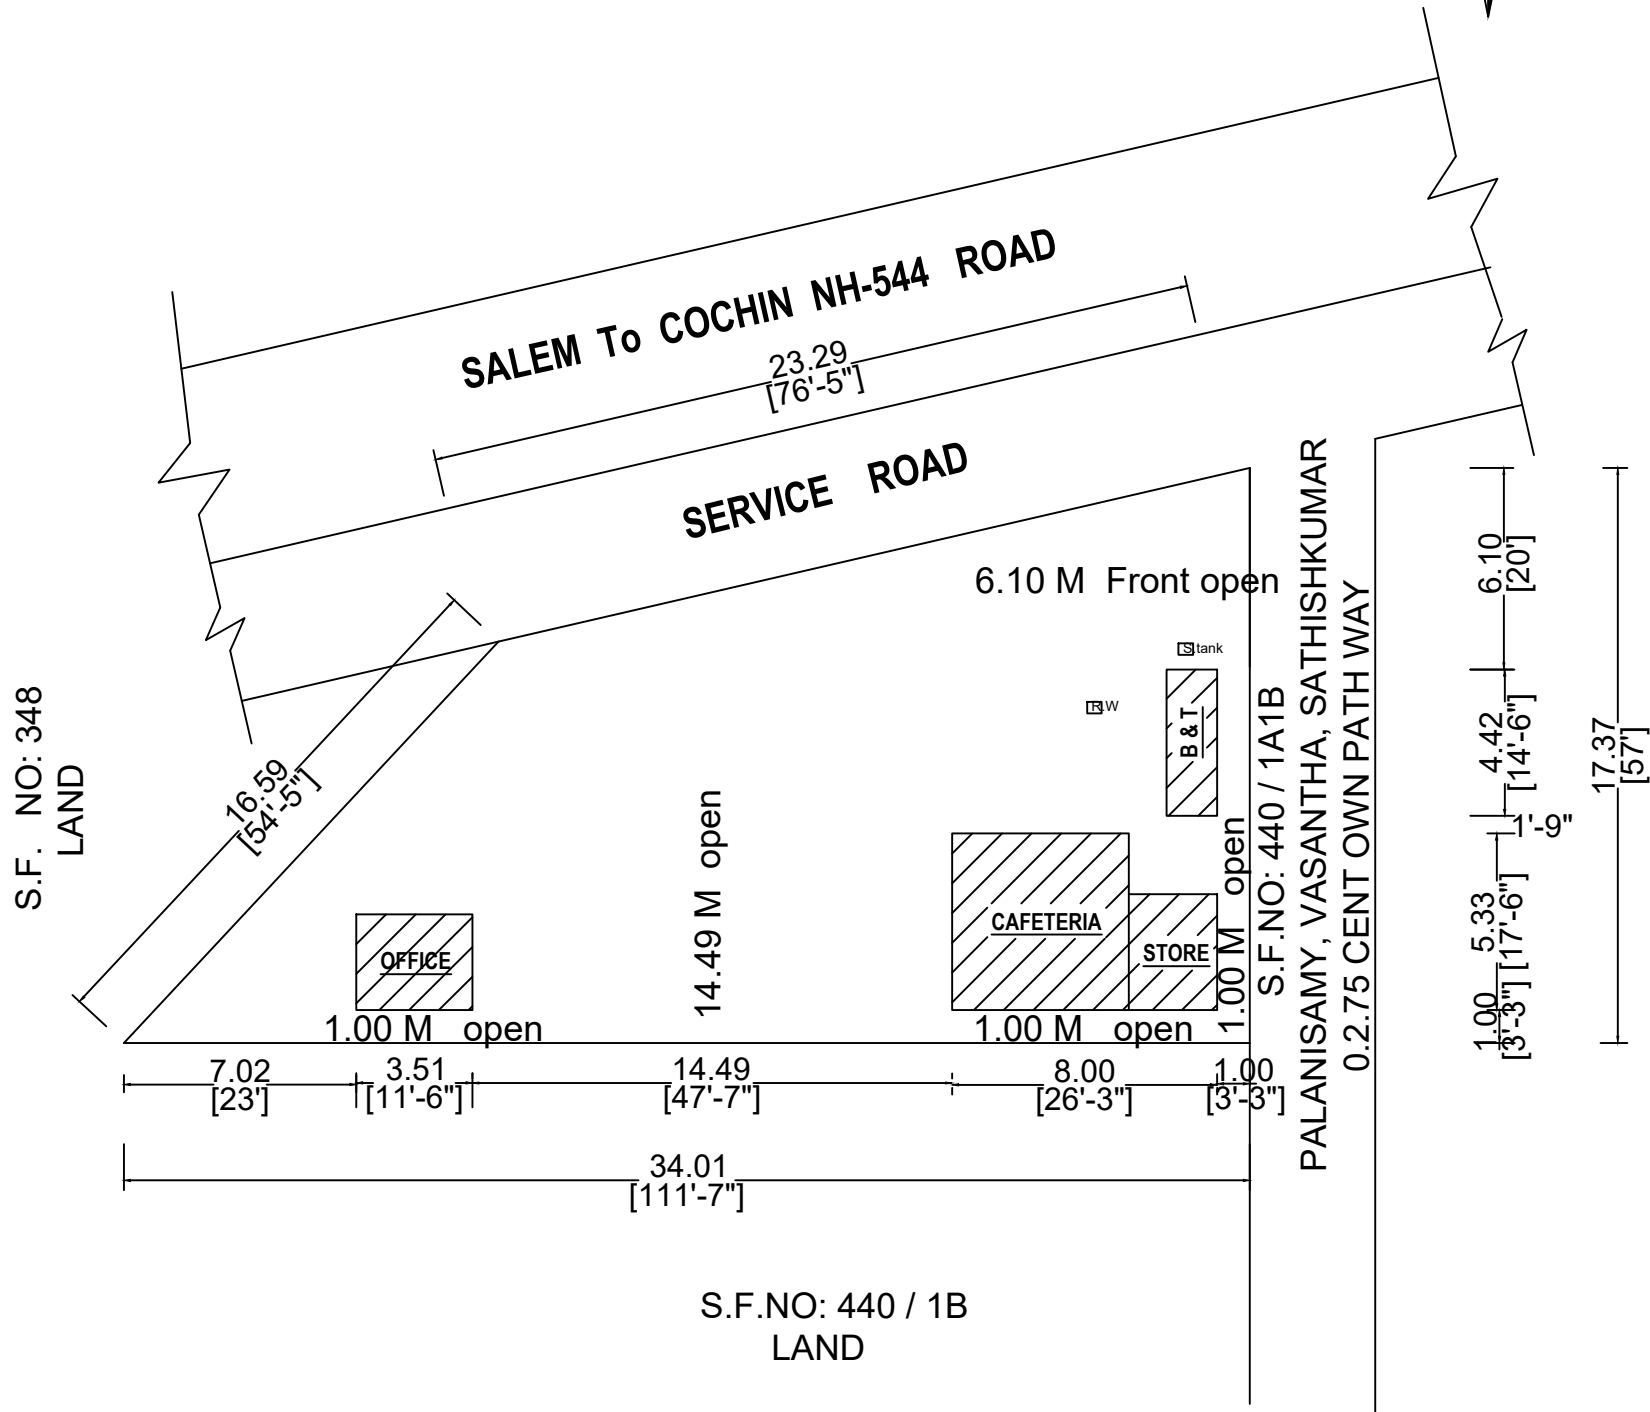

AREA STATEMENT		SQ.M.	SQ.FT.
AREA OF THE SITE	(0.11.25 Cent)	455.26	4900.50
PLINTH AREA (R.C.C. ROOF)		10.12	109.00
PLINTH AREA (A.C. SHEET ROOF)		44.77	482.00
AREA OF THE OPEN SPACE		400.37	4306.50
CARPET AREA		38.64	416.00
PRO.. SEPTIC TANK , .R.W.H. TANK ,		1 Nos	
JOINERY SCHEDULE		SCALE 1 : 100 ALL MEASUREMENTS ARE IN " METRE " AND " FEET "	
D - DOOR	- 1.22 X 2.13	SITE BOUNDARY - ☐	
D1 - DOOR	- 0.76 X 2.13	PRO... BUILDING - ☐	
W - WINDOW	- 1.22 X 1.22		
V - VENTILATOR	- 0.76 X 0.61		
APPLICANT'S		ENGINEER	
V.V. Kumar		Er.P. SUBHASHINI, B.E., Namakkal / RE-III / Reg.No.1/2021 SARBE GROUPS Register Engineer & Contractor Sivasakthi Complex, Trichy Road, Namakkal-637001 Cell : 97868 29885	
R. Saranya		98428 66698 , 81441 50070	