

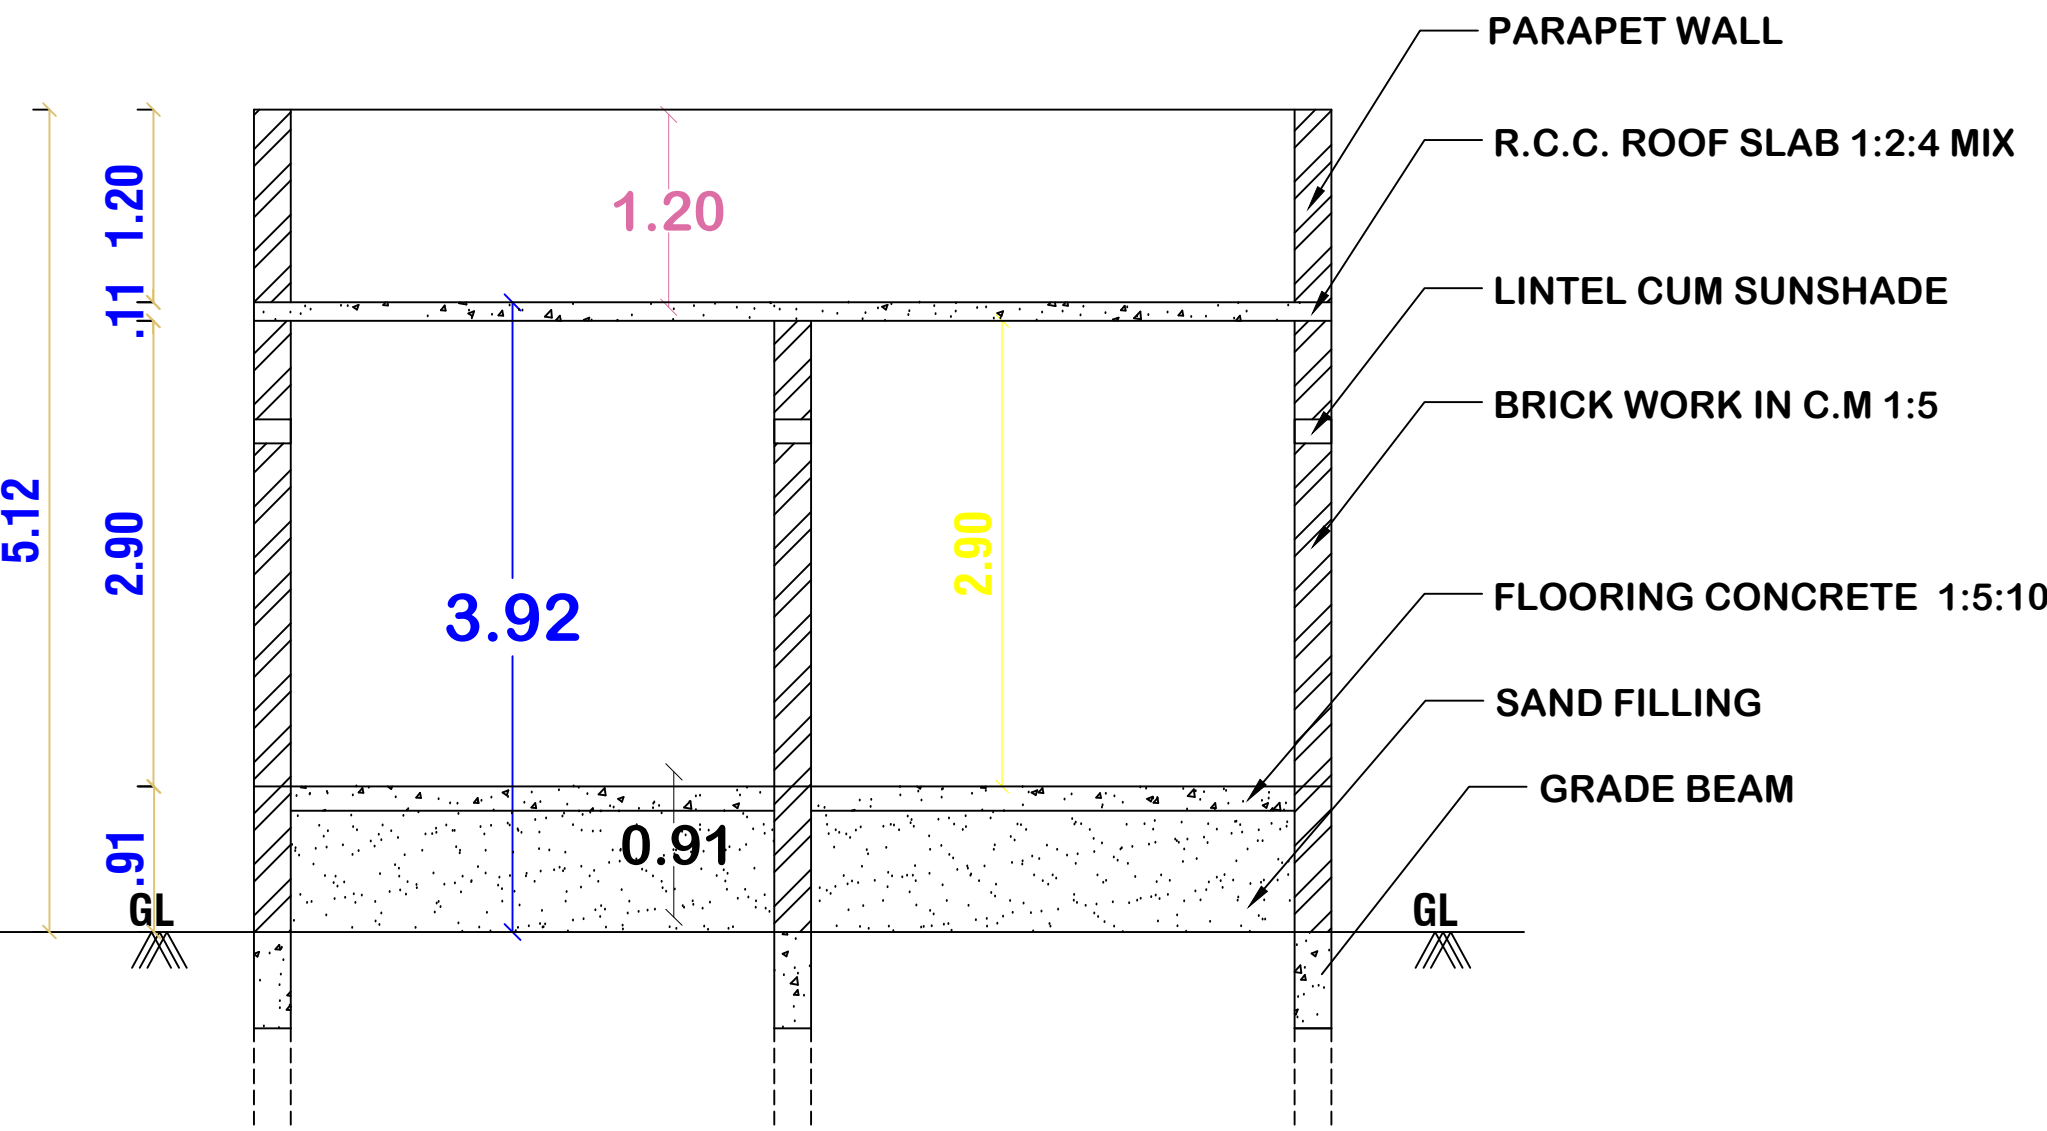


PLAN SHOWING THE PROPOSED CONSTRUCTION RCC ROOF COMMERCIAL BUILDING IN SF.NO: 148 / 1Q1 , AT KULLANUR PERIYASORAGAI VILLAGE PANCHAYAT , PERIYASORAGAI VILLAGE , NANGAVALLI UNION , METTUR TK , SALEM DT.


NAME OF APPLICANT :- Mr.P.MADHAIYAN , S/O. Mr.PONNUPAIYAN.

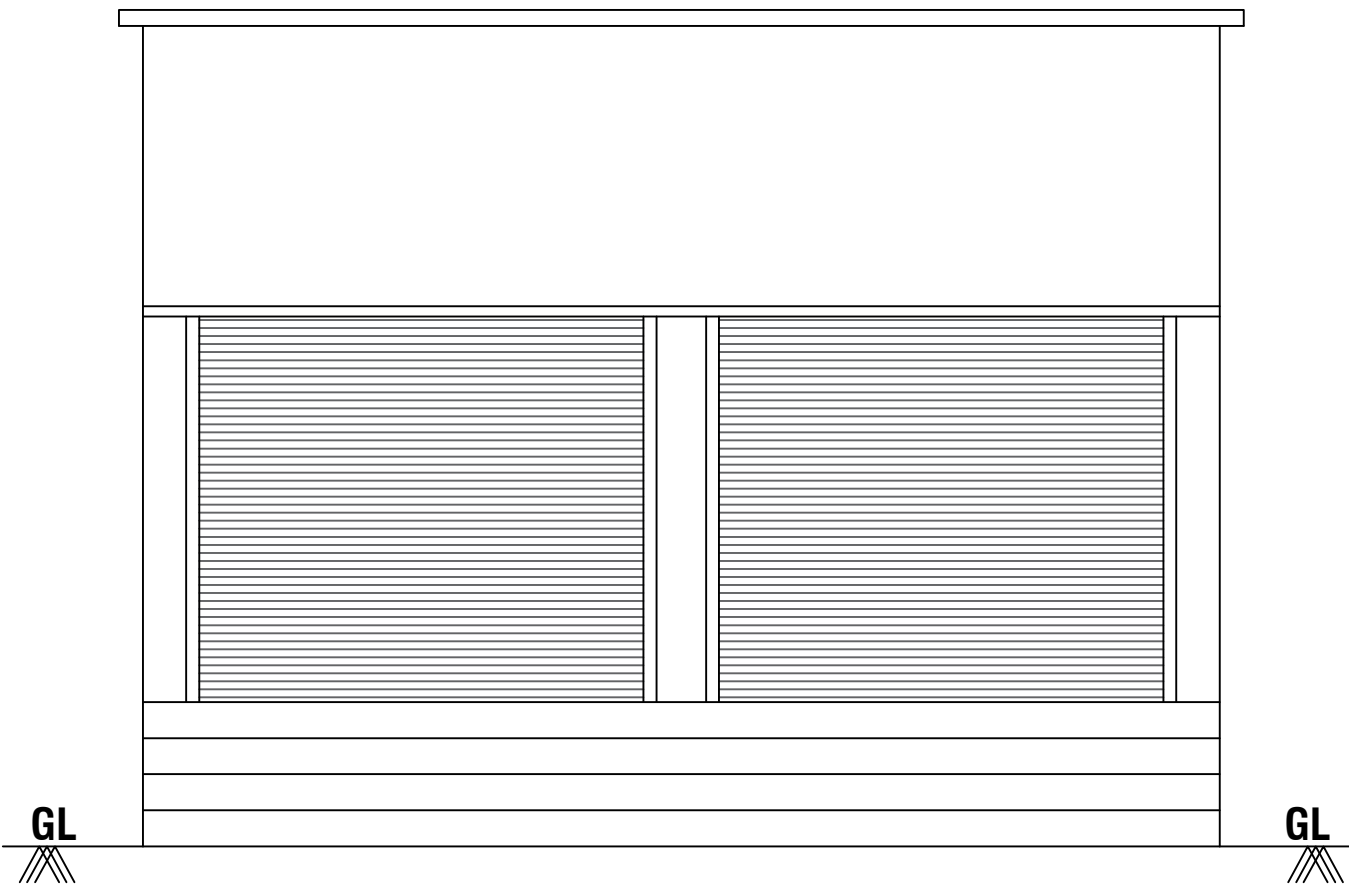


SECTION-"AA"

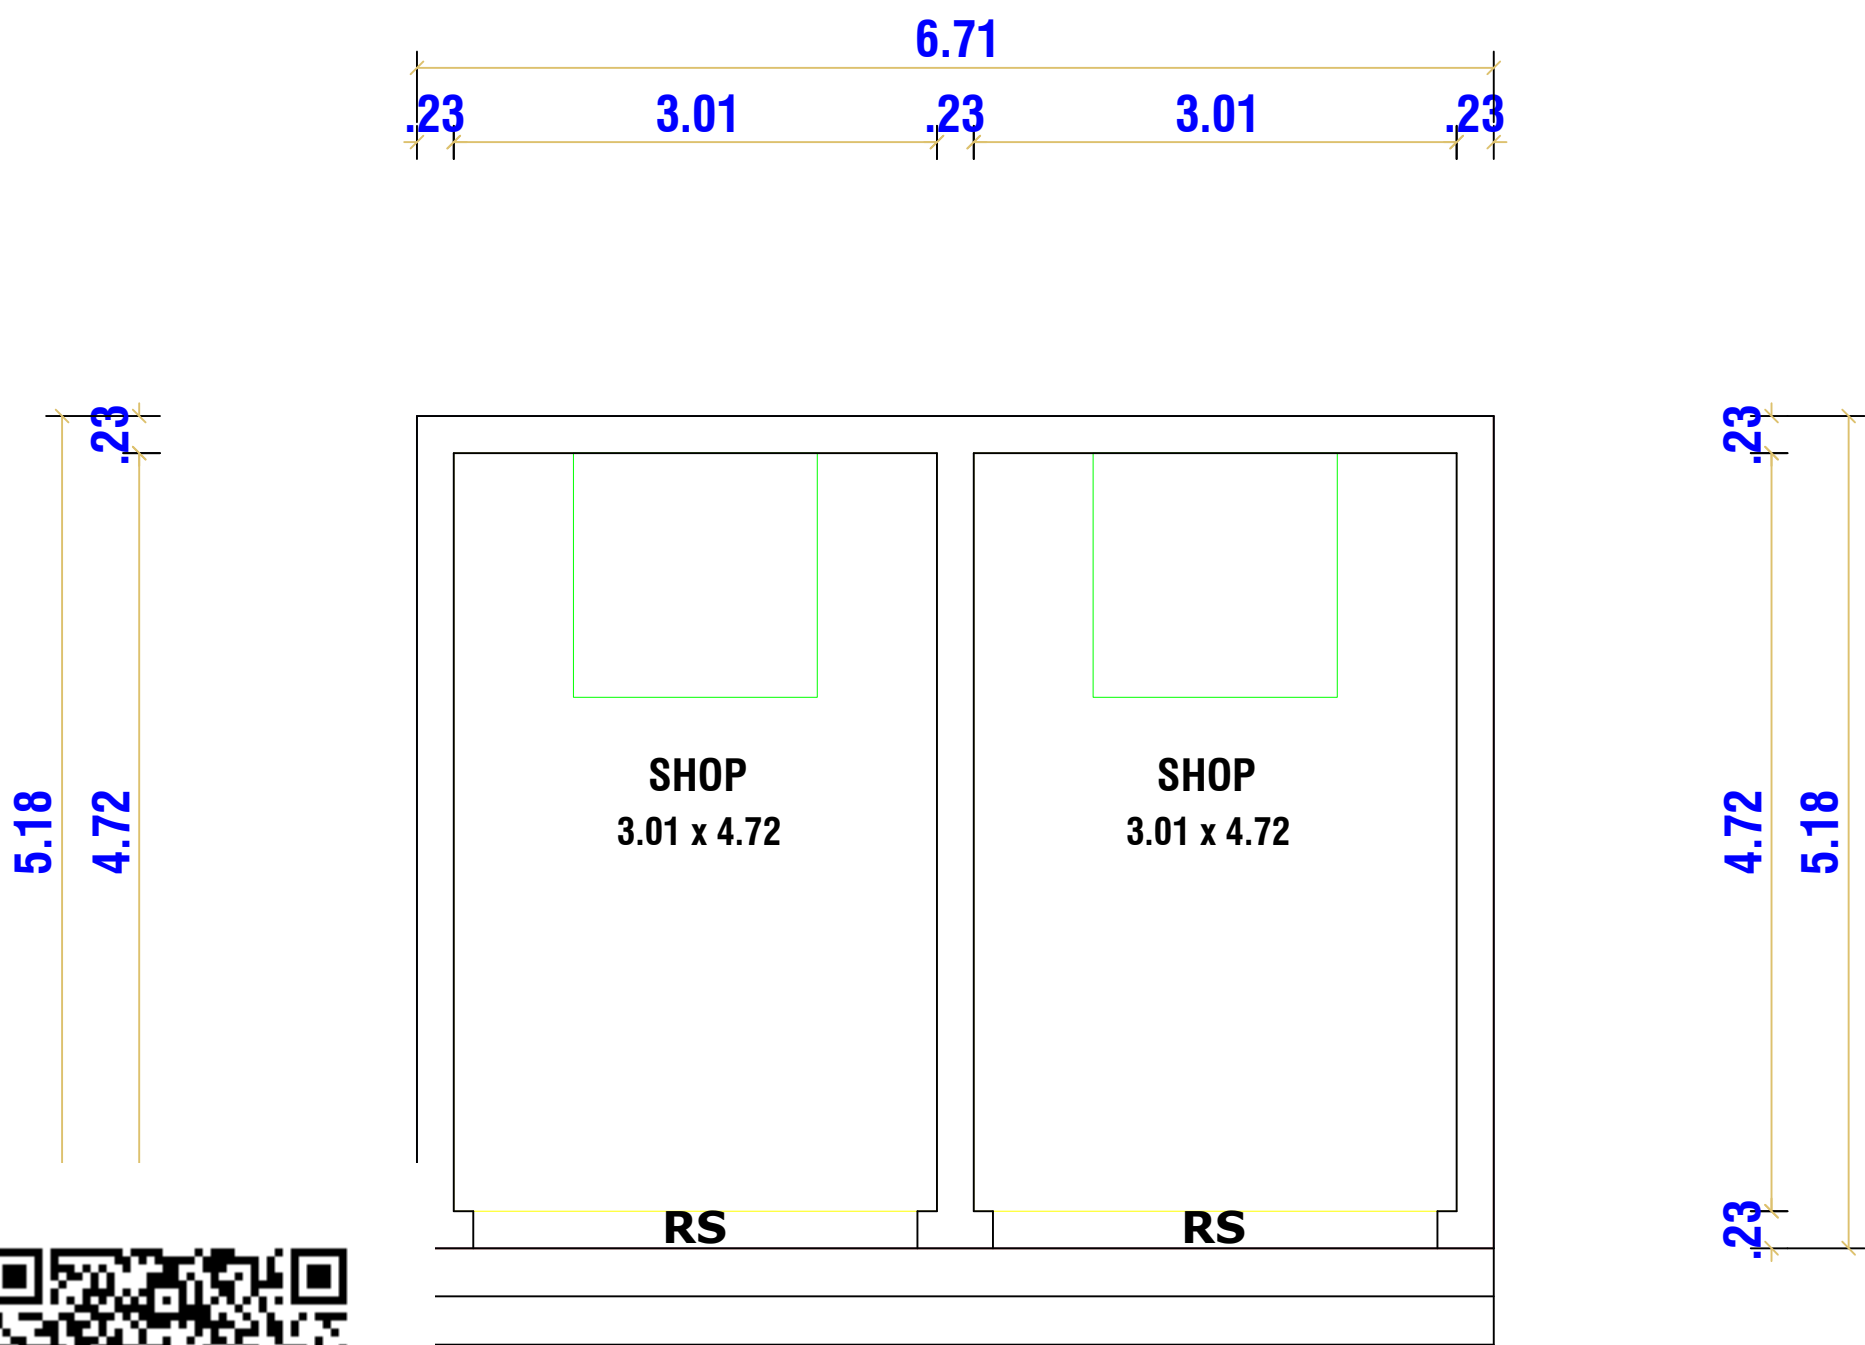


PLAN

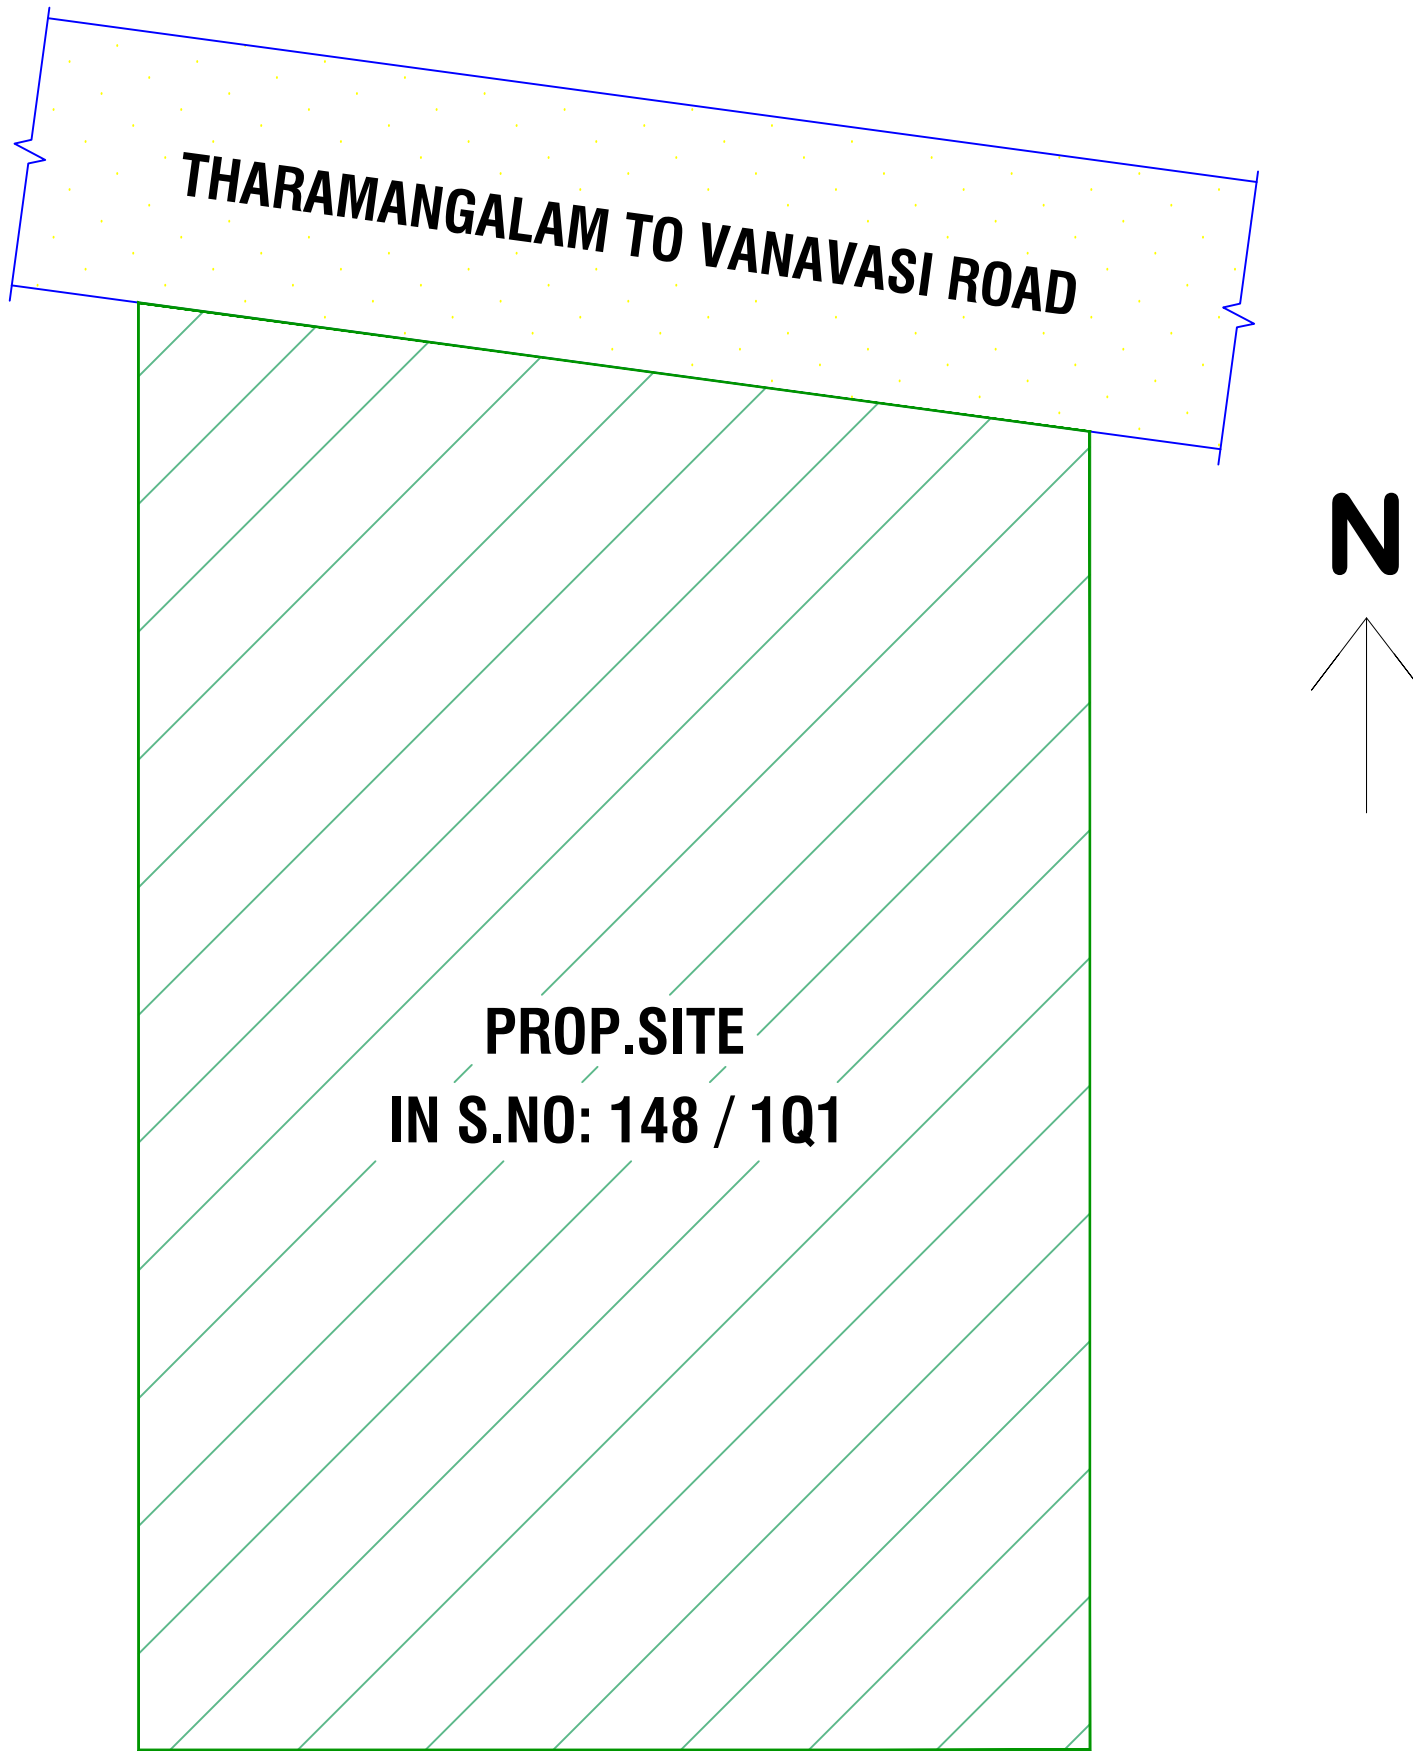


KEY PLAN (N.T.S)

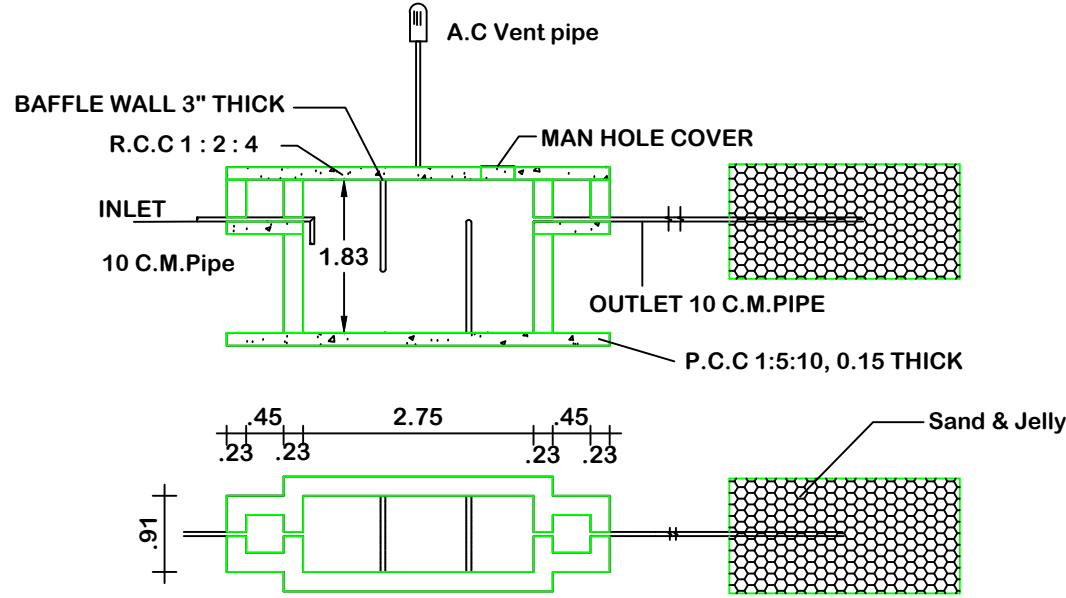


SEPTIC TANK AND TRENCH

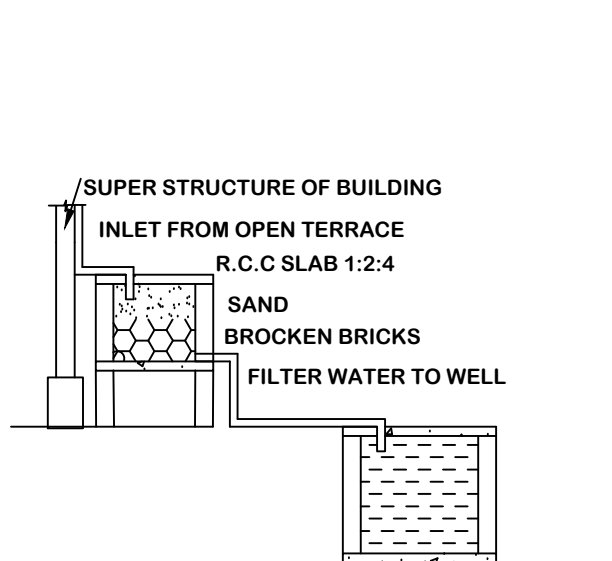


RAINWATER HARVESTING

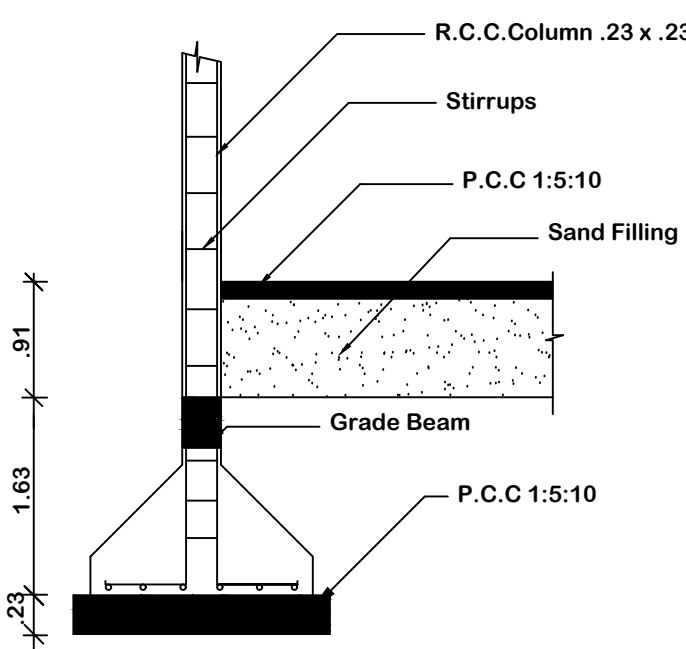


COLUMN DETAIL

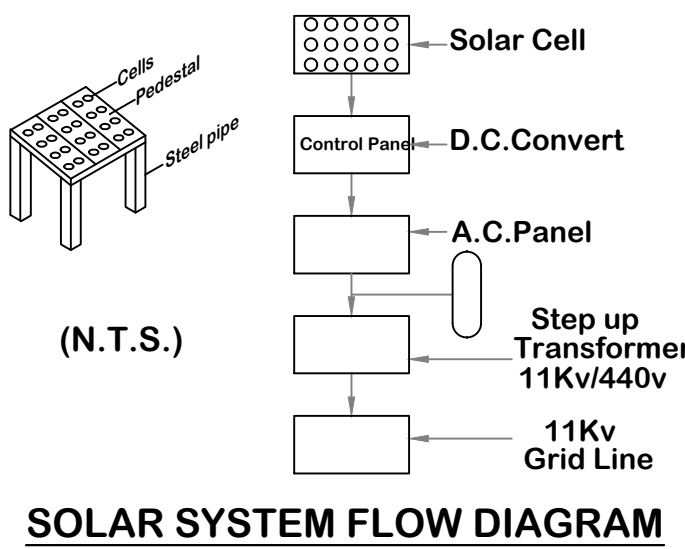

SOLAR SYSTEM FLOW DIAGRAM

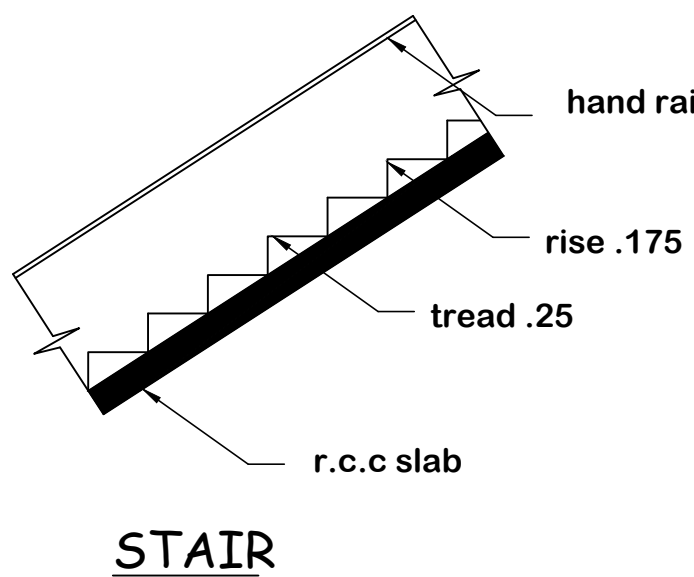

STAIR

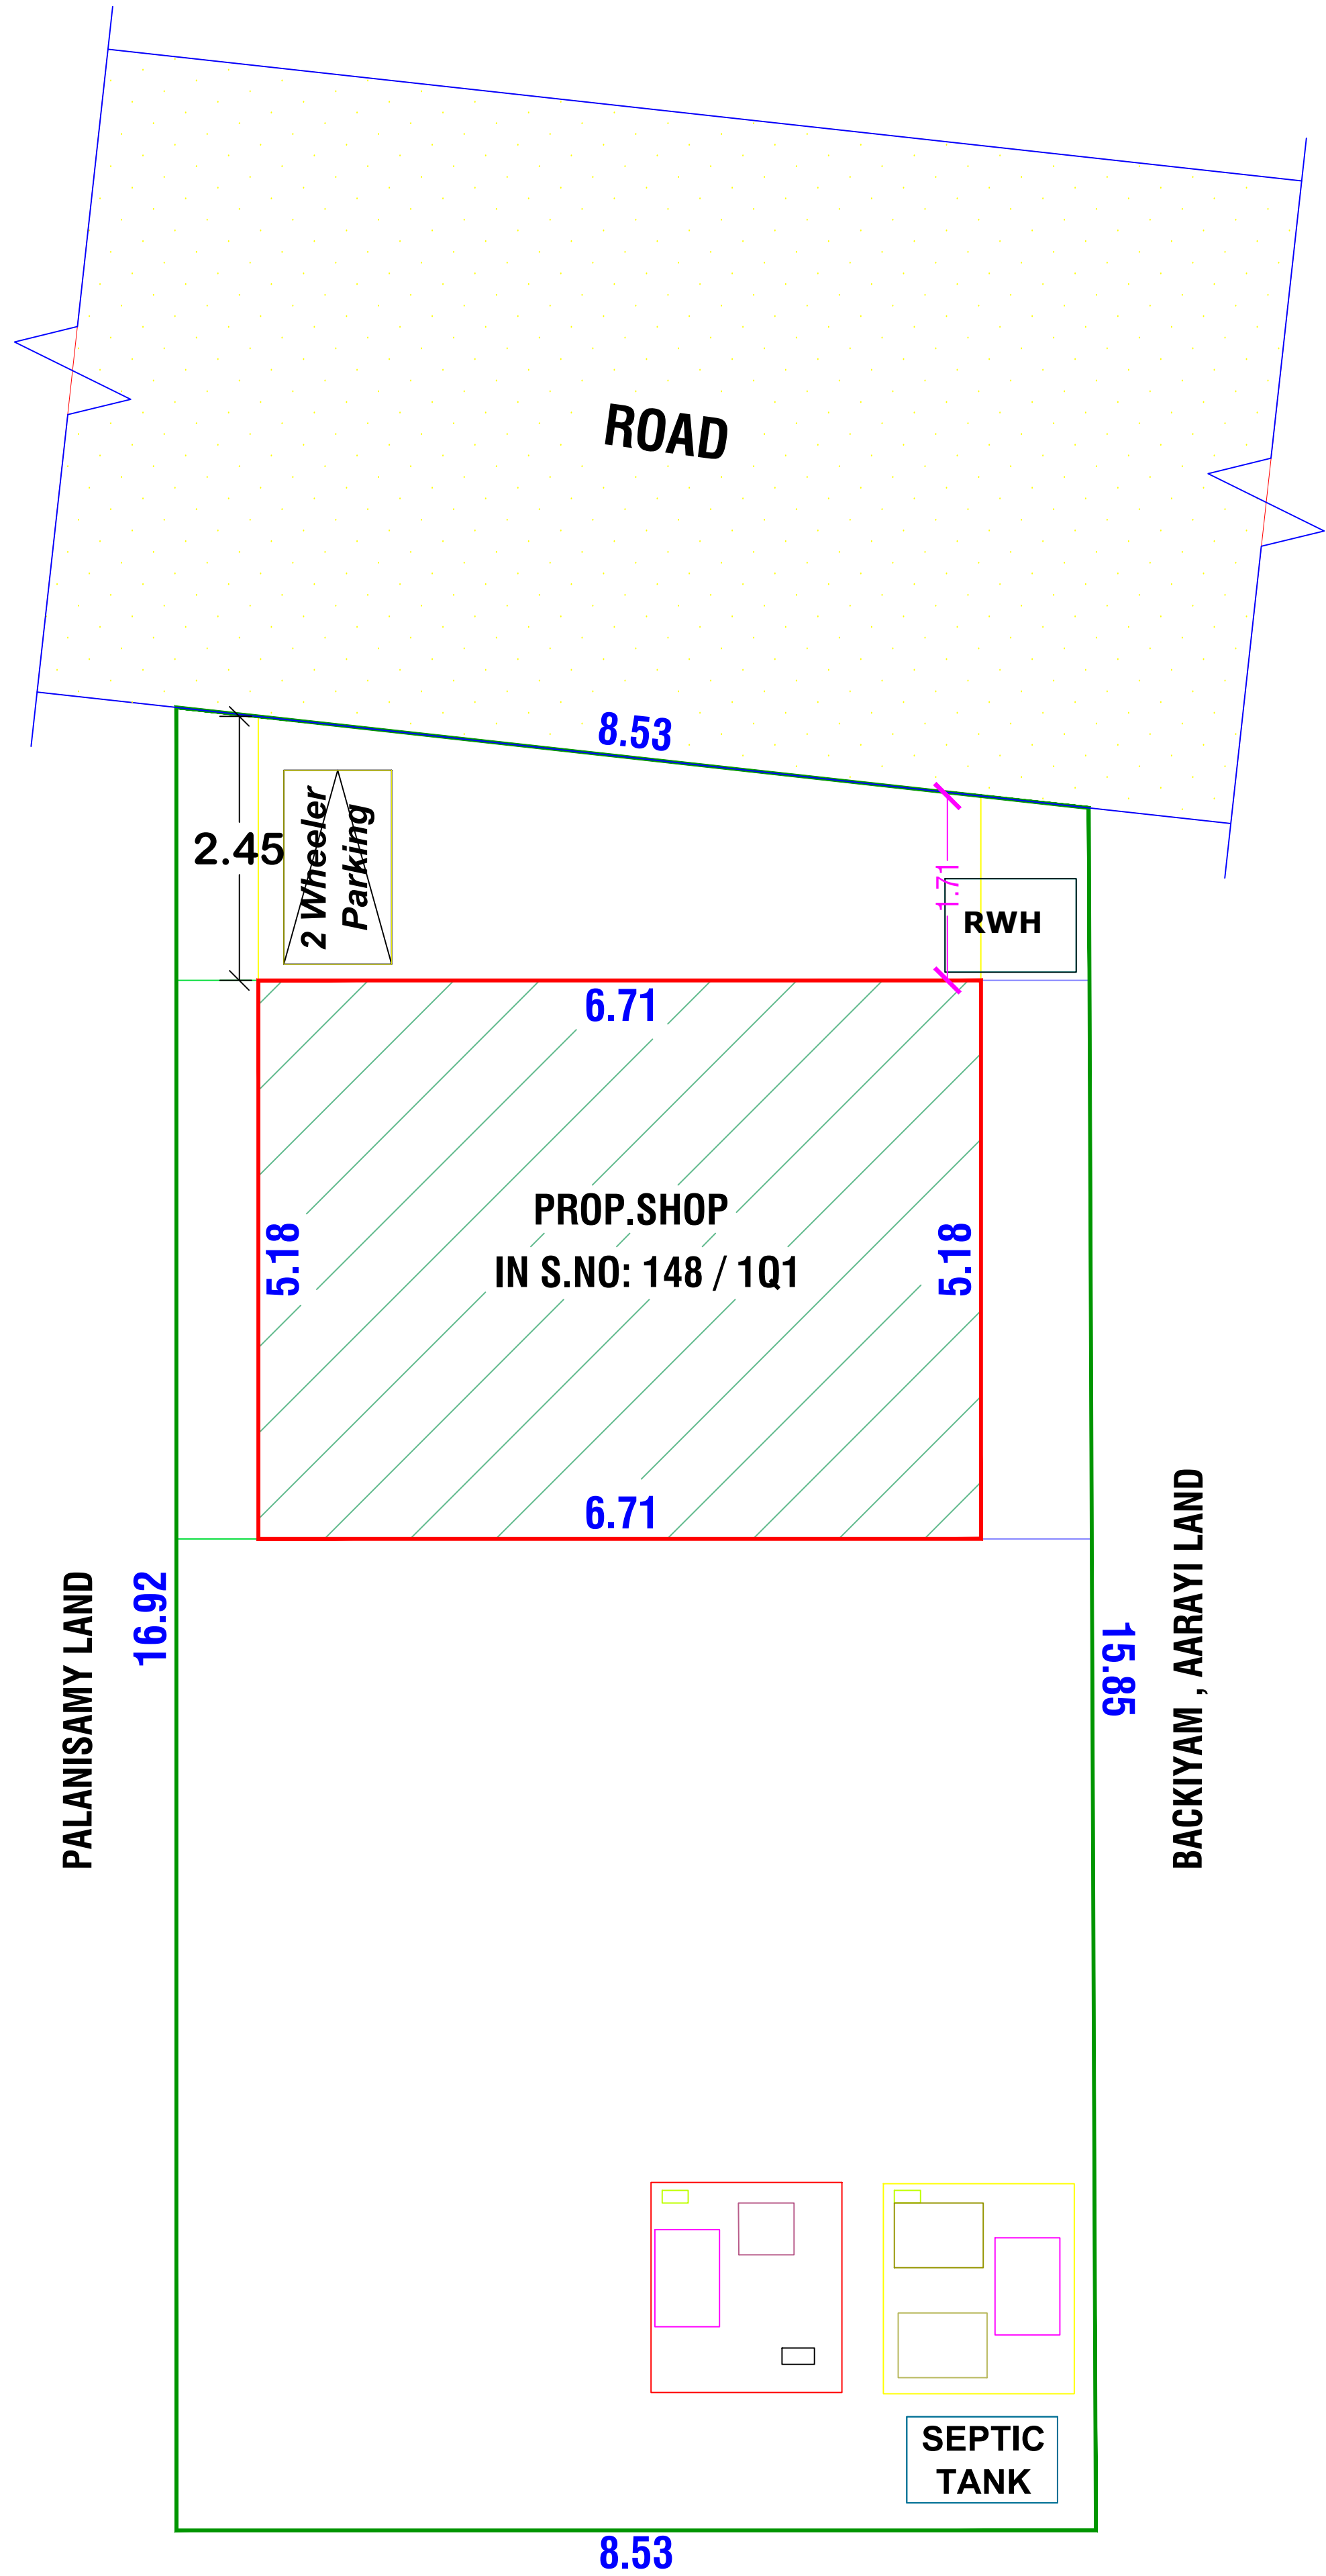

SITE PLAN
SCALE 1:100

OFFICE USE

AREA DETAILS

REF.	DESCRIPTION	SQ.M	SQ.FT
□	SITE AREA	139.82	1505
□	PLINTH AREA IN G.F	34.75	374
□	OPEN AREA	105.07	1131
□	F.S.I	0.25	

JOINERY DETAILS

RS	Rolling Shutter	3.00 x 2.44
MD	Door	1.00 x 2.10
D1	Door	0.91 x 2.10
D2	Door	0.75 x 2.10
W	Window	1.50 x 1.50
W1	Window	1.20 x 1.50
V	Ventilator	0.90 x 0.60

ALL DIMENSIONS ARE IN METRE, SCALE 1:100

Note:

Waste Water Used for Garden
Rain Water harvesting Details Provided
Rain water harvesting tank to be provided

APPLICANT

K. GANESAN, DCE.,
LICENSED BUILDING SURVEYOR
VANAVASI - 636 457.
Mettur (Tk), Salem (Dt),
Mob: 98946 08983, 9885884037
mail: ms.thangam02@gmail.com

ENGINEER