

PLAN SHOWING THE PROPOSED CONSTRUCTION OF R.C.C RESIDENTIAL GROUND FLOOR BUILDING IN PLOT NO:13,


S No: 82/22, AT KANJIRANGAL VILLAGE, KANJIRANGAL PANCHAYAT, SIVAGANGAI UNION,

SIVAGANGAI TALUK, SIVAGANGAI DISTRICT.

all dimensions are in 'metres'

Owner Name: Mr.R.MATHIVANAN, s/o RAMASAMY

(scale 1 : 100)

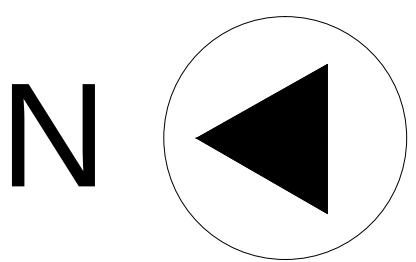

- 1.WASTE WATER FROM KITCHEN AND WASH WILL BE RECHARGED IN R.W.H AS PER BUILDING RULE NO.17A
- 2.'U' TRAP WILL BE PROVIDED IN ALL THE OUTLETS
- 3.ALL SEWAGE LINE TO BE CONNECTED TO THE EXG UGS

Reference	Meter
MD - MAIN DOOR	1.07 X 2.13
D - DOOR	1.00 X 2.13
D1 - DOOR	0.76 X 2.13
W1 - WINDOW	1.22 X 1.37
V - VENTILATOR	0.90 X 0.60

Applicant:


R Mathivanan

Engineer:


Er.M.Ajith Kumar.DCE.

Er.M.AJITH KUMAR.DCE.,
Reg Engg No: SVG/CE/08/2023
No.2, SAIBABA NAGAR,
Devakottai - 630 302
Phone: +91 7806825596,
Email : kalamassociate2020@gmail.com


AREA DETAILS		SQ.M	SQ.FT
Total Site Area (as per Patta)		139.00	1496.19
Total Site Area (as per document)		139.35	1500.00
Total. Pro. Ground Floor		51.14	550.47
Headroom		-	-
Free Space		87.86	945.72
F.S.I AREA	51.14 sq.m	PLOT COVERAGE	0.36%
NON F.S.I AREA	-		

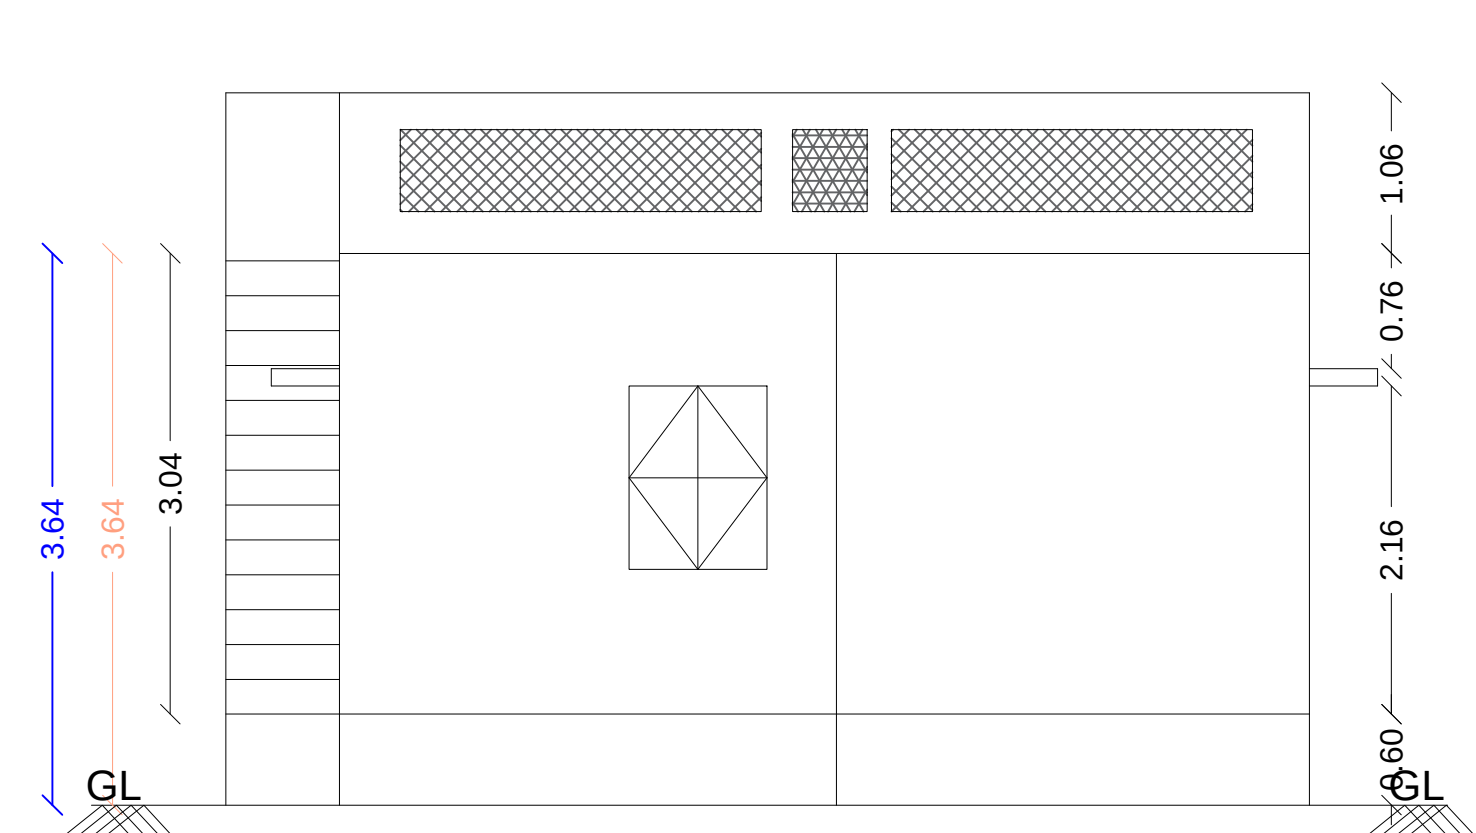

ELEVATION

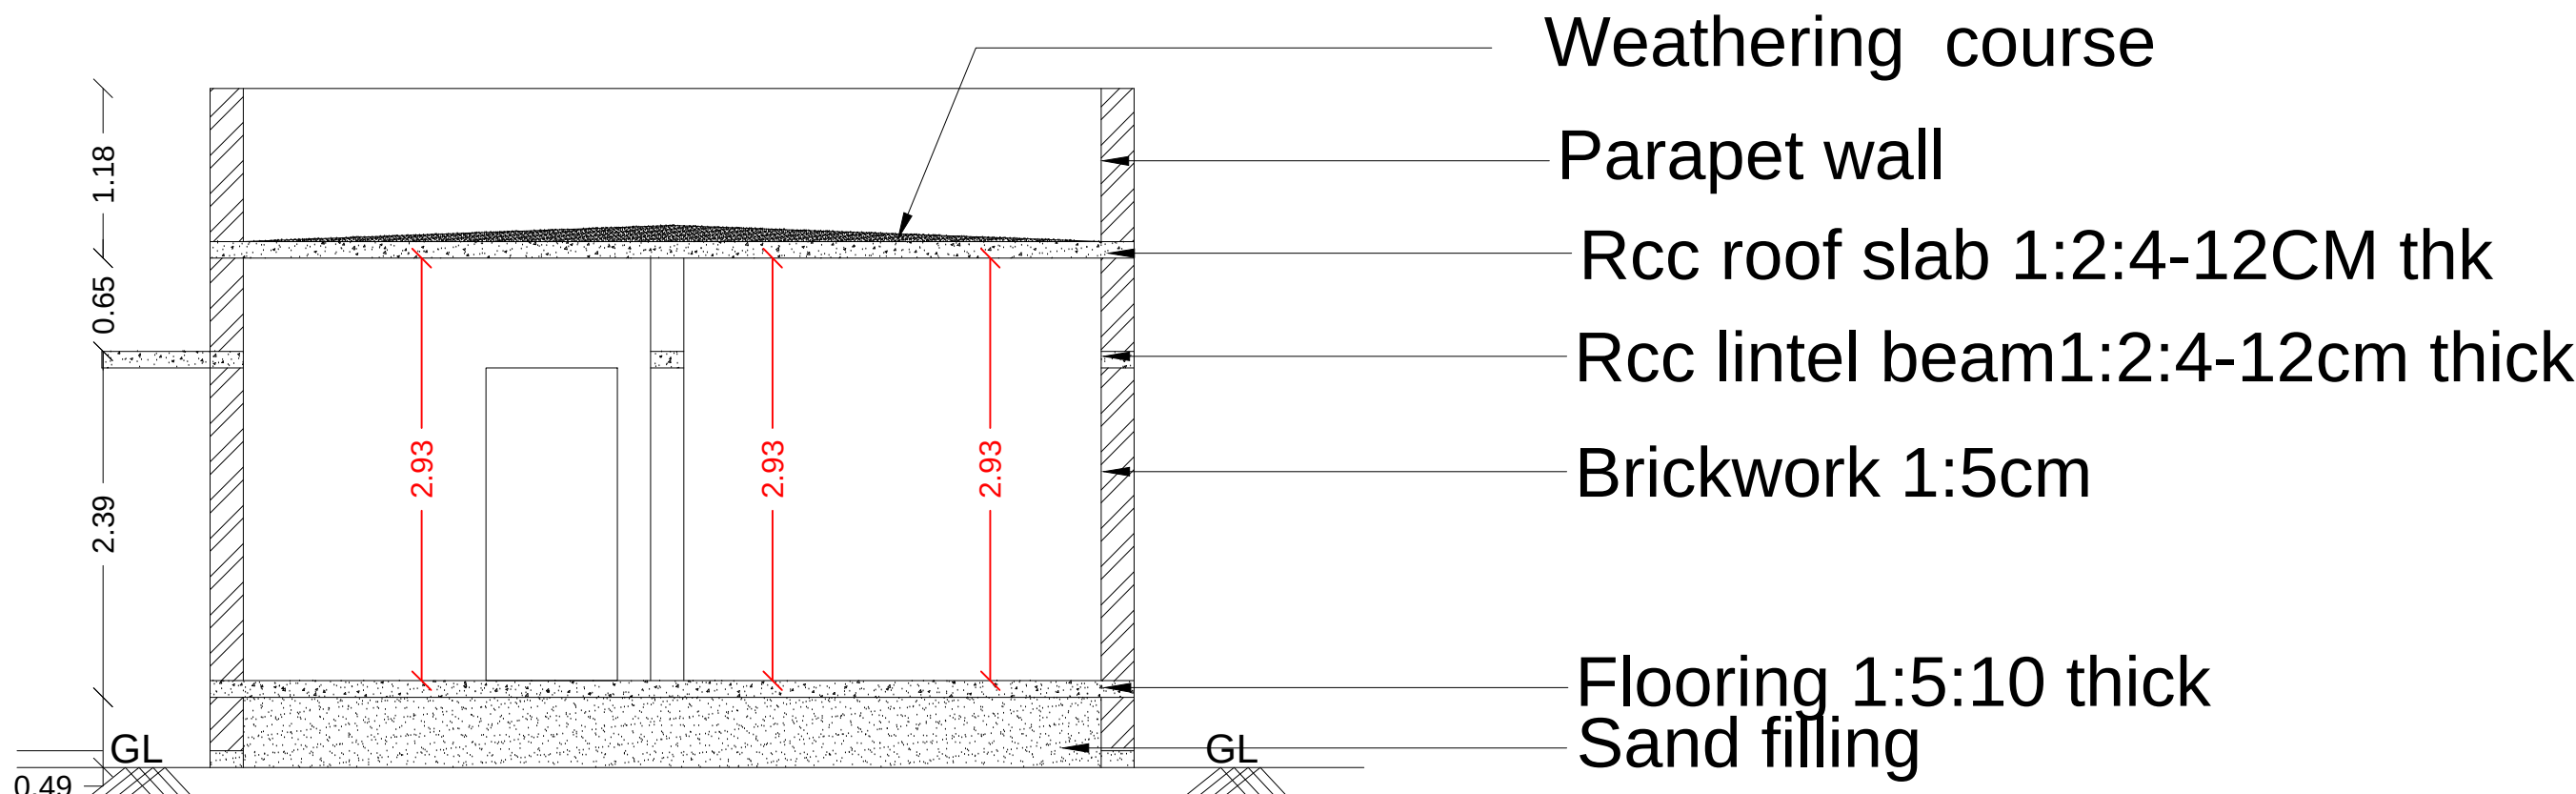


SECTION-AA

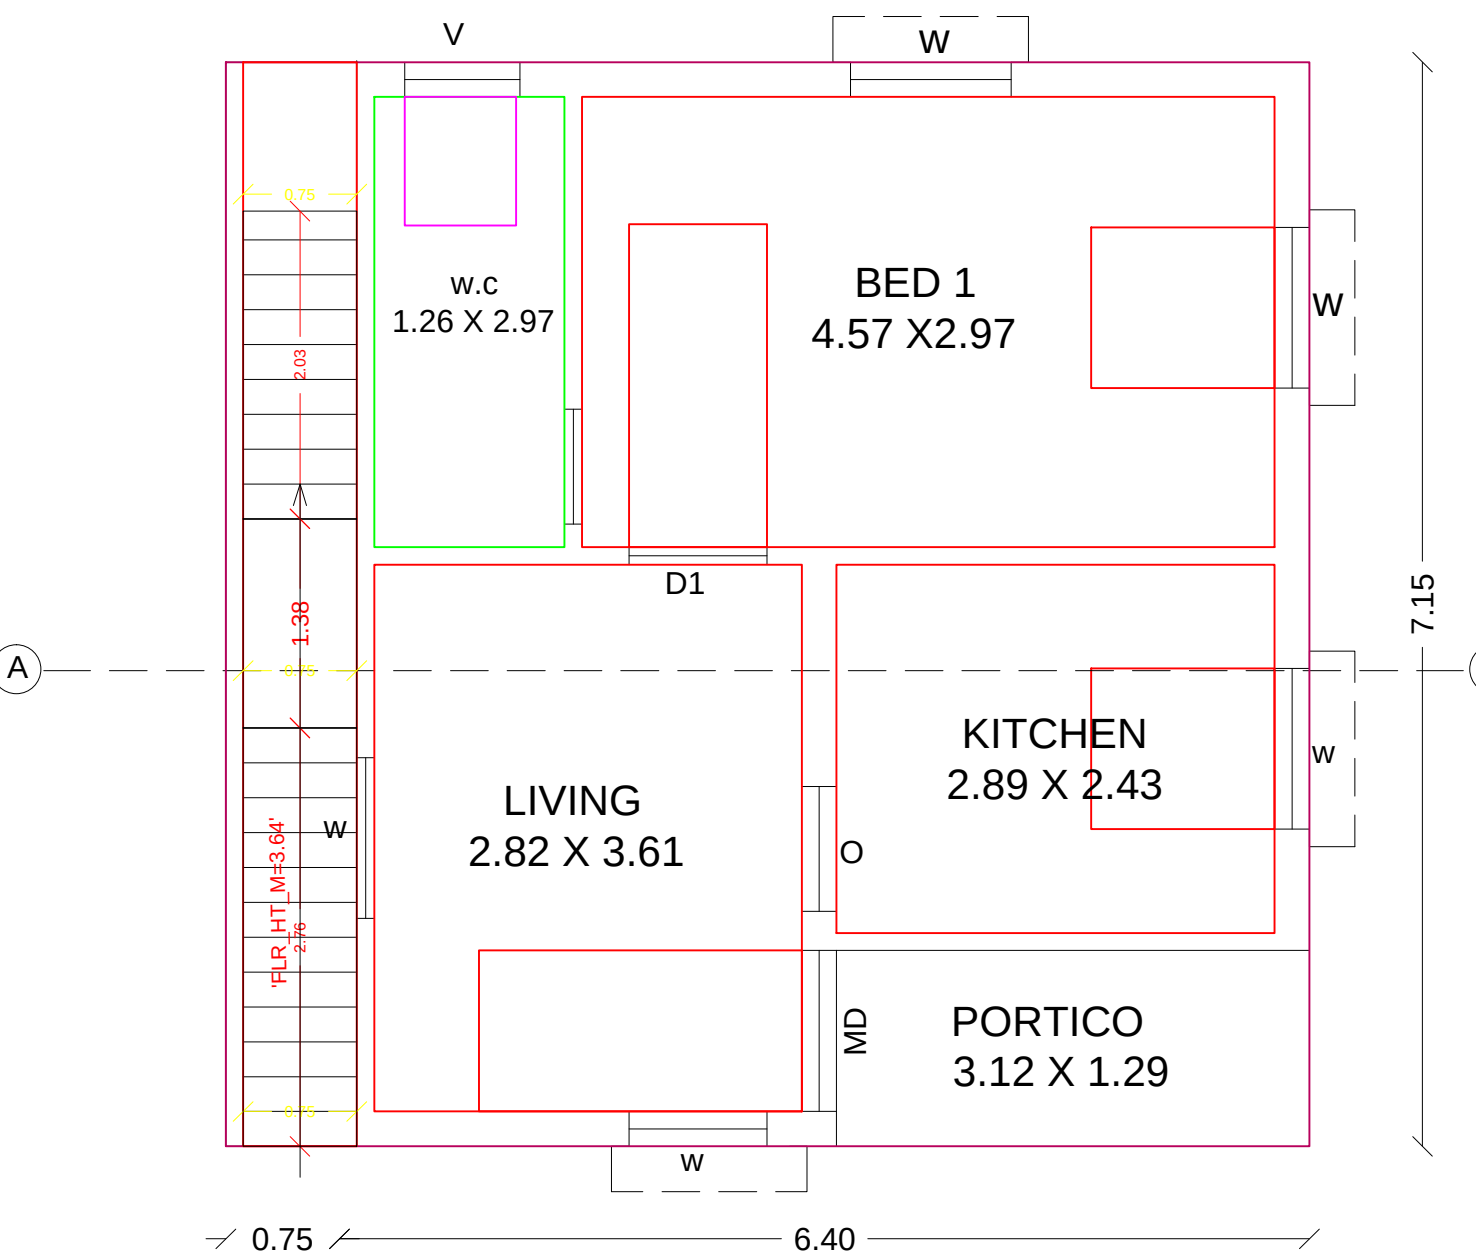


GROUND FLOOR PLAN


SOLAR PANEL FOR HEATING SYSTEM

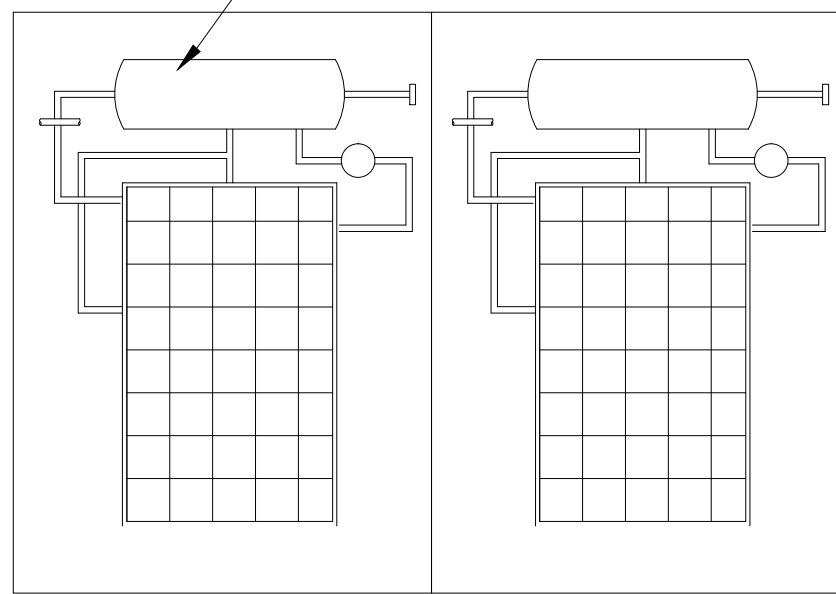


SOLAR HAETING SYSYTEM

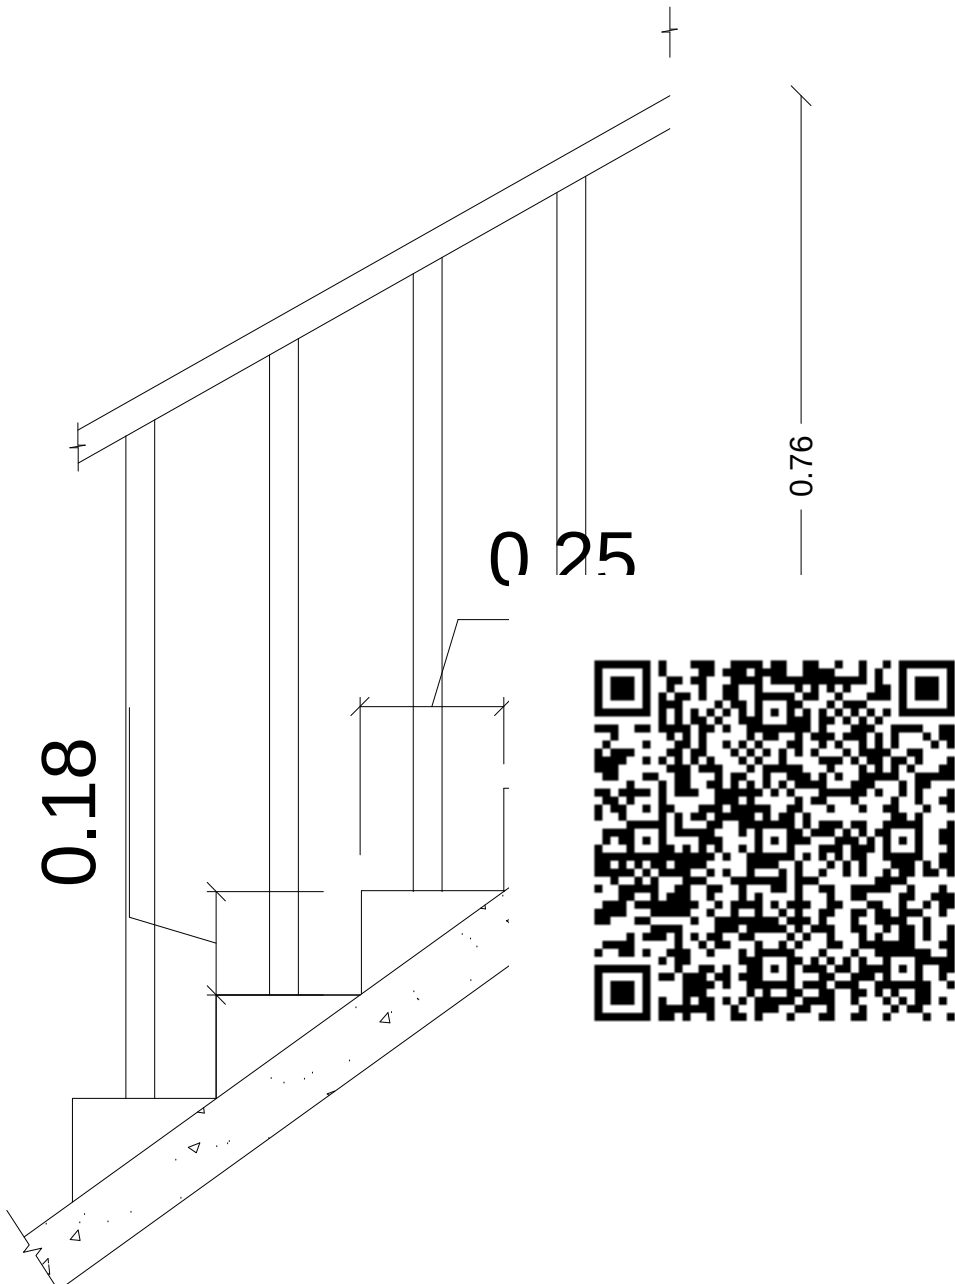


SECTION OF STAIRCASE

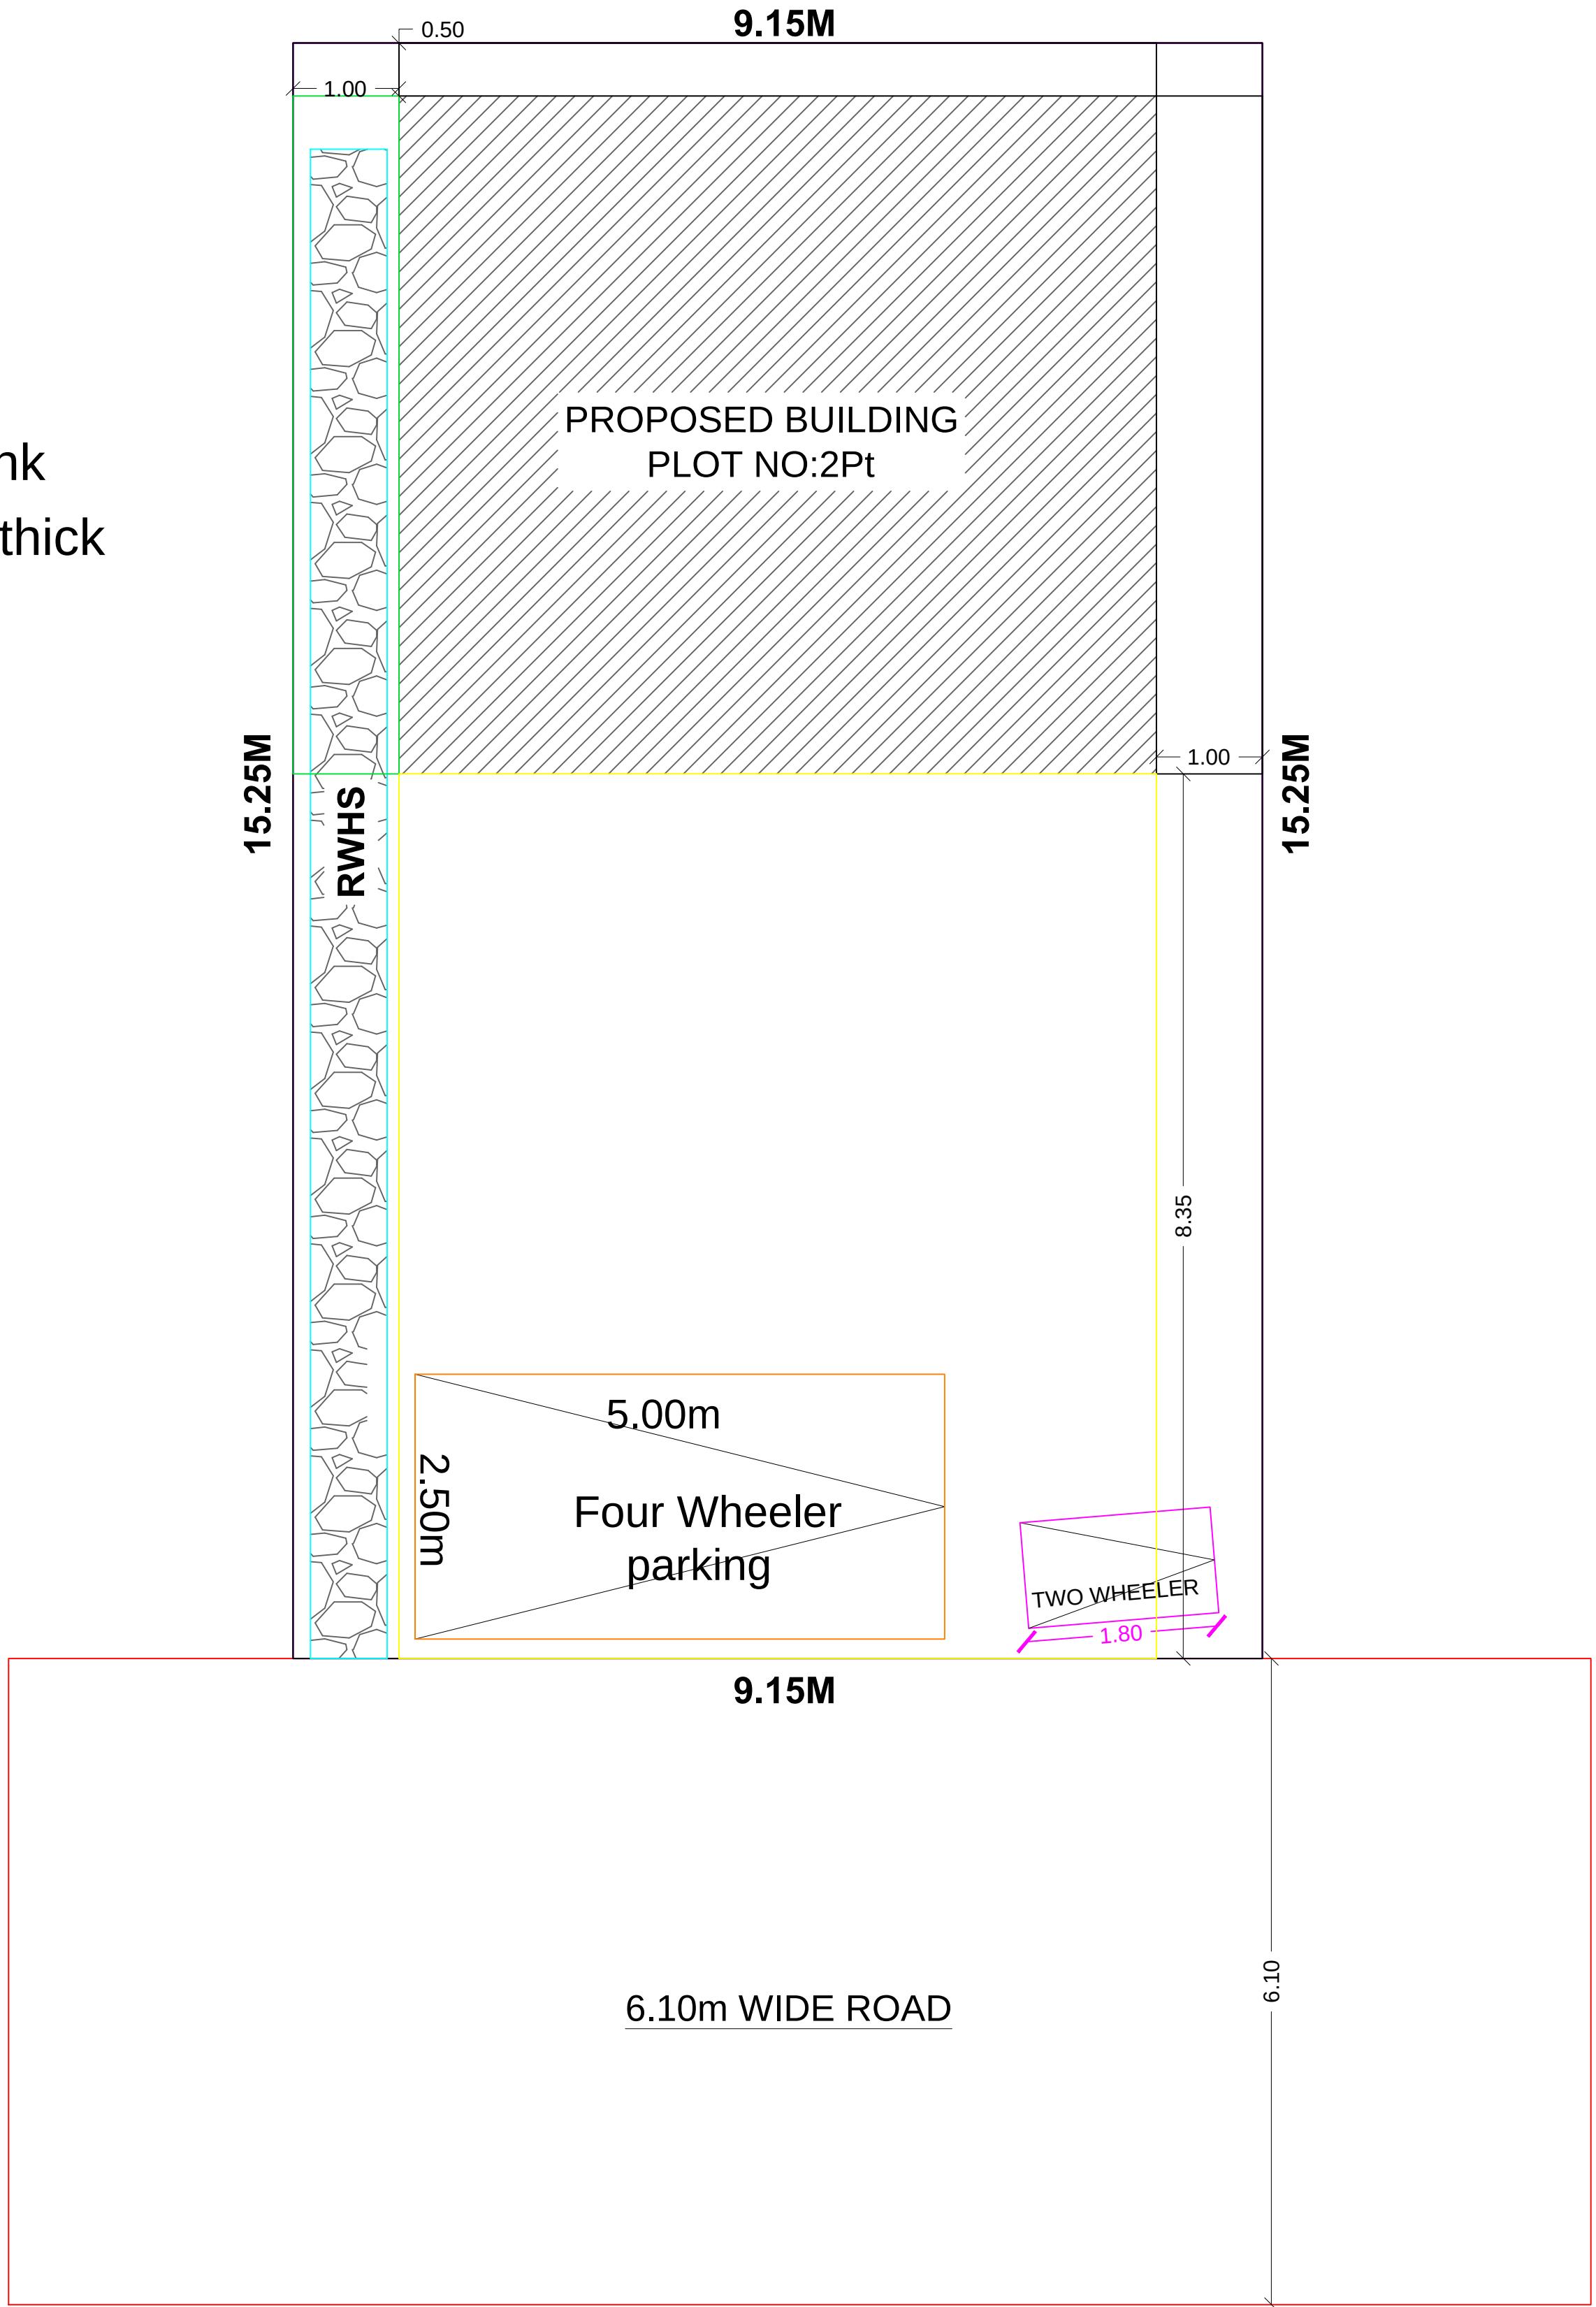


SITE PLAN

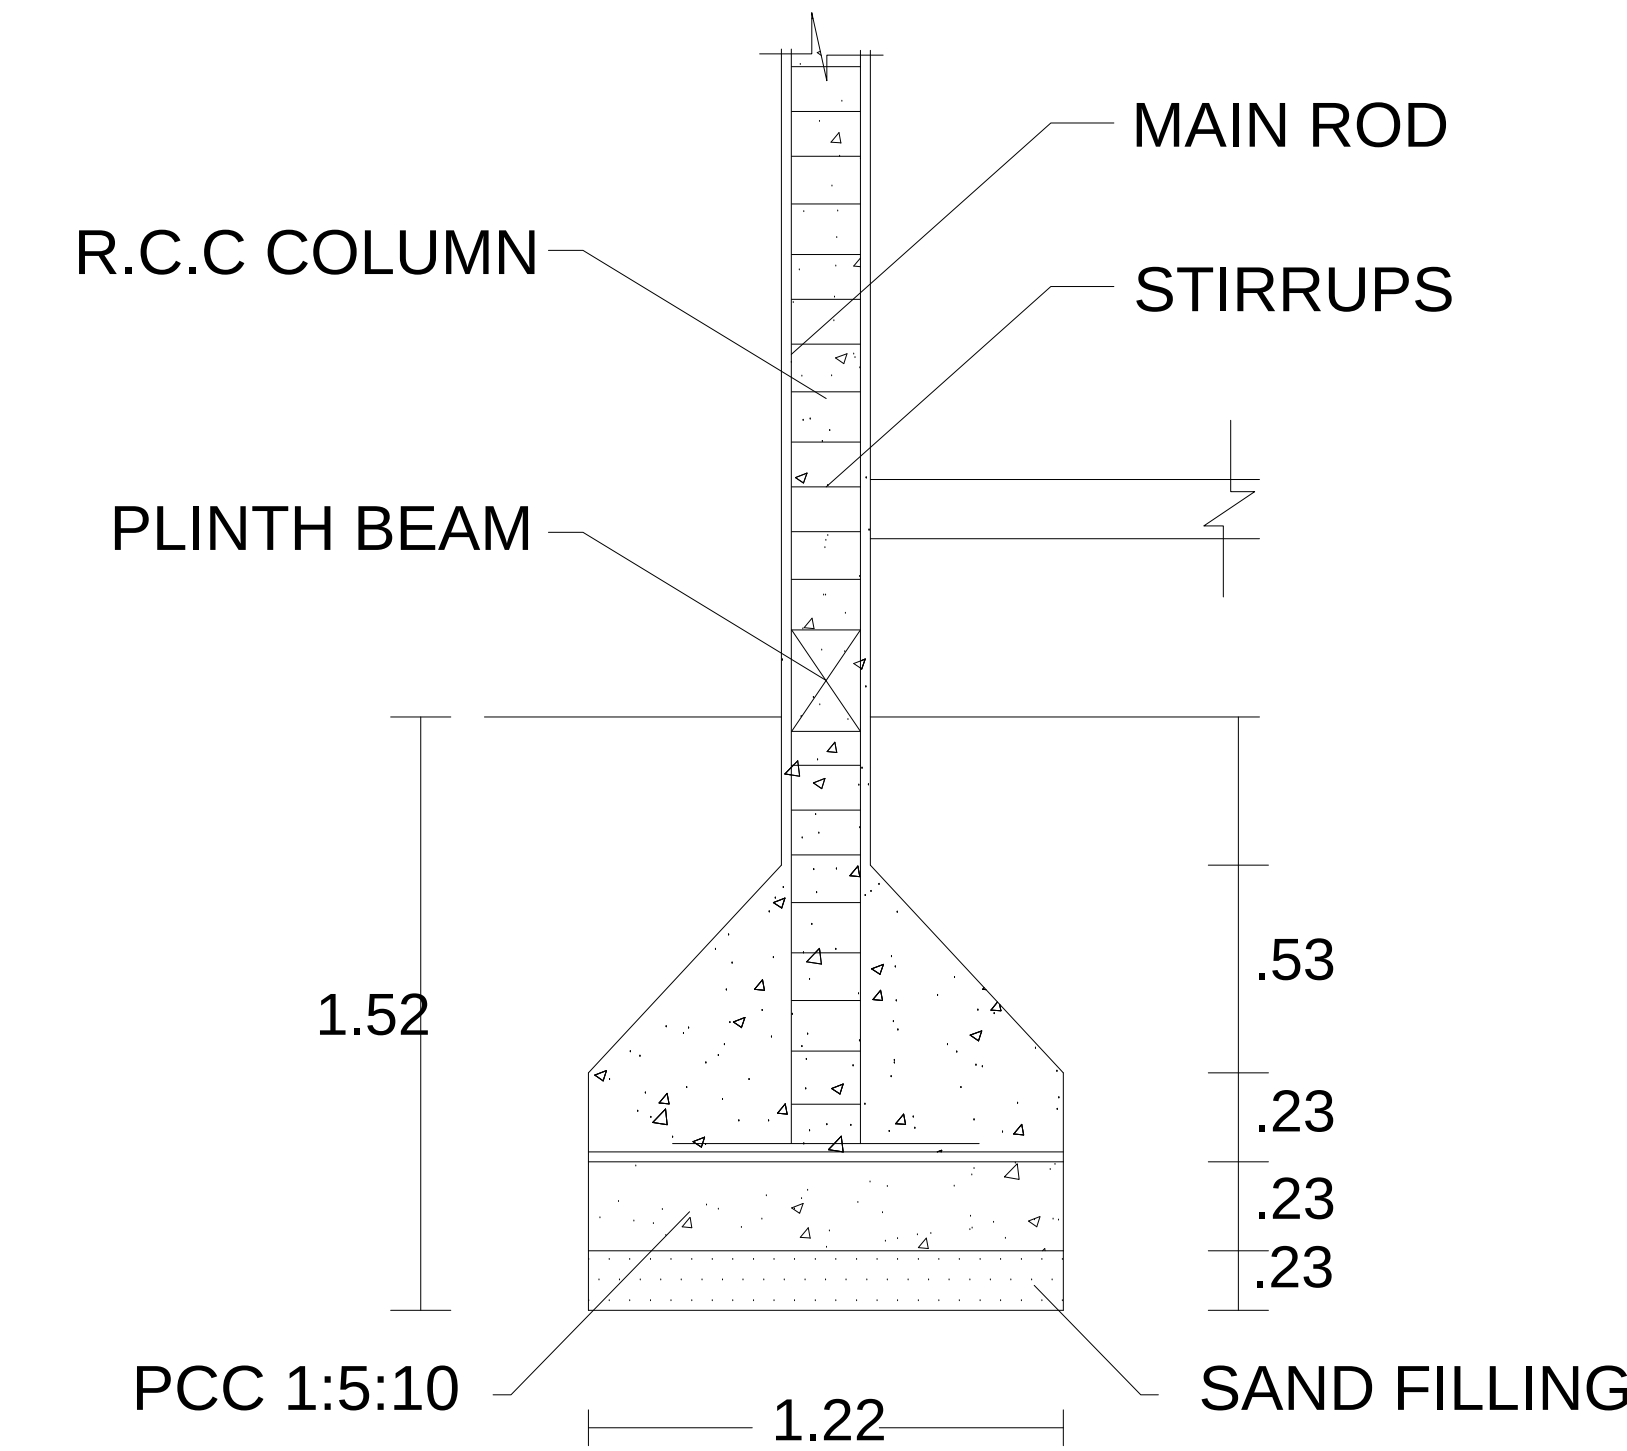


COLUMN DETAILS

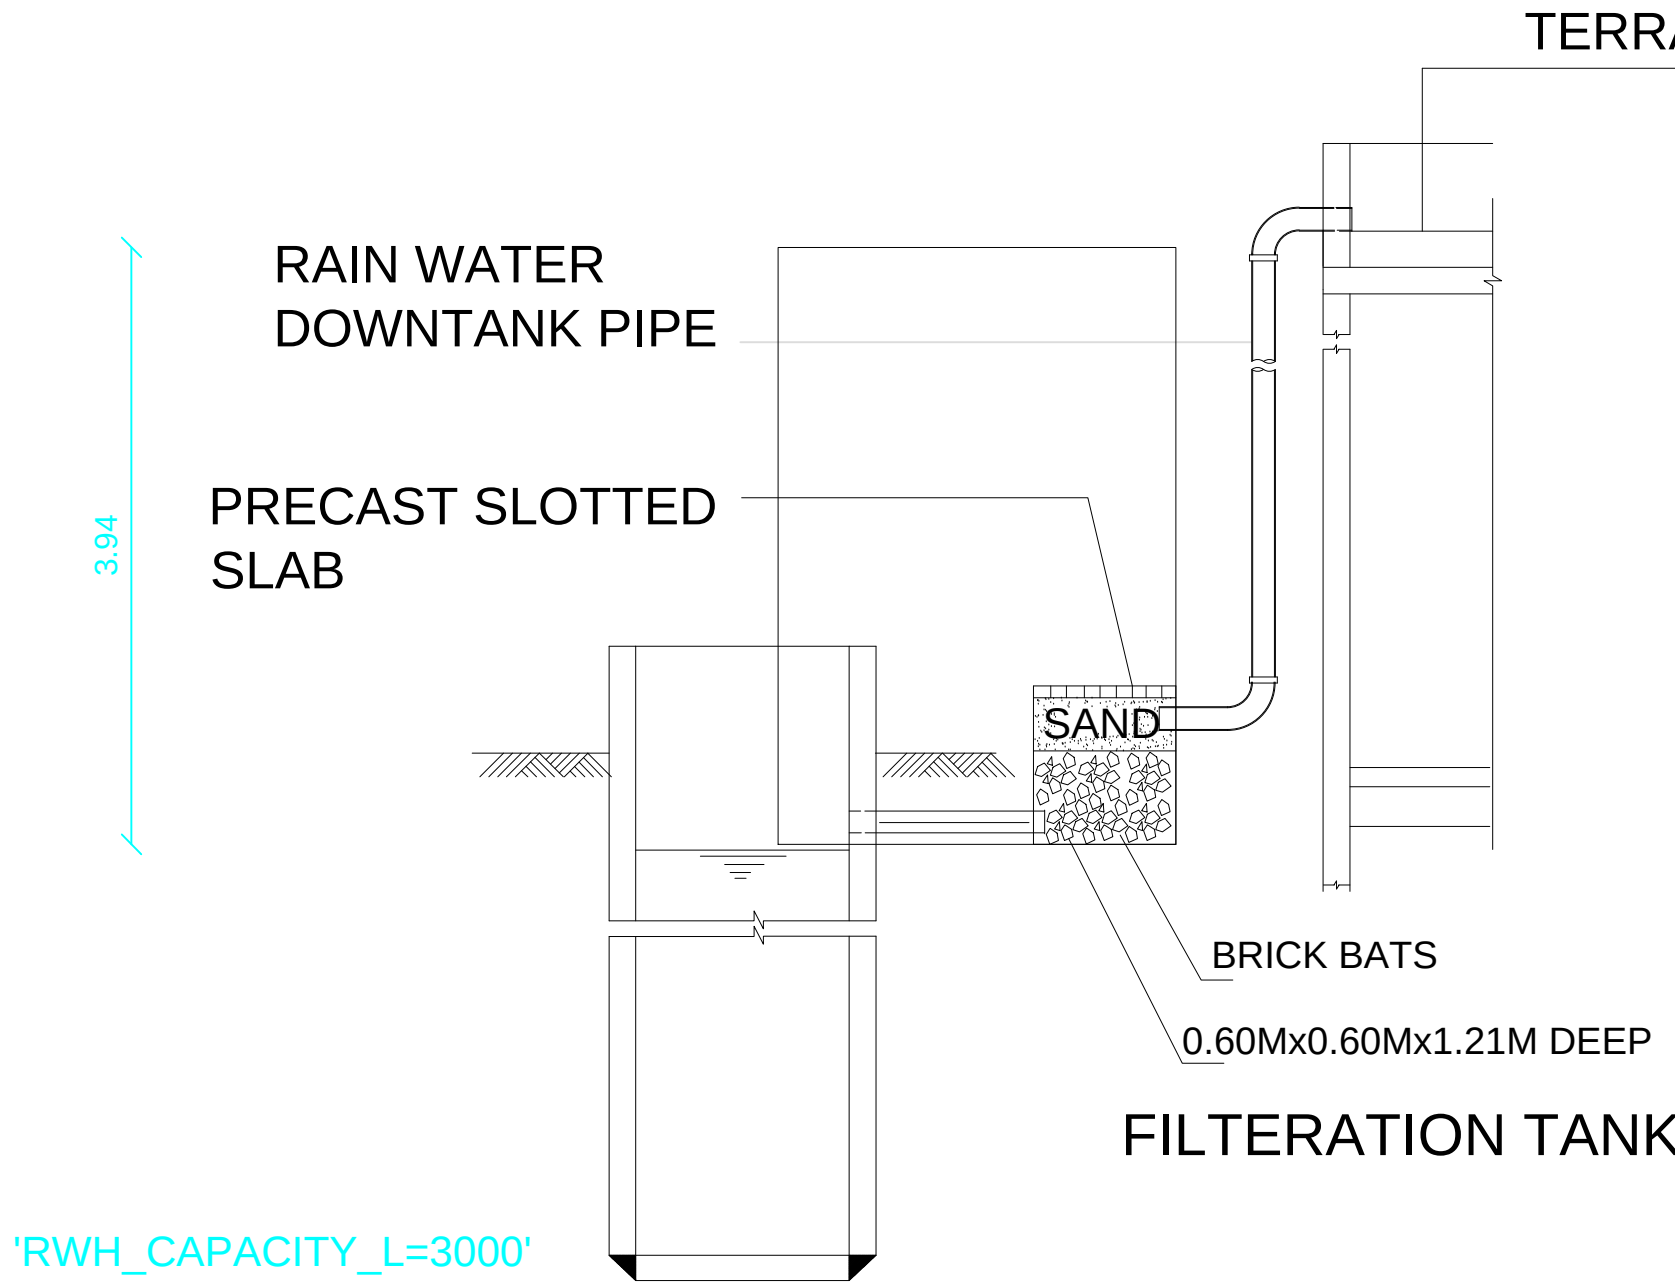


RAIN WATER HARVESTING SYSTEM

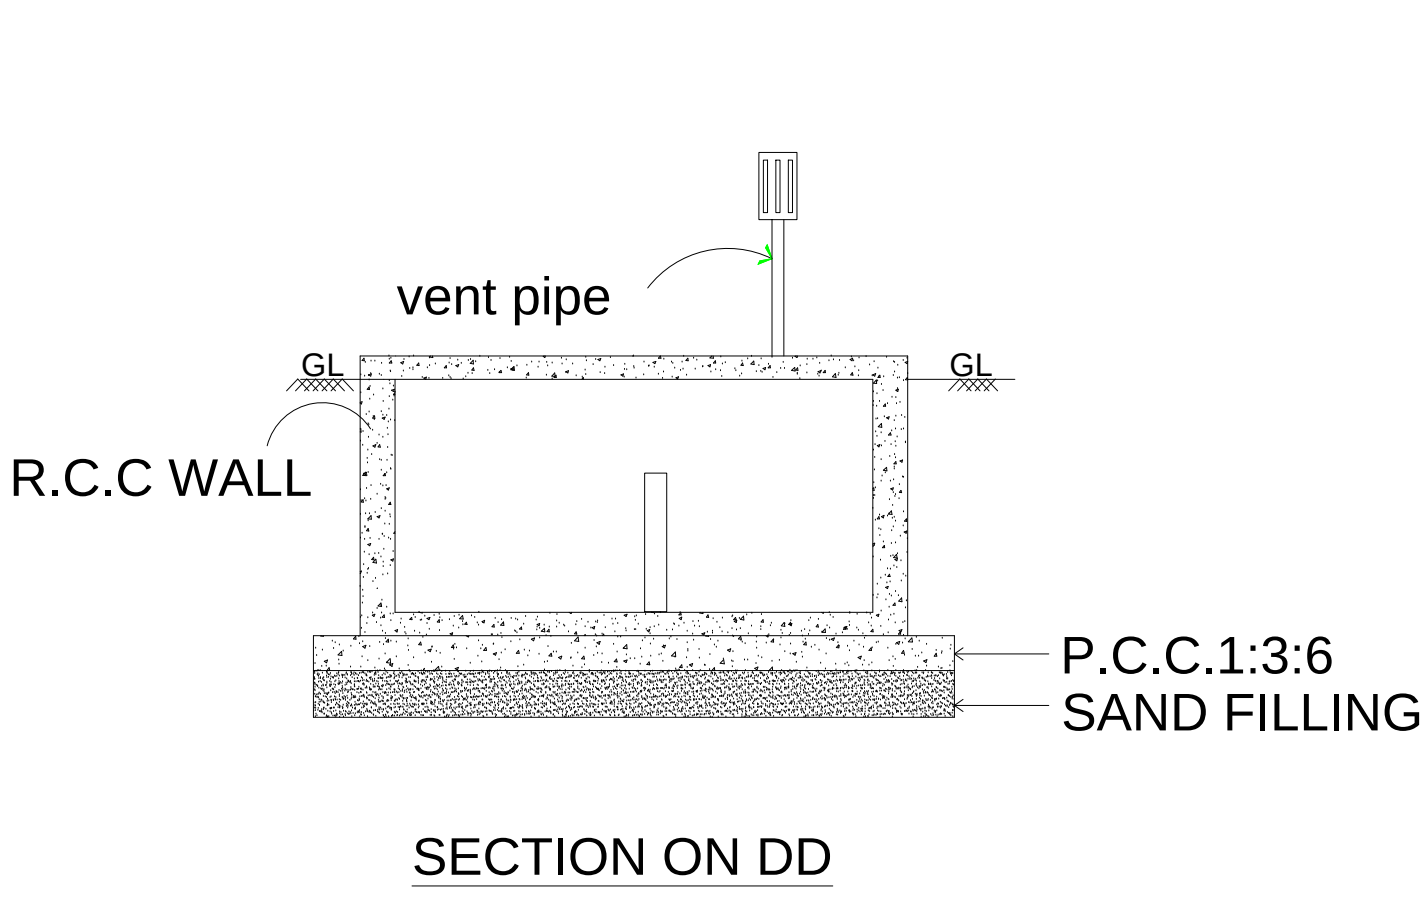


SECTION ON DD

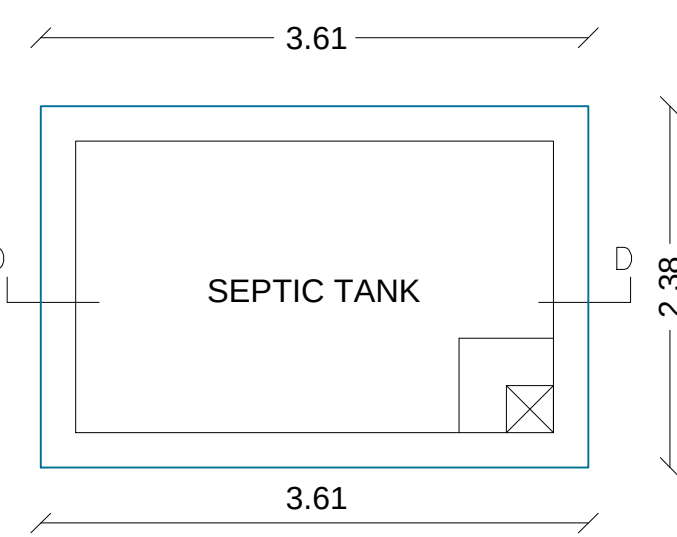


PLAN OF SEPTIC TANK

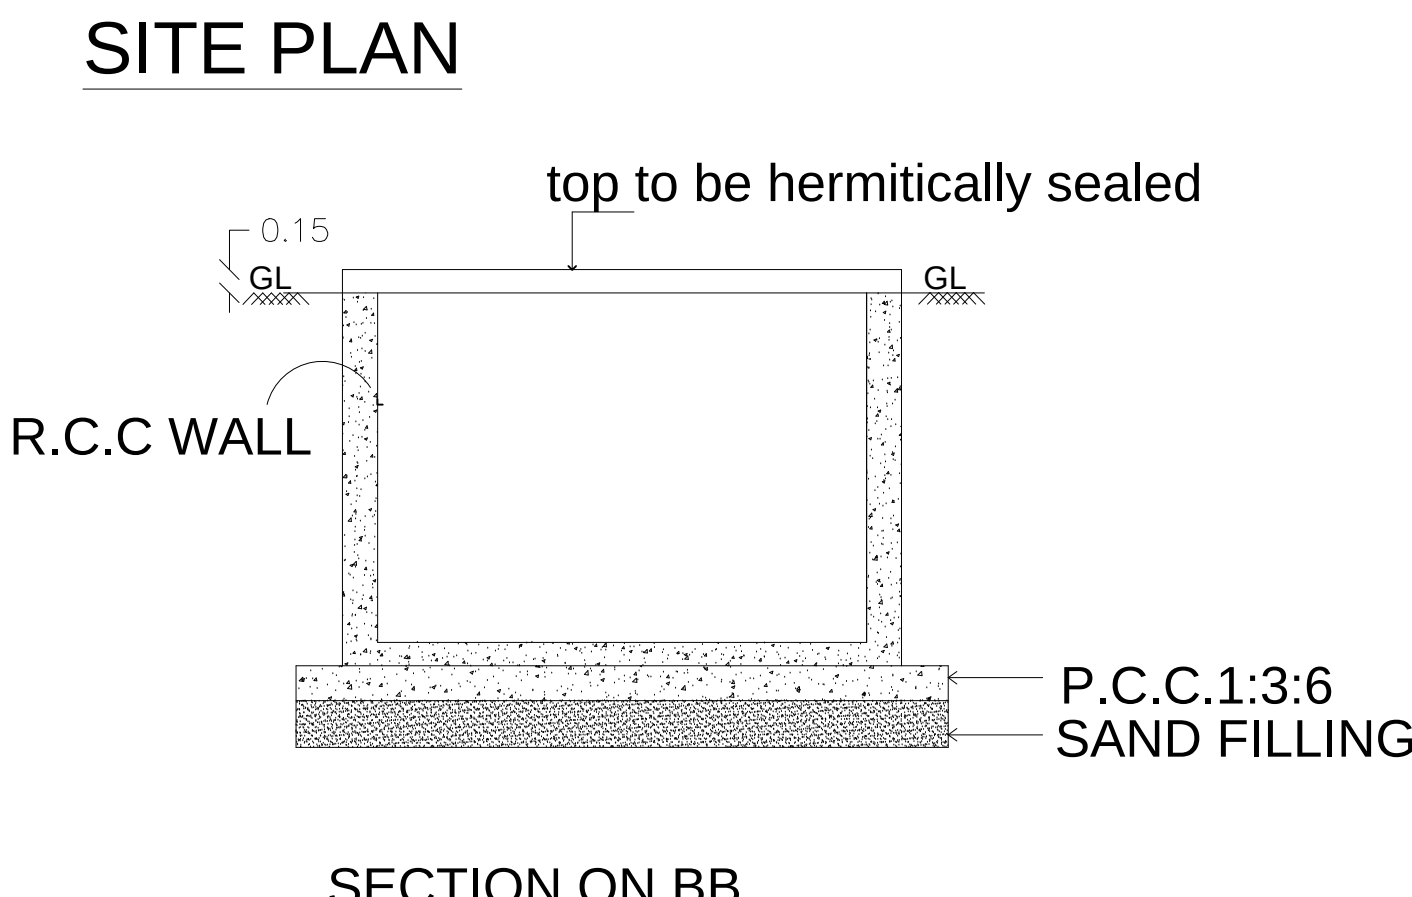

SECTION ON BB

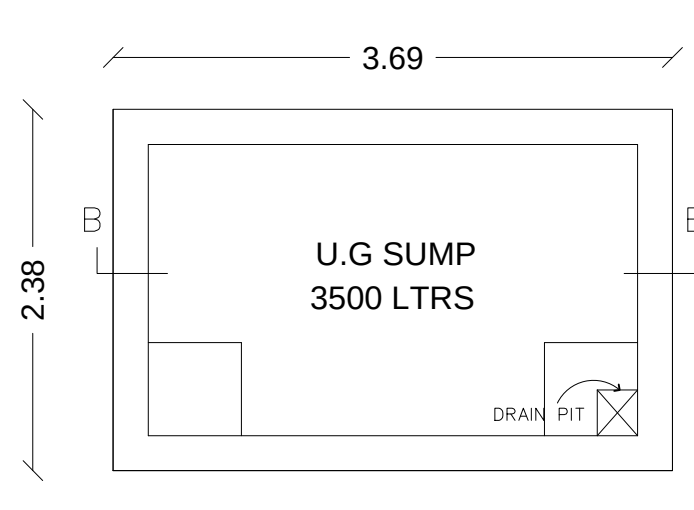

PLAN OF SUMP

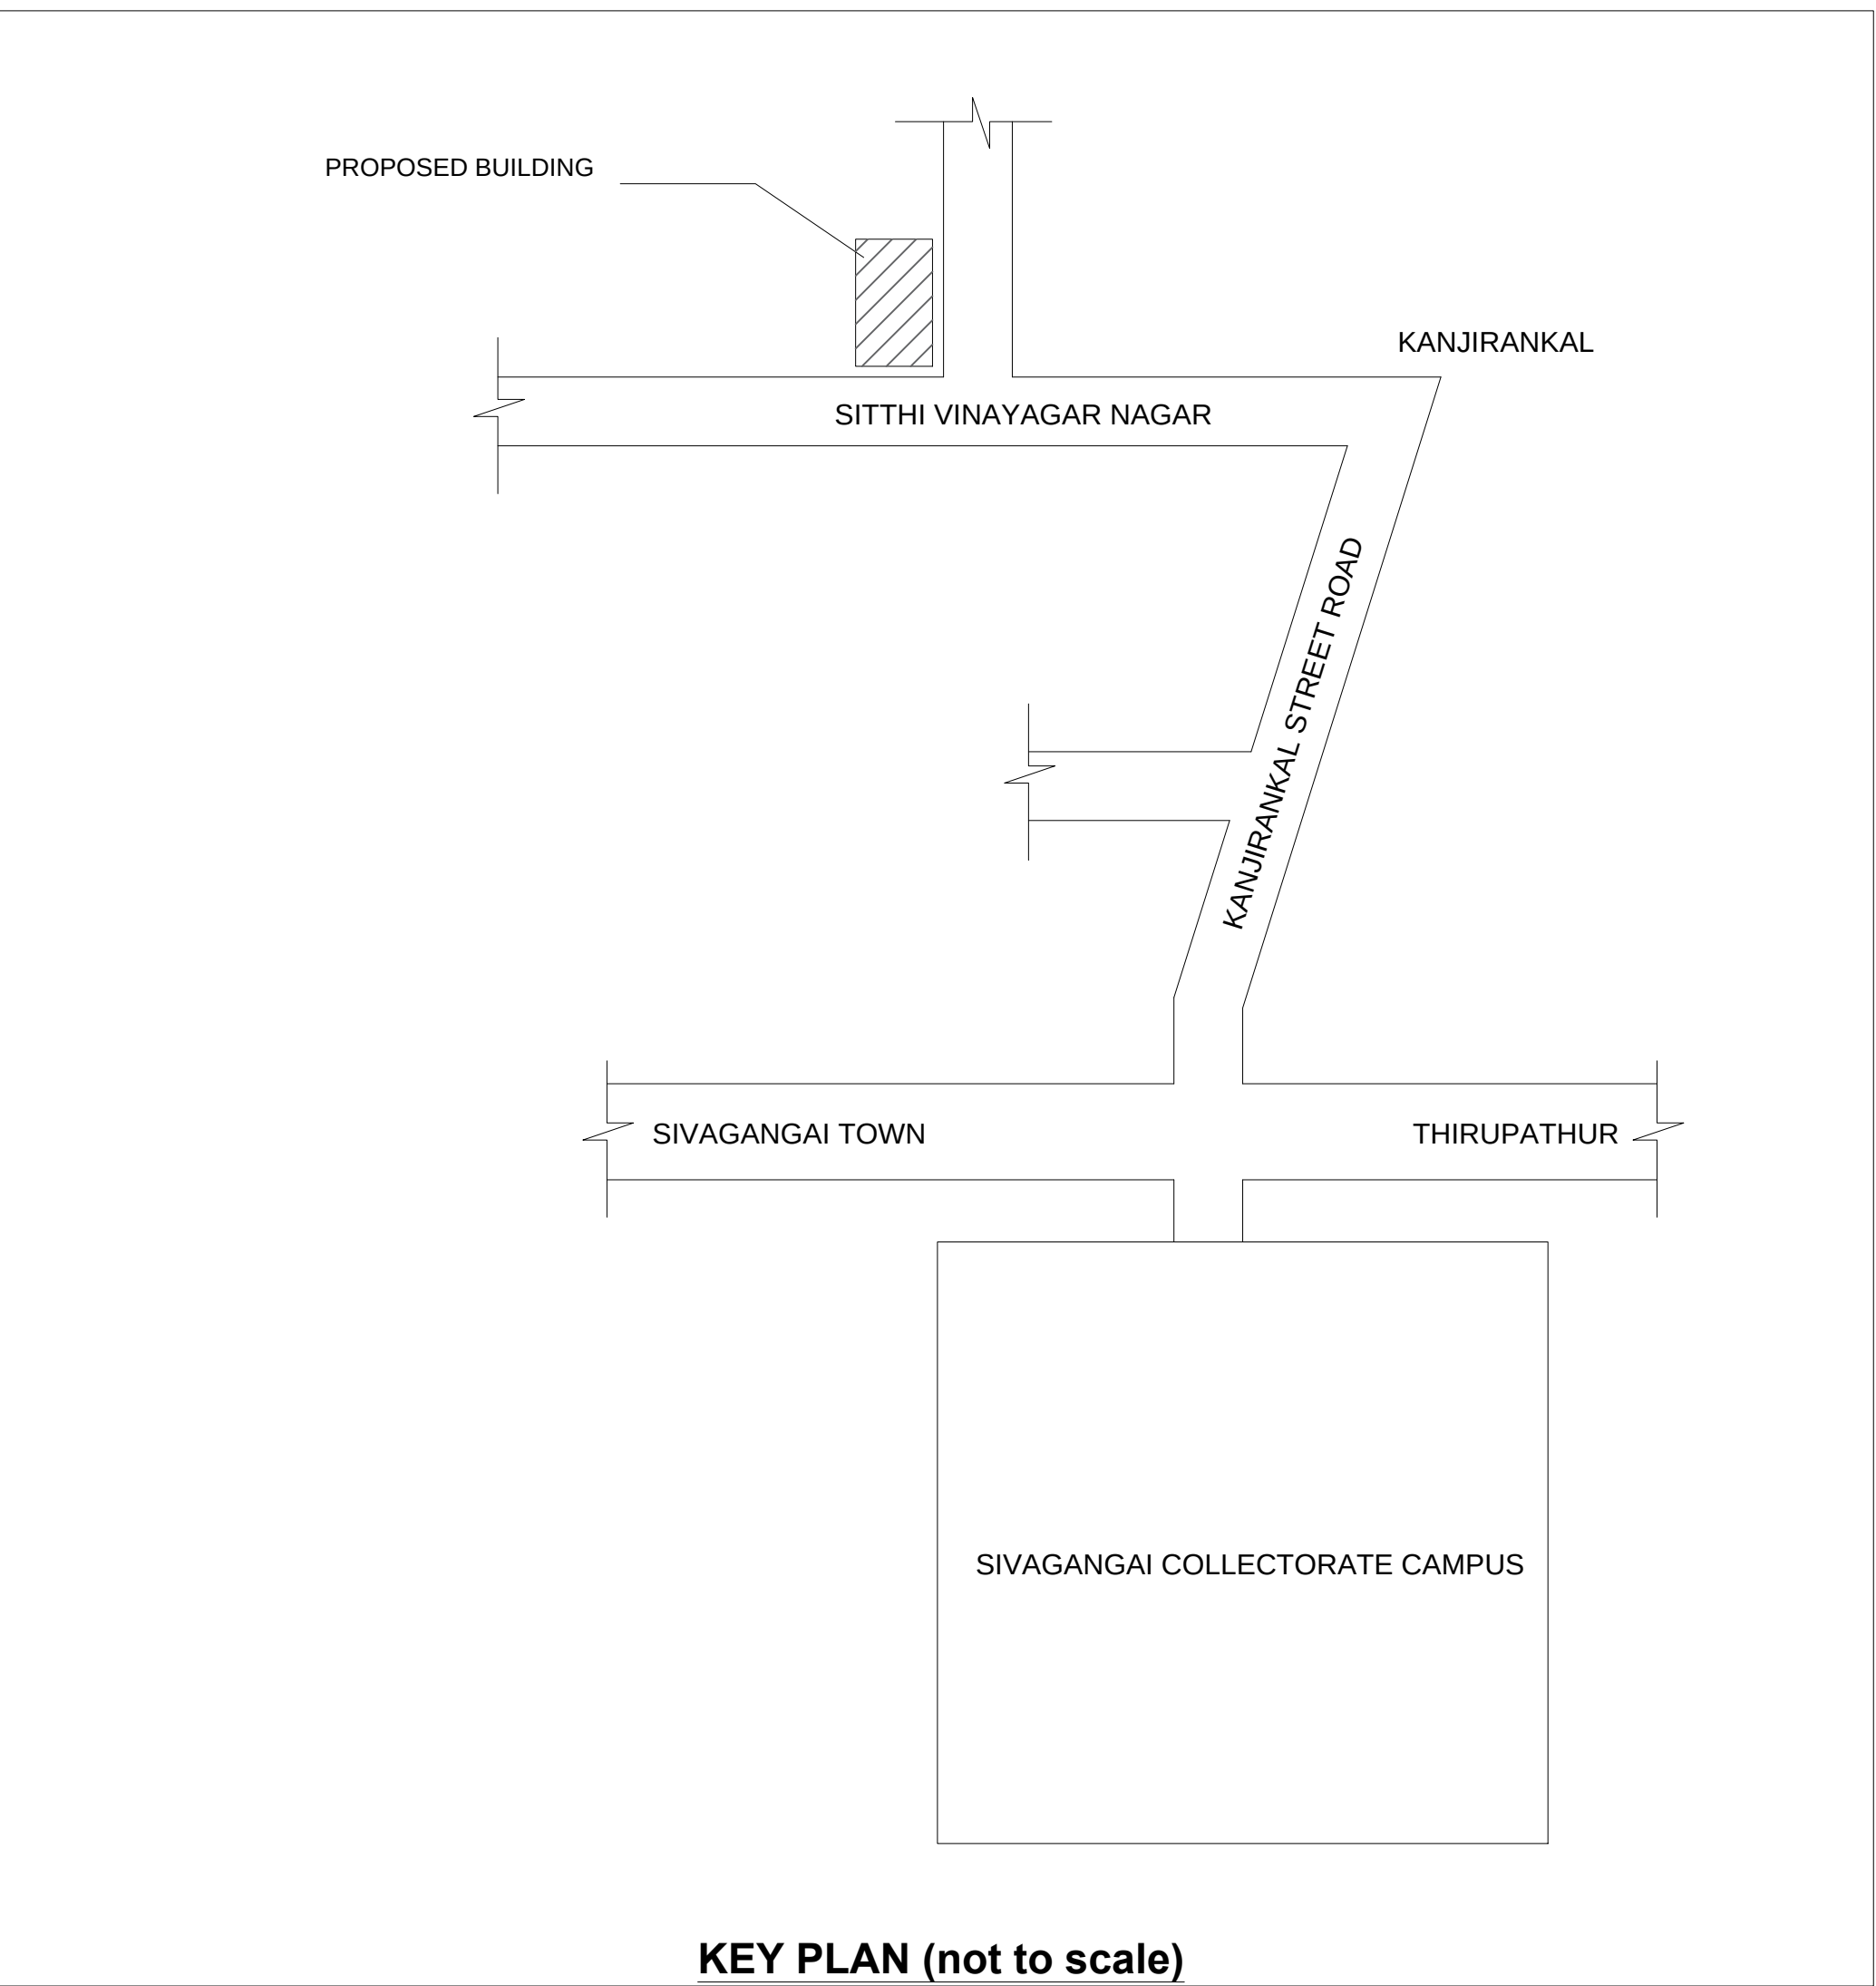

KEY PLAN (not to scale)