
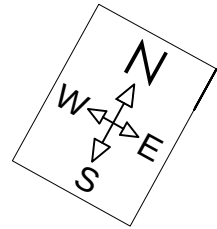


PLAN SHOWING THE PROPOSED CONSTRUCTION OF R.C.C. ROOF PETROL BUNK BUILDING (OFFICE CUM TOILET BLOCK)(BHARAT PETROLEUM CORPORATION LTD., (BP) AT SY.NO.335/7,NEW SY.NO.335/7A, OLD PATTa NO.209, NEW PATTa NO.1998, NOW PATTa NO.8179 IN PATHARAKUDI VILLAGE,PATHRAKUDI PANCHAYAT, MANAGIRI-SUKKANENDHAL GROUP, KALLAL UNION, KARAikUDI TALUK, SIVAGANGAI DISTRICT, TAMILNADU.

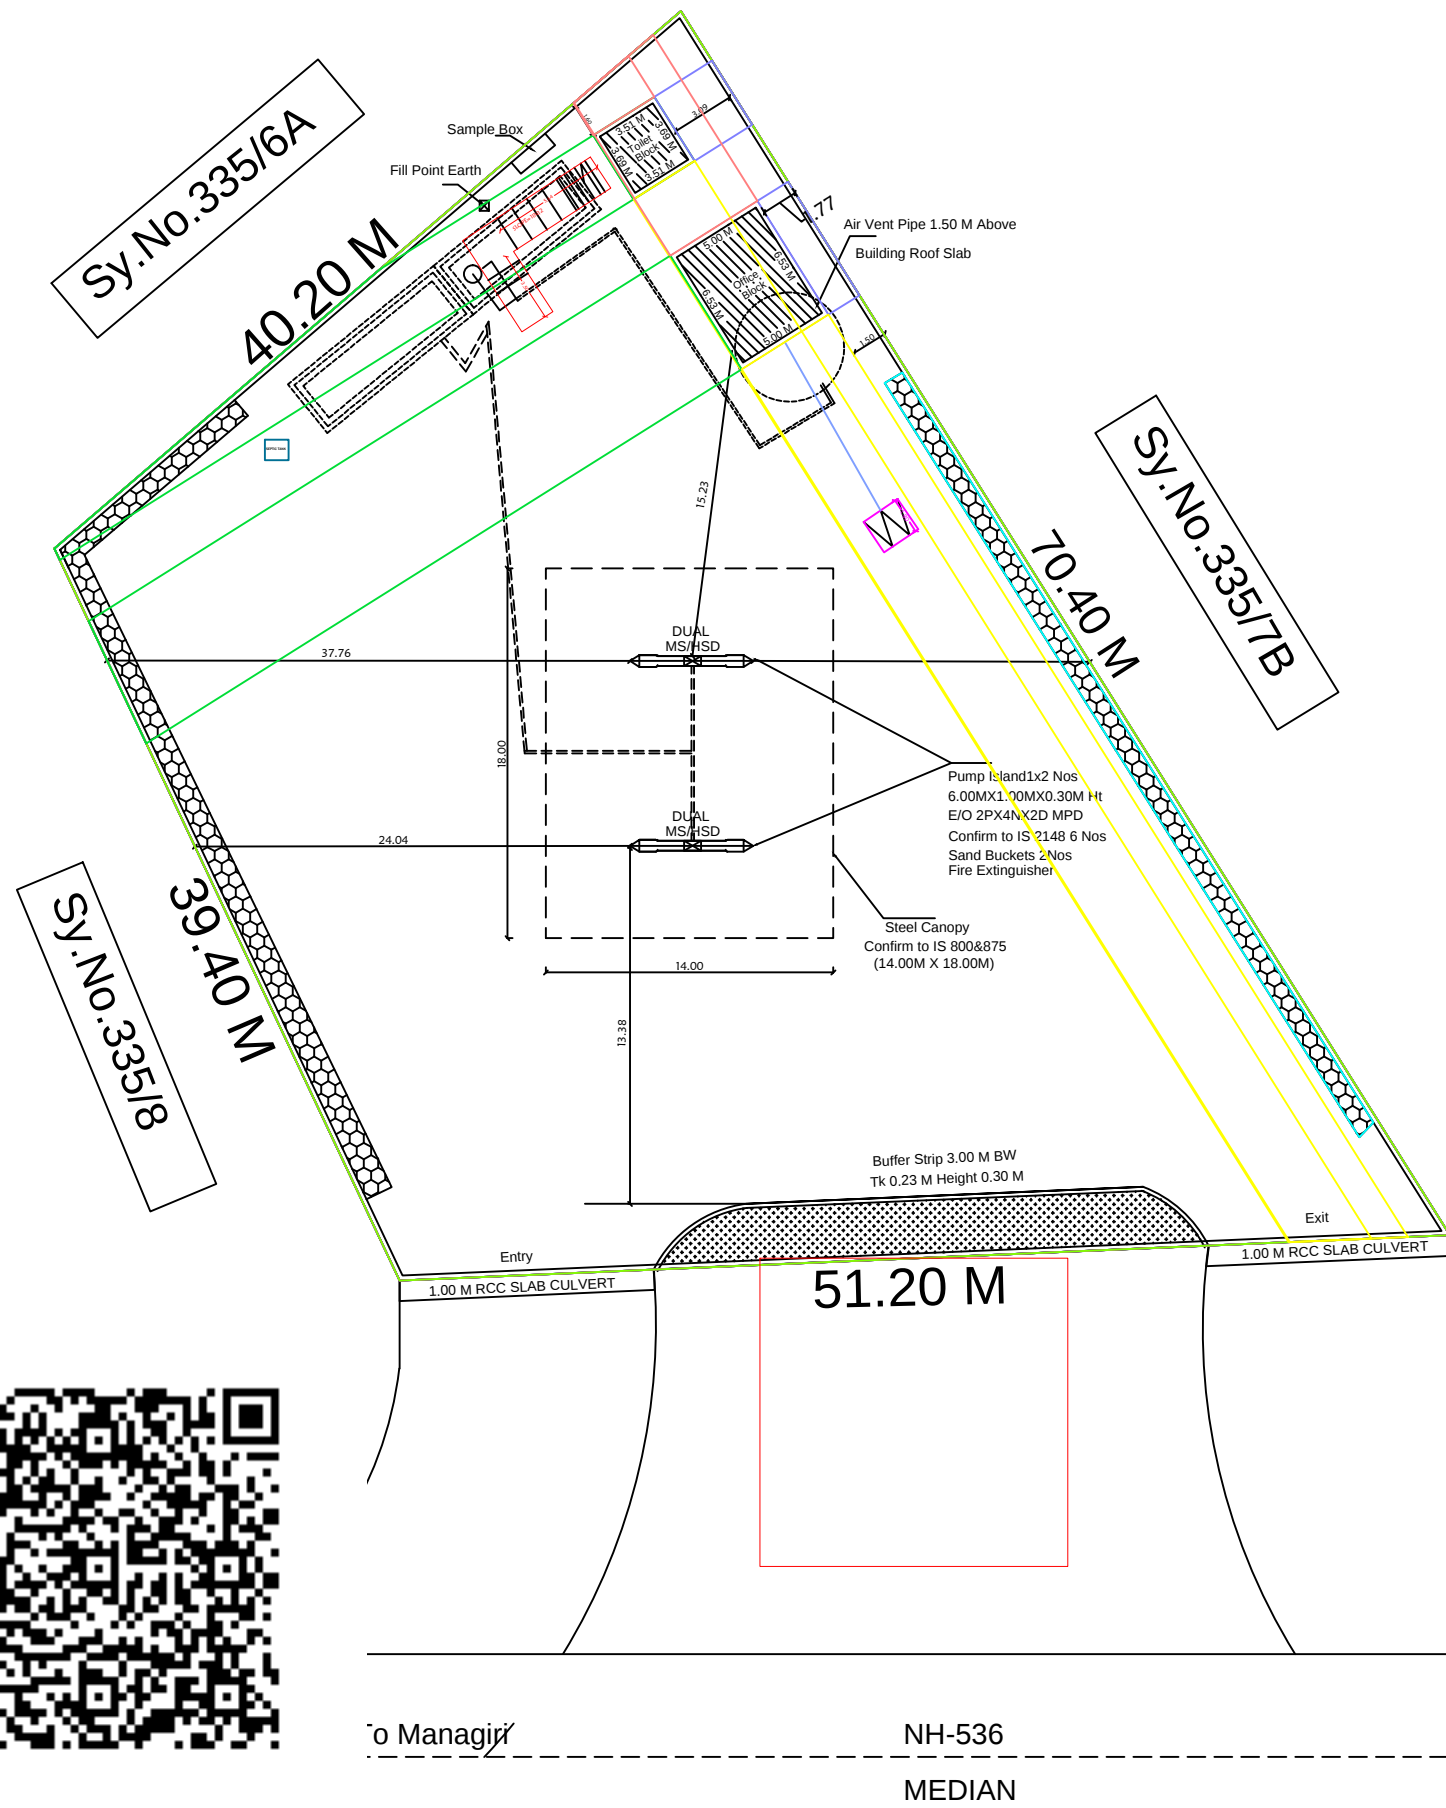

LEGEND	FEET	METRE
RD, D DOOR	3'0"x7'0"	0.92x2.13
MD MAIN DOOR	3'6"x7'0"	1.10x2.13
D1 DOOR	2'6"x7'0"	0.76x2.13
AO ARCH OPEN	3'0"x7'0"	0.92x2.13
W WINDOW	5'0"x4'6"	1.52x1.37
V VENTILATOR	3'0"x2'0"	0.91x0.60
AREA DETAILS	SQ.FT.	SQ.M.
As Per Document	23680.60	2200.00
As Per BP Sketch	23777.47	2209.00
As Per Site	23777.47	2209.00
PLINTH AREA DETAILS		
Sales Building Area	351.44	32.65
Toilet Building Area	139.39	12.95
Open Space Area	23286.64	2163.40
FSI DETAILS	PROPOSED	PERMISSIBLE
Total Plinth Area Plot Area 45.60 2209.00	0.02	2

OWNER'S NAME & SIGN:-

Thiru.V.Balasubramanian
S/o : Thiru.Velu

Name of the Applicant:-

Smt.B.Pugazharasi
W/o : Thiru.Balasubramanian

ENGINEER:-

Ln.Er. V. MUTHU, B.E., M.I.E., F.I.V., M.Sc. (Valuation),
Registered Valuer, (L.T.) Reg. No: 07 / 2004-05 (Wealth Tax) / IBB
Chartered Engineer, Structural Engineer,
Karaikudi Municipality Registered Engineer Grade - I
D.T.C.P & Collectorate Panel Engineer
M.R. CONSTRUCTIONS
No: 25, " Ever Green Complex ", College Road,
Karaikudi - 2, Sivagangai District.
Cell: 94432 26127, 6379891035

OFFICE:-

SITE PLAN
SCALE : 1:100

PLAN BY:



Ln.Er.V.Muthu B.E.,M.I.E.,F.I.V.,M.Sc., (RV)
MR CONSTRUCTIONS
No.25, Ever Green Complex, College Road
Karaikudi-630 002
Mob:94432 26127 ,6379891035