

OFFICE USE


CERTIFICATE	
◆ Rain water will be Collected Through pits. ◆ U-Trab will be provided in septic tank. ◆ Waste Water will be Utilised by Gardening. ◆ Exhaust fan will be provide in Kitchen room.	

APPLICANT SIGN.

Er. C. MURUGESAN, M.E.(Str), M.Sc.(Val), M.B.A., LL.B.
PGDCC, D.Astro., FIV, MIE, MIAStE, MITA, Arbo., P.E.MISSE
Structural & Chartered Engineer, Master Value(IT) and IBE
Regd. Civil Engineer Grade I (RE), Regn.No. RE/Gr.1/SVG Regn / 013/2019
CEE YEM CONSTRUCTIONS No.1, Subramaniasapuram
4th Street Corner, Near I.O.B.Ro, College Road, Karaikkudi.
Cell: 9443466241

REGISTERED ENGINEER SIGN

ER. C.MURUGESAN.,BE., ME., MBA., MSc.,PGDCC
 **CEE YEM CONSTRUCTIONS**
 REGISTERED -ENGINEER / STRUCTURAL/SOIL/
 CONSTRUCTION ENGINEER
 9443466241 KARAUKUDI

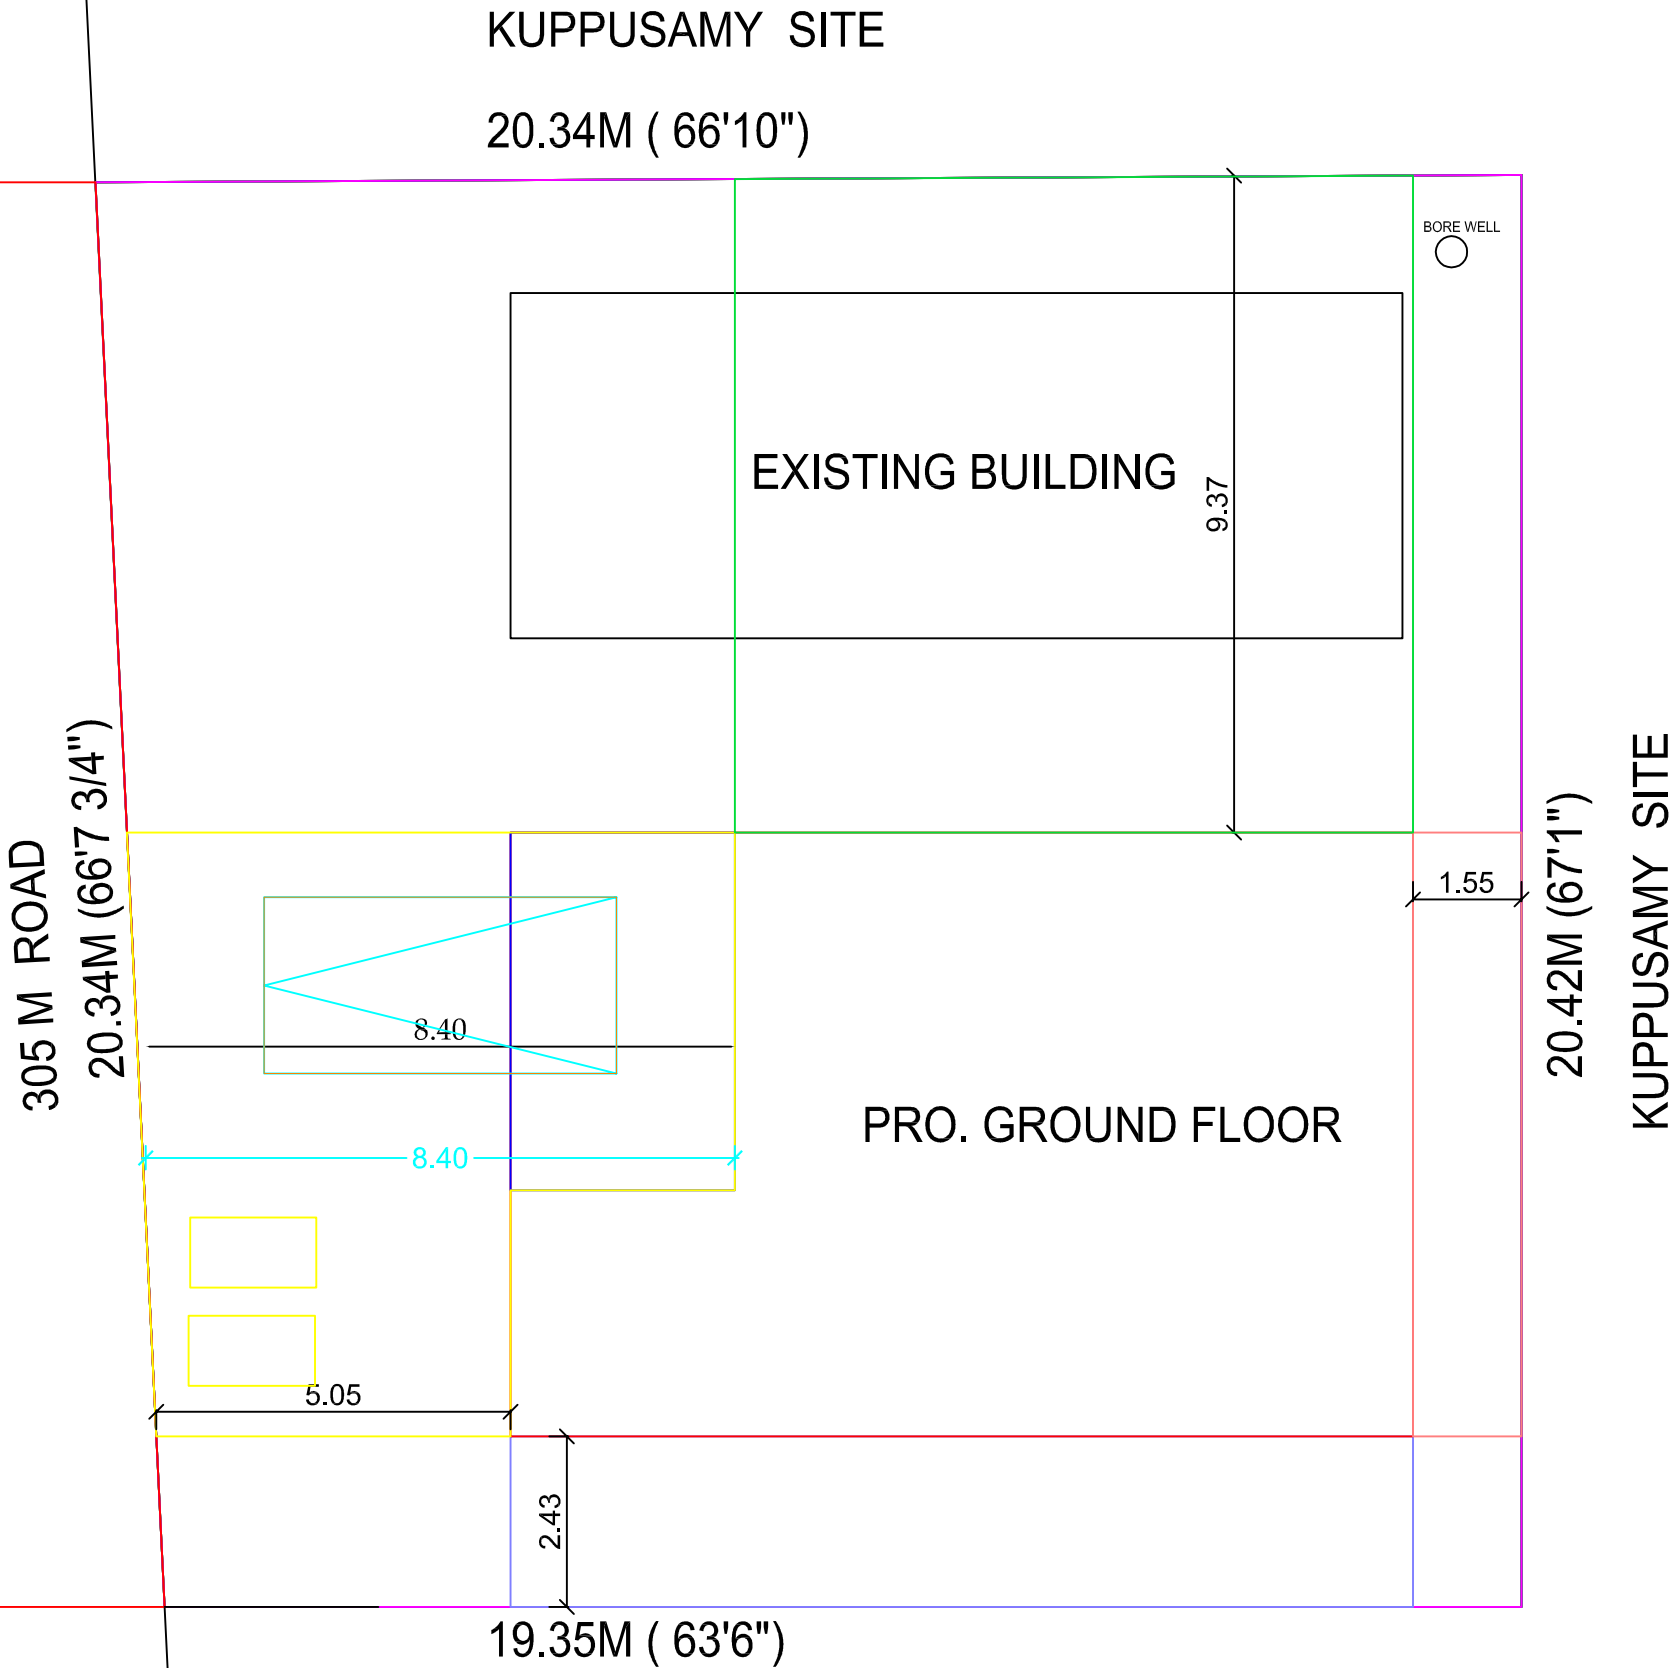

PRO. GROUND FLOOR

CHINNAIAH SITE

SITE PLAN SCALE 1 :100