

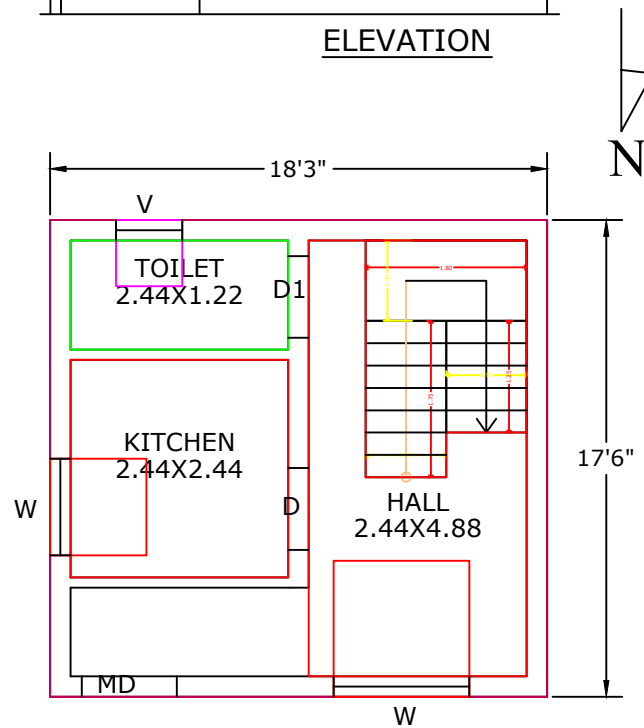
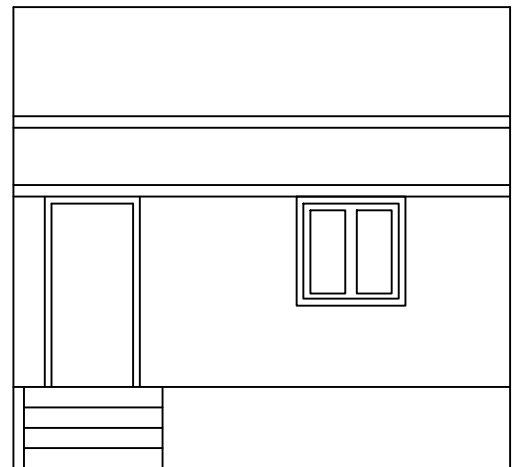



PLAN SHOWING THE PROPOSED CONSTRUCTION OF A RCC ROOF RESIDENTIAL BUILDING S.NO:123/3C,
PATHUPPATTI (THERKANENTHAL)VILLAGE, MELACHORIKULAM PANCHAYAT, THIRUPPUVANAM PANCHAYAT
UNION, THIRUPPUVANAM TALUK, SIVAGANGAI DISRTICT.

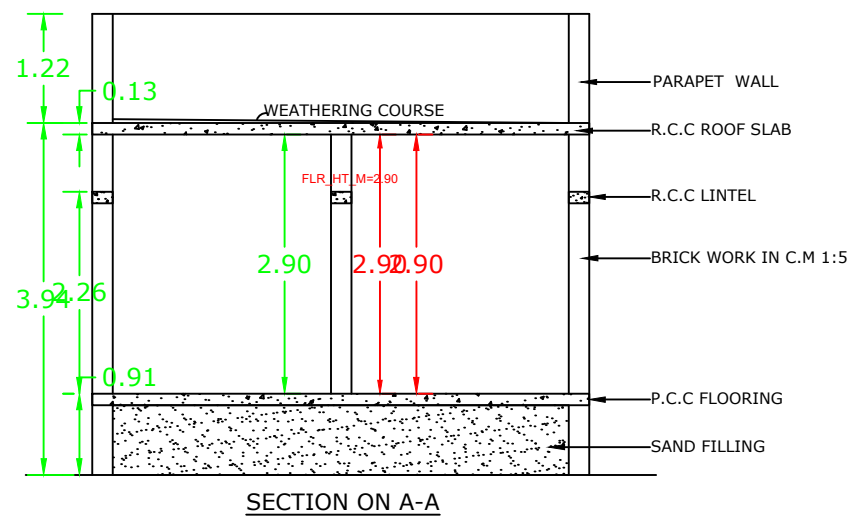




PRO.GROUND FLOOR PLAN

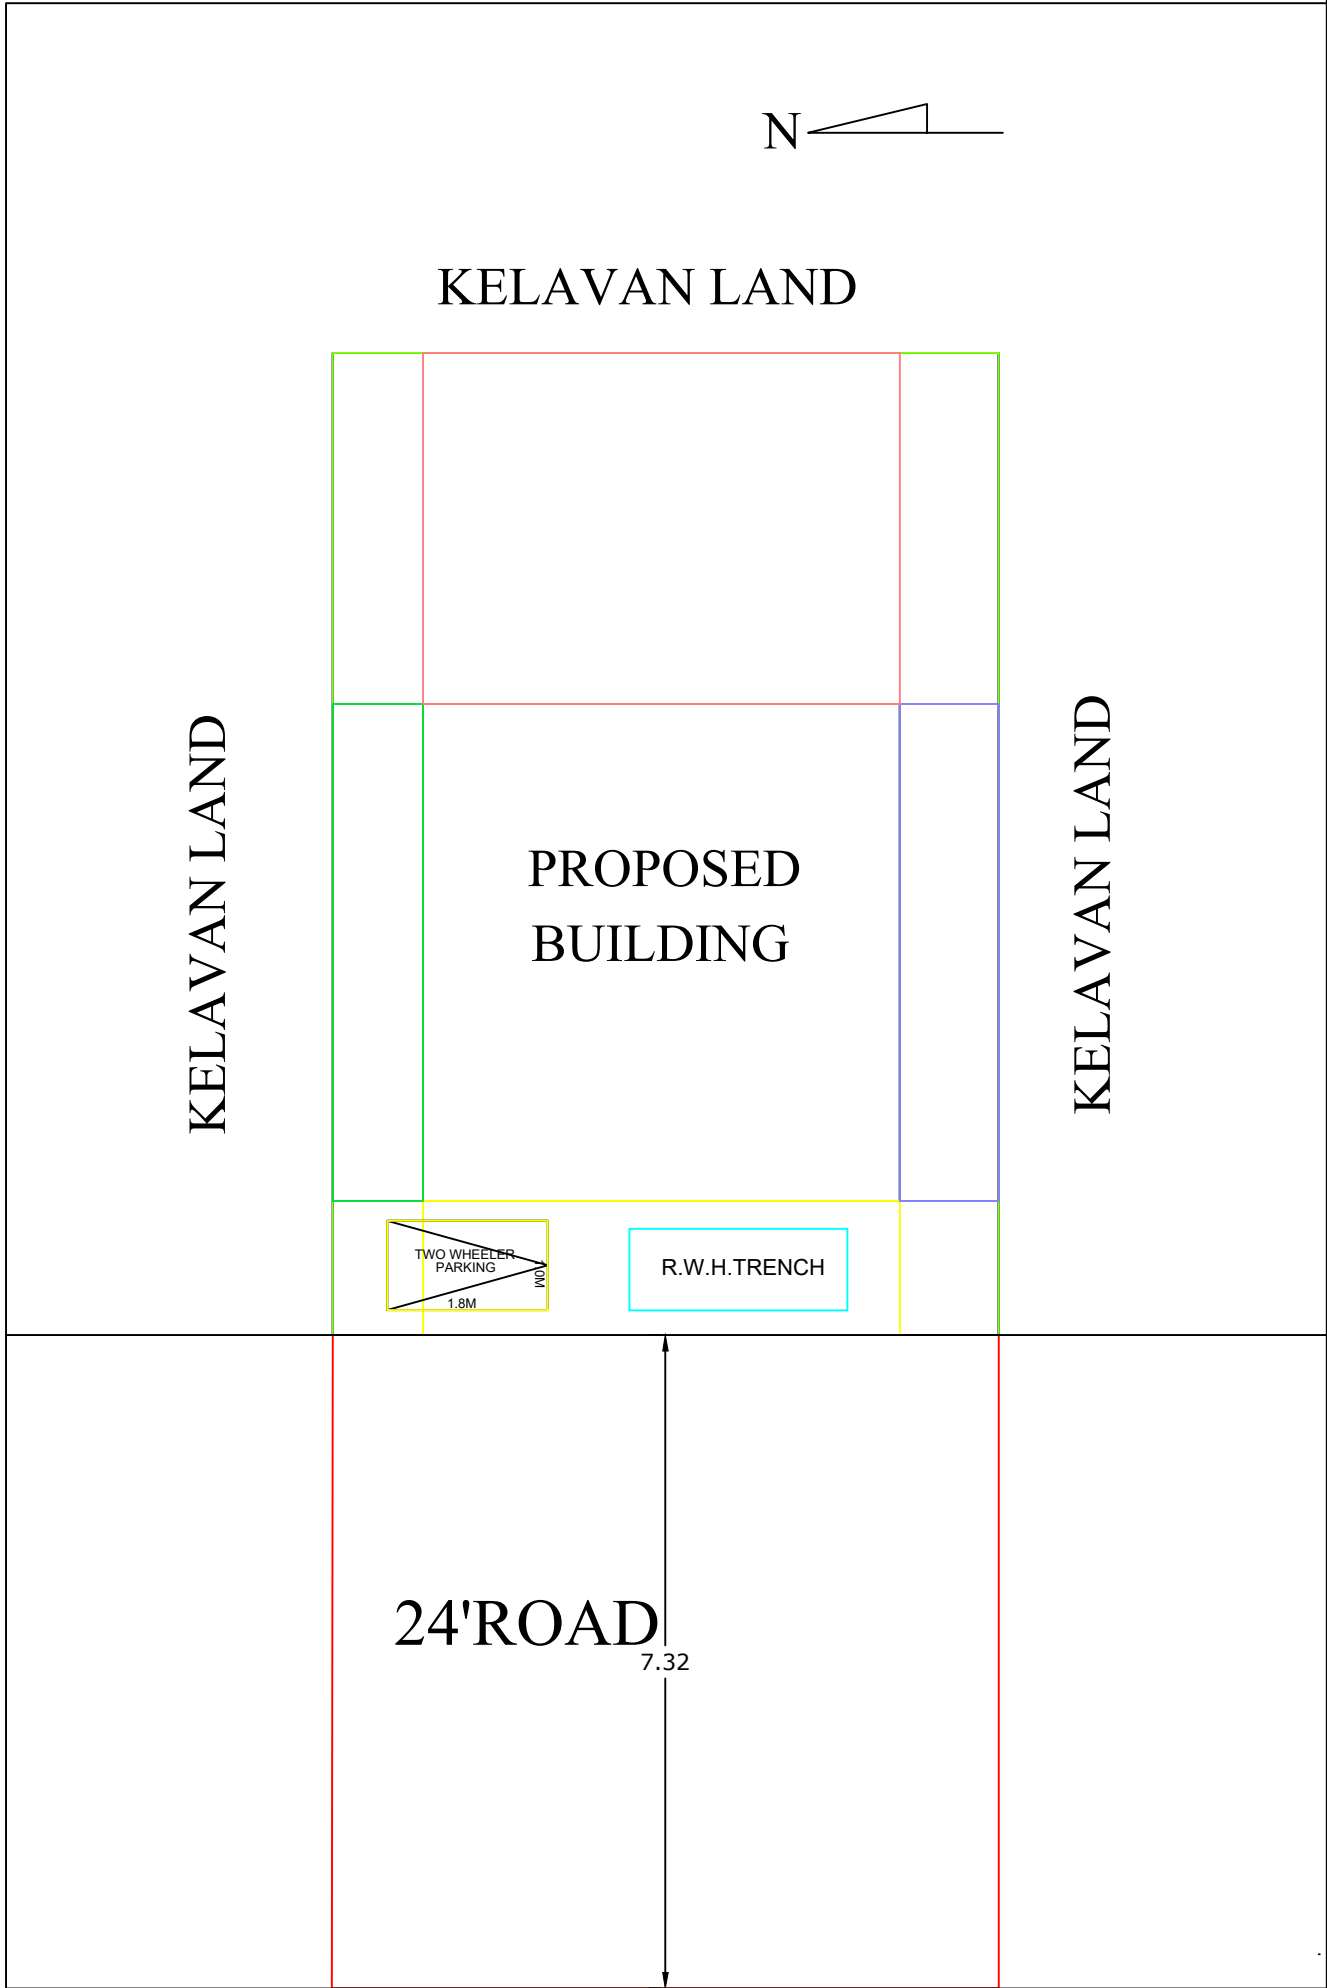

SITE PLAN

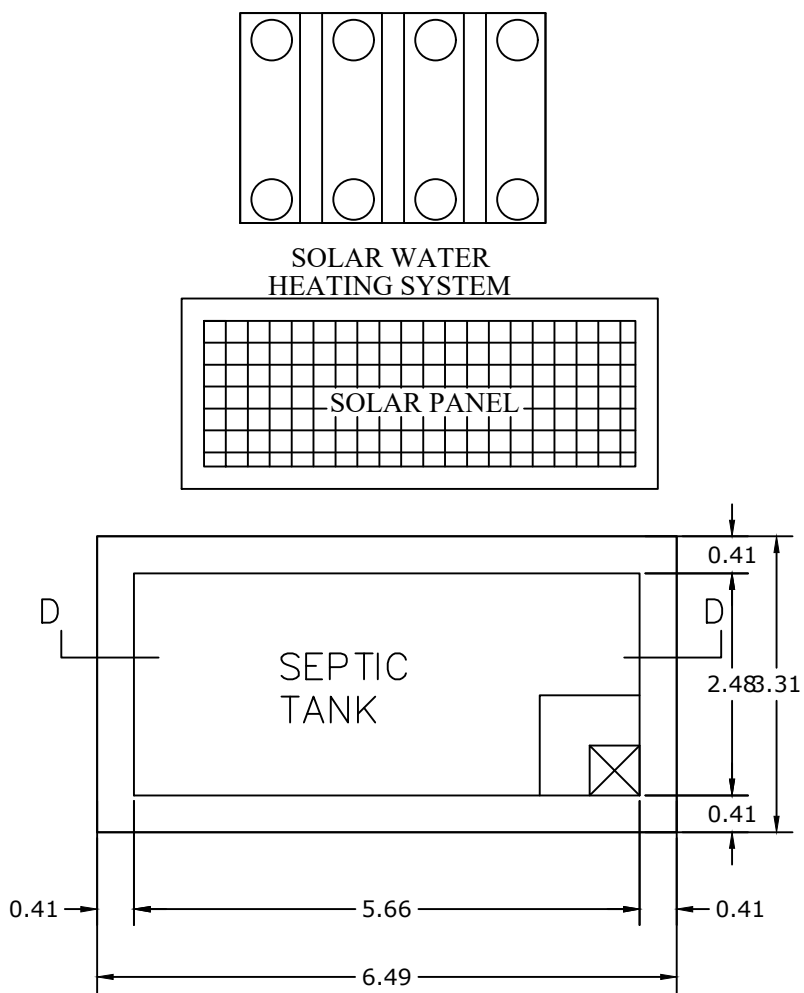

PLAN OF SEPTIC TANK
SCALE 1" = 2'-0"

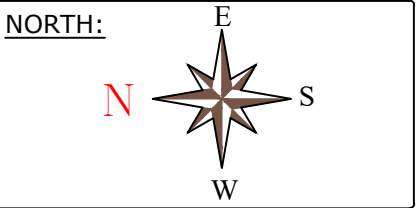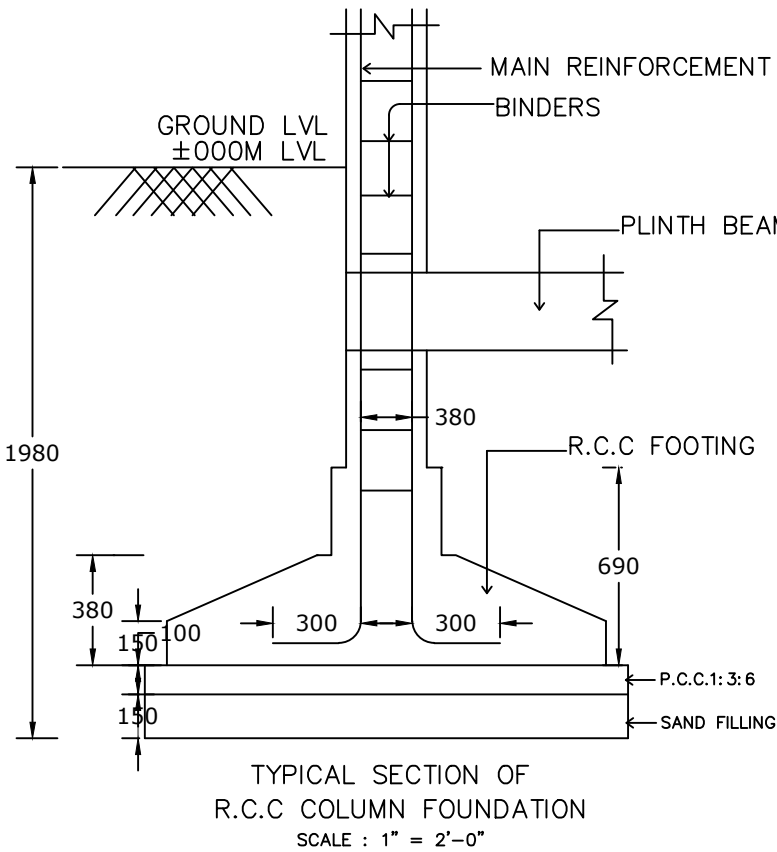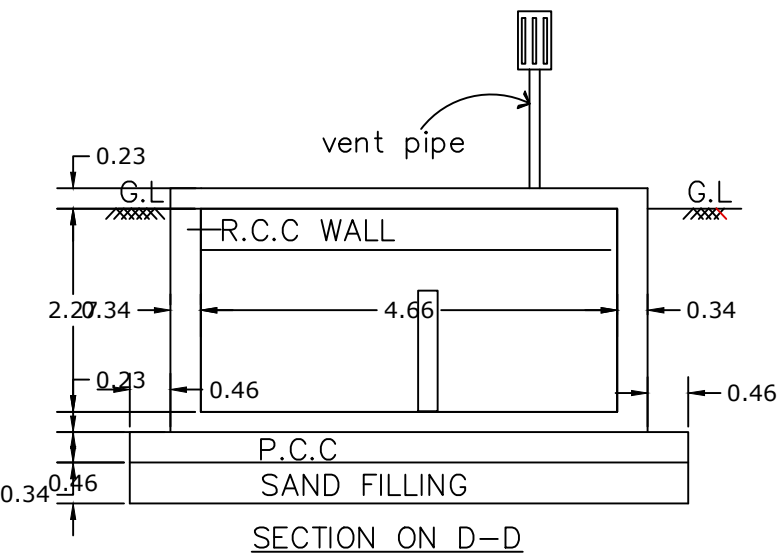

AREA DETAILS:		
	Sq.Ft	Sq.m
TOTAL AREA OF SITE (AS PER DOCUMENT)	882.00	81.94
PRO.GROUND FLOOR AREA	319.36	29.67
OPEN AREA	562.64	52.27

JOINERY:	
MD	> 3'6" X 7'0"
D	> 3'0" X 7'0"
D1	> 3'0" X 7'0"
D2	> 2'6" X 7'0"
W	> 4'6" X 4'0"
W1	> 4'6" X 2'6"
V	> 2'6" X 2'6"

REGISTER ENGINEER:

N. S. R.

Er.N.SRINIVASA RAMANUJAM DCE.,
Consulting & Licensed Engineer
Construction Engineer D.T&CP
REG No - CE/SVG DIST/34/2021
7B,Swamy Sannathi Street
THIRUPPUVANAM -630 611,sivagangal Dist.
Cell : 98421 14028 ,94871 24028

CLIENT

Yasothai

YASOTHAI

FSL:
Floor Space Index = $\frac{29.67}{81.94} \leq 2 = 0.362$

OFFICE USE :