

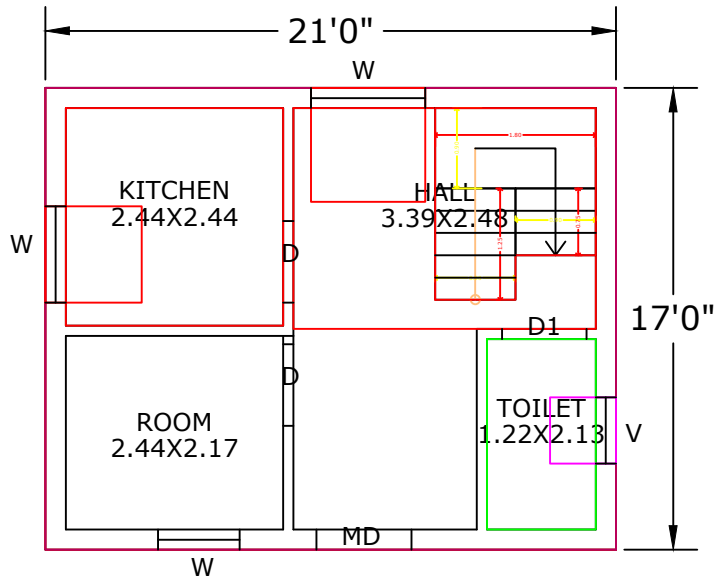
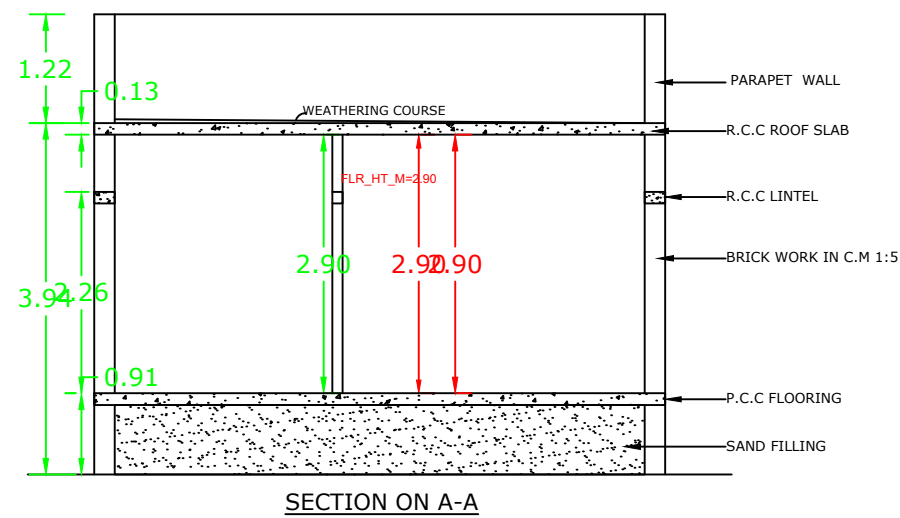
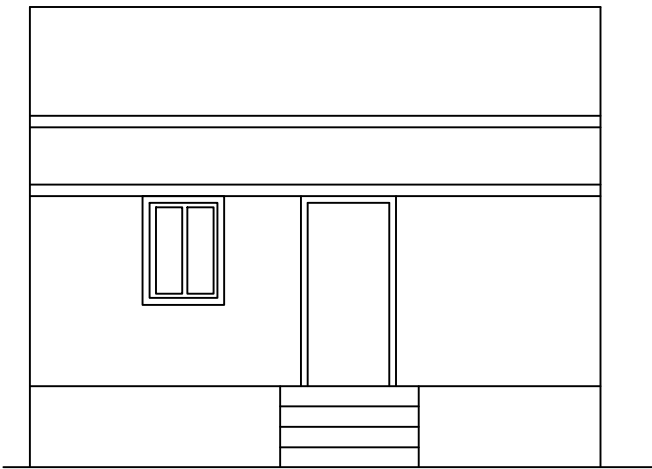





PLAN SHOWING THE PROPOSED CONSTRUCTION OF A RCC ROOF RESIDENTIAL BUILDING NATTAM S.NO:58/12, NEW PATTA NO:889  
NEW S.NO:58/12B, KARUNKULAM PETHANENDAL SEKARAM MANALMEDU VILLAGE, K.PETHANENTHAL PANCHAYAT,  
THIRUPPUVANAM PANCHAYAT UNION, THIRUPPUVANAM TALUK, SIVAGANGAI DISRTICT.

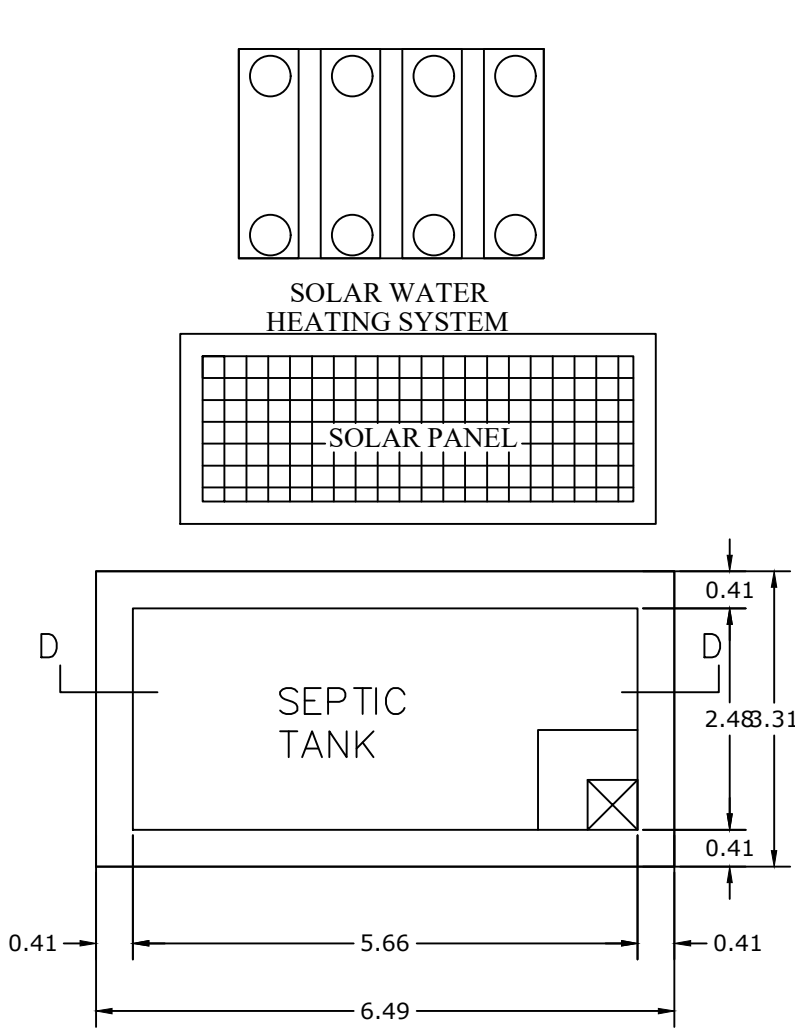

PRO.GROUND FLOOR PLAN

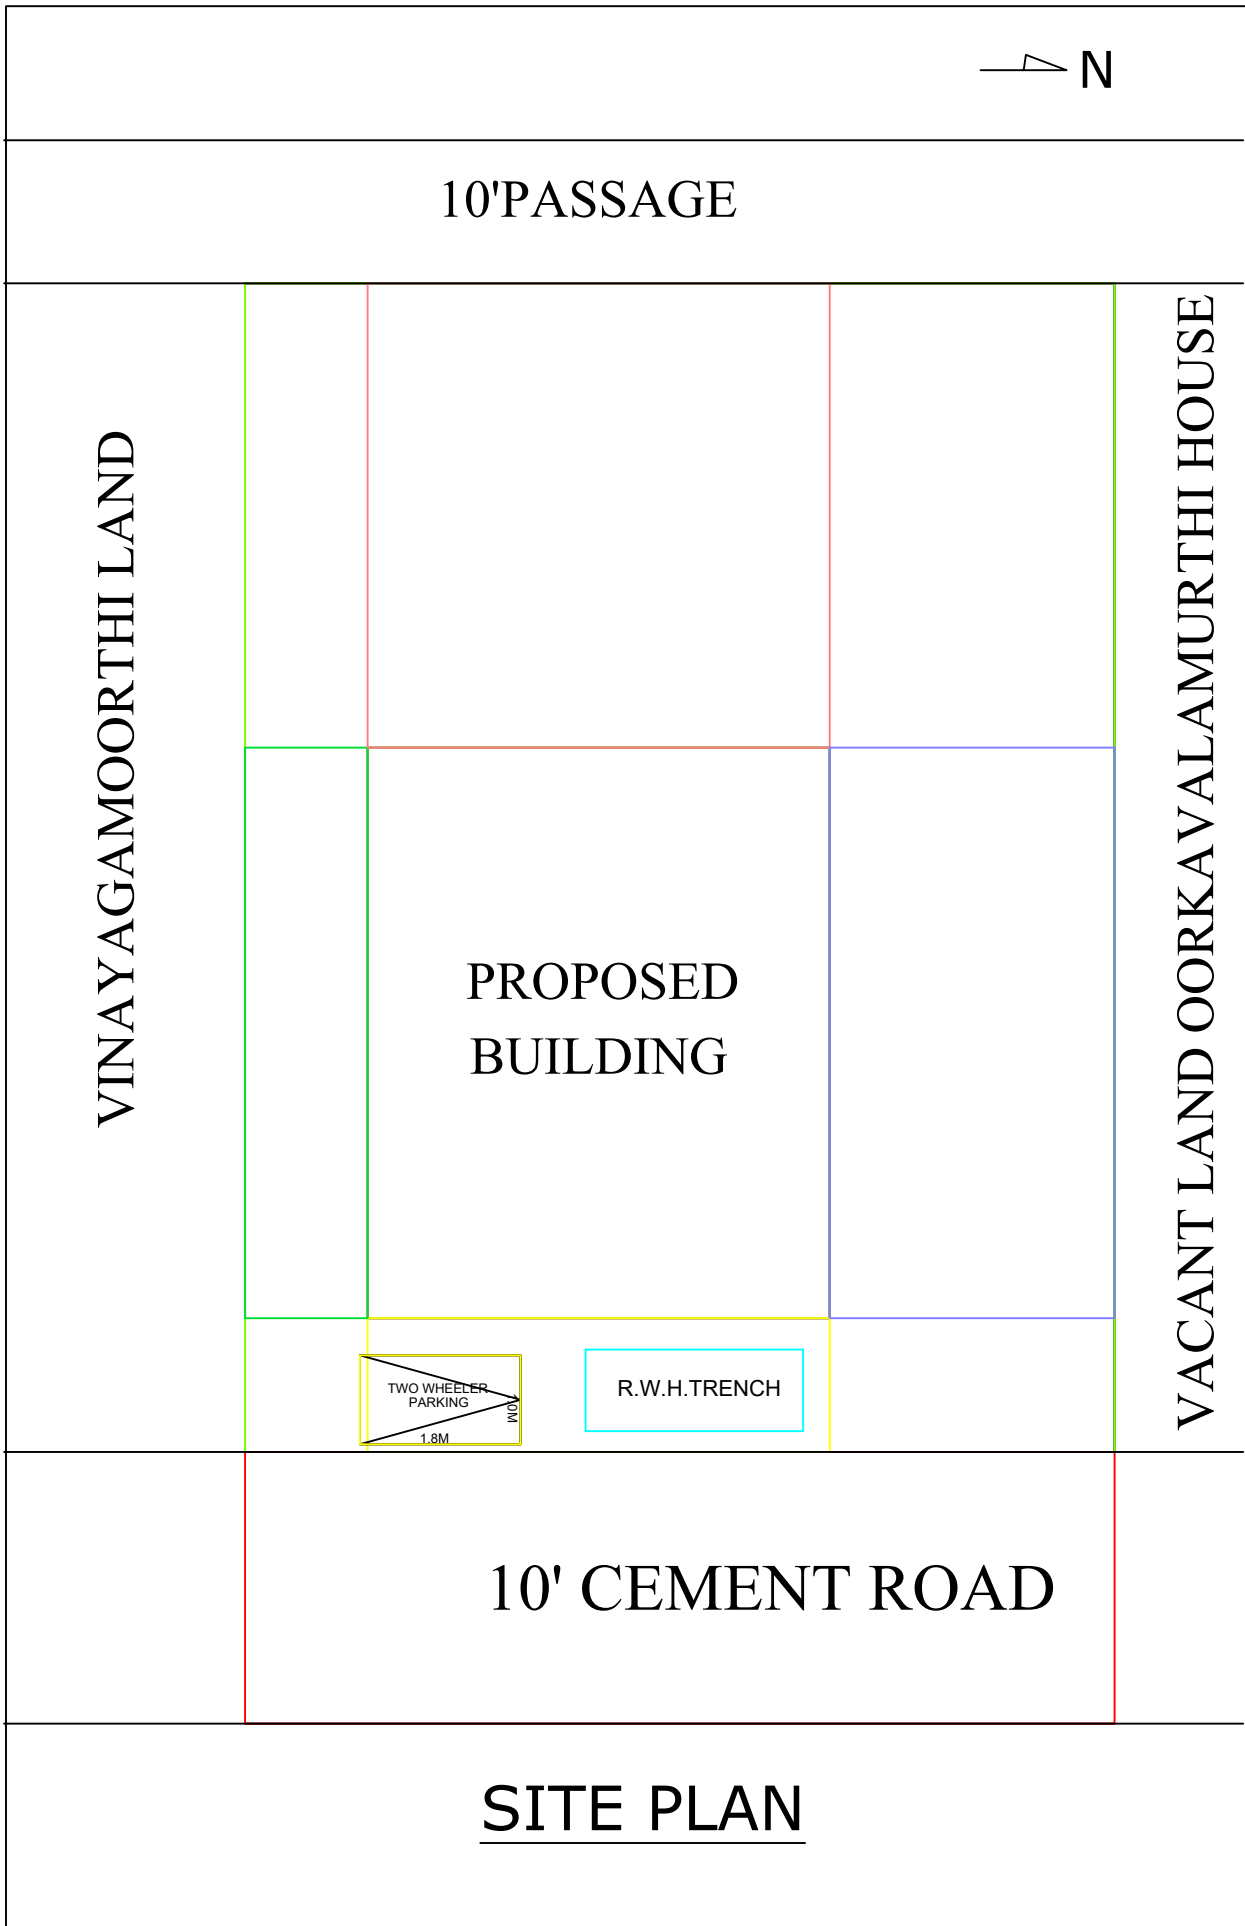

PLAN OF SEPTIC TANK  
SCALE 1"=2'0"

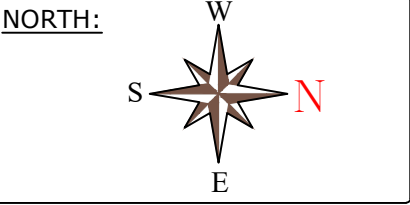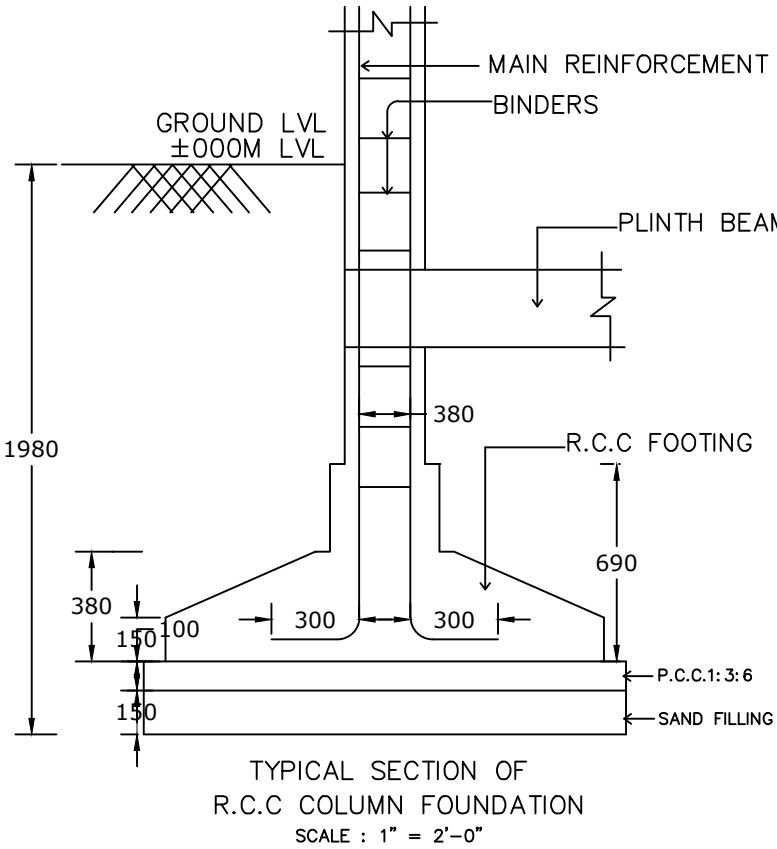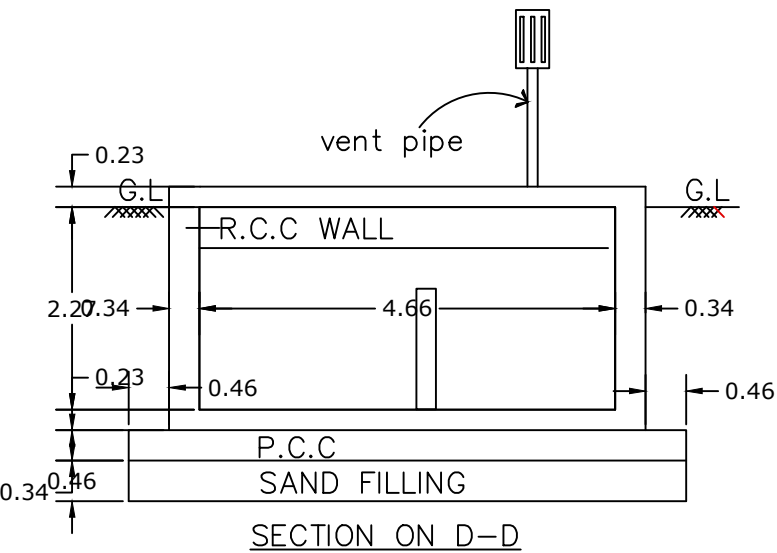

| AREA DETAILS:         |         |        |
|-----------------------|---------|--------|
|                       | Sq.Ft   | Sq.m   |
| TOTAL AREA OF SITE    | 1376.00 | 127.83 |
| PRO.GROUND FLOOR AREA | 357.04  | 33.17  |
| OPEN AREA             | 1018.96 | 94.66  |

| JOINERY: |               |
|----------|---------------|
| MD       | > 3'6" X 7'0" |
| D        | > 3'0" X 7'0" |
| D1       | > 3'0" X 7'0" |
| D2       | > 2'6" X 7'0" |
| W        | > 4'6" X 4'0" |
| W1       | > 4'6" X 2'6" |
| V        | > 2'6" X 2'6" |

REGISTER ENGINEER:  
  
N. S. R.  
Er.N.SRINIVASA RAMANUJAM DCE.,  
Consulting & Licensed Engineer  
Construction Engineer D.T&CP  
REG No - CE/SVG DIST/34/2021  
7B,Swamy Sannathi Street  
THIRUPPUVANAM -630 611,sivagangal Dist.  
Cell : 98421 14028 ,94871 24028

CLIENT  
  
C. Vijay  
  
C.VIJAY

FSI :  
Floor Space Index =  $\frac{33.17}{127.83} \leq 2 = 0.259$

OFFICE USE :