


PLAN SHOWING THE PROPOSED CONSTRUCTION OF A GROUND FLOOR RCC ROOF RESIDENTIAL BUILDING IN

NEW S.F NO-201/15 & PATTa NO-5588 AT THIRUKANURPATTI REVENUE VILLAGE & PANCHAYAT


THANJAVUR TALUK & THANJAVUR DISTRICT-613 303

APPLICANT NAME: Mrs.LATHA W/o Mr.KALIYAMOORTHY

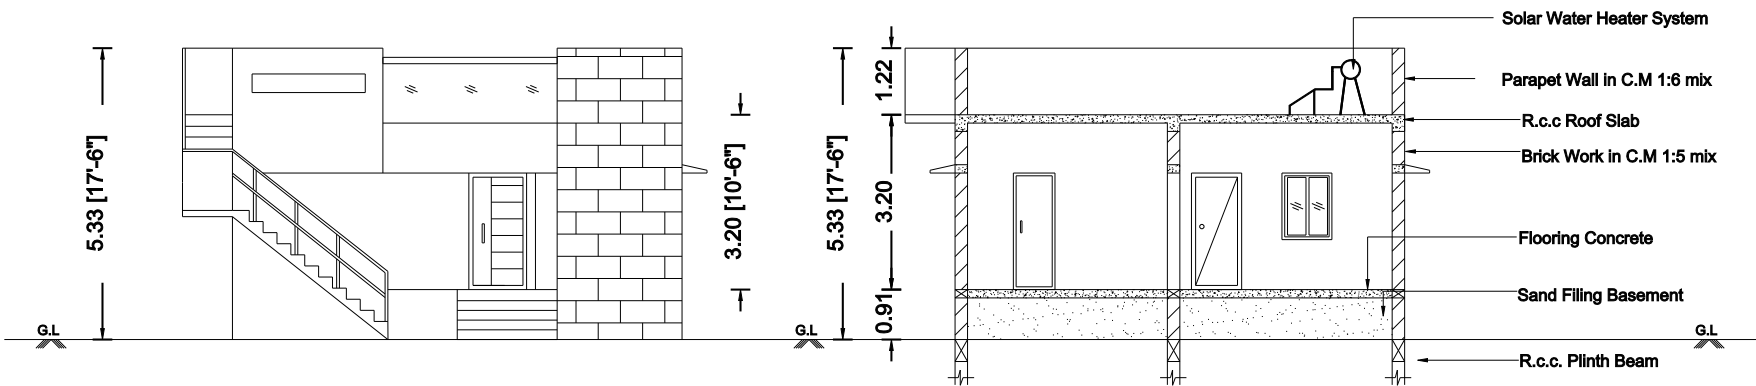

FRONT ELEVATION

SECTION A-A

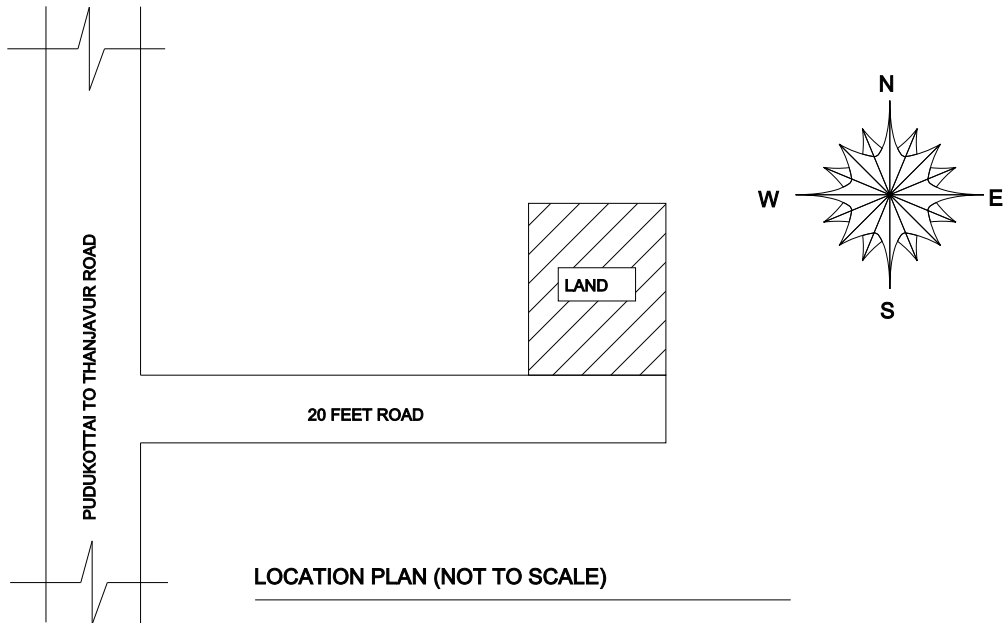

(THIS DRAWING IS DIGITALLY SIGNED)

COLOR INDEX

	SITE BOUNDRY
	PRO. R.C.C ROOF RESIDENTIAL BUILDING
	ROAD DETAILS

PARKING STALL DETAILS

CAR SPACE	0	0
BIKE SPACE	0	1

SCALE =(1:100) All Dimensions Are In Meters

SCHEDULE OF JOINERIES

DESCRIPTION	SIZE IN FEET	SIZE IN M
Main Door - MD	4'0" x 7'0"	1.22 x 2.13
Door - D1	3'0" x 7'0"	0.91 x 2.13
Door - D2	2'6" x 7'0"	0.76 x 2.13
Window - W1	4'6" x 4'0"	1.37 x 1.22
Window - W2	3'0" x 4'0"	0.91 x 1.22
Kitchen Window - KW	4'6" x 3'0"	1.37 x 0.91
Ventilator - V	2'0" x 3'0"	0.61 x 0.91

AREA OF THE PROPOSED CONSTRUCTION DETAILS

DESCRIPTION	SQ.FT	SQ.M
Total Site Area (as per Document)	3480.00	323.30
Proposed Ground Floor	778.02	72.28
Area of the Open Space	2701.98	251.02

Total Builtup Area=72.28 Sqm / 778.02 Sft

FSI = Total Builtup Area / Total Site Area =0.224


K. Latha

Mrs.LATHA W/o Mr.KALIYAMOORTHY


APPLICANT NAME & SIGNATURE

S. Silambarasan
Er. S. SILAMBARASAN, B.E.,
REGISTERED ENGINEER
Reg.No. 089/LS/2024/00001
SSCONSTRUCTION
71, M.K Complex, Opp Darling Show Room
Vengadesapuram, Perambalur - 621212
PH: 9597500575

ENGINEER / L.B.S

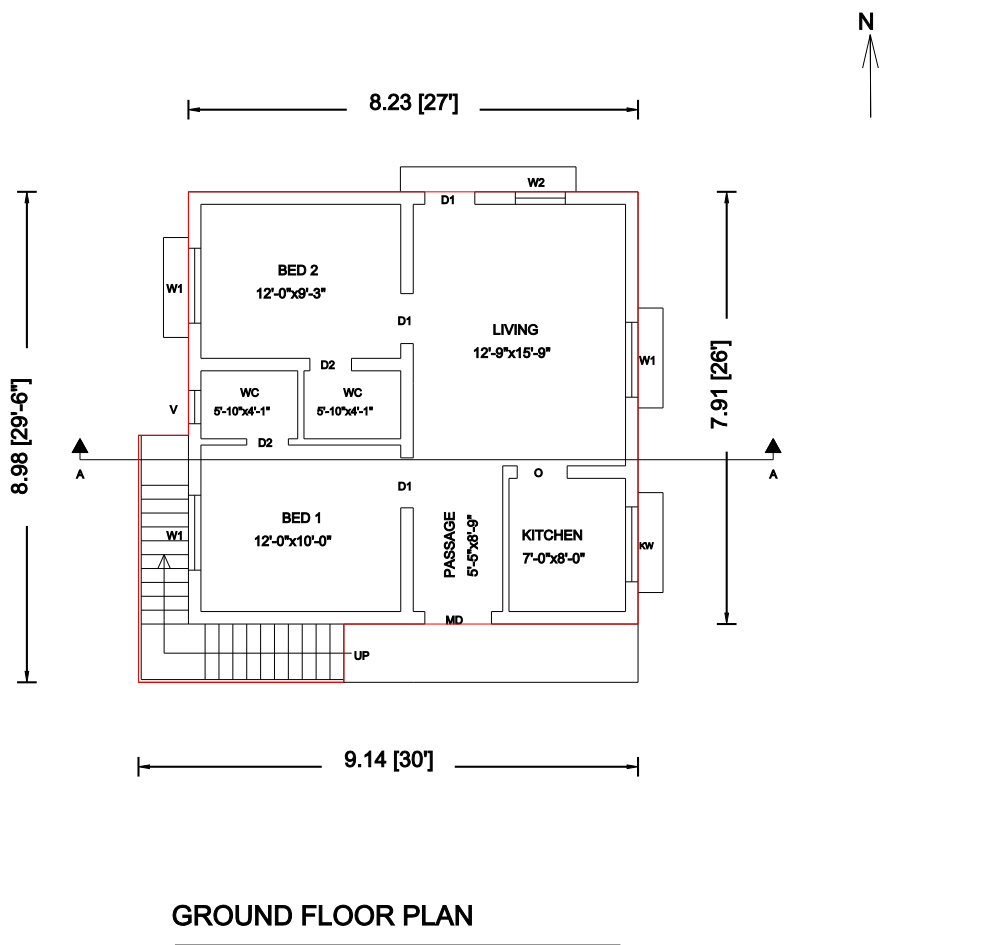


GROUND FLOOR PLAN

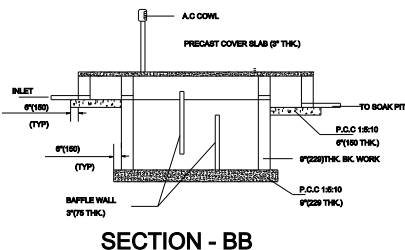


SECTION - BB

PLAN OF SEPTIC TANK

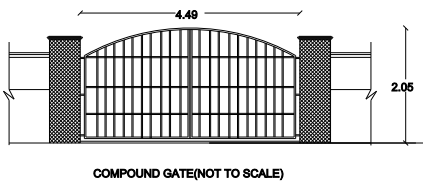


COMPOUND GATE (NOT TO SCALE)

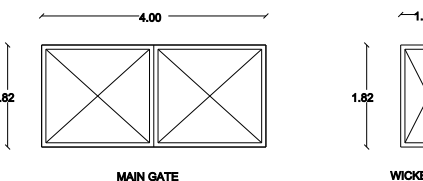


MAIN GATE

WICKET GATE

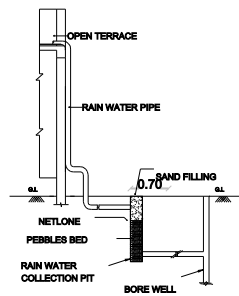


RAIN WATER HARVESTING SYSTEM

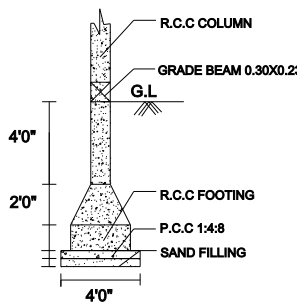


COLOUMN FOUNDATION DETAILS




SITE PLAN (SCALE 1:100)

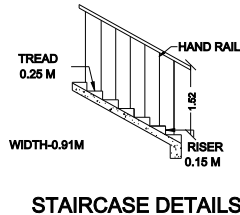

STAIRCASE DETAILS

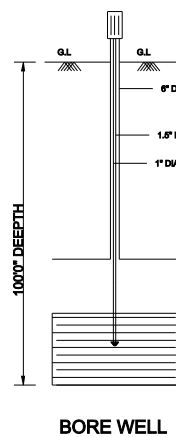

BORE WELL

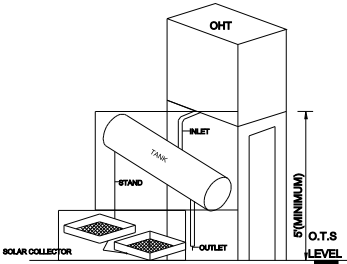

SOLAR WATER HEATING SYSTEM



QR CODE