



PLAN SHOWING THE PROPOSED GROUND FLOOR CONSTRUCTION OF R.C.C ROOF RESIDENTIAL BUILDING
IN R.S.NO. 17/3B2 , PATTa NO: 28 , AT PADAPPANARVAYALVILLAGE,SORNAKKADU VILLAGE PANCHAYAT,
PERAVURANI - UNION ,PERAVURANI - TALUK, THANJAVUR - DISTRICT.

OWNER NAME: Mrs.M.LALITHADEVI, W/O .ELANTHAMIZHAN.



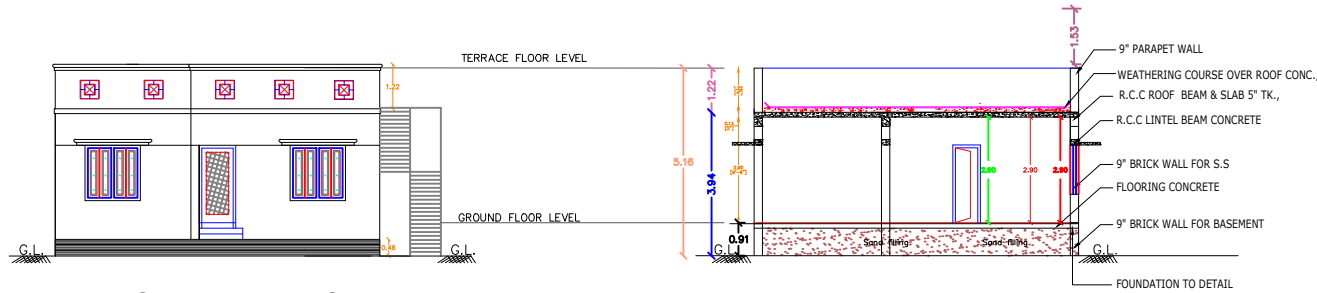


FRONT ELEVATION

SECTION ON 'A-A'


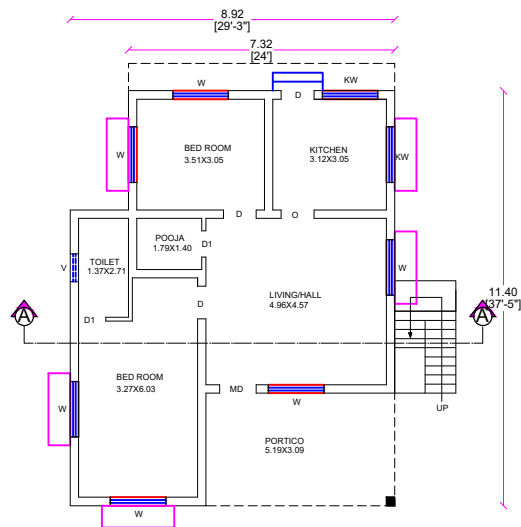


GROUND FLOOR PLAN

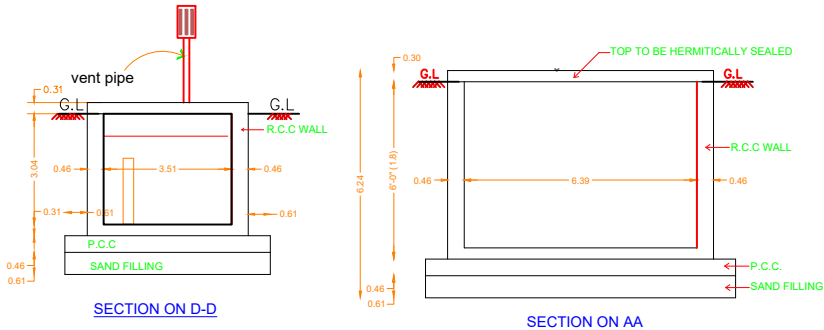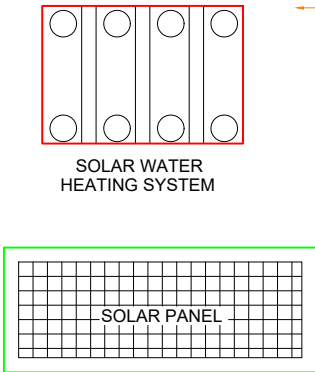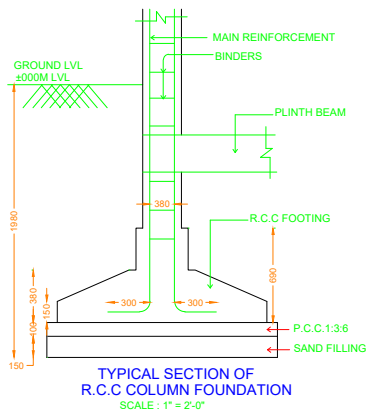


SECTION ON D-D

SECTION ON AA

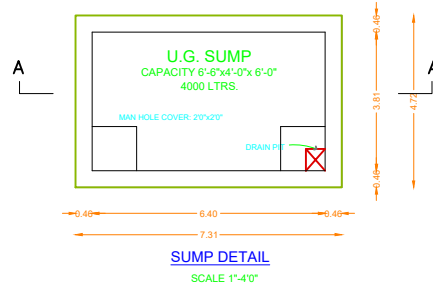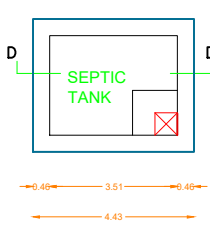


SUMP DETAIL

SCALE 1\"/>

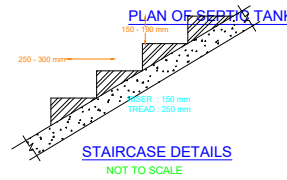


PLAN OF SEPTIC TANK

 SCALE 1\"/>




EXIT MAIN GATE ELEVATION

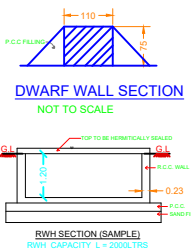


DWARF WALL SECTION

NOT TO SCALE

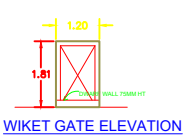


WICKET GATE ELEVATION

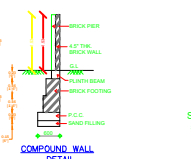

COMPENSATING WALL


DETAIL

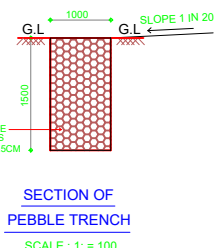

SECTION OF PEBBLE TRENCH


SCALE: 1 : 100

KEY PLAN
SCALE: 1\"/>

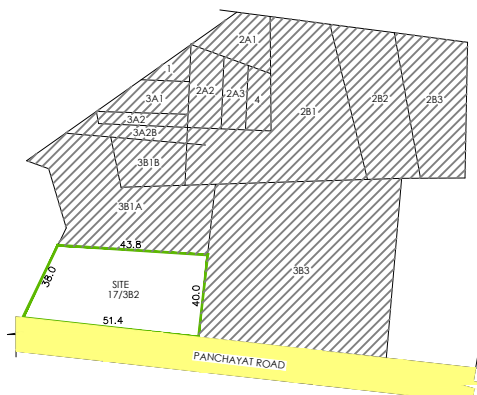

SITE PLAN

SCALE: 1:500

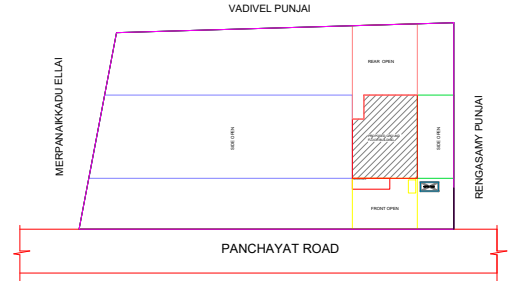

SHEET NO=01

COLOUR INDEX:

BOUNDARY - PROPOSED - ROAD -

JOINERY DETAILS :-

S.No.	Description	Feet	Meter	S.No.	Description	Feet	Meter
01	MD - MAIN DOOR	3'3" X 7'0"	1.00 X 2.13	05	W1 - WINDOW	4'0" X 4'6"	1.22 X 1.37
02	D - DOOR	3'0" X 7'0"	0.91 X 2.13	06	W2 - WINDOW	3'0" X 4'6"	0.91 X 1.37
03	D1 - DOOR	2'6" X 7'0"	0.76 X 2.13	07	KW - WINDOW	5'0" X 4'6"	1.52 X 1.37
04	W - WINDOW	5'0" X 4'6"	1.52 X 1.37	08	V - VENTILATOR	2'6" X 2'6"	0.76 X 0.76

--- SPECIFICATION ---

AREA DETAILS : -	In Sq.m	In Sq.ft
AS PER DOC	1348.60	14516.21
AS PER PATTa	1348.60	14516.21
AS PER DWG./SPRAY	1348.60	14516.21

--- AREA CALCULATION ---

FLOOR AREA	F.S.I AREA		NON-F.S.I AREA		TOTAL AREA	
	in Sq.m	in Sq.ft	in Sq.m	in Sq.ft	in Sq.m	in Sq.ft
GROUND FLOOR	96.44	1038.07	---	---	96.44	1038.07
FIRST FLOOR	---	---	---	---	---	---
SECOND FLOOR	---	---	---	---	---	---
HEAD ROOM	---	---	---	---	---	---
TOTAL AREA	96.44	1038.07	---	---	96.44	1038.07

FLOOR SPACE INDEX = $\frac{96.44}{1348.60} = 0.0715 < 2.0$		DWELLING AREA STATEMENT			
PLOT COVERAGE = $\frac{96.44}{1348.60} \times 100 = 07.15\%$		FLOORS	NO OF DWELLING UNITS	TYPES	
		GROUND FLOOR	01	A1	B1
		FIRST FLOOR	--	--	--

--- PARKING DETAILS ---

PARKING TYPE	REQUIRED	PROVIDED
CAR	--	--
TWO WHEELER	01	01

HEIGHT OF THE BUILDING : 3.94 M SCALE - 1 : 100

*All dimensions are in feet & inches,those with in brackets are in M.
*Sewage line connected to Septic Tank main line

(Mrs.LALITHADEVI.M)
APPLICANT / OWNER

E. R. R. SUMITHRA, B.E.,
Consulting Engineer/Surveyor
Banmuga Complex
Ruramangalam - 614 004
Mob. 90928 77431

REGISTERED ENGINEER

