


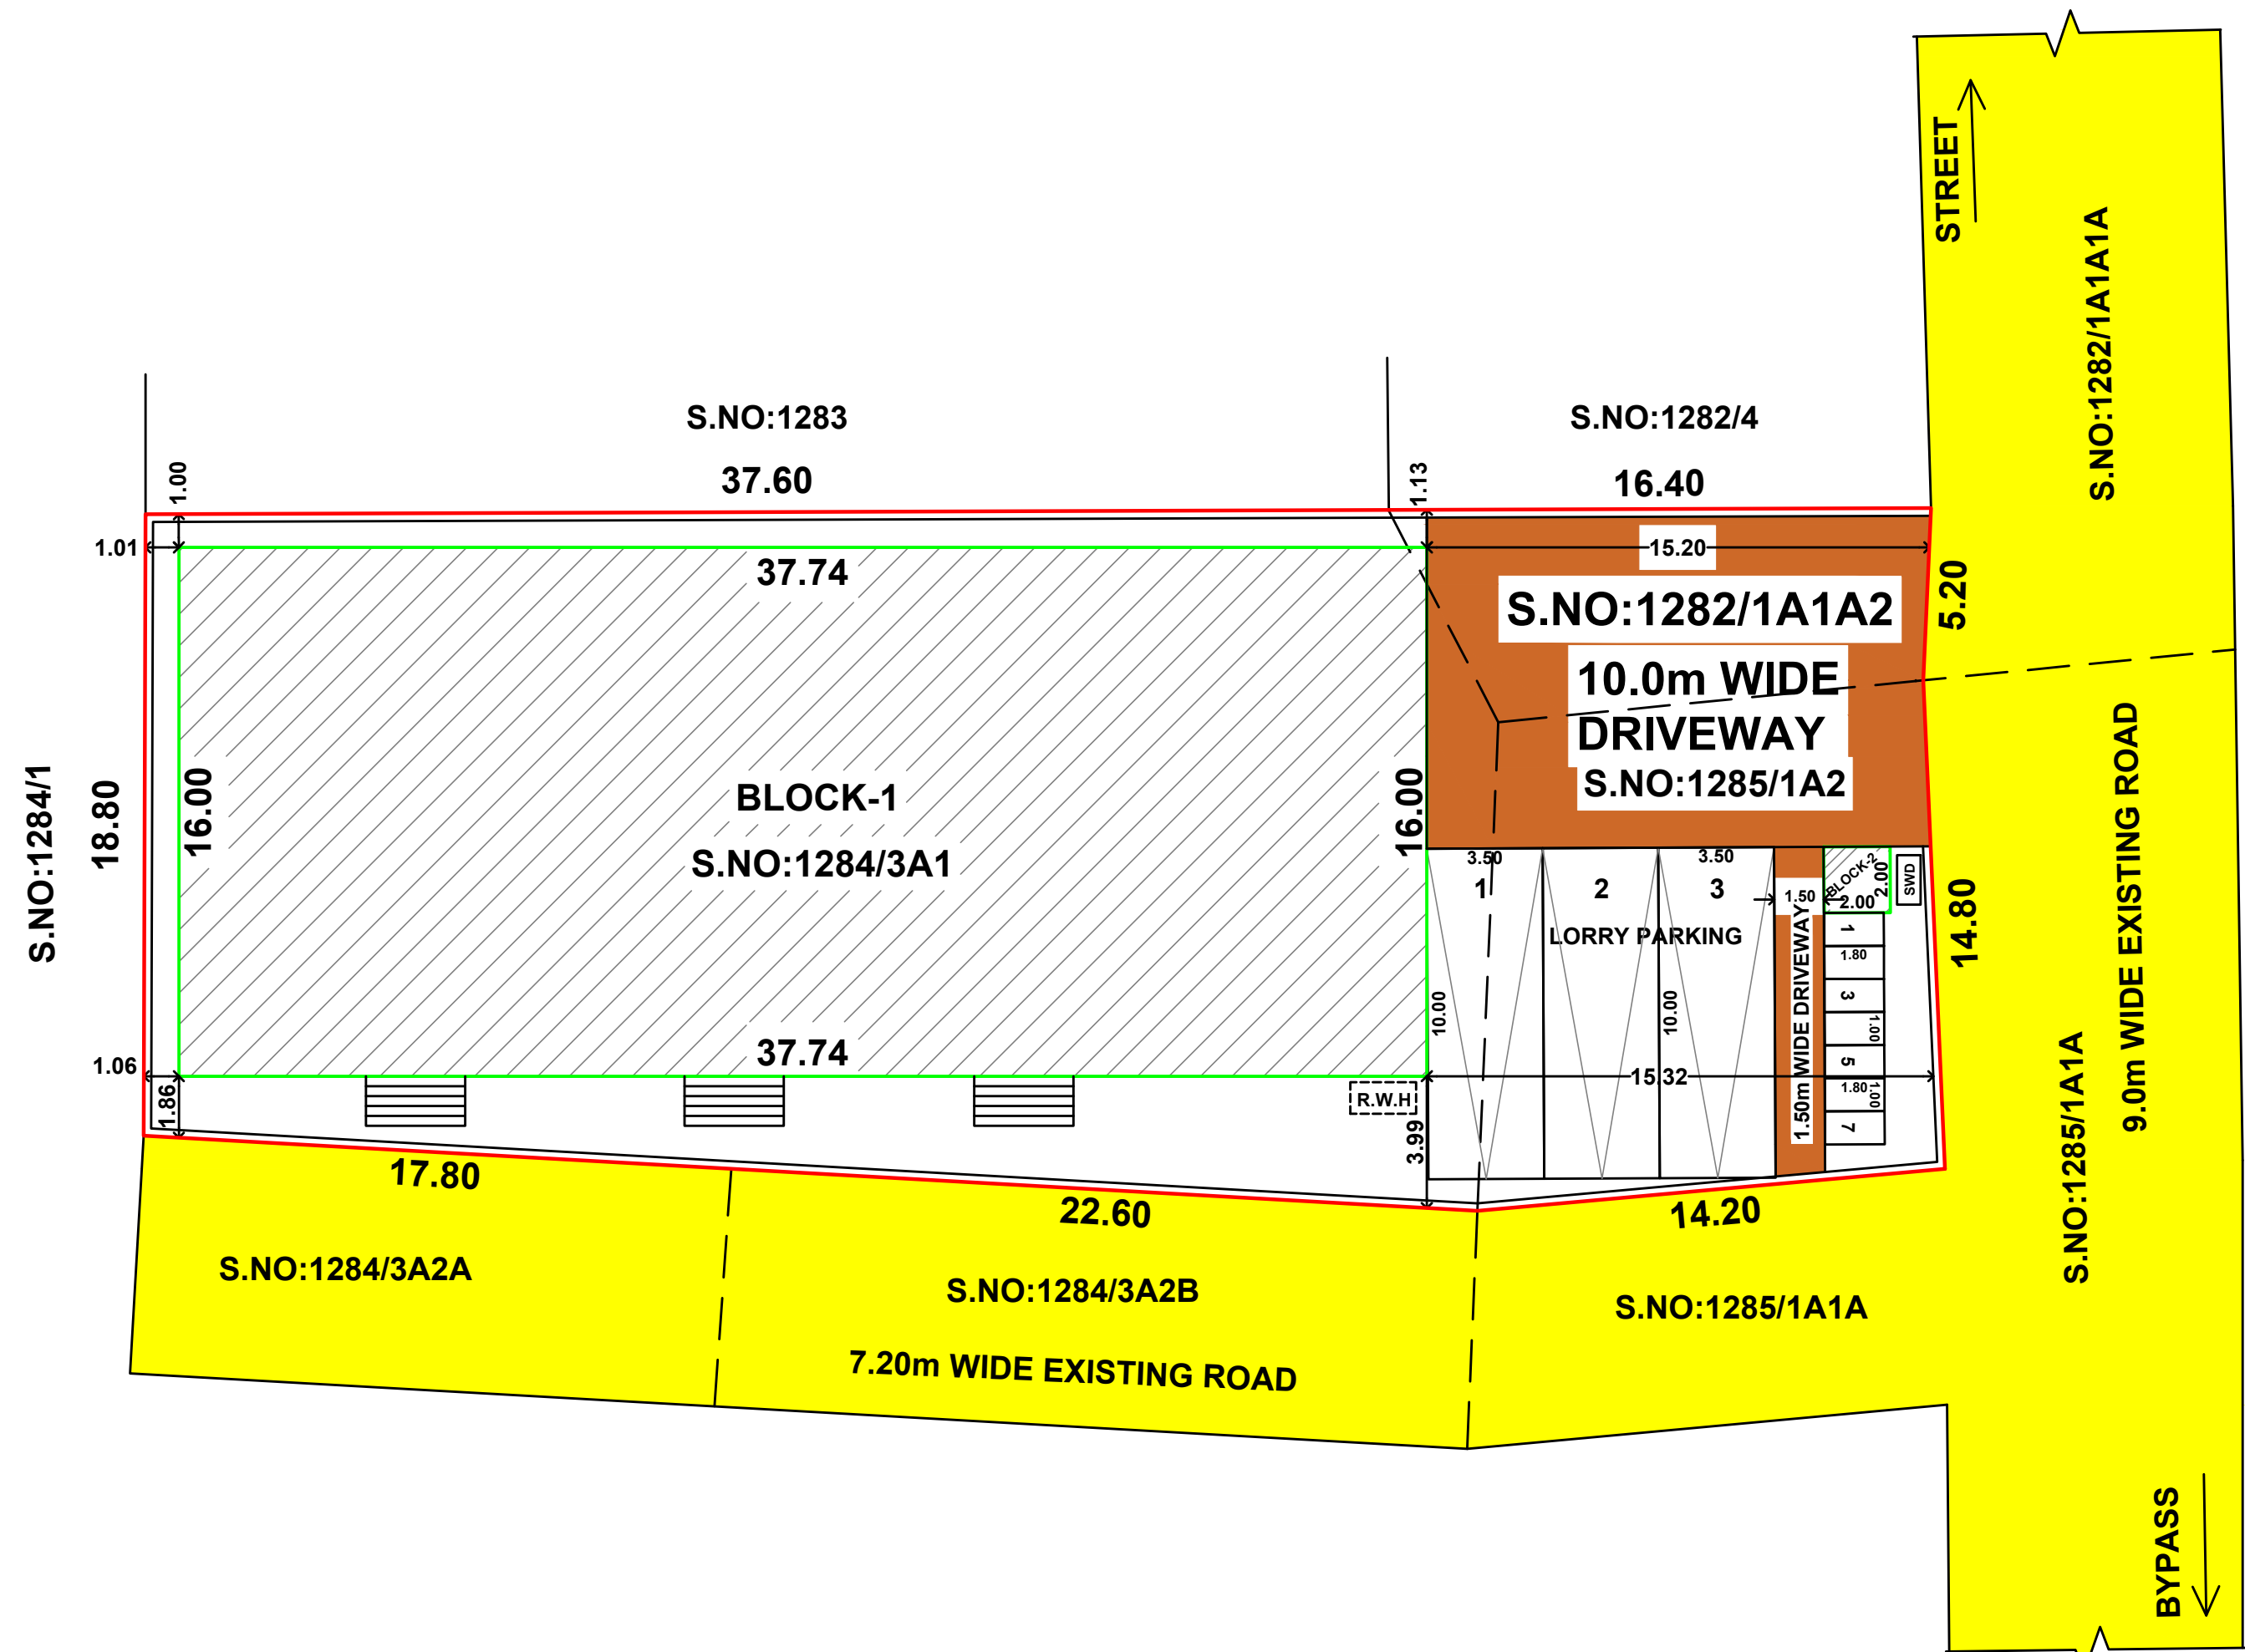

PLAN SHOWING THE PROPOSED CONSTRUCTION
OF GODOWN BUILDING IN S.NO: 1282/1A1A2,
1284/3A1 & 1285/1A2, UNJAMPATTY VILLAGE &
UNJAMPATTY PANCHAYAT, THENI TALUK,
THENI DISTRICT.

SITE AREA DETAILS:-

1. SITE AREA (As Per Document)	= 1092.65Sq.m(27.00Cent)
2. SITE AREA (As Per Patta)	= 1094.00Sq.m
3. SITE AREA (Super Imposed)	= 1090.09Sq.m

BUILTUP AREA DETAILS:- SCALE 1:400

SL.NO	DESCRIPTION	FSI (Sq.Mt)	NON FSI (Sq.Mt)	TOTAL (Sq.Mt)
(1)	BLOCK-1 (Godown)			
	Ground Floor	603.84	-----	603.84
(2)	BLOCK-2 (Security Room)			
	Ground Floor	-----	4.00	4.00
Total		603.84	4.00	607.84




FSI = $\frac{\text{Total FSI Area}}{\text{Total Site Area}} = \frac{603.84}{1090.09} = 0.55 < 2.00$

PARKING DETAILS:-

SL.NO	DESCRIPTION	REQUIRED (NOS)	PROVIDED (NOS)
1	Car	-	-
2	Lorry	03	03
3	Two Wheeler	06	07



- REFERENCES:
- SITE BOUNDARY
 - DRIVE WAY
 - Pro. BUILDING
 - EXG. ROAD

SITE PLAN

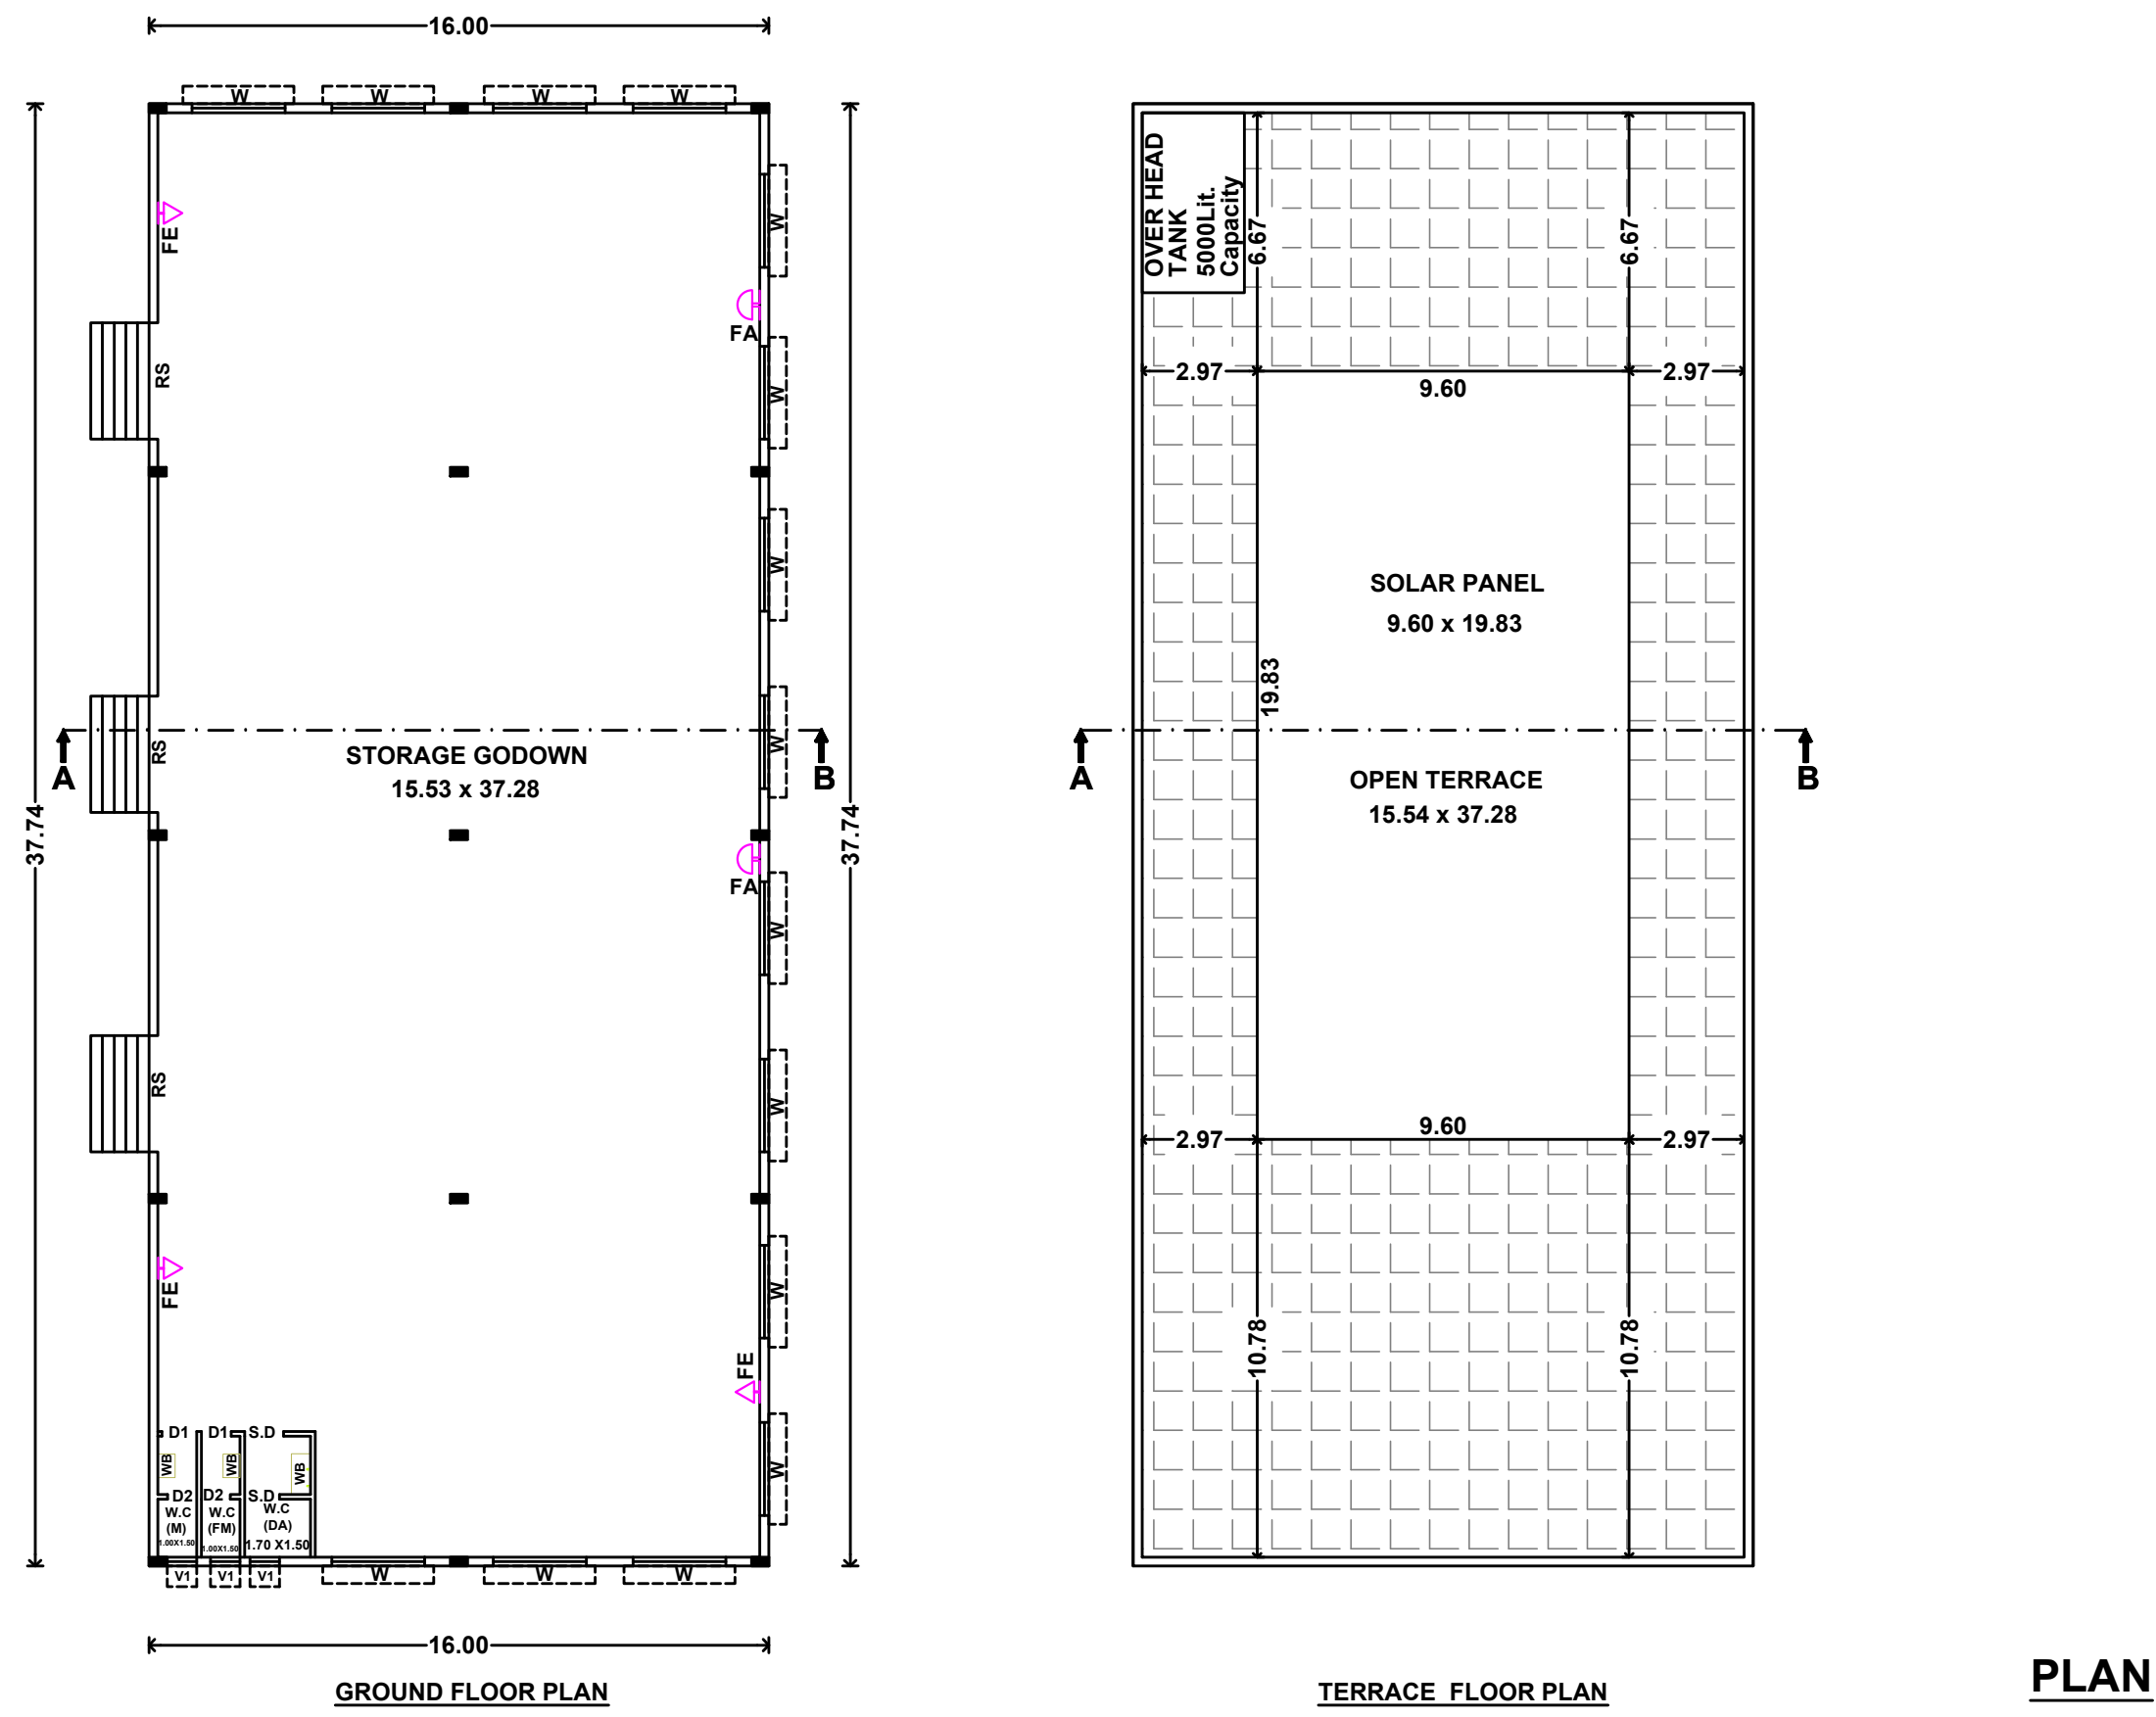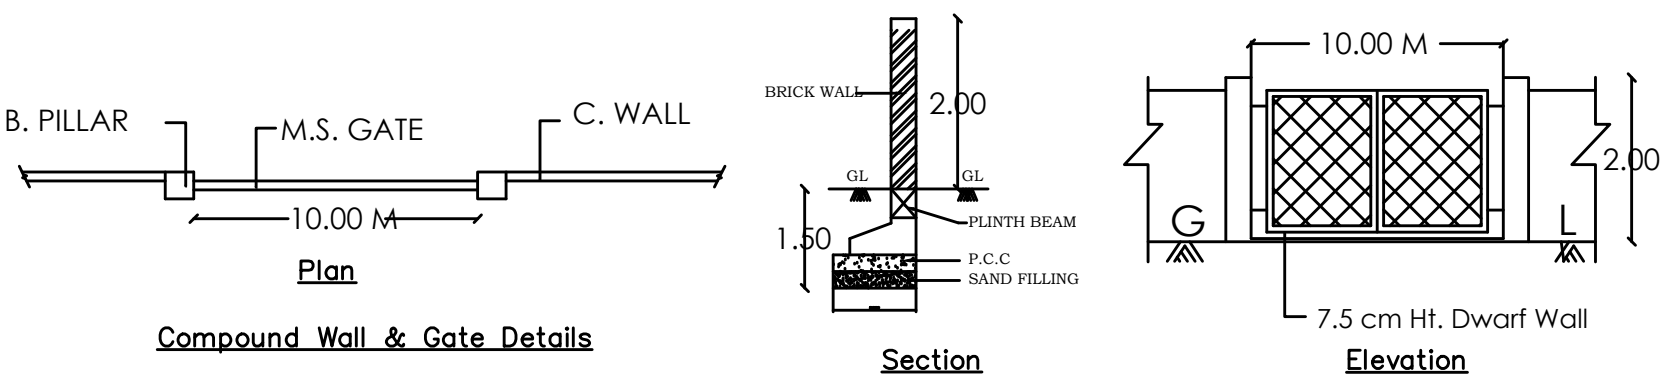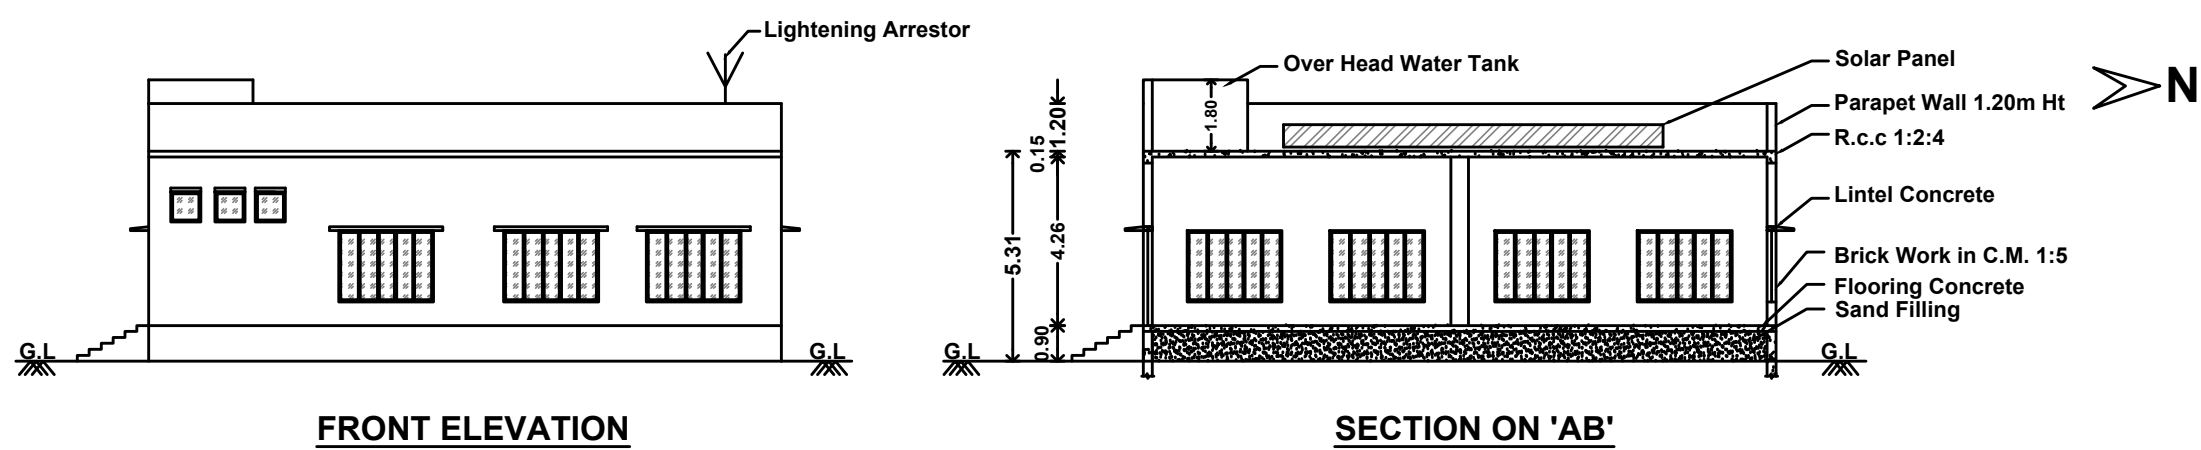

JOINERY DETAILS:

R.S	- Rolling Shutter	3.00 x 2.40	10'0" x 8'0"
SD	- Sliding Door	1.00 x 2.40	3'3" x 8'0"
D1	- Door	0.90 x 2.40	3'0" x 8'0"
D2	- Door	0.76 x 2.40	2'6" x 8'0"
W	- Window	2.40 x 1.80	8'0" x 6'0"
V	- Ventilator	0.76 x 0.76	2'6" x 2'6"
FE	- Fire Extinguisher		
DW	- Drinking Water		
FA	- Fire Alarm		

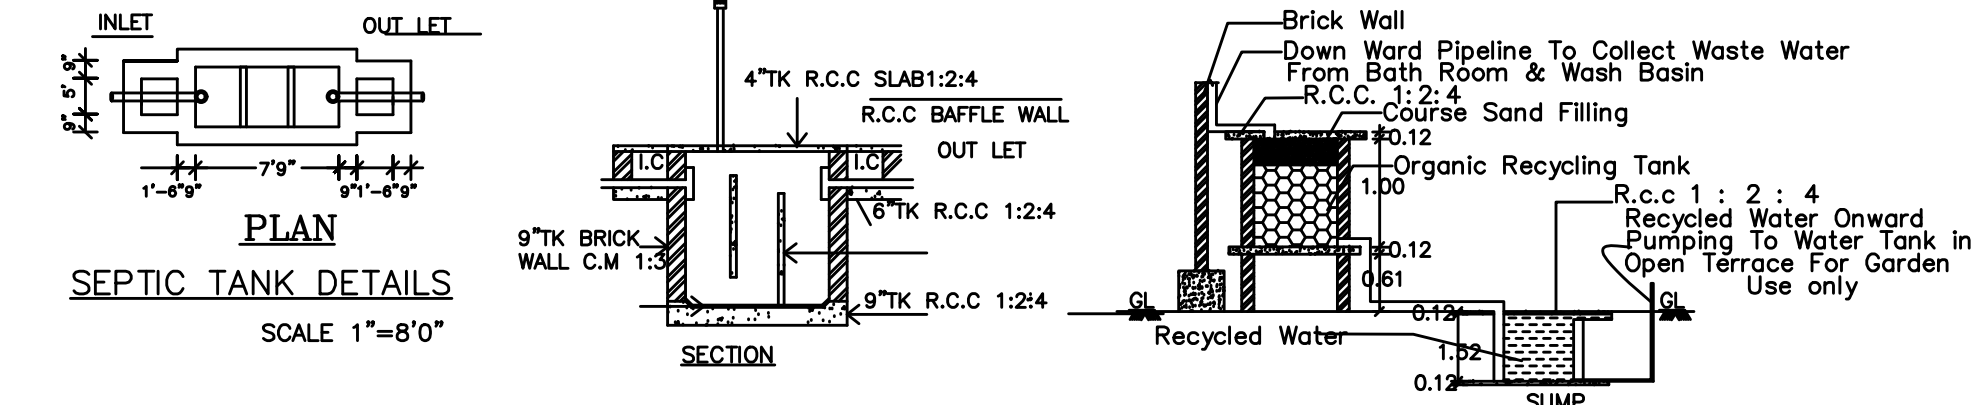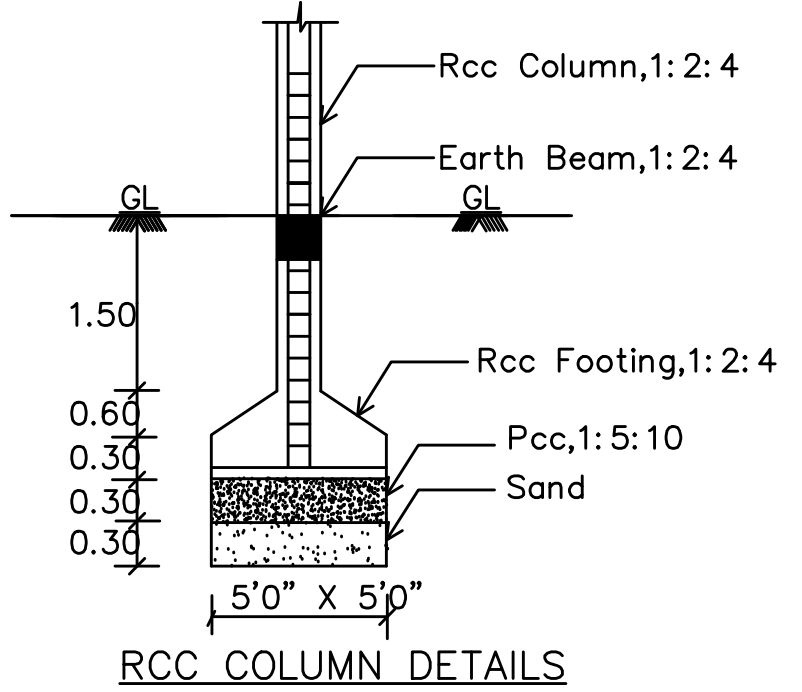

- NOTES:-
- Rain Water Harvesting System to be Provided.
 - Solar Energy System to be Provided.
 - W/C water to be connected with Septic Tank.
 - Fire Resistance to be provided
 - Emergency alarm to be provided
 - Structure is Designed Safely For Earthquake Resistance.
 - First Aid Box with all Equipment to be provided.
 - Mechanical Ventilation provided.(whether it is used)
- All Dimensions are in Metre

APPLICANT

REGISTERED STRUCTURAL ENGINEER

REGISTERED ARCHITECT & ENGINEER