
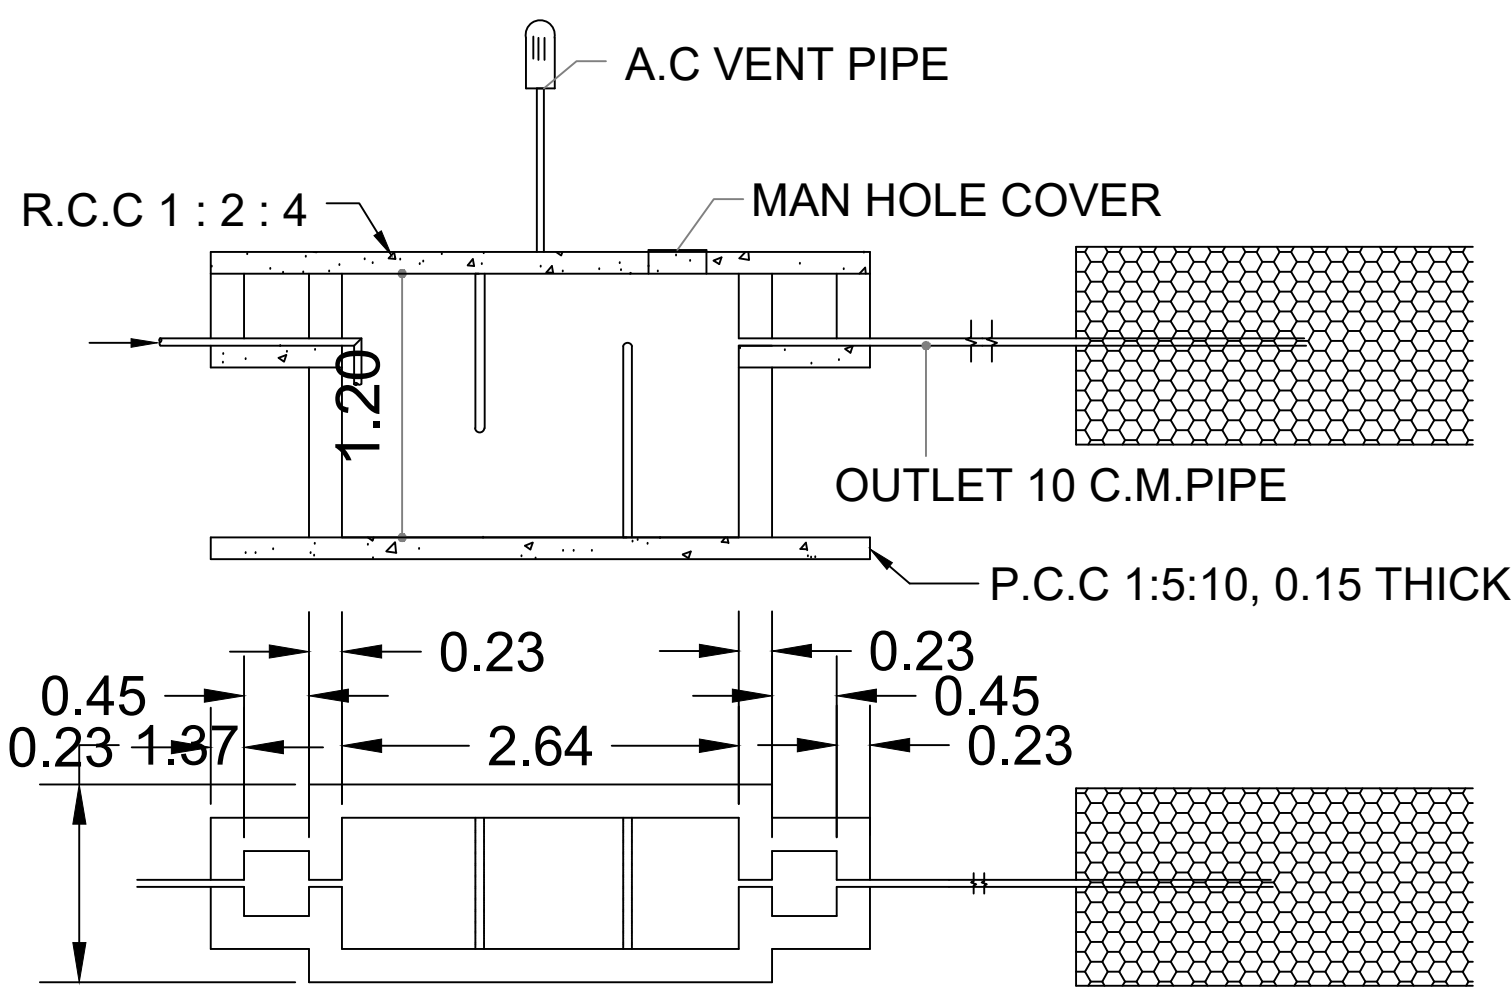
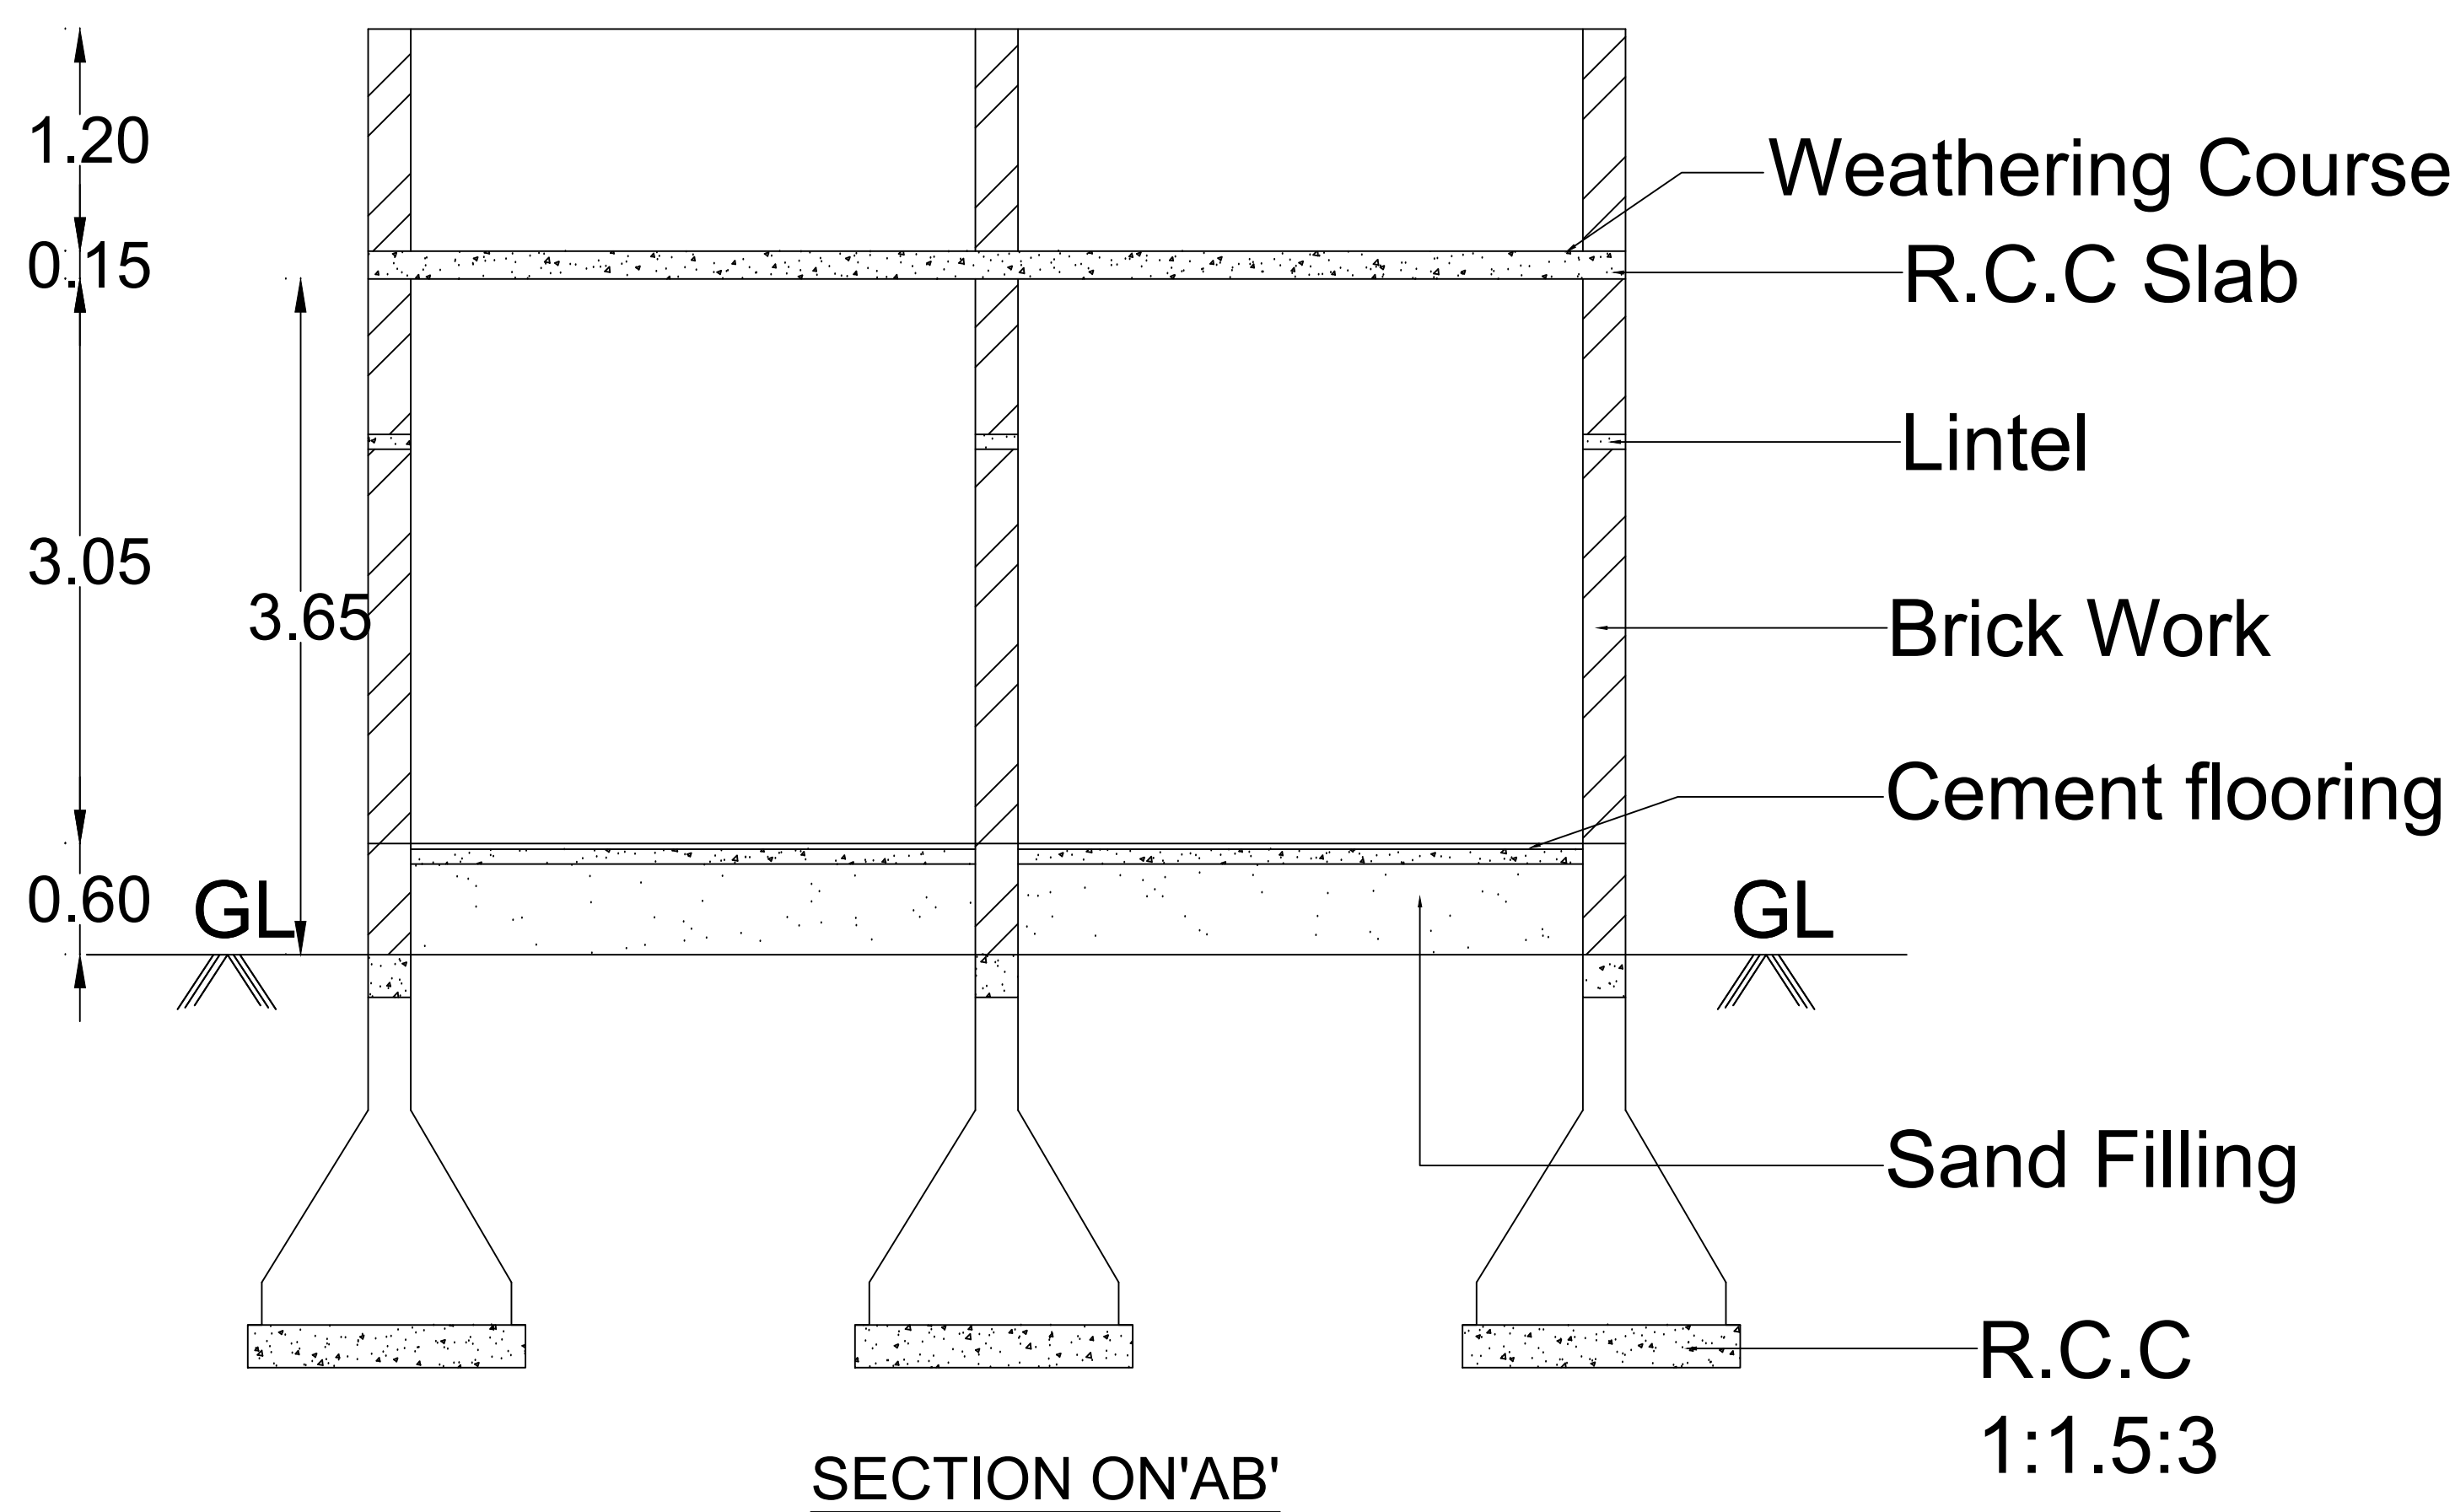
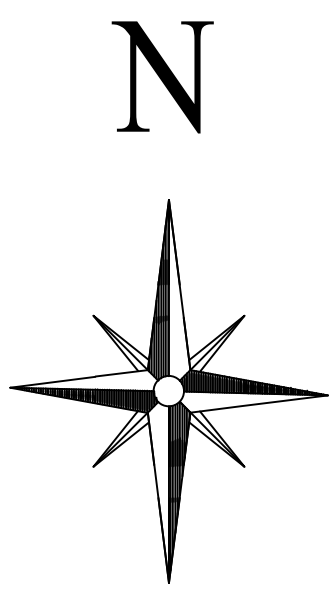
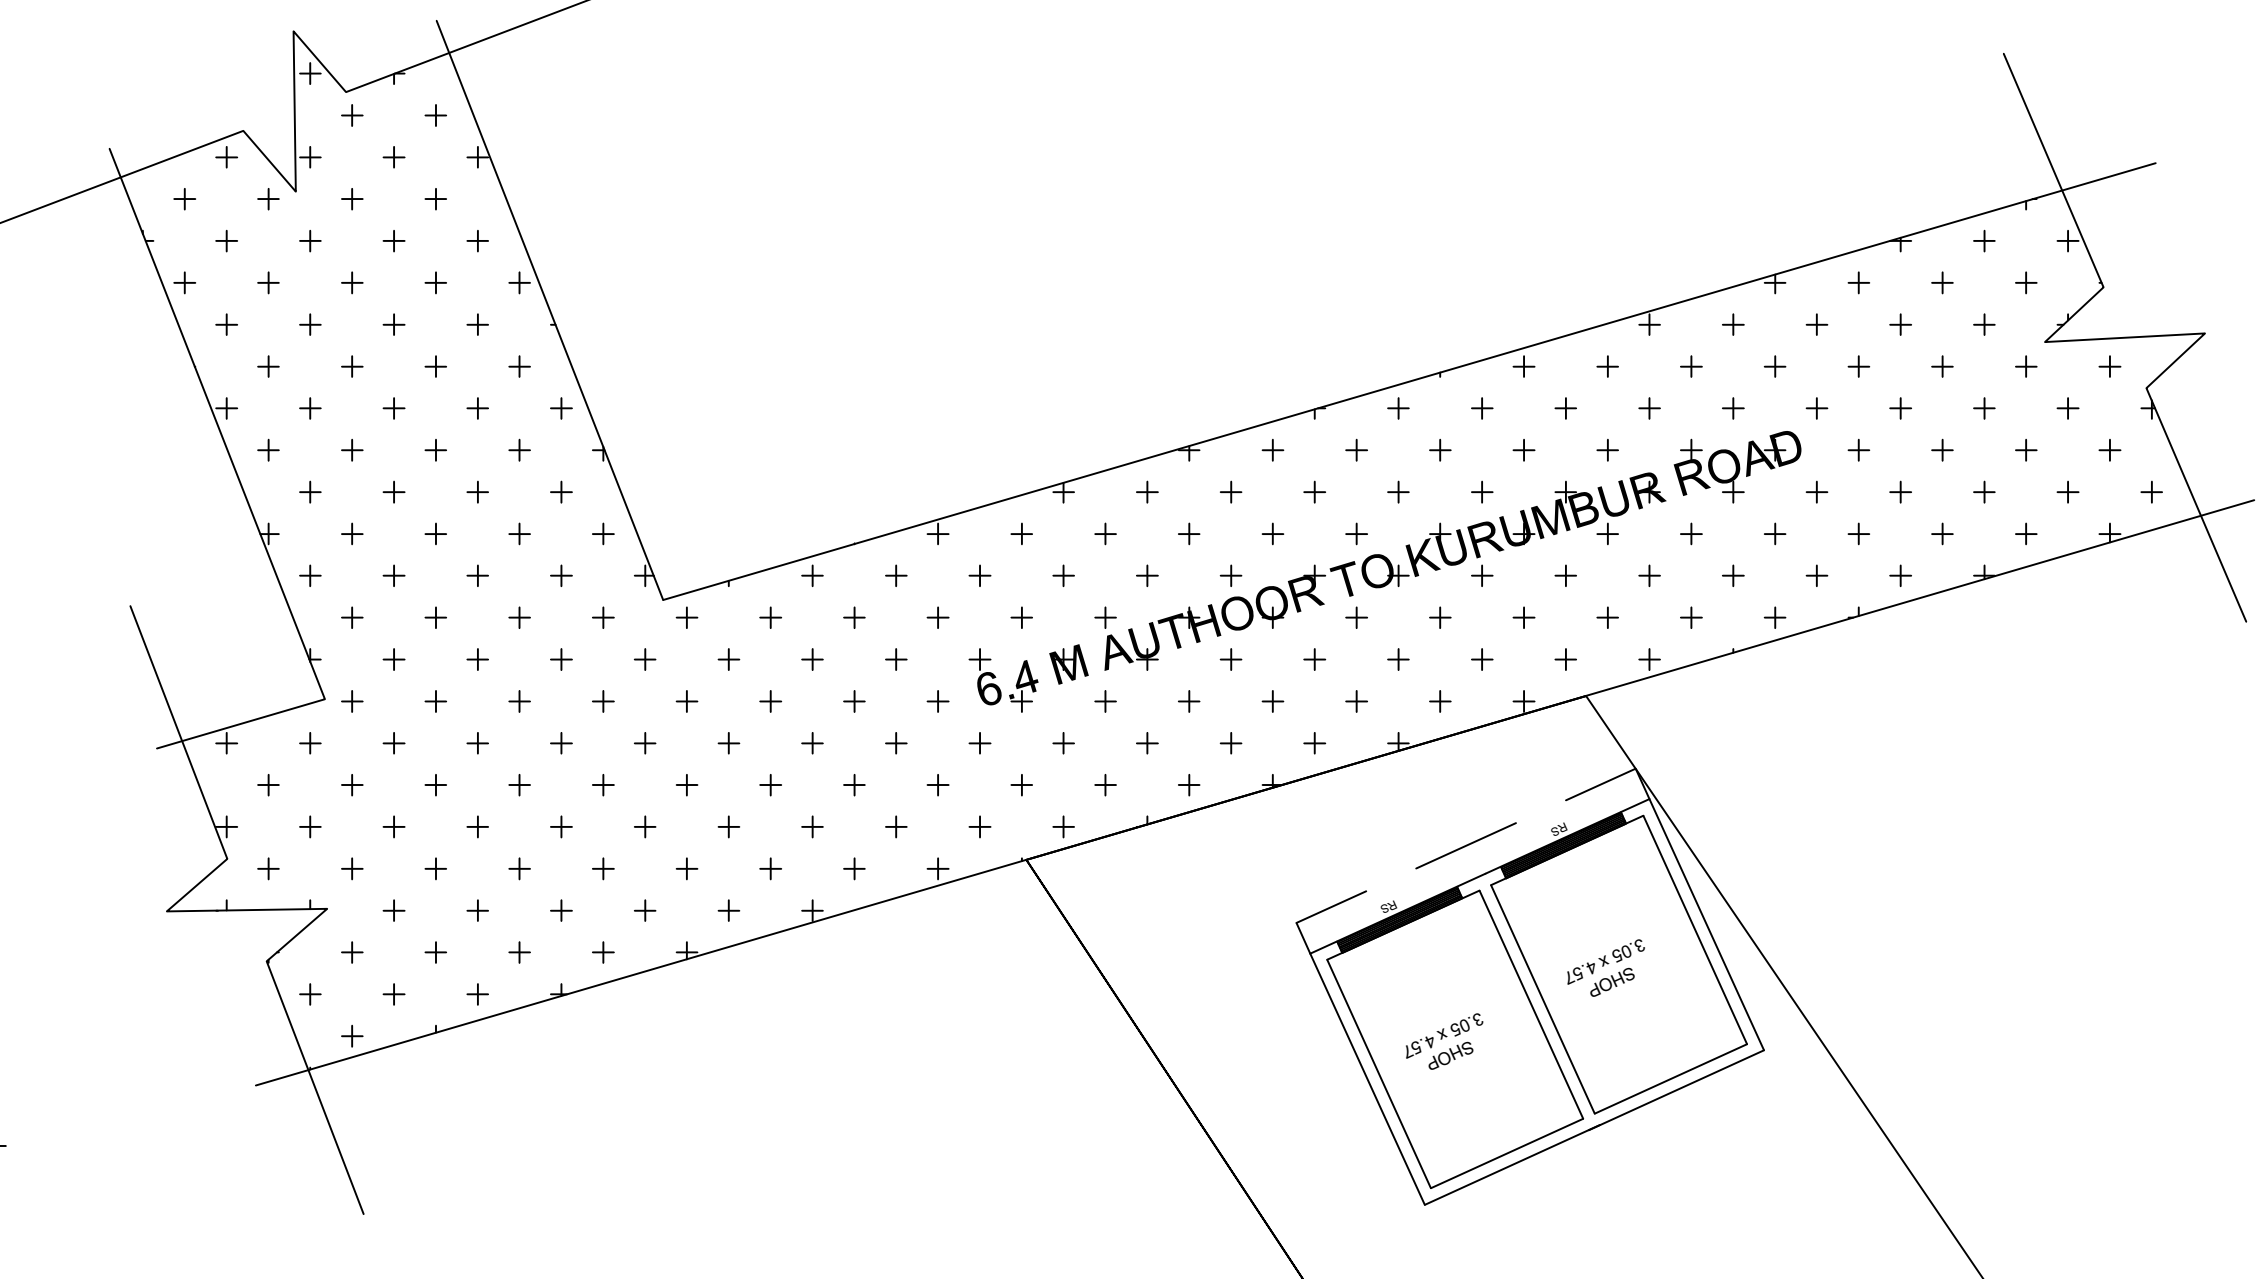




PLAN SHOWING THE PROPOSED CONSTRUCTION OF R.C.C ROOF SHOP,IN SY.NO:382/2,AT SOUTH MARANTHALAI VILLAGE,SUGANTHALAI PANCHAYAT OF ALWARTHIRUNAGARI UNION.

NAME OF THE APPLICANT : Mr.SARAVANAN S/O.Mr.JEYARAJ.

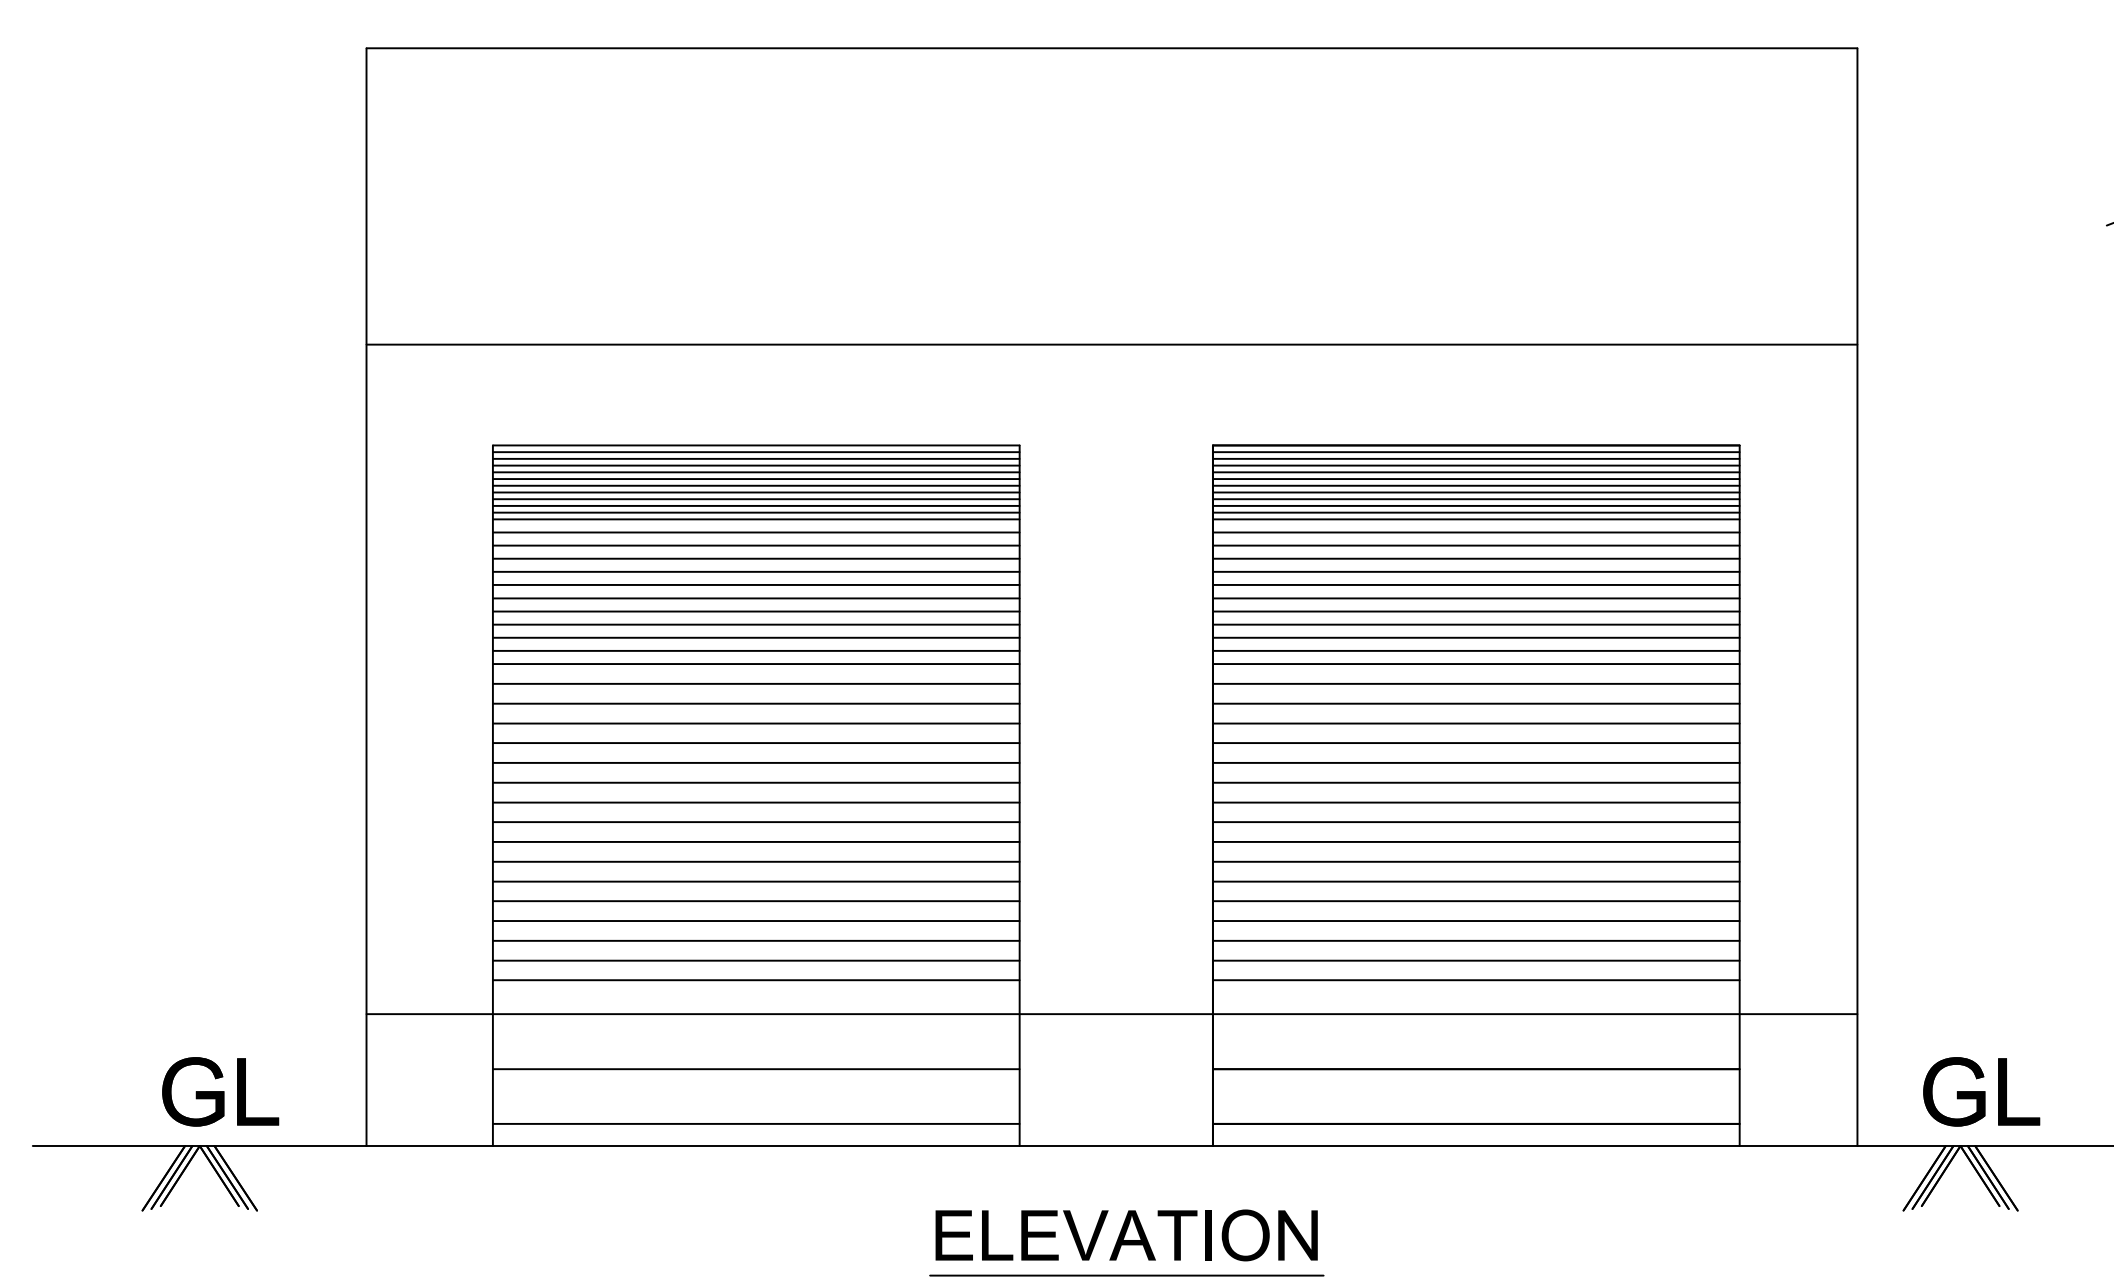

SEPTIC TANK DETAILS

PICHAI NADAR,MOOKA NADAR,
VELLAIYA NADAR,KASI NADAR
LAND

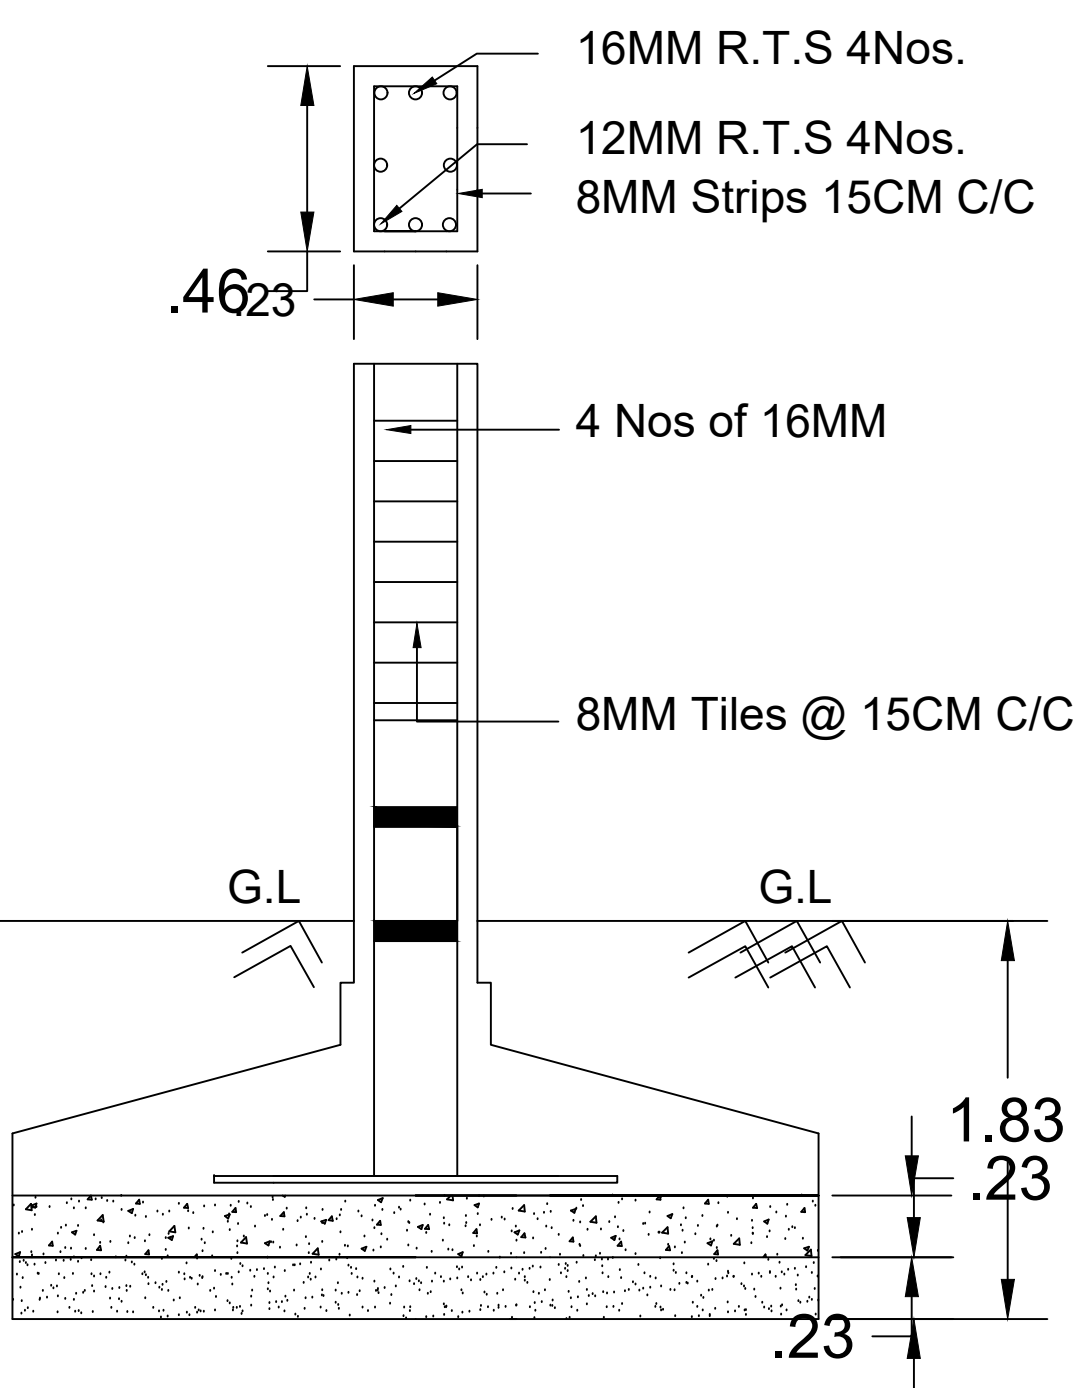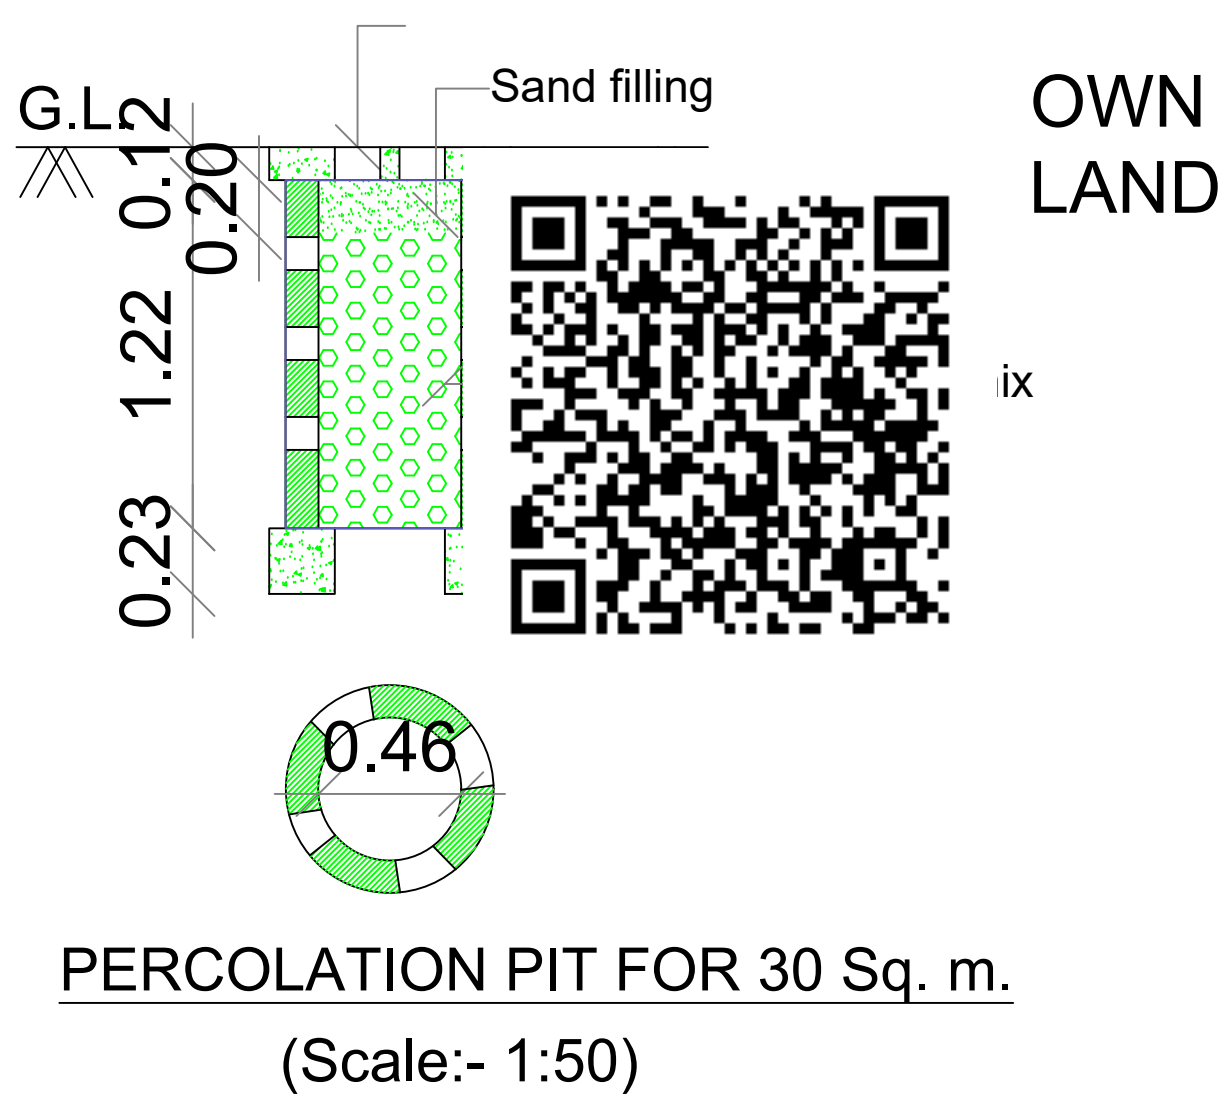


SITE PLAN
(NOT TO SCALE)

JOINERY			
W3	Window 4.49 X 1.22	W2	Window 2.98 X 1.22
D	DOOR 1.22 X 2.10	V1	Ventilator 2.33 X 0.61
D2	DOOR 0.76 X 2.10	V	Ventilator 0.91 X 0.61
AREA DETAILS		SQ.M	SQ.FT
	SITE AREA	934.85	10059.04
	PRO. GROUND FLOOR	34.15	367.45
	OPEN SPACE	900.70	9691.59
	ROAD		
○ RAIN WATER COLLECTING TANK IS TO BE PROVIDED waste water to be garden ALL DIMENSION ARE IN METRE SCALE 1:100			

OFFICE USE

G.P.S:8.612482,78.060291

APPLICANT

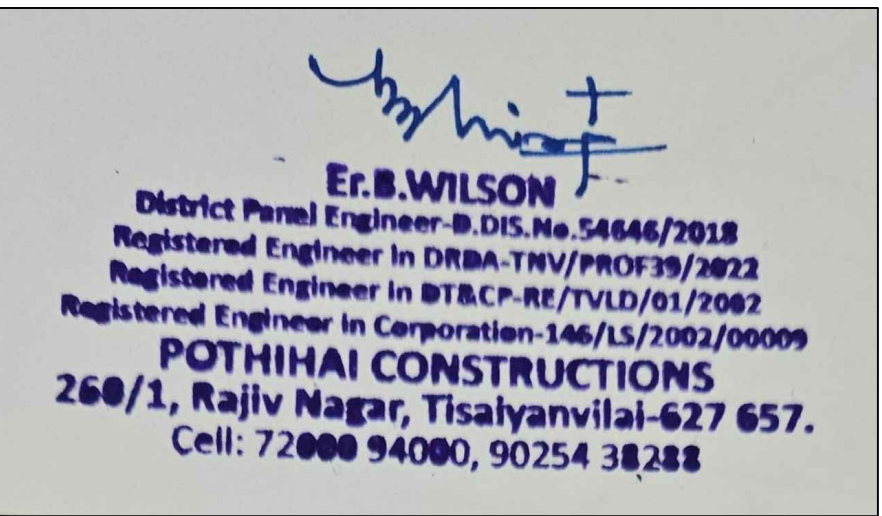

ENGINEER



POTHIHAI CONSTRUCTIONS
Near Pothihai Public School
Tisaiyanvilai.
Cell No. 90254 38288 , 99524 69037

PLAN.NO:
989