



PLAN SHOWING THE PROPOSED CONSTRUCTION OF A DWELLING 4 HOUSES IN SURVEY NO: 32/1A,31/1B2A,22/2C2C1, PATTA NO:949,1294,1081,


KULASEKARANPATTINAM VILLAGE AND PANCHAYAT OF UDANGUDI PANCHAYAT UNION, TIRUCHENDUR TALUK, THOOTHUKUDI DISTRICT

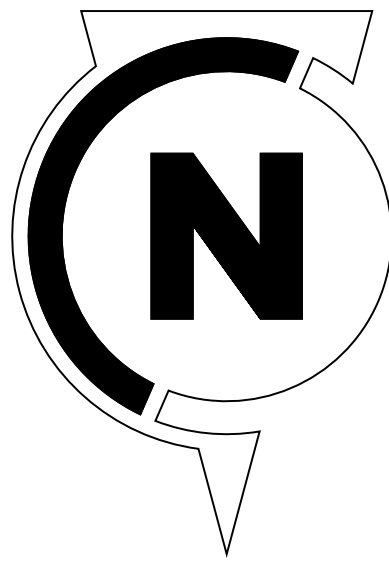


APPLICANT NAME: Mr. SELVAN S S/O.SUDALAI

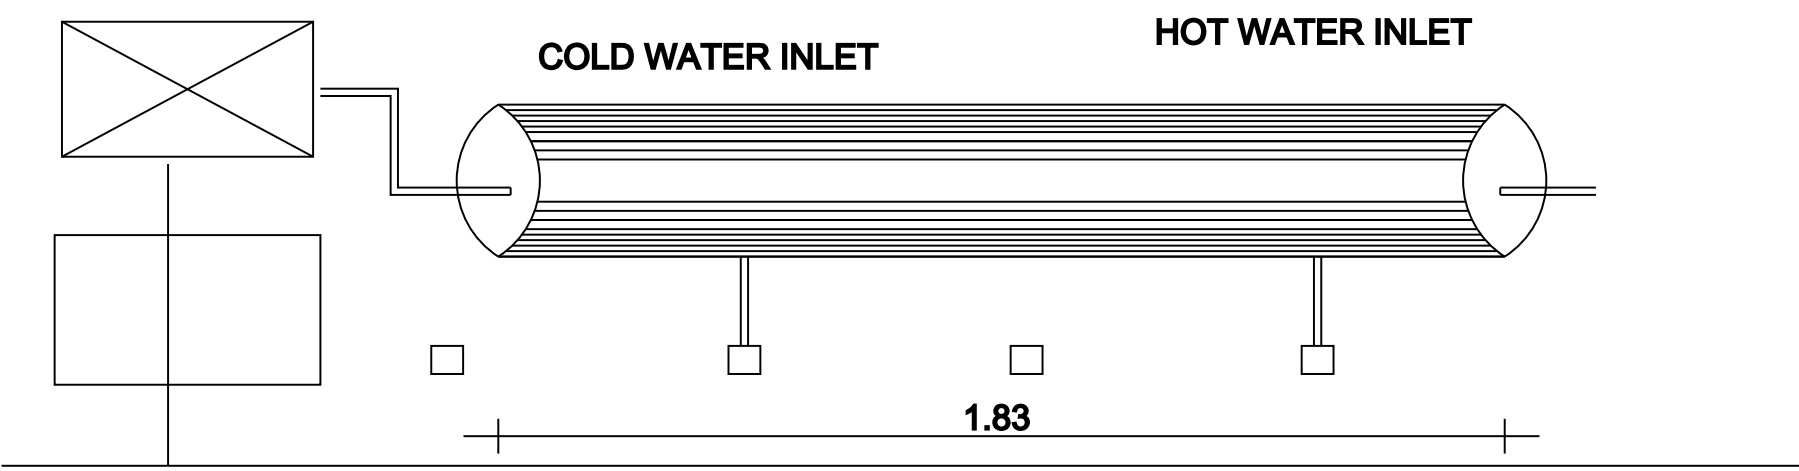


DETAILS OF SOLAR HOT WATER SYSTEM

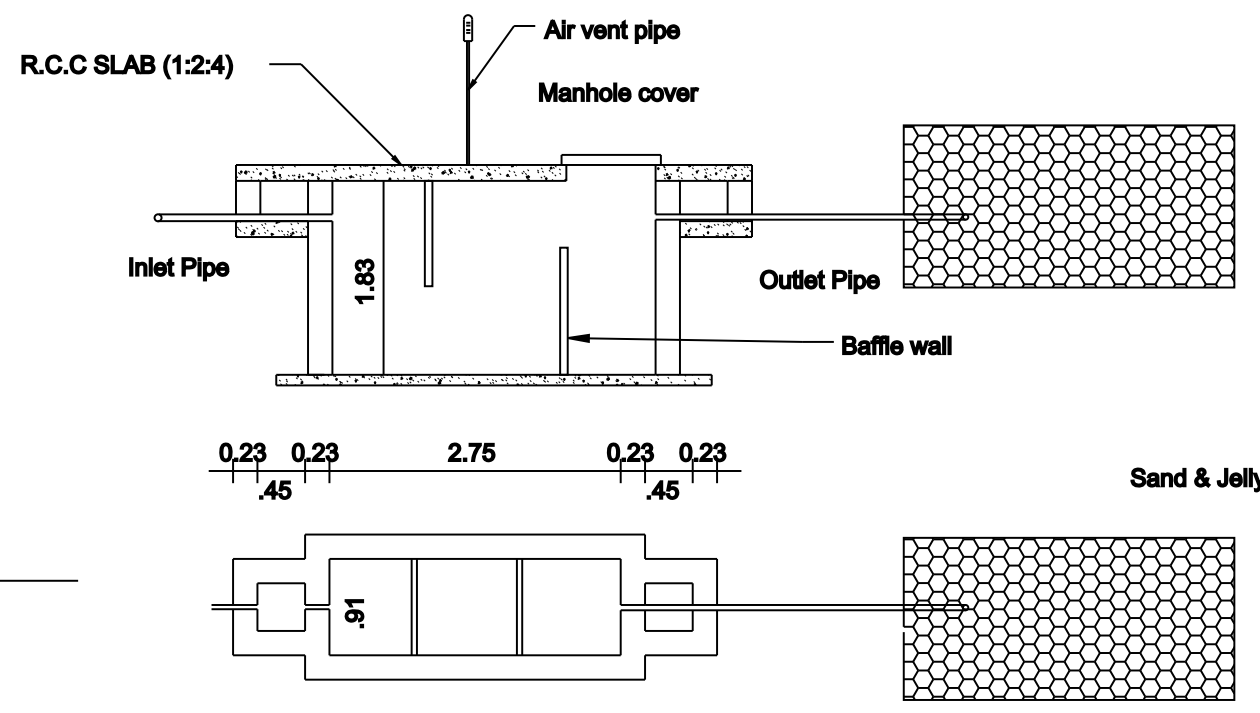


SEPTIC TANK & TRENCH

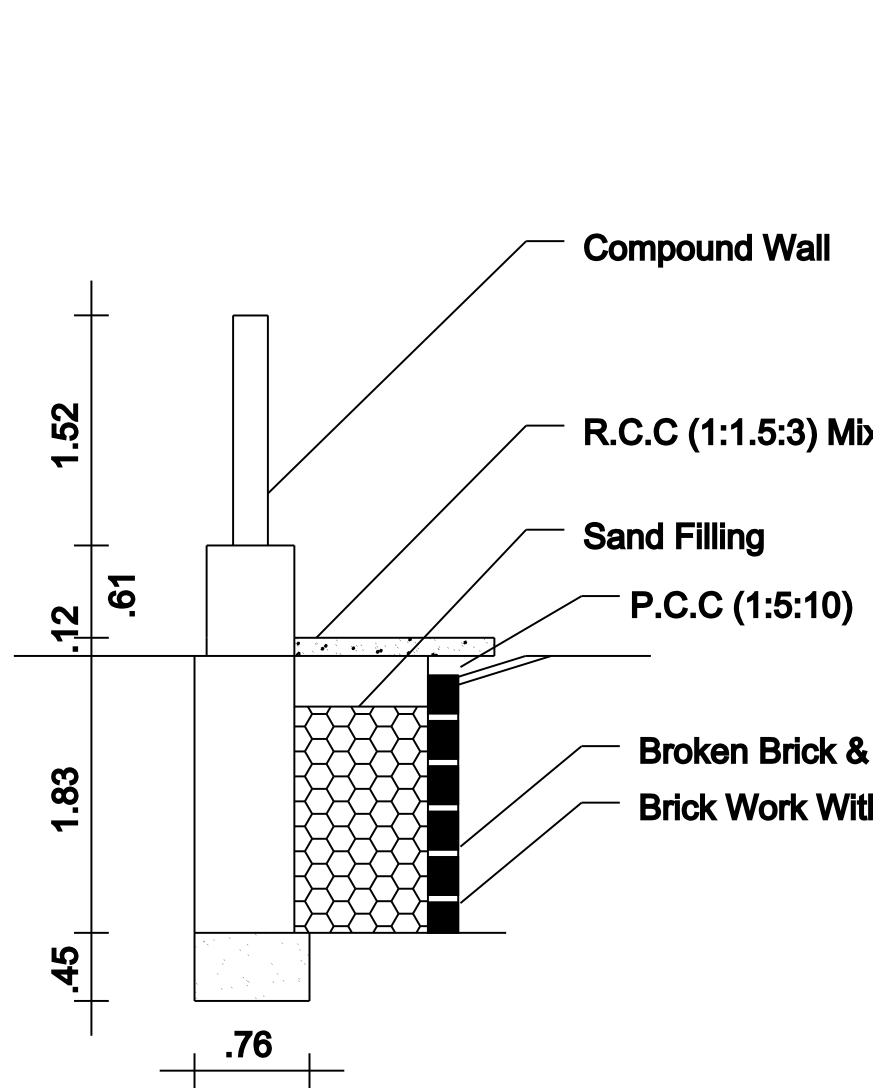

RAIN WATER HARVEST DETAILS

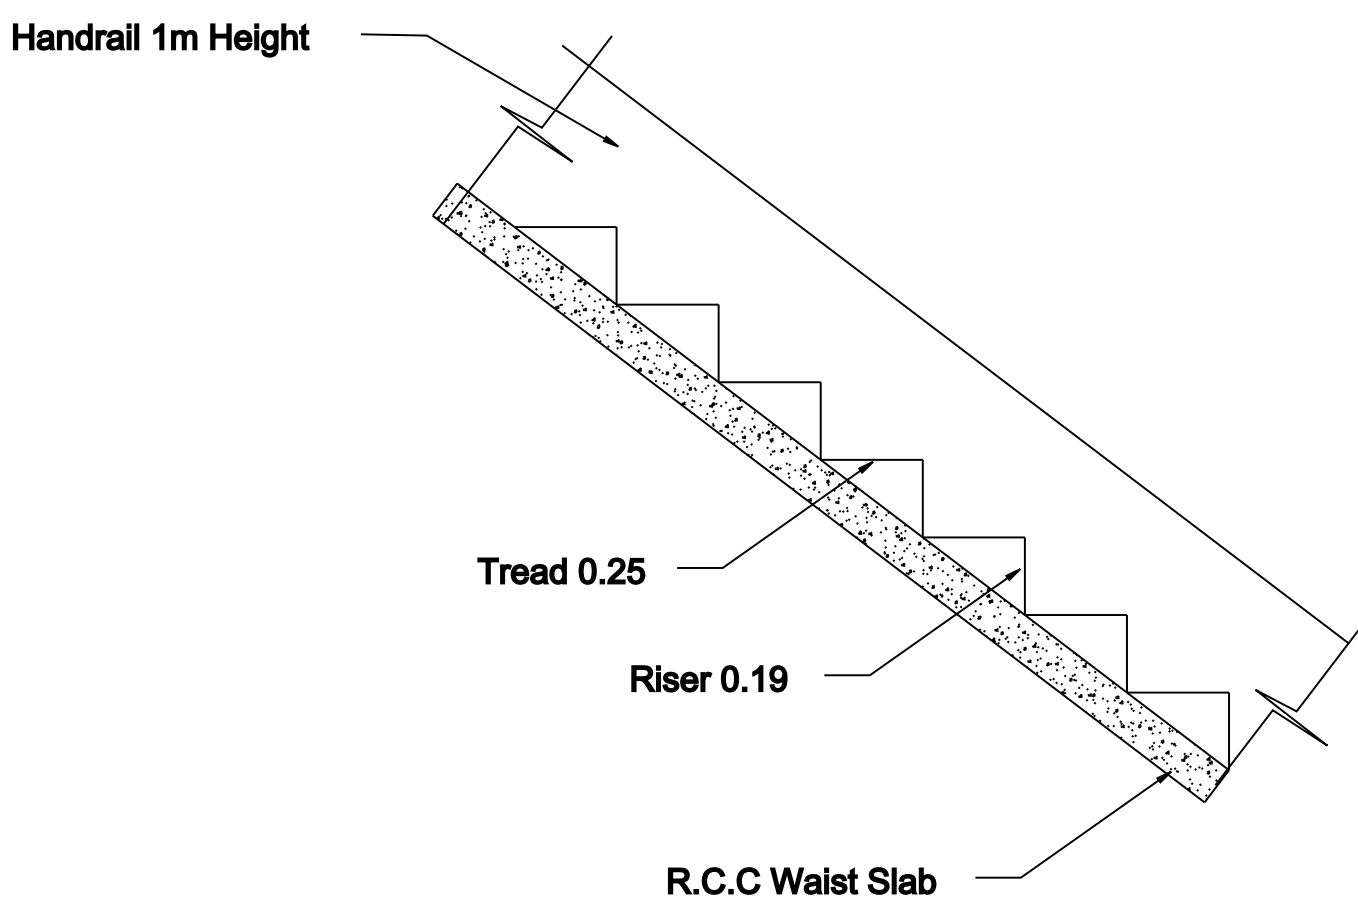

STAIR DETAILS

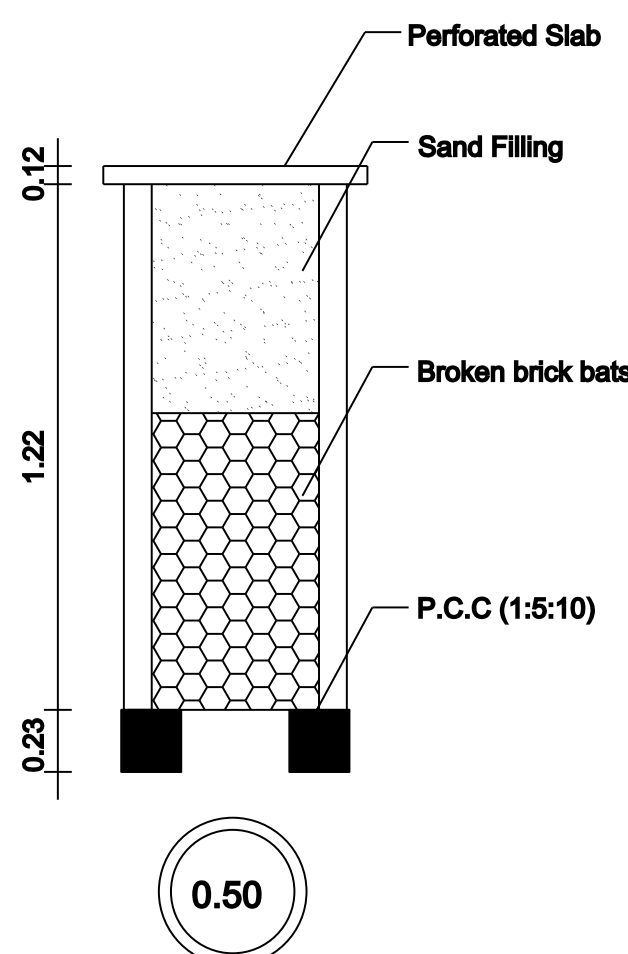


RAIN WATER COLLECTION WELL

FLOOR SPACE INDEX


FSI= 171.58/2266.24=0.07<2

PLOT COVERAGE


PC= 171.58/2266.24=07.57%

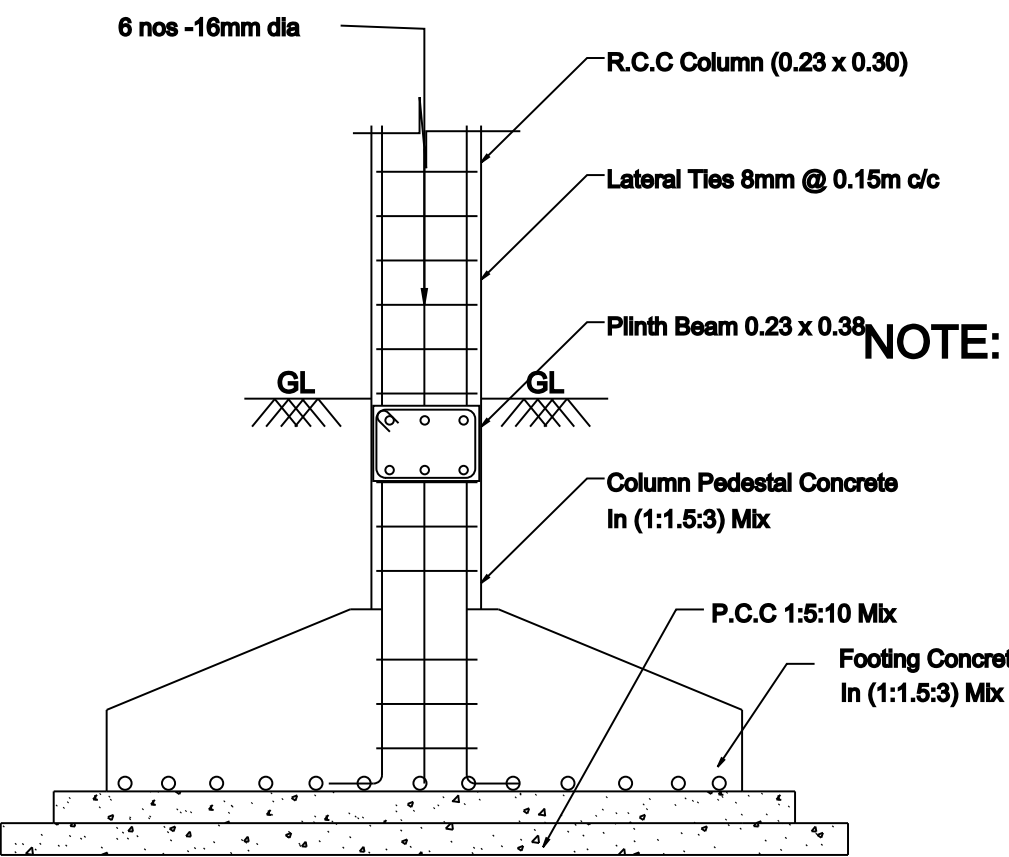


COLUMN FOOTING DETAILS

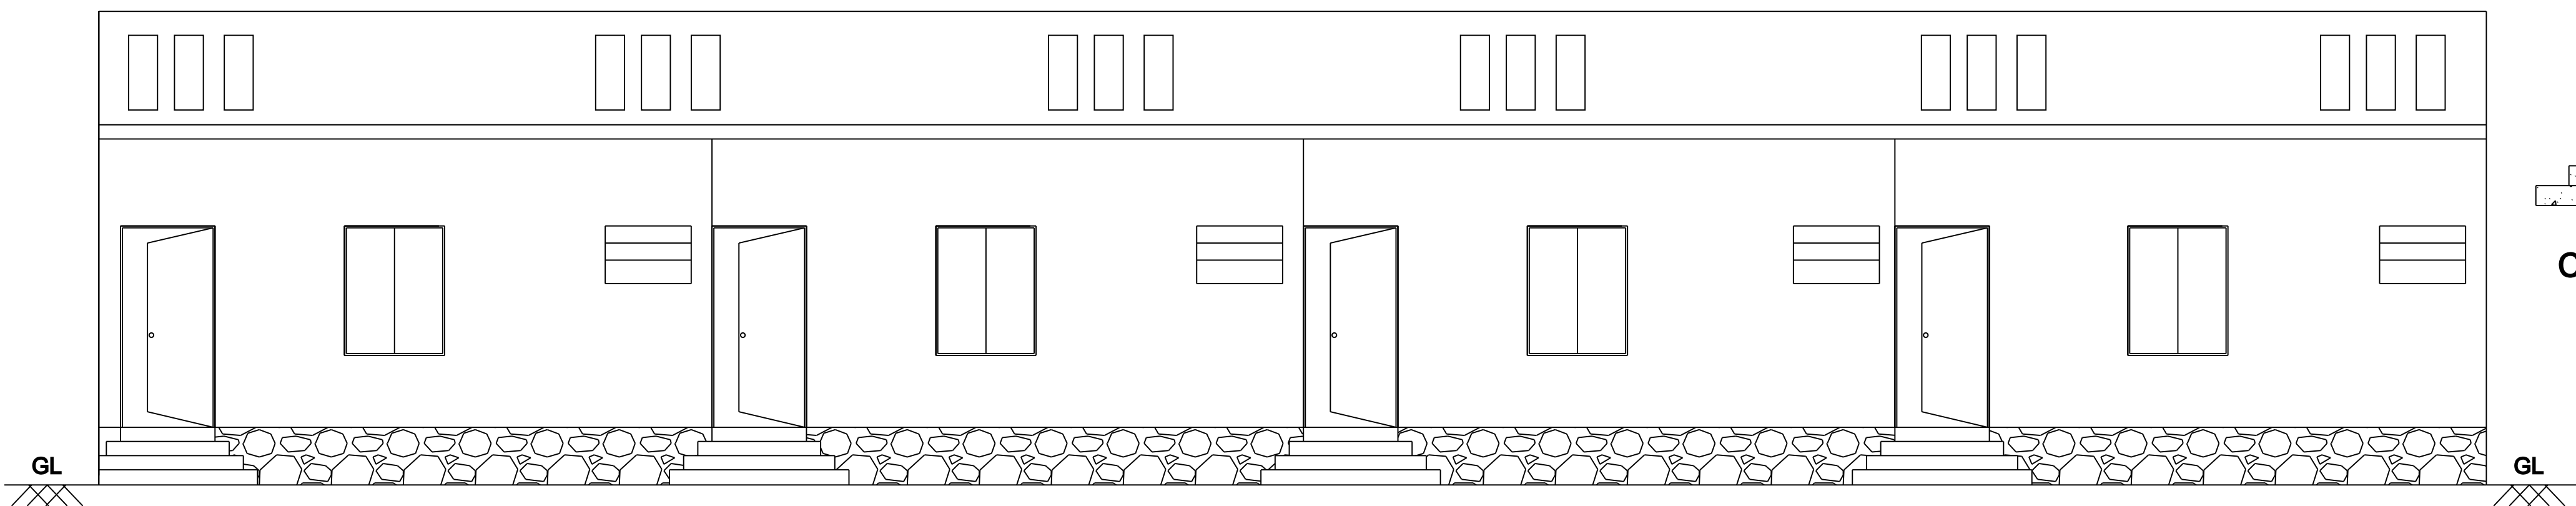


FRONT ELEVATION

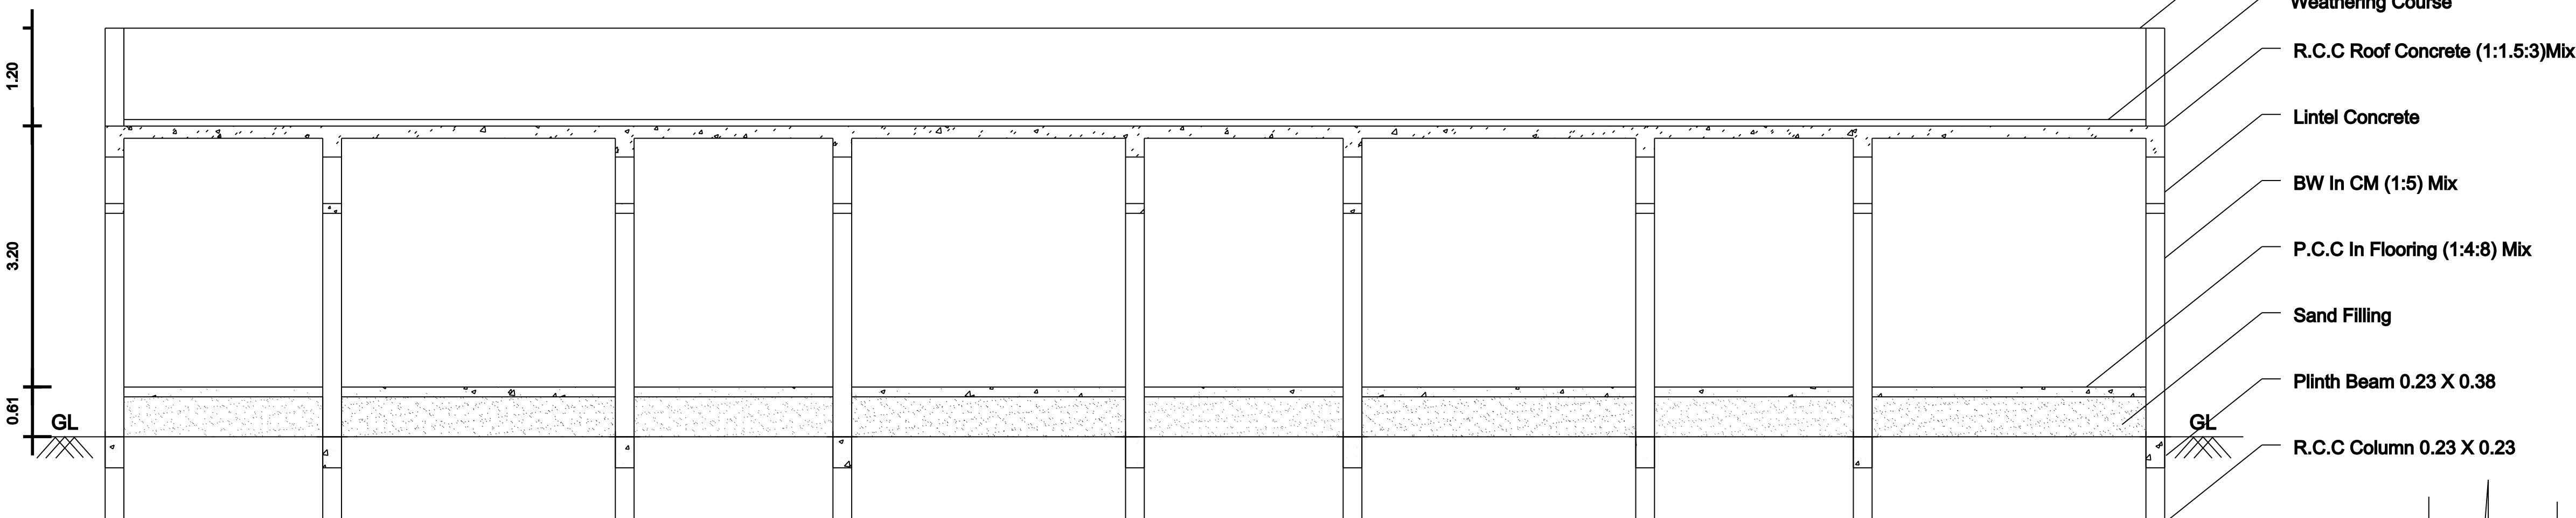


SECTION ON 'AB'

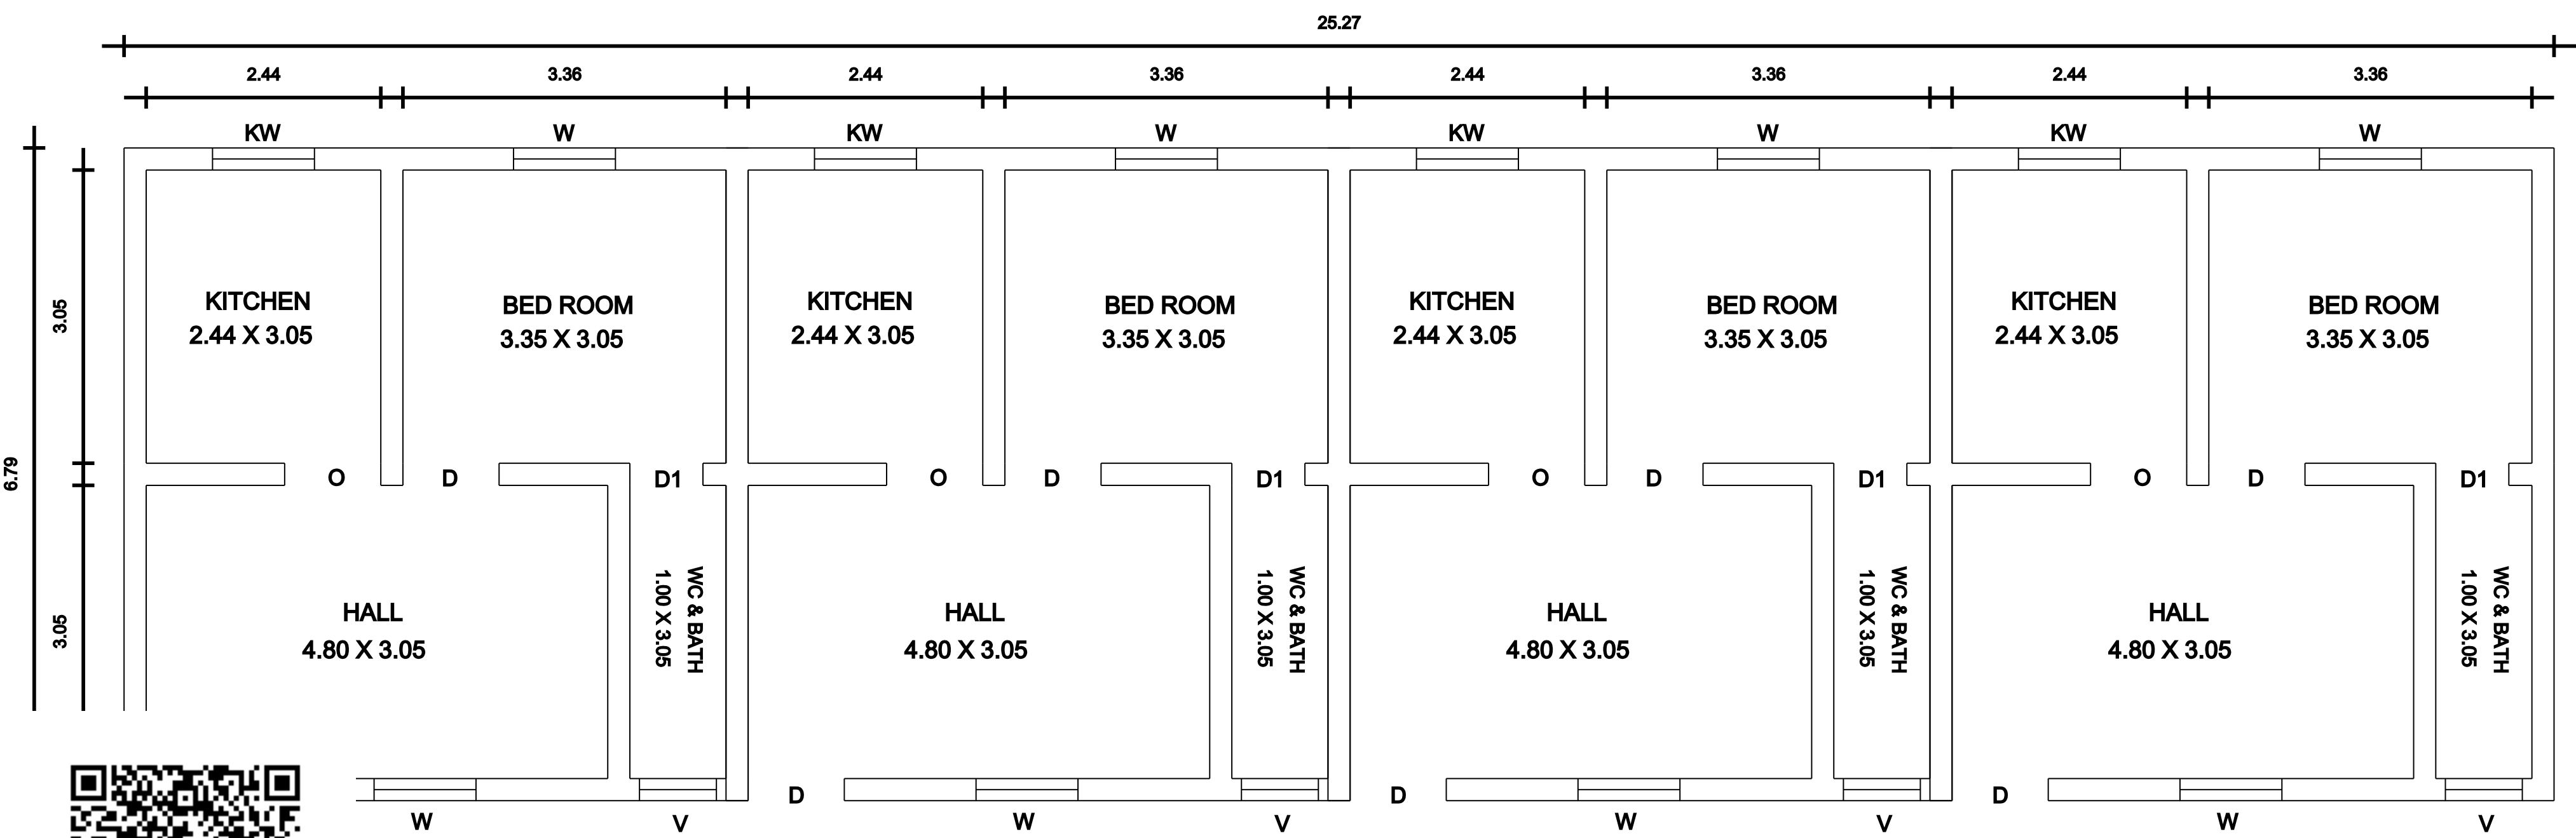

GROUND FLOOR PLAN

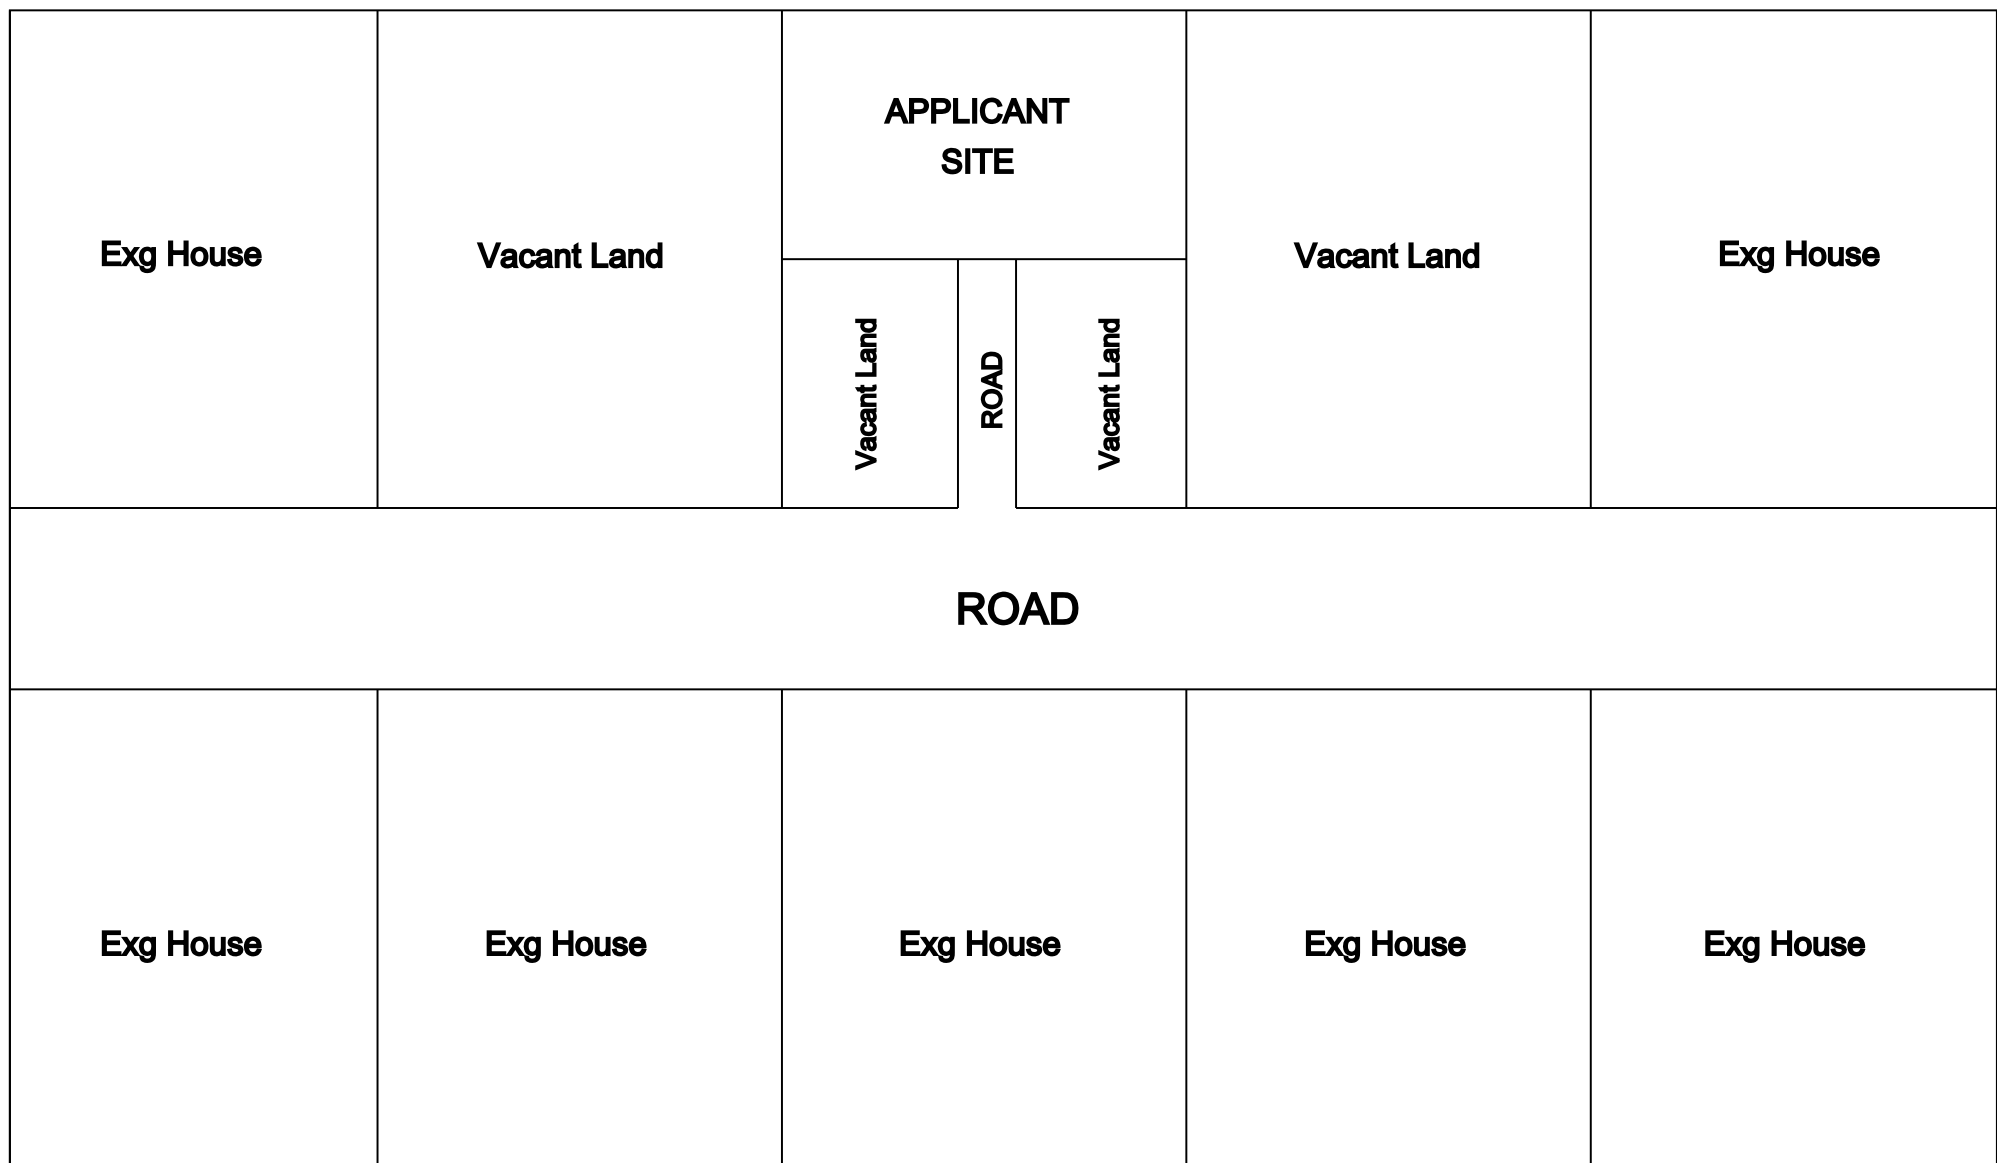

KEY PLAN

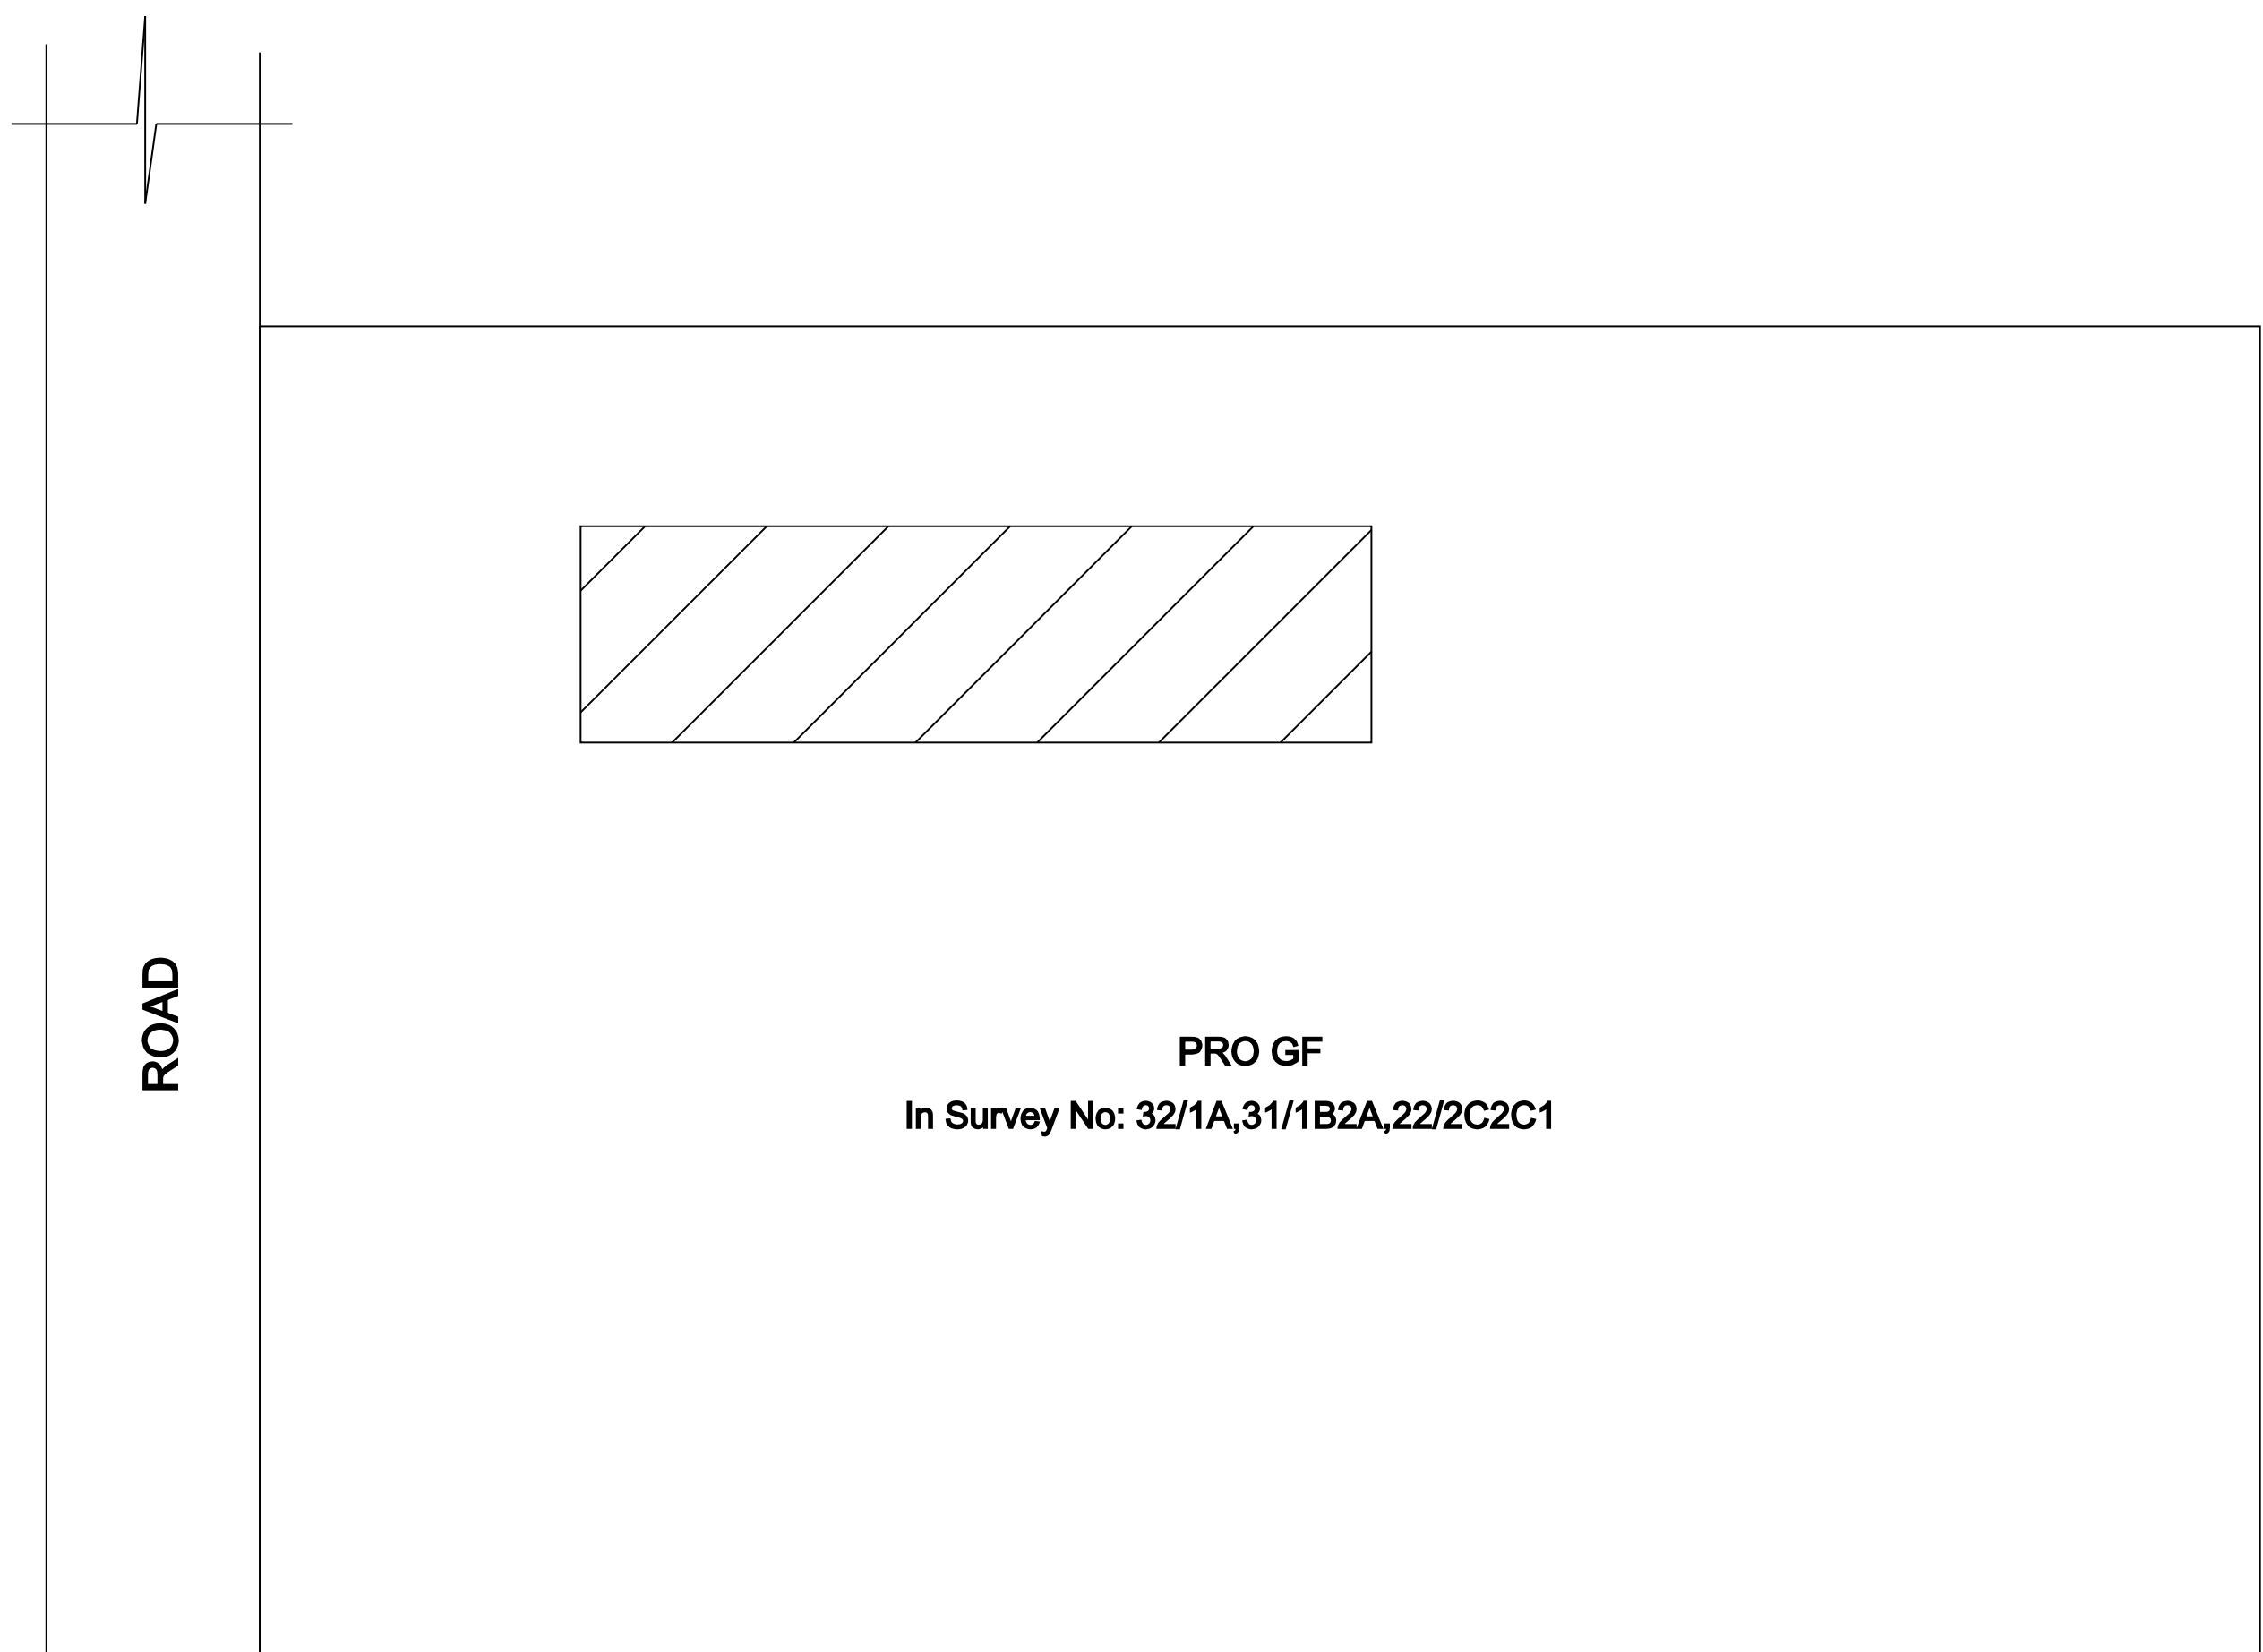

SITE PLAN

Not To Scale

Rain Water to be Provided
Waste Water To Garden
Percolation Pit to be Provided
Solar System to be Provided

AREA STATEMENT			
	Site Area(56 Cents)	2266.24 Sq.m	24393.60 Sq.ft
	Pro Ground Floor Plan	171.58 Sq.m	1846.87 Sq.ft
	Open Area	2094.66 Sq.m	22546.73 Sq.ft

JOINERY DETAILS			
D	DOOR	1.00	2.13
D1	DOOR	0.76	2.13
W3	WINDOW	1.06	1.37
KW	KITCHEN WINDOW	1.22	1.06
V	VENTILATOR	0.91	0.61

OFFICE USE				

APPLICANT				

R. Mohamed

Er.R.MOHAMED IRSATH

Register Engineer in DRDA-UDY/2022/05

Municipality Engineer -139/LS/2022/00002058

Licensed Surveyor & Consulting Engineer

Build-Up Construction,

18, Periya Street, Udangudi-628203

Cell:9750953055, 9629271761

REGISTERED ENGINEER

ALL DIMENSIONS ARE IN METER (Scale:1:100)