



PLAN SHOWING THE PROPOSED CONSTRUCTION OF A DWELLING GROUND FLOOR HOUSE AT SURVEY NO: 543/22B1A1, PATTA:1499, MELA STREET,

SIRUNADARKUDIRUPPU VILLAGE AND PANCHAYATH, UDANGUDI PANCHAYATH UNION, TIRUCHENDUR TALUK,THOOTHUKUDI DISTRICT.


NAME OF THE APPLICANT: Mrs.MASANAM (W/O) Mr.CHELLAPPA

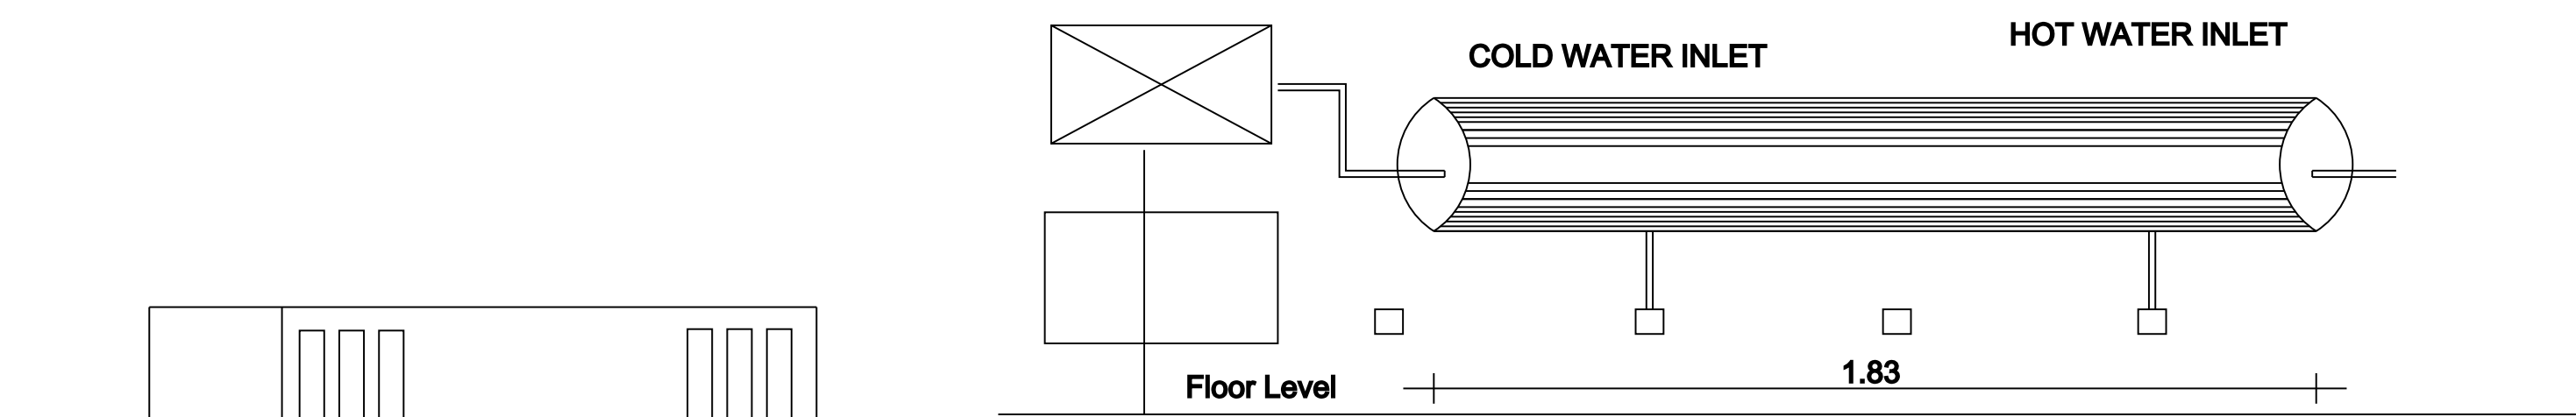


DETAILS OF SOLAR HOT WATER SYSTEM

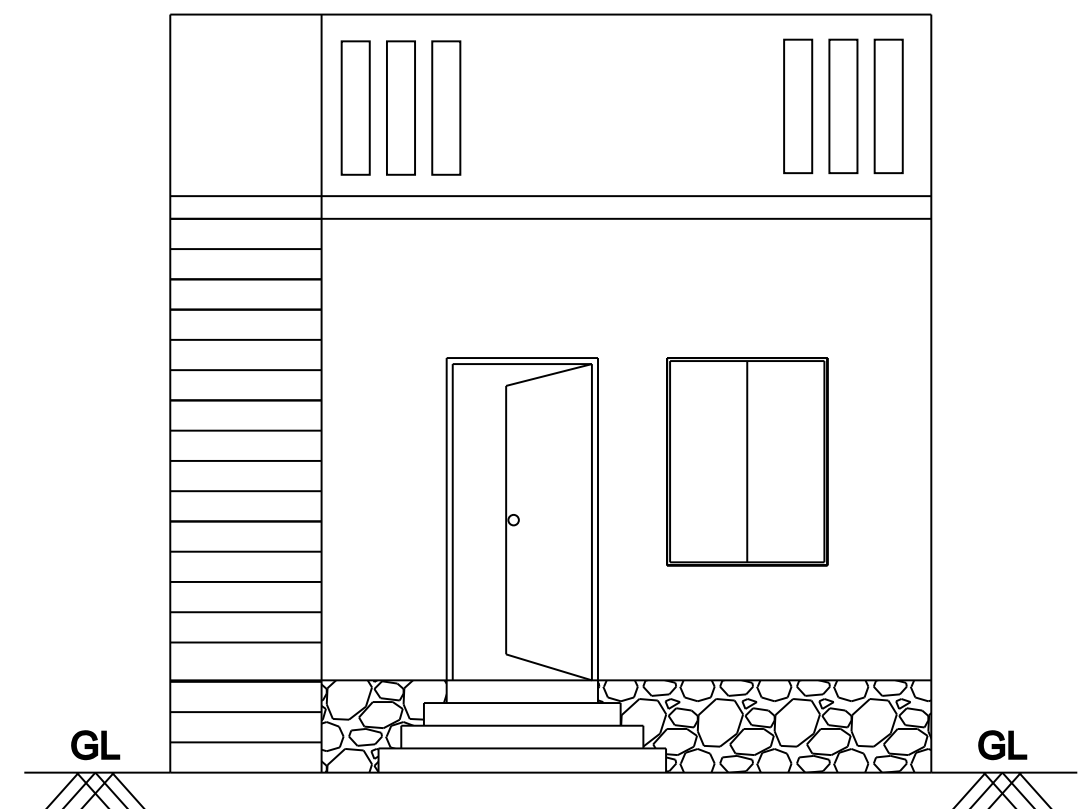


FRONT ELEVATION

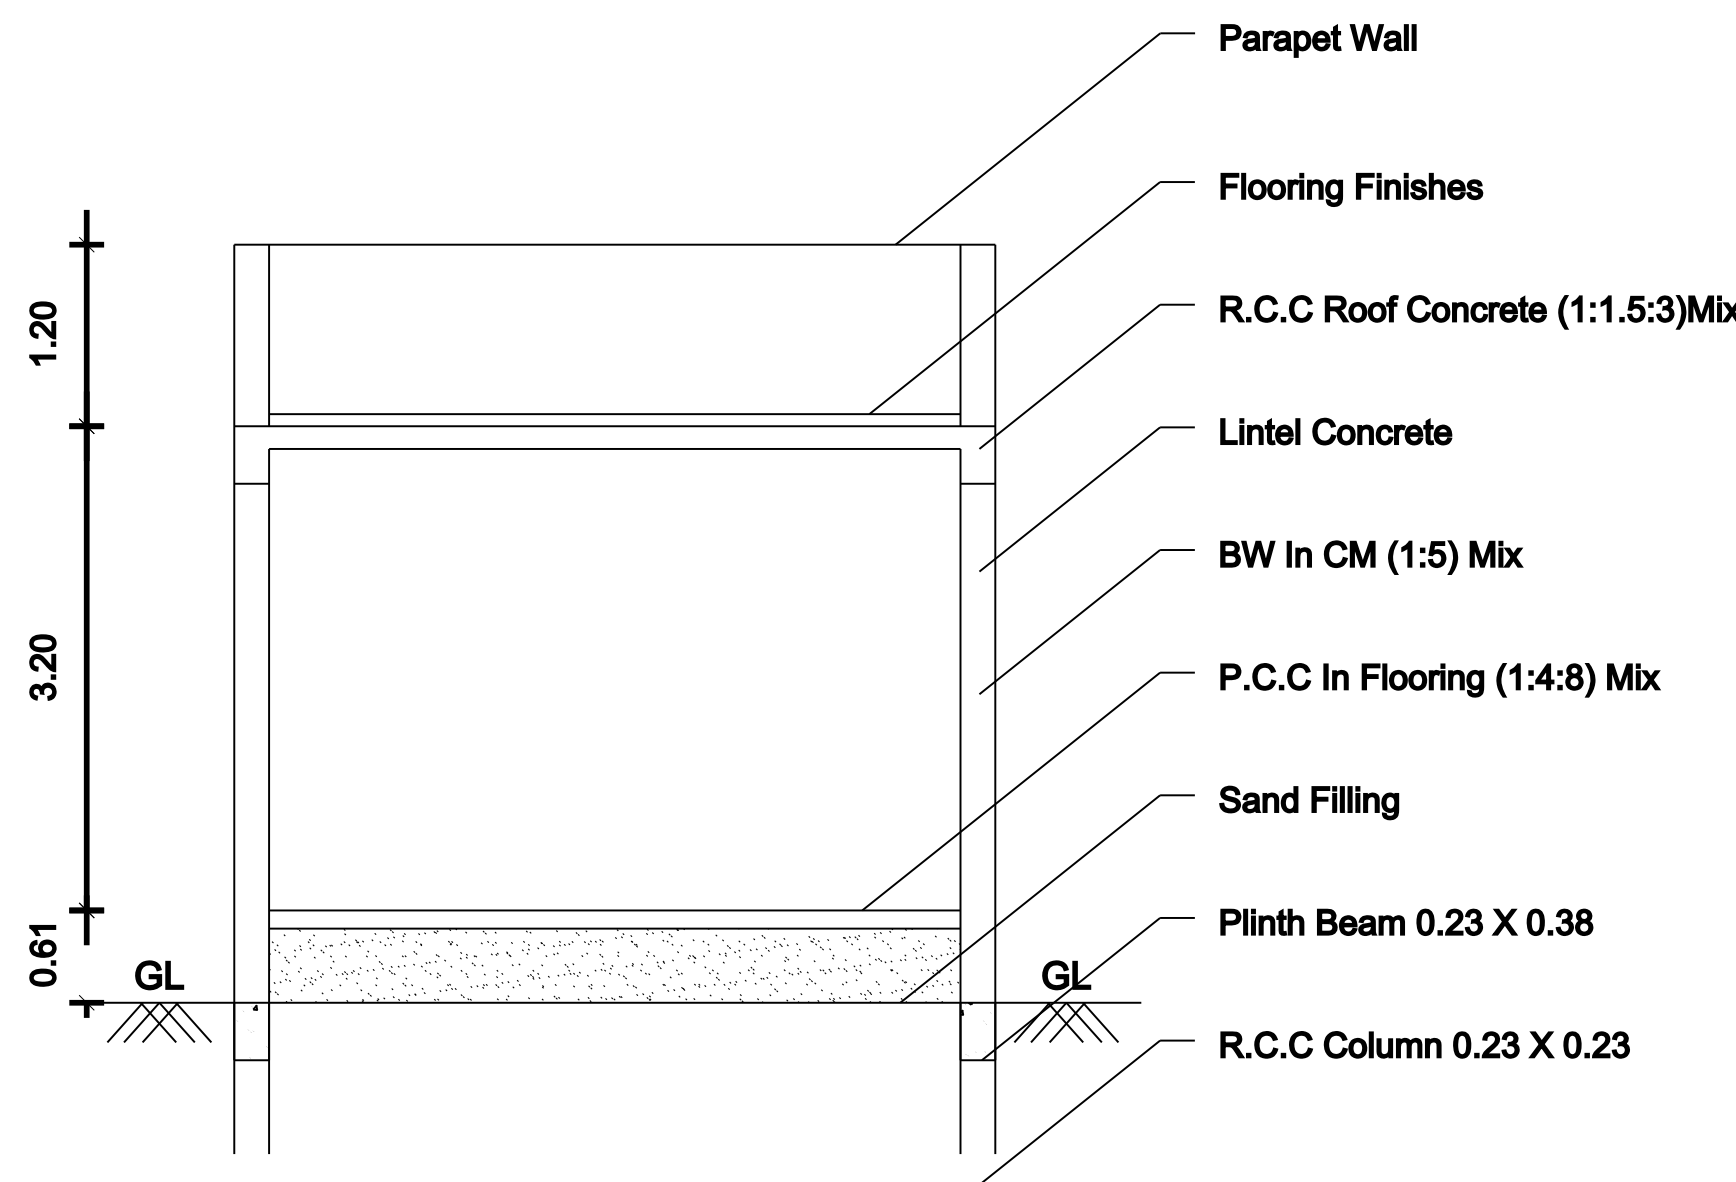


SECTION ON 'AB'

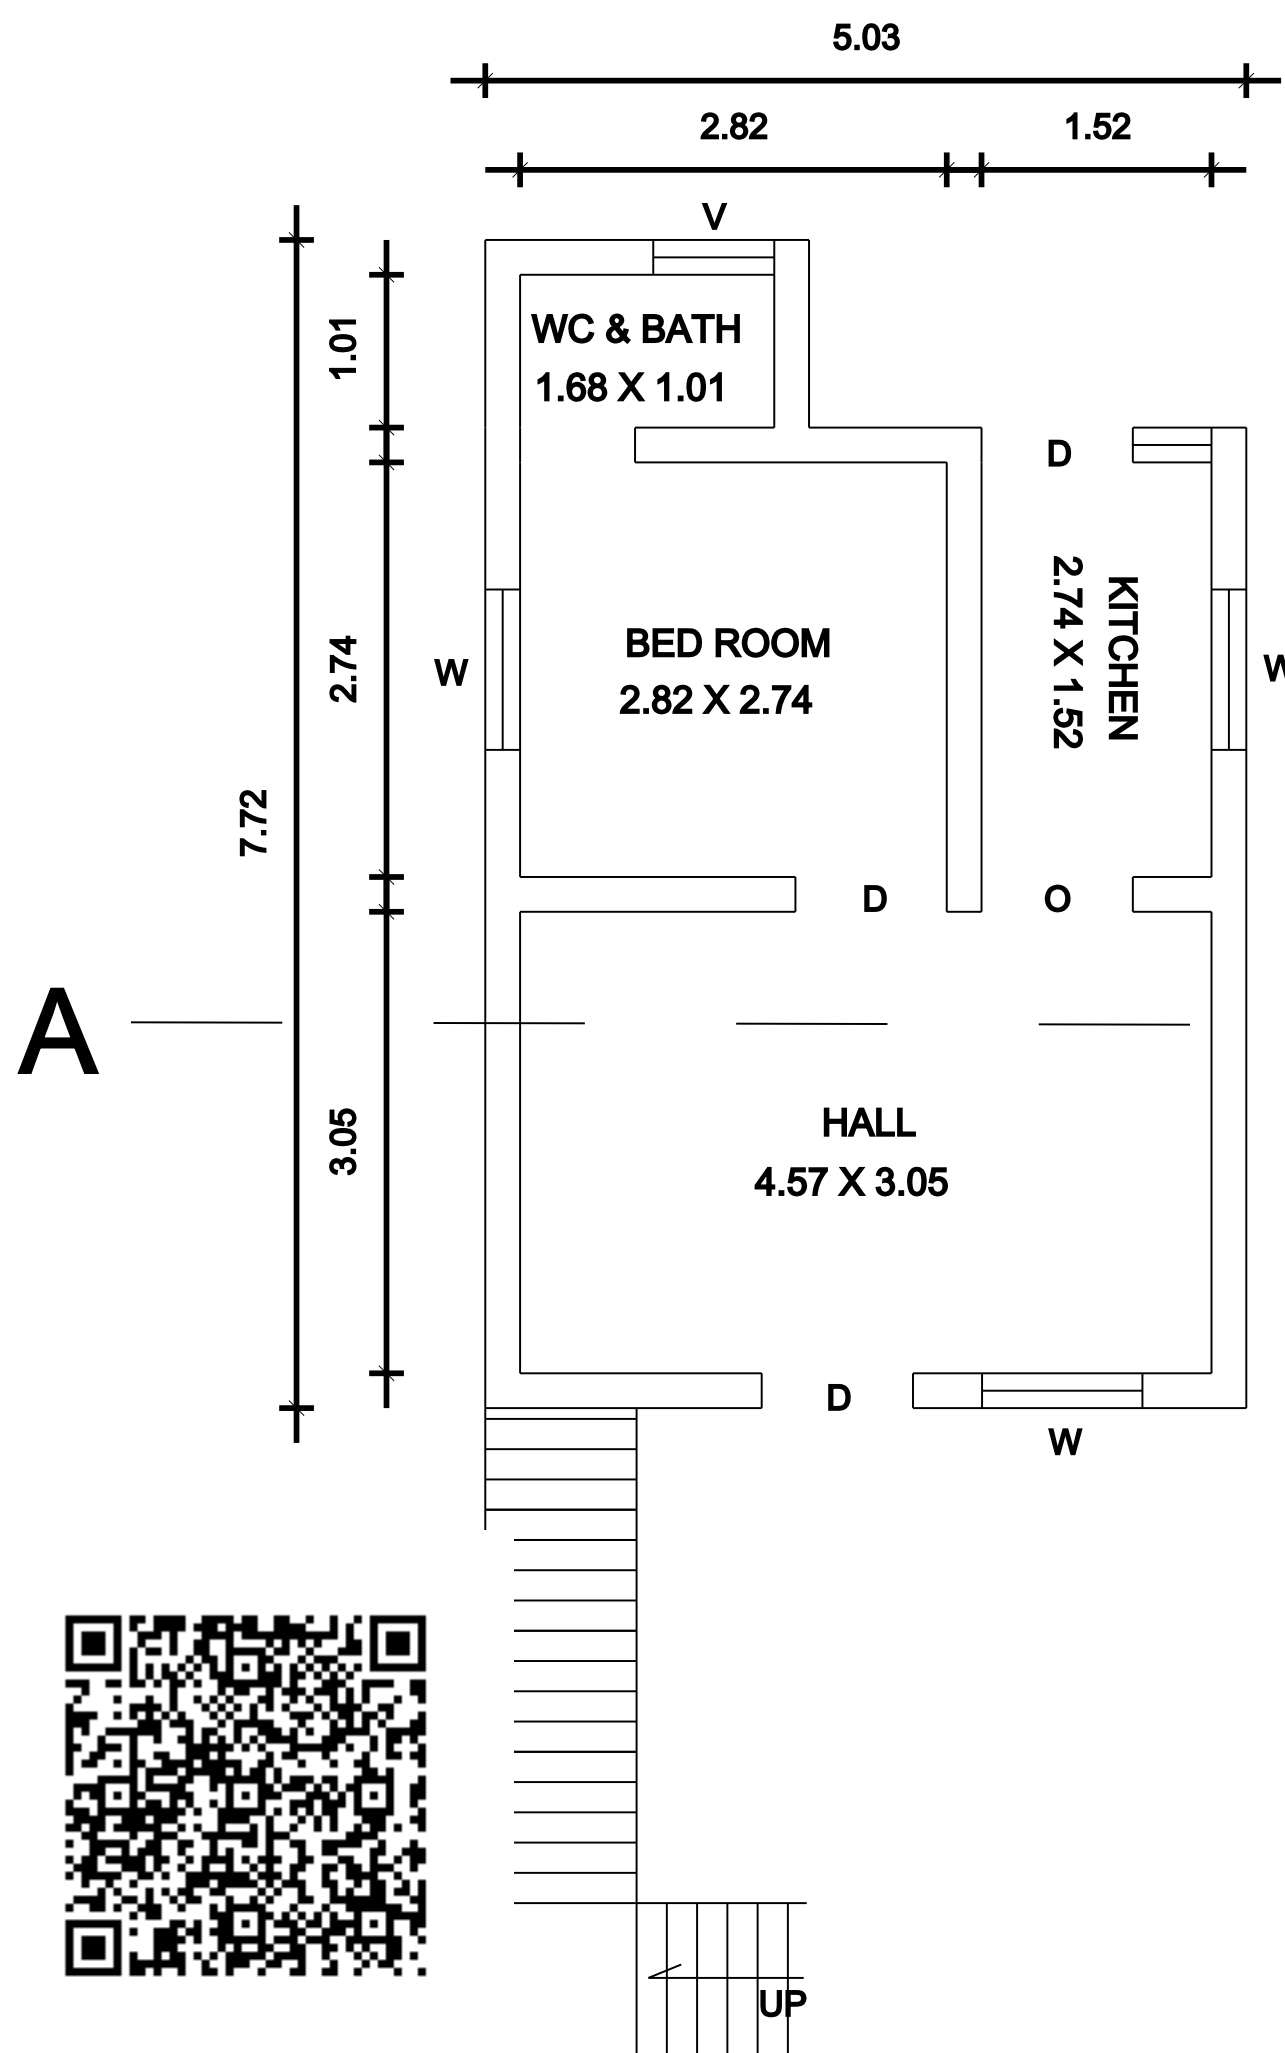


GROUND FLOOR PLAN

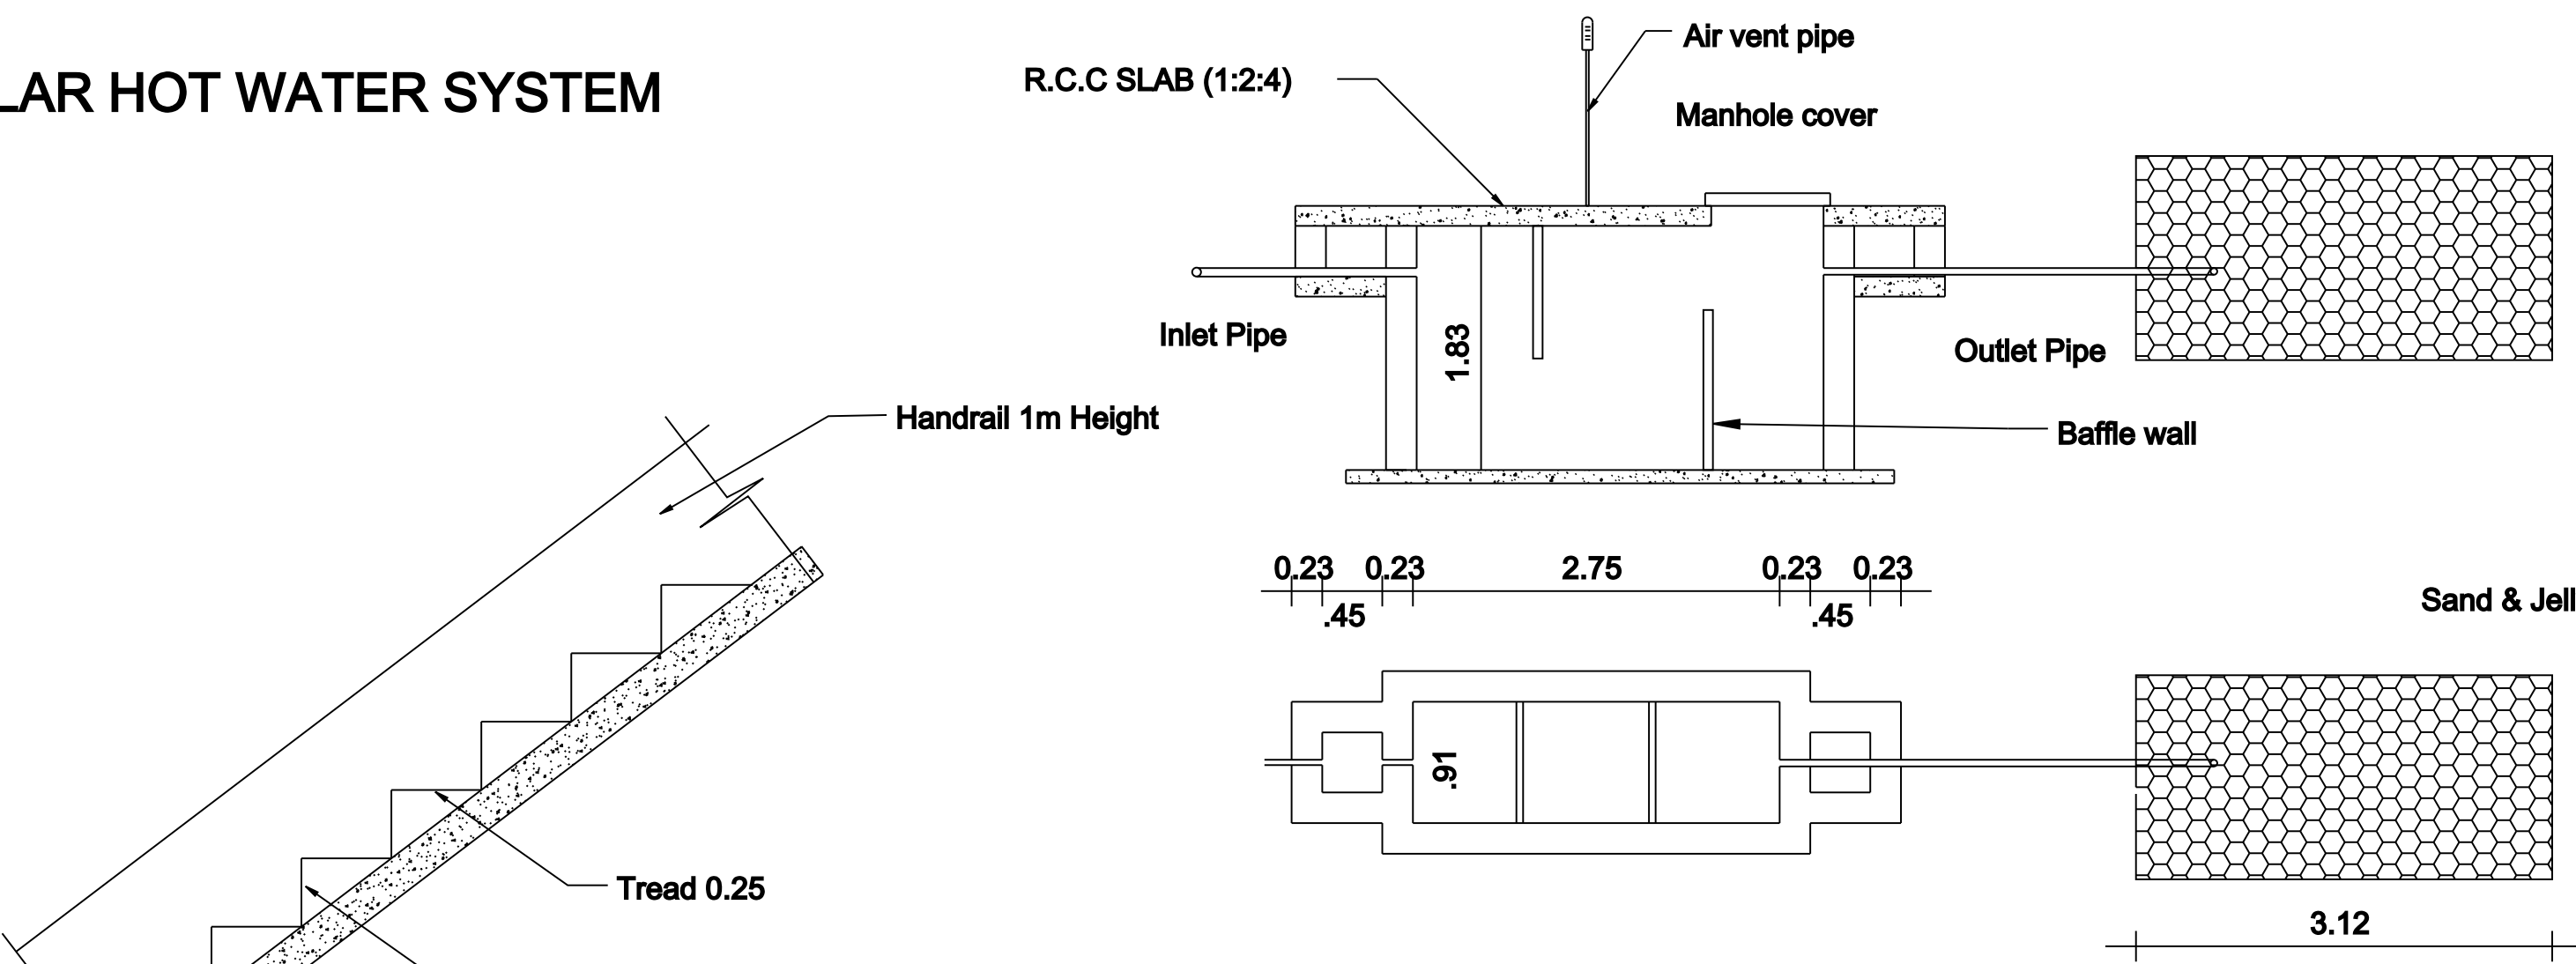

SEPTIC TANK & TRENCH

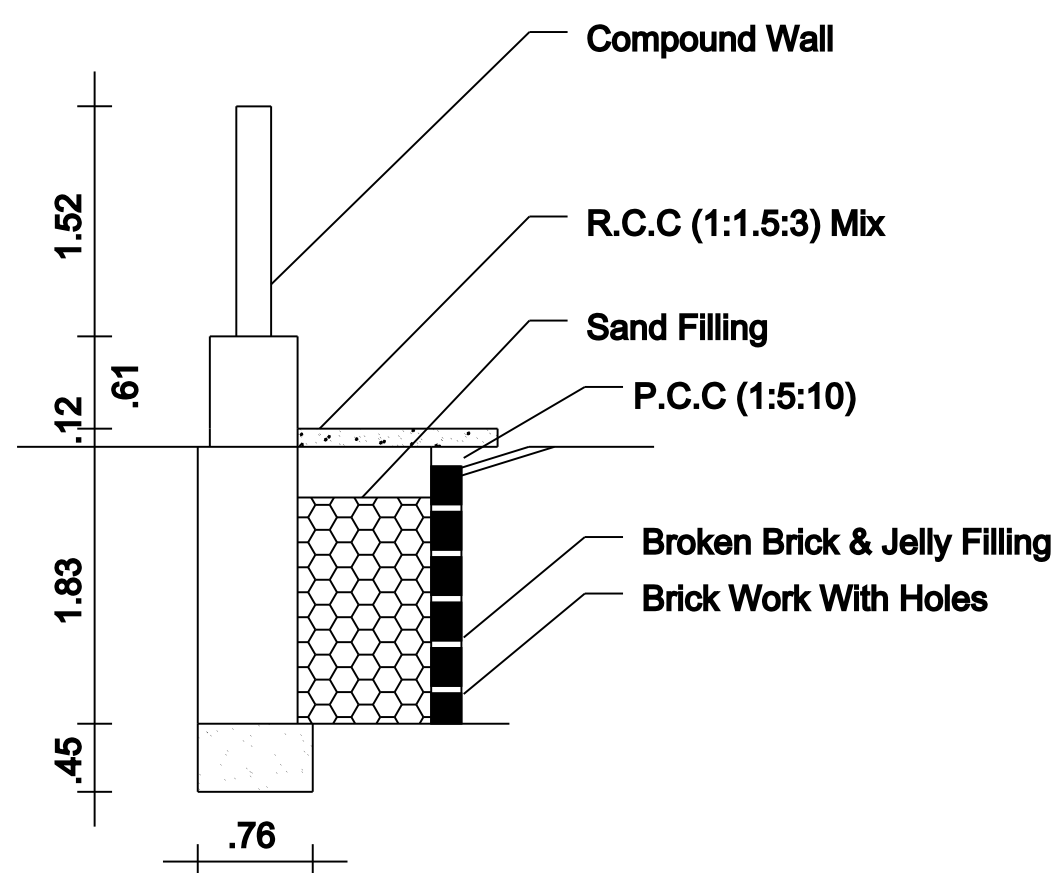


RAIN WATER HARVEST DETAILS

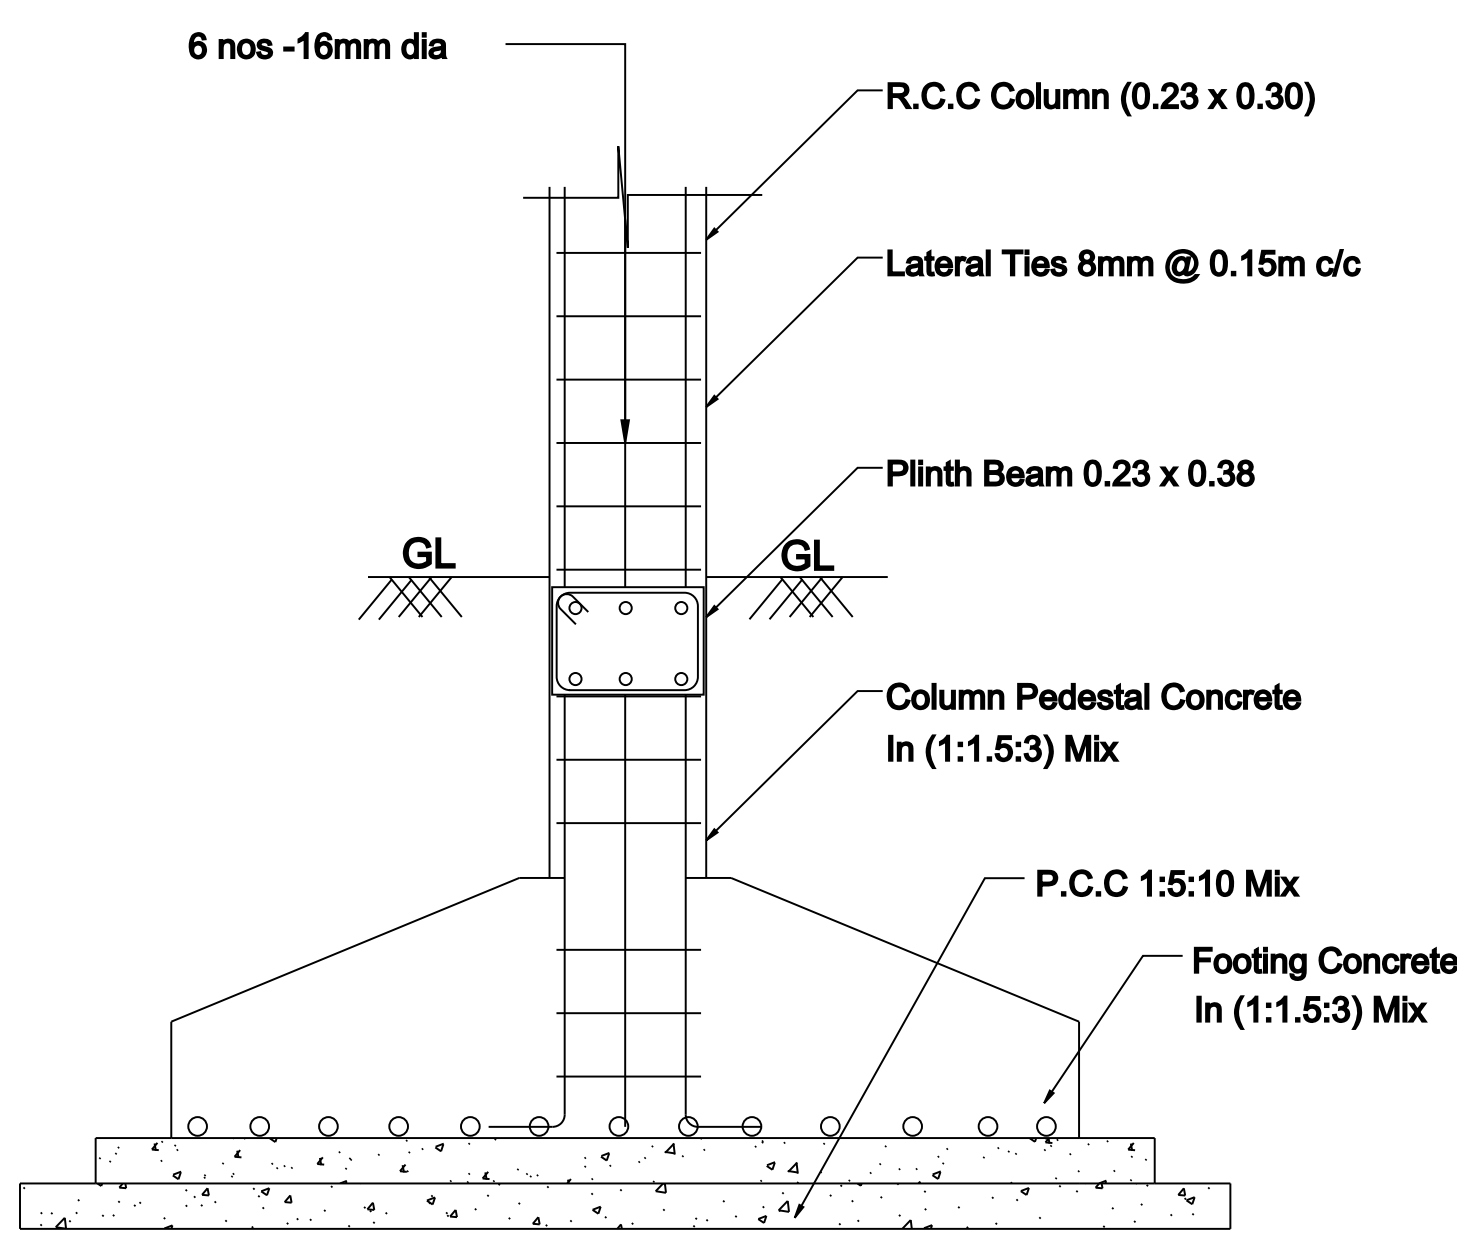

COLUMN FOOTING DETAILS

KEY PLAN

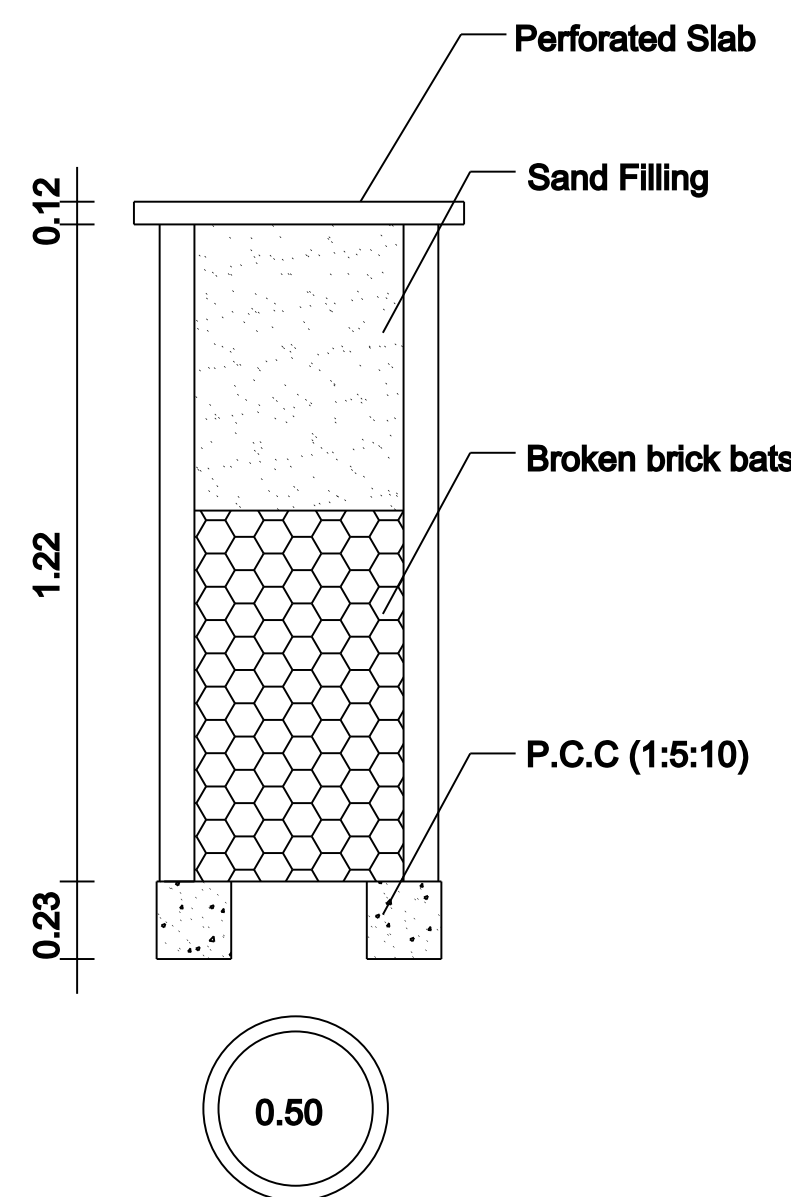


RAIN WATER COLLECTION WELL

NOTE:
Rain Water to be Provided
Waste Water To Garden
Percolation Pit to be Provided
Solar System to be Provided

FLOOR SPACE INDEX
FSI= 35.25/121.56=0.28<2

PLOT COVERAGE
PC= 35.25/121.56=28.99 %

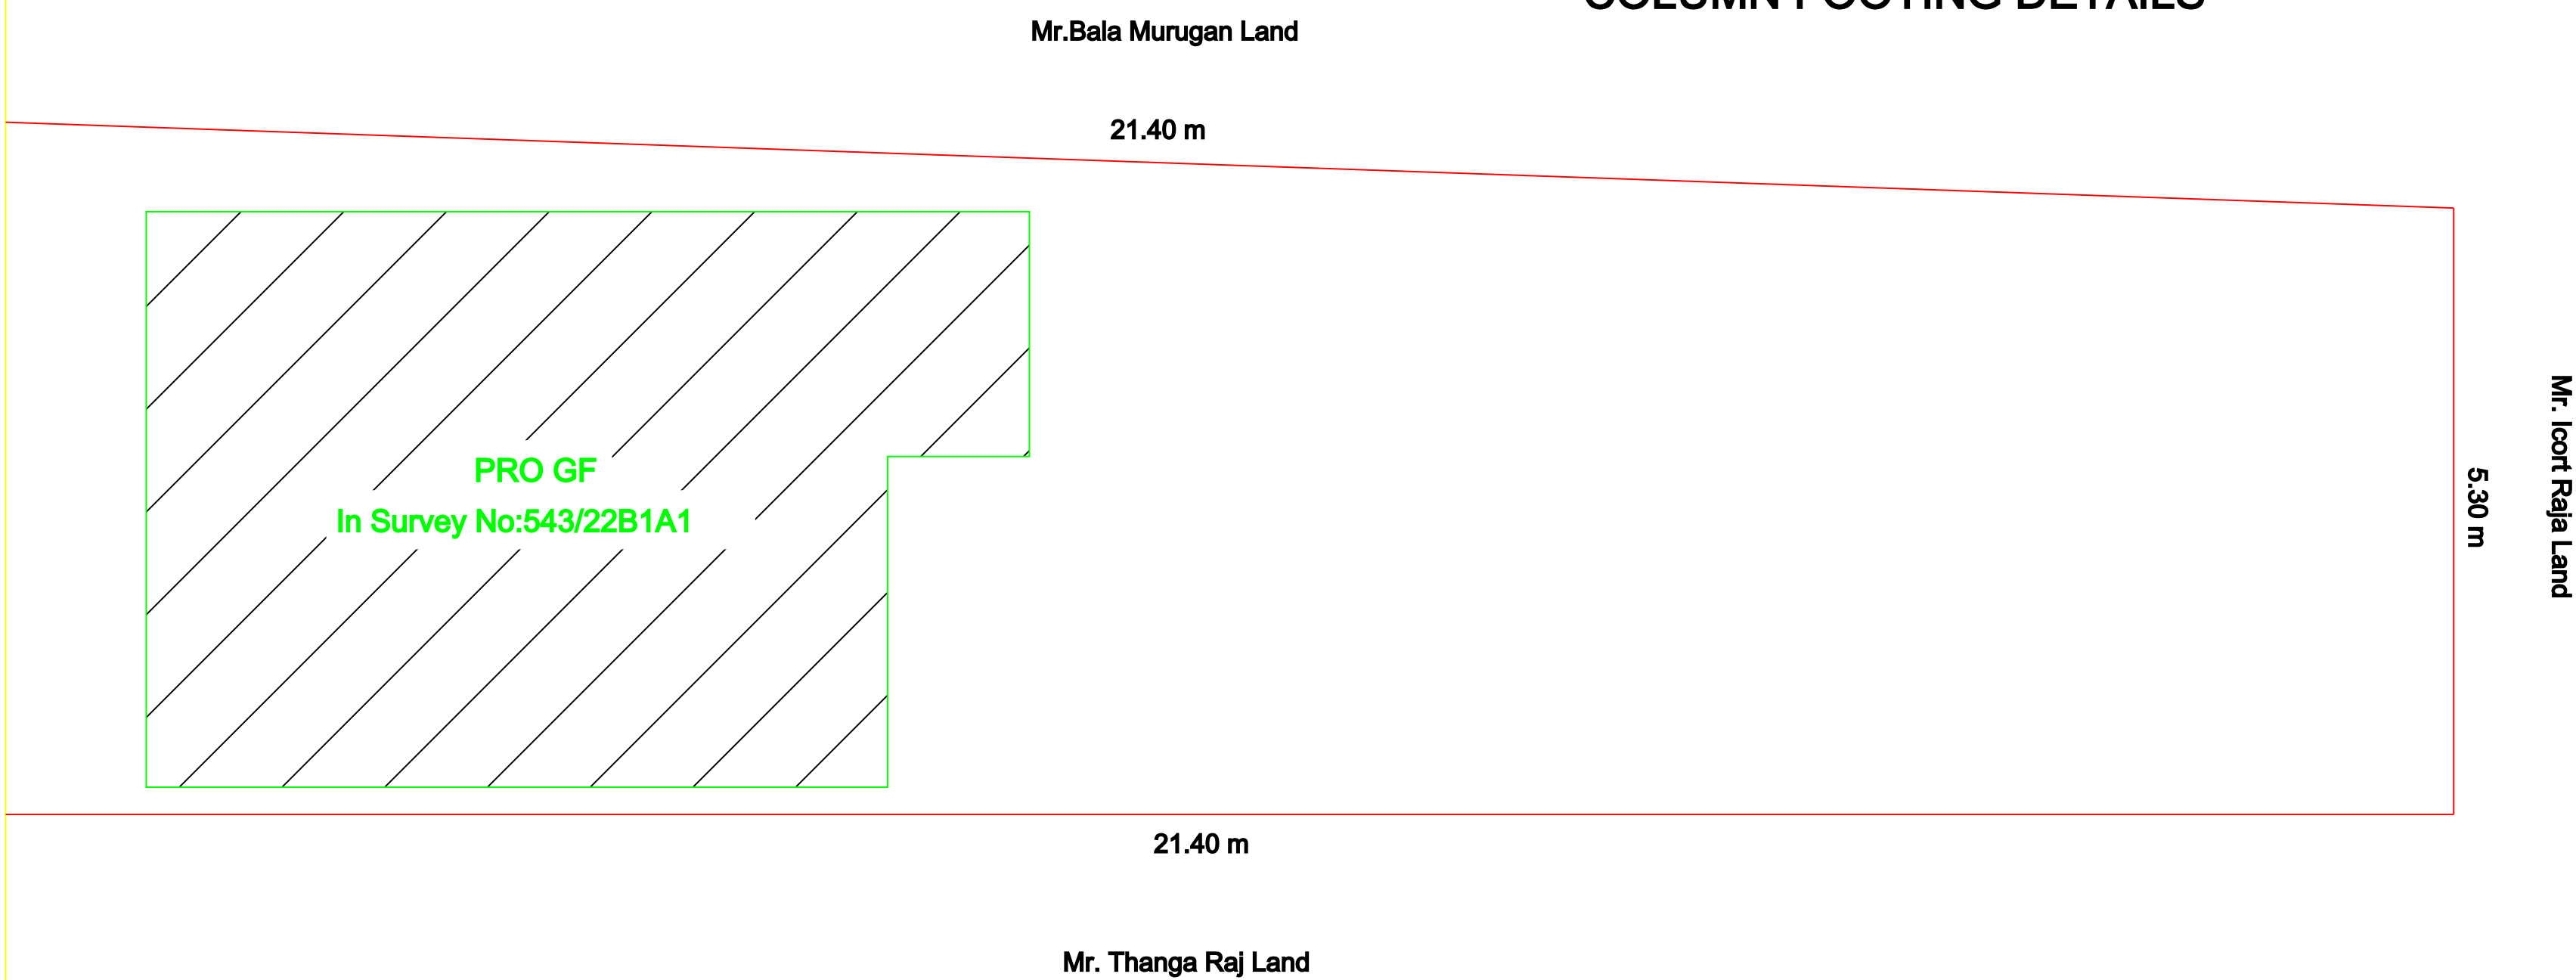

SITE PLAN (1:100)

AREA STATEMENT

	Site Area(3.00 Cents)	121.56 Sq.m	1308.52 Sq.ft
	Pro Ground Floor Area	35.25 Sq.m	379.43 Sq.ft
	Open Area	86.31 Sq.m	929.09 Sq.ft

JOINERY DETAILS

D	DOOR	1.00	2.13
D1	DOOR	0.76	2.13
W	WINDOW	1.06	1.37
KW	KITCHEN WINDOW	1.22	1.06
V	VENTILATOR	0.91	0.61

OFFICE USE

APPLICANT

Er.R.MOHAMED IRSATH

Register Engineer in DRDA-UDY/2022/05

Municipality Engineer -139/LS/2022/00002058

Licensed Surveyor & Consulting Engineer

Build-Up Construction,

18, Periya Street, Udangudi-628203

Cell:9750953055, 9629271761

REGISTERED ENGINEER

ALL DIMENSIONS ARE IN METER (Scale:1:100)