



PLAN SHOWING THE PROPOSED CONSTRUCTION OF RCC ROOF COMMERCIAL BUILDING IN GROUND FLOOR , IN S.NO: 497 / 8B , WARD NO : 04 , NESAPURAM ,
VENKATARAMANUJAPURAM VILLAGE PANCHAYAT , TIRUCHENDUR TALUK , THOOTHUKUDI DISTRICT.


NAME OF APPLICANT :- Mr.G.CHINNADURAI , S/O.GOPALAKRISHNAN.

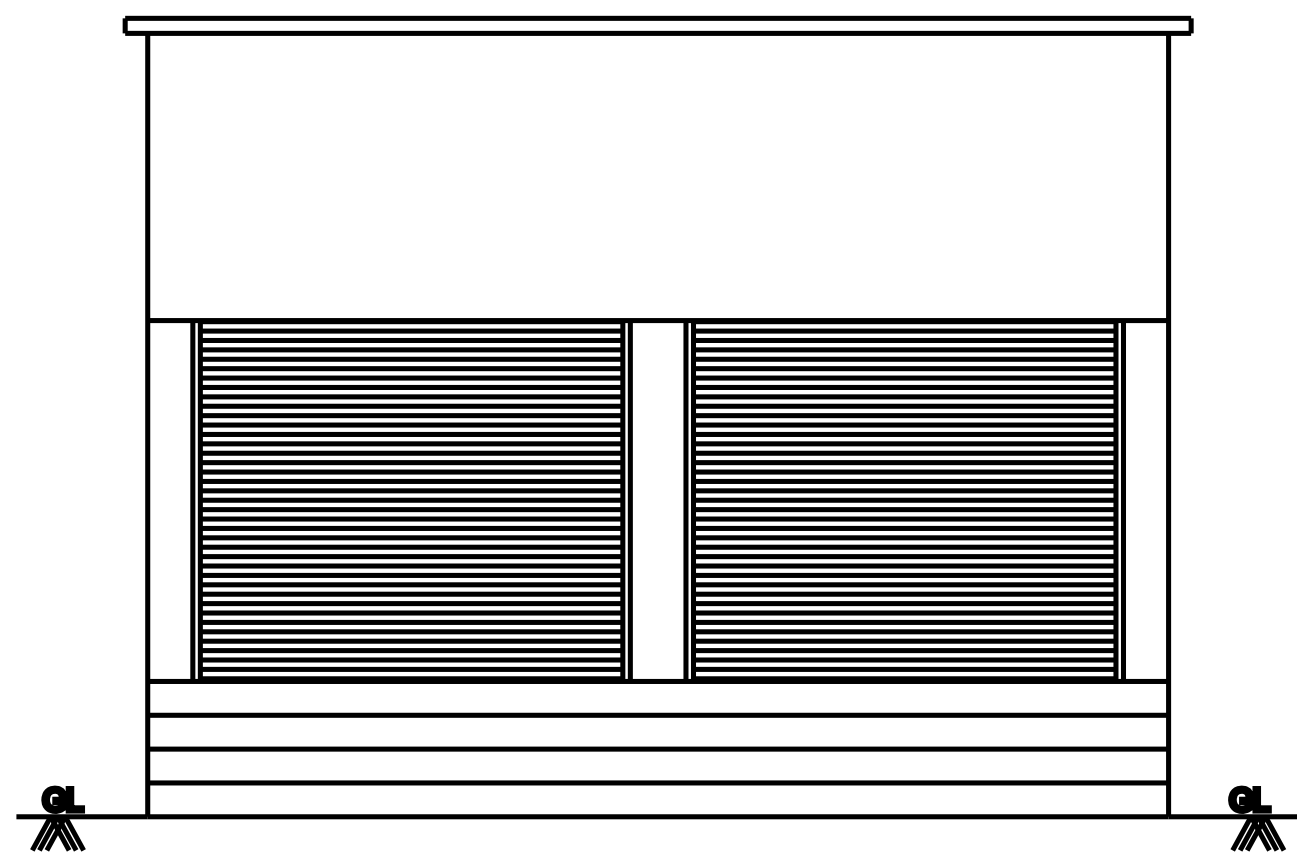


ELEVATION

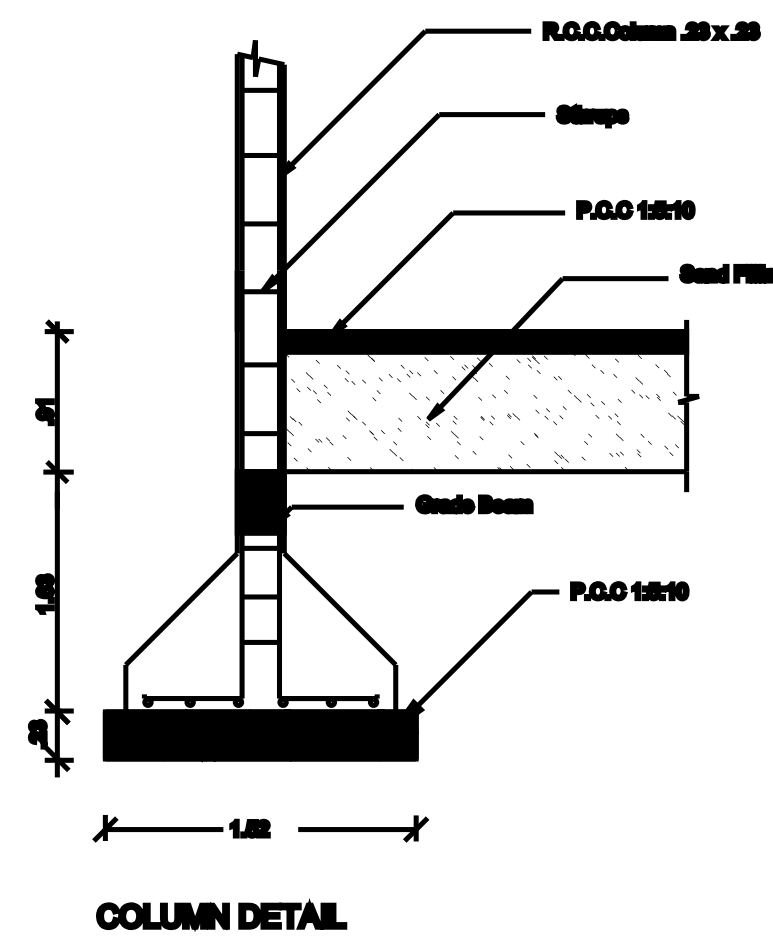


COLUMN DETAIL

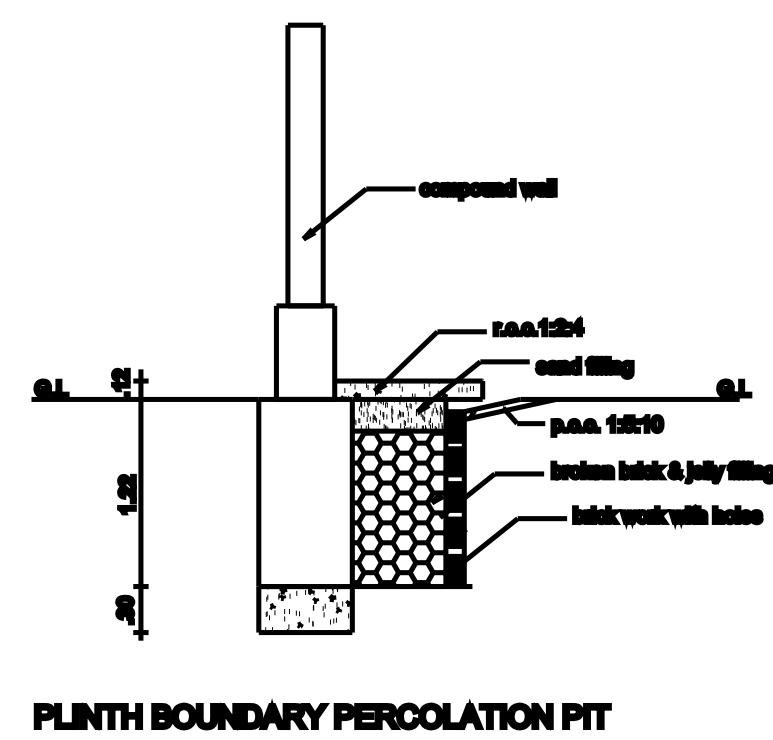


PLINTH BOUNDARY PERCOLATION PIT

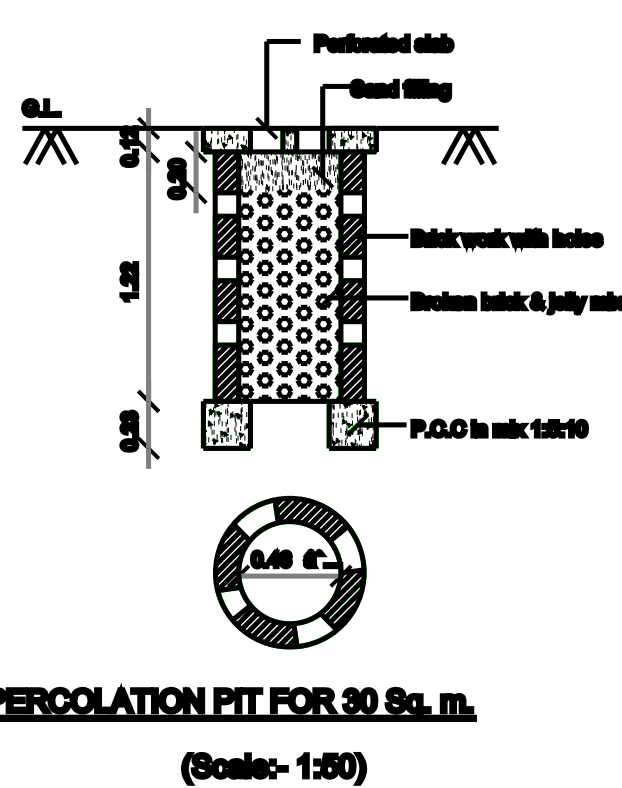


PERCOLATION PIT FOR 30 Sq. ft.
(Scale:- 1:50)

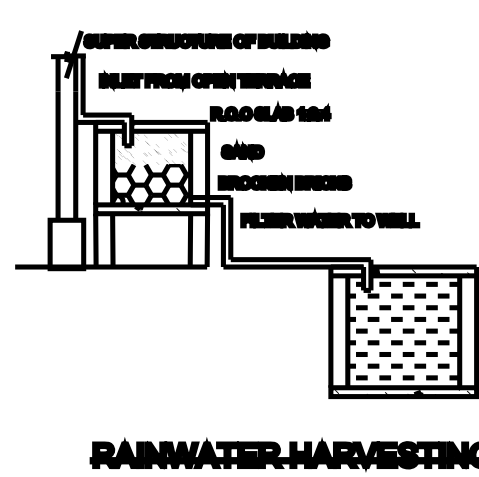



RAINWATER HARVESTING

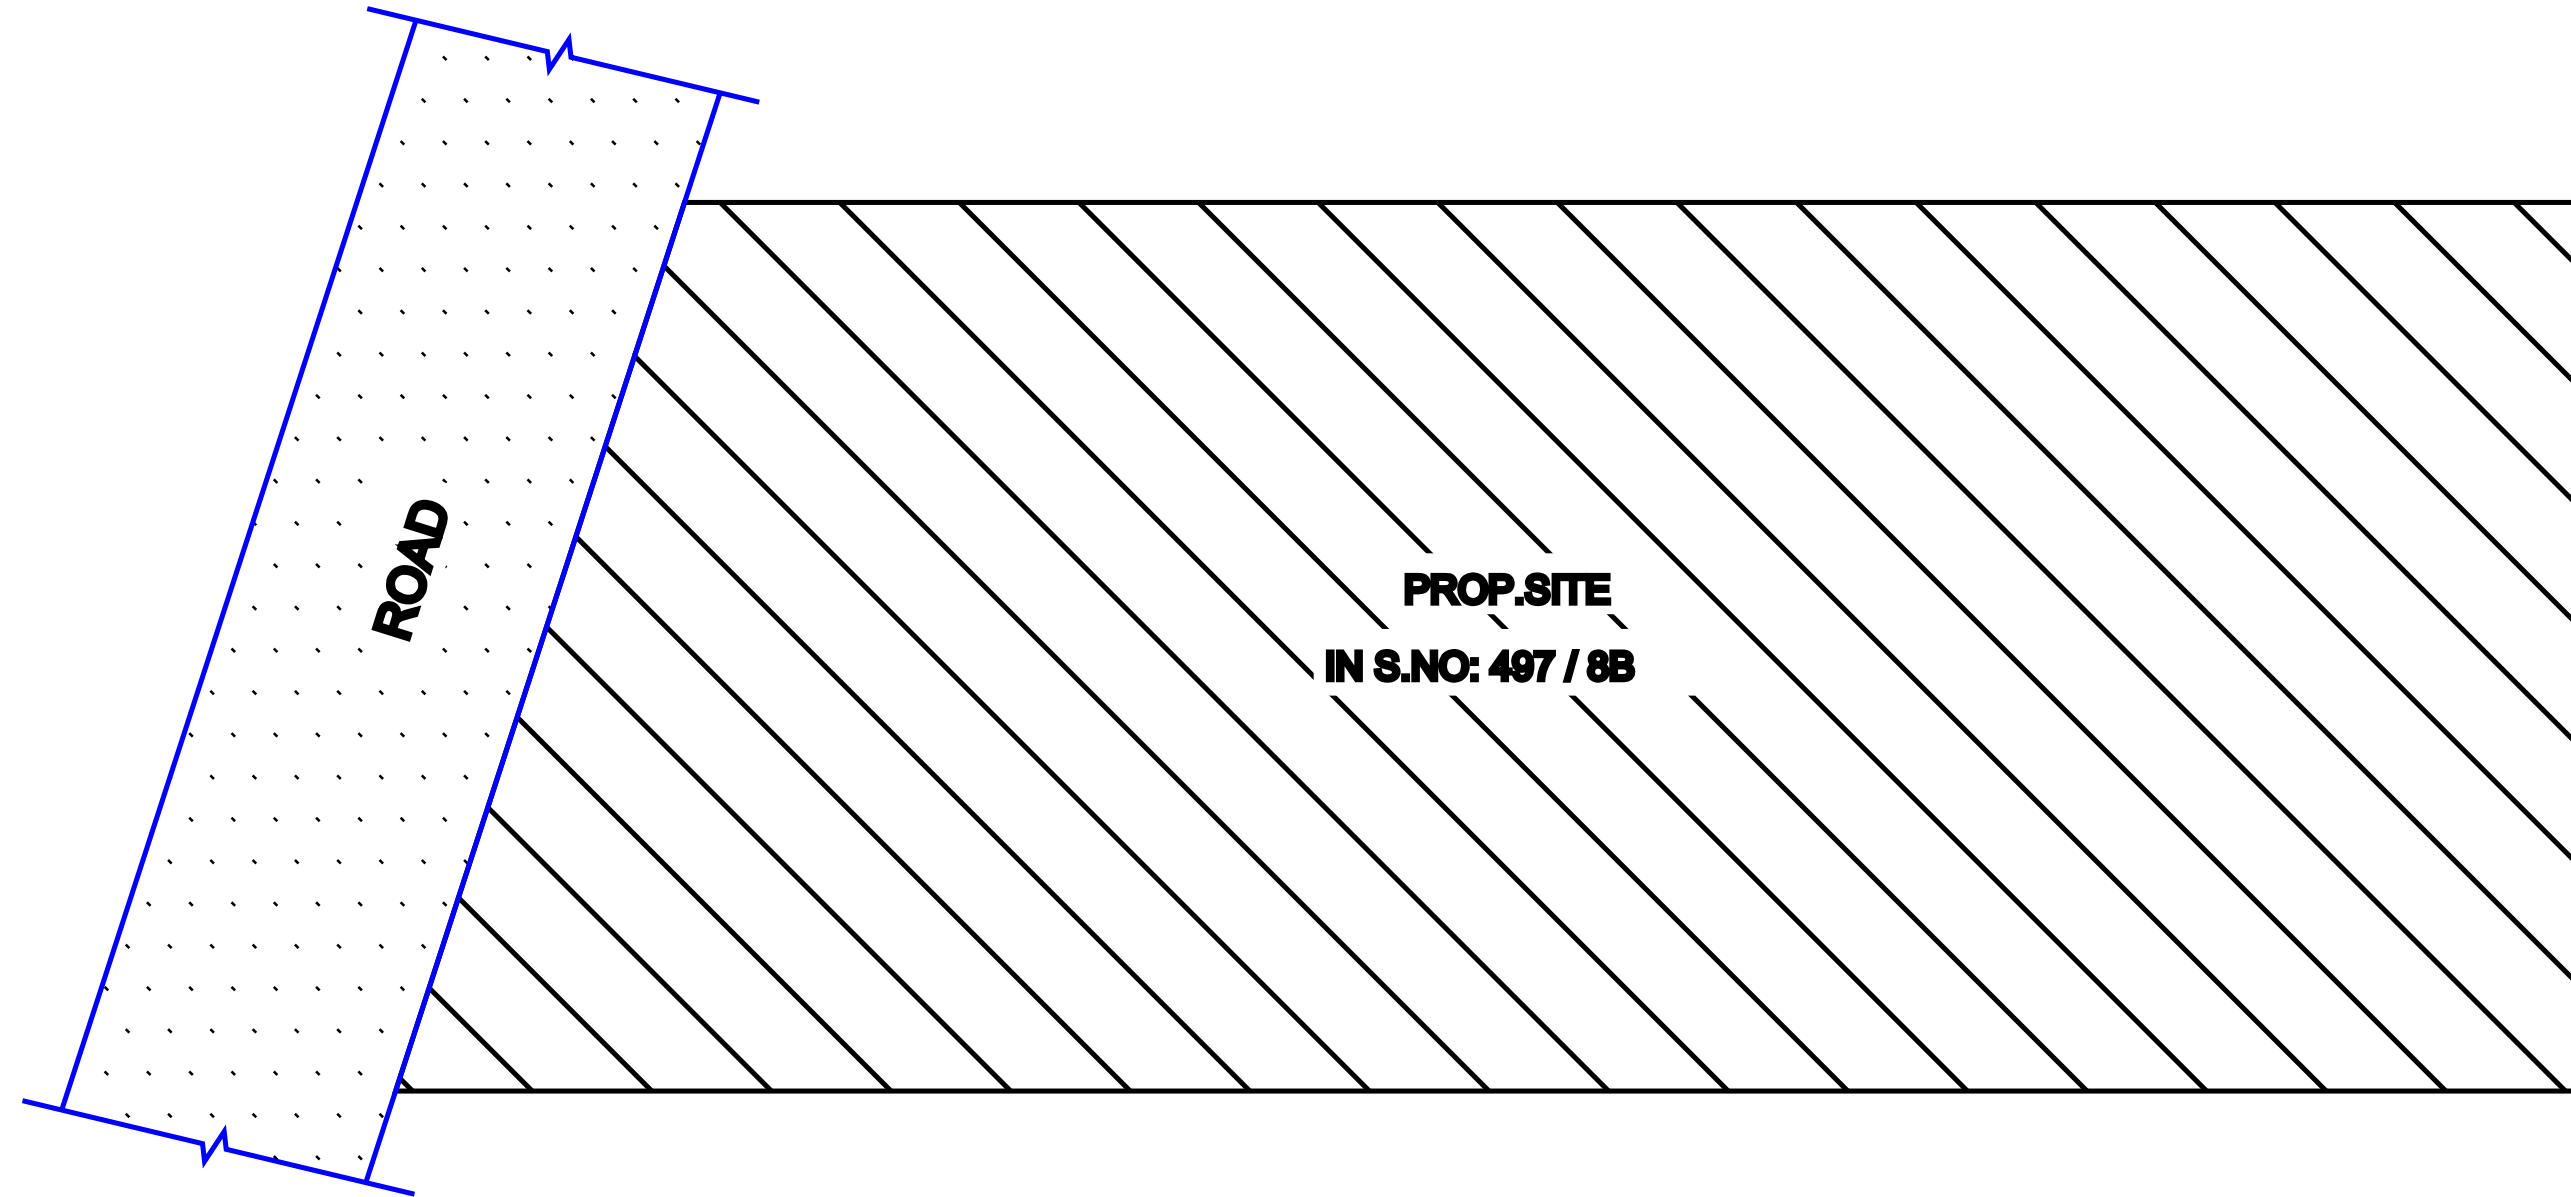

KEY PLAN (N.T.S.)

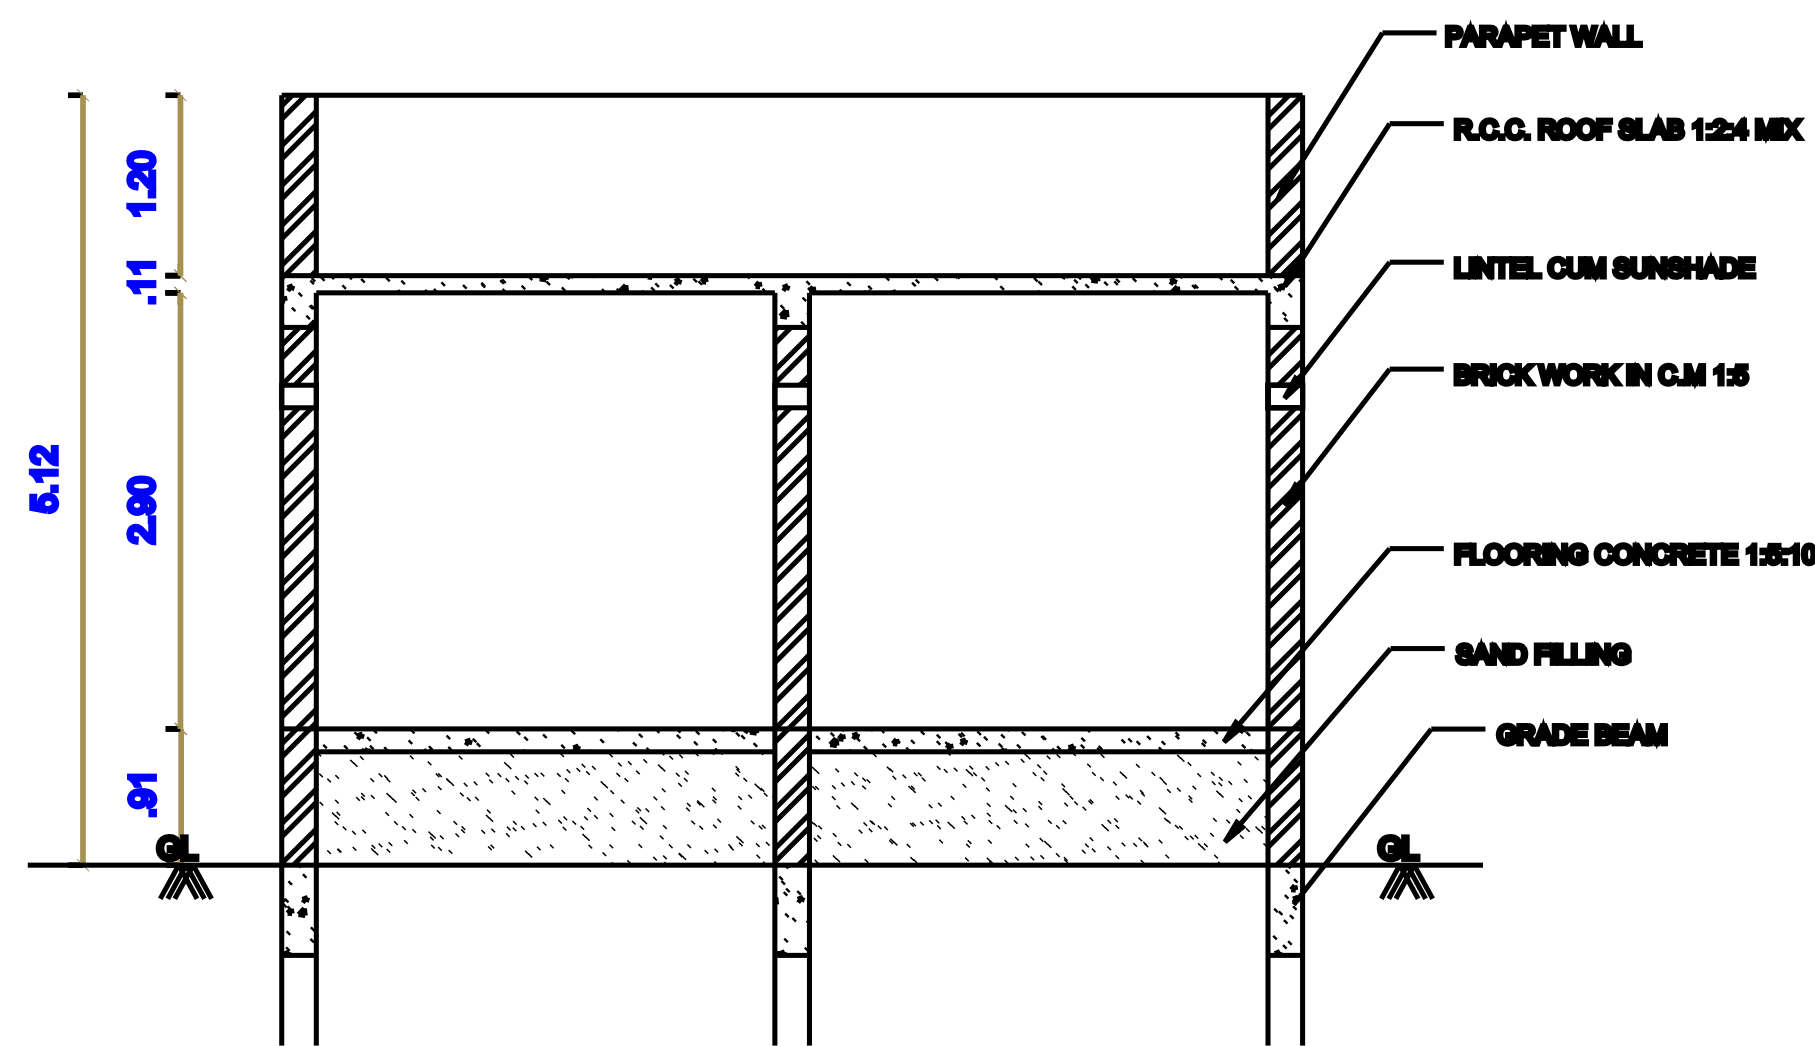


SECTION-AA

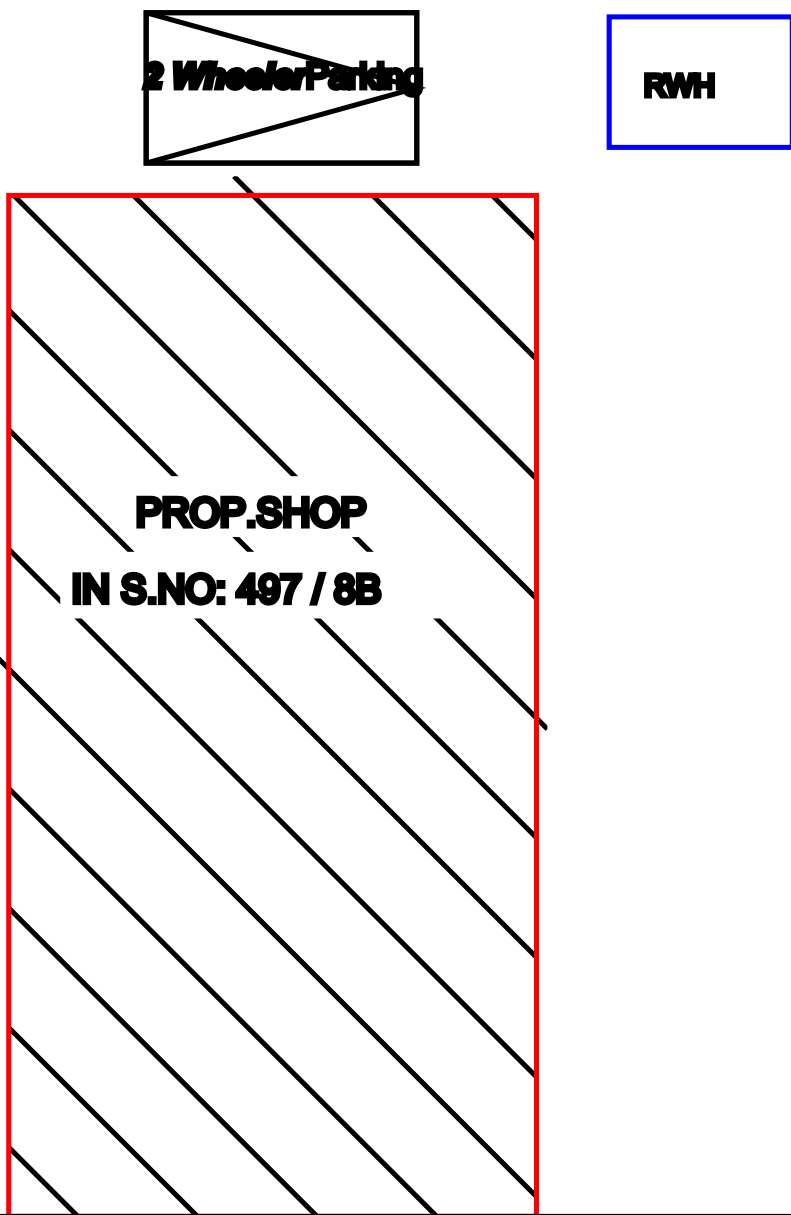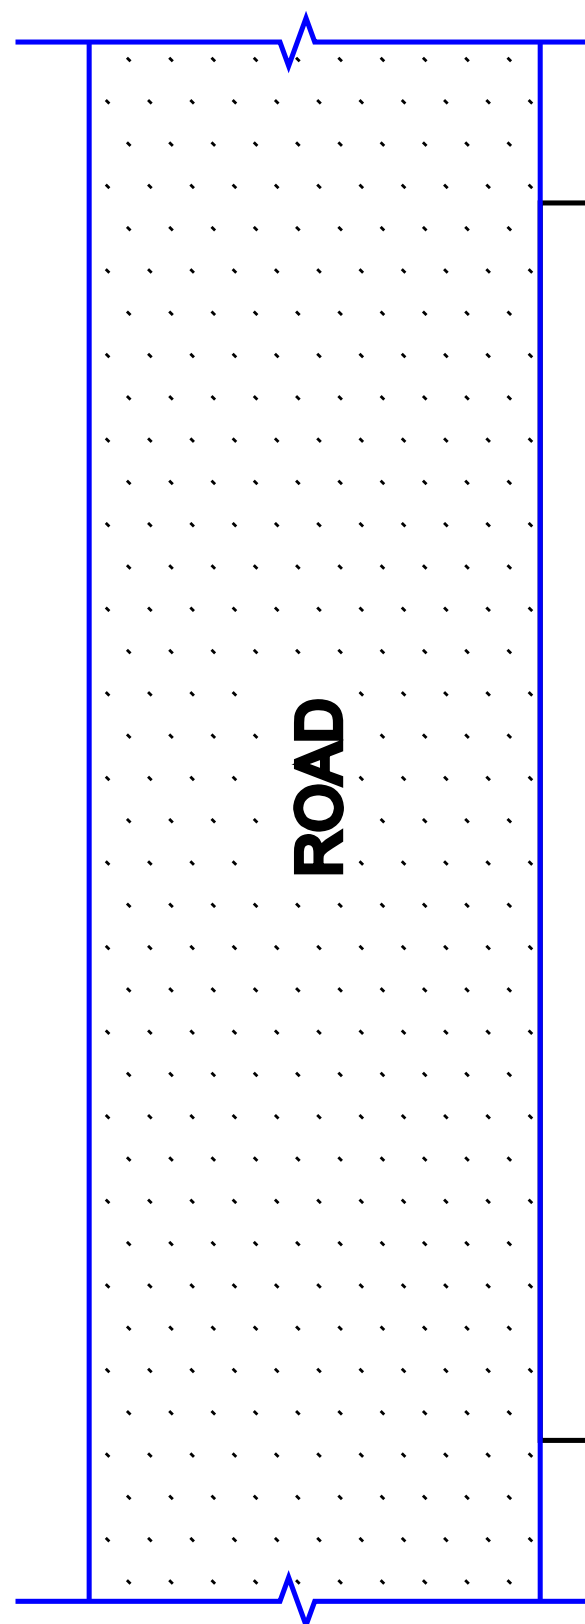

MAHALINGAM LAND


ANANDAPANDI LAND

GANESAN NADAR LAND

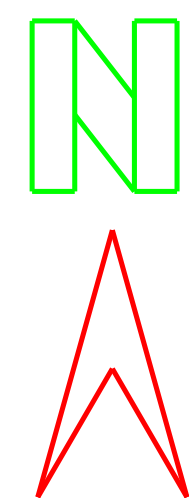


SEPTIC
TANK


SITE PLAN
SCALE 1:100

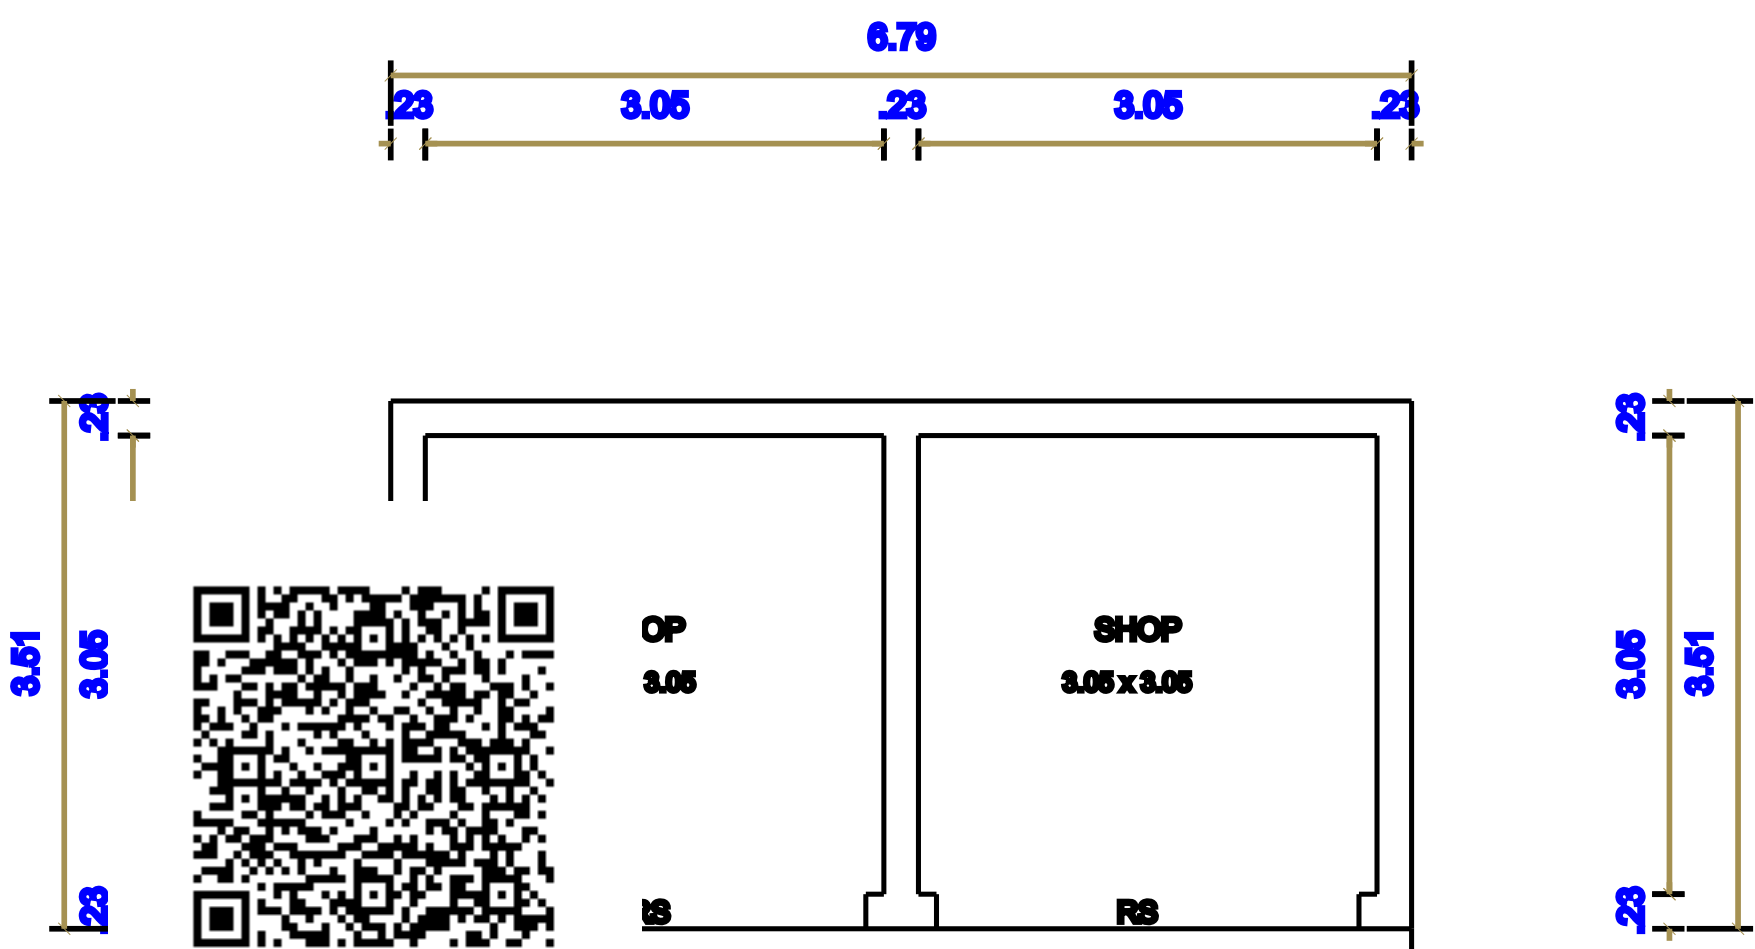


PLAN

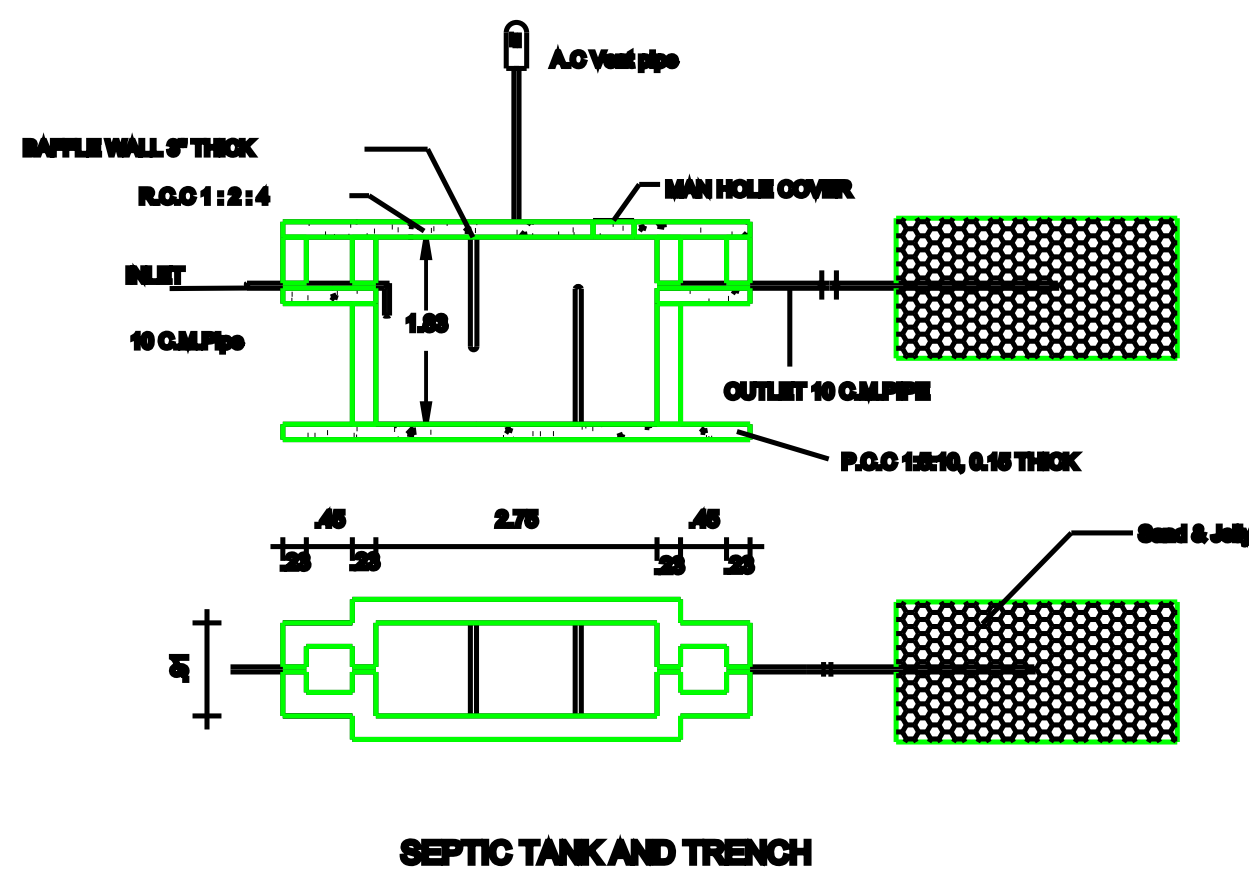


SEPTIC TANK AND TRENCH

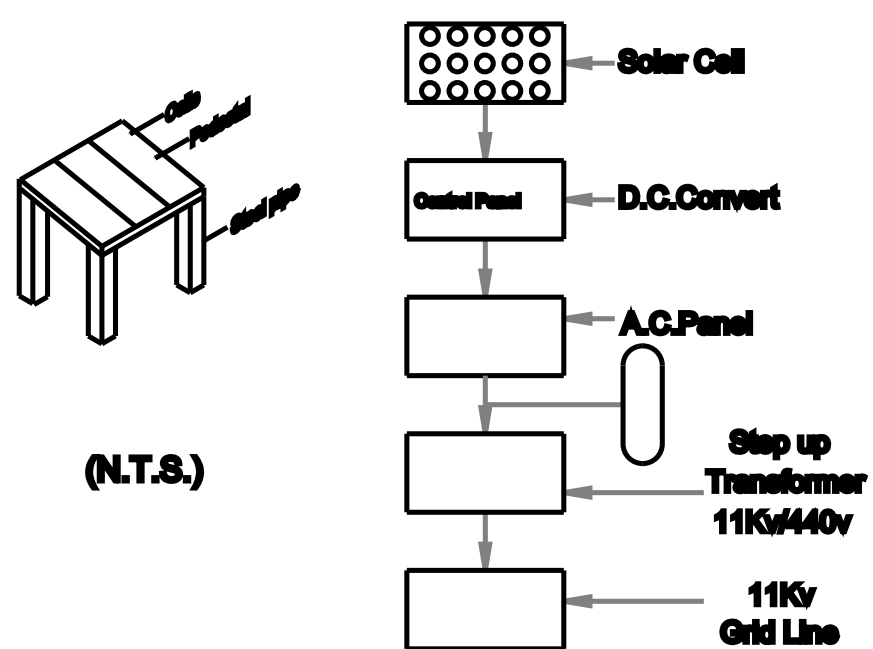

SOLAR SYSTEM FLOW DIAGRAM

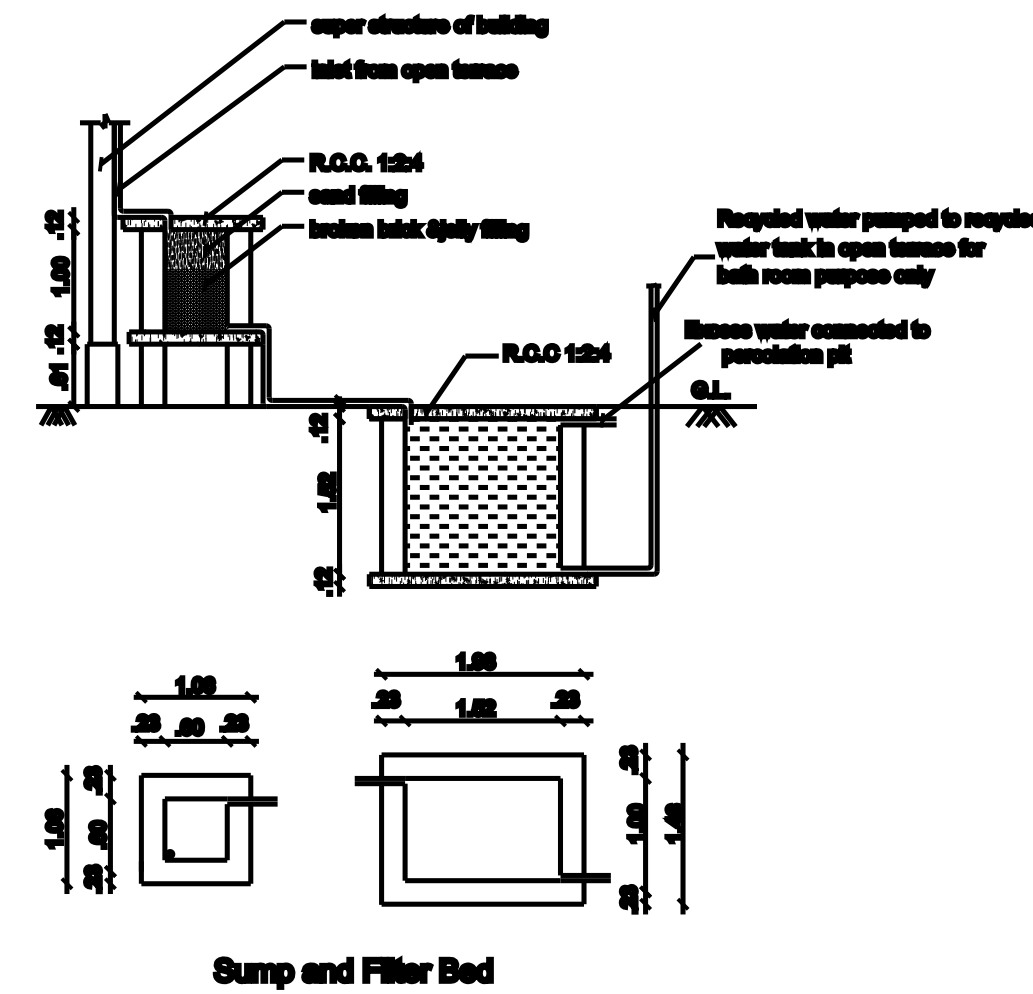

Sump and Filter Bed

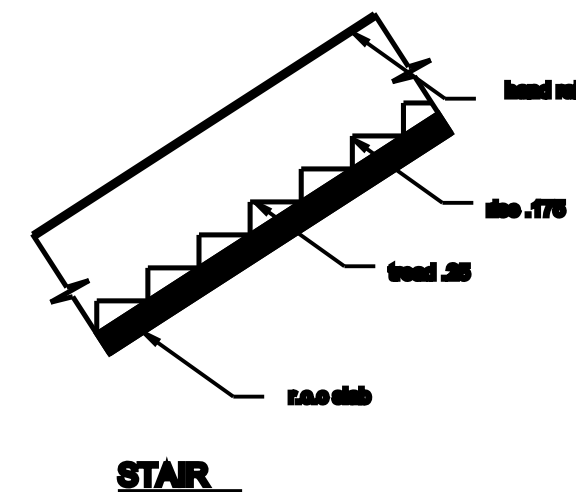

STAIR

OFFICE USE

AREA DETAILS

REF.	DESCRIPTION	SQ.M	SQ.FT
□	SITE AREA	323.75	3485
□	PRO. PLINTH AREA IN G.F	23.83	257
□	OPEN AREA	299.92	3228
□	F.S.I		0.07

JOINERY DETAILS

RS	Rolling shutter	3.00 x 2.40
MD	Door	1.00 x 2.10
D1	Door	0.91 x 2.10
D2	Door	0.75 x 2.10
W	Window	1.50 x 1.50
W1	Window	1.20 x 1.50
V	Ventilator	0.80 x 0.60

ALL DIMENSIONS ARE IN METRE, SCALE 1:100

Note:

Waste Water Used for Garden
Rain Water harvesting Details Provided
Rain water harvesting tank to be provided

APPLICANT

Er.T.Anandaraj.M.Tech.,
Consulting Civil Engineer &
Licensed Building Surveyor
ANAND CONSTRUCTIONS
82,INDIRA MARKET
THISAIYANVILAI-627657
PH 272231 CELL. 98425 18066

ENGINEER