

PLAN SHOWING THE PROPOSED CONSTRUCTION OF A DWELLING HOUSE WITH SURVEY NO:360/2J, PATTA:2299, WARD NO:02, PERIYAKANDANVADALI,

SIRUNADARKUDIRUPPU VILLAGE AND PANCHAYATH, UDANGUDI PANCHAYATH UNION,TIRUCHENDUR TALUK,THOOTHUKUDI DISTRICT.

NAME OF THE APPLICANT: Mrs. JAYALAKSHMI (W/O) Mr. JAYARAJ

FLOOR SPACE INDEX



FSI= 24.83/46.00=0.53<2

PLOT COVERAGE


PC= 24.83/46.00=53.97 %

NOTE:


Rain Water to be Provided
Waste Water To Garden
Percolation Pit to be Provided
Solar System to be Provided

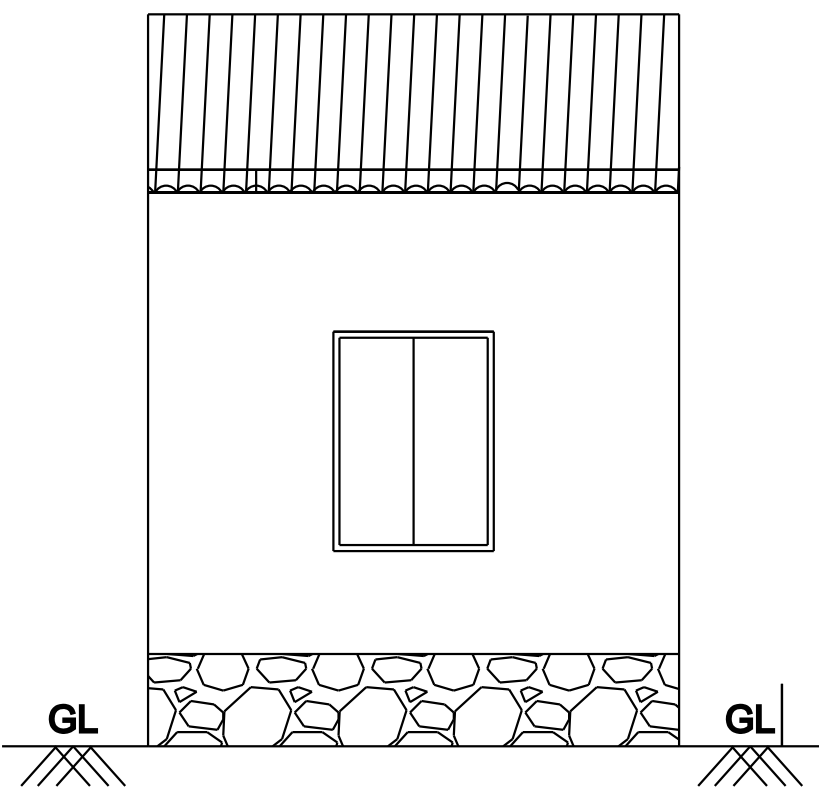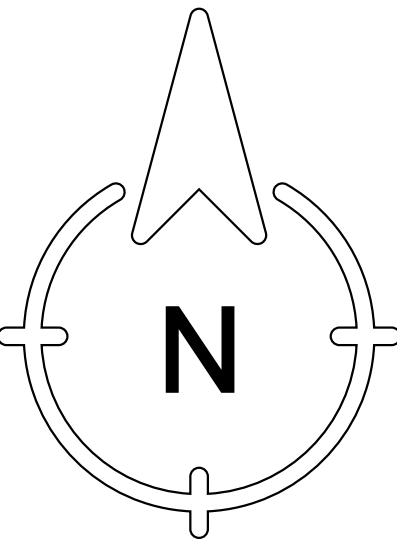


FRONT ELEVATION

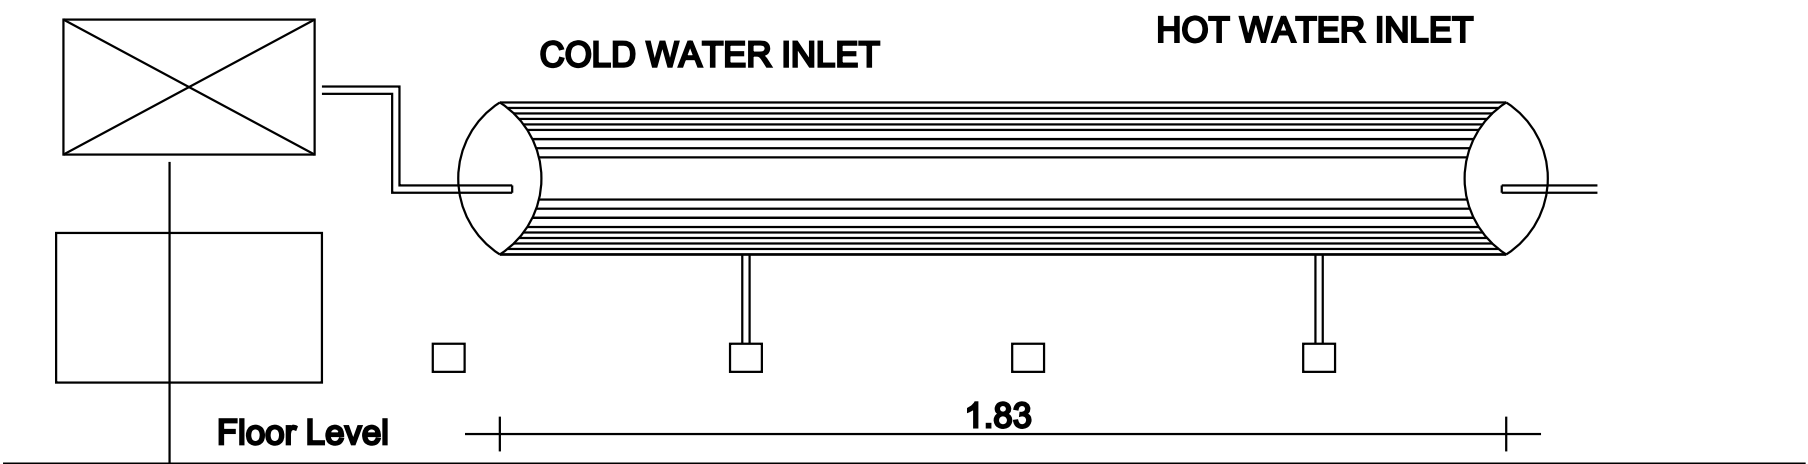


DETAILS OF SOLAR HOT WATER SYSTEM

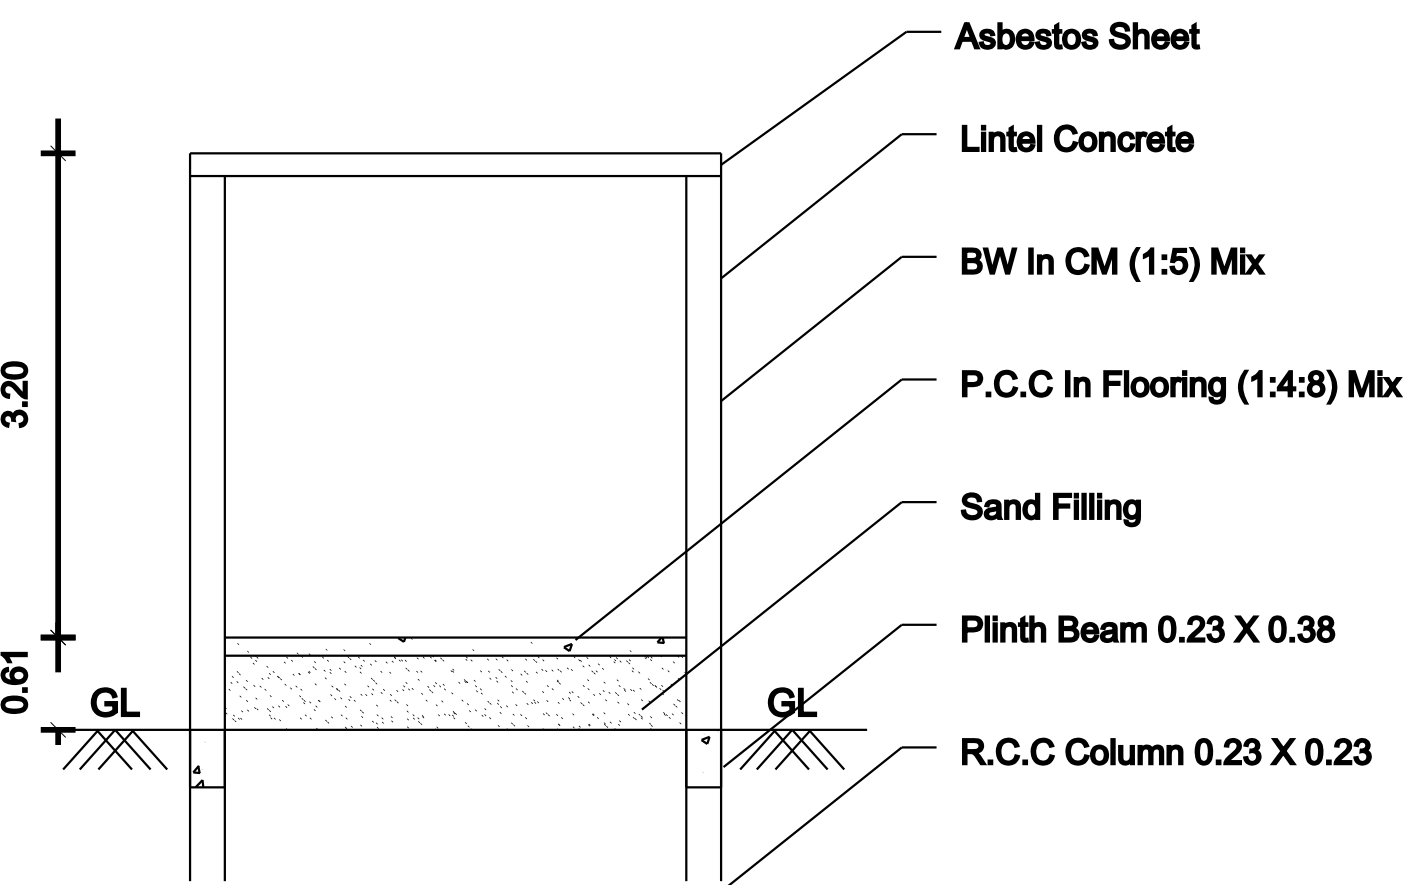


SECTION ON 'AB'

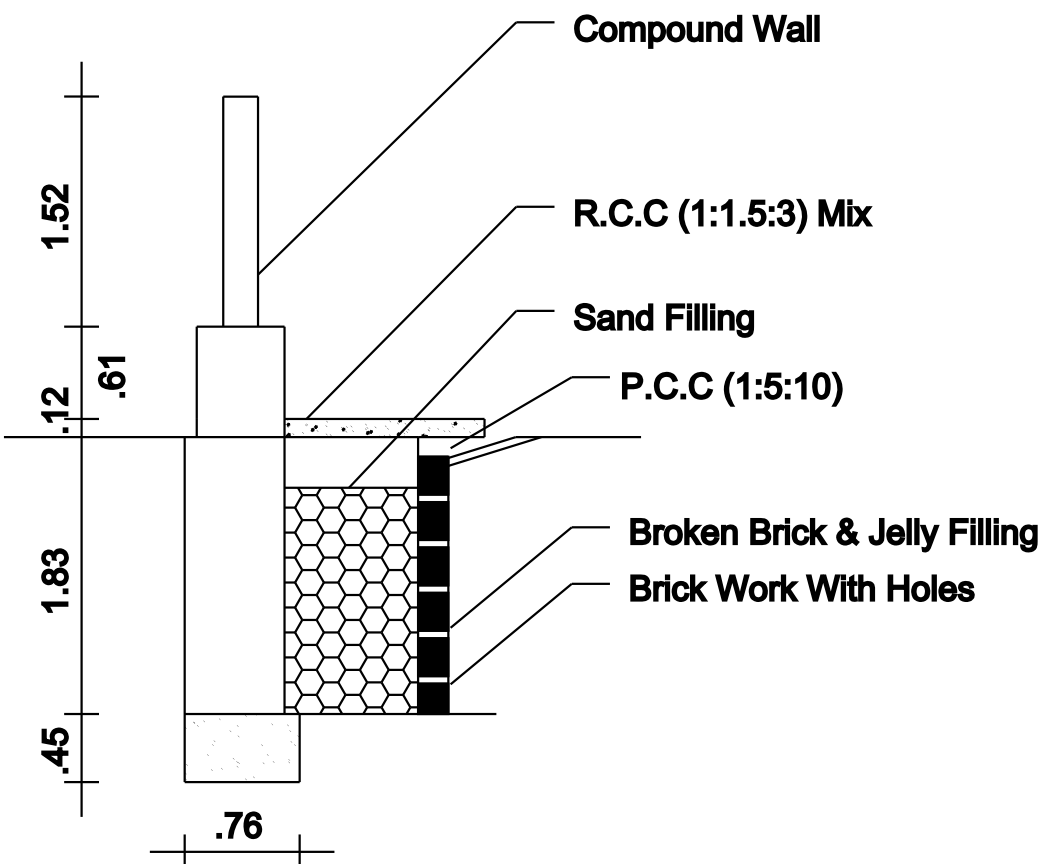


RAIN WATER HARVEST DETAILS

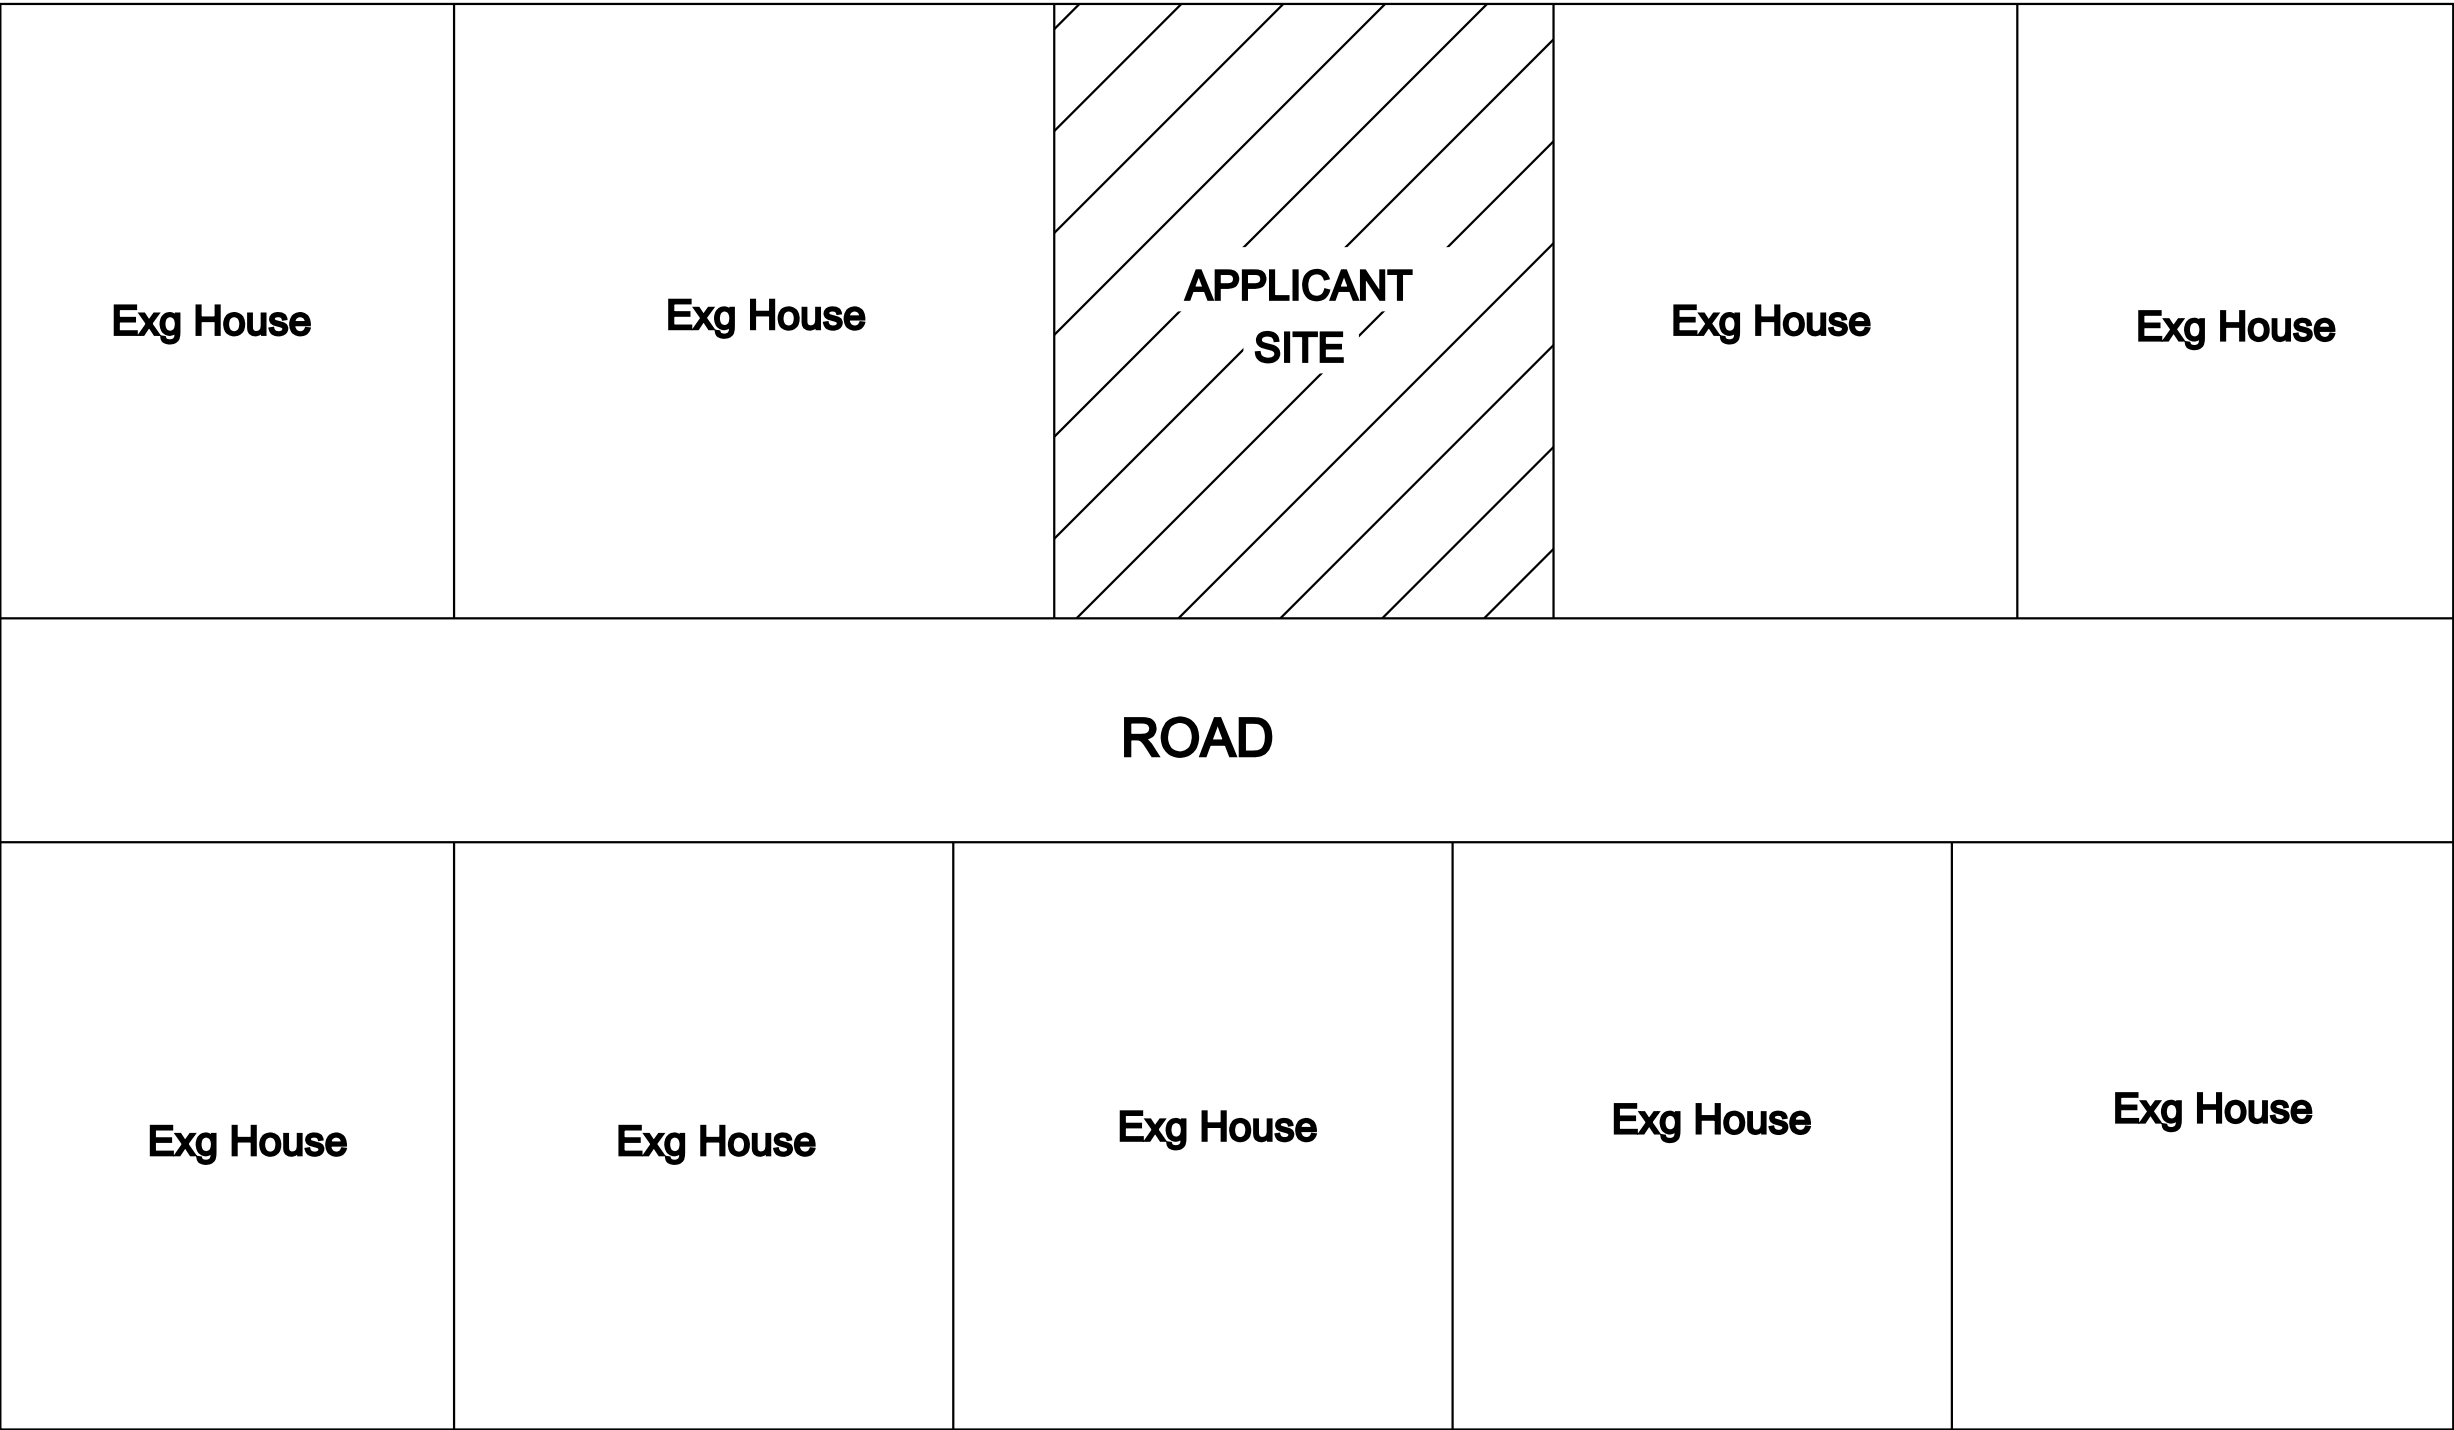


KEY PLAN

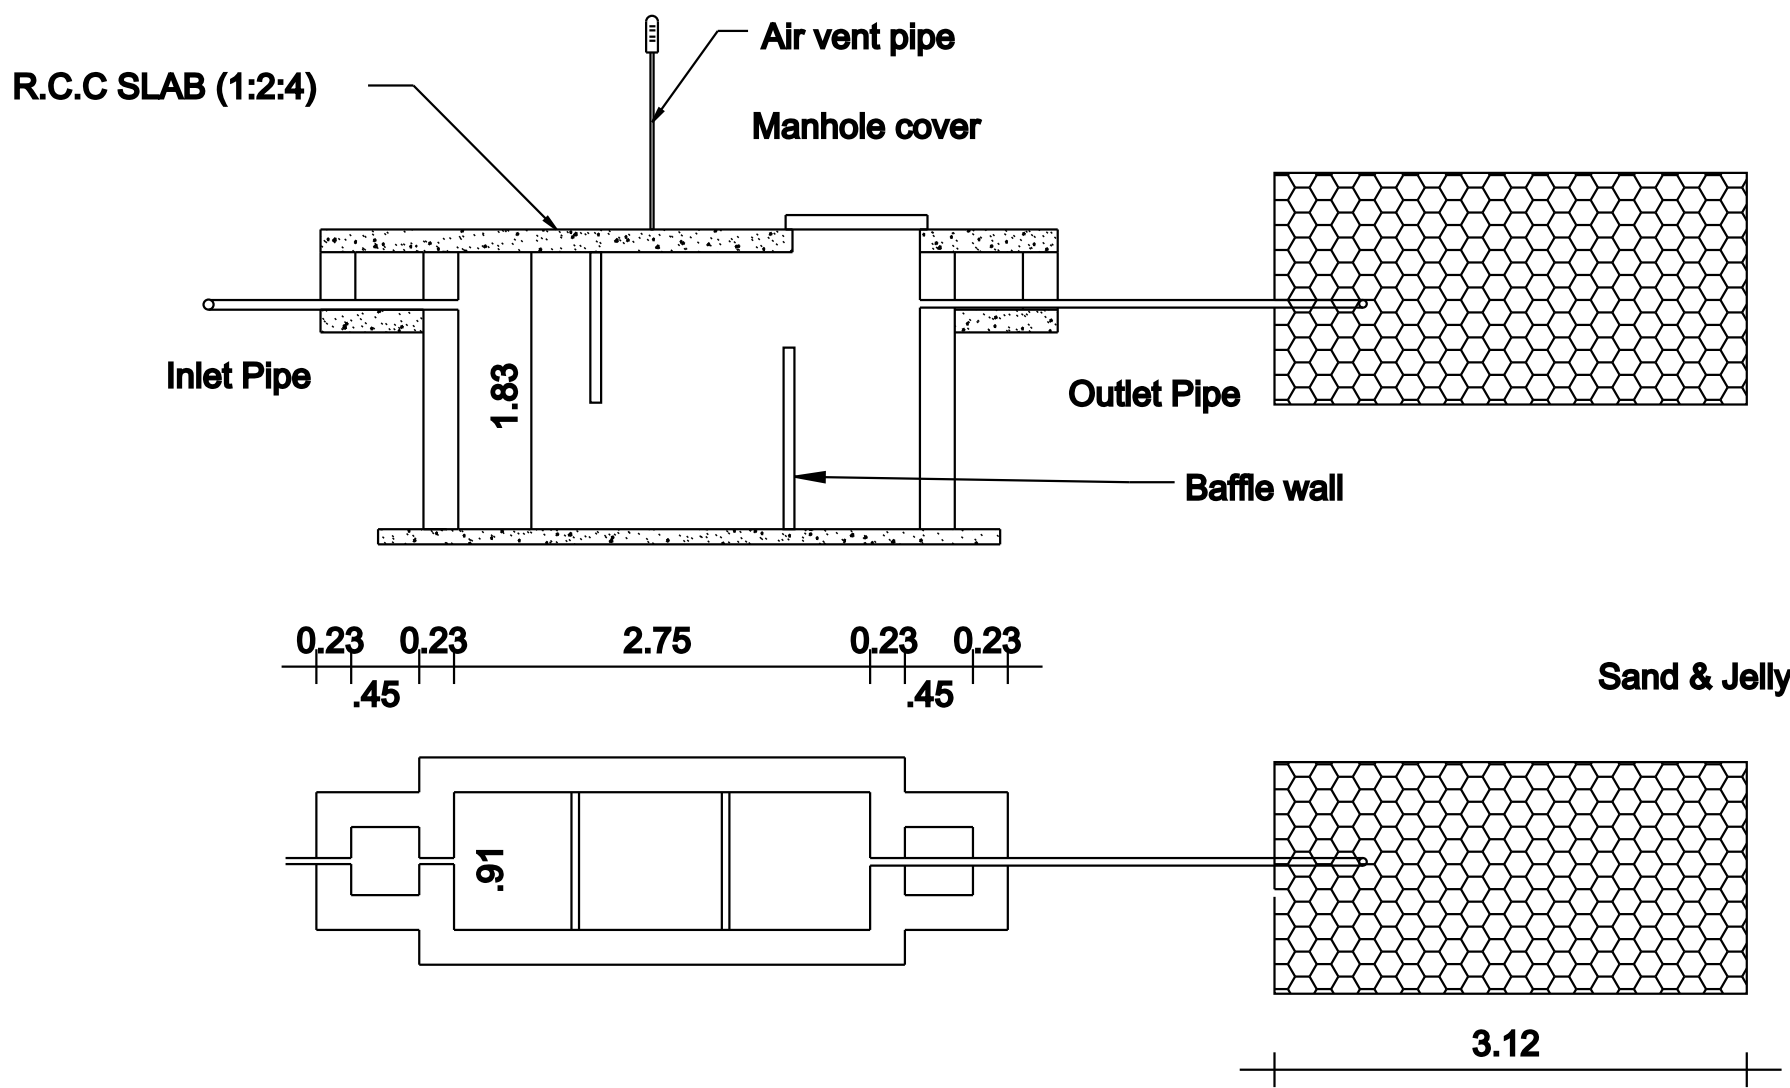


SEPTIC TANK & TRENCH

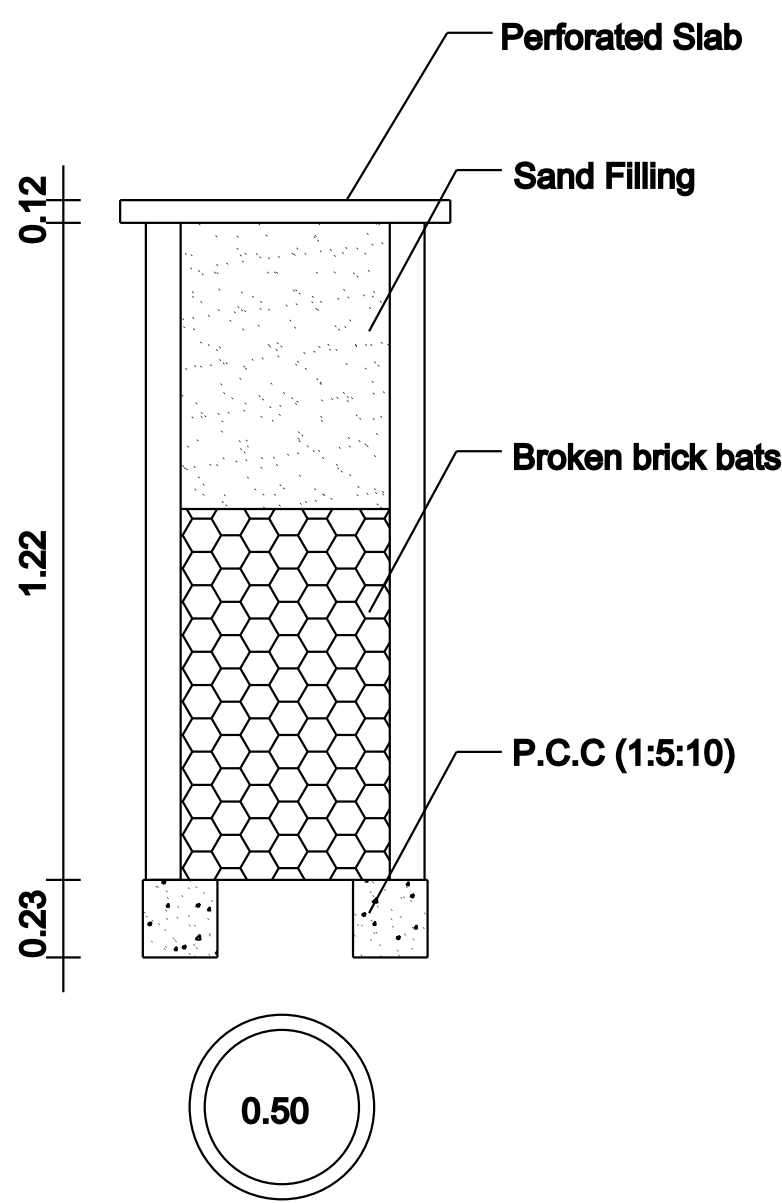


RAIN WATER COLLECTION WELL

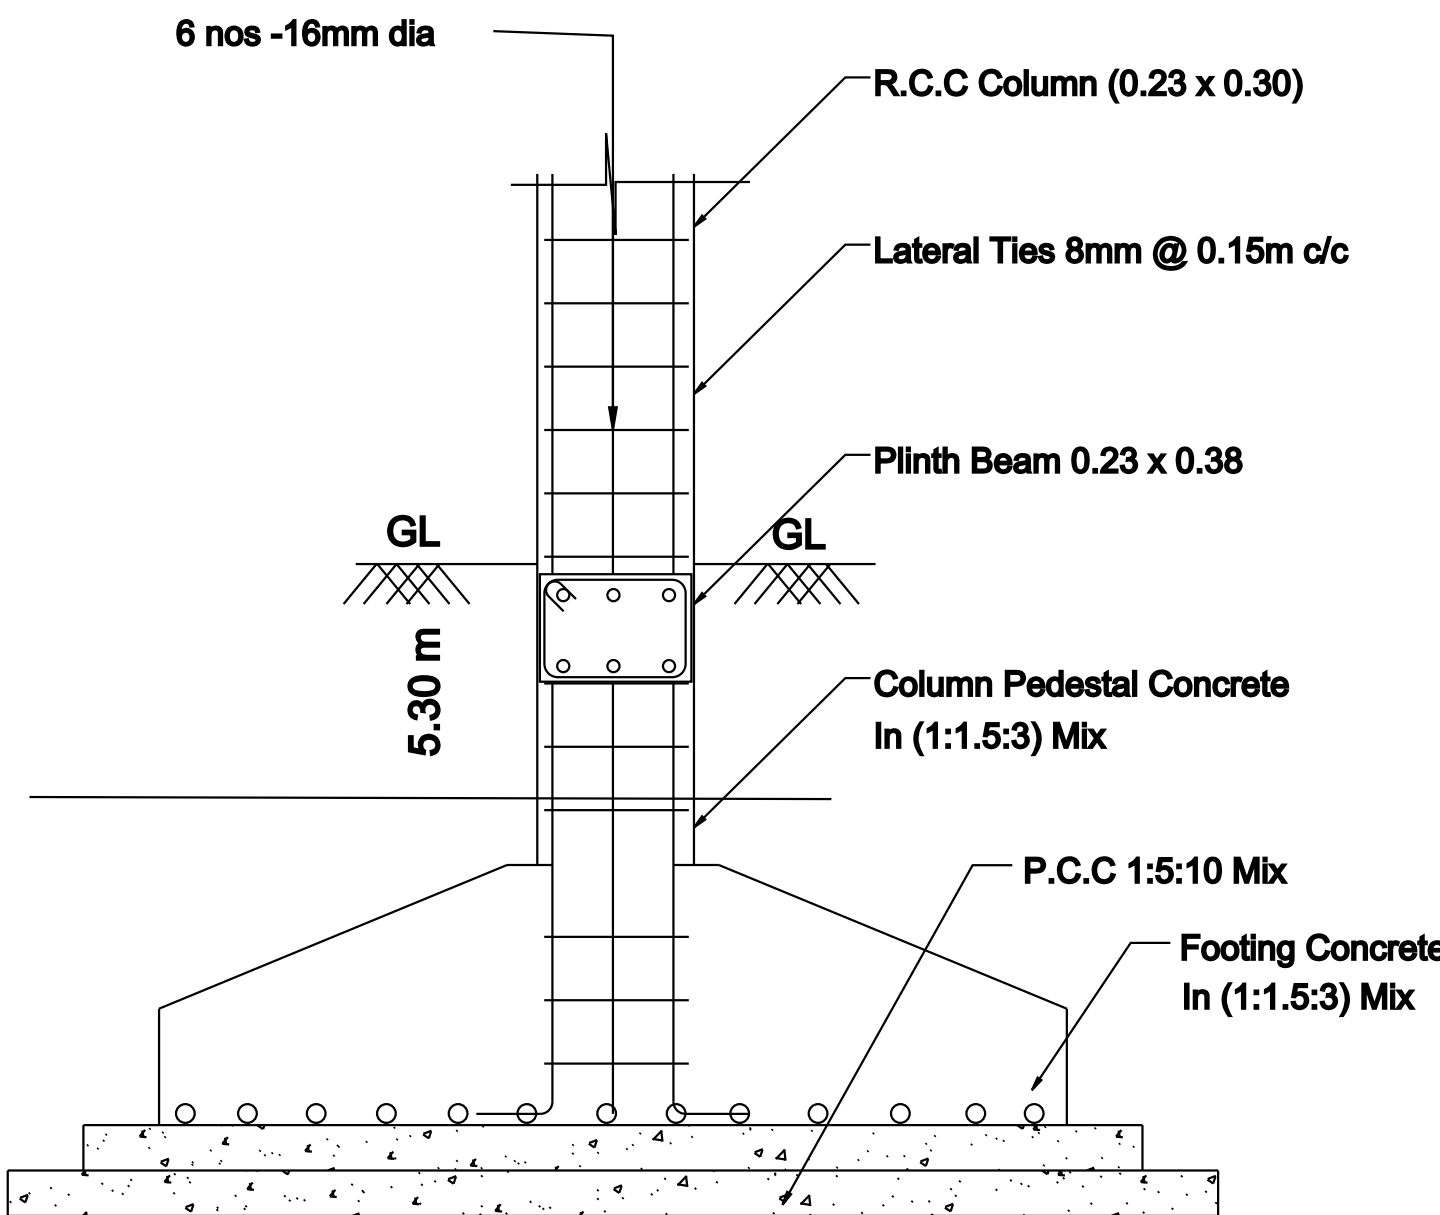

COLUMN FOOTING DETAILS

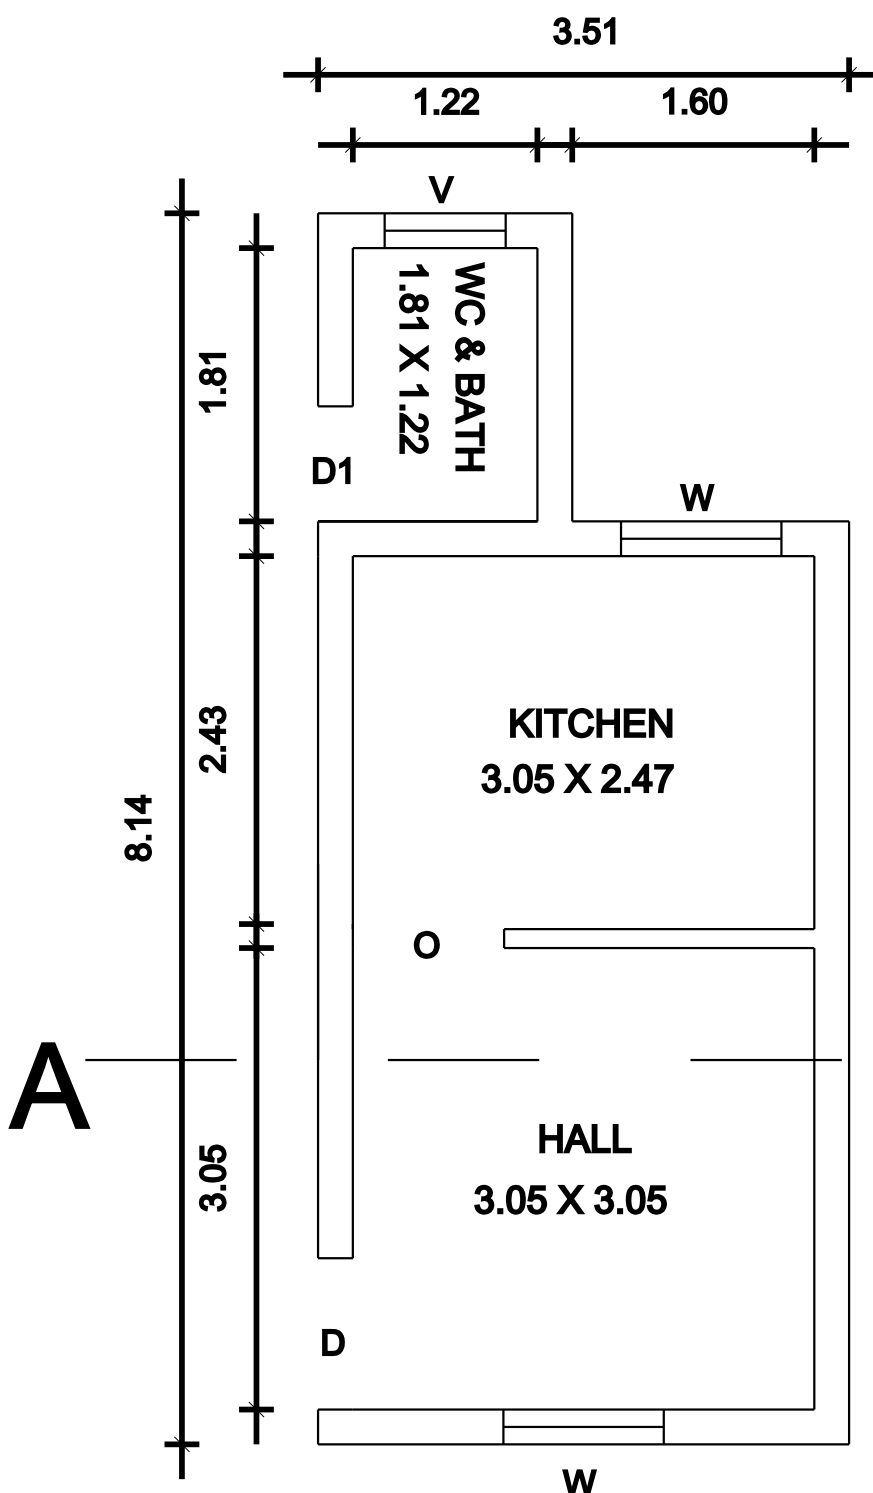

GROUND FLOOR PLAN

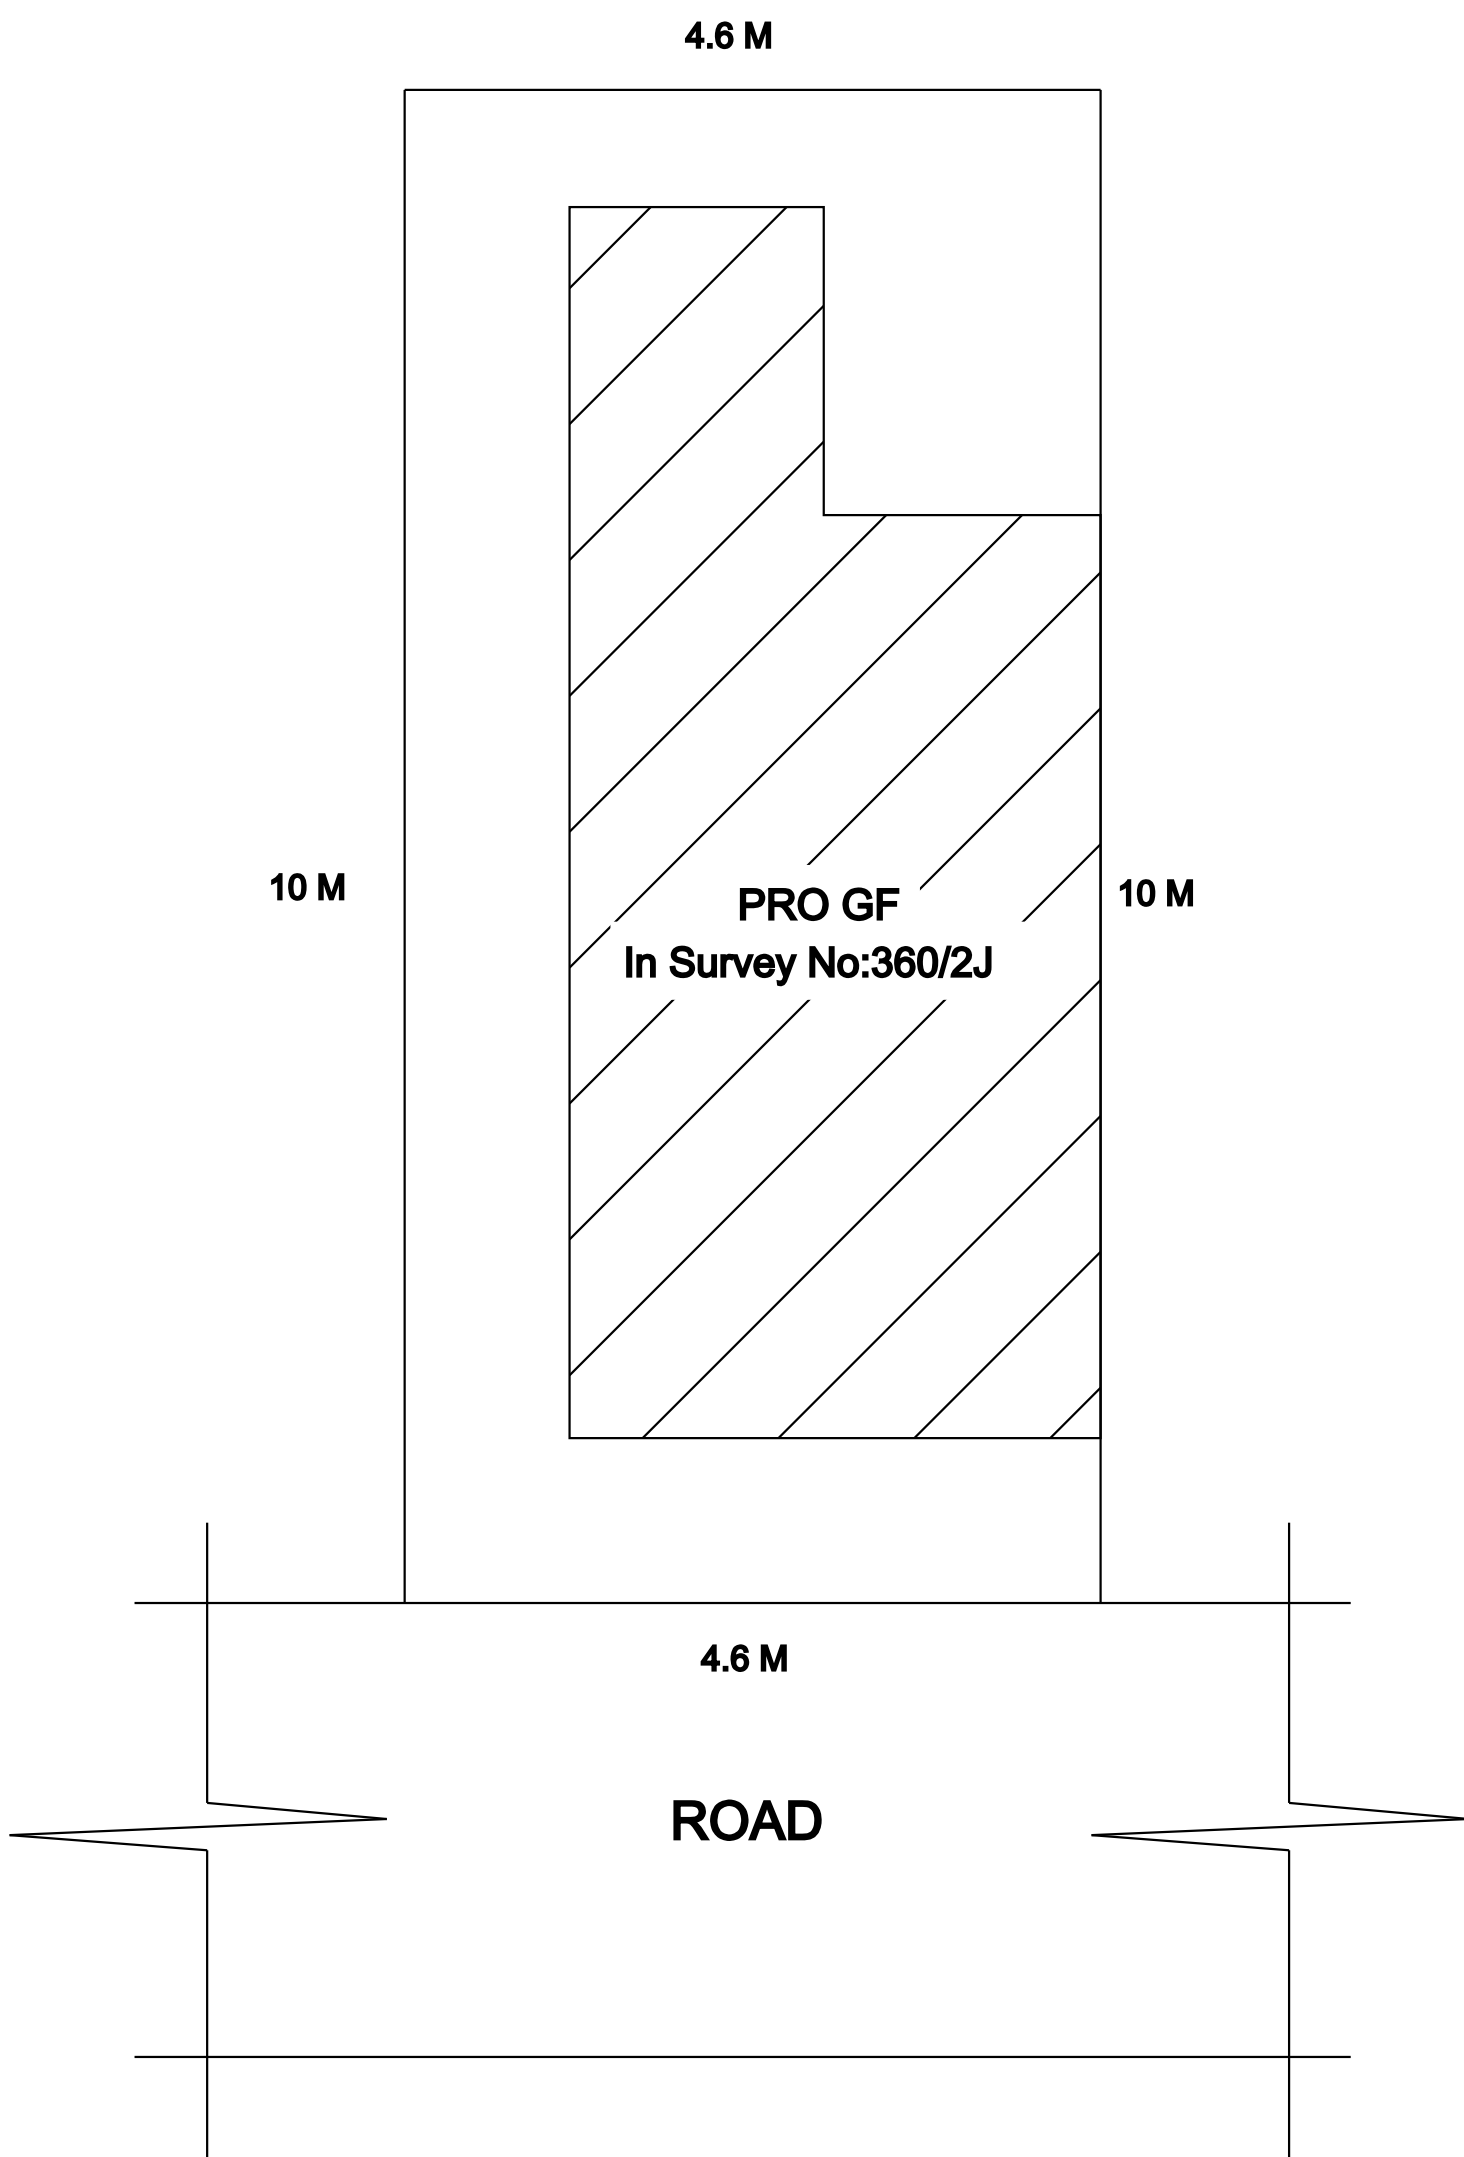

SITE PLAN

AREA STATEMENT

	Site Area(1.14 Cents)	46.00 Sq.m	495.14 Sq.ft
	Pro Ground Floor Area	24.83 Sq.m	267.27 Sq.ft
	Open Area	21.17 Sq.m	227.87 Sq.ft

JOINERY DETAILS

D	DOOR	1.00	2.13
D1	DOOR	0.76	2.13
W	WINDOW	1.06	1.37
V	VENTILATOR	0.91	0.61

OFFICE USE

APPLICANT

R. Mohamed Irath

Er.R.MOHAMED IRSATH

Register Engineer in DRDA-UDY/2022/05

Municipality Engineer -139/LS/2022/00002058

Licensed Surveyor & Consulting Engineer

Build-Up Construction,

18, Periya Street, Udangudi-628203

Cell:9750953055, 9629271761

REGISTERED ENGINEER

ALL DIMENSIONS ARE IN METER (Scale:1:100)

