

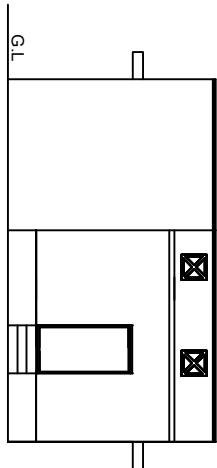


PLAN SHOWING THE PROPOSED CONSTRUCTION OF A RESIDENTIAL BUILDING IN S.F. NO.:305/3B3A & 305/3C1, PATTA NO.:1841, SUB DIVISION S.F. NO.:305/3B3A2 & S.F. NO.:305/ 3C1, PIRAMPATTY SOUTH VILLAGE, MARUNGAPURI TALUK, TIRUCHIRAPPALLI DISTRICT.


(SCALE 1 : 100)

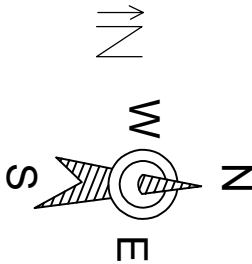



ELEVATION

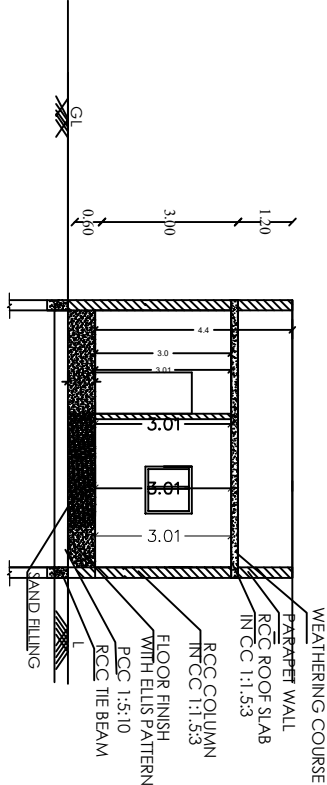


SECTION ON AA

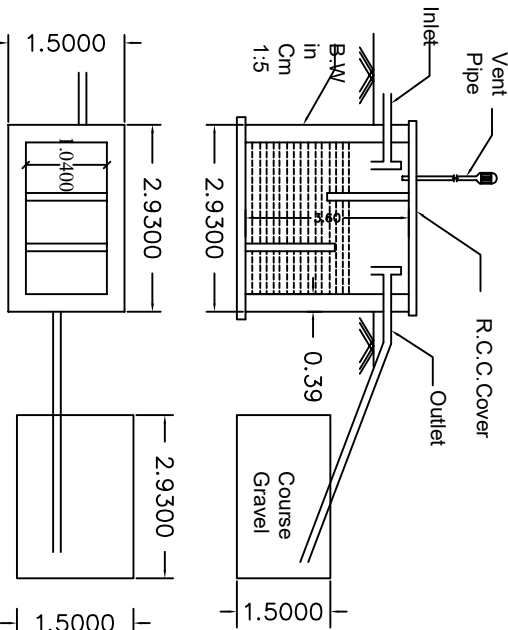

SEPTIC TANK & D-TRENCH DETAILS

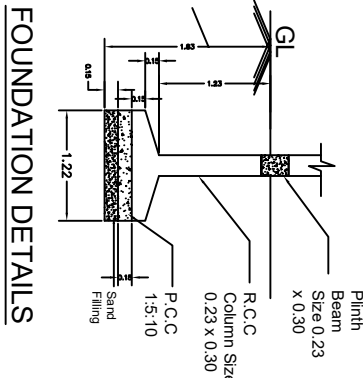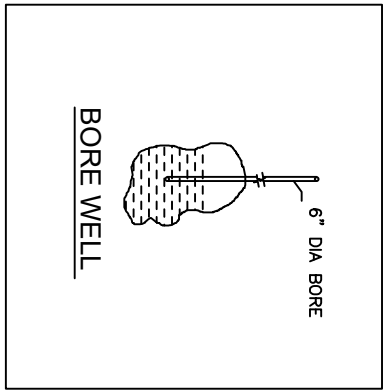


FOUNDATION DETAILS

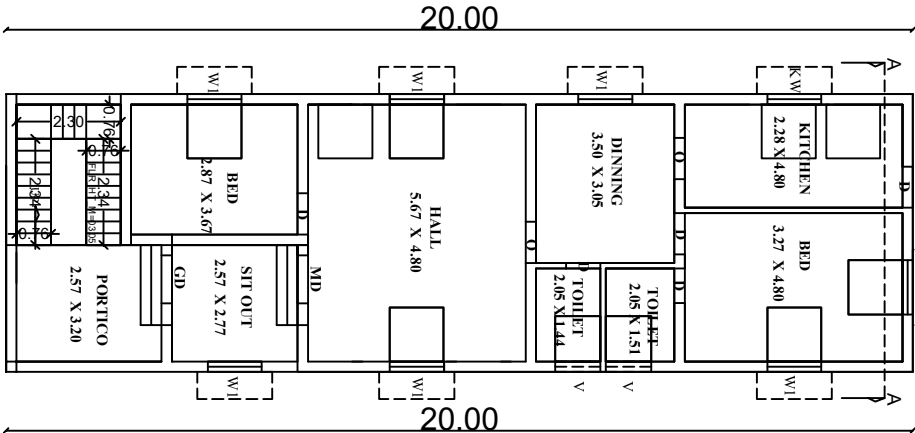

FLOOR- GROUND

PRO.GROUND FLOOR PLAN

SCHEDULE OF JOINERIES	
REFERENCE	METER
MD - MAIN DOOR	1.20 x 2.13
D1 - FLUSH DOOR	0.91 x 2.13
O - OPEN	1.00 x 2.13
W - GLAZED WINDOW	1.50 x 1.50
W1 - GLAZED WINDOW	1.20 x 1.50
KW - KITCHEN WINDOW	1.20 x 1.00
V - VENTILATOR	1.00 x 0.91

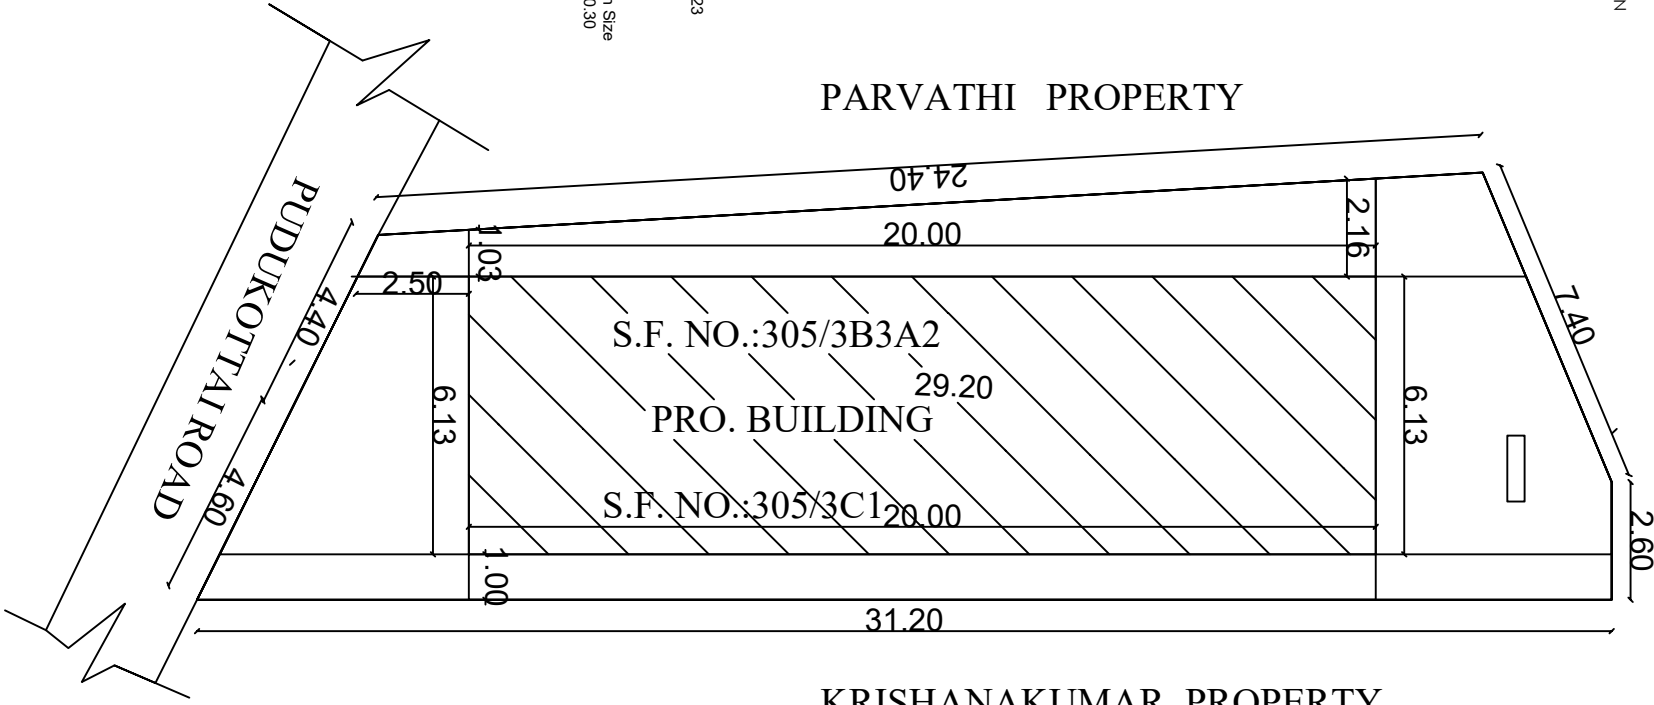

SITE PLAN

(SCALE 1 : 100)

NOTE

1. L.P GAS WILL BE USED FOR KITCHEN.
2. SULLAGE WASTE FROM TOILET WILL BE CONNECTED INTO STP.
3. BORE WELL WITH MOTAR WATER TANK AND CORPORATION WATER SUPPLY WILL BE PROVIDED.
4. RAIN WATER PERCOLATION PIT PROVIDED @ 1/30 Sqm OF PLINTH AREA @ 6 M C/C
5. RAIN WATER PERCOLATION BED 1.0m WIDE WILL BE PROVIDED AROUND THE BUILDING AS PER GO (MS) NO: 138 DATED 11-10-02.
6. RAIN WATER TAKEN TO THE BORE WELL THROUGH 150MM DIA PIPES.
7. RAIN WATER COLLECTED FROM OPEN TERRACE SHALL BE COLLECTED THROUGH PIPES AND LED INTO A FILTER PIT (SIZE 60 X 60 X 60 CM) WITH APPROPRIATE FILTER MATERIAL AND THEN LED INTO COLLECTION TANK.

AREA DETAILS

<u>DESCRIPTION</u>		<u>SQ.FT</u>	<u>SQ.M</u>
PLOT AREA AS PER DOCUMENT		3336.84	310.00
PLOT AREA AS PER FMB		2798.64	260.00
<u>PROPOSED BUILTUP AREA</u>			
<u>SL NO.</u>	<u>DESCRIPTION</u>	<u>(SQ.FT)</u>	<u>F.S.I AREA (SQM)</u>
1)	GROUND FLOOR AREA	1319.66	122.60
2)	TOTAL	1319.66	122.60
3)	VACANT AREA	1478.98	137.40

BOUNDARY SHOWN IN	-	PERCOLATION PIT	-
PROPOSED AREA	-	BORE WELL	-
EXISTING SHOWN AREA	-	ROAD	-
RAIN WATER PERCOLATION BED	-		

ALL DIMENSION ARE IN METER
SCALE - 1:100

OWNER SIGNATURE

REGISTERED ENGINEER

M. S. Srinivasan

Mr. S. Srinivasan
REGISTERED ENGINEER
GOVT REG. NO.086, LS.100020
SHREE ANJANEYA CONSTRUCTION
HEBER ROAD, BEEMA NAGAR
TIRUCHI-1, Call : 73736 09652