




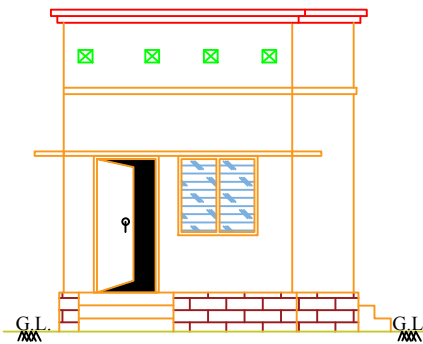


ELEVATION

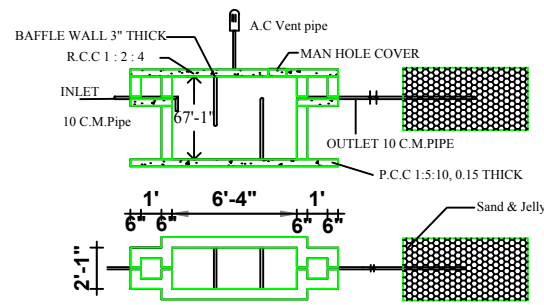


Septic tank and trench

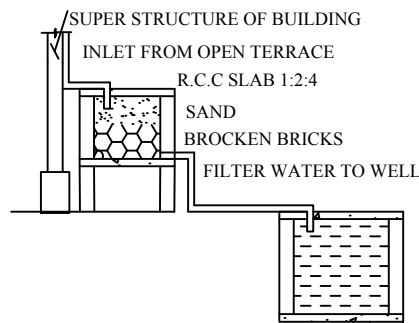



Rainwater harvesting

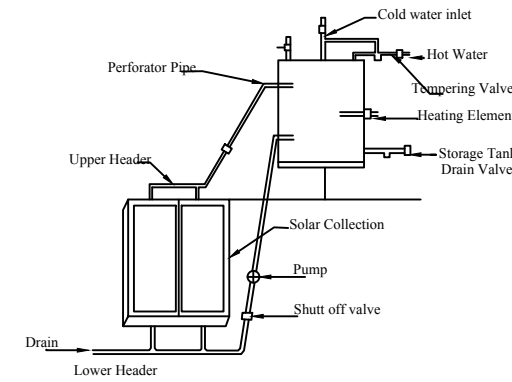




Details Of Solar Water Heater (NTS)

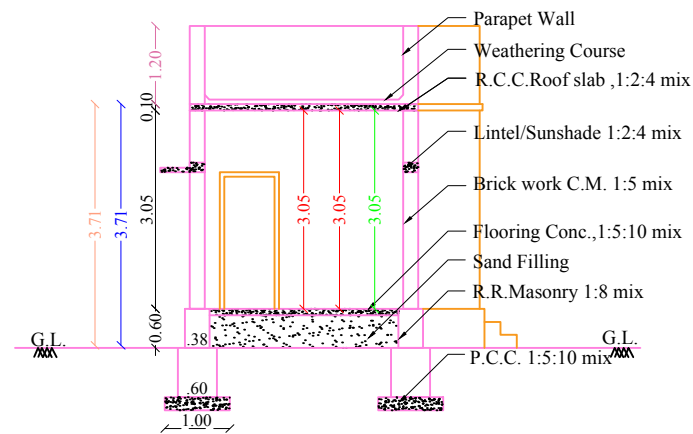

SECTION ON A-B

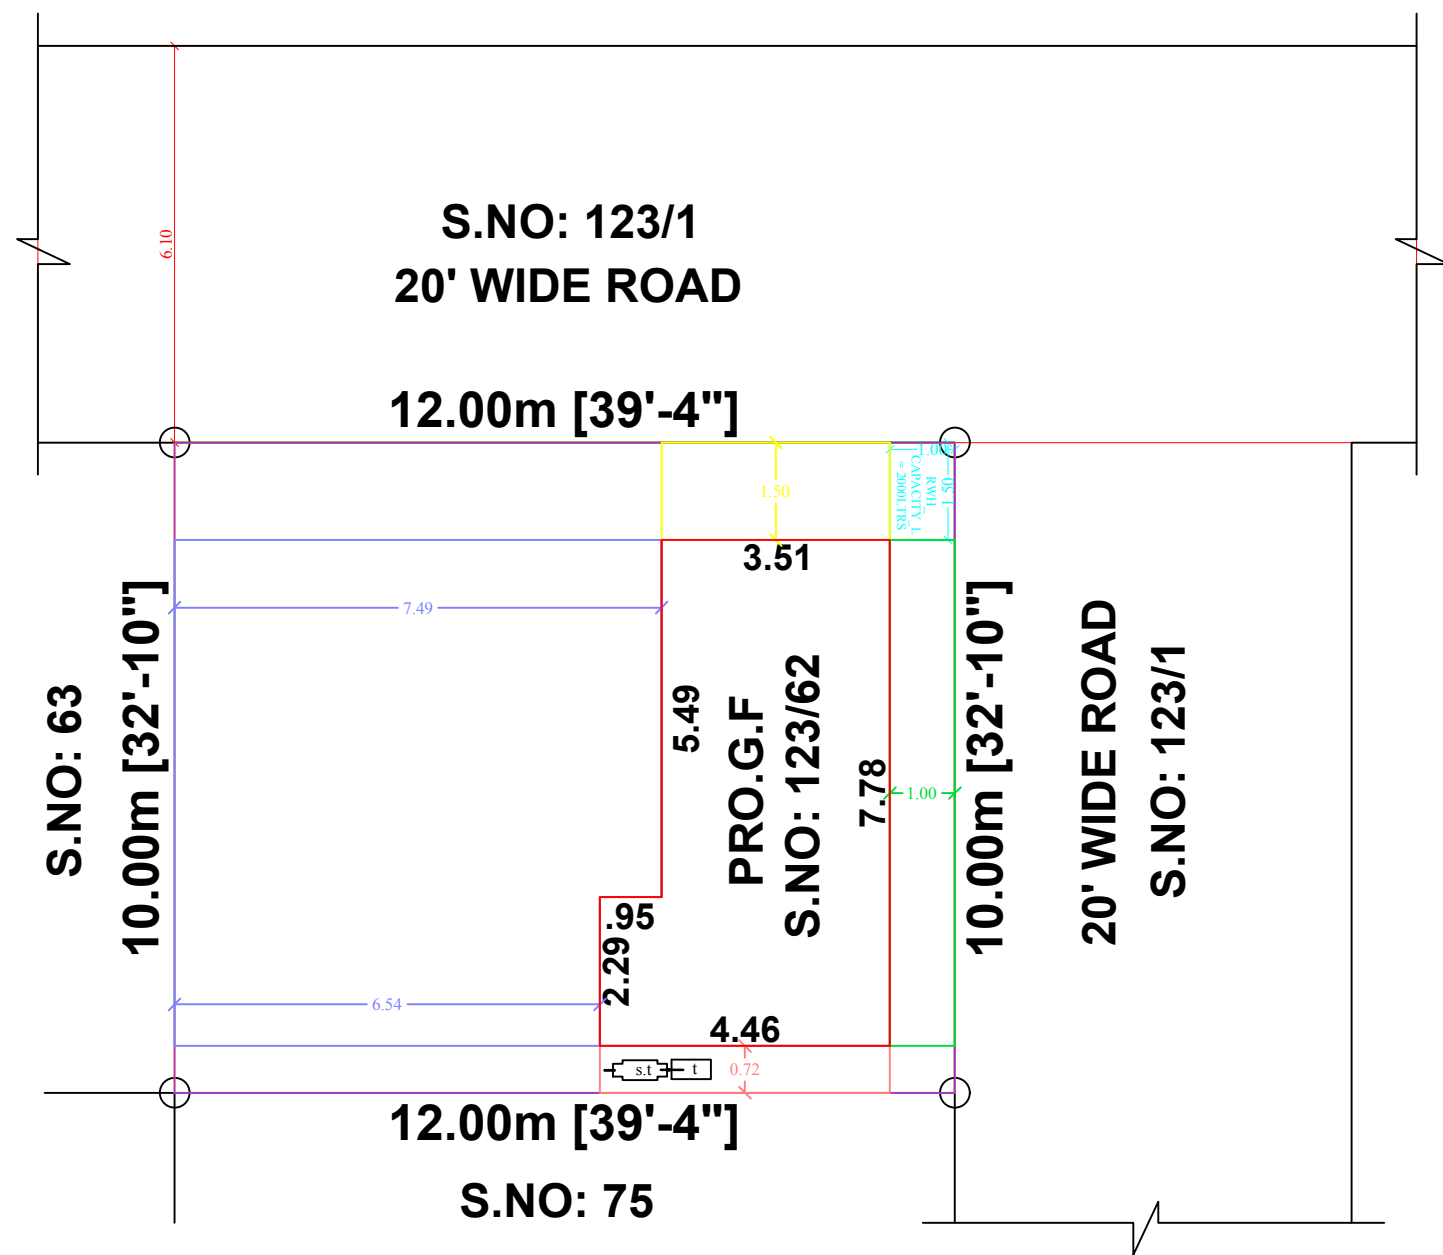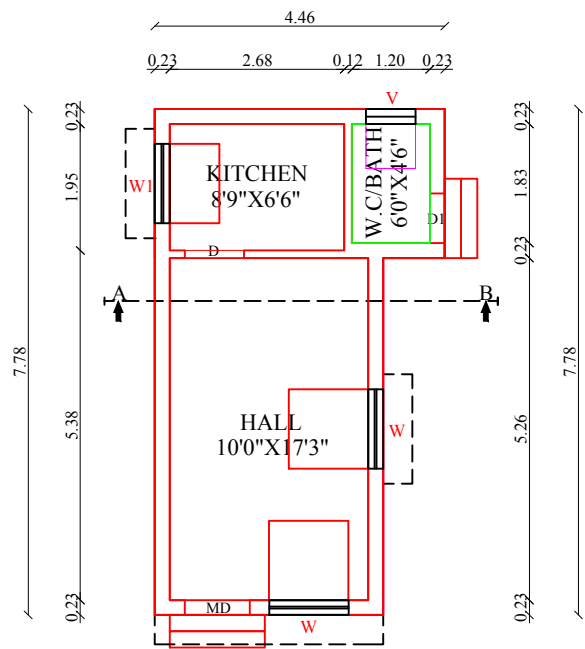

SITE PLAN
SCALE 1:100

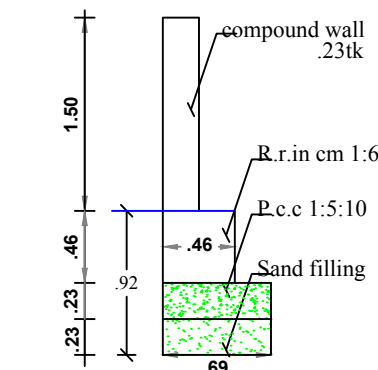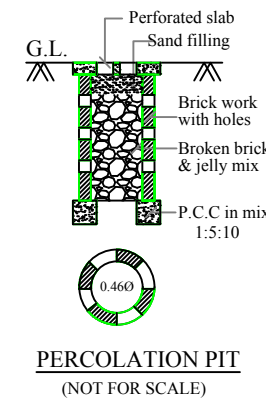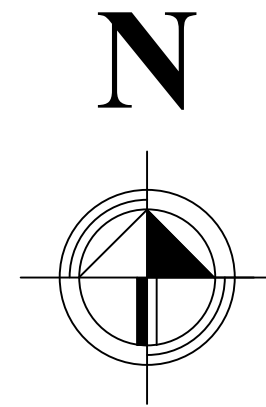

Compound Wall Detail

PLAN SHOWING THE PROPOSED CONSTRUCTION

OF G.F RESIDENTIAL BUILDING IN S.NO: 123/62, PATTA NO: 3689,
KEELANATHAM VILLAGE AND PANCHAYAT, PALAYAMKOTTAI-
PANCHAYAT UNION AND PALAYAMKOTTAI TALUK,
TIRUNELVELI DISTRICT.

JOINERY					AREA DETAILS			
MD	DOOR	1.10 X 2.10	W	Window 1.22 X 1.22	COL	DESCRIPTION	SQ.M	SQ.FT
D	DOOR	0.91 X 2.10	W1	Window 1.22 X 0.76		SITE AREA (as per patta)	120.00	1291.68
D1	DOOR	0.76 X 2.10	V	Ventilator 0.78 X 0.68		PRO. GROUND FLOOR	29.48	317.32
☐ RAIN WATER COLLECTING TANK IS TO BE PROVIDED waste water to be garden						OPEN SPACE	90.52	974.36
☐ ALL DIMENSION ARE IN METRE = SCALE 1:100						ROAD		

G. Vairamuthu Selvi

(Mrs. G.VAIRAMUTHU SELVI)
APPLICANT

(Er. C.BALAKRISHNAN)
REG. ENGINEER

BK DESIGN PVT LTD.
STRUCTURAL FIRM

BK DESIGN PVT.LTD
NO.5, USA Complex,
Opp.Mutharamman Temple,
Palayamkottai.
Cell No. 9787008789