





PLAN SHOWING THE PROPOSED CONSTRUCTION OF RESIDENTIAL GROUND FLOOR
BUILDING IN S.NO:270/1B,PLOT NO:253,ISIS AVENUE,PALASTHINAPURAM VILLAGE,
VAGAIKULAM PANCHAYAT,MANUR UNION,TIRUNELVELI DISTRICT.

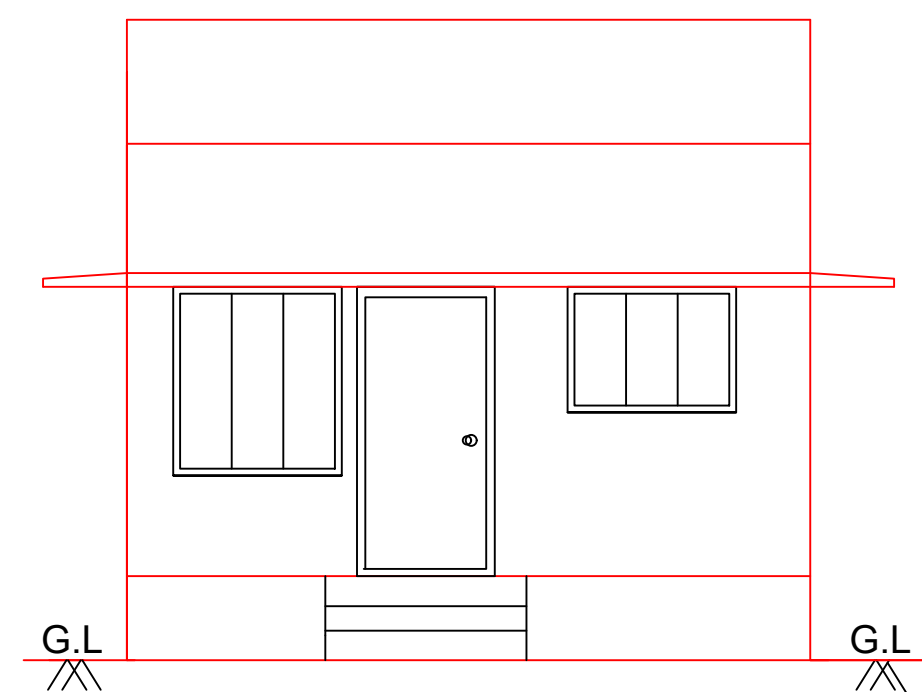


ELEVATION

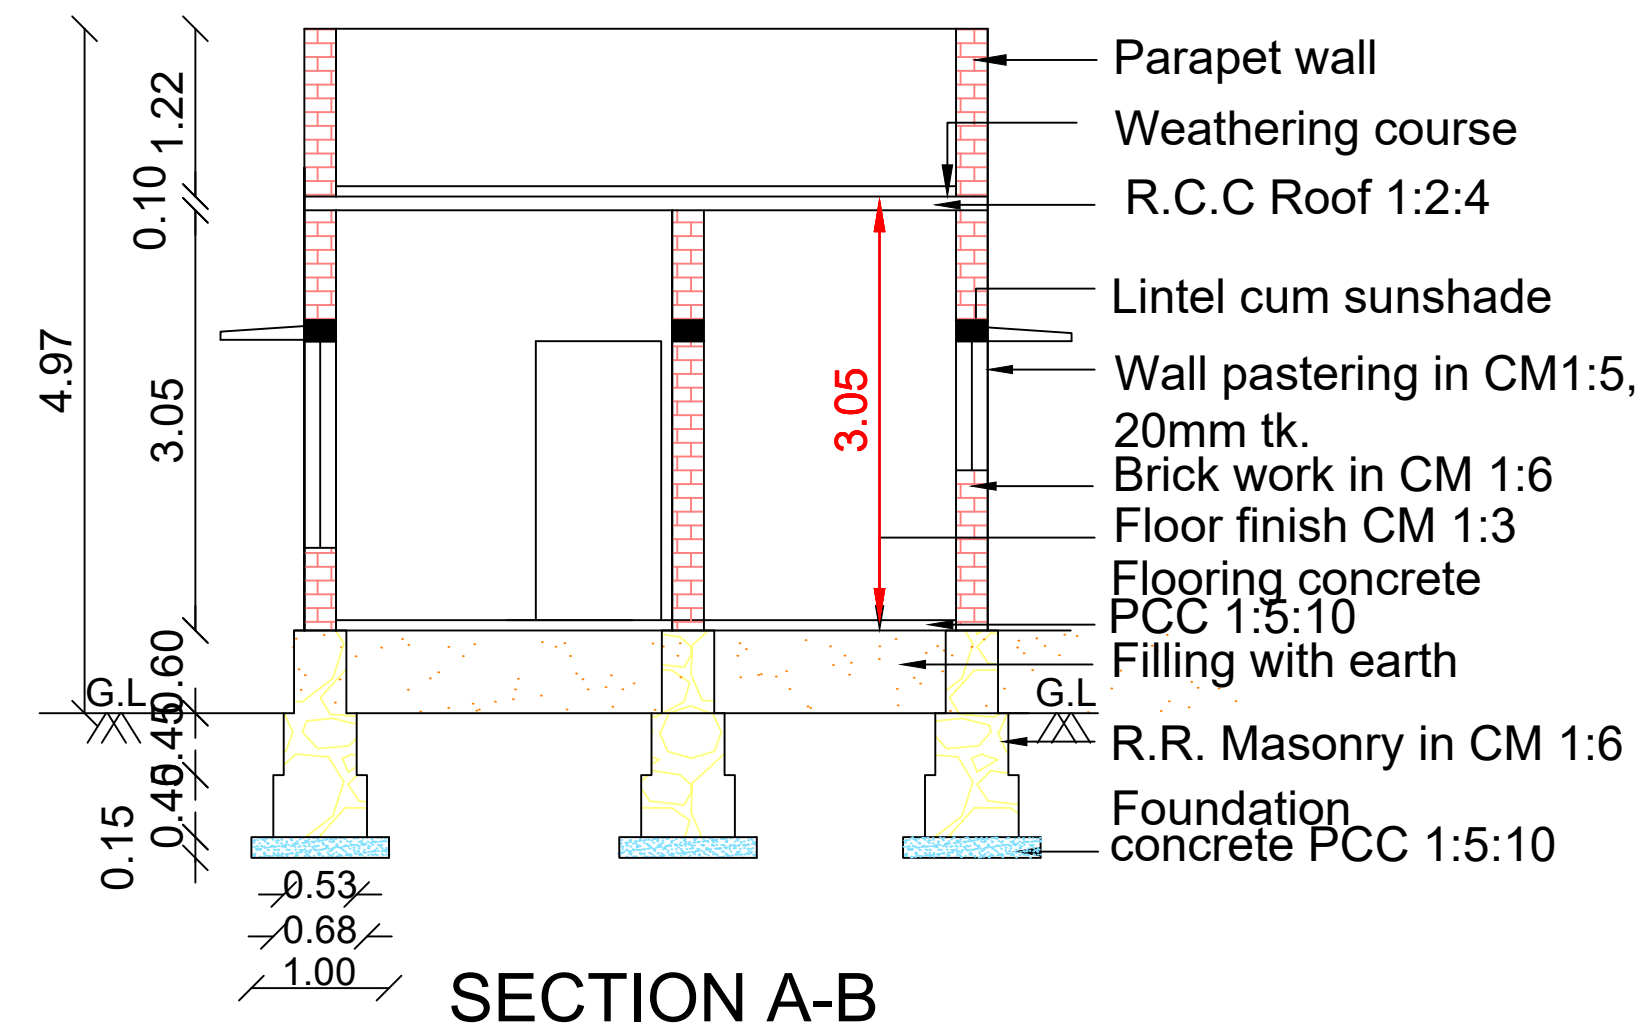


SECTION A-B

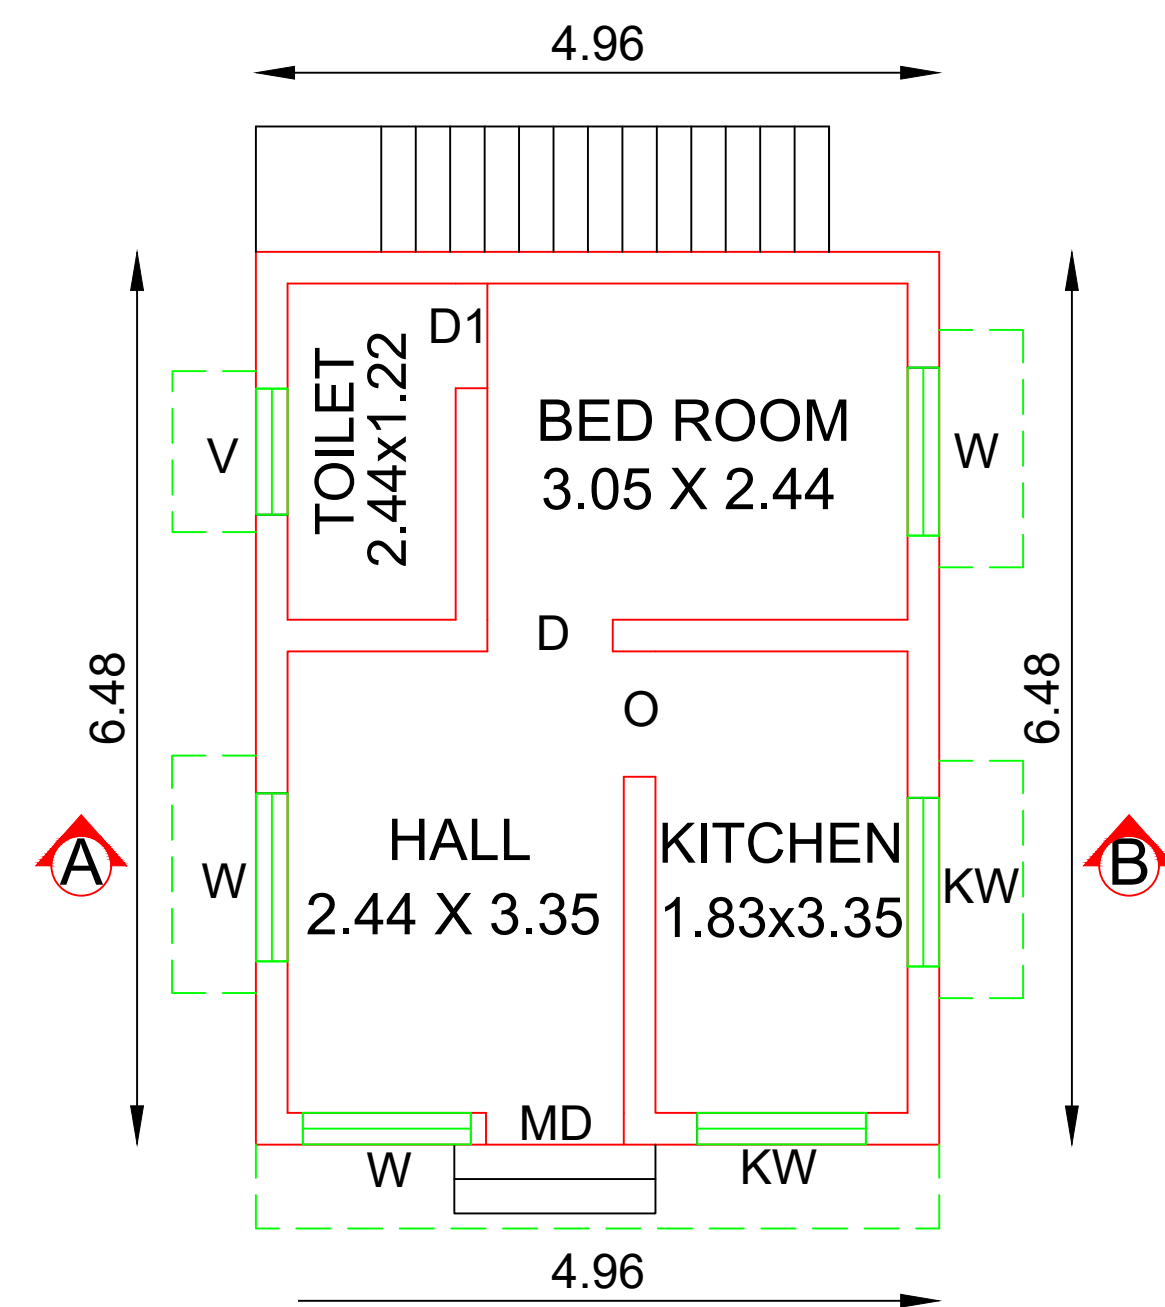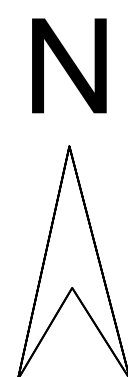


GROUND FLOOR PLAN

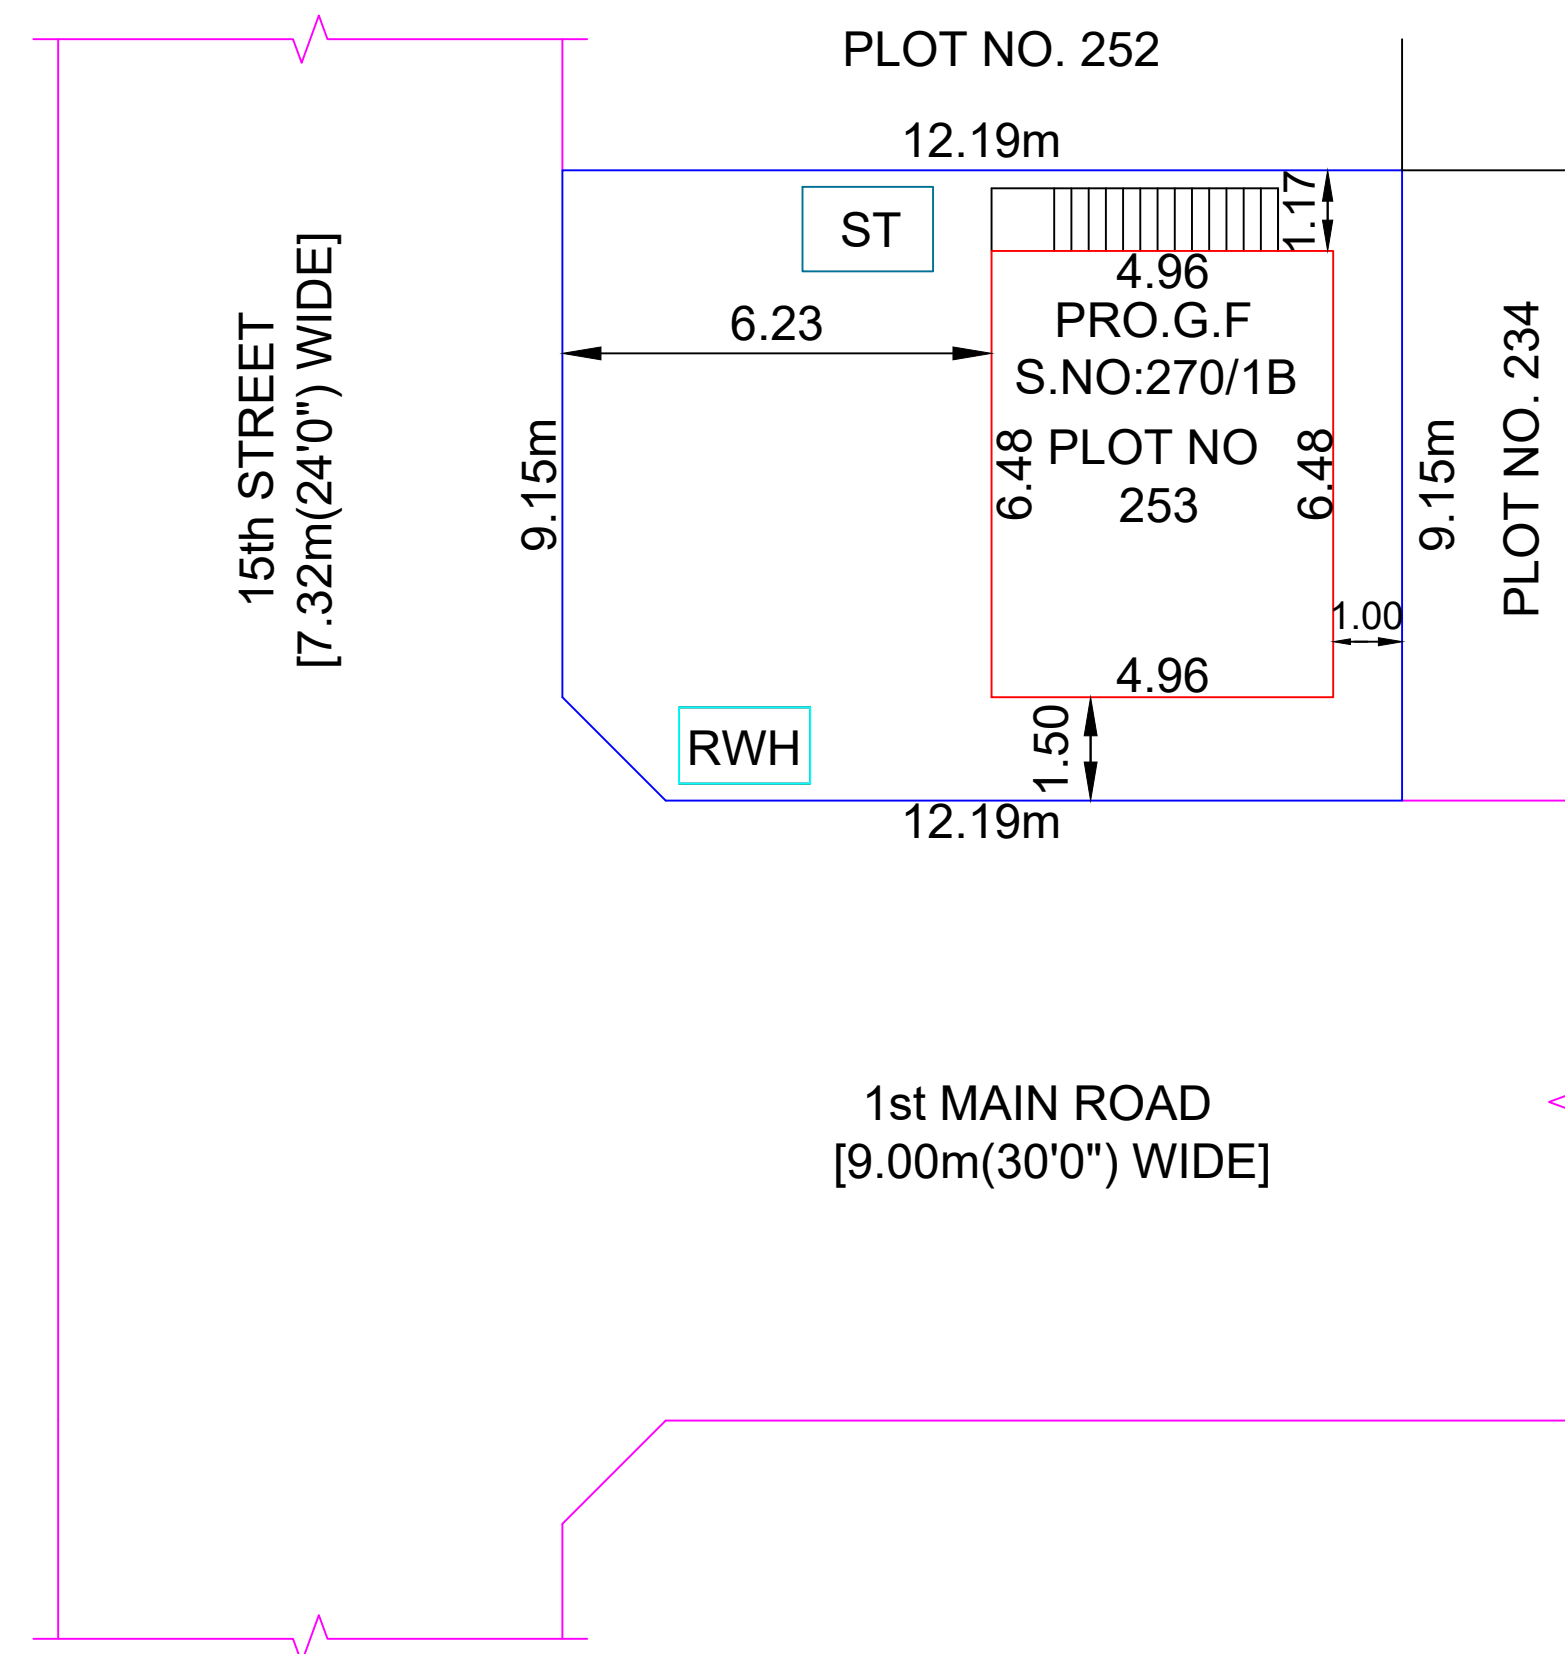


SITE PLAN
(Scale 1:200)

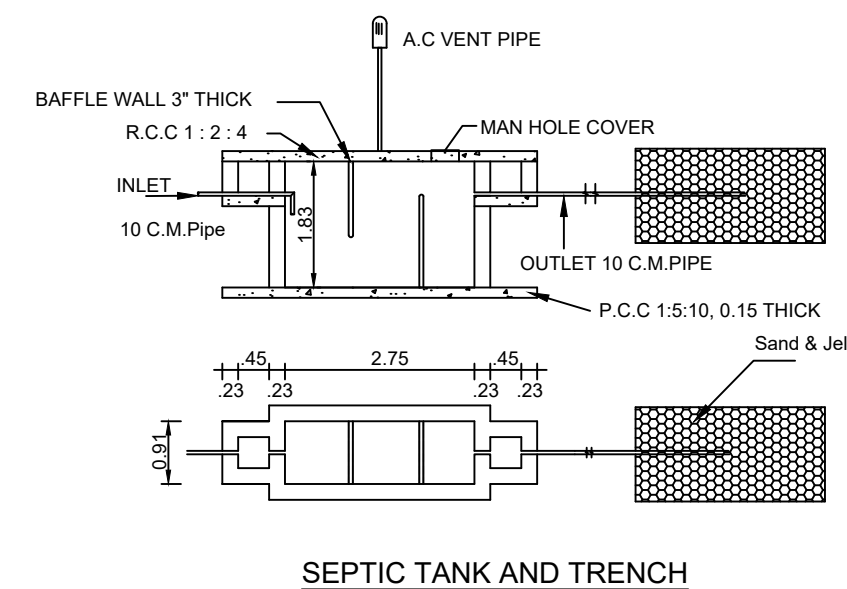

SEPTIC TANK AND TRENCH

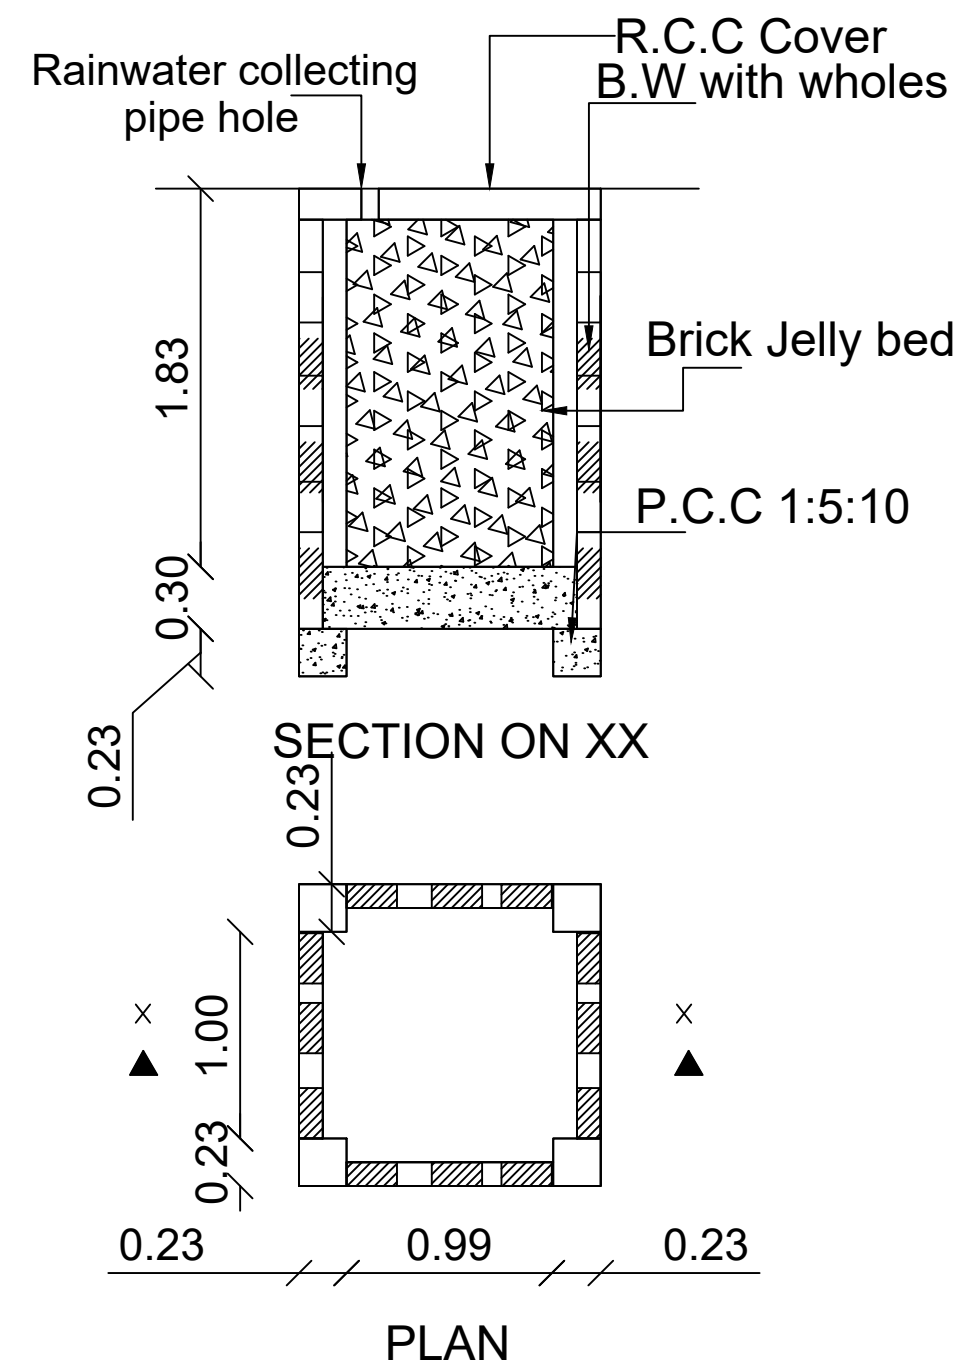

PLAN

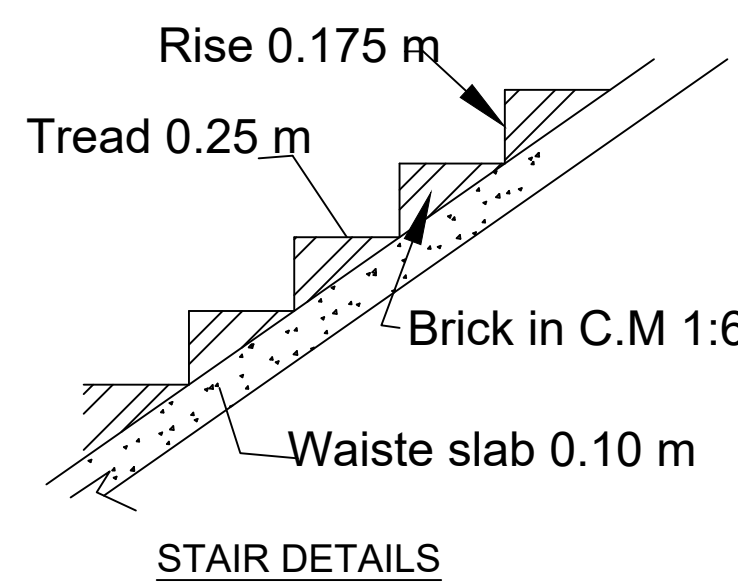

STAIR DETAILS

NOTE-
All dimensions are in metre
Waste water to be used in garden.
Rain water Harvest well provided in site.
Exhaust fan provided in kitchen
Chimney to be provided over the kitchen
Cantilever open staircase provided
Solar system water tank to be provided.
'U' Traps provided in septic tank
prevent curb breeding of mosquitoes.

OFFICE USE.

NAME OF OWNER: Mr.L.RAJ KUMAR.

Area details	Sq.M	Sq.Ft
Applicant site area	111.48	1200.00
Proposed G.F Area	32.13	345.72
Open space	79.35	854.28

JOINERIES		
MD	Door	1.00 X 2.10
D	Door	0.91 X 2.10
D1	Door	0.75 X 2.10
W	Window	1.22 X 1.37
KW	Kitchen Window	0.91 X 0.91
W1	Window	1.52 X 1.37
V	Ventilator	0.91 X 0.61

COLOUR REFERENCE	
Site area	
Pro.building	
Exg.road	

APPLICANT: L.RAJ KUMAR

Er. B. SELVIN SANTHOSH B.E.,
Registered Engineer Gr - III
Reg. No: 146/LS/2022/00033
SB CONSTRUCTIONS
VSM Anusya Complex
Manur - 627 201
Mobile - 9360604359

ENGINEER