 


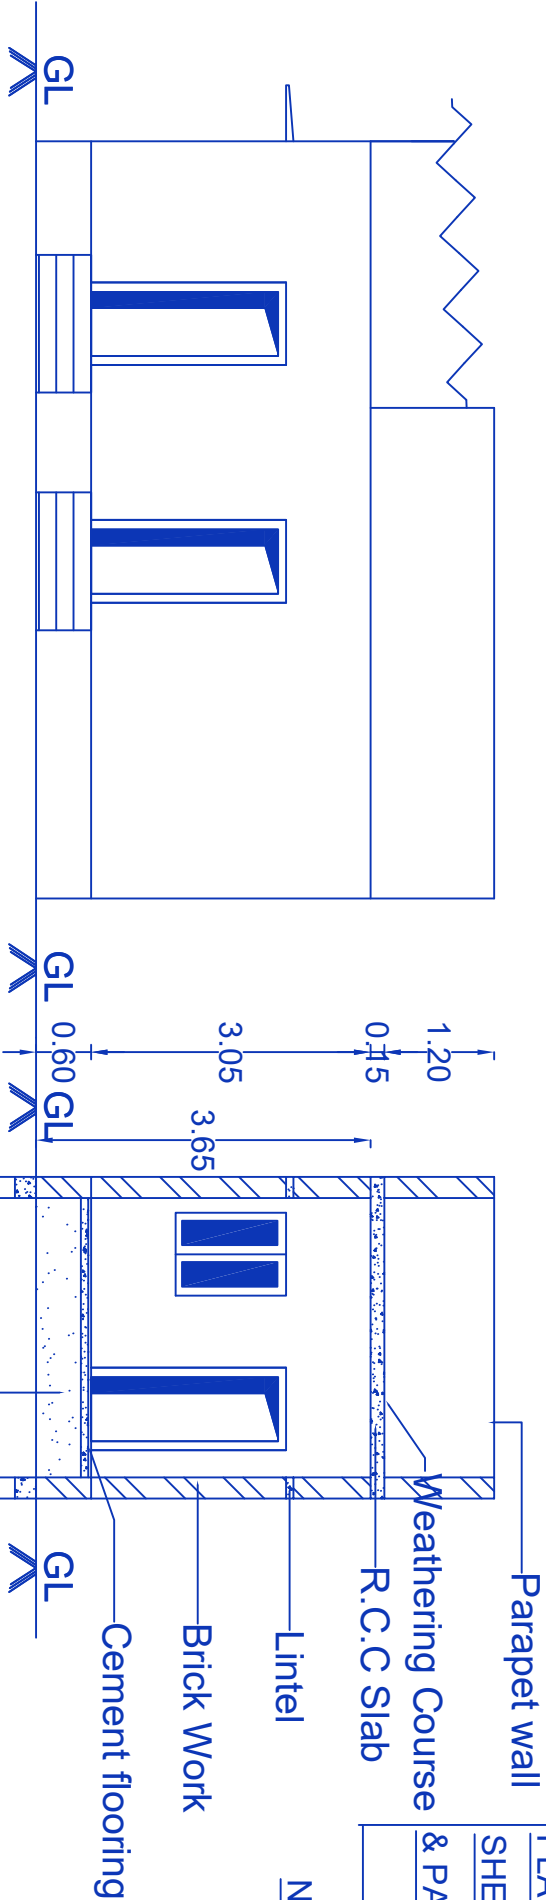


PLAN SHOWING THE PROPOSED CONSTRUCTION OF R.C.C & COOLING
SHEET ROOF HOUSE, IN SY.NO:740/1, AT SHENBAGARAMANALLUR VILLAGE
& PANCHAYAT OF NANGUNERI UNION.





NAME OF THE APPLICANT : Mr.SIVA CHELVAN S/O.Mr.MUTHUSWAMY.

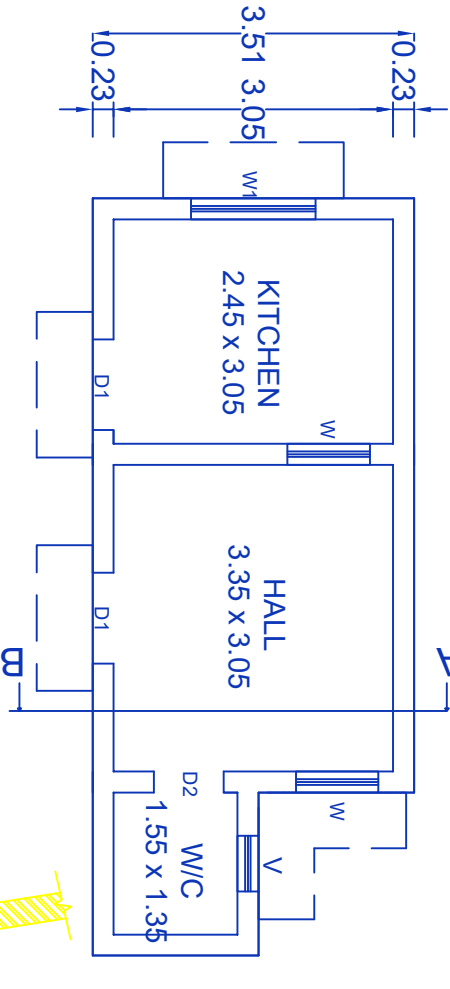


SECTION ON'AB'

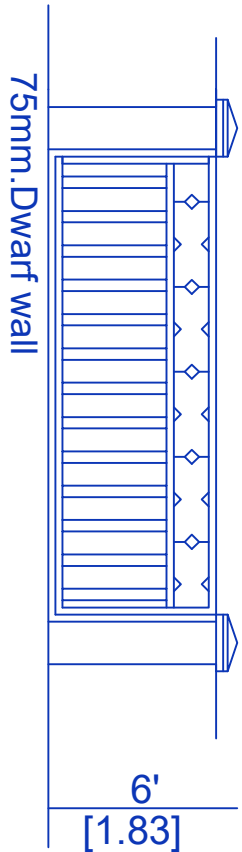

GROUND FLOOR PLAN

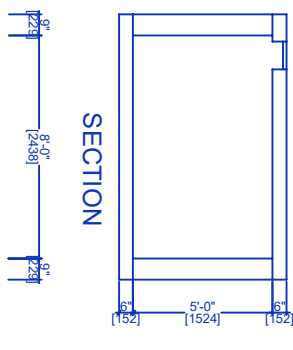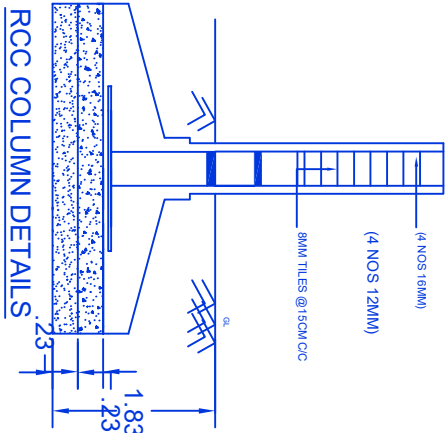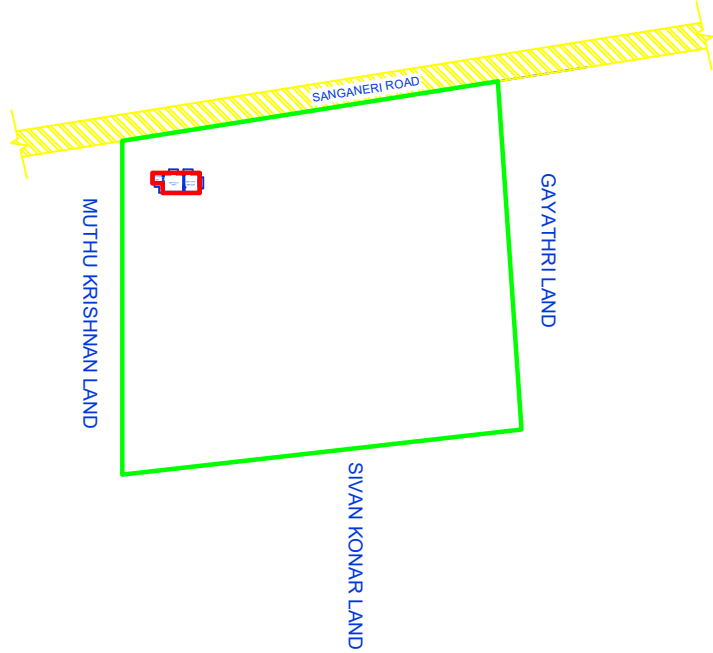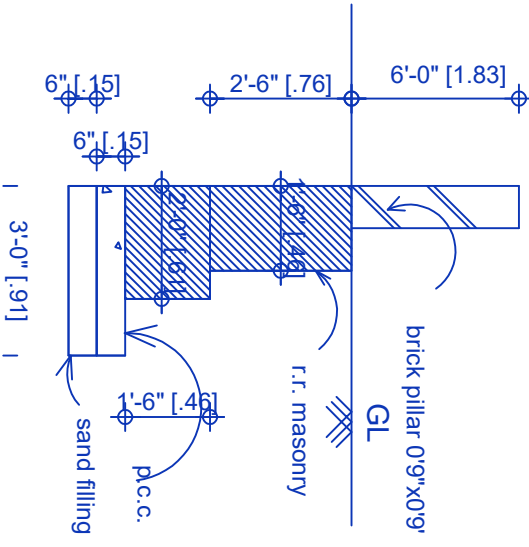

SECTION

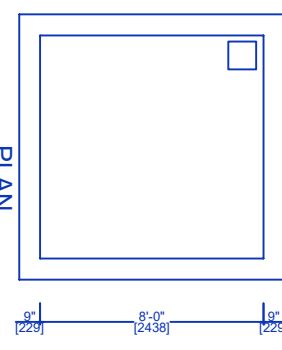

PLAN



DETAILS OF COLLECTION SUMP FOR RAIN
WATER HARVESTING OF ROOF TOP RAIN WATER

G.P.S:-8.483081, 77.702753

JOINERY			
W3	Window 4.49 X 1.22	W2	Window 2.98 X 1.22
D	D00R 1.22 X 2.10	V1	Ventilator 2.33 X 0.61
D2	D00R 0.76 X 2.10	V	Ventilator 0.91 X 0.61
AREA DETAILS		SQ.M	SQ.FT
☐	SITE AREA	4046.45	43556.00
☐	PRO. GROUND FLOOR	26.00	279.86
☐	OPEN SPACE	4020.45	43276.14
☐	ROAD		
☐ RAIN WATER COLLECTING TANK IS TO BE PROVIDED waste water to be garden ALL DIMENSION ARE IN METRE SCALE 1:100			
OFFICE USE			



Er.B.
District Panel Engine
Registered Engineer in
Registered Engineer in Civil
POTHIHAI CC
260/1, Rajiv Nagar,
Cell: 72000 940

APPLICANT

ENGINEER

PLAN NO
1266

POTHIHAI CONSTRUCTIONS
Near Pothihai Public School
Tisaiyavittai.
Cell No. 90254 38288 , 99524 69037