




PLAN SHOWING THE PROPOSED CONSTRUCTION OF RESIDENTIAL BUILDING IN SY.NO: 774/7, PILLAYAR KOVIL STREET, PADALAIYARKULAM VILLAGE AND PANCHAYAT, KALAKAD UNION, NANGUNERI TALUK, TIRUNELVELI DIST.
APPLICANT NAME: Tmt. P.PONNAMMAL W/O VINOTH KUMAR.

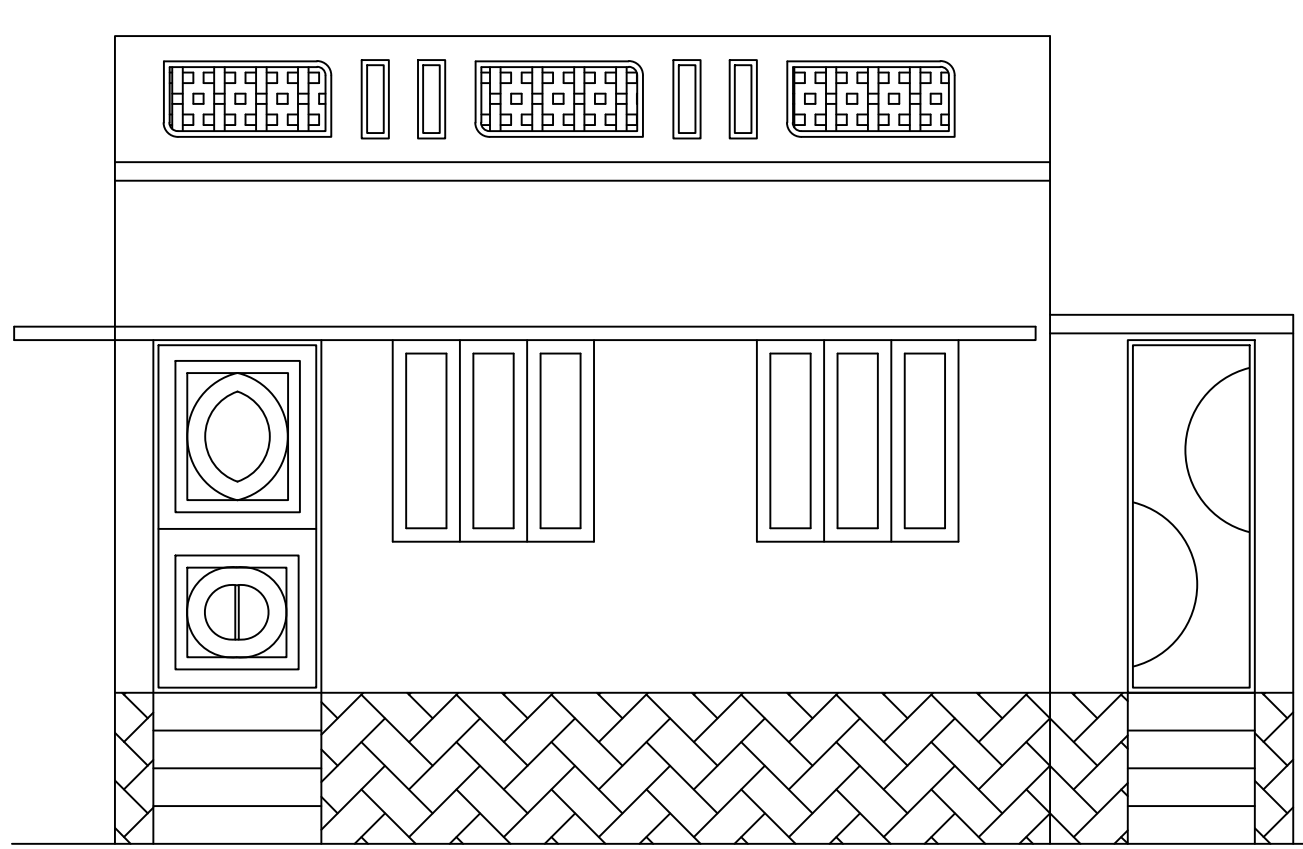

ELEVATION

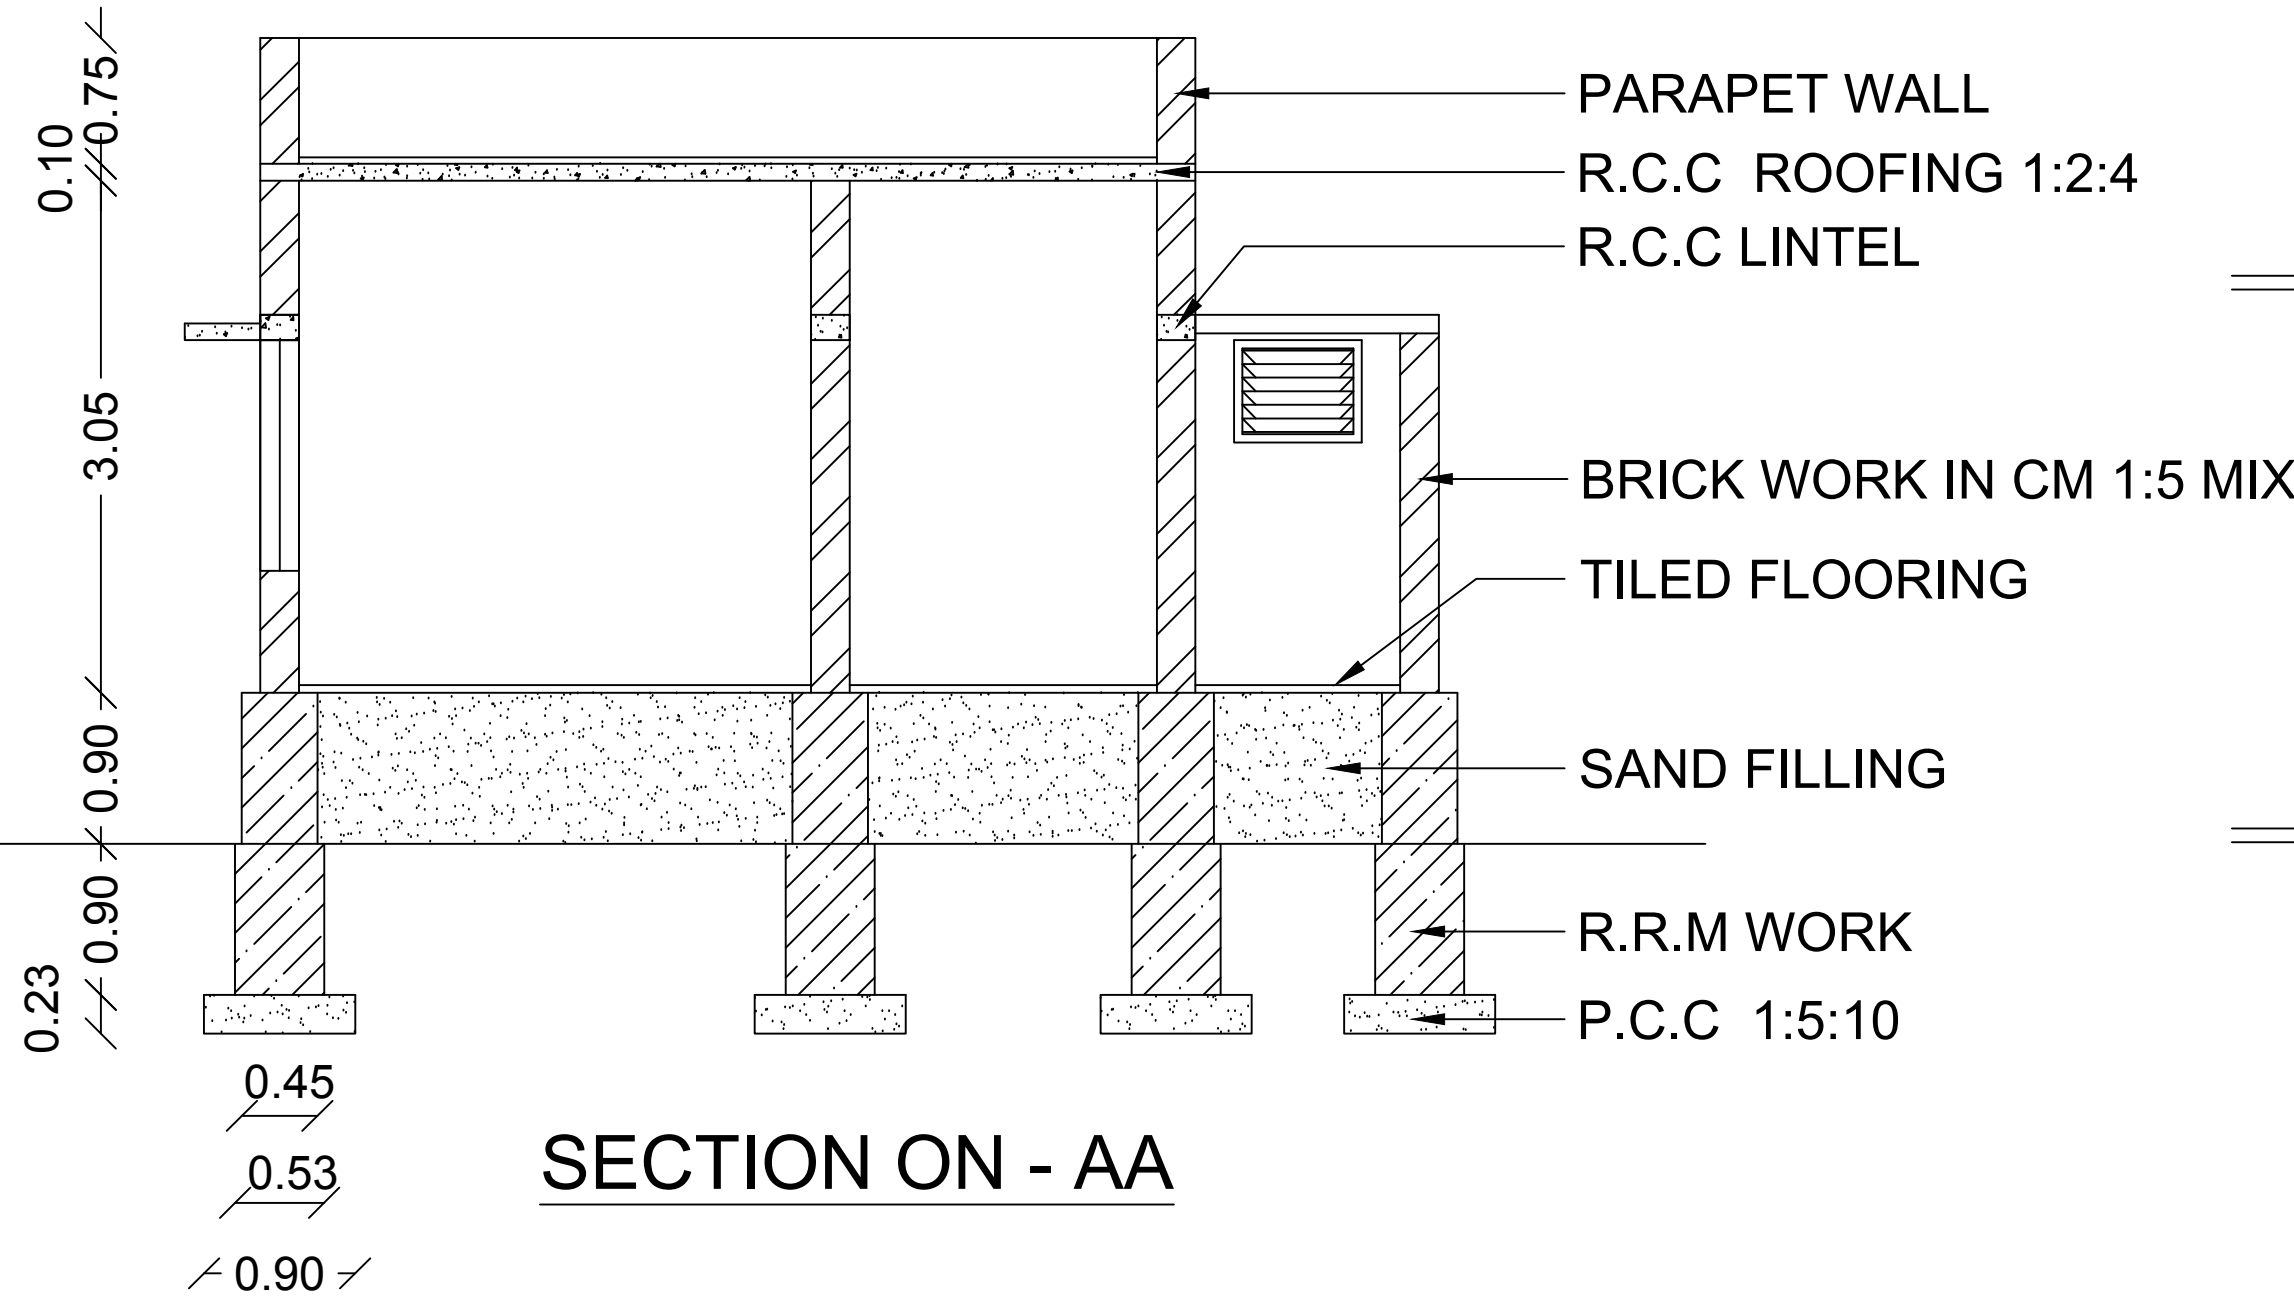

SECTION ON - AA

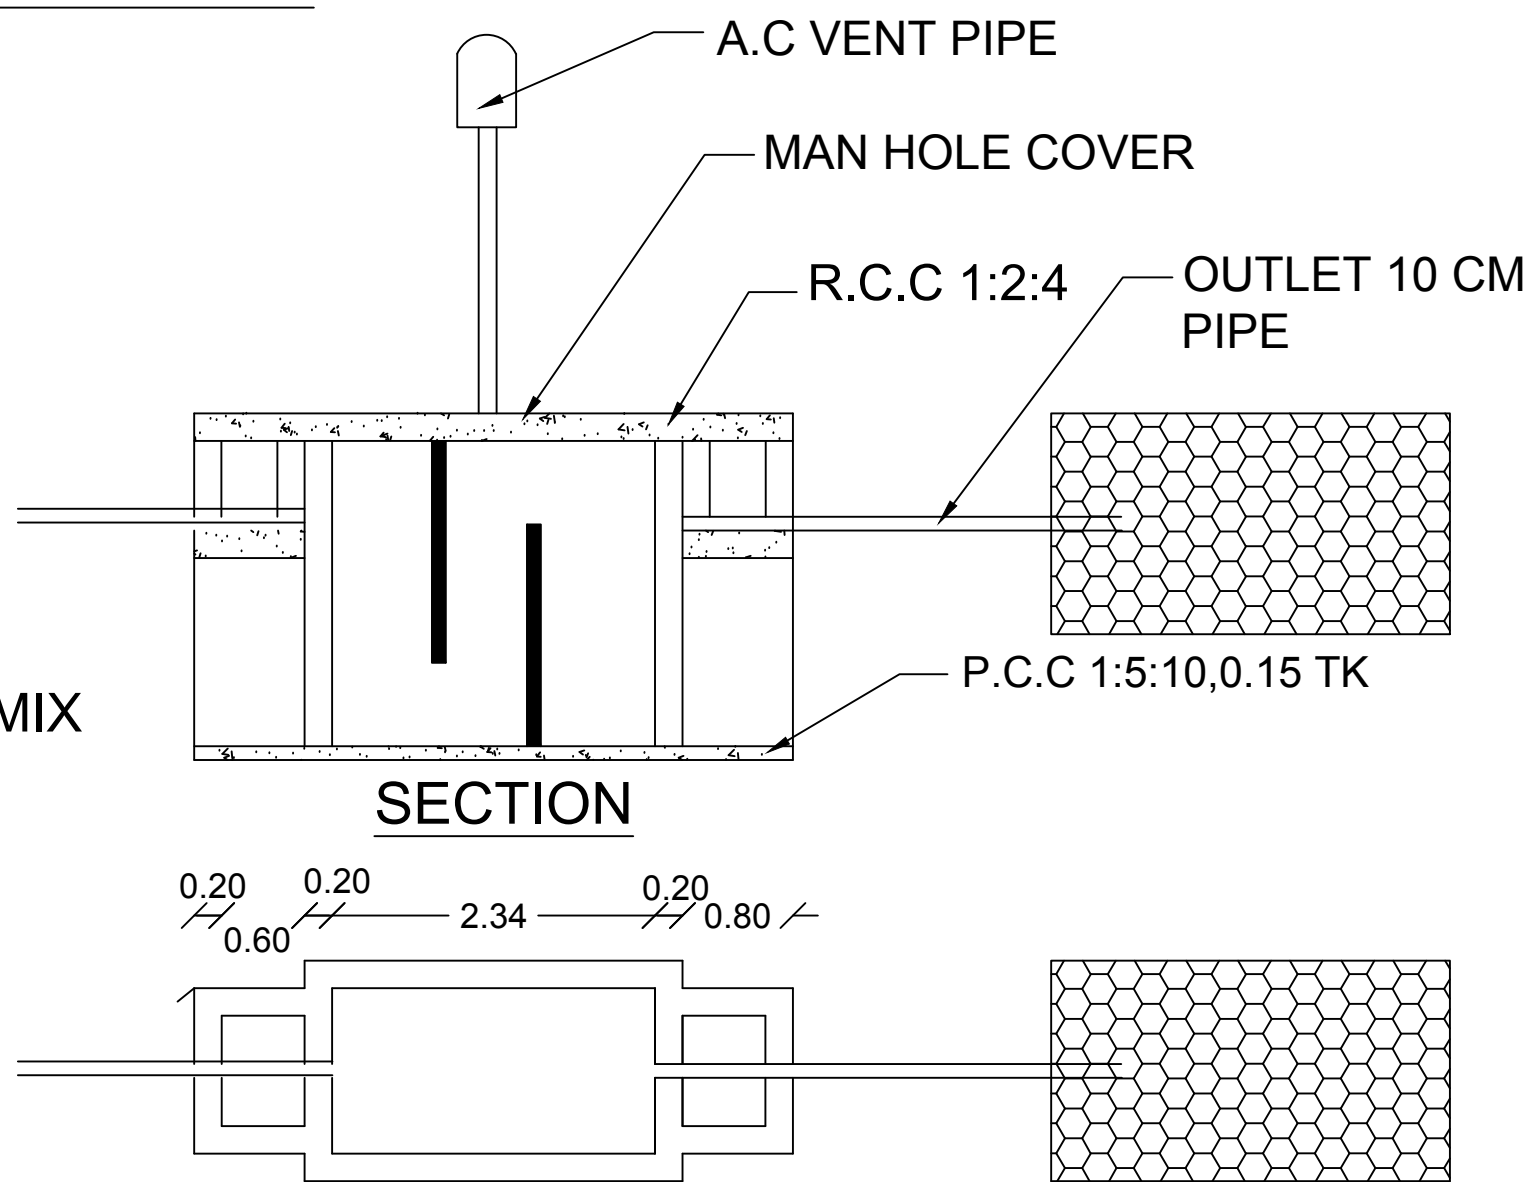

PLAN OF SEPTIC TANK & TRENCH

AREA DETAILS :		Sq.Mt	Sq.Ft
SITE AREA		632.32	6806.25
PROPOSED			
G.F.PLINTH AREA		22.87	246.17
G.F.FLOOR AREA		18.24	196.33
JOINERY DETAILS		L	B
D	DOOR	1.00	2.10
D1	DOOR-1	0.76	2.10
O	OPENING	1.00	2.10
W	WINDOW	1.20	1.20
W1	WINDOW-1	1.20	0.61
V	VENTILATION	0.76	0.61

NOTE:-
* ALL DIMENSION ARE IN METER SCALE 1:100
* WASTE WATER USED TO GARDEN
* PERCOLATION PIT TO BE PROVIDED

	SEPTIC TANK TRENCH
	RAIN WATER TRENCH
	PROPOSED
	ROAD
	SITE


APPLICANT :

P. Ponnammal


ENGINEER :

Er. S. VELRAJ D.G.E., B.Tech.,
Consulting Engineer & Licensed Surveyor
Thirumanee Construction
16/5, Main Road, Singampathu
Kalakad - 627 501.
Cell : 9443613826
TNV/PROF/31/2022


OFFICE USE

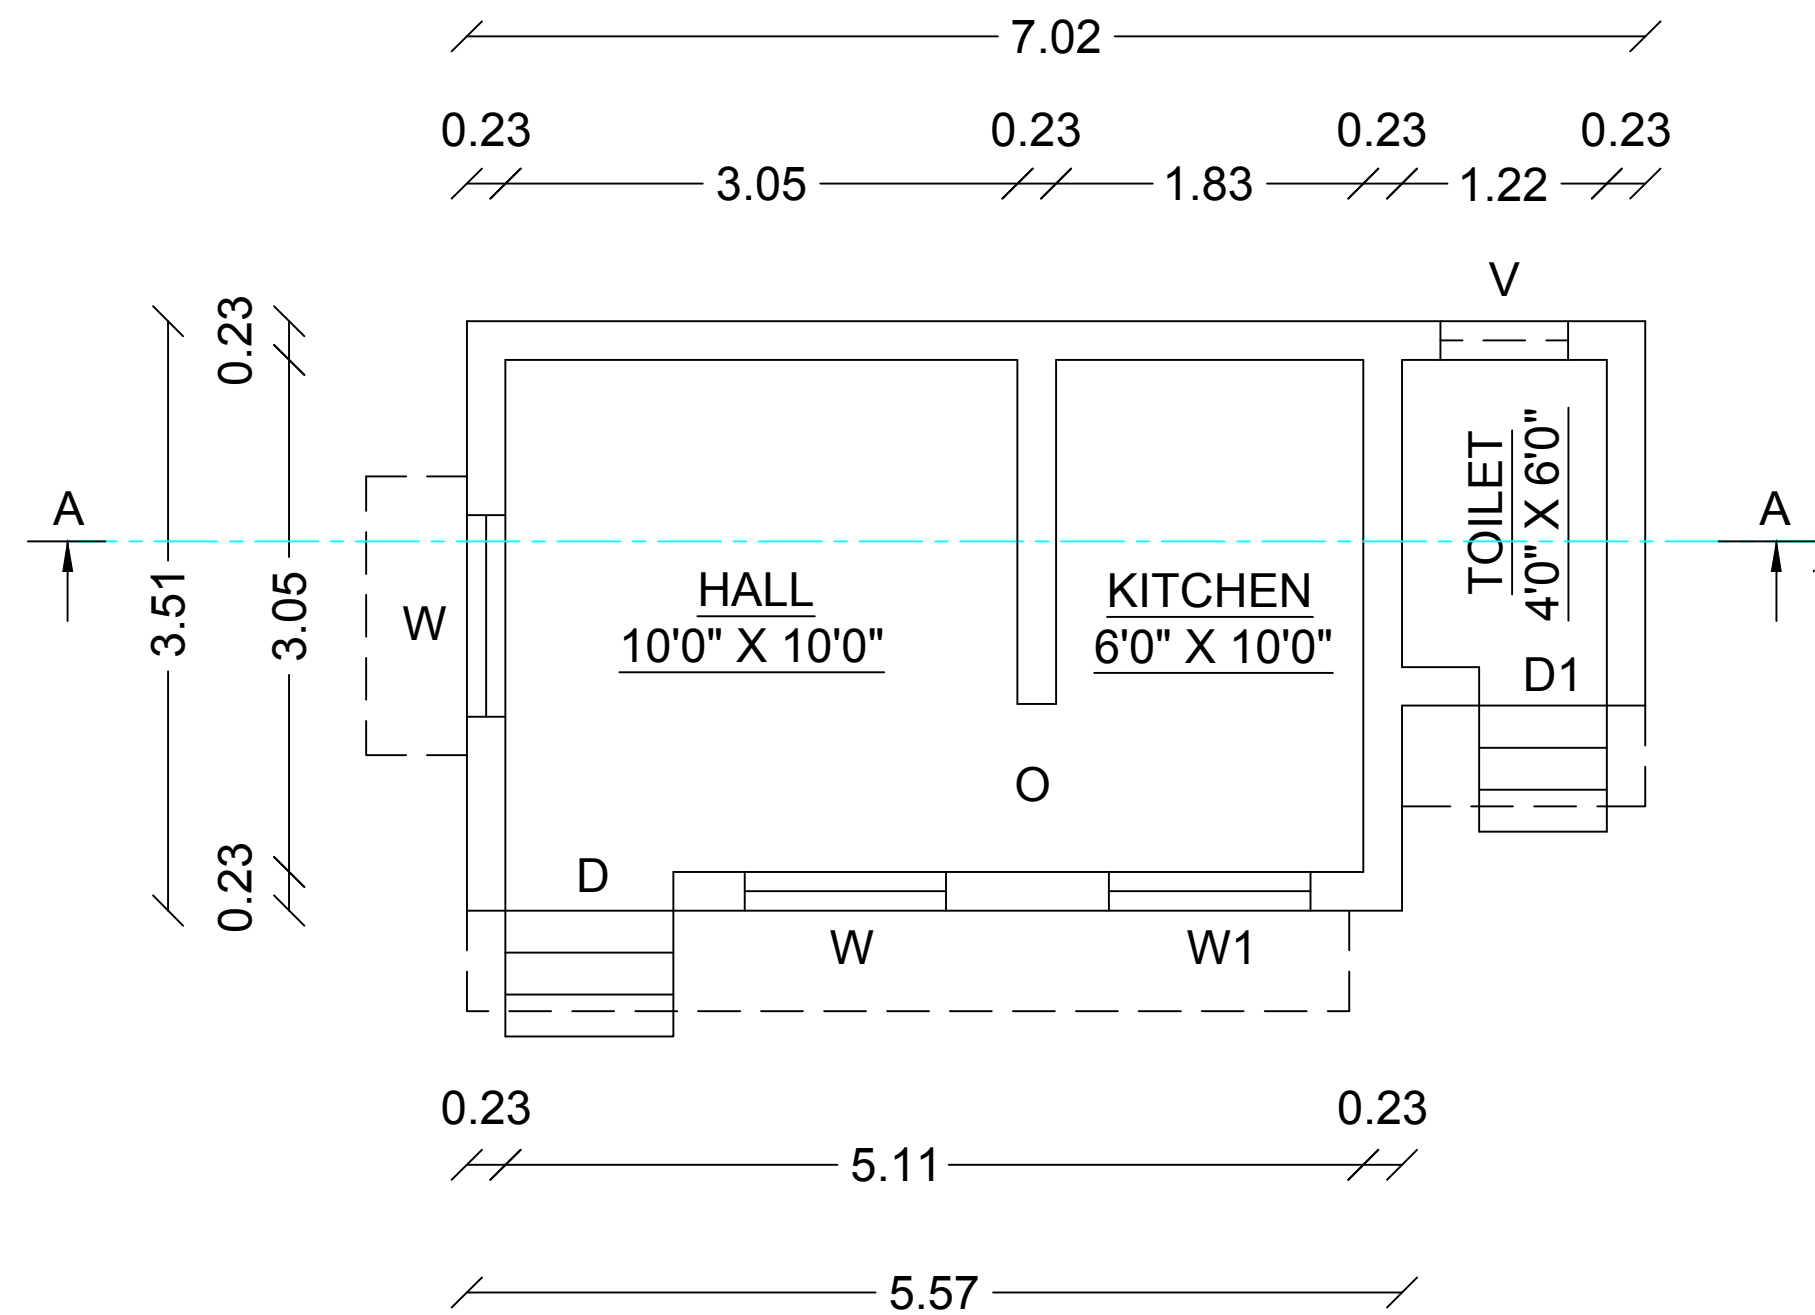


GROUND FLOOR PLAN

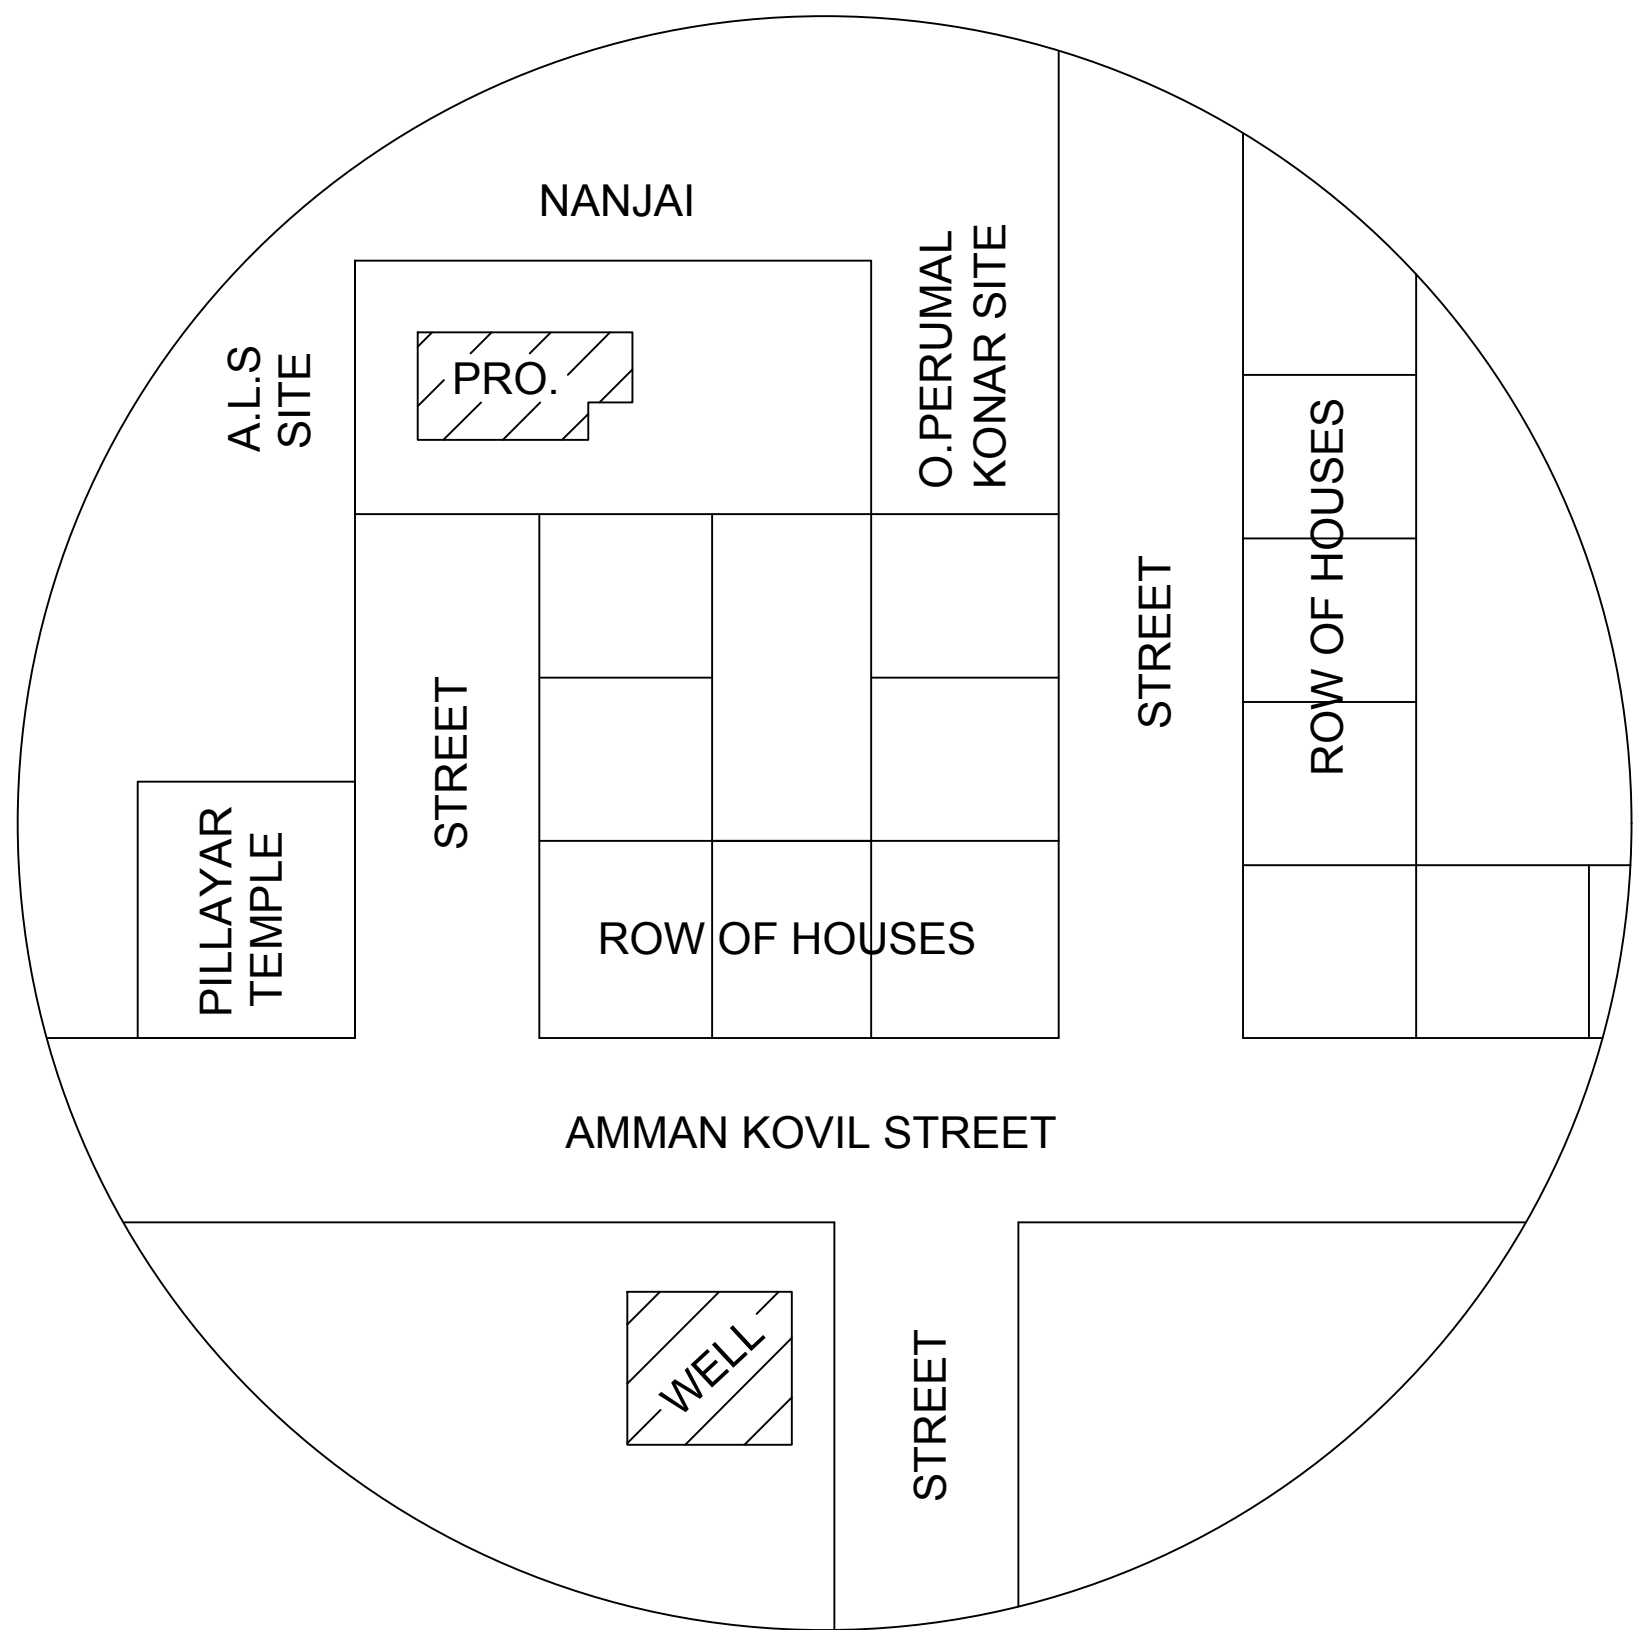


TOPO PLAN
SCALE = N.T.S

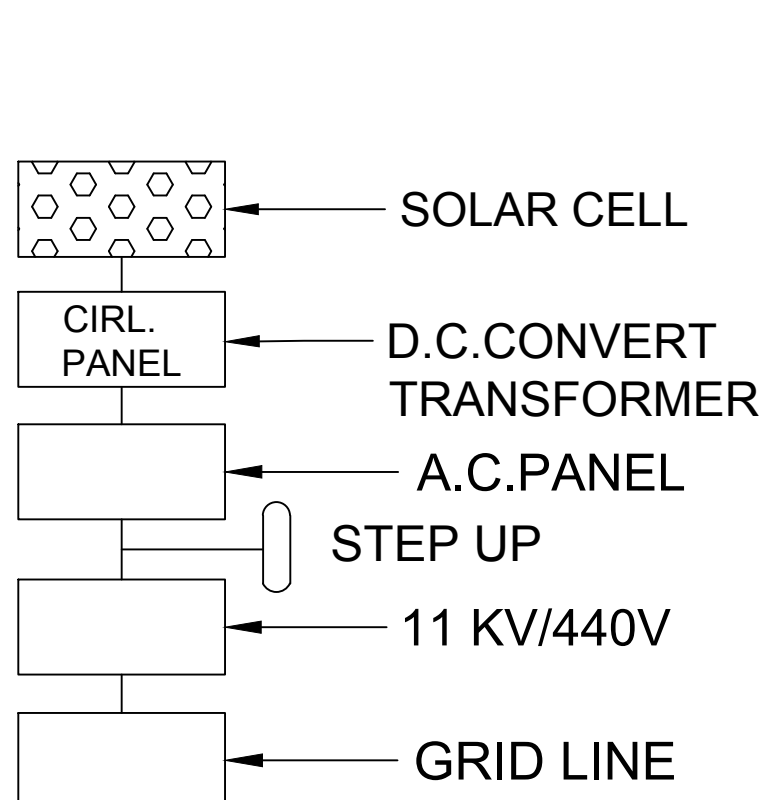

SOLAR SYSTEM
FLOW DIAGRAM

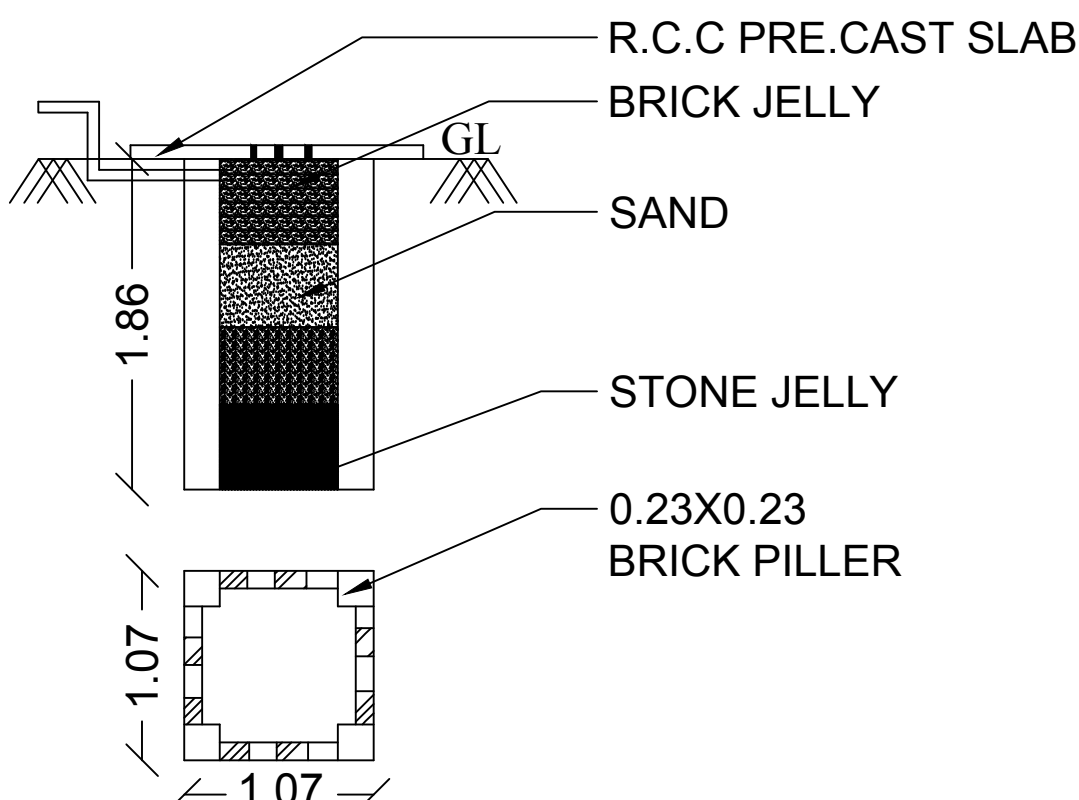


PLAN AND SECTION OF
RAINWATER COLLECTION
WELL

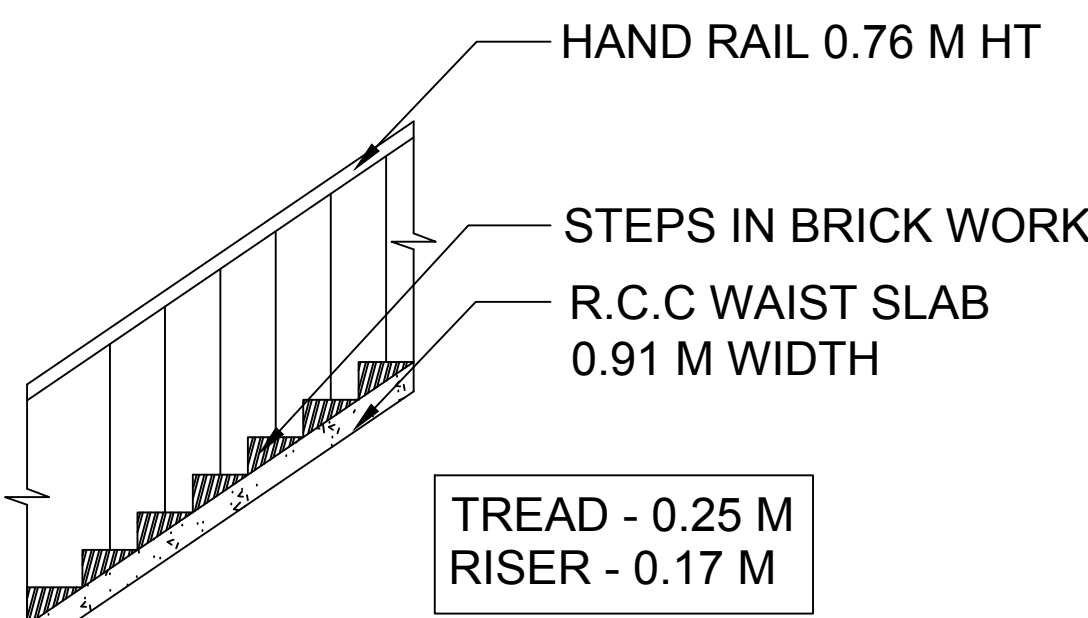

STEP DETAILS

A.L. SUBRAMANIAN SITE

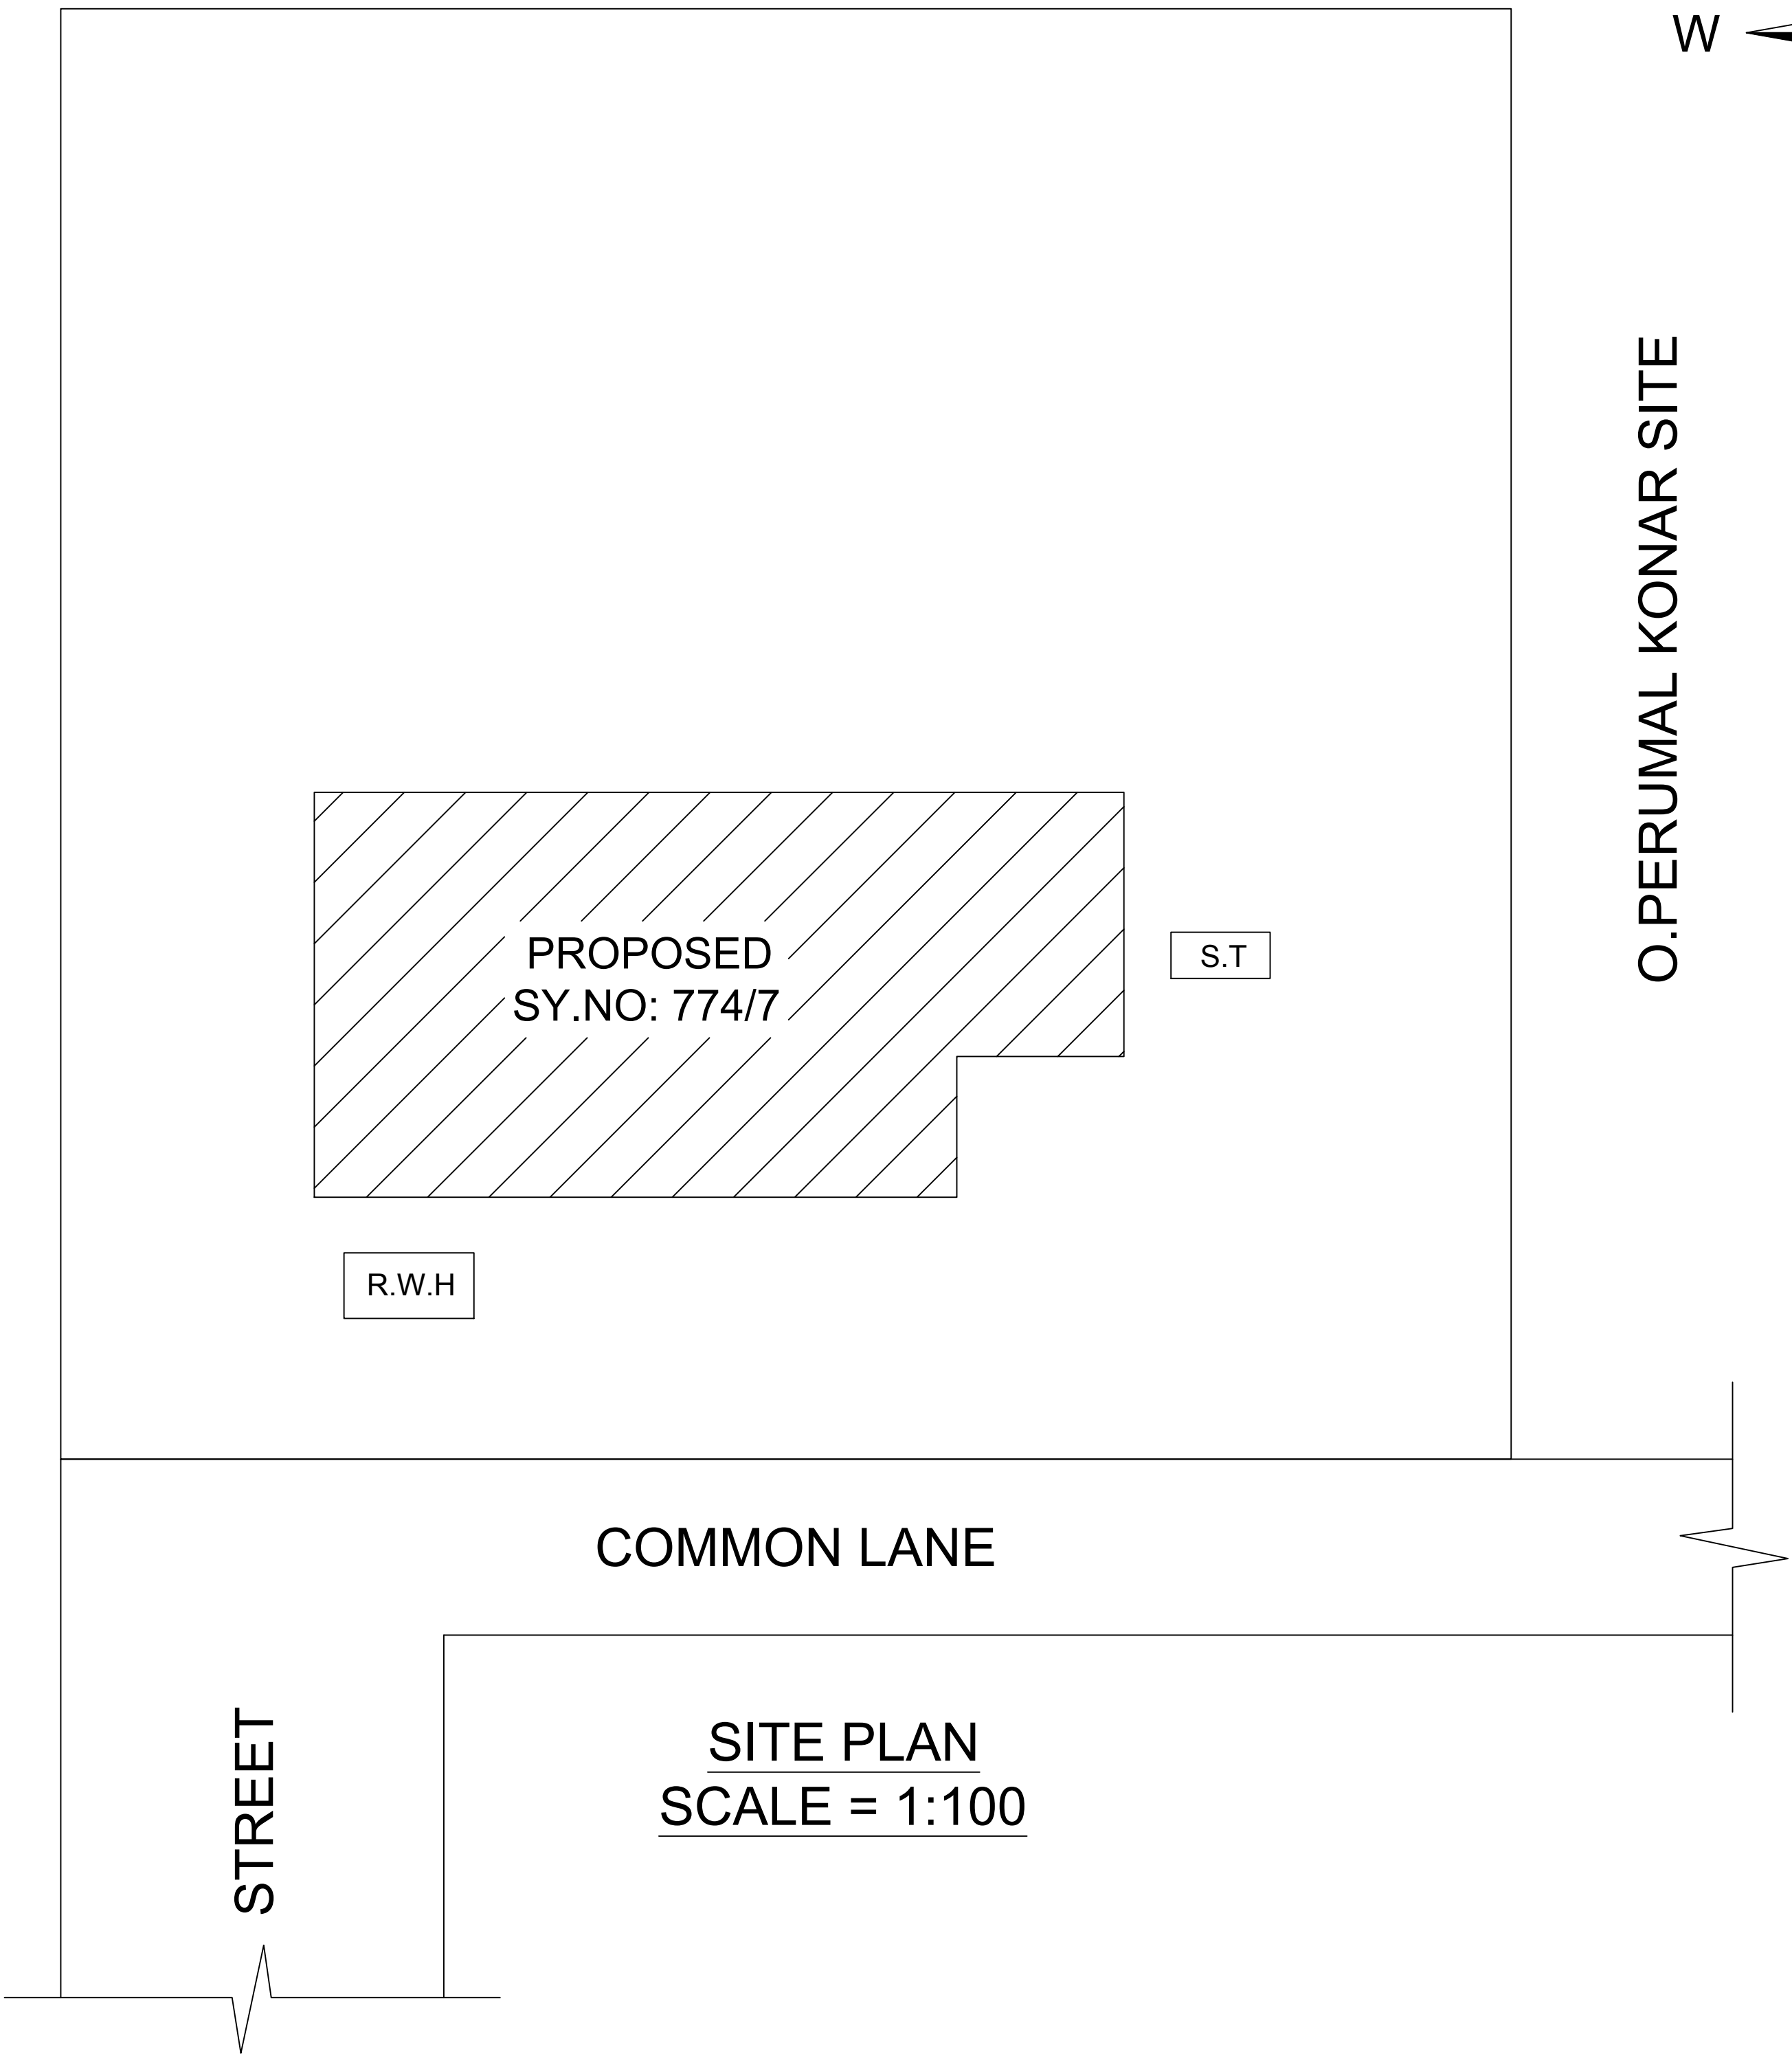

SITE PLAN
SCALE = 1:100

