

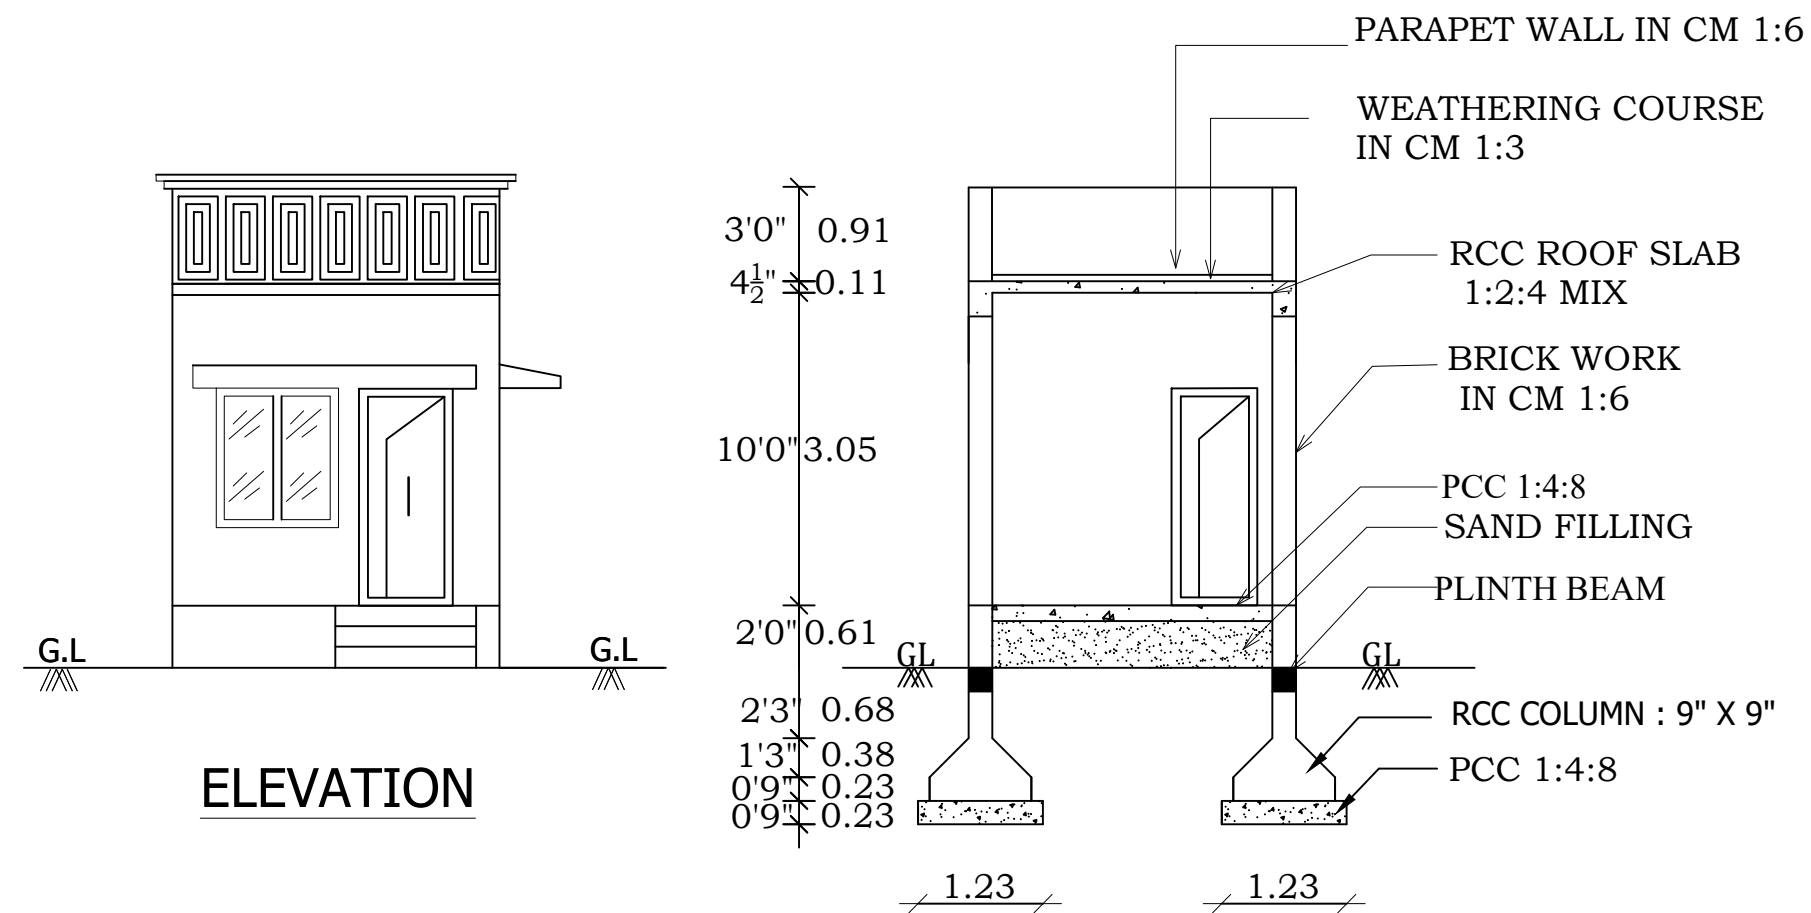



ALL DIMENSIONS ARE IN METER. SCALE 1 : 100

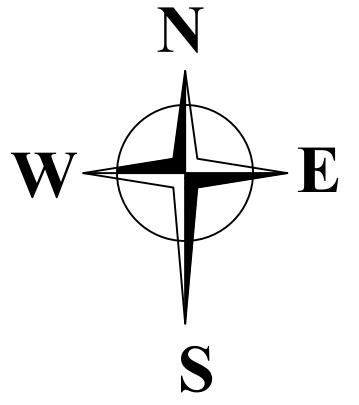


SECTION - AB

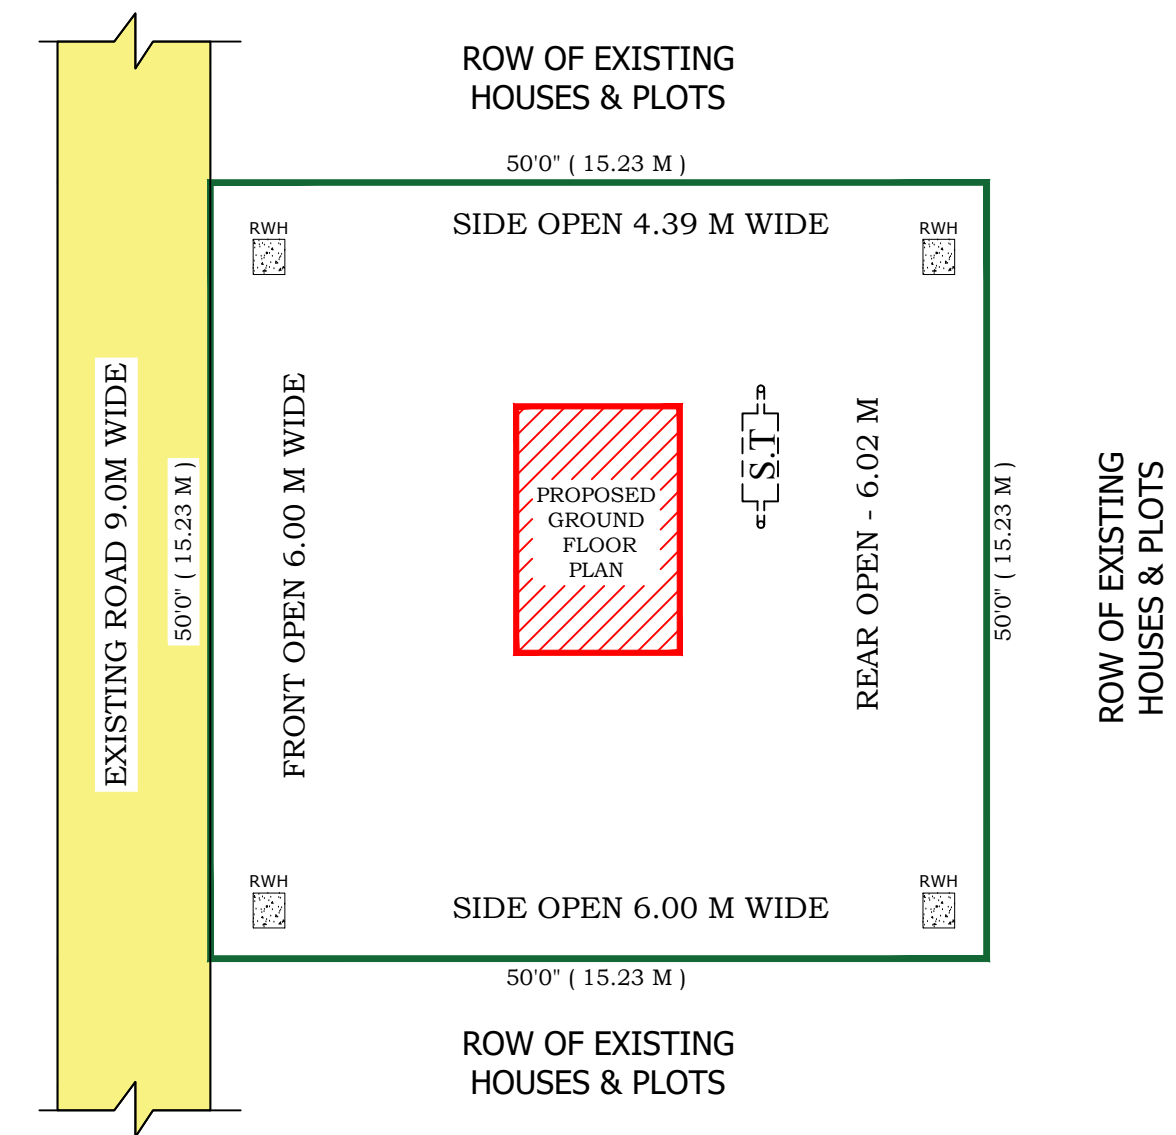


SITE PLAN
SCALE - 1:200

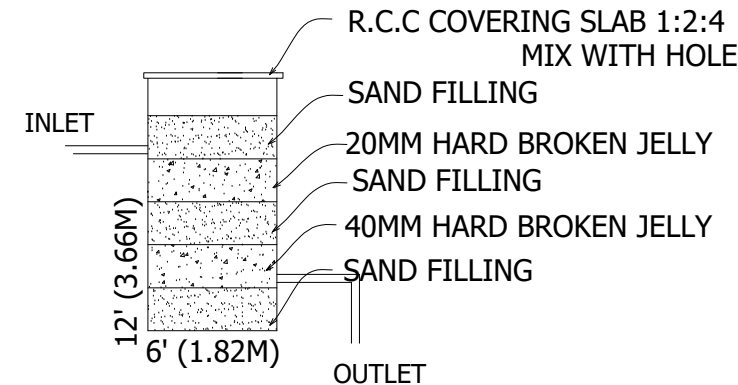


BATH & WASH BASIN PIPE LINE
CONNECTION IS DIRECTLY CONNECTED
TO THE RECTANGLE PIT FOR RECYCLING
THE WASTE WATER.

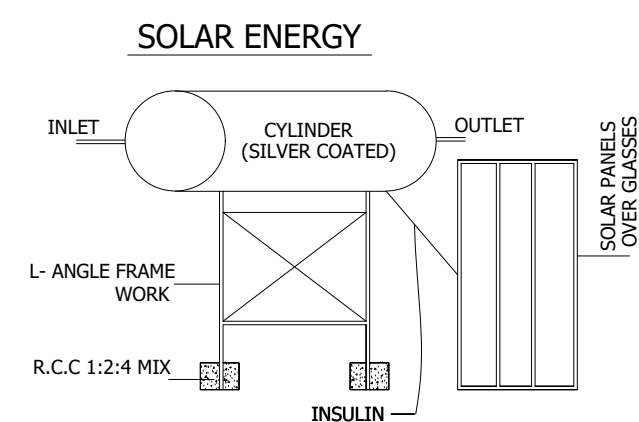


SOLAR ENERGY

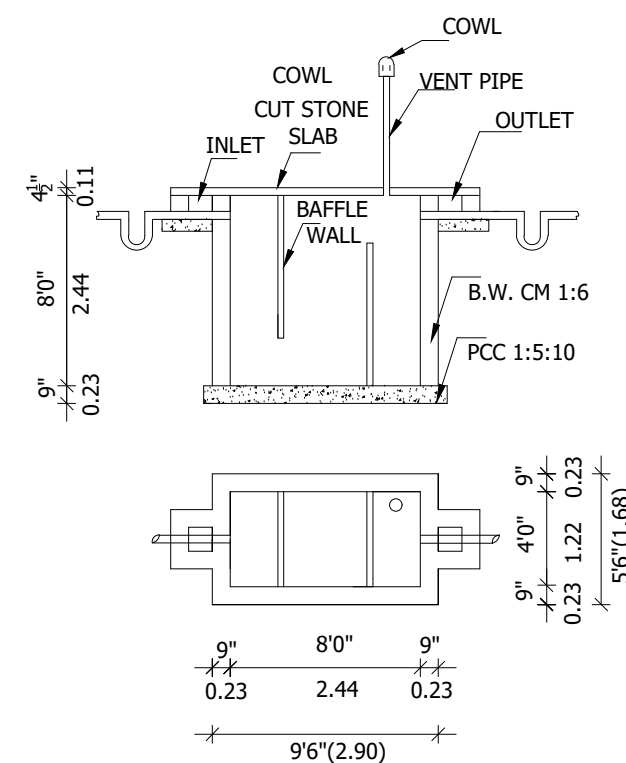

SEPTIC TANK DETAILS

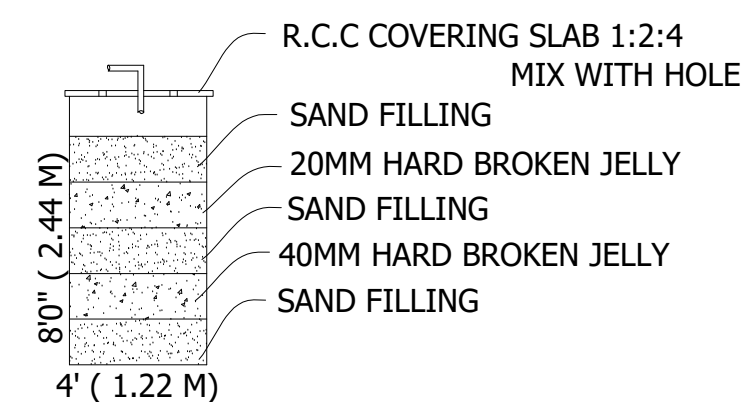

2NOS OF RWH UNIT WITH SIZE
4'0" x 4'0" x 8'0" USING 150MM DIA
PVC PIPE WITH NECESSARY FITTINGS.

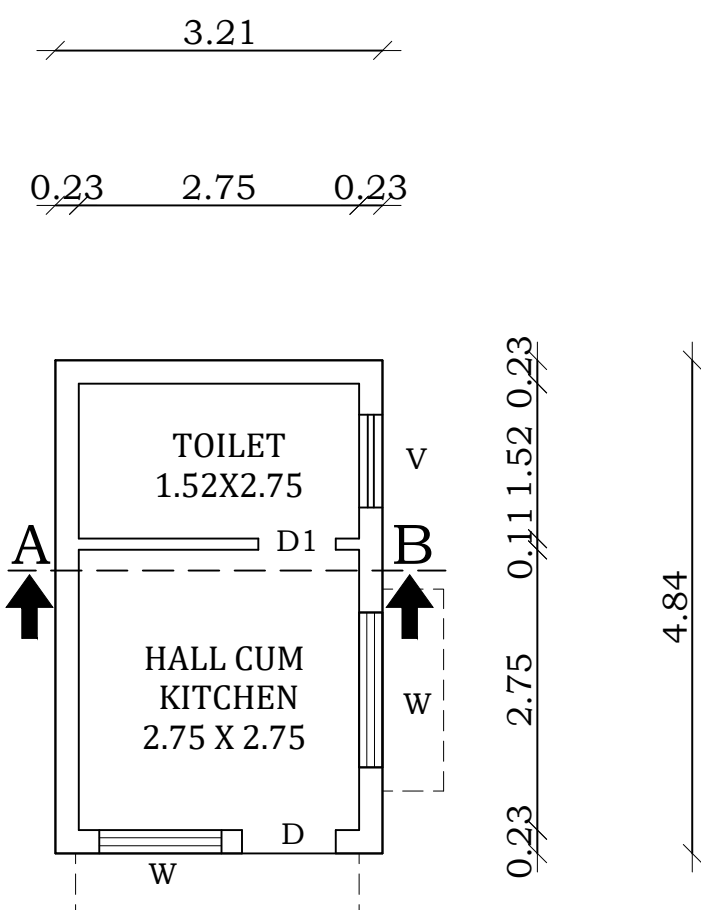

D FLOOR PLAN



NOTE

OWNERS BOUNDARY SHOWN IN -----
PROPOSED BUILDING SHOWN IN -----
EXISTING ROAD SHOWN IN -----

AREA DETAILS

AREA DETAILS	SQ.FT.	SQ.M.
TOTAL AREA OF THE SITE -----	2500.00	232.25
PROPOSED BUILDING IN G.F. AREA -----	167.00	15.53
OPEN SPACE AREA -----	2333.00	216.72

JOINERY DETAILS

MD -----	MAIN DOOR -----	3'6" X 7'0"	1.06 X 2.13 M
D-----	DOOR -----	3'0" X 7'0"	0.91 X 2.13 M
D1-----	DOOR -----	2'6" X 7'0"	0.76 X 2.13 M
W -----	WINDOW -----	5'0" X 5'0"	1.52 X 1.52 M
GW -----	GRILL WINDOW ---	5'0" X 5'0"	1.52 X 1.52 M
V -----	VENTILATOR -----	3'0" X 2'0"	0.91 X 0.61 M

SPCIFICATION

AS SHOWN IN SECTION ON - AB

APPLICANT NAME:-

Mr/Mrs.

தமிழ்


S. DHANEESH, D.C.D.C.E.,
Registered Engineer-Grade-III,
Reg. No. RE/G-I/III-01/2020
Deputy Director Town and Country Planning
(D.T.C.P.), Vellore - 632 001,
Cell No : 99945 27047

APPLICANT

ENGINEER

DRG. NO :

SD-10-03-2025