

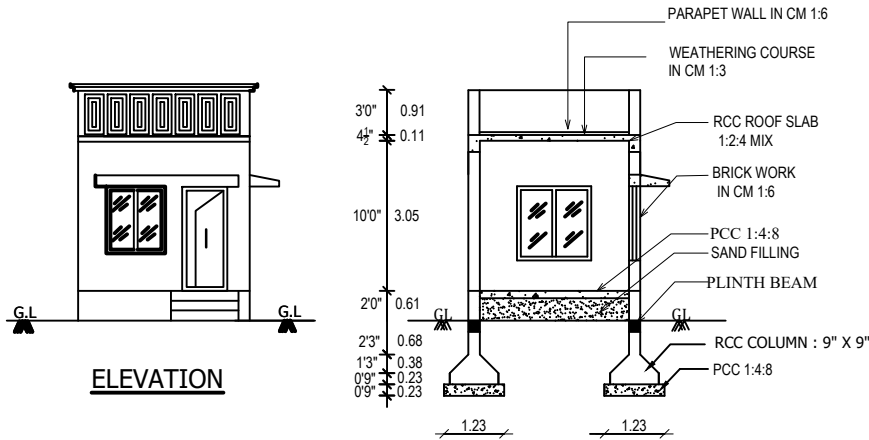



PLAN SHOWING THE PROPOSED CONSTRUCTION FOR RCC TERRACE ROOF RESIDENTIAL BUILDING IN GROUND FLOOR PLAN AT MAADUMAATHI NAGAR,
PLOT NO:21,22, S.F. NO: 28/2 NARAYANAKUPPAM VILLAGE & PANCHAYAT, THANDARAMPATTU TALUK, TIRUVANNAMALAI DISTRICT.
ALL DIMENSIONS ARE IN METER. SCALE 1 : 100

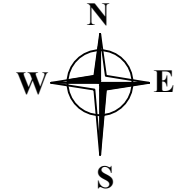


SECTION - AB

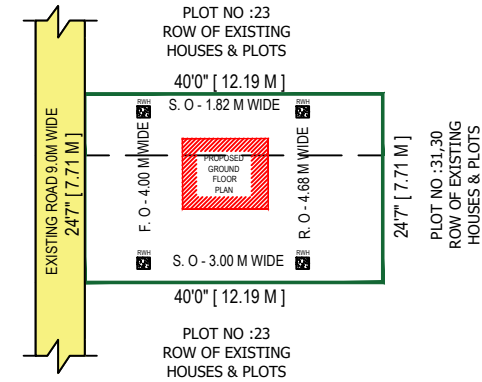

**SITE PLAN
SCALE - 1:200**

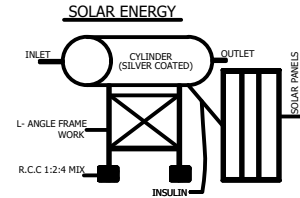


RAIN WATER HARVEST UNIT

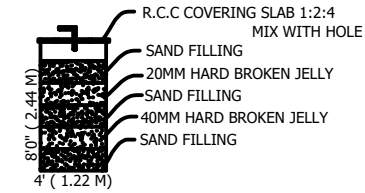


2NOS OF RWH UNIT WITH SIZE
 4'0" x 4'0" x 8'0" USING 150MM DIA
 PVC PIPE WITH NECESSARY FITTINGS.

WASTE WATER RECYCLE UNIT

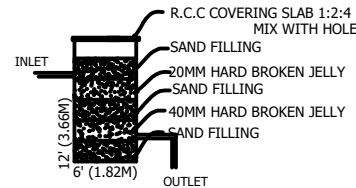

BATH & WASH BASIN PIPE LINE
 CONNECTION IS DIRECTLY CONNECTED
 TO THE RECTANGLE PIT FOR RECYCLING
 THE WASTE WATER.

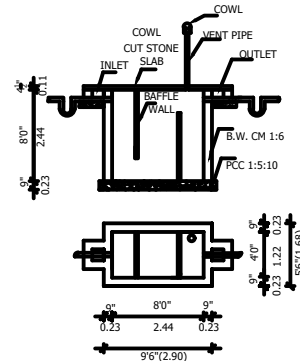

SEPTIC TANK DETAILS

NOTE

OWNERS BOUNDARY SHOWN IN -----
 PROPOSED BUILDING SHOWN IN -----
 EXISTING ROAD SHOWN IN -----



AREA DETAILS

	SQ.FT.	SQ.M.
TOTAL AREA OF THE SITE	990.00	91.97
PROPOSED BUILDING IN G.F. AREA	109.00	10.14
OPEN SPACE AREA	881.00	81.83

JOINERY DETAILS

MD	MAIN DOOR	3'0" X 7'0"	0.91 X 2.13 M
W	WINDOW	5'0" X 5'0"	1.52 X 1.52 M
GW	GRILL WINDOW	3'9" X 5'0"	1.20 X 1.52 M

SPECIFICATION

AS SHOWN IN SECTION ON - AB

APPLICANT NAME:-

Mr/Ms.

Ganesh

S. DHANESH, O.C.D.C.E.
 Registered Engineer-Grade-III,
 Reg. No. REG-01010203
 Deputy Director Town and Country Planning
 (D.T.C.P.) Villavakkam - 632 001,
 Cell No. 98945 27047

DRG. NO :
 SD-52-04-2025

APPLICANT

ENGINEER