

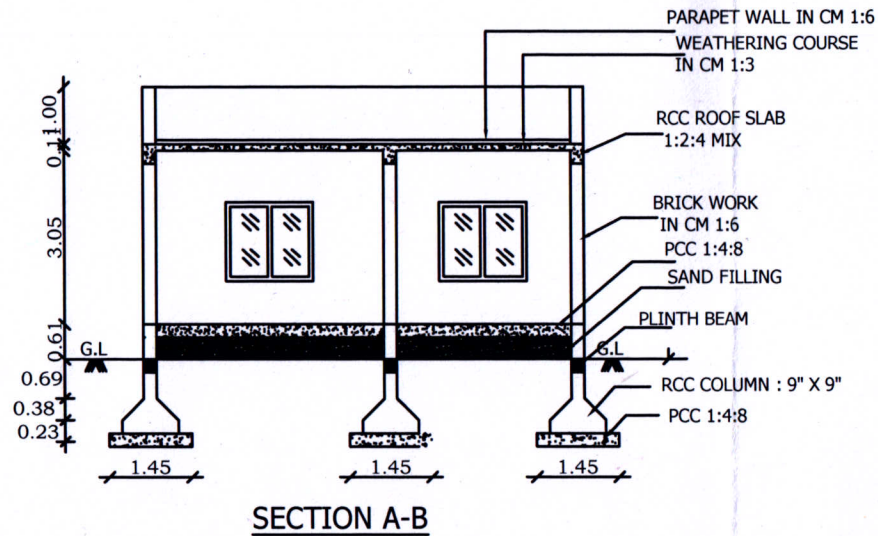


PLAN SHOWING THE PROPOSED CONSTRUCTION FOR RCC TERRACE ROOF RESIDENTIAL BUILDING IN GROUND FLOOR PLAN
AT PLOT NO: 3, S.F.NO : 489/1F2A1 & 489/3, ADUKKAMPARAI VILLAGE & PANCHAYAT, VELLORE TALUK & DISTRICT.
ALL DIMENSIONS ARE IN FEET (OR) METER. SCALE 1 : 100




OFFICE USE:-

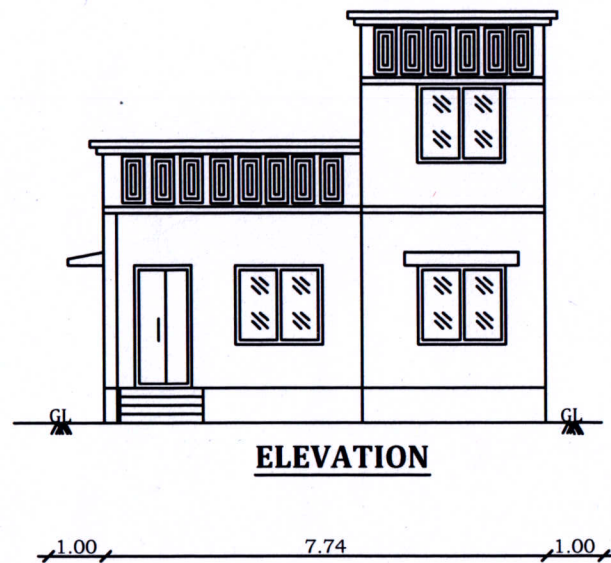


RAIN WATER HARVEST UNIT

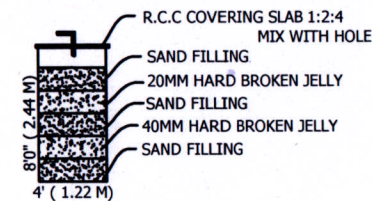


2NOS OF RWH UNIT WITH SIZE
4'0" x 4'0" x 8'0" USING 150MM DIA
PVC PIPE WITH NECESSARY FITTINGS.

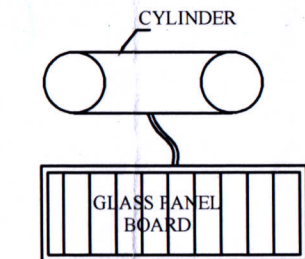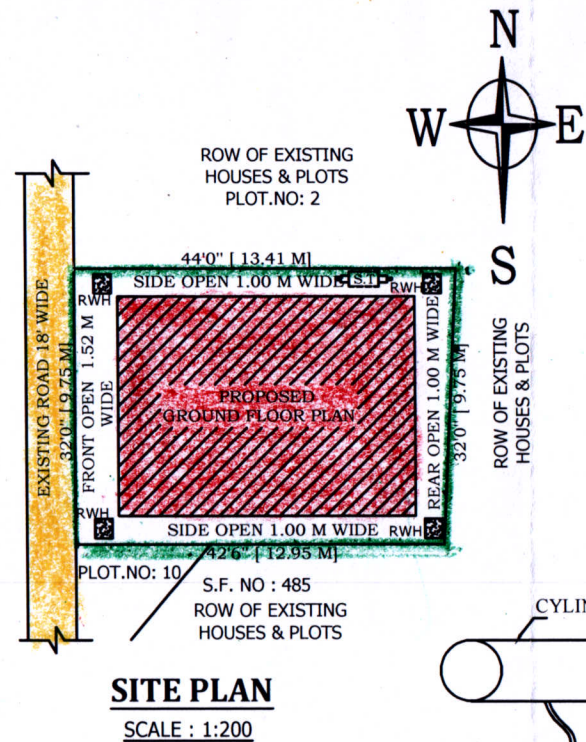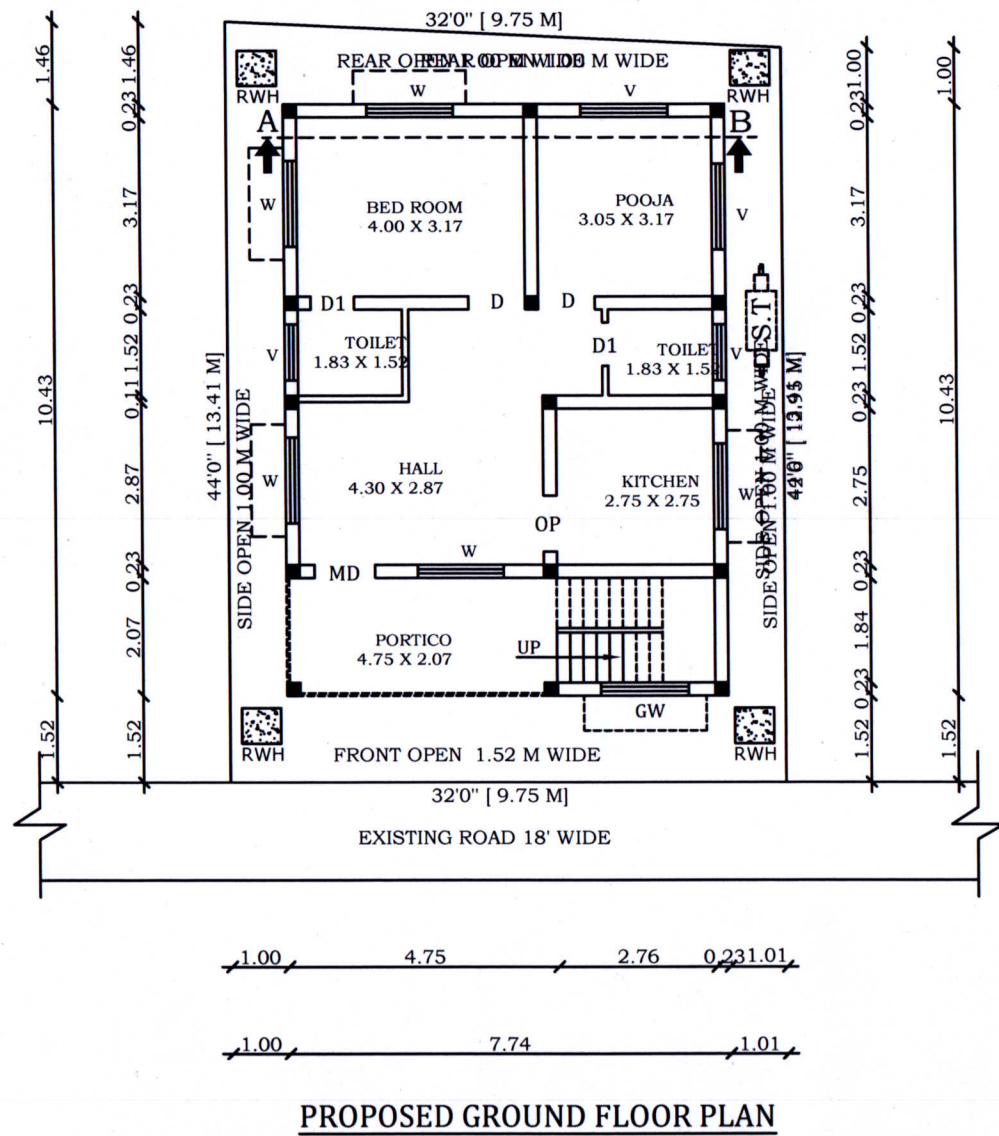

SOLAR ENERGY PLANT
(NOT TO SCALE)

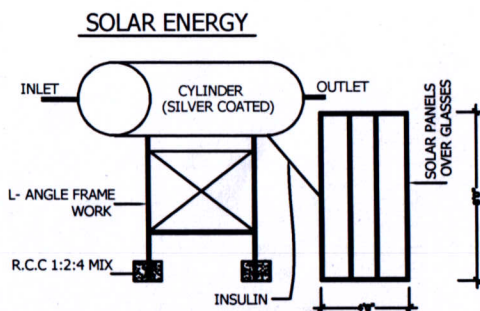

WASTE WATER RECYCLE UNIT

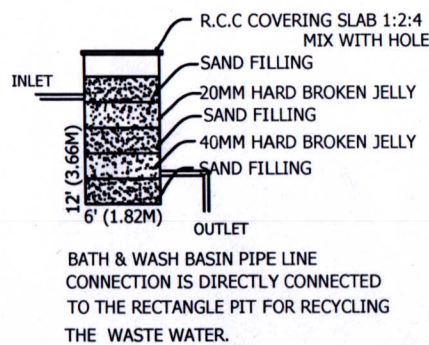

NOTE

OWNERS BOUNDARY SHOWN IN -----
PROPOSED BUILDING SHOWN IN -----
EXISTING ROAD SHOWN IN -----

AREA DETAILS

	SQ.FT.	SQ.M.
TOTAL AREA OF THE SITE	1384.00	128.58
PROPOSED BUILDING IN G.F. AREA	869.00	80.73
OPEN SPACE AREA	515.00	47.85

JOINERY DETAILS

MD	MAIN DOOR	3'6" X 7'0"	1.06 X 2.13 M
D	DOOR	3'0" X 7'0"	0.91 X 2.13 M
D1	DOOR	2'6" X 7'0"	0.76 X 2.13 M
W	WINDOW	5'0" X 4'6"	1.52 X 1.37 M
GW	GRILL WINDOW	5'0" X 4'6"	1.52 X 1.37 M
V	VENTILATOR	3'0" X 2'0"	0.91 X 0.61 M

SPECIFICATION

AS SHOWN IN SECTION ON - AB

APPLICANT NAME:-

Mr/Mrs.

B. Sathish
B. Pankaj

Er. S. DHANESH, D.C.D.
Registered Engineer-Grade-III
Reg. No. RE/Gr-III/01/2020
Deputy Director Town and Country P
(D.T.C.O.), Vellore - 632 001.
Cell No : 99945 27047

DRG. NO :
SD-03-01-24

APPLICANT

ENGINEER