


PLAN SHOWING PROPOSED CONSTRUCTION OF R.C.C AND A.C.C SHEET ROOF RESIDENTIAL SISTERS HOME BUILDING IN R.S. NO - 121/1, OLD SURVEY NO - 121/1 ,
PATTA NO - 372, AT NAVAMMAL KAPPER VILLAGE AND PANCHAYAT, KANDAMANGALAM PANCHAYAT UNION, VILLUPURAM TALUK, VILLUPURAM DISTRICT.

APPLICANT NAME:- THE PRESIDENT (NIRMALA NOVITIATE).


[SCALE -1:100]

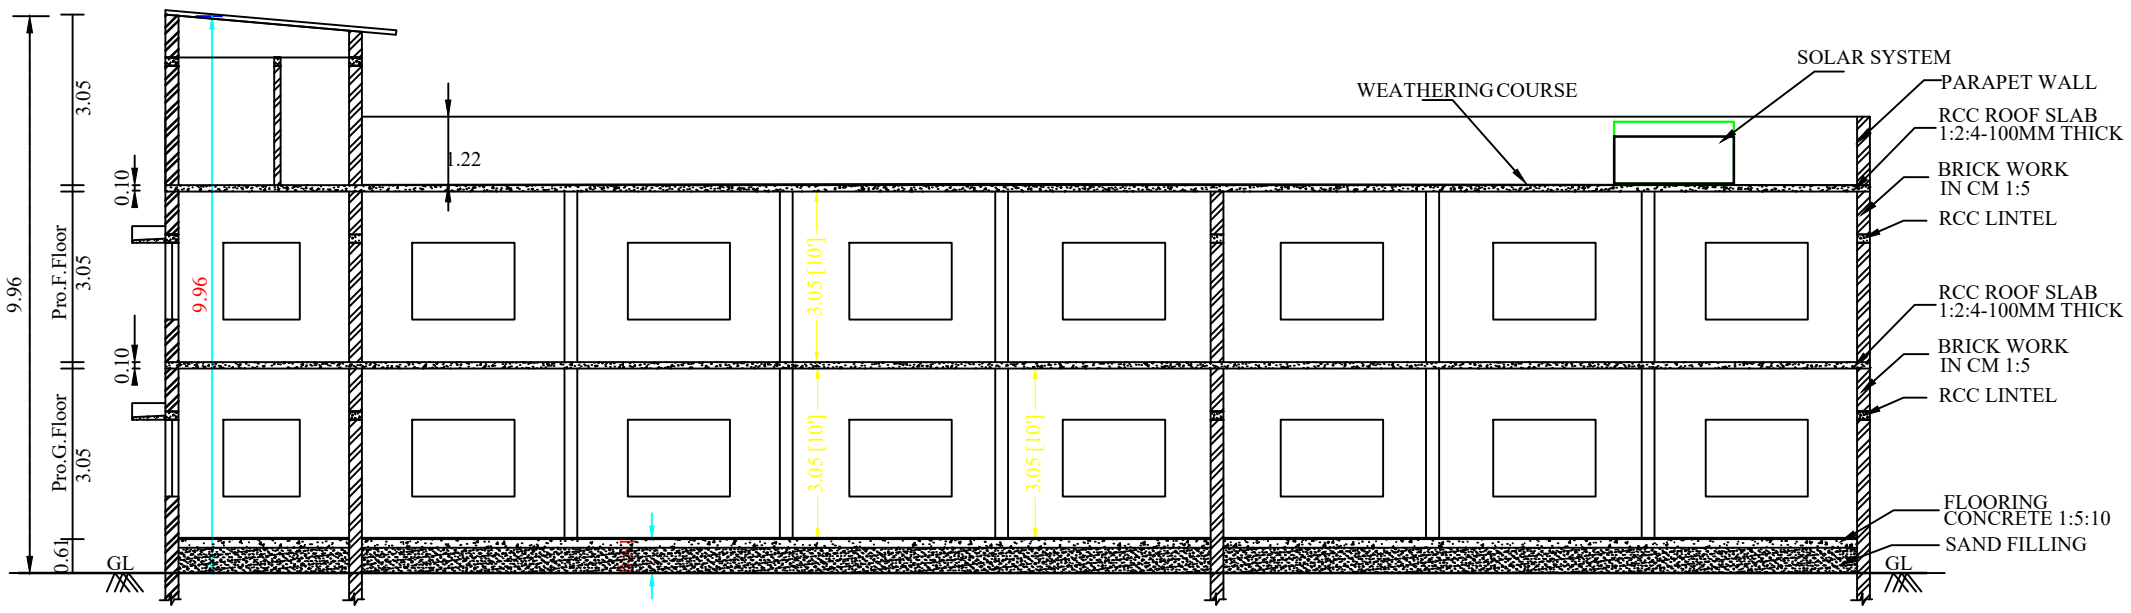


SECTION ON X-X'




ELEVATION

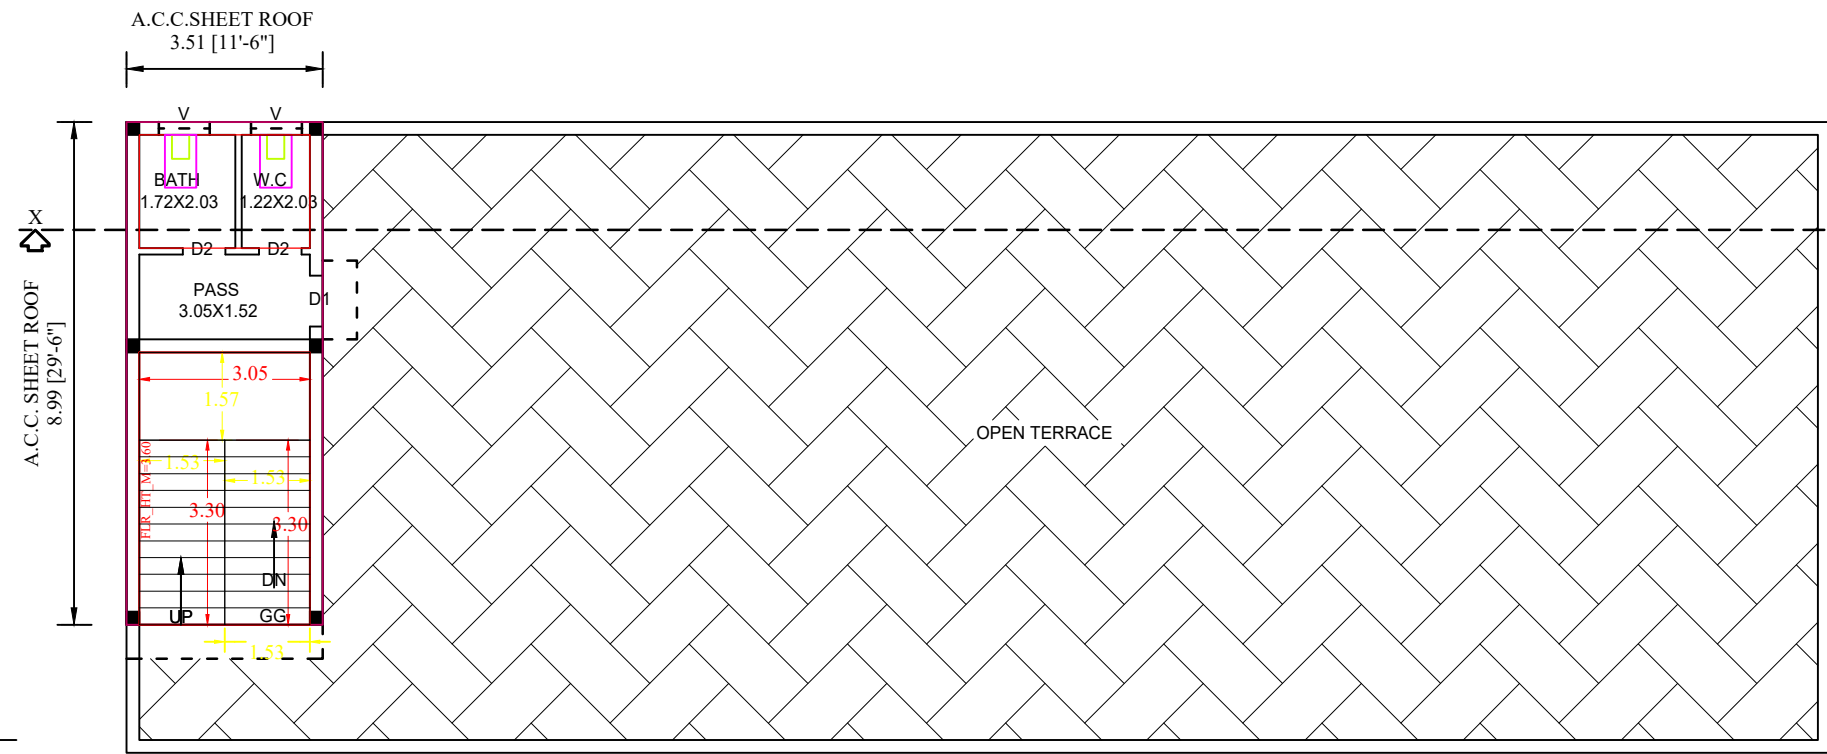


HEAD ROOM AND TERRACE FLOOR PLAN

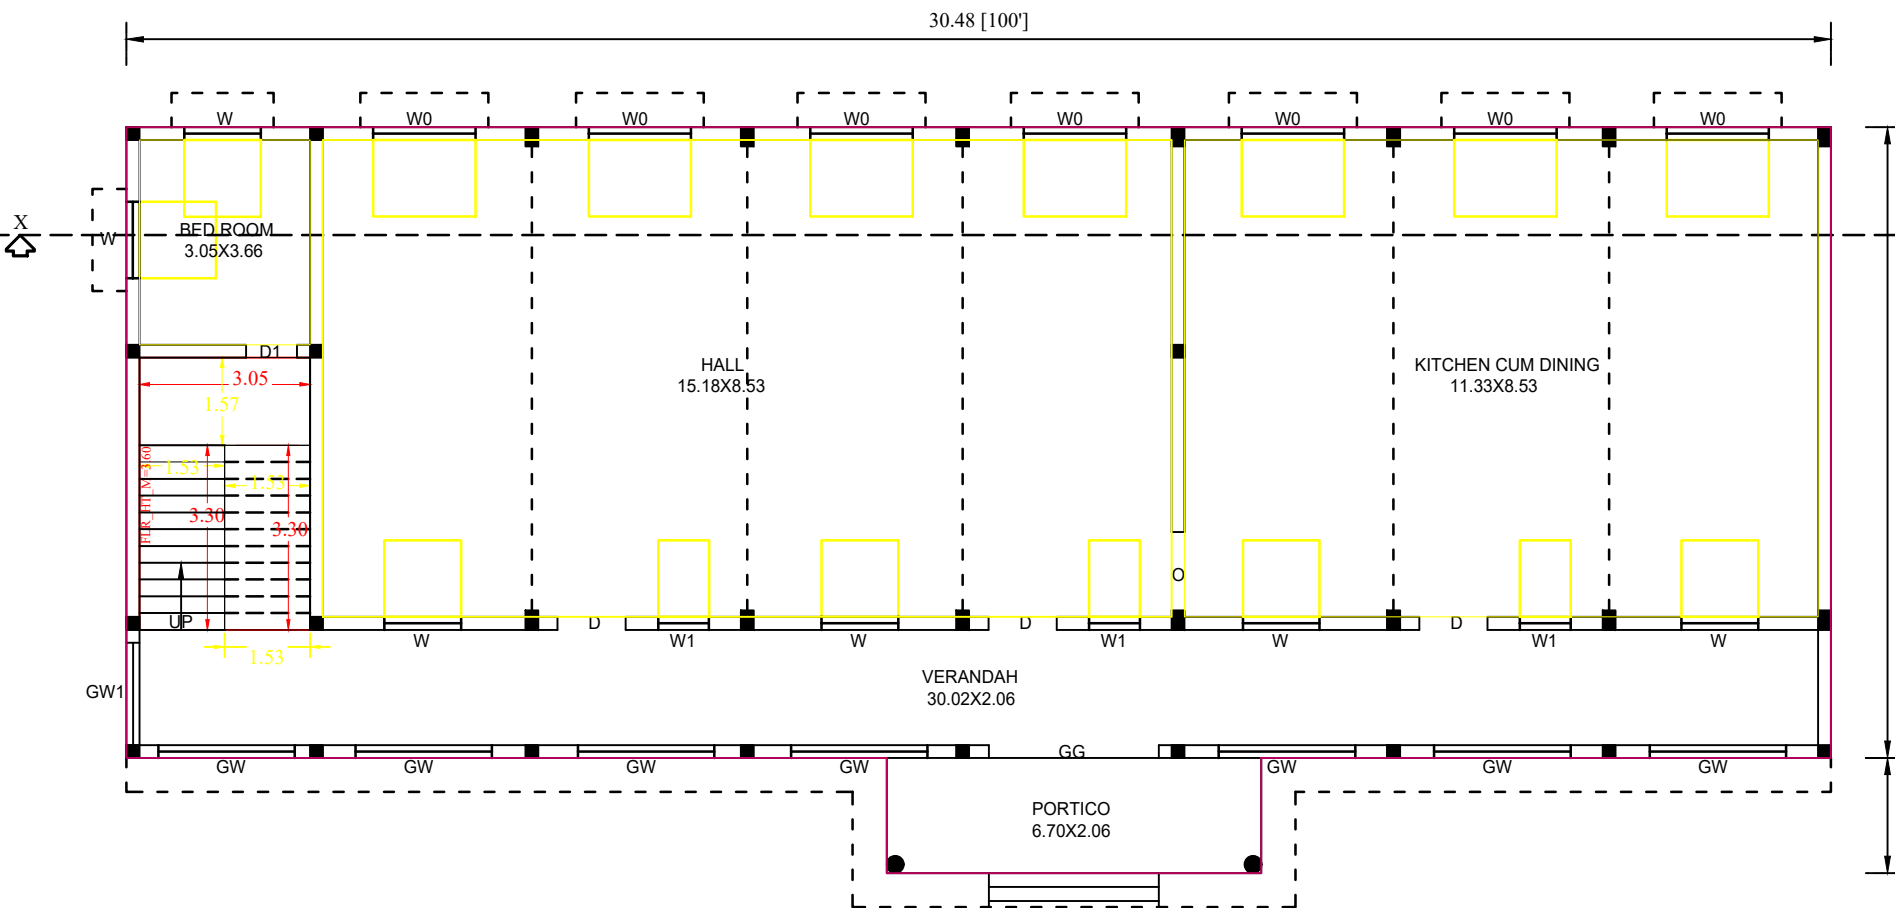


GROUND FLOOR PLAN

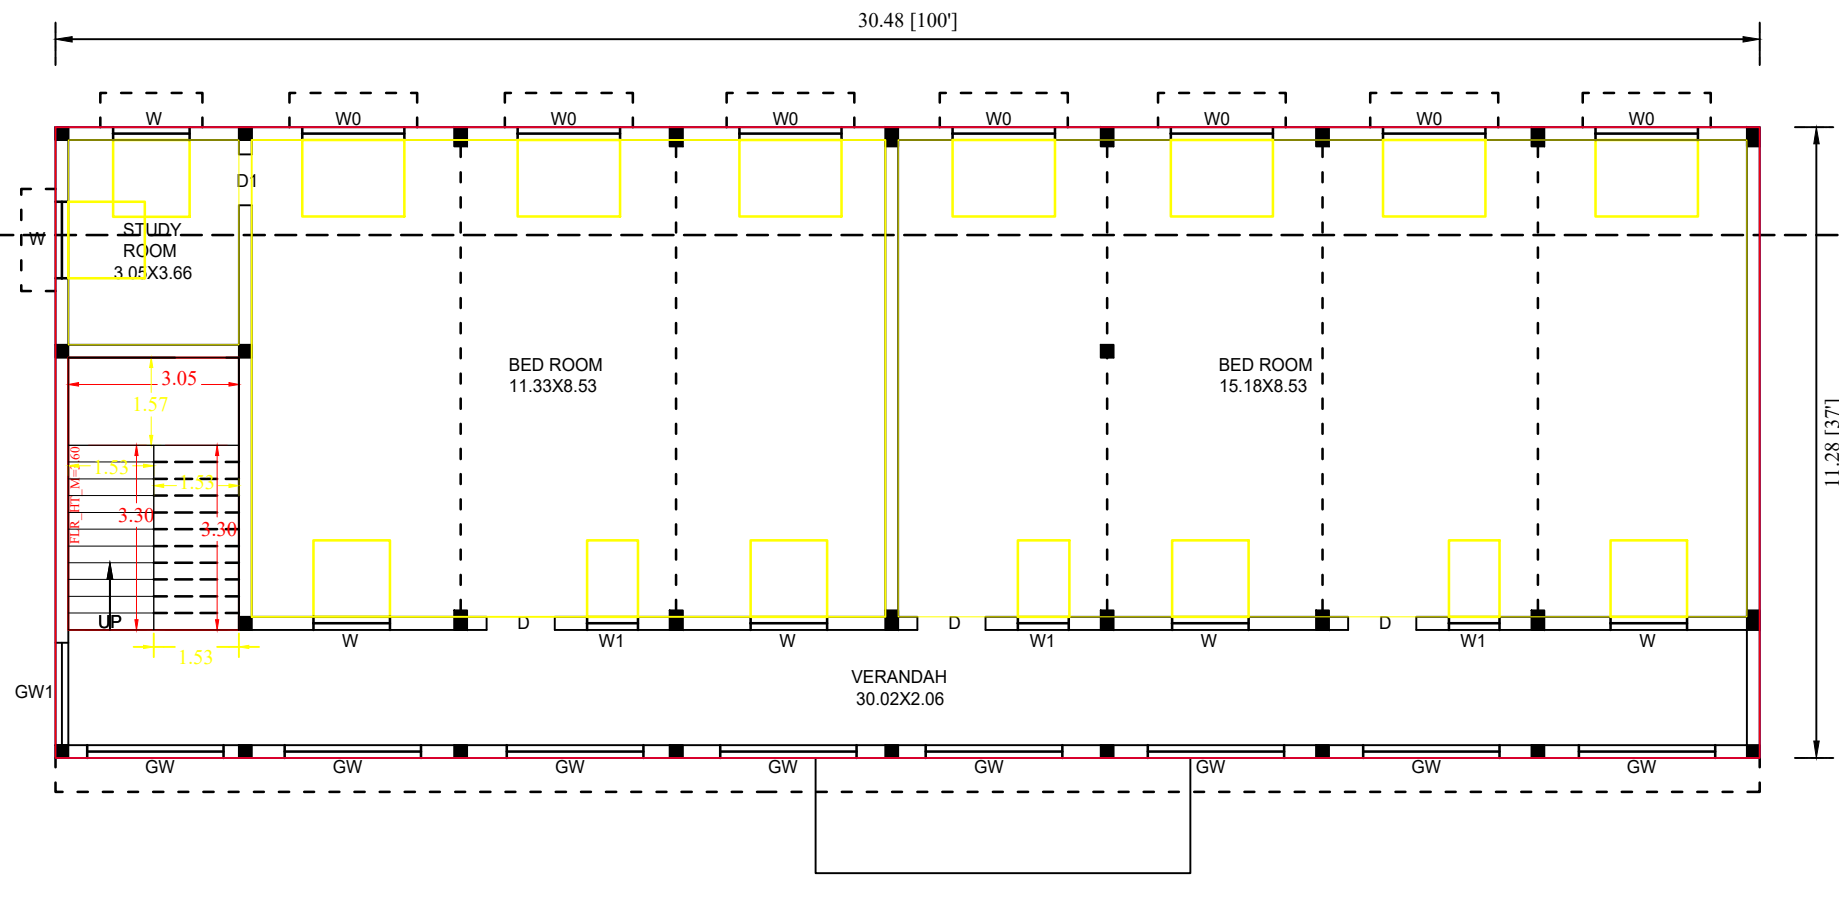


FIRST FLOOR PLAN

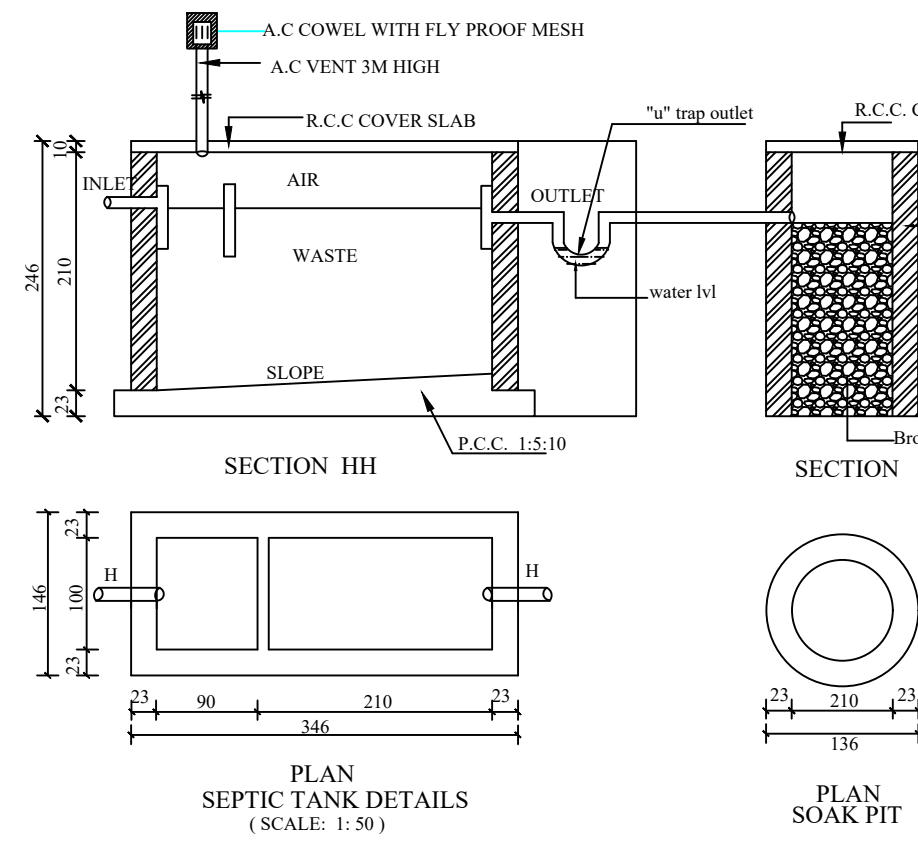


PLAN SEPTIC TANK DETAILS (SCALE: 1:50)

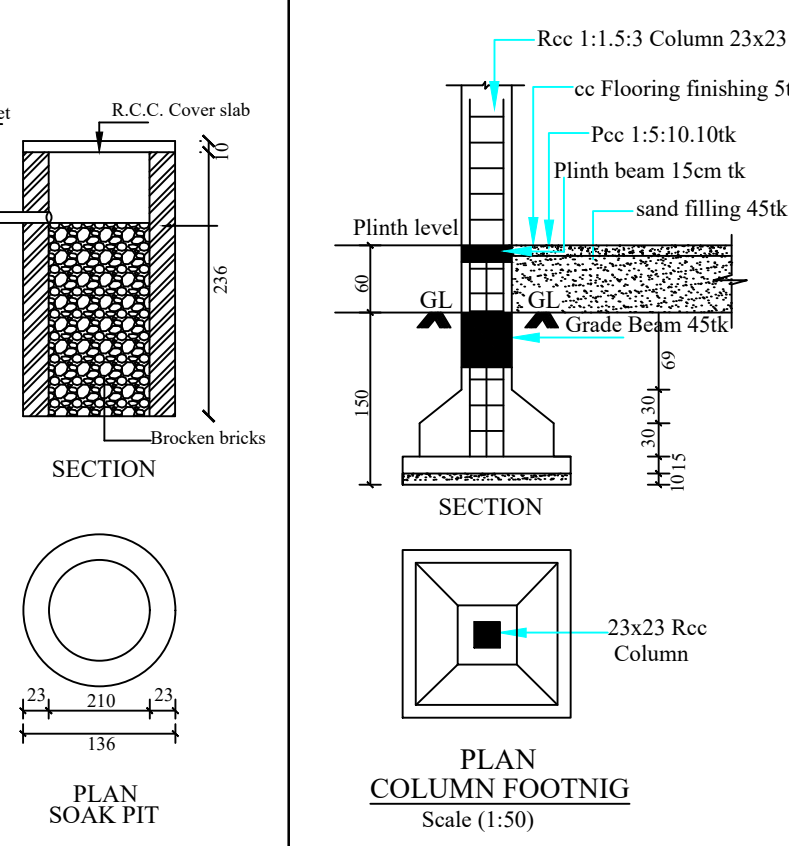


PLAN COLUMN FOOTING Scale (1:50)

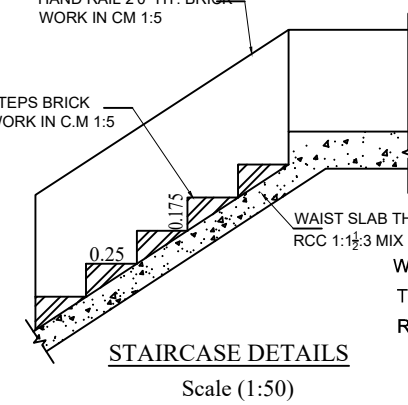

STAIRCASE DETAILS Scale (1:50)

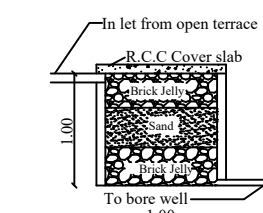


RAIN WATER HARVEST PIT

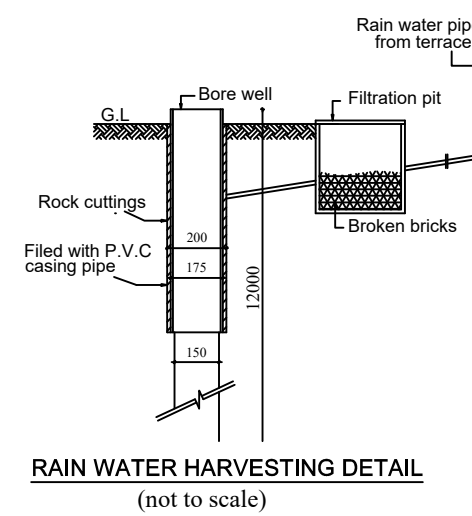

RAIN WATER HARVESTING DETAIL (not to scale)

SITE PLAN
SCALE - 1:400

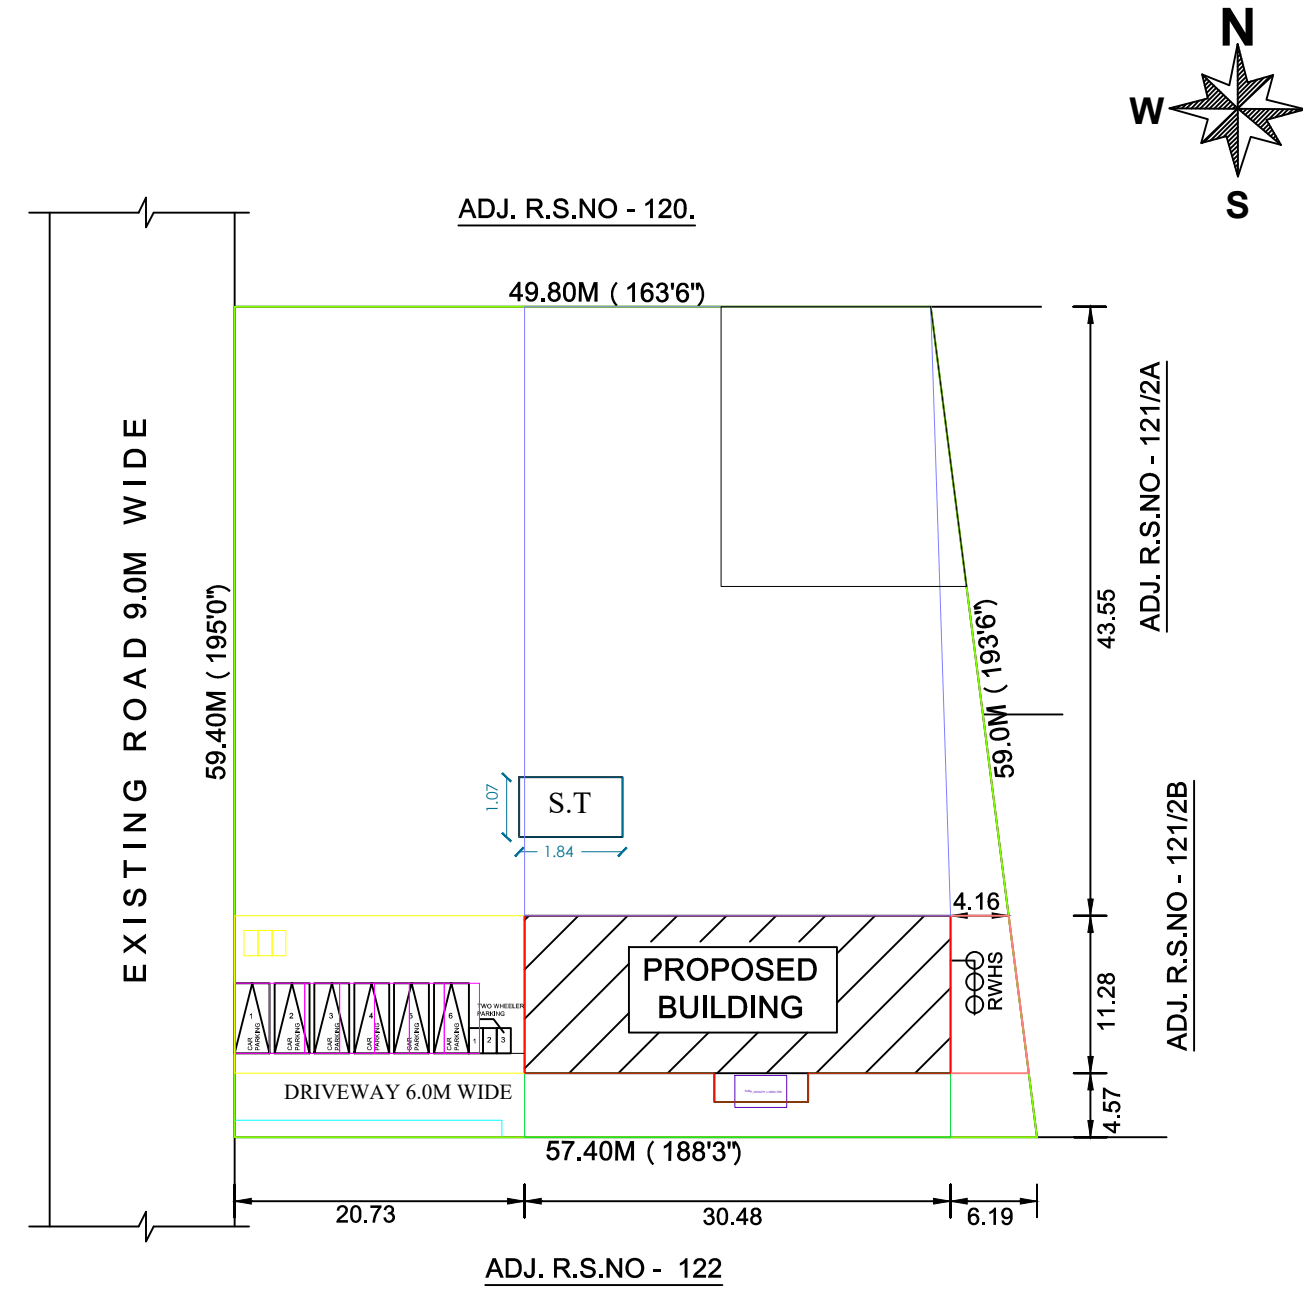

AREA DETAILS:

S.NO	DESCRIPTION	AREA IN SQ. M	AREA IN SQFT
1.	PLOT AREA (as per Document)	3157.00	33977.00
2.	PLOT AREA (as per Patta)	3150.00	33907.00
3.	PRO. G.F. AREA	357.62	3849.00
4.	PRO. F.F. AREA	343.81	3700.00
5.	PRO. HEAD ROOM	31.55	339.00
6.	TOTAL AREA	732.98	7888.00
7.	OPEN AREA	2792.38	30058.00
8.	P.C (357.62/3150.00)		11.35
9.	F.S.I (732.98/3150.00)		0.23
10.	CAR PARKING		7Nos
11.	TWO WHEELER PARKING		3Nos


REFERENCE:

S.NO	DESCRIPTION	TYPE	SIZE
1.	MAIN DOOR	MD	1.22 X 2.10
2.	DOOR	D1	0.91 X 2.10
3.	DOOR	D2	0.76 X 2.10
4.	GRILL WINDOW	GW	1.83 X 1.37
5.	WINDOW	W0	1.83 X 1.37
6.	WINDOW	W	1.37 X 1.37
7.	VENTILATOR	V	0.91 X 0.61

NOTES:

1. ALL DIMENSIONS ARE IN "METRE"
2. THE EXHAUST FAN IS PROVIDED AT KITCHEN
3. THE SINK & BATH WATER IS CONNECTED TO ORGANIC FILTRATION BED.
4. THE WASTE WATER FROM KITCHEN AND BATH WILL BE RECHARGED IN RAIN WATER PIT AS PER RULE NO.17A.
5. THE RAIN WATER IS CONNECTED TO RAIN WATER PERCOLATION PITS.
6. PROVISION MADE FOR SOLAR WATER HEATER.
7. SEWAGE LINE SHOULD BE CONNECTED IN THE EXT.UGD.
8. "U" TRAP WILL BE PROVIDED IN ALL OUTLETS.

KEY PLAN
SCALE - NTS

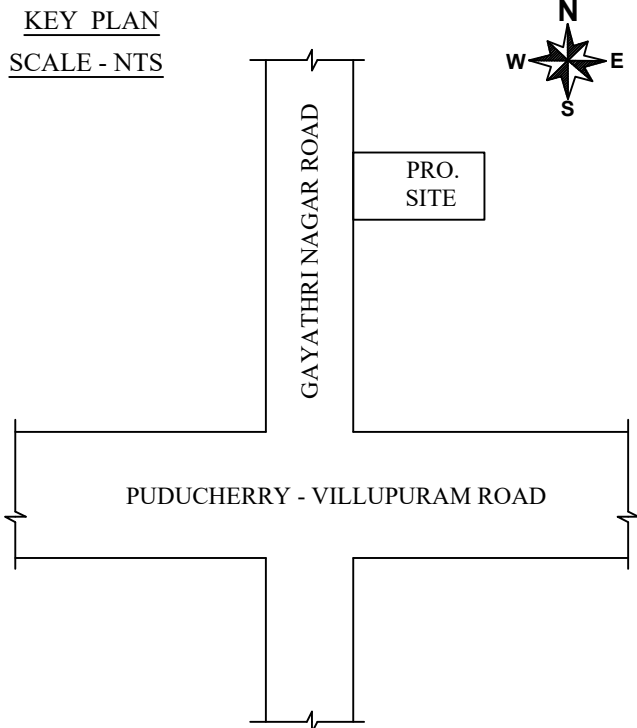

APPLICANT

Sr. Jeyamary Lourdu Swamy

(Sr.JEYAMARY LOURDUSWAMY - PRESIDENT)

REGISTERED ENGINEER

Er. M. ARAVIND, M.E., AMIE.,
GRADE-III-REGISTERED ENGINEER
CUDDALORE MUNICIPAL CORPORATION
Reg. No. 093/LS/2023/0001
ARAVIND STRUCTURES
No. 99, Meenatchi Pettai Street,
C.N.Palayam, Cuddalore-607 102
Cell: 97915 48224

