



PLAN SHOWING THE PROPOSED CONSTRUCTION OF INDUSTRIAL BUILDING (MANUFACTURING UNIT) UNDER GREEN INDUSTRIES , S.NO:257/5A, POOTHURAI VILLAGE, VANUR PANCHAYAT UNION,VANUR TALUK , VILLUPURAM DISTRICT.

APPLICANT NAME: K.VIDJERAGAVANE S/O KRISHNAN


ALL DIMENSIONS ARE IN METER SCALE 1:100

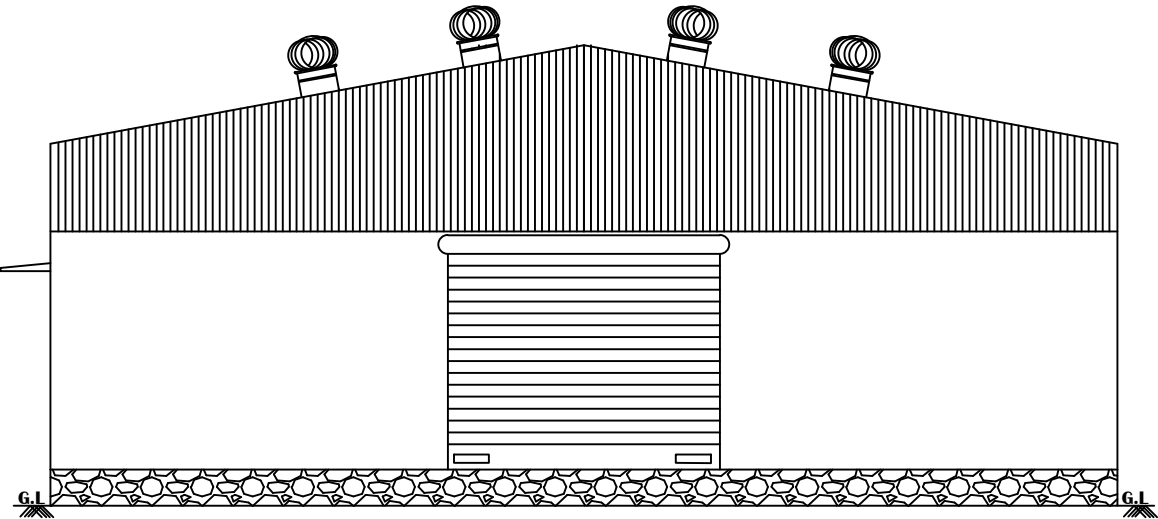


ELEVATION

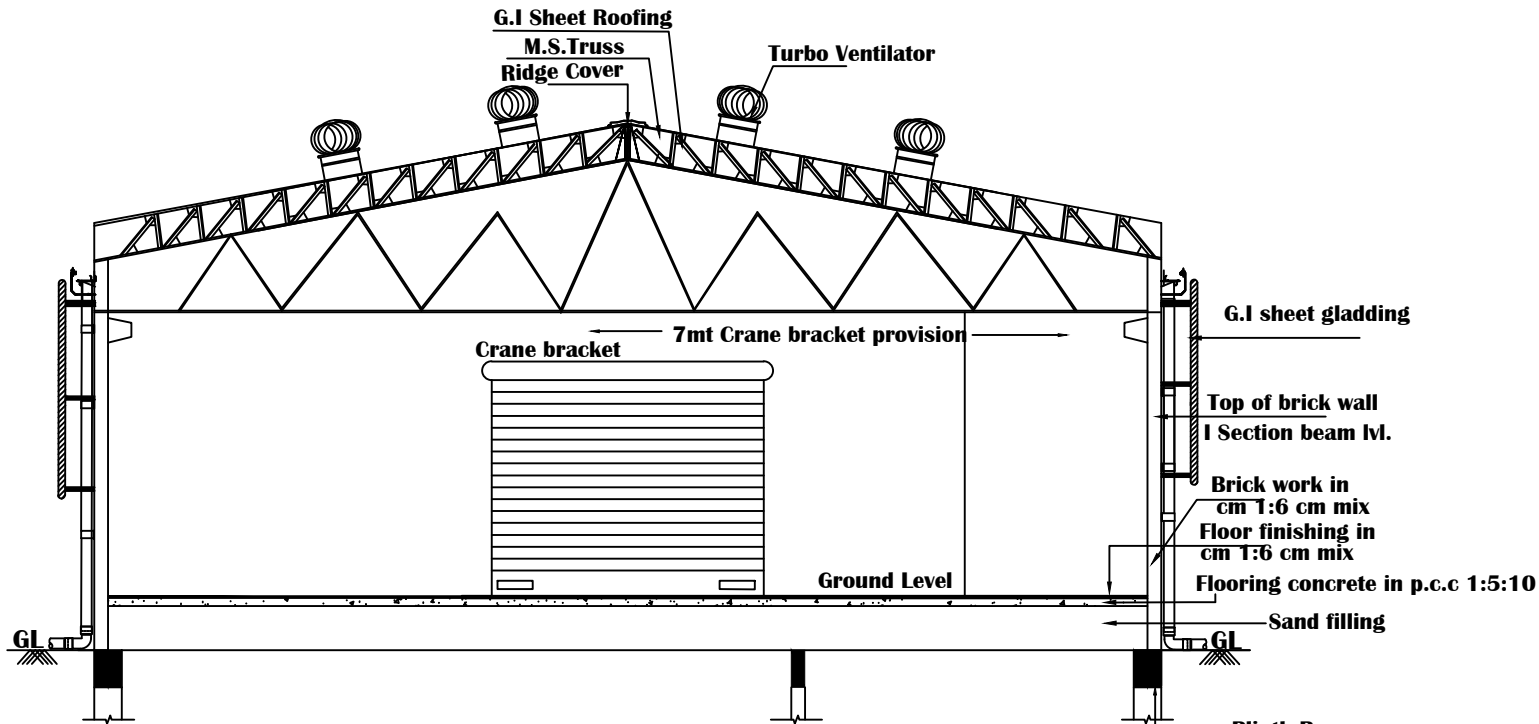


SECTION AA

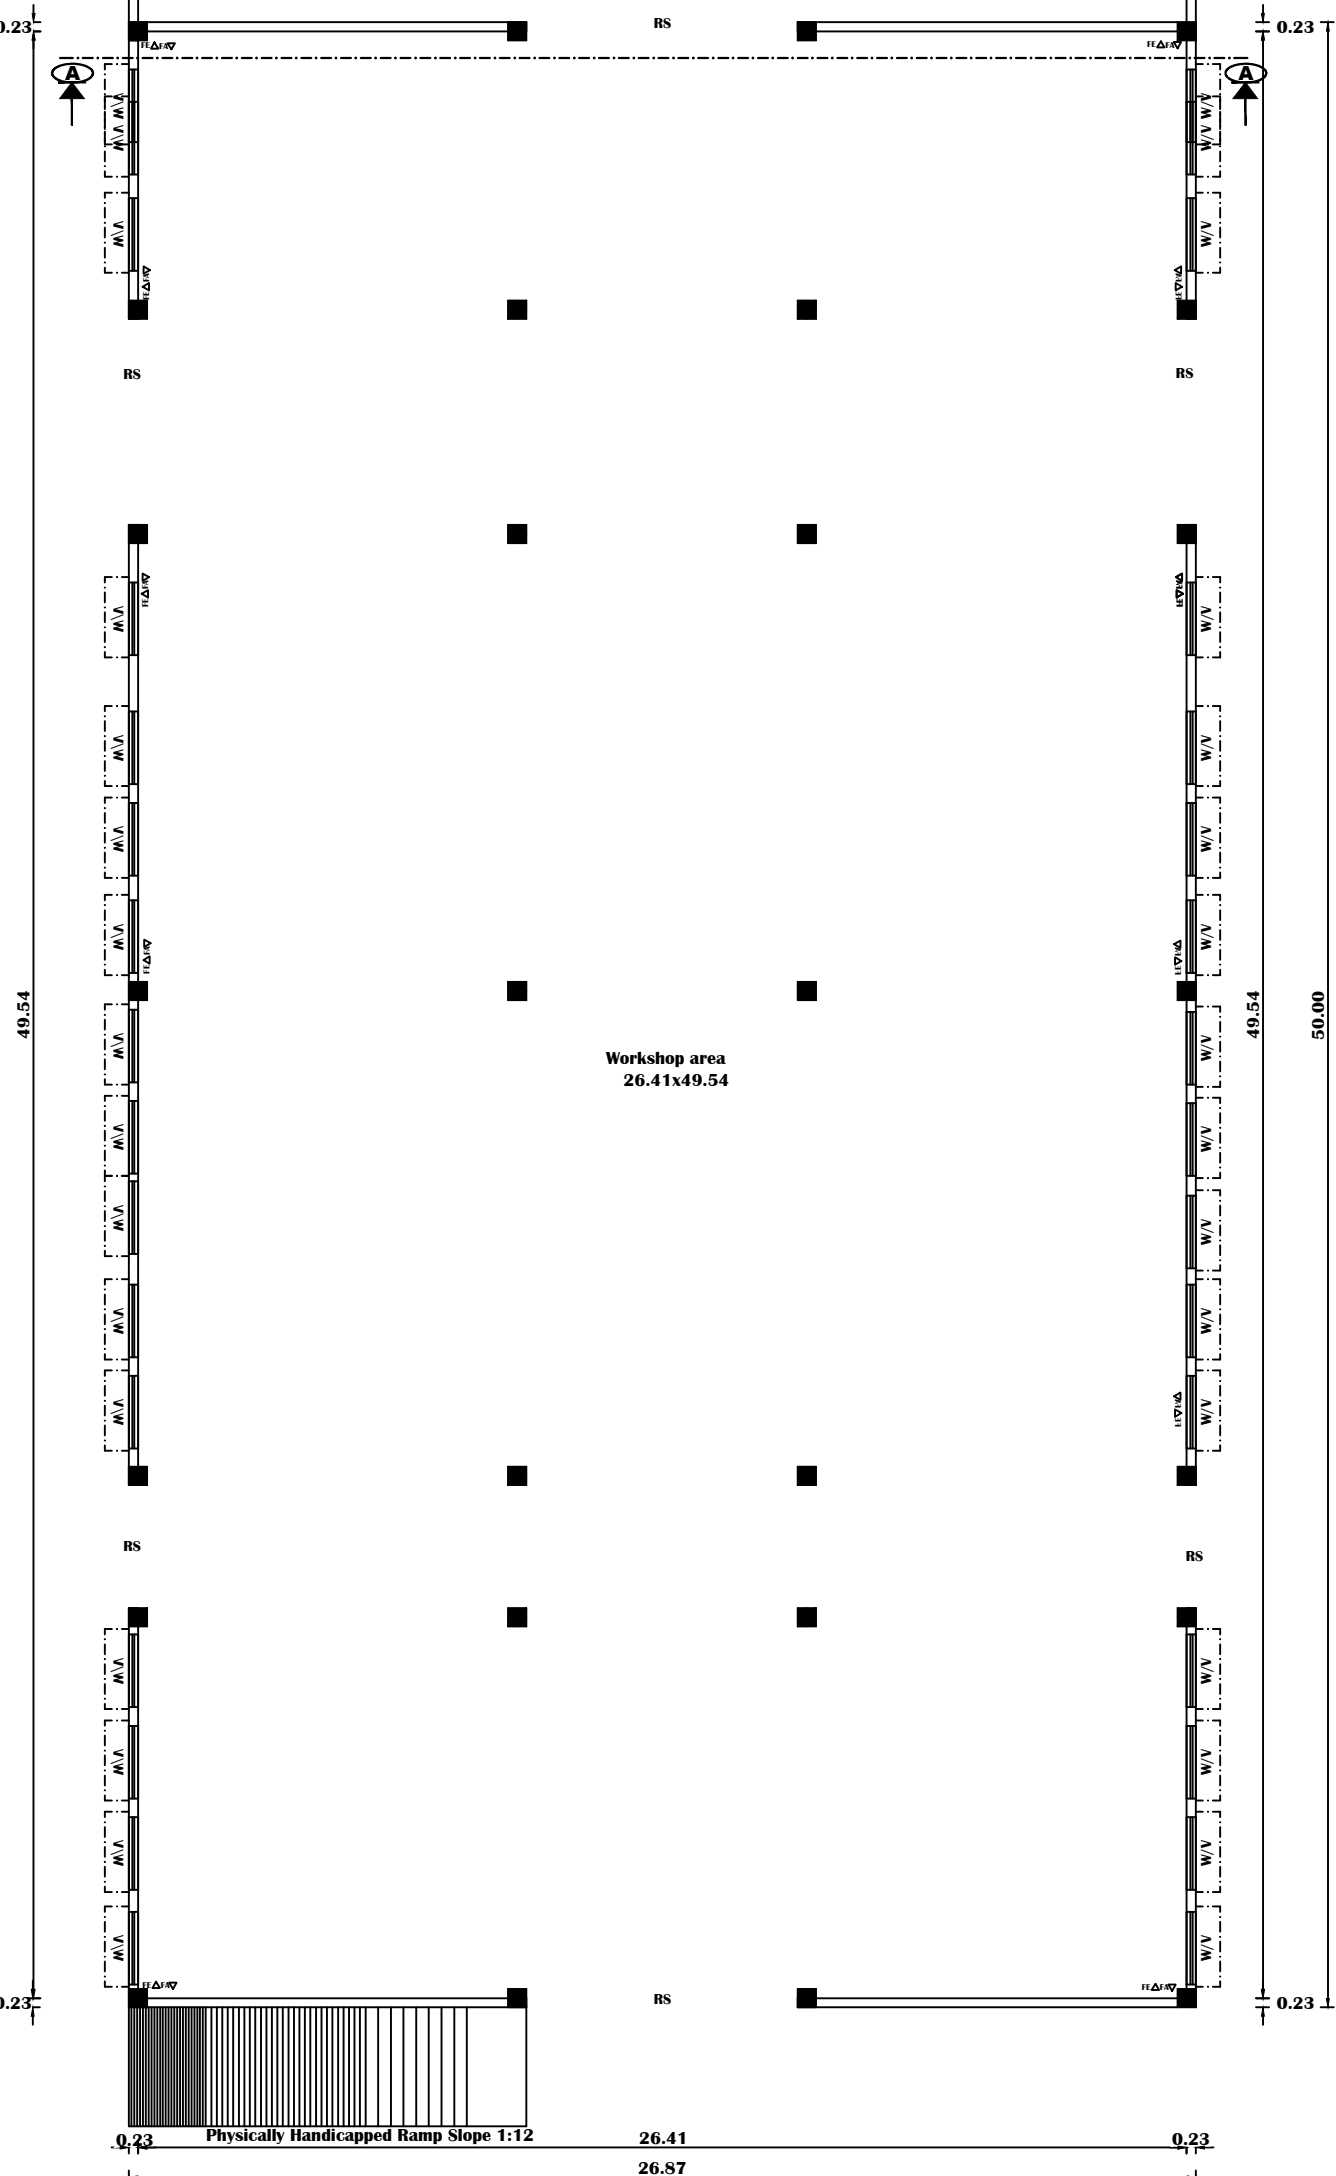


Ground Floor Plan

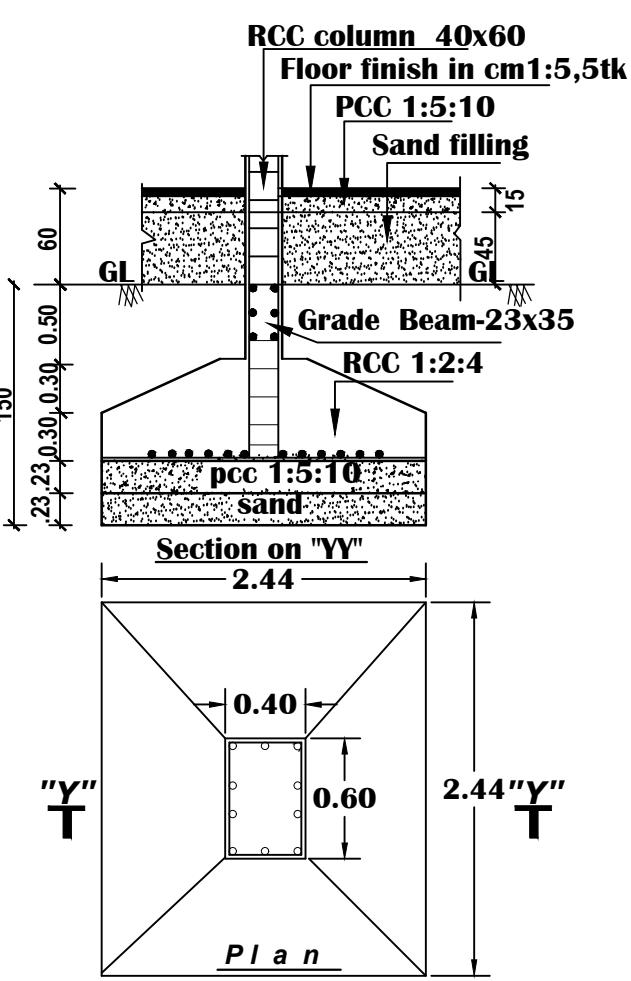


FOUNDATION DTLS
(Scale 1:50)

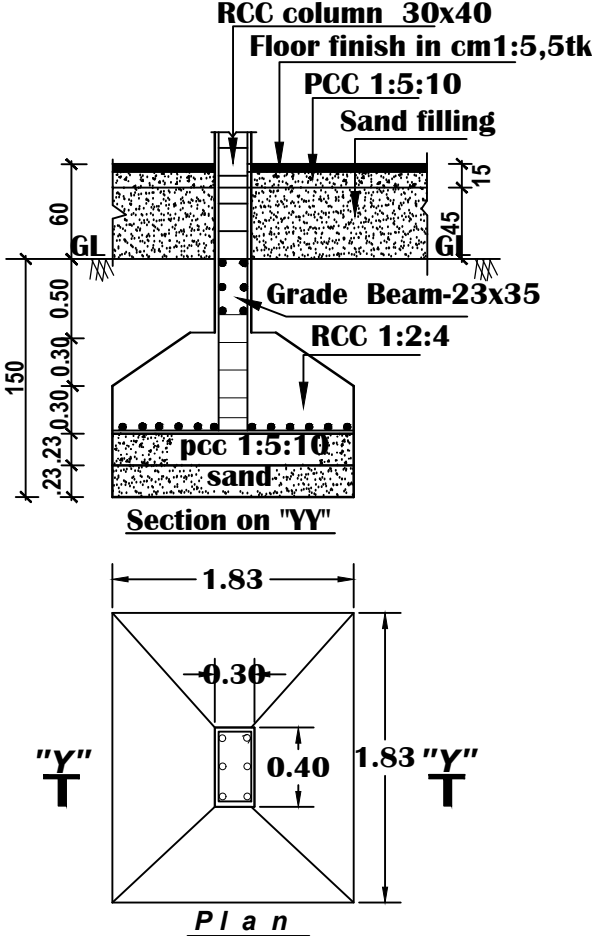


FOUNDATION DTLS
(Scale 1:50)

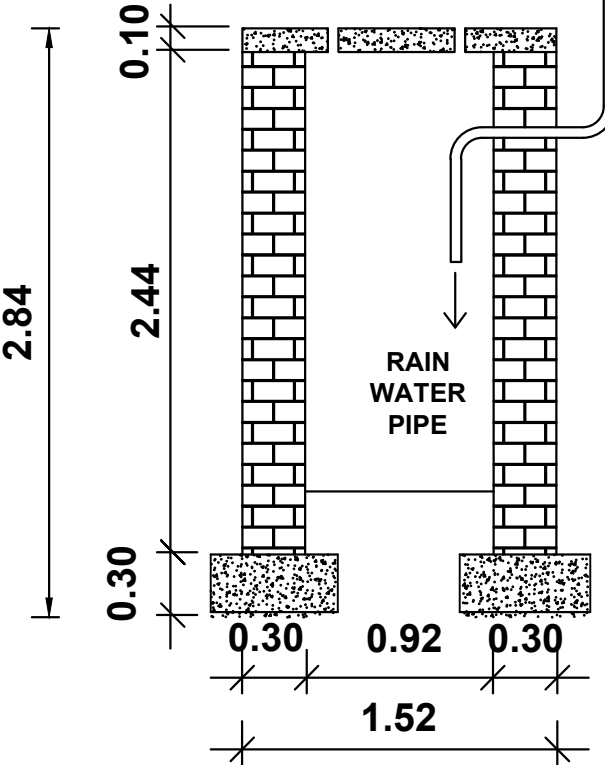



RAIN WATER HARVESTING
NOT TO SCALE

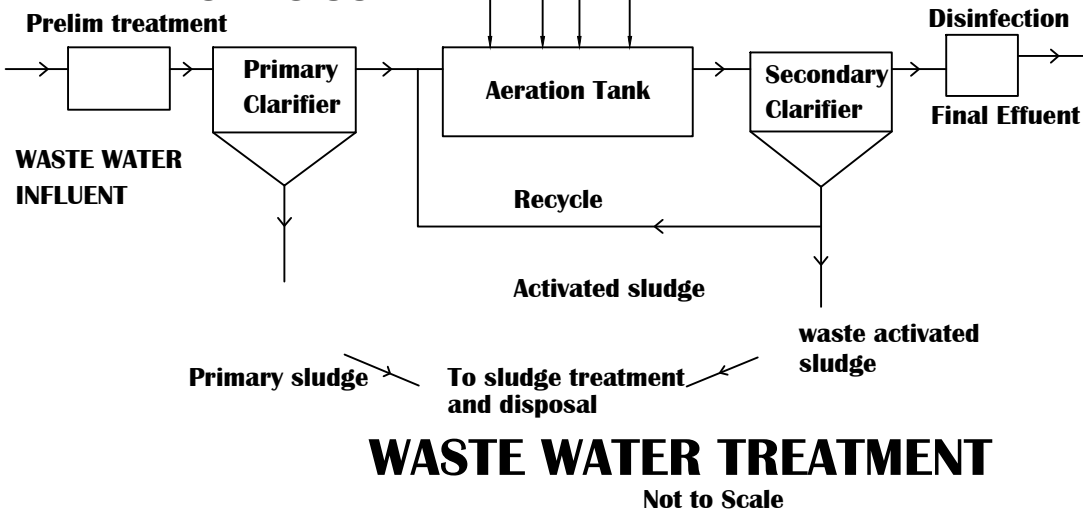


WASTE WATER TREATMENT
Not to Scale

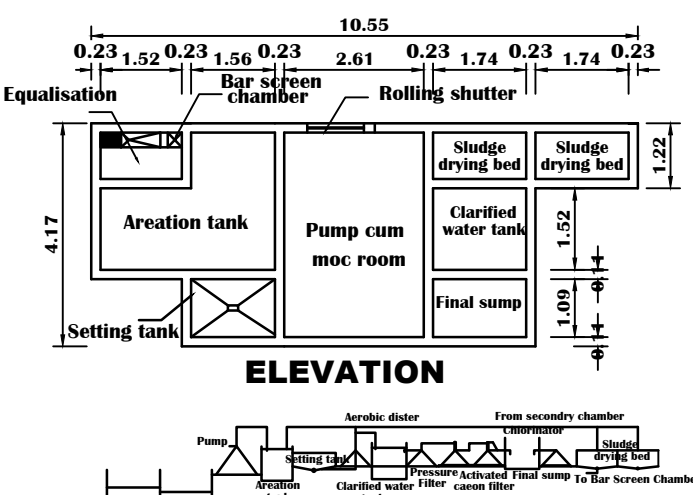

PLAN
SEWAGE TREATMENT PLANT

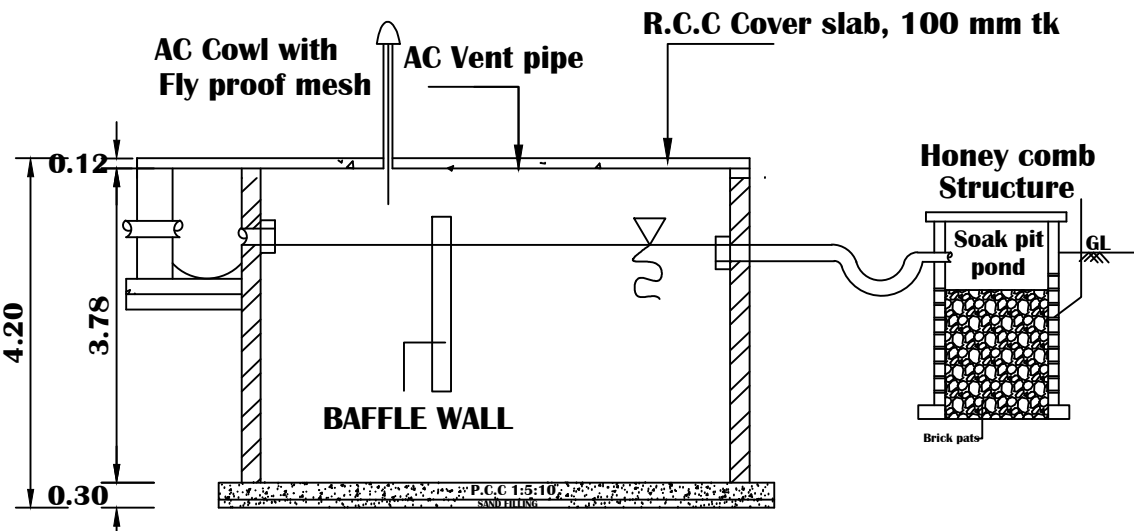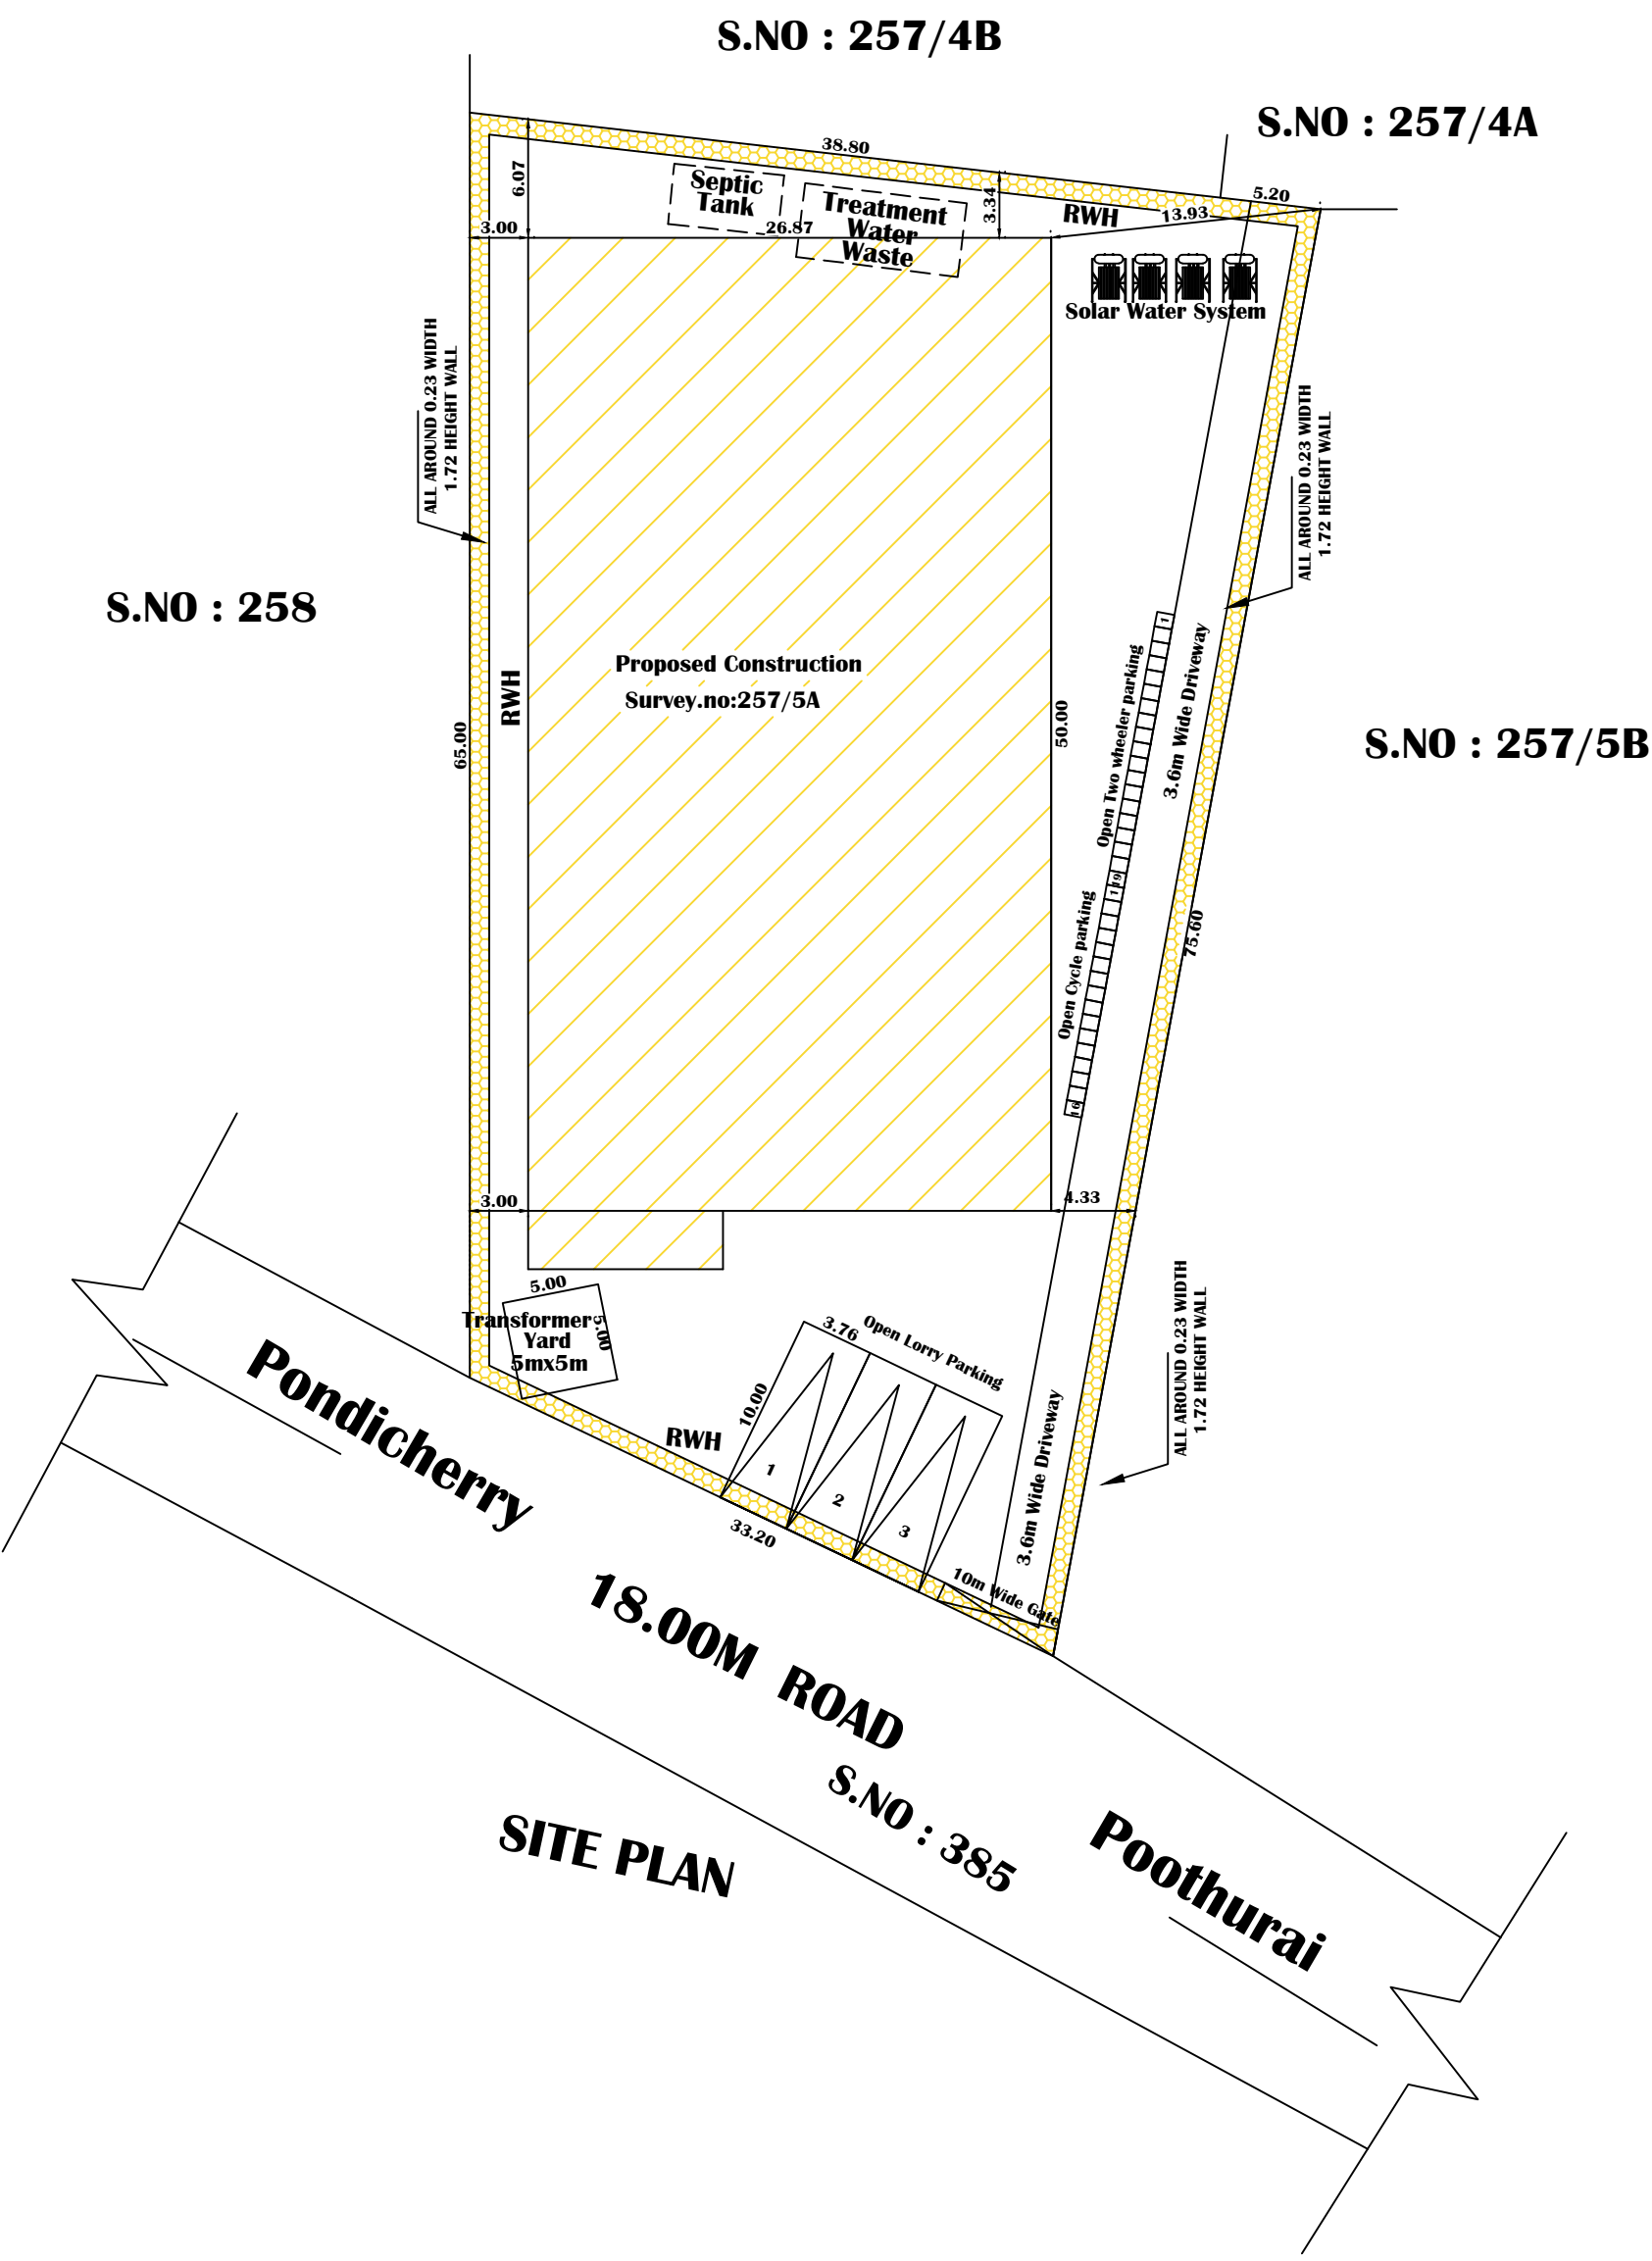

SECTION

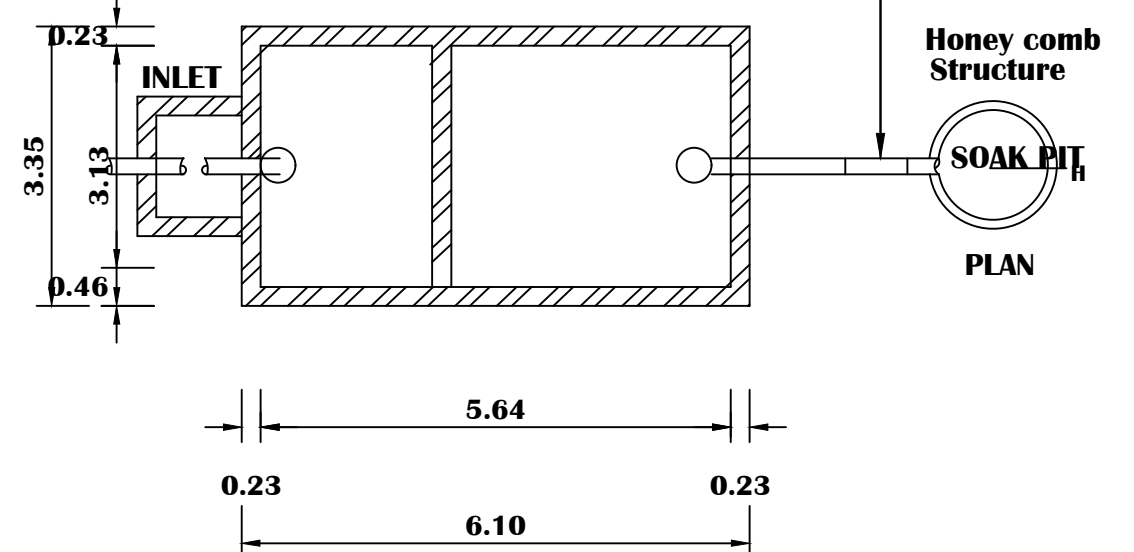

SEPTIC TANK PLAN
SCALE 1:100

LAND DETAIL FOR BUILDING			
S.F.NO		EXTENT	
257/5A		2700.00 Sq.m	
BUILDING AREA DETAIL			
Area	Sq.m	F.S.I	Non.F.S.I
Ground Floor Area		1343.5	-
TOTAL		1343.5	-

Plot Coverage = $\frac{1343.5}{2700} \times 100 = 49.75 < 50\%$

F.S.I = $\frac{1343.5}{2700} = 0.497 < 1.0$

Providing 3nos Lorry parking.

COLOR INDEX

PROPOSED CONSTRUCTION
EXISTING ROAD
SITE BOUNDARY
DRIVE WAY

JOINERY DETAILS

RS	ROLLING SHUTTER	6.10 x 2.44
D	DOOR	1.22 x 2.44
RS1	ROLLING SHUTTER-1	4.57 x 2.44
W	WINDOW	1.83 x 1.83
RS2	ROLLING SHUTTER-2	2.44 x 1.83
V	VENTILATOR	1.83x 0.61
V1	VENTILATOR	1.52 x 0.61
V2	VENTILATOR	0.91 x 0.61

No. of Workers 20.

- FA ▽ FIRE ALARM
- FE △ FIRE EXTINGUISHERS.
- FHR○Fire Hose Reel
- EF⊗ Exhaust Fan With 0.46 Dia
- Providing fire alarm & extinguishers.
- Providing "U" Trap for septic tank.
- Providing solar water heater system.
- Providing sewage treatment plant

[Signature]

APPLICANT

[Signature]
Er.R.SARANYA,M.E.,(Struc.)
Registered Engineer Grade-II(RE)
DTCP Reg. No: RE/GR-II/FEBRUARY-2023/065
Municipal Registered. No: 044/LS/2023/00001
26-C Vadamalai Complex, Trichy Main Road,
Villupuram - 605 602. Cell: 7708262761

ENGINEER

OFFICE USE