

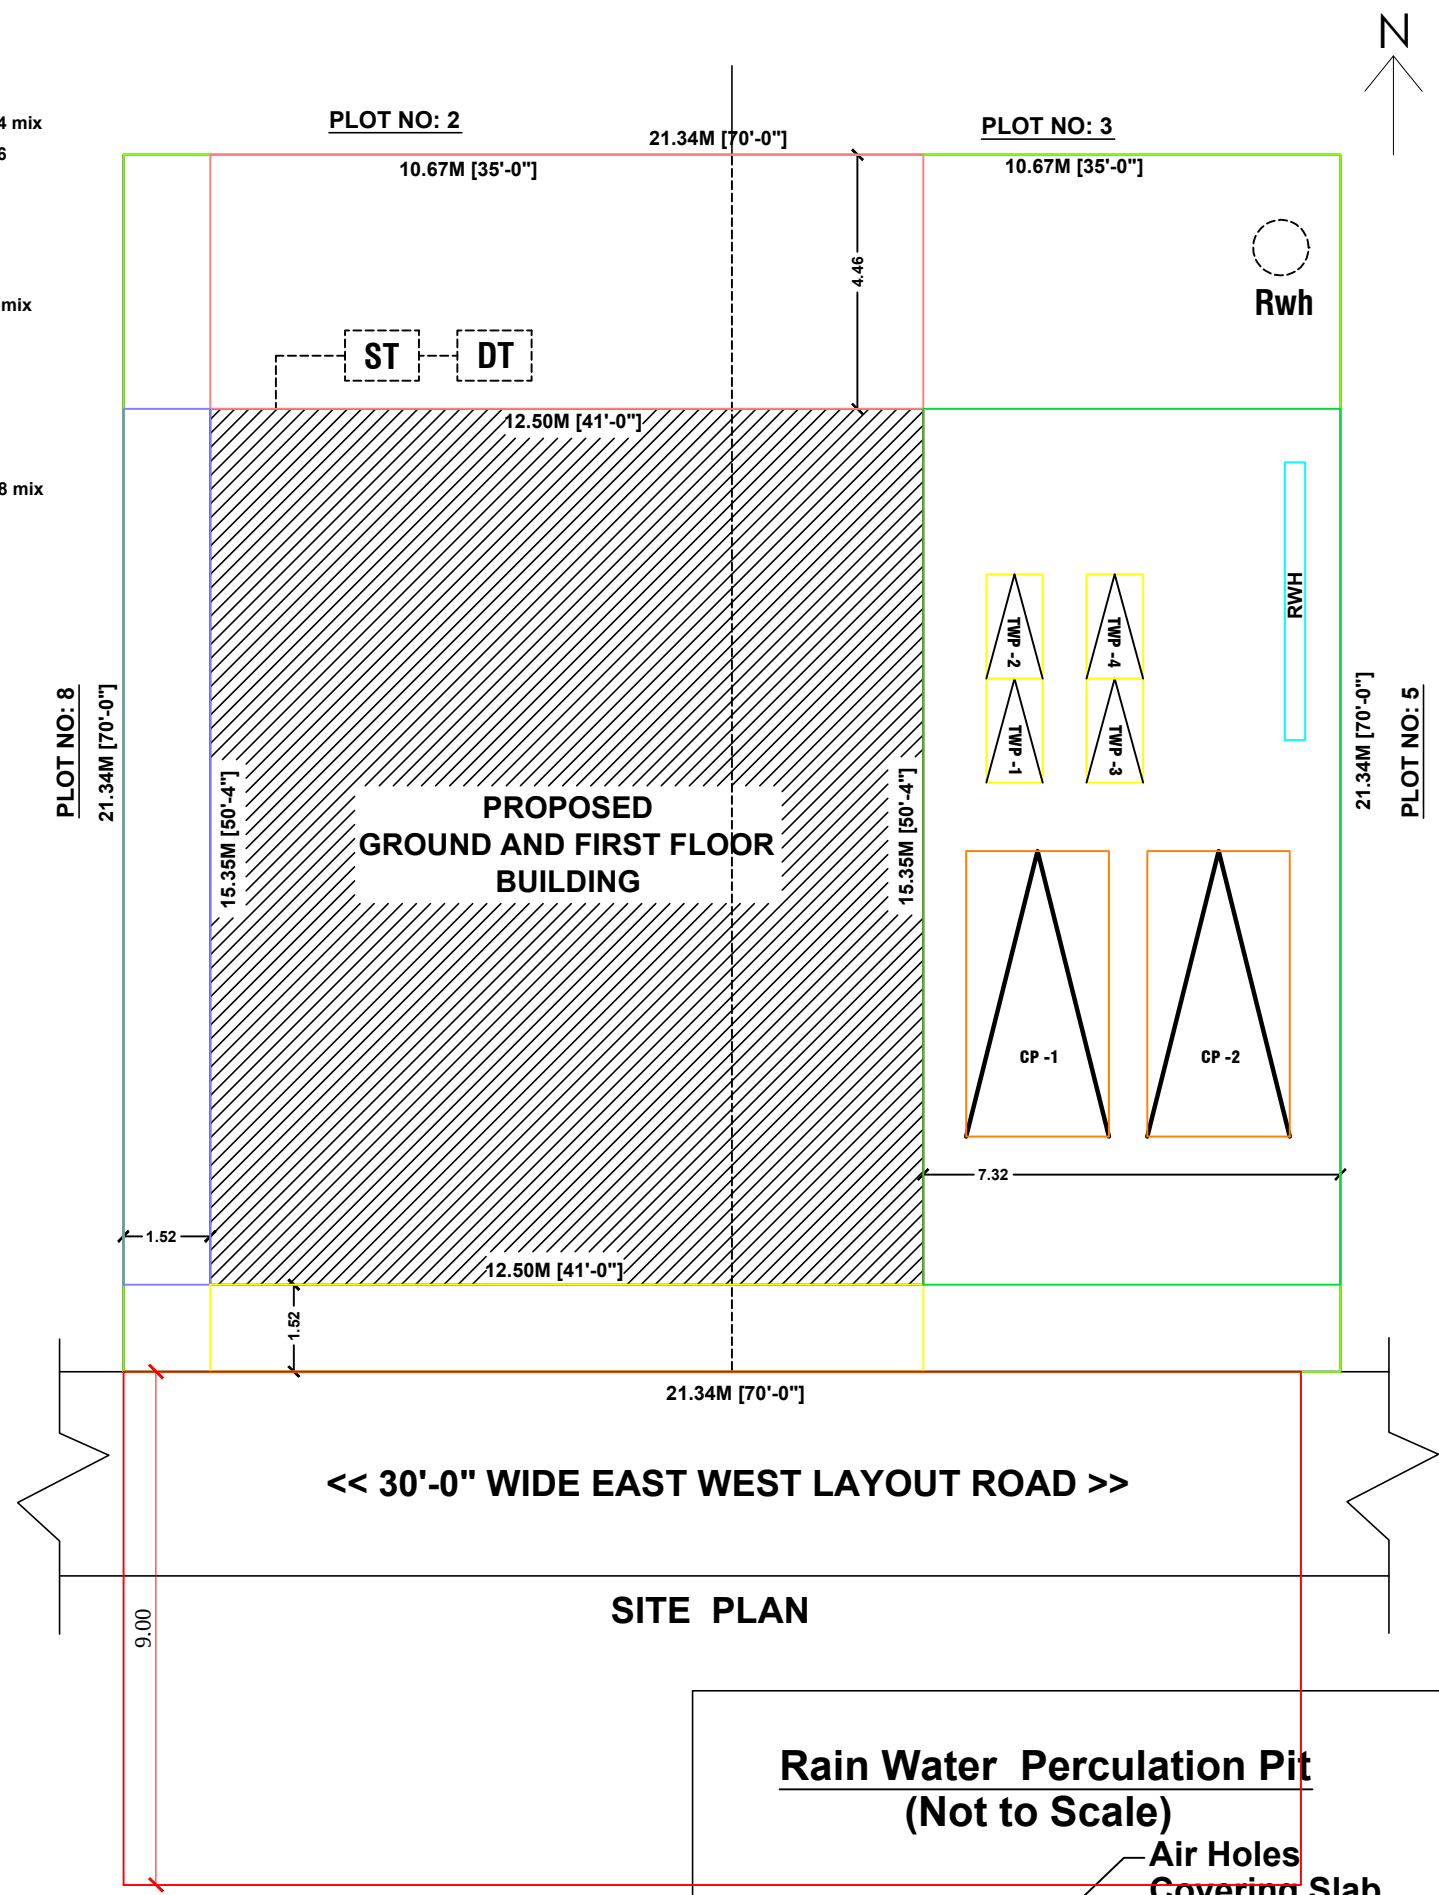
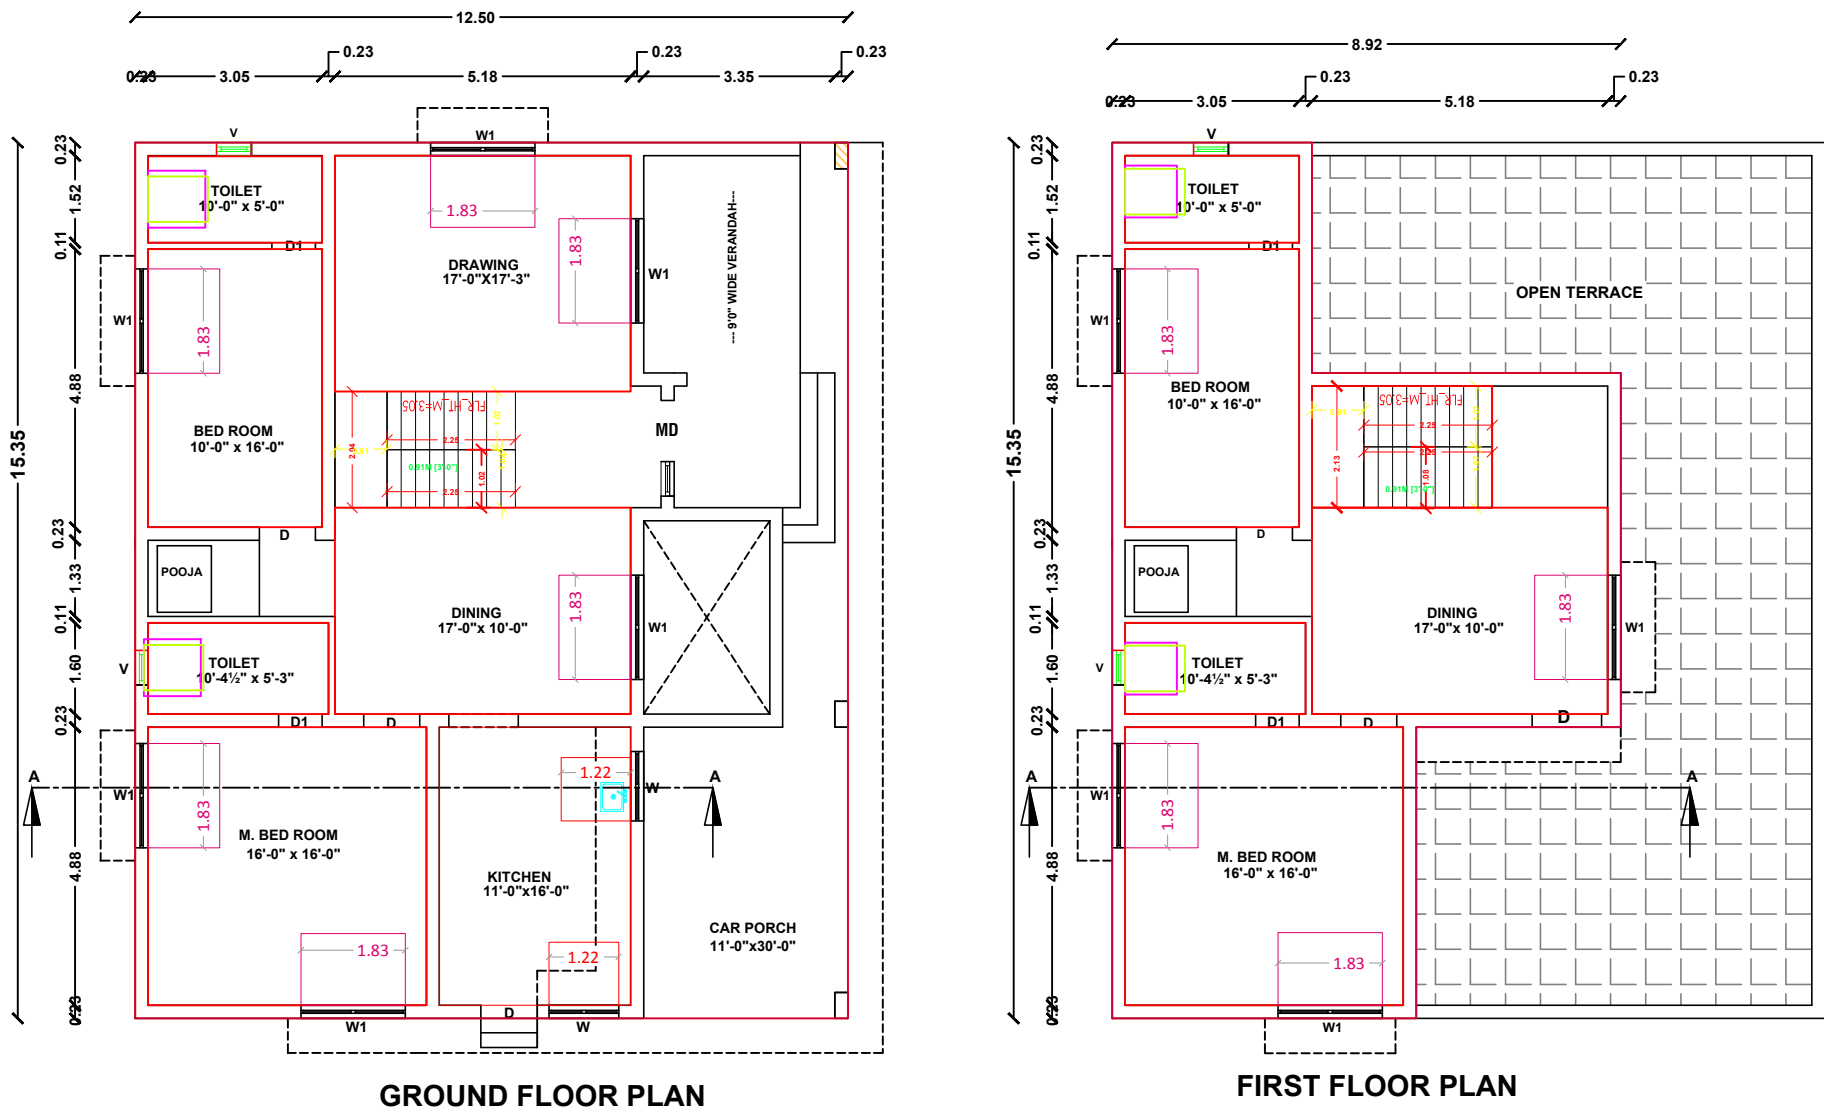


Plan showing the Proposed Construction of R.C.C. Roof Residential Building in Patta No:871,262, S.F. No :233/1B & 233/2B, New S.F. No :233/1B1A & 233/2B1,Plot No :6,7,Muthu Nagar Layout, Zaminuthukuli Town Panchayat,Pollachi Taluk,Coimbatore Dt. DTCP Approved No:998/1995

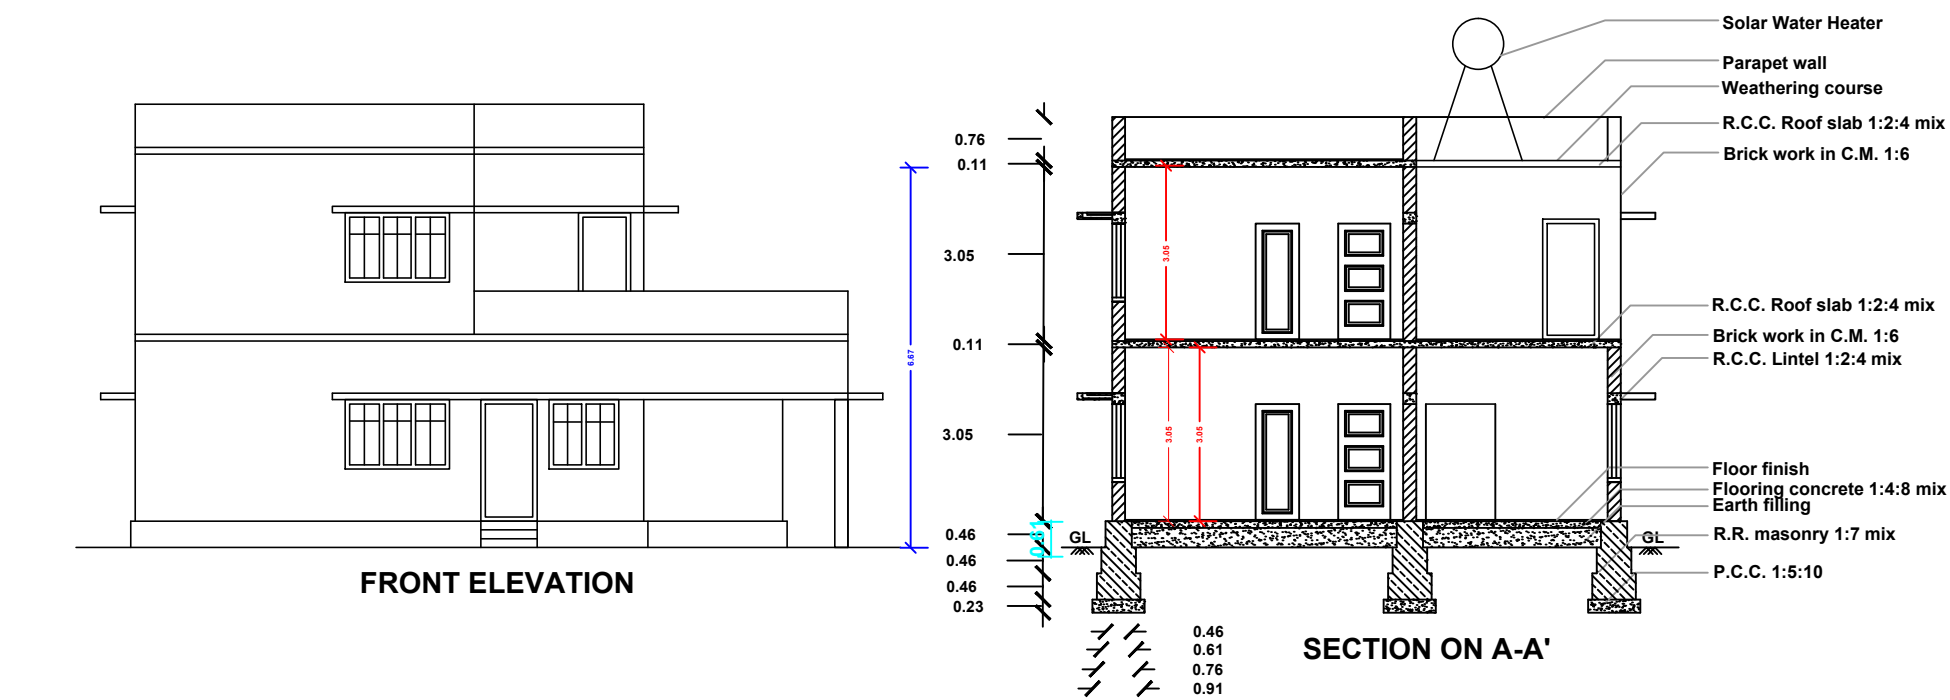

SEPTIC TANK WITH DISPERSION TRENCH (250 Gls.,)

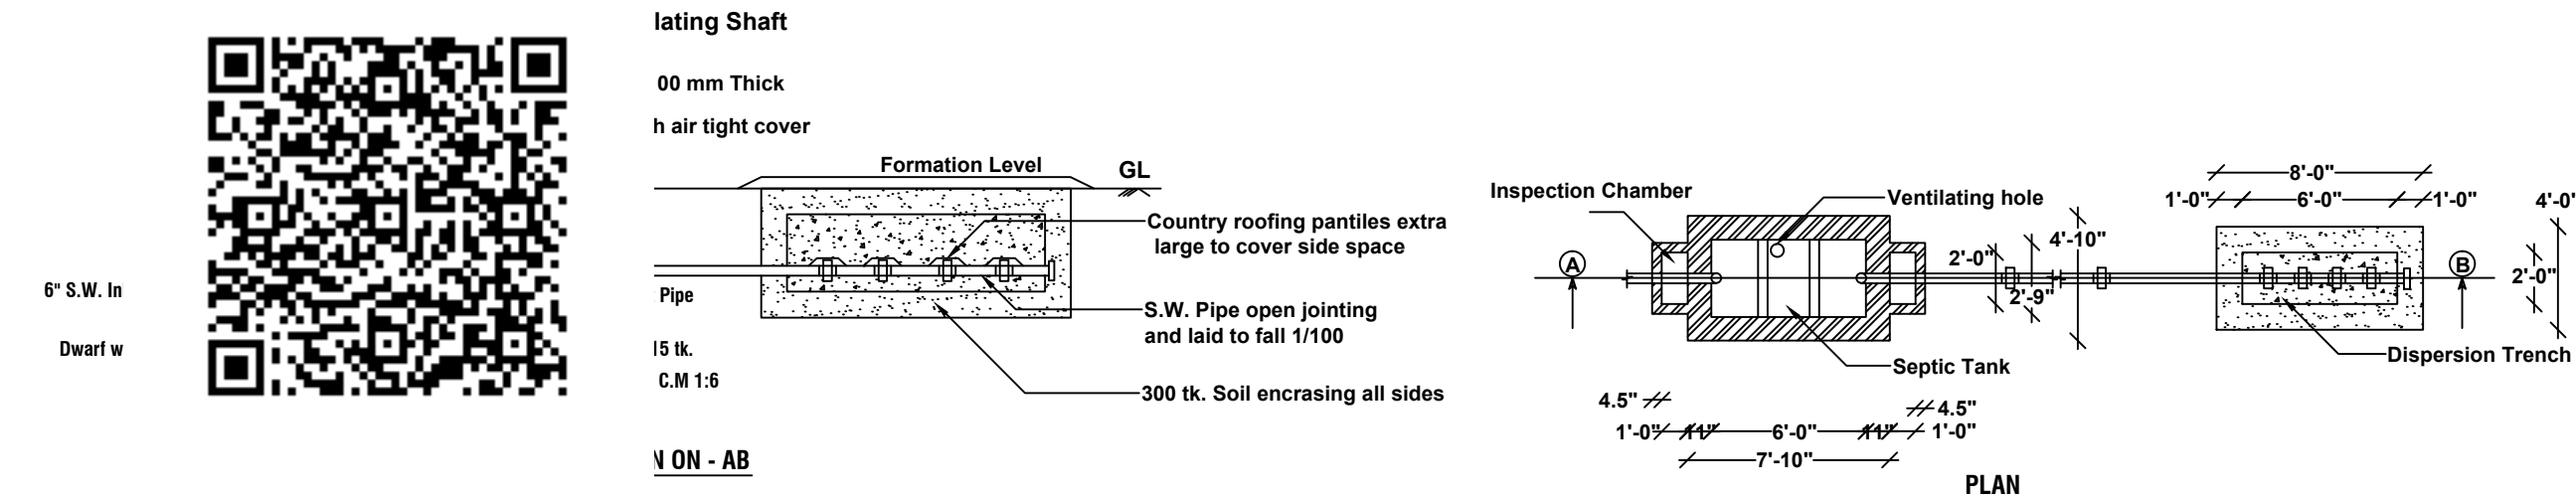

Scale	Plan : 1: 100	Site Plan : 1: 200
-------	---------------	--------------------

Area details	Sq.ft.	Sq.m.
Area of the site	4900.00	455.22
Area of the Pro.G.F Building	2065.00	191.91
Area of the Pro.F.F Building	1041.00	96.74
Area of the Open Space	2835.00	263.47

Schedule of Joineries		
MD Maindoor	3'-3" x 7'-0"	(0.99 x 2.13)
D Door	3'-3" x 7'-0"	(0.99 x 2.13)
D1 Door	2'-9" x 7'-0"	(0.83 x 2.13)
W Window	4'-0" x 4'-6"	(1.21 x 1.37)
W1 Window	6'-0" x 4'-6"	(1.82 x 1.37)
v Ventilator	2'-6" x 2'-0"	(0.76 x 0.60)

Site boundary	
Prop. R.C.C. Building	
Road	
Rain Water Pit (Rwh)	

Mr.Muthu Rajesh Kumar S/O.Thirumalaisamy

Mr. Muthu Rajesh Kumar

Applicant.

K. Manikandan
Er. K. Manikandan D.C.E
Registered Engineer Grade-III
CADD TECHNOLOGY
Building & Layout Plan Approval & Vastu Planer
NVM Complex, Water Tank Road
Venkadesha Colony, Pollachi - 642 001.
Cell : 63824 92860,90950 99505

L.B.S/Engineer

Drawn By : CADD TECHNOLOGY, Pollachi. 04250 - 224219

SHEET_1