


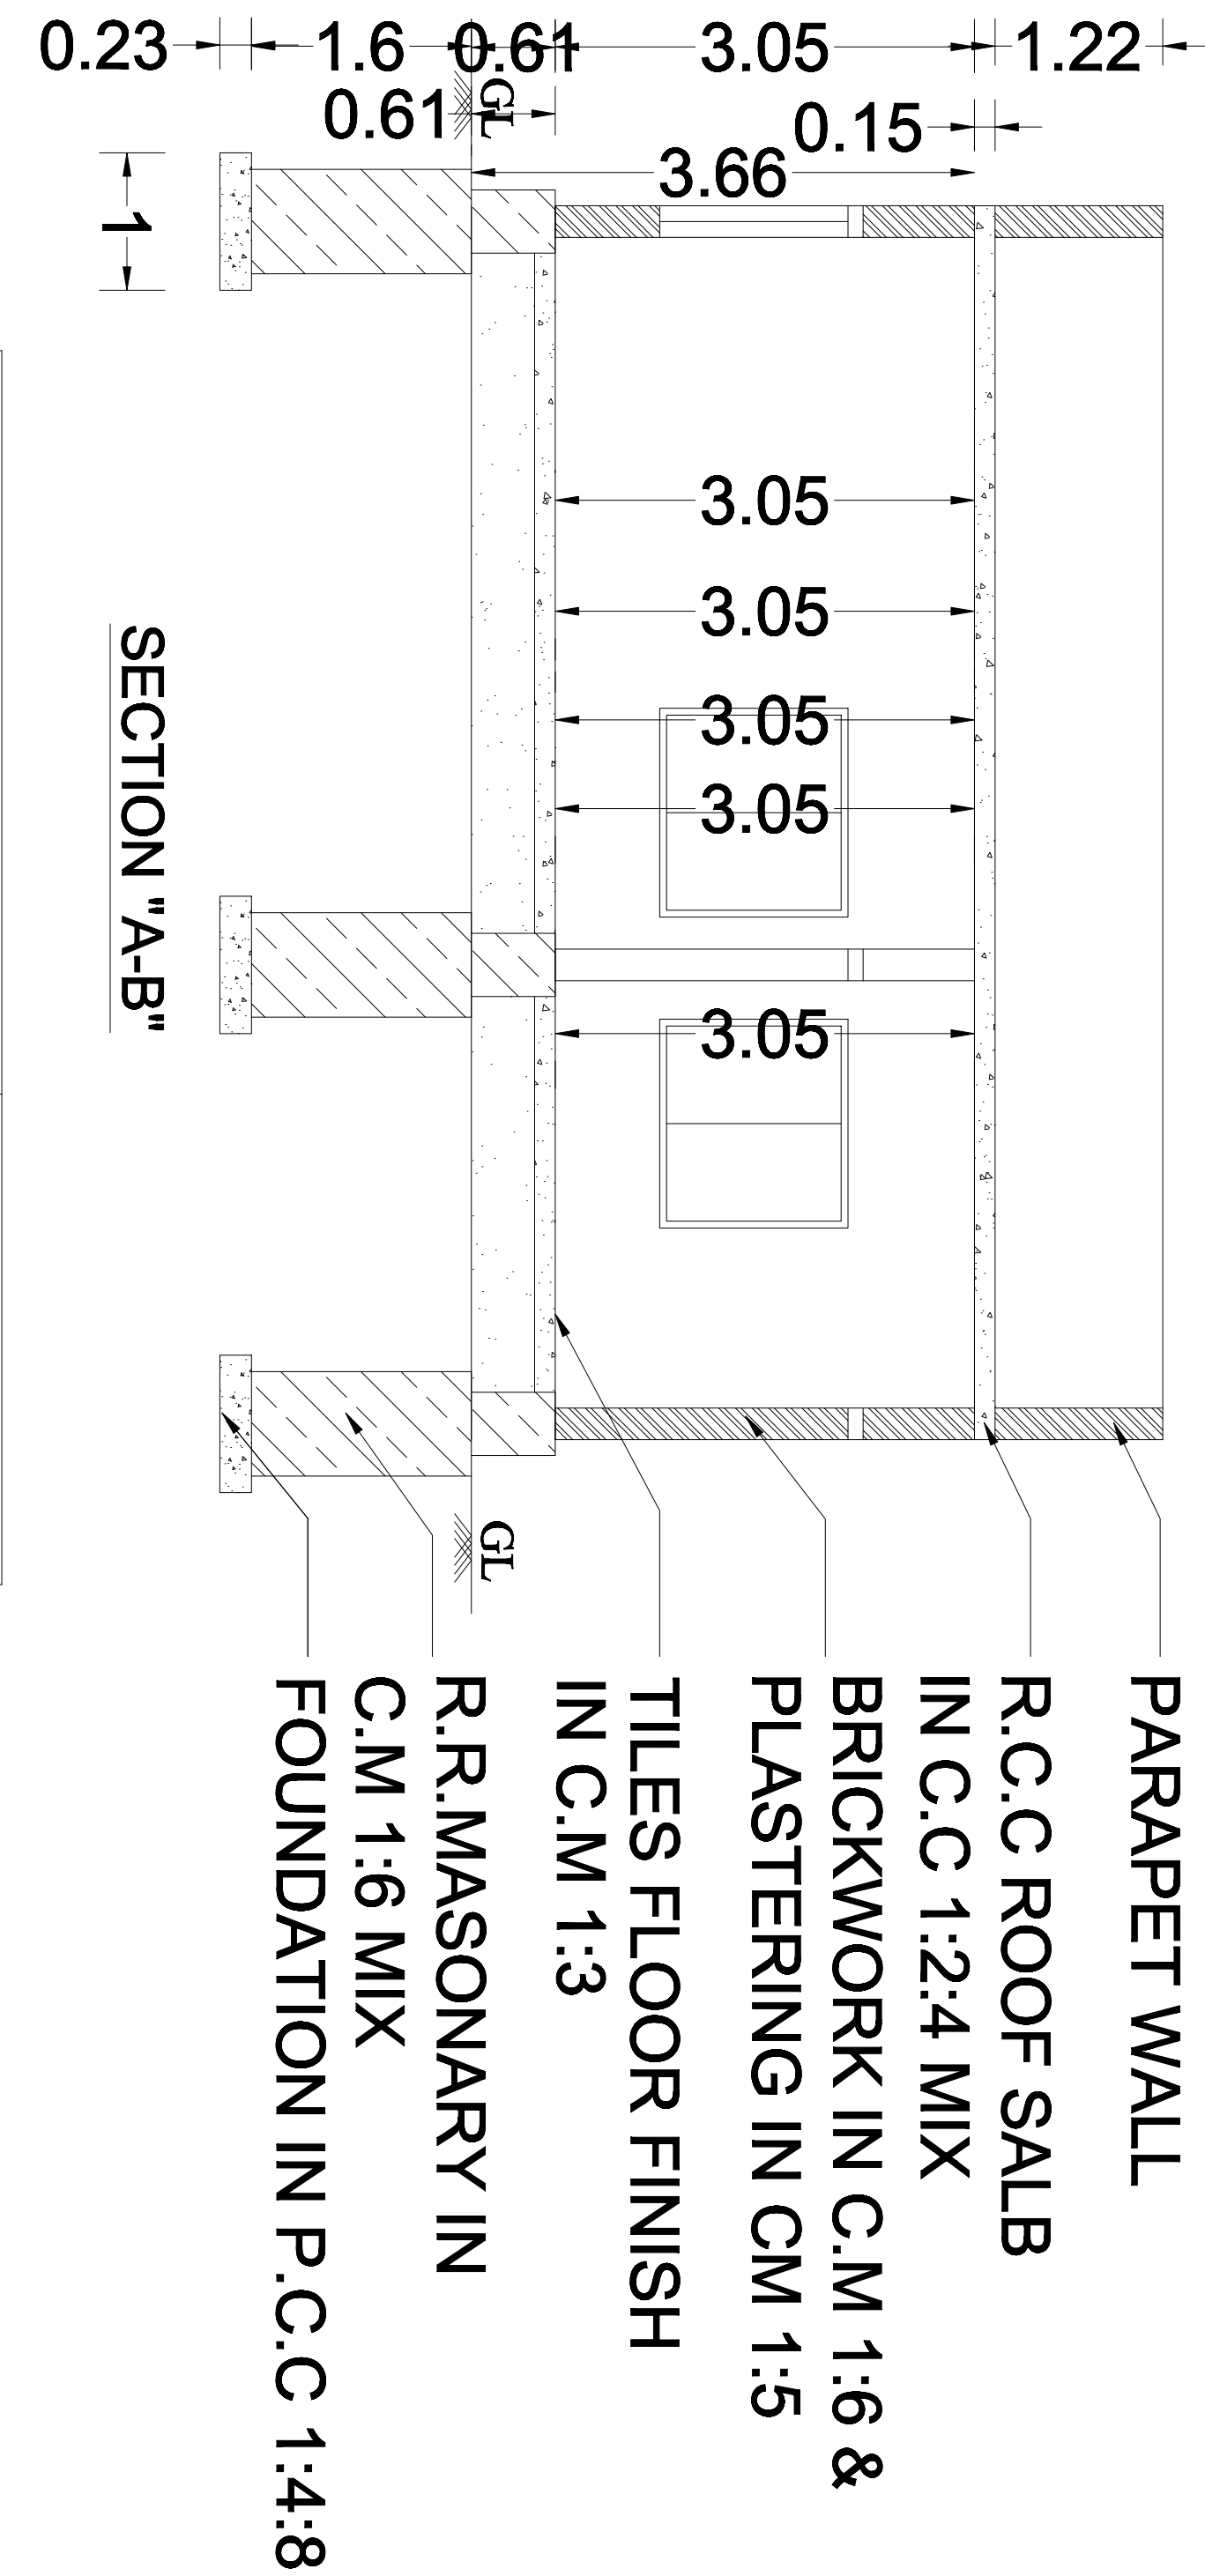


PLAN SHOWING THE PROPOSED CONSTRUCTION OF
R.C.C ROOF GROUND FLOOR RESIDENTIAL BUILDING
IN NEW SUB-DIVISION S.F.NO: 62/2B1, S.F.NO:62/2B1,
IN OLD S.F.NO: 62/2, PATTA NO: 668, OF HARUR VILLAGE,
HARUR TALUK, DHARMAPURI DISTRICT




APPLICANT:-

MR. M. ANBURAJ,
S/o. MATHAIYAN.


FRONT ELEVATION

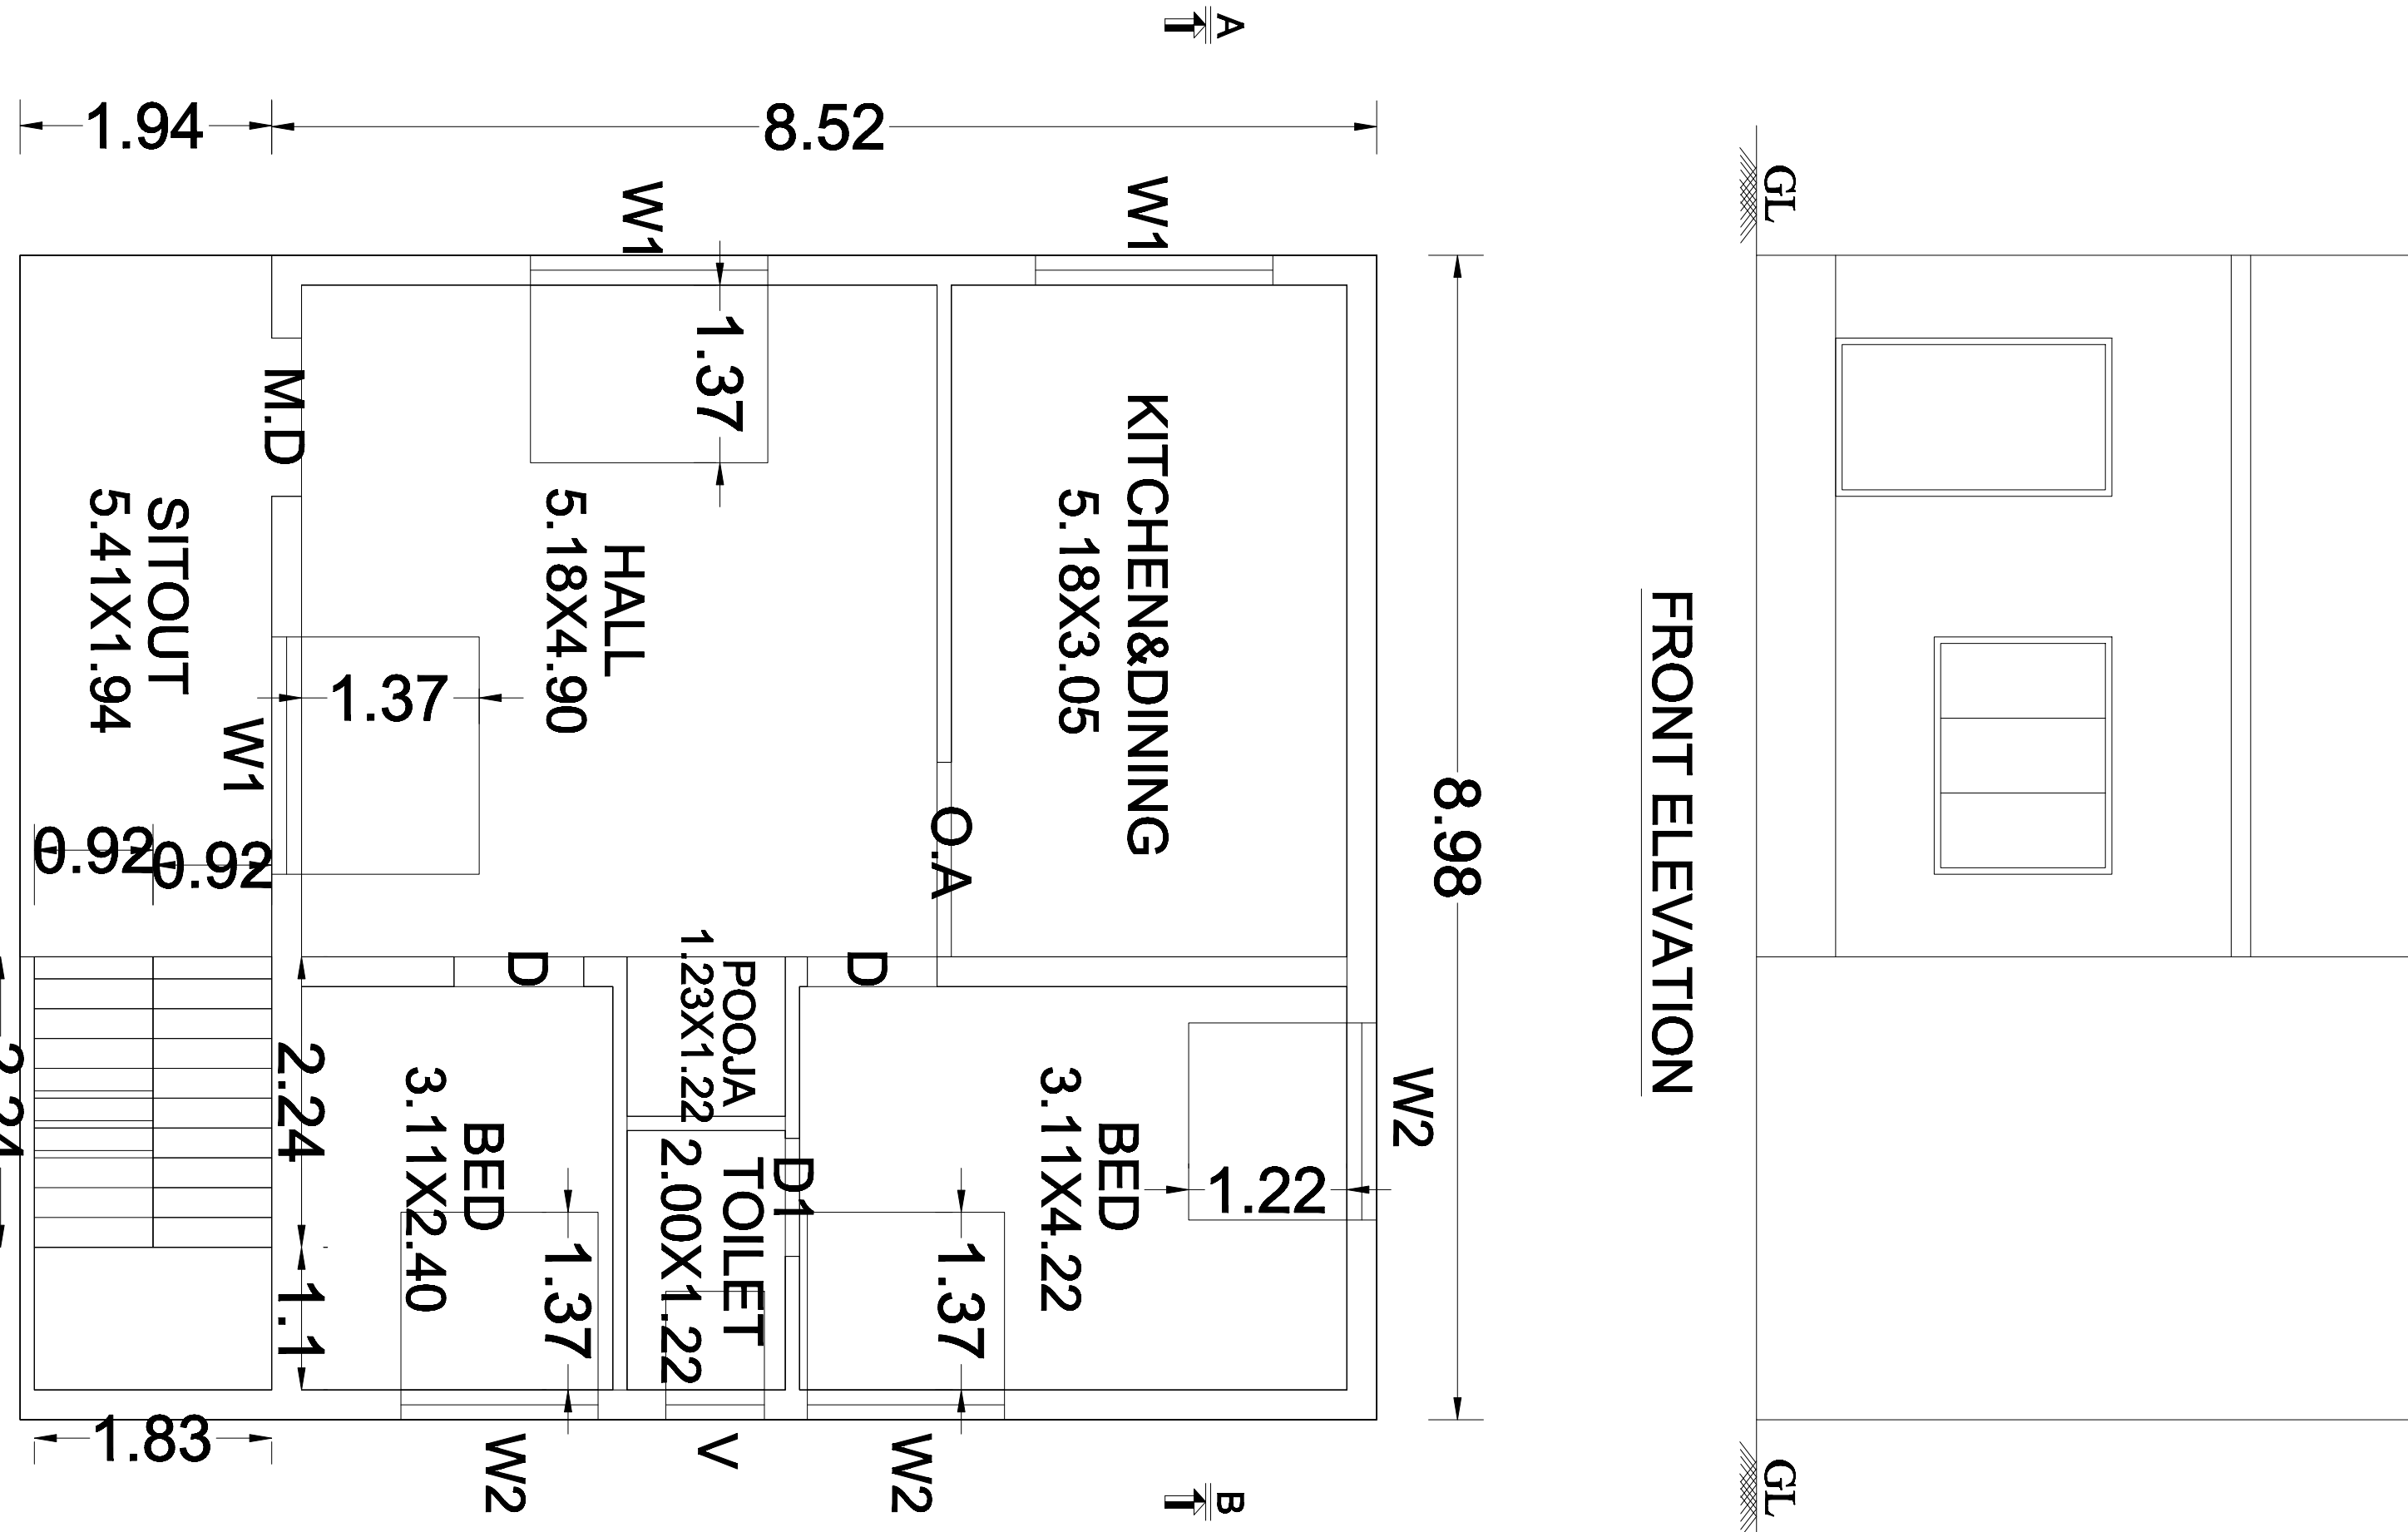

GROUND FLOOR PLAN
SCALE 1:100
F.L.R. HT. M=3.05

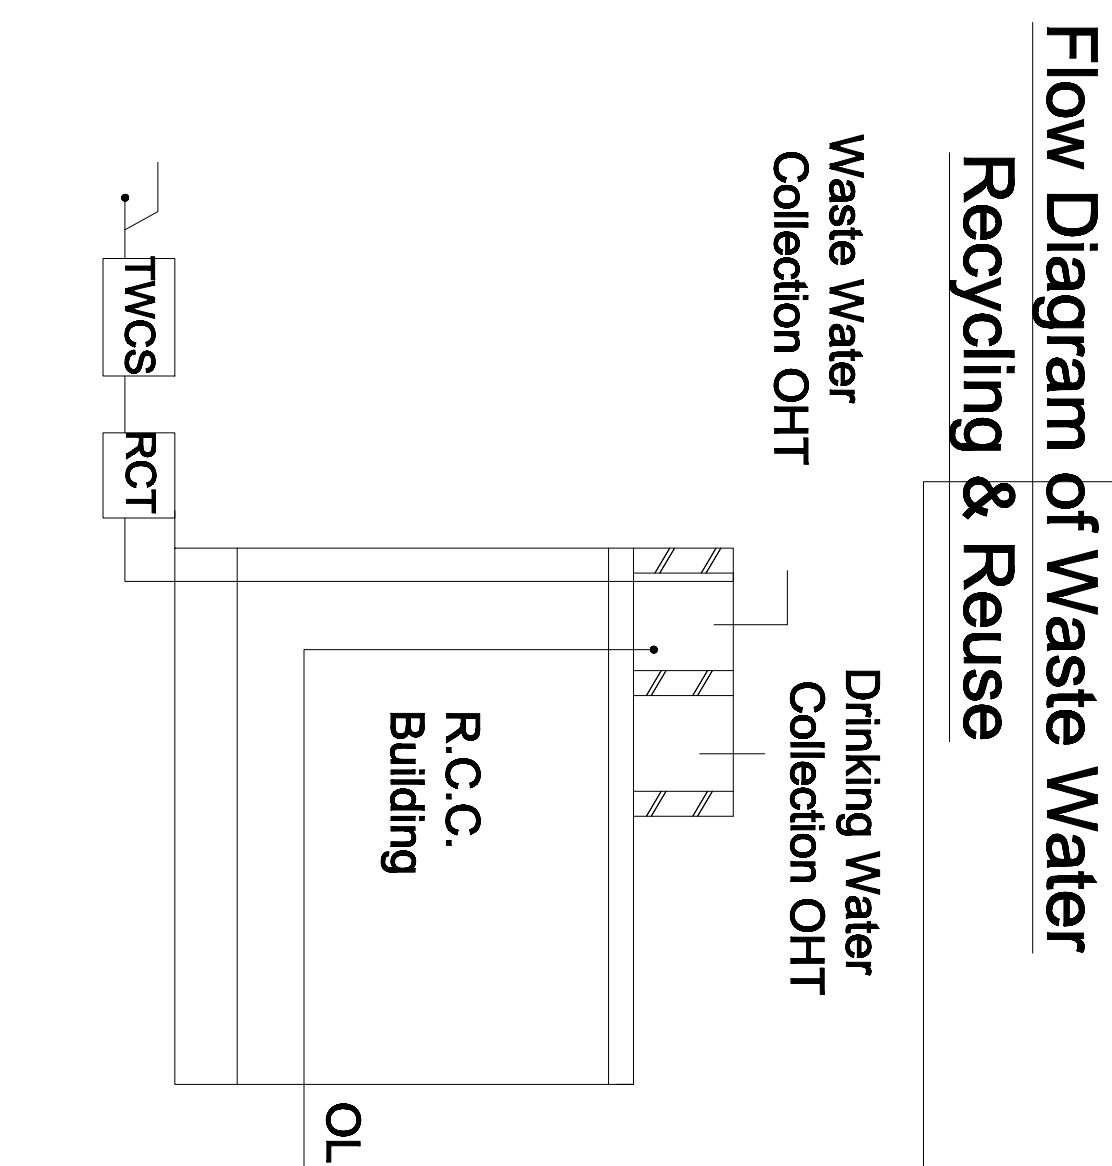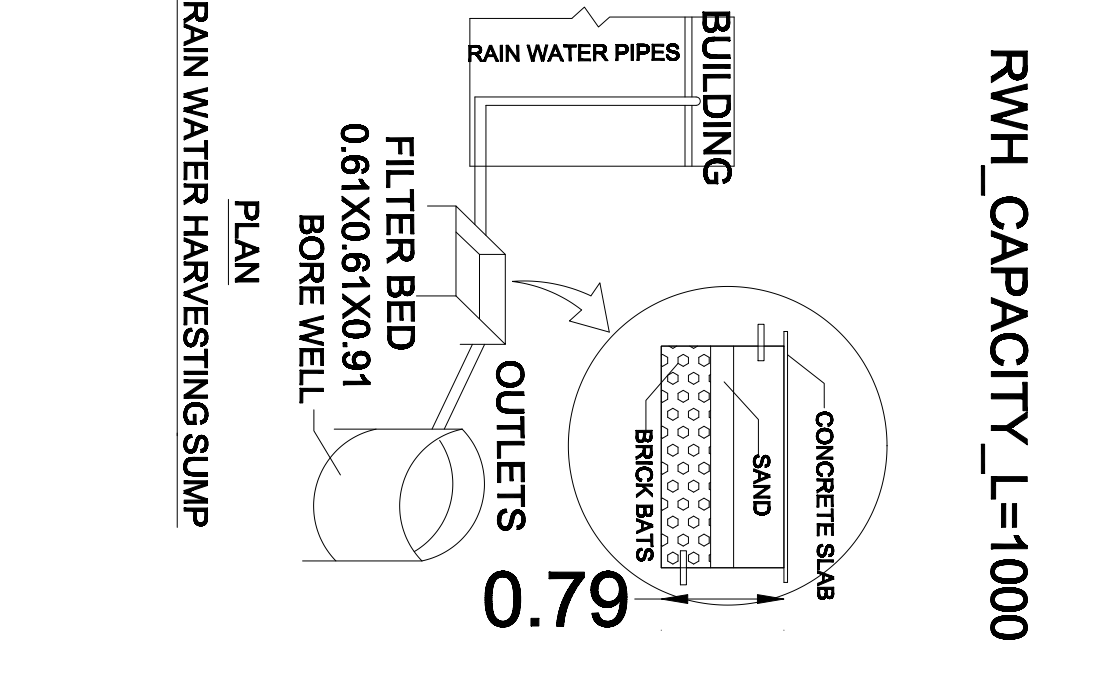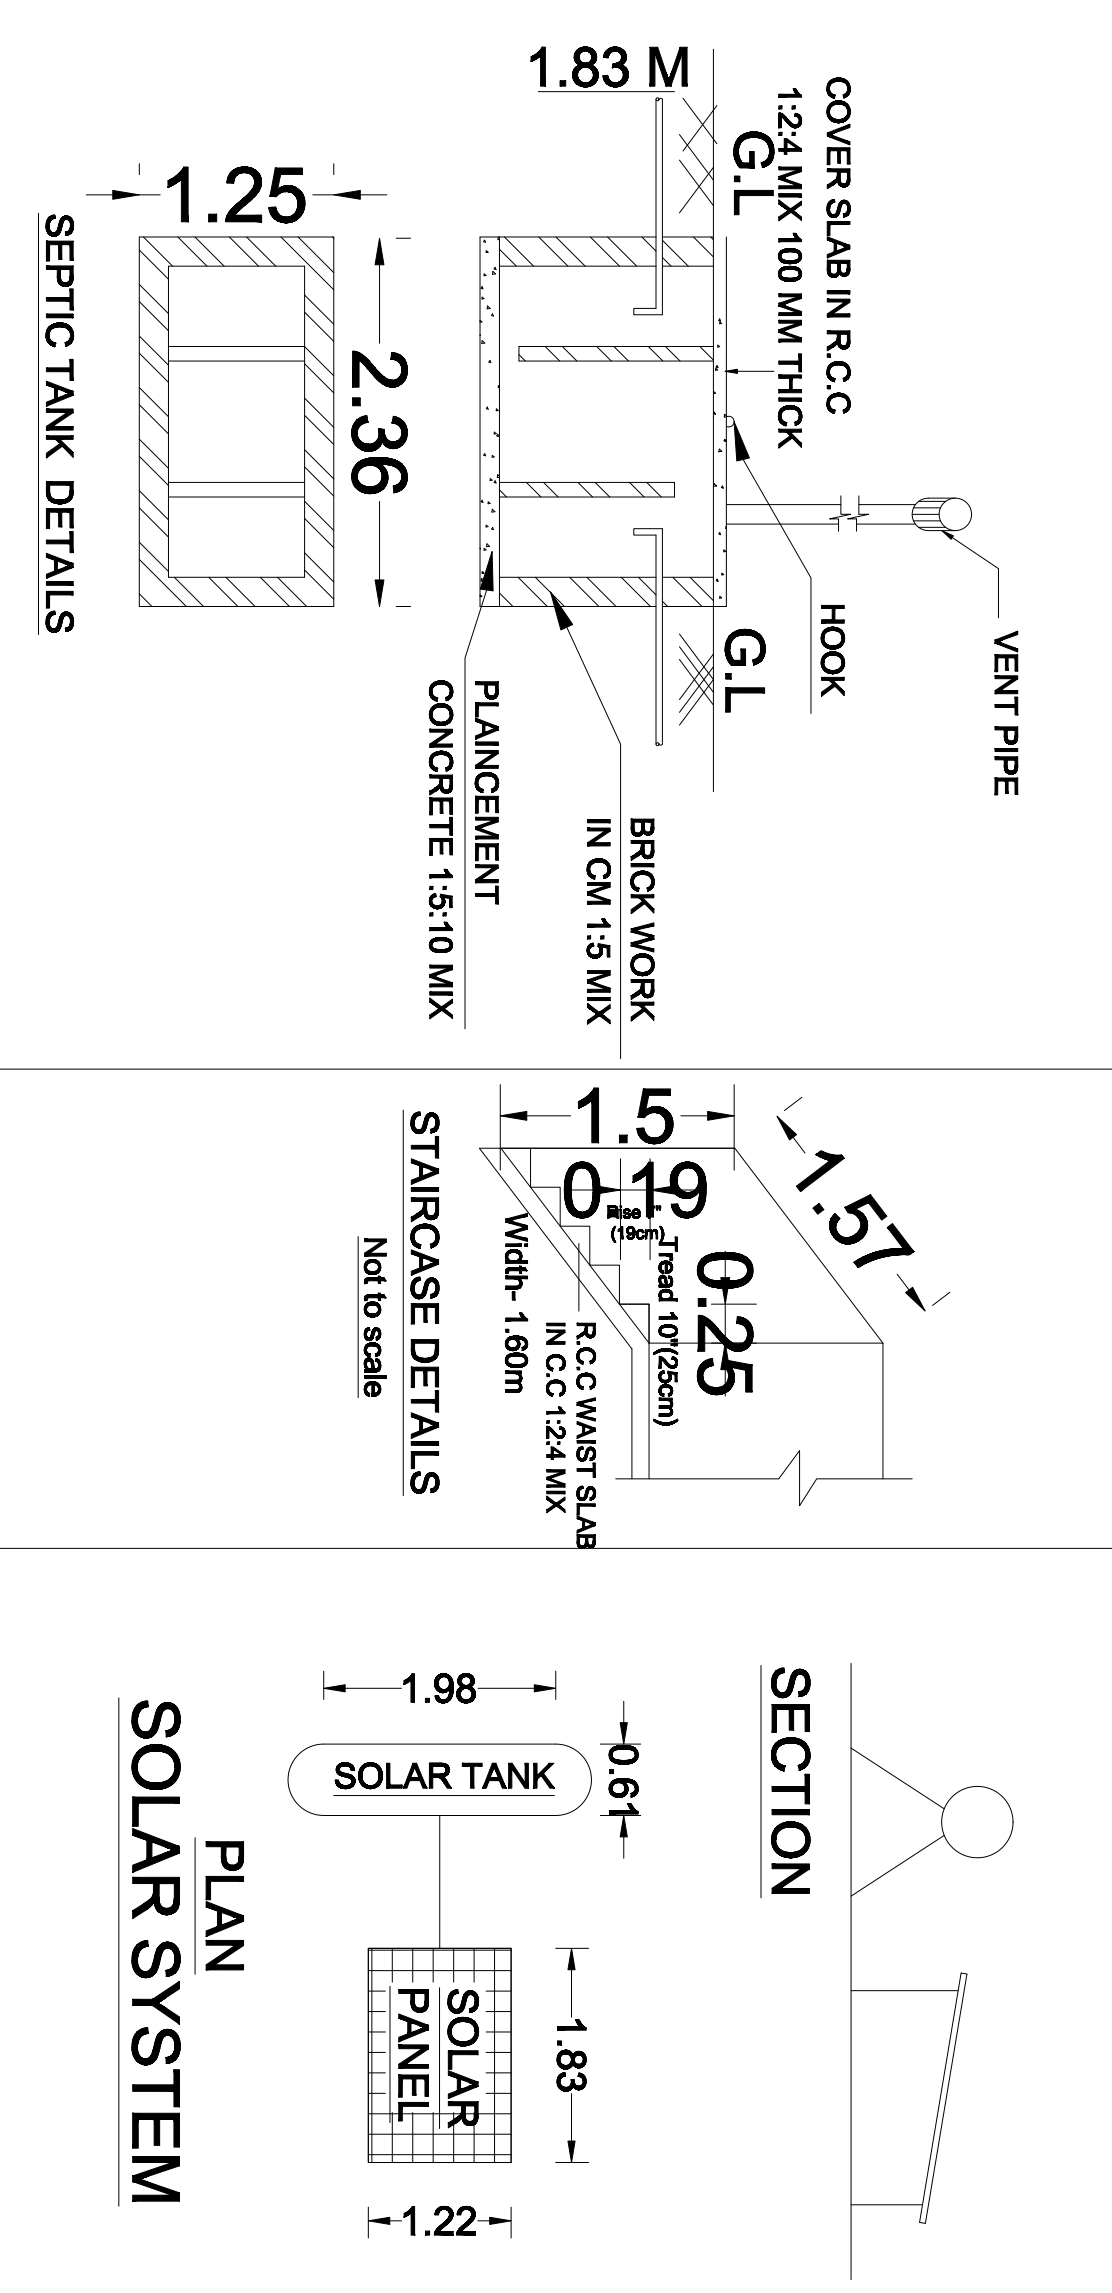

Details of Waste Water Recycling Tank - Kitchen, Bath Waste Water Reuse Method	
WWP	Waste Water Pipe Line 2" Dia From Kitchen, Bath & Dining
C	Collection Chamber
RCT	Organic (or) Mechanical Recycling Tank
TWCS	Treated Waste Water Collection Sump
TWS OHT	Treated Waste Water Storage O.H.T
OLP	Treated Water Outlet Pipe Line 9" Dia. To W.C. & Flush Tank

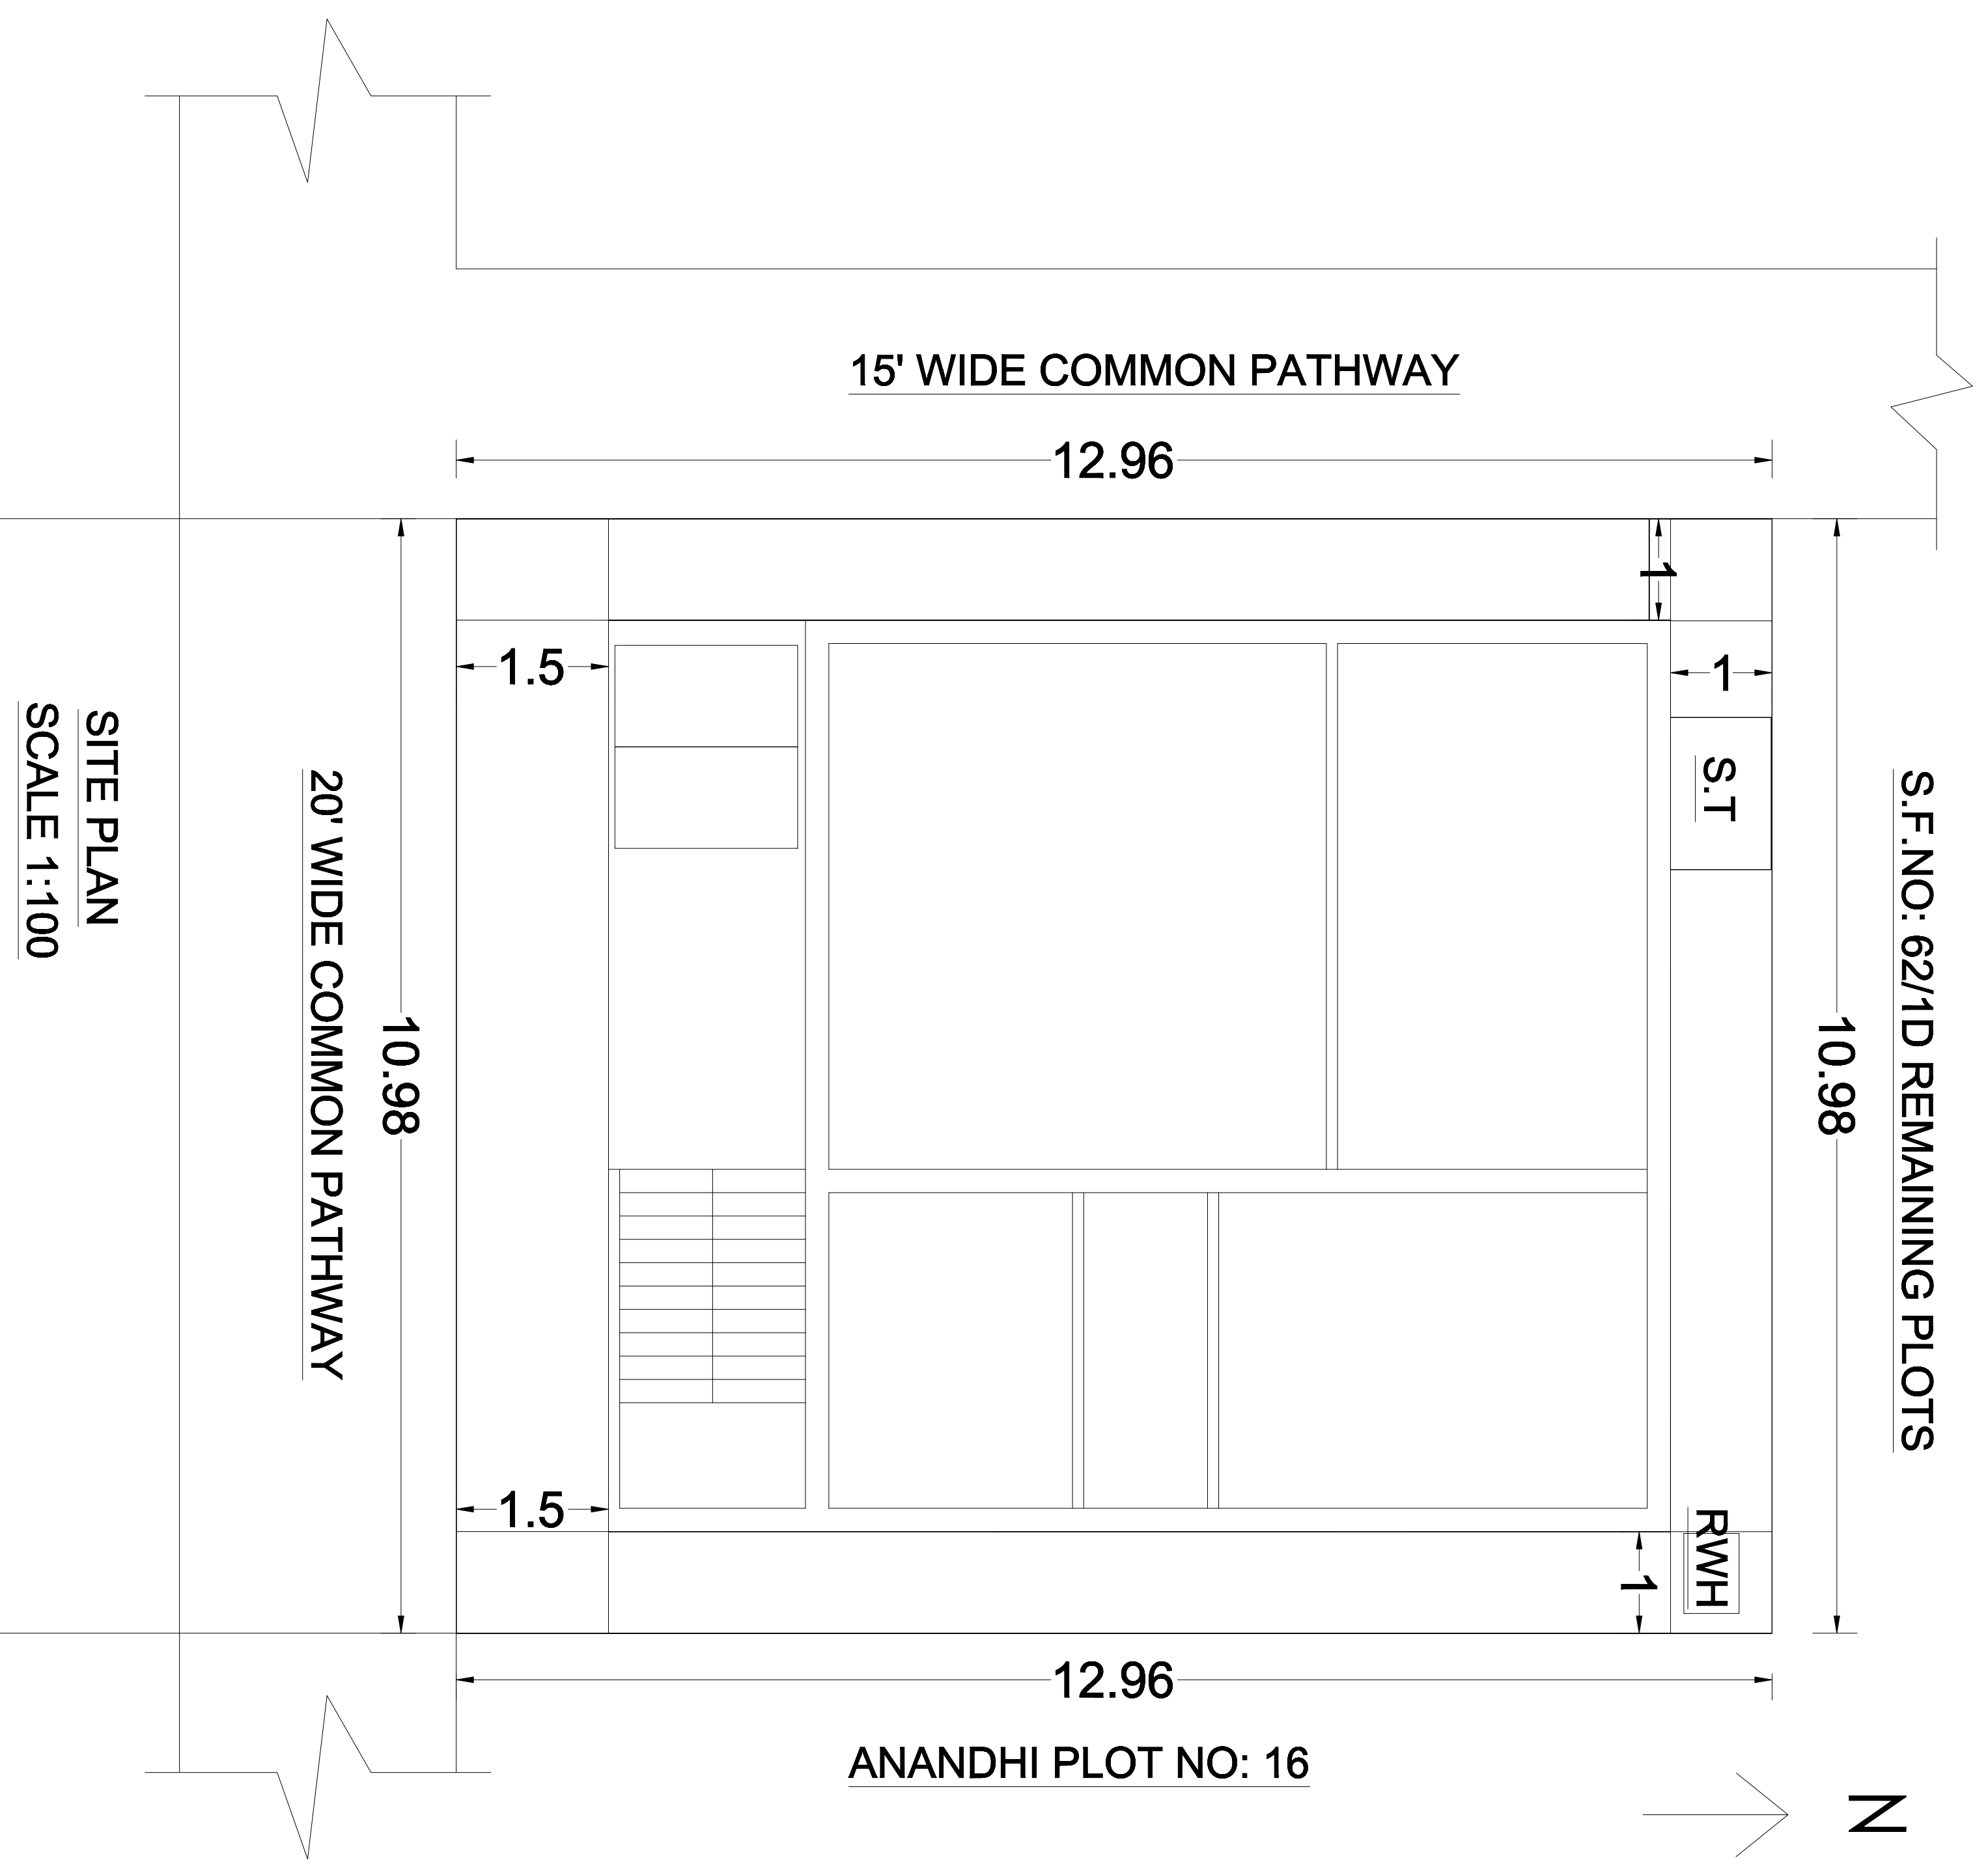

SITE PLAN
SCALE 1:100

AREA DETAILS		SQ.M.	SQ.FT.
AREA OF THE SITE		142.14	1530.00
PLINTH AREA OF THE PROPOSED R.C.C ROOF BUILDING IN GROUND FLOOR		93.93	1011.06
FLOOR AREA OF THE PROPOSED R.C.C ROOF BUILDING		77.21	831.09
AREA OF OPEN SPACE		48.21	518.94
PROPOSED SEPTIC TANK - 1 NO & SOAK PIT		-	1 NO.,
PROPOSED RAINWATER HARVESTING TANK & SUMP		-	1 NO.,

REF	JOINERY SCHEDULE	Meter
MD	Main Door	1.07 x 2.13
D	Door	1.00 x 2.13
D1	Door	0.76 x 2.13
O	Open	1.00 x 2.13
W1	Window	1.83 x 1.37
W	Window	1.20 x 1.37
V	Ventilator	0.91 x 0.91

ALL DIMENSIONS ARE IN METRE & FEET SCALE - 1 : 100

APPLICANT	ENGINEER
-----------	----------

M. A. S.

Er. S. MANOJALABE,
Licensed Building Surveyor,
LIC No: 487/2023
BY ARCHITECTS & CONSTRUCTION
Opp:BSNL Office, TVK Nagar,
Harur Taluk, Dharmapuri District,
Cell:8012122506,3072682507.

OFFICE USE :-