



1
Te

This Document

"EXECUTIVE OF

PANCHAYAT, PALACODE PANCHAYAT

UNION" . So any seal or Sign is not necessary.

ALL DIMENSIONS ARE IN "METER & FEET"

Area Details

PLR / FMB Area	82.00 Sq.Mt
Document Area	82.00 Sq.Mt
Super Imposed Area	82.00 Sq.Mt

SITE DETAILS

Particulars	Total Buildup Area Sq.mt	Total Buildup Area Sq.ft
Total Site Area	82.00	882.32
Ground Floor Plinth Area	45.73	492.05
Ground Floor Carpet Area	61.11	657.72
First Floor Plinth Area	45.73	492.05
First Floor Carpet Area	61.11	657.72
Total Buildup Area	91.46	984.10

SCHEDULE OF JOINERIES


	IN M	
MAIN DOOR	1.05 X 2.1	M.D
DOOR	0.91 X 2.10	D
DOOR (Toilet)	0.76 X 2.10	D1
WINDOW	1.83 X 1.22	W
WINDOW-W1	1.52 X 1.22	W1
VENTILATOR	0.6 X 0.45	V

COLOR INDEX

SITE BOUNDARY	
EXISTING ROAD	
PROPOSED BUILDING	
SEPTIC TANK	
RAIN WATER HARVESTING	

m. Lina

APPLICANT SIGN:

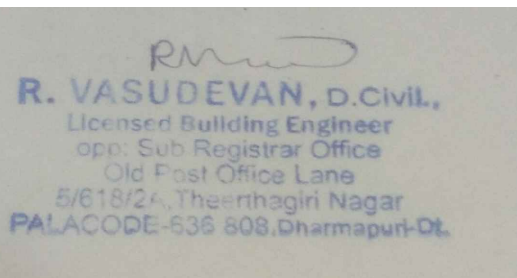


REGISTER ENGINEER:

PLAN SHOWING THE PROPOSED CONSTRUCTION OF R.C.C ROOF GROUND AND FIRST FLOOR RESIDENTIAL BUILDING In OLD SF.NO.1054/55 In PATTA NO:3288, NEW SF.No:1054/55C AT THEERTHAGIRI NAGAR WARD NO:6,NEAR BYPASS ROAD, PALACODE TOWN PANCHAYAT, PALACODE UNION AND TALUK DHARMAPURI DISTRICT.


APPLICANT: Mr.ANANDAN S/o.Mr.MUNUSAMY.

Scale 1:100

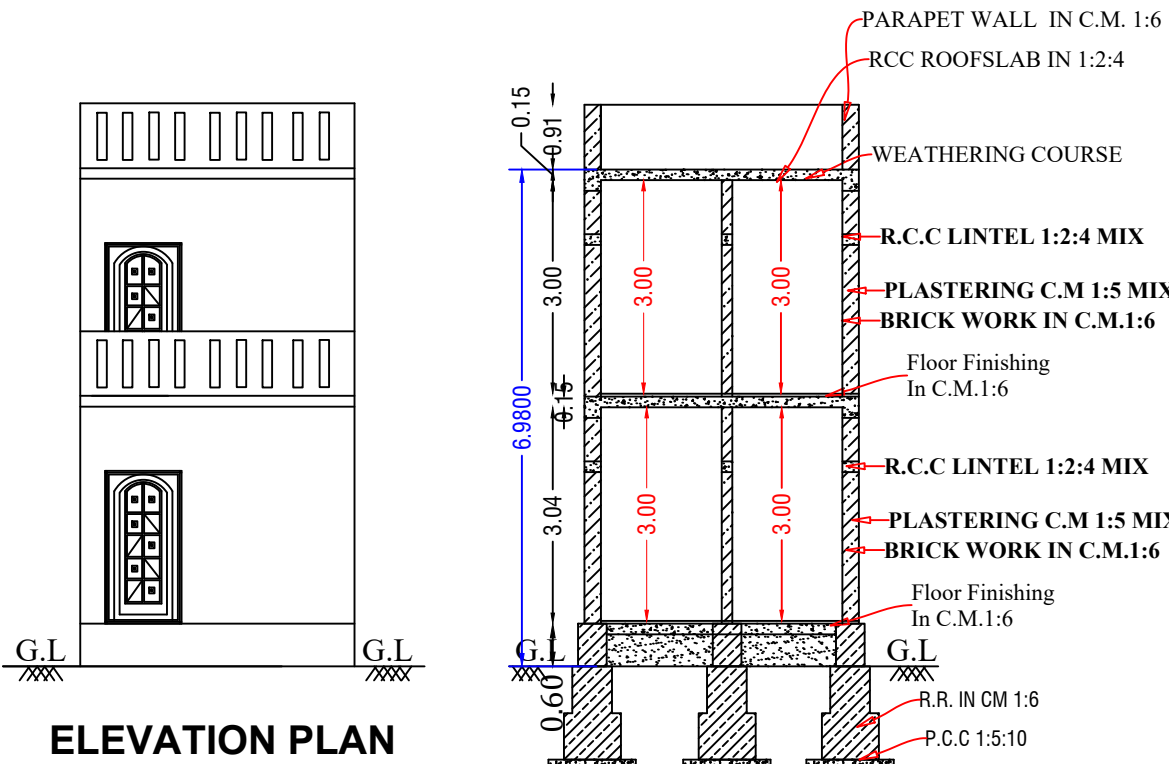

ELEVATION PLAN


SECTION ON-AA'

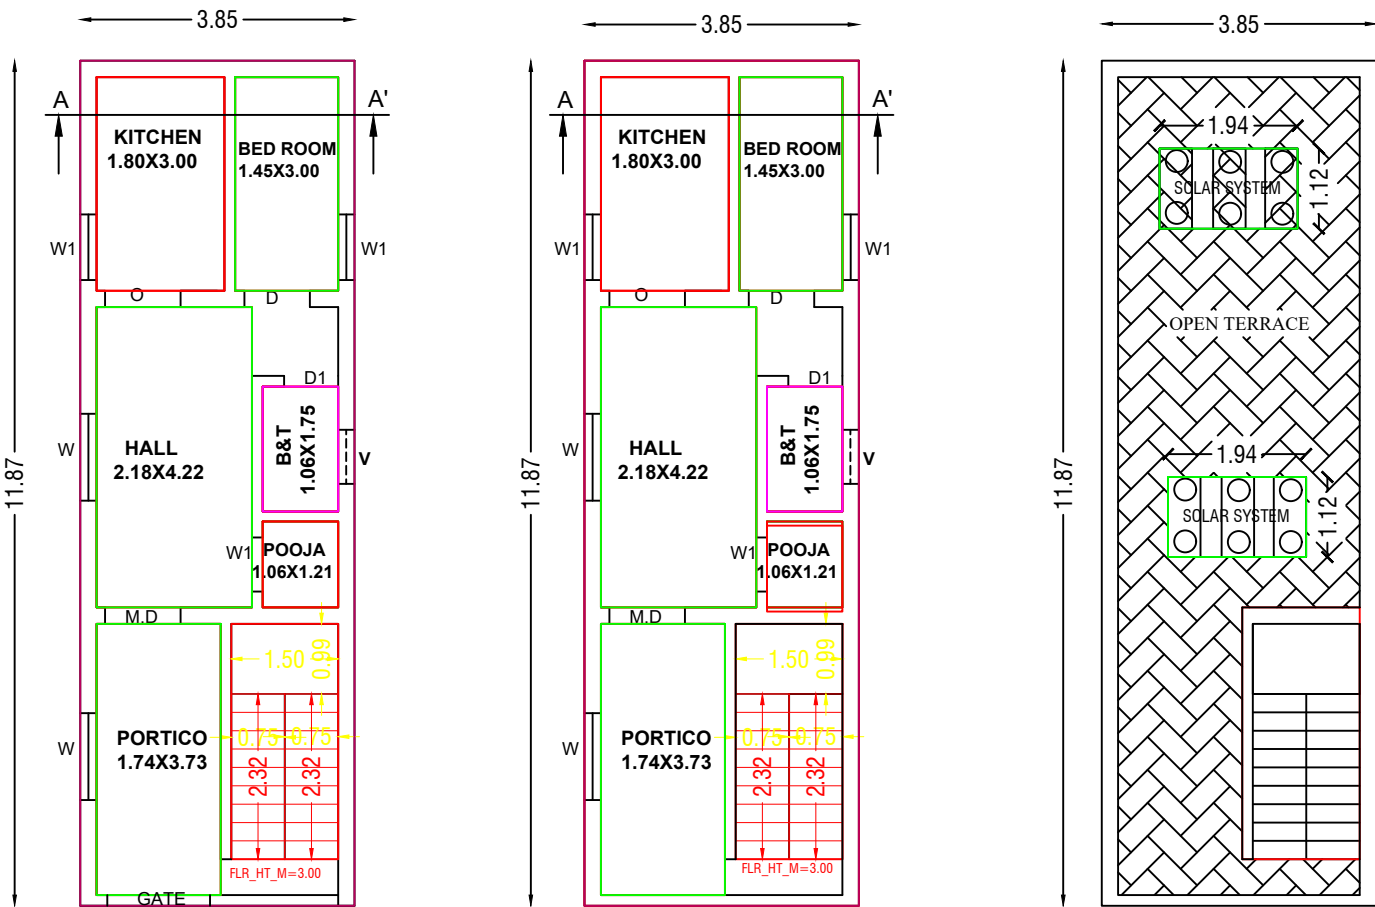

Ground Floor Plan

First Floor Plan

Terrace Floor Plan

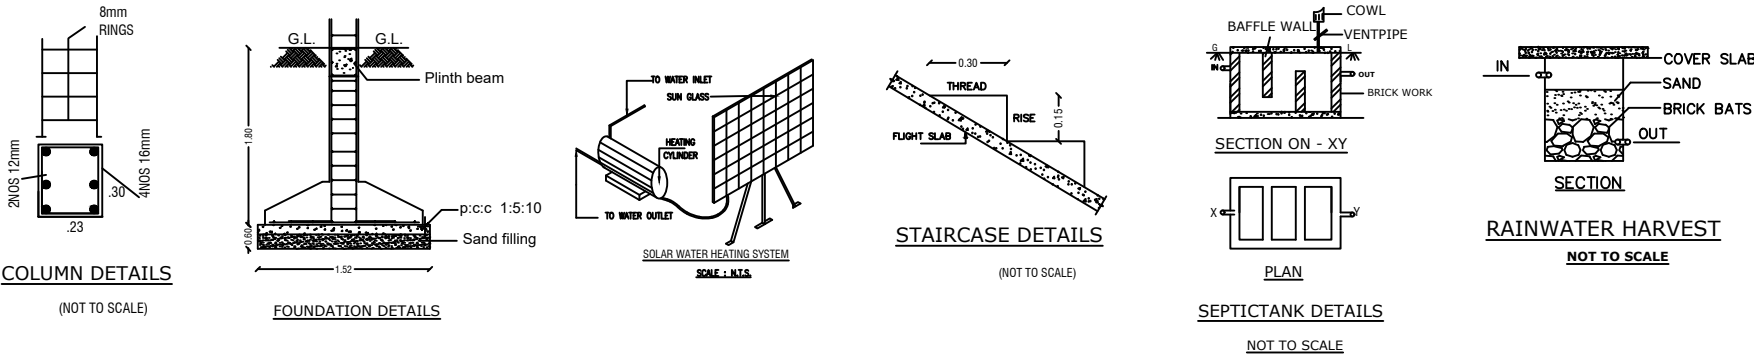

COLUMN DETAILS
(NOT TO SCALE)

FOUNDATION DETAILS

SOLAR WATER HEATING SYSTEM
SCALE: 1:100



STAIRCASE DETAILS
(NOT TO SCALE)

SEPTICTANK DETAILS
NOT TO SCALE

RAINWATER HARVEST
NOT TO SCALE

LOCATION PLAN

NOT TO SCALE

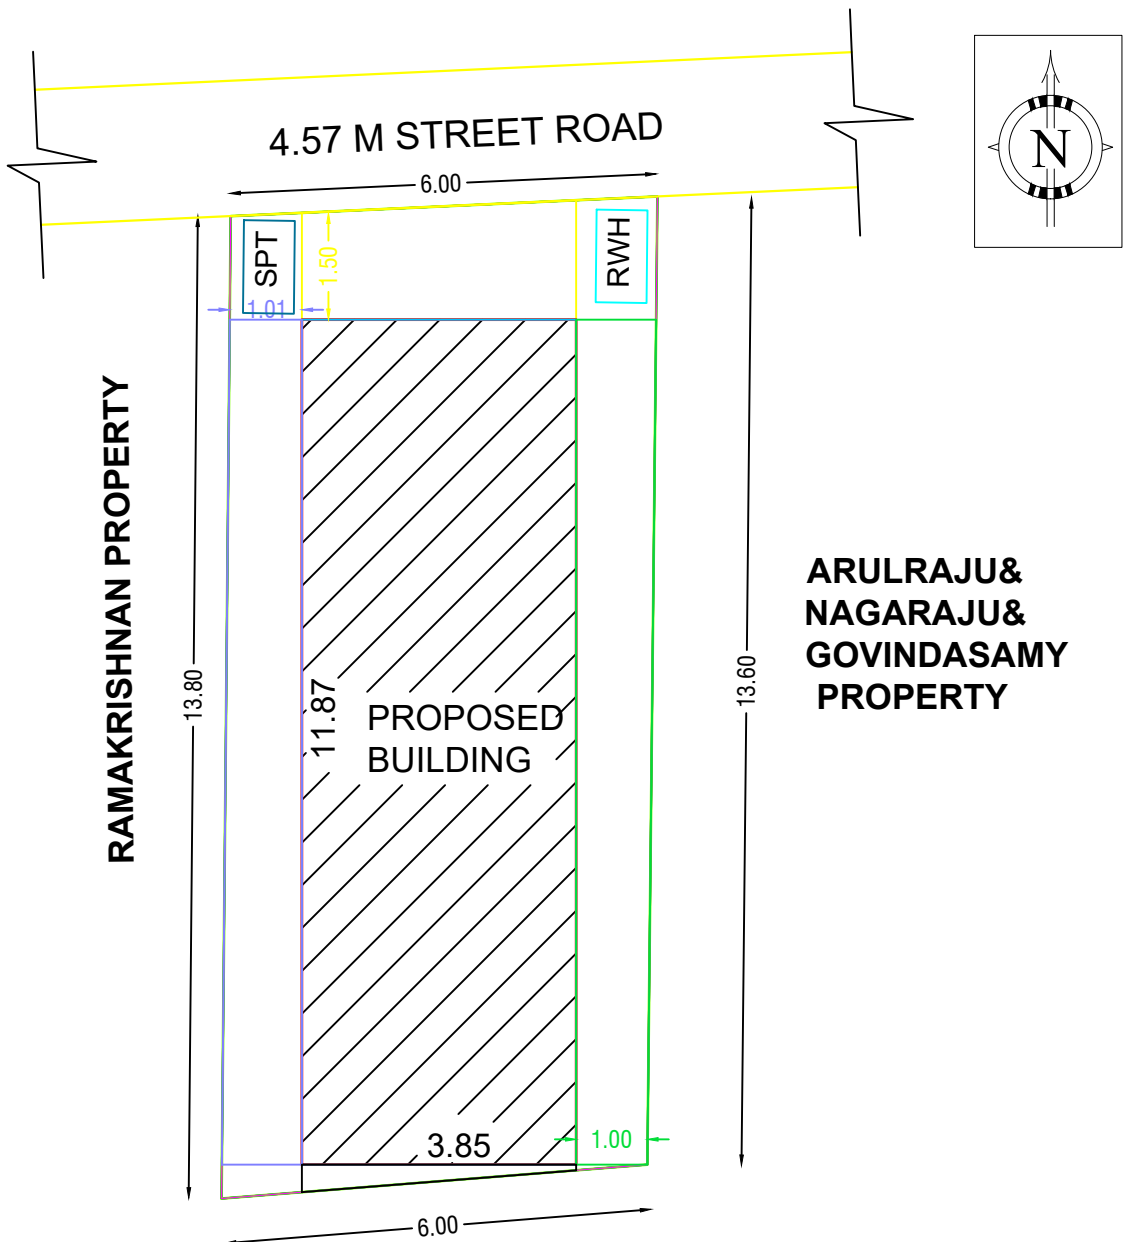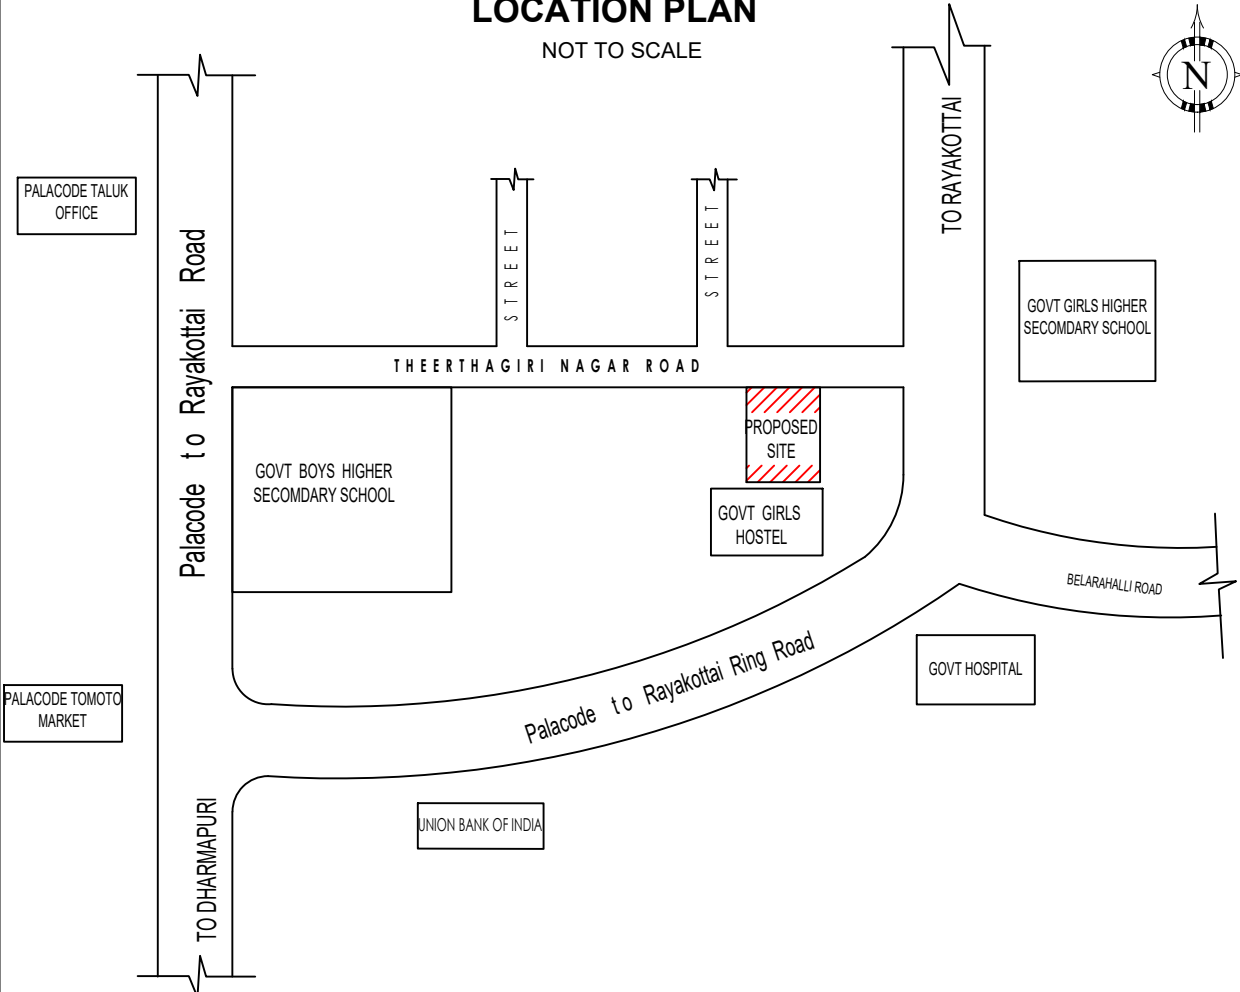

GOVT GIRLS HOSTEL

SITE PLAN

SCALE - 1:100