



PLAN SHOWING THE PROPOSED CONSTRUCTION OF A TERRACE ROOF RESIDENTIAL BUILDING IN RE.SY.NO: 306 / 16B IN ANDUCODE "B" VILLAGE , EDAICODE TOWN PANCHAYAT, VILAVANCODE TALUK,K.K.DISTRICT.


NAME AND ADDRESS OF OWNER: Mr.R.SHAJESSH KUMAR , S/O Mr.RAJAYYAN, 8-43 , KANJIRAMKUZHIVILAI , ANDUCODE (P.O) , K.K.DISTRICT .

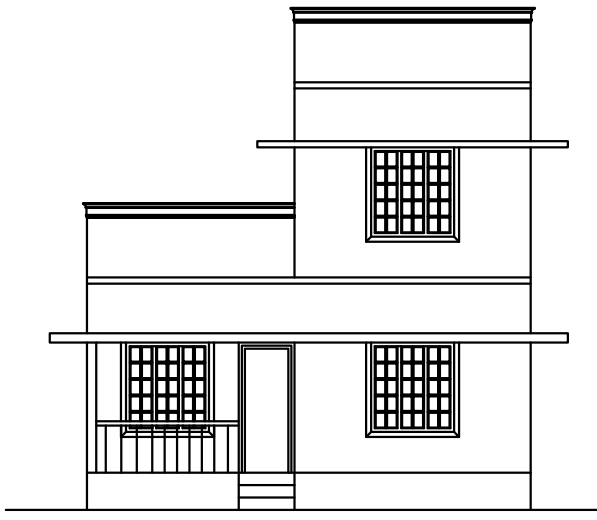


ELEVATION

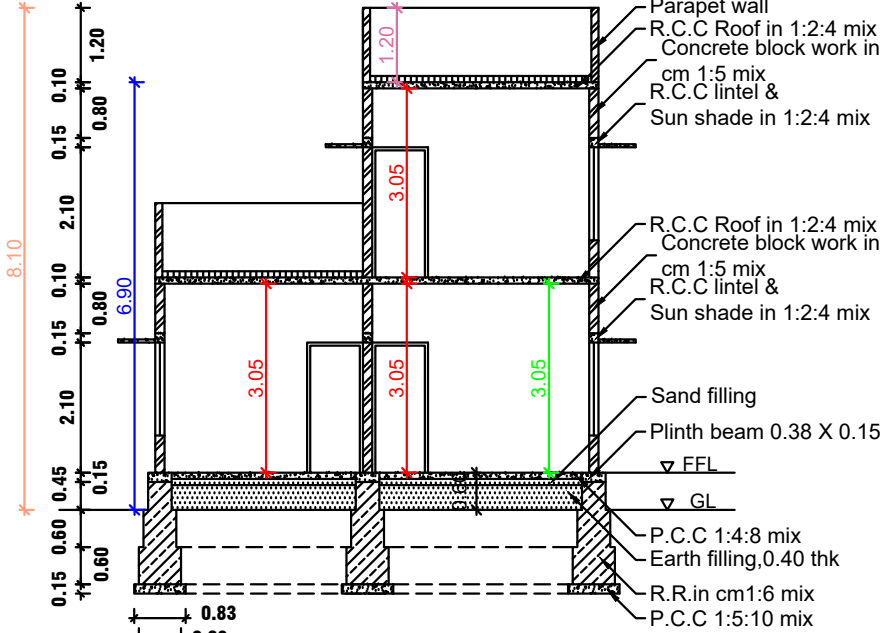

SECTION ON AB

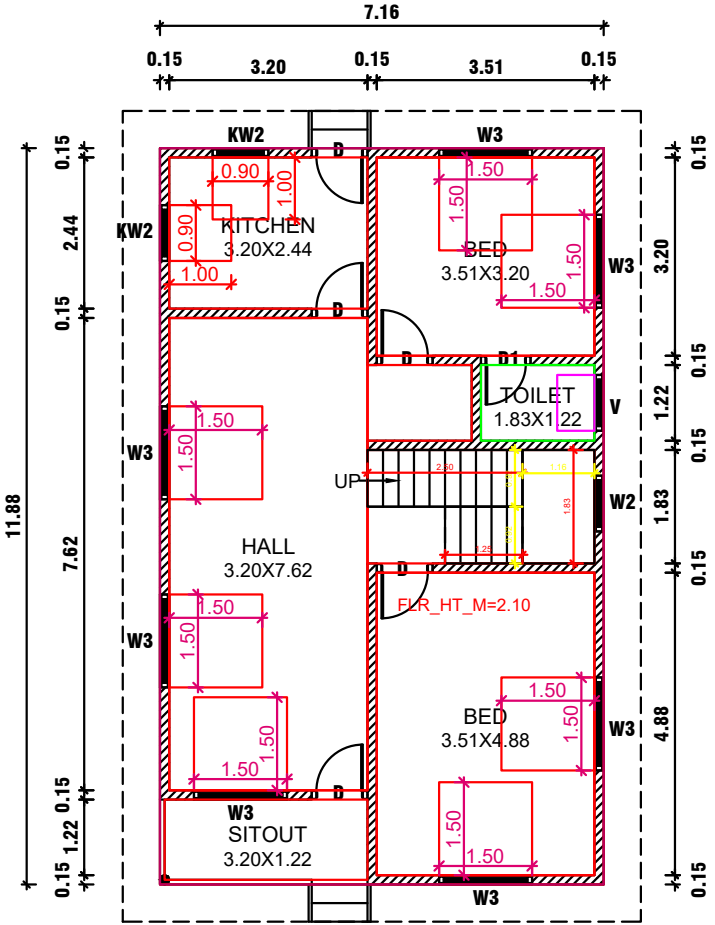


GROUND FLOOR PLAN

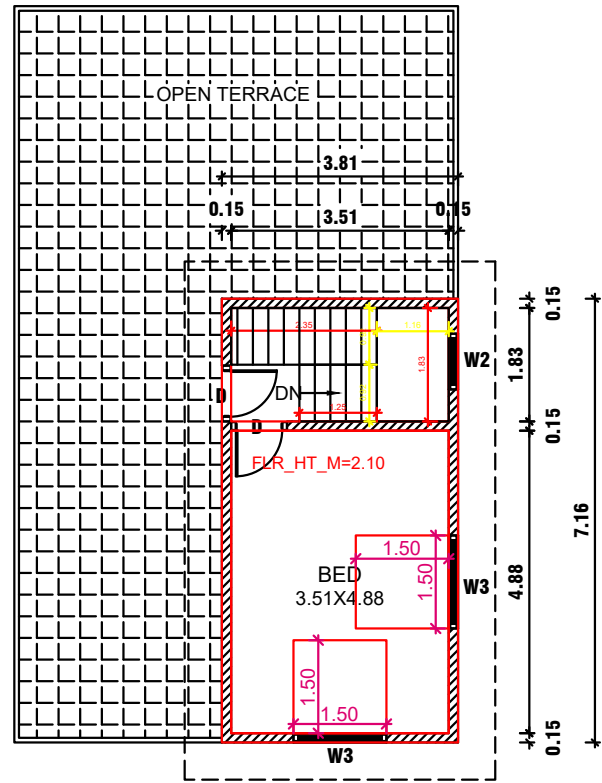

FIRST FLOOR PLAN


PLAN INFO
PLOT_AREA_M2=404.70
AS_AT_SITE=403.00
FMB_OR_PLR=404.70
AS_PER_DOCUMENT=404.70
ROAD_WIDTH=4.00
AVG_PLOT_WIDTH=13.00
AVG_PLOT_DEPTH=31.00
ROAD_LENGTH=100.00
AREA_TYPE=OTHERS
SURVEY_NO=306/16B
PATTA_NO=5841
TALUK=VILAVANCODE
JURISDICTION_TYPE= PANCHAYAT
FAMILY_BLDG=YES
LICABLE=NO
R_BUYBACK_RETAIN=RETAIN
FSI_REQUIRED=NO
RENDER_OR_BUYBACK=YES
IVED_LAYOUT=YES
ATION_TYPE=PRIVATE

IE_ZONE = RESIDENTIAL
I=0
=KANYAKUMARI
LING_POOL_EXISTS=NO
CLARED=YES
AGE_TOWN_LESS THAN 1KM_RADIUS=NO

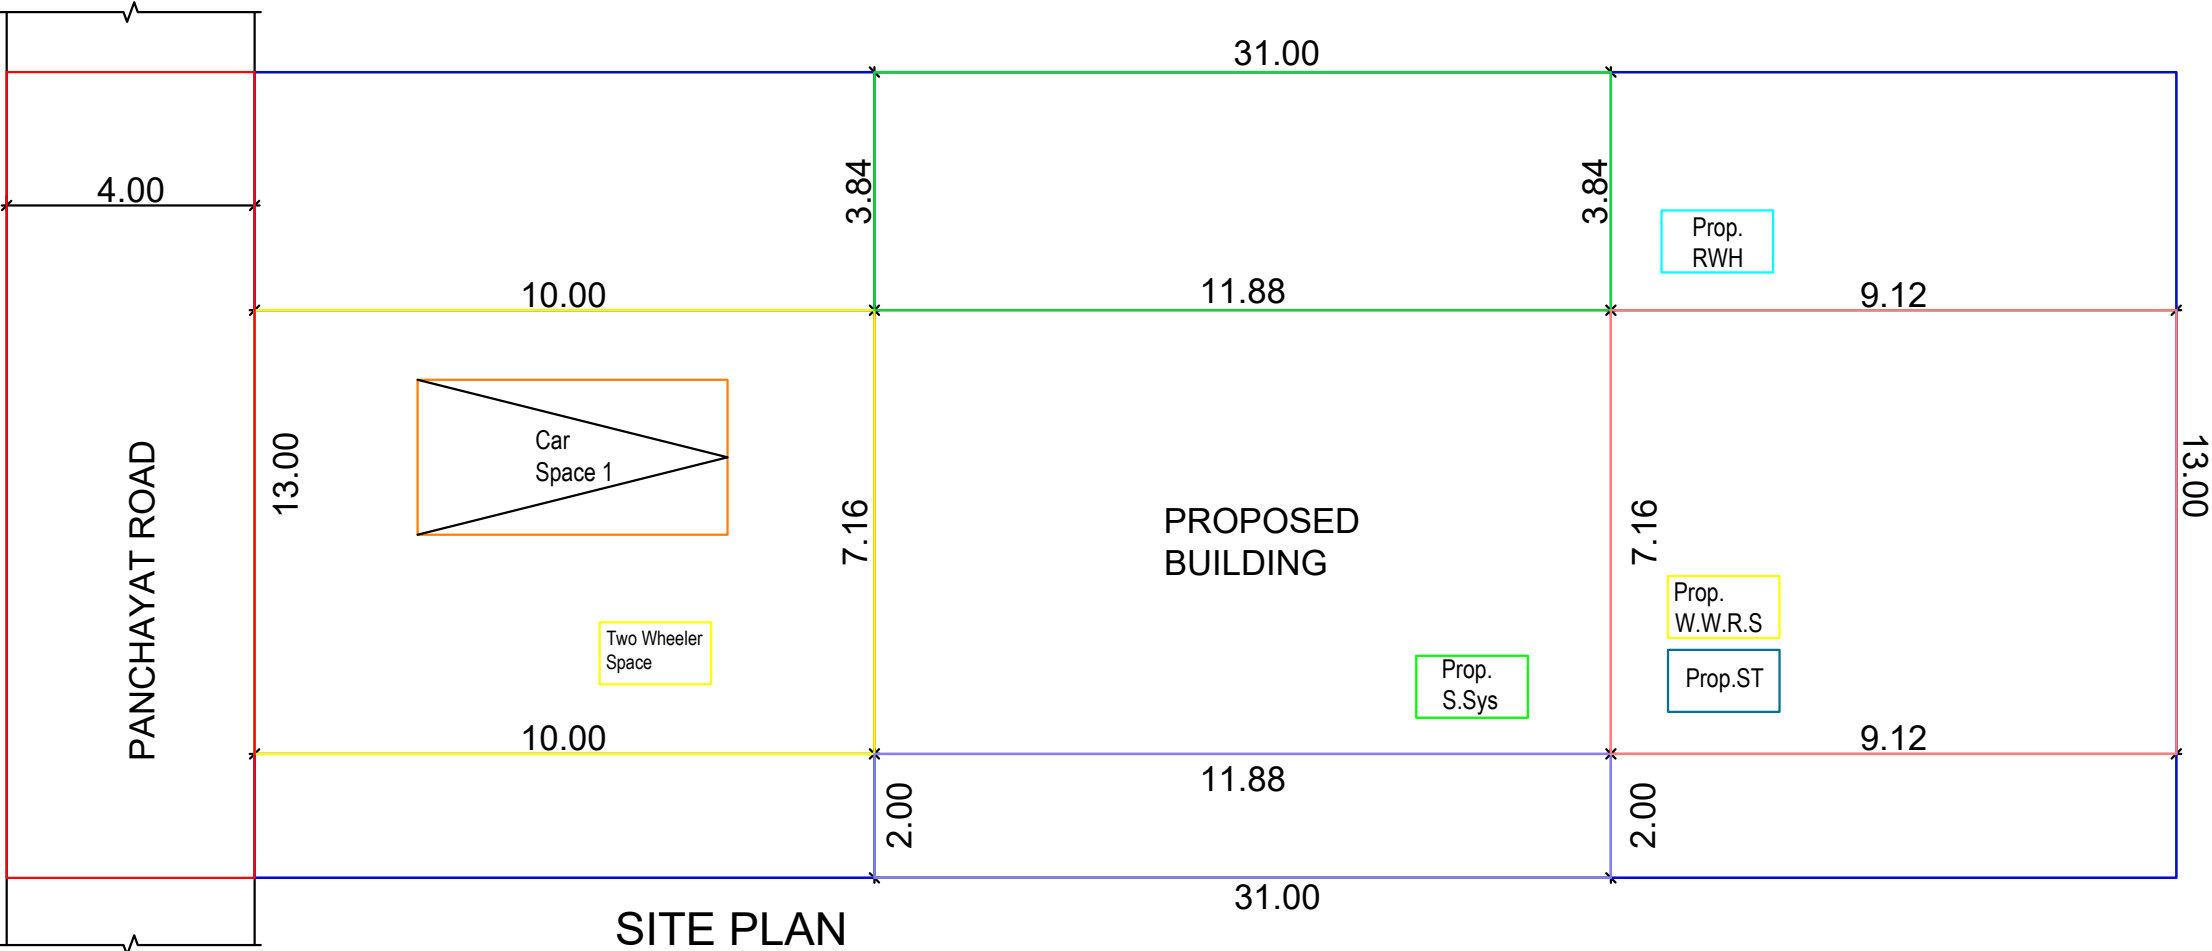


SITE PLAN


SCALE: 1:100.

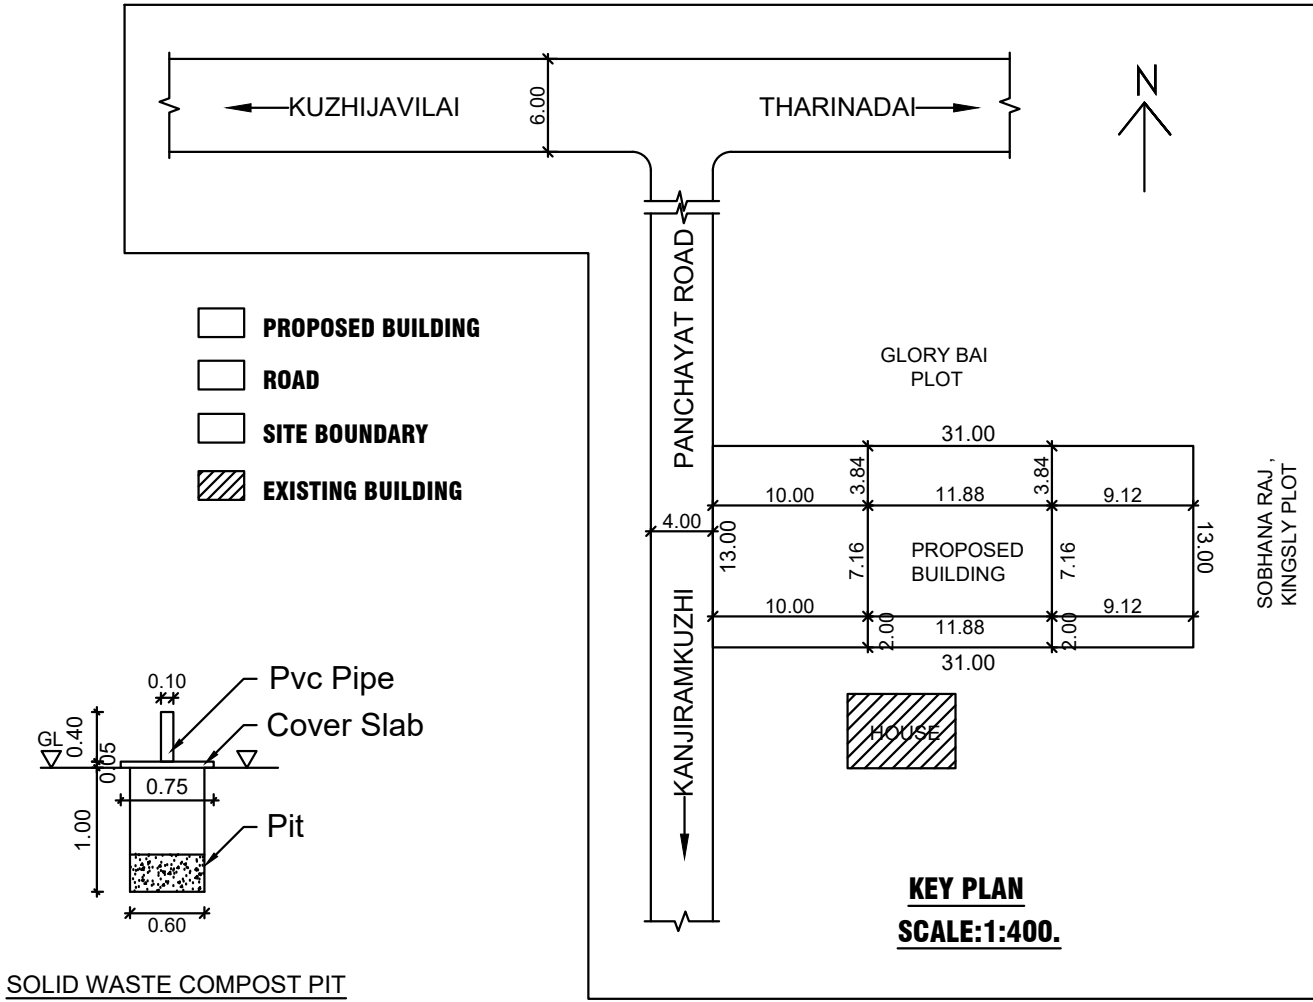


KEY PLAN
SCALE:1:400.

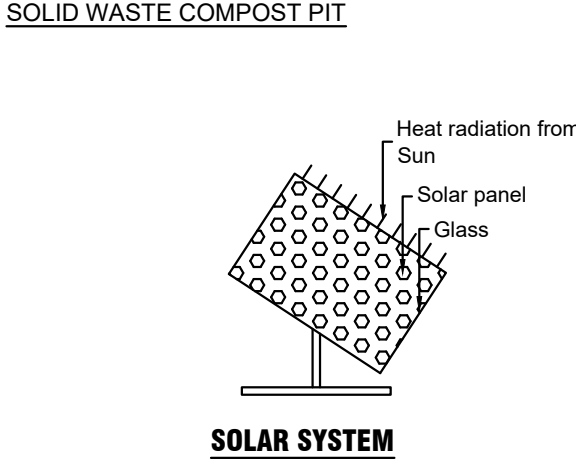


SOLAR SYSTEM

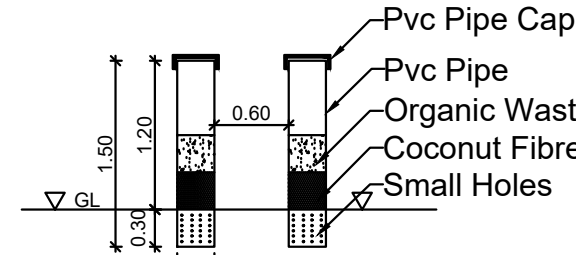


PIPE COMPOST PIT

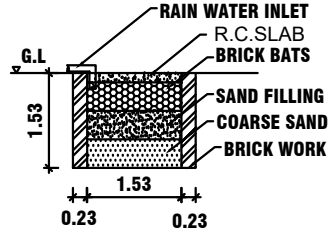

RAIN WATER
HARVESTING PIT

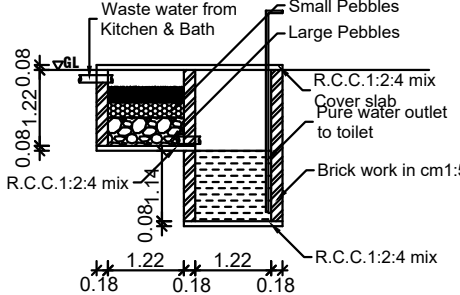


WASTE WATER RECYCLING SYSTEM

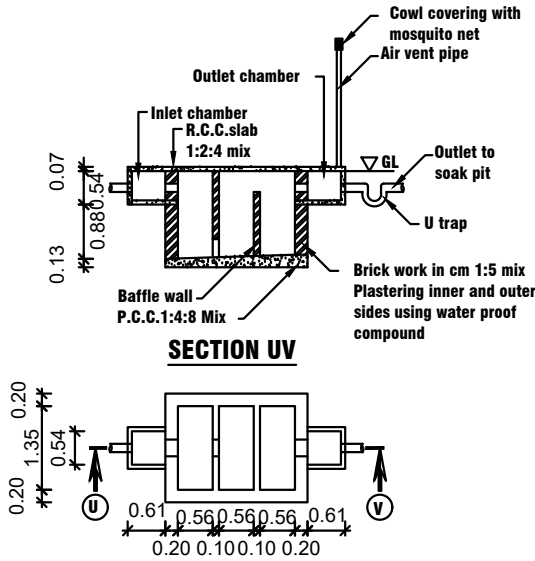

SECTION UV

SEPTIC TANK PLAN

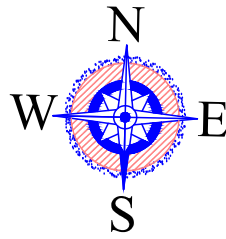

AREA DETAILS - BUILDING			
PLINTH AREA			
Ground Floor	85.06 Sq.m	915.59 Sq.ft	
First Floor	27.28 Sq.m	293.64 Sq.ft	
Total	112.34 Sq.mt	1209.23 Sq.ft	
FLOOR AREA			
Ground Floor	75.48 Sq.m	812.47 Sq.ft	
First Floor	23.55 Sq.m	253.49 Sq.ft	
Total	99.03 Sq.mt	1065.96 Sq.ft	
AREA DETAILS - PLOT			
Site Area	10.000 Cents	4.05 Are	
	(404.700 Sq.m)	(4356.00 Sq.ft)	
Vacant Area	319.64 Sq.m	3440.60 Sq.ft	
F.S.I	112.34 /	404.70	0.28 < 2.00
PC	85.06 /	404.70	21.02 < 50
SCHEDULE OF JOINERIES			
REF	DESCRIPTION	SIZE	
D	DOOR	0.90X2.10	
D1	DOOR	0.80X2.10	
W3	WINDOW	1.50 X 1.50	
W2	WINDOW	0.90 X 1.50	
KW2	WINDOW	0.90 X 1.00	
V	VENTILATOR	0.90 X 0.60	
SCALE :	ALL DIMENSIONS ARE IN METRE	EDWG NO :	
1:100		0 1 1 0 8 2	
		1 1 1 2 4	
Drawn By:			MOBILE NO: 9442304902
SOBHANA ENGINEERING CONSTRUCTION			
PUTHENCHANTHAI.			

APPLICANT

S. SAMIRAJ WELL, DCE
REGISTERED CIVIL ENGINEER
BETHEL COMPOUND, MELPALAI,
EDAICODE - P.O. 629 152
CELL: 9443595349

ENGINEER