



PLAN SHOWING THE PROPOSED CONSTRUCTION OF A TERRACE ROOF RESIDENTIAL BUILDING
IN RE.SY NO:695 / 3A OF UNNAMALAIKADAI VILLAGE, UNNAMALAIKADAI TOWN PANCHAYAT,
VILAVANCODE TALUK, KANYAKUMARI DISTRICT.

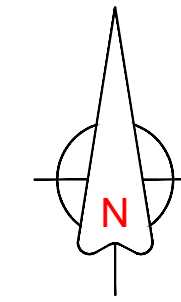


NAME OF APPLICANT :


Mrs.SHYAMALA,
W/O.Mr.JOHNSON,
PULLUVILAI VEEDU, MALANVILAI,
VIRICODE (P.O),
K.K.DIST.

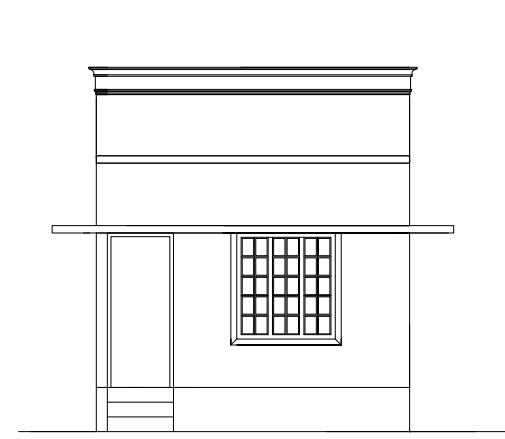


ELEVATION

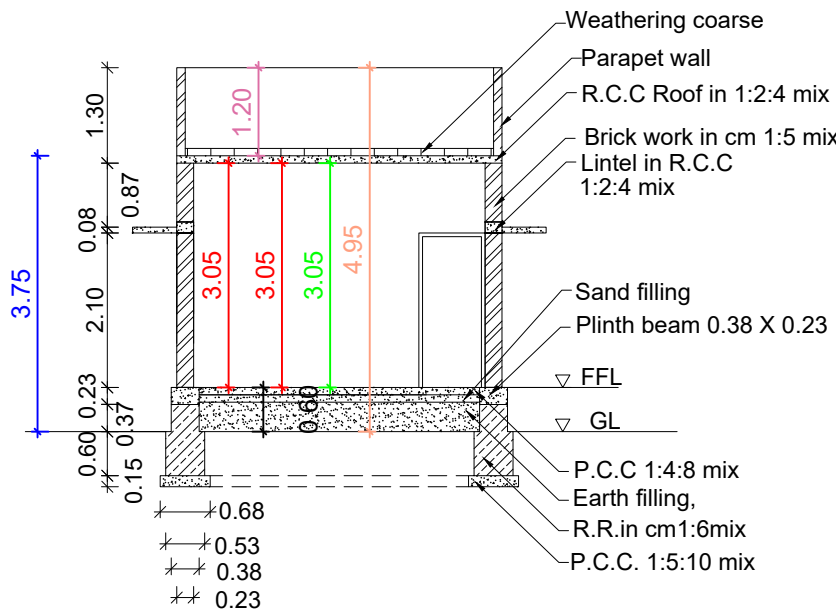

SECTION ON AB

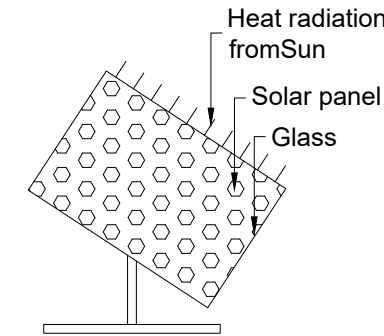

SOLAR SYSTEM

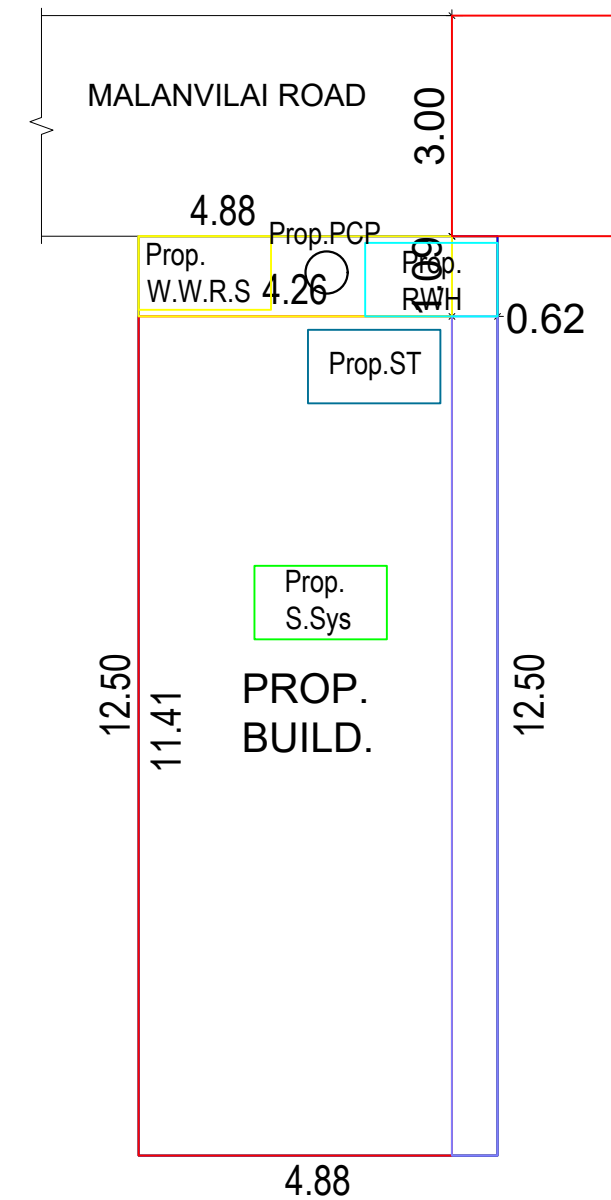

SITE PLAN
SCALE:1:100

AREA DETAILS - BUILDING		
PLINTH AREA		
Plinth Area	48.61 Sq.m	523.24 Sq.ft
Floor Area	41.62 Sq.m	448.00 Sq.ft
AREA DETAILS - PLOT		
Site Area	1.500 Cents	0.61 Are
	(60.705 Sq.m)	(653.40 Sq.ft)
Vacant Area	12.10 Sq.m	130.19 Sq.ft
F.S.I	48.61 / 60.71	0.80 < 2.00

SCHEDULE OF JOINERIES

REF	DESCRIPTION	SIZE
D	Door	0.90X2.10
D1	Door	0.80X2.10
W3	Window	1.50X1.50
KW3	Window	1.50X1.00
V	Ventilator	0.90X0.60
SCALE :	ALL DIMENSIONS ARE IN METRE	DWG NO : 0 0 9 6 0 1 0 2 5


T. Shya

APPLICANT


A. Arunesh

A. ARUNESH DCB
Engineer - Grade III-RE
Reg No: RE III/KKDTCP/004/2024
Opp to Panchayat Office, Viricode & (P.O)
Cell: 9443162900, 9944373900
E.mail: aarunesh14@gmail.com


ENGINEER

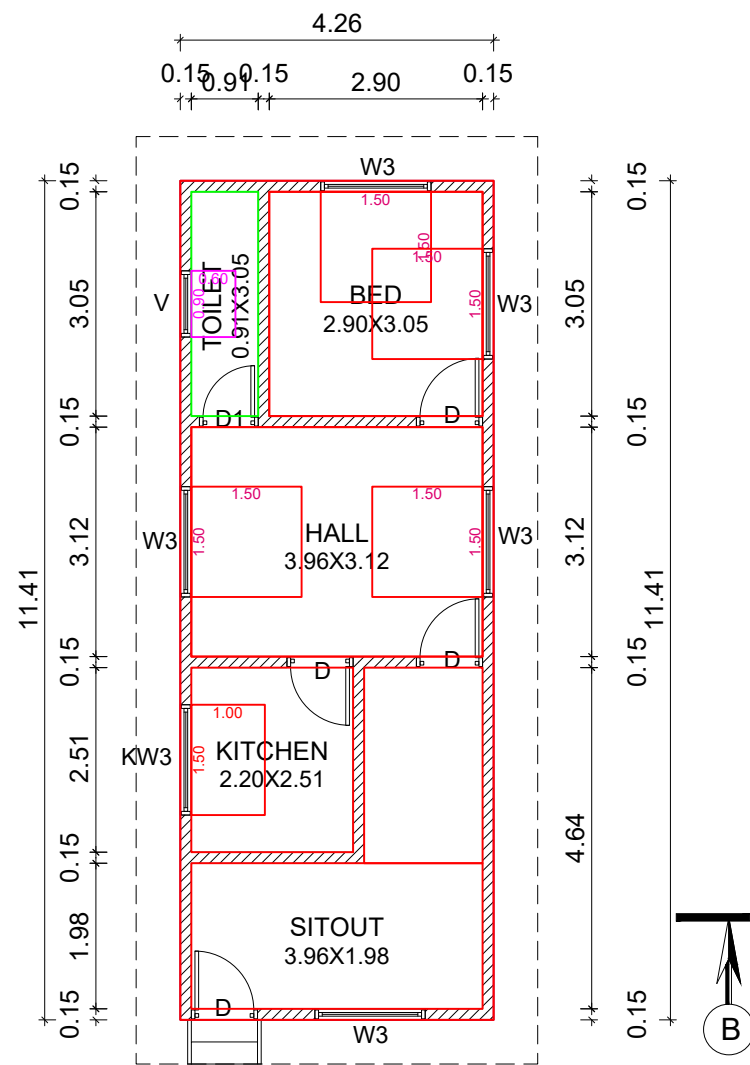

GROUND FLOOR PLAN

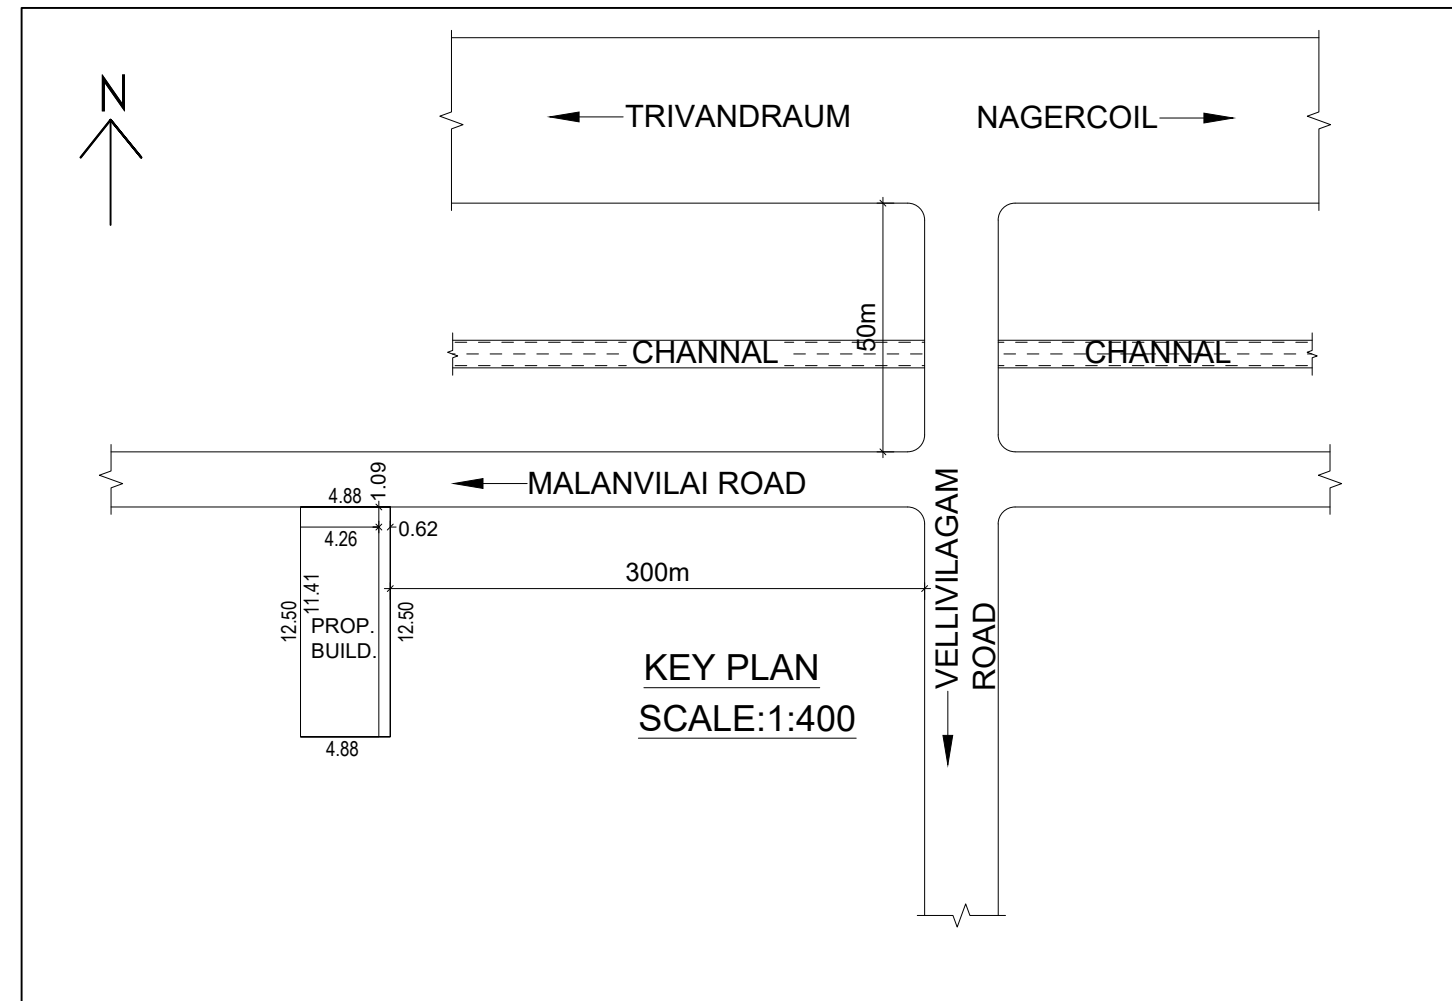


KEY PLAN
SCALE:1:400

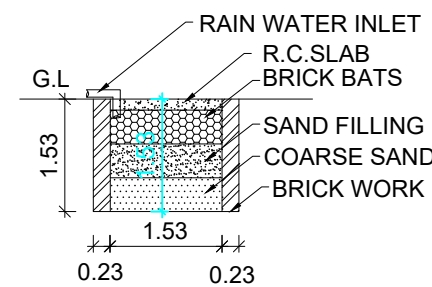


RAIN WATER
HARVESTING TANK

RWH_CAPACITY_L=5000LTRS

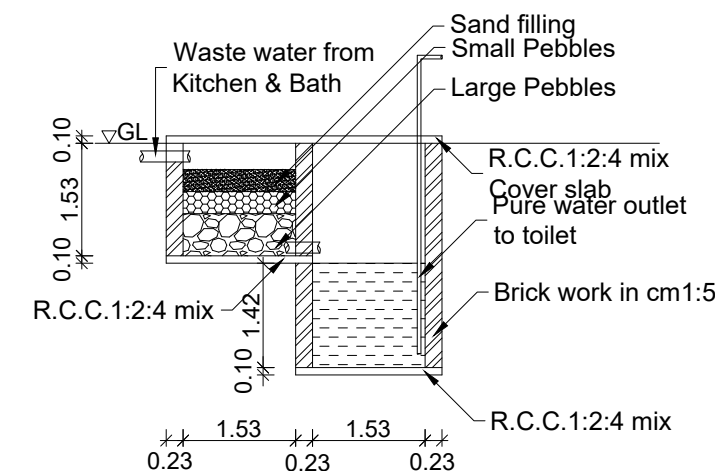


WASTE WATER RECYCLING SYSTEM


PLAN INFO
PLOT_AREA_M2=60.71
AS_AT_SITE=61.00
FMB_OR_PLR=60.71
AS_PER_DOCUMENT=60.71
ROAD_WIDTH=3.00
AVG_PLOT_WIDTH=4.88
AVG_PLOT_DEPTH=12.50
ROAD_LENGTH=100.00
AREA_TYPE=EWS
SURVEY_NO=695/3A
PATTA_NO=4955
TALUK=VILAVANCODE
JURISDICTION_TYPE=PANCHAYAT
SINGLE_FAMILY_BLDG=YES
OSR_APPLICABLE=NO
OSR_SURR_BUYBACK_RETAIN=RETAIN
PREMIUM_FSI_REQUIRED=NO
OSR_SURRENDER_OR_BUYBACK=YES
IS_APPROVED_LAYOUT=YES
ORGANIZATION_TYPE=PRIVATE
CRZ=NO
LAND_USE_ZONE=RESIDENTIAL
PLOT_NO=0
DISTRICT=KANYAKUMARI
IS_SWIMMING_POOL_EXISTS=NO
RWH_DECLARED=YES
IF_HERITAGE_TOWN_LESS THAN 1KM_RADIUS=NO

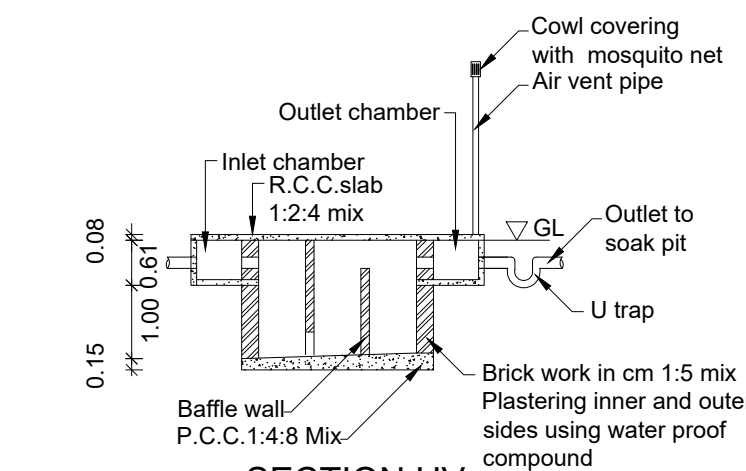

SECTION UV

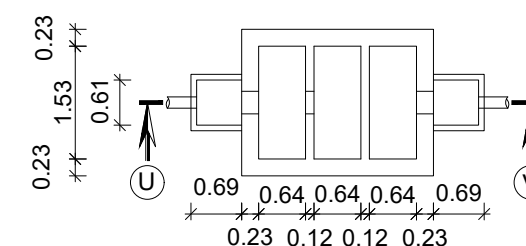

SEPTIC TANK PLAN

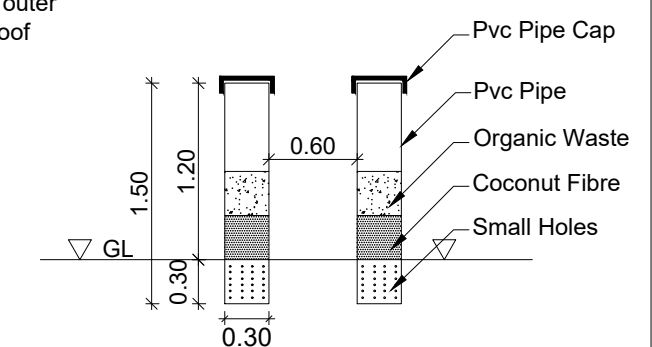

PIPE COMPOST PIT

