


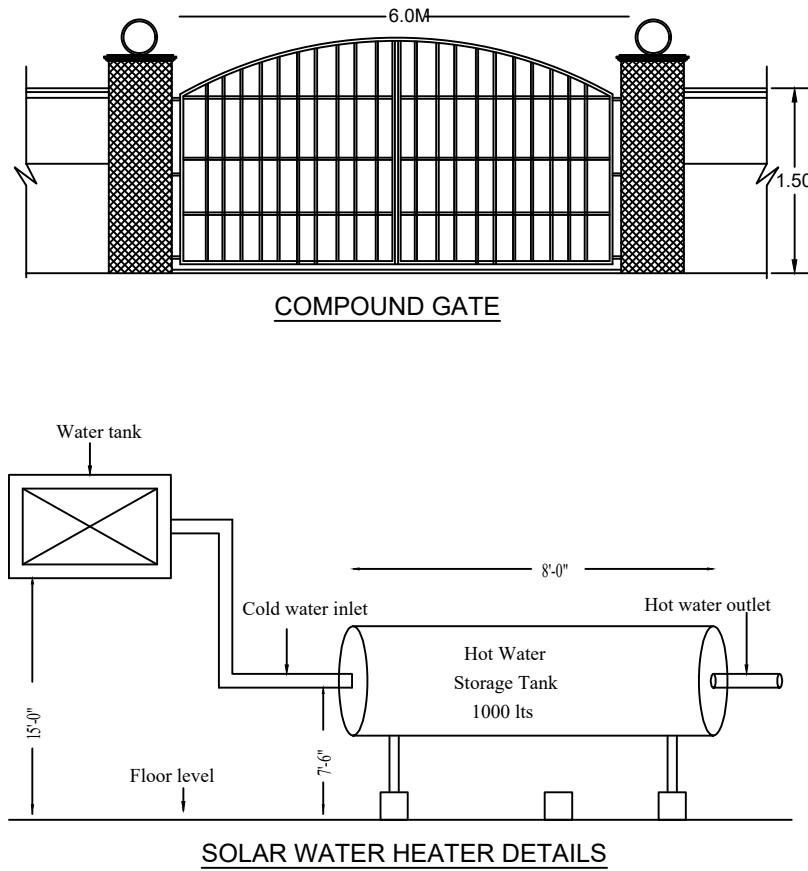
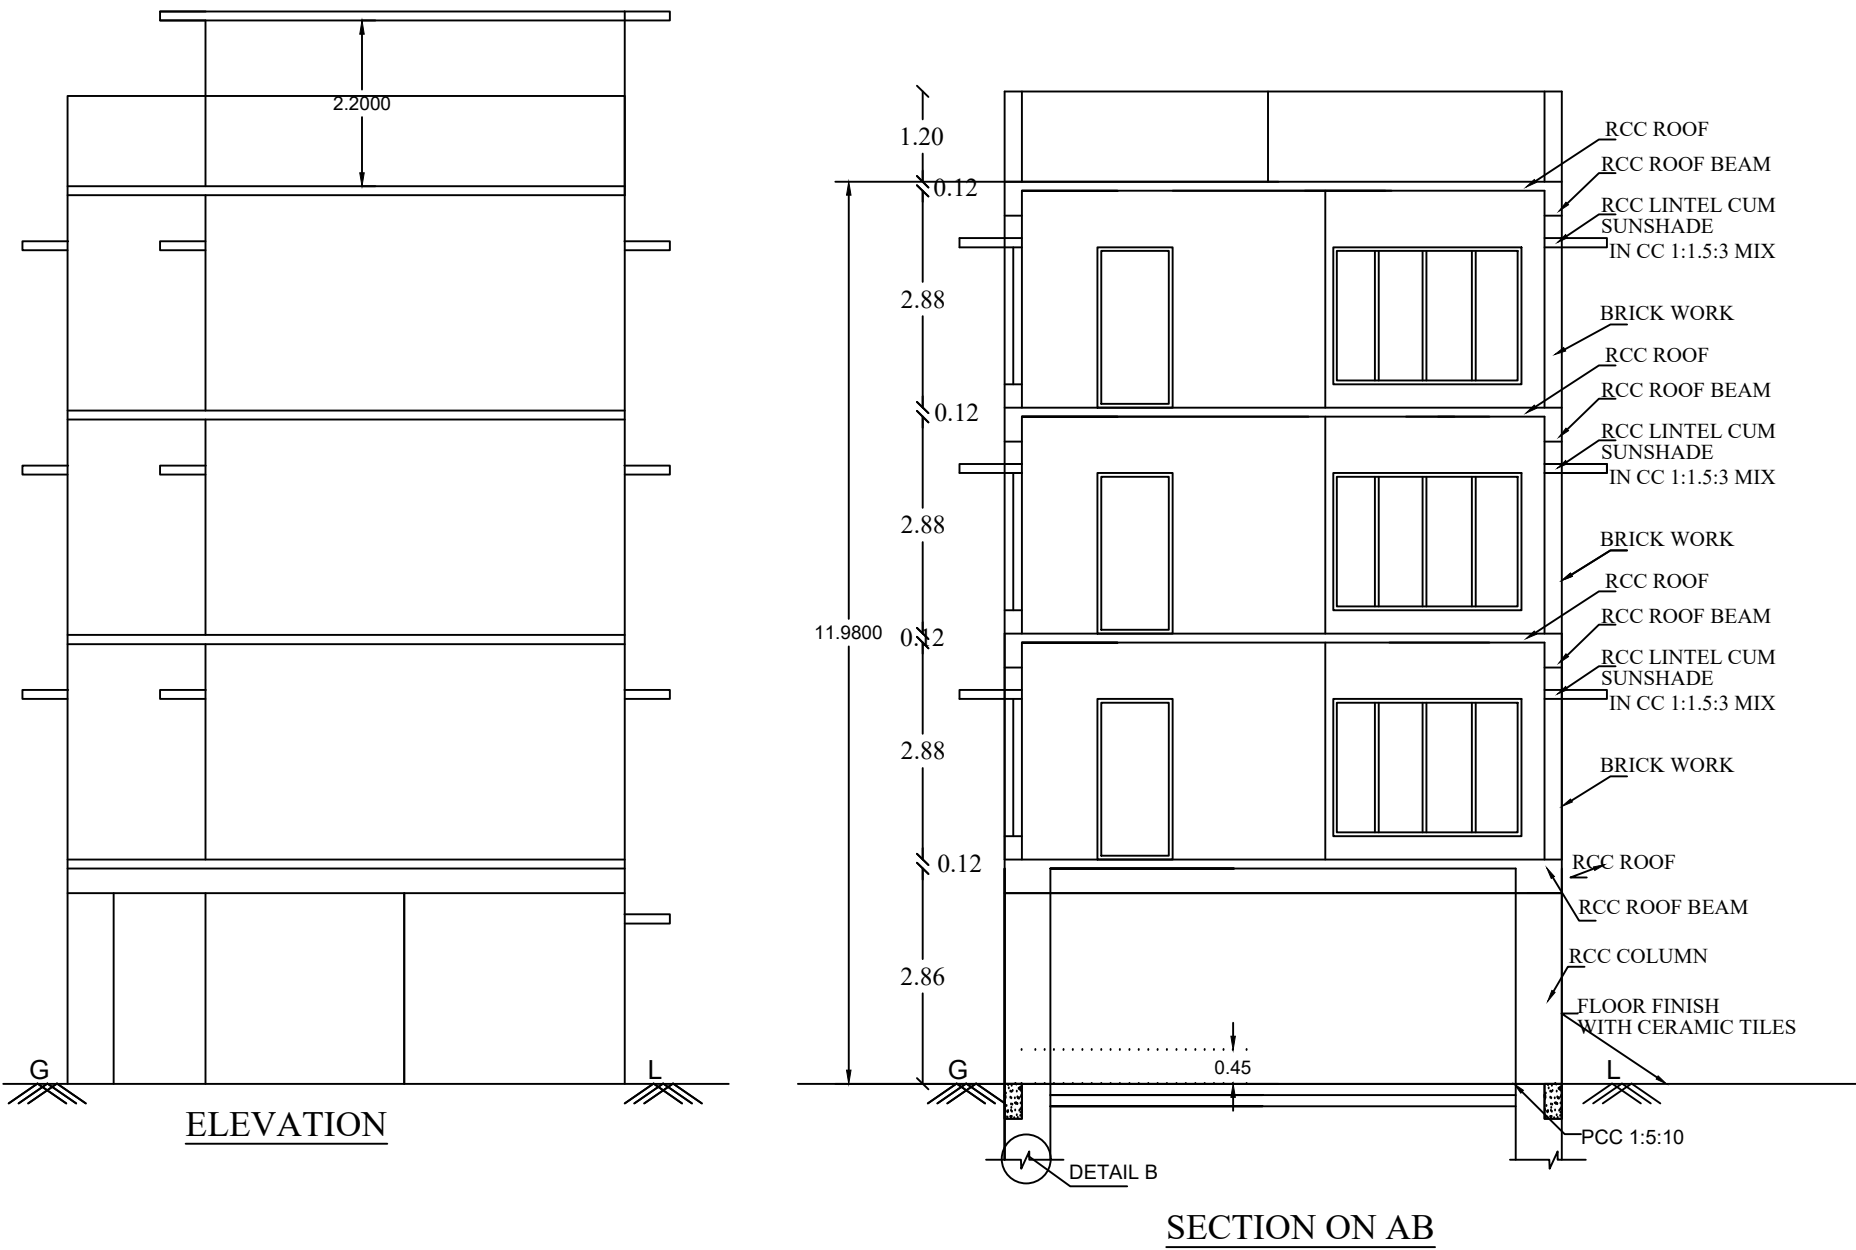


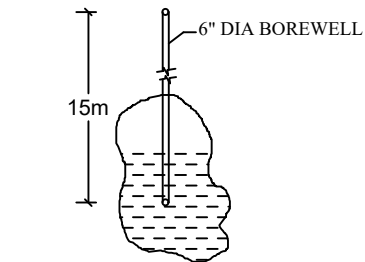


- NOTE**
- SULLAGE WASTE FROM TOILET WILL BE CONNECTED INTO ST.
 - BORE WELL WITH MOTAR WATER TANK AND CORPORATION WATER SUPPLY WILL BE PROVIDED.
 - RAIN WATER PERCOLATION PIT PROVIDED @ 1/30 Sqm OF PLINTH AREA @ 6 M C/C
 - RAIN WATER PERCOLATION BED 1.0m WIDE WILL BE PROVIDED AROUND THE BUILDING AS PER GO (MS) NO: 138 DATED 11-10-02.
 - RAIN WATER TAKEN TO THE BORE WELL THROUGH 150MM DIA PIPES.
 - RAIN WATER COLLECTED FROM OPEN TERRACE SHALL BE COLLECTED THROUGH PIPES AND LED INTO A FILTER PIT (SIZE 60 X 60 X 60 CM) WITH APPROPRIATE FILTER MATERIAL AND THEN LED INTO COLLECTION TANK.
 - SOLAR WATER HEATER LINE ARRANGEMENTS WILL BE PROVIDED.

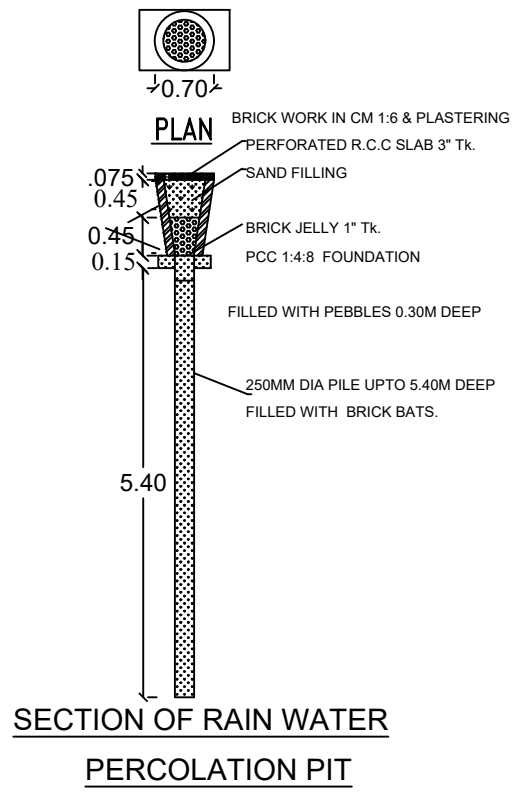


BORE WELL DETAIL

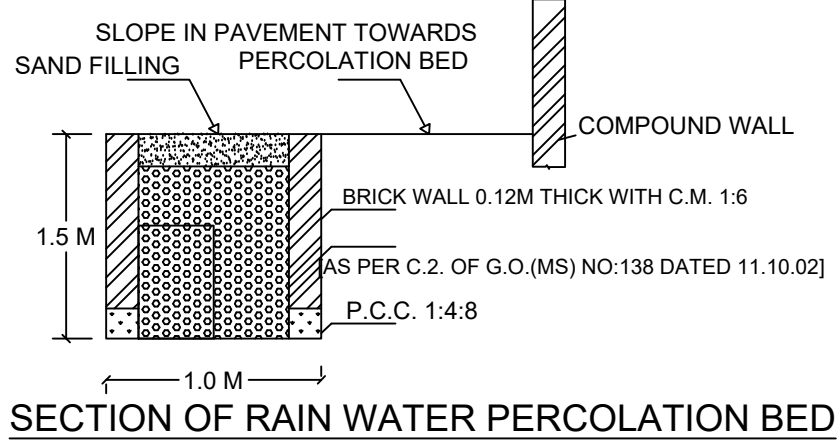

SECTION OF RAIN WATER PERCOLATION PIT

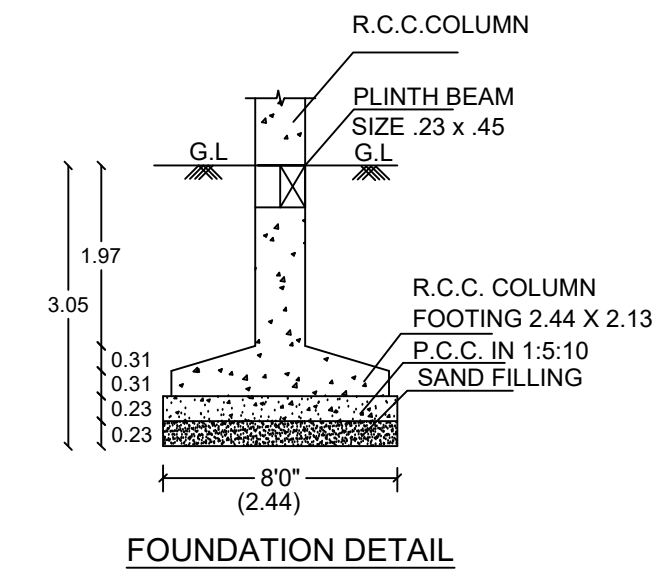


FOUNDATION DETAIL

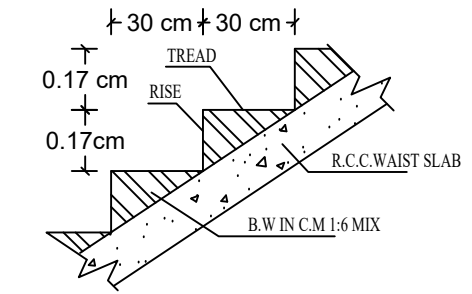


SCHEDULE OF JOINERIES:


REFERENCE	METER
RS - ROLLING SHUTTER	2.00 x 2.13
D1 - FLUSH DOOR	1.00 x 2.13
D3 - FLUSH DOOR	0.91 x 2.13
W - GLAZED WINDOW	2.50 x 1.82
W1 - GLAZED WINDOW	1.82 x 1.52
V - VENTILATOR	1.00 x 0.91

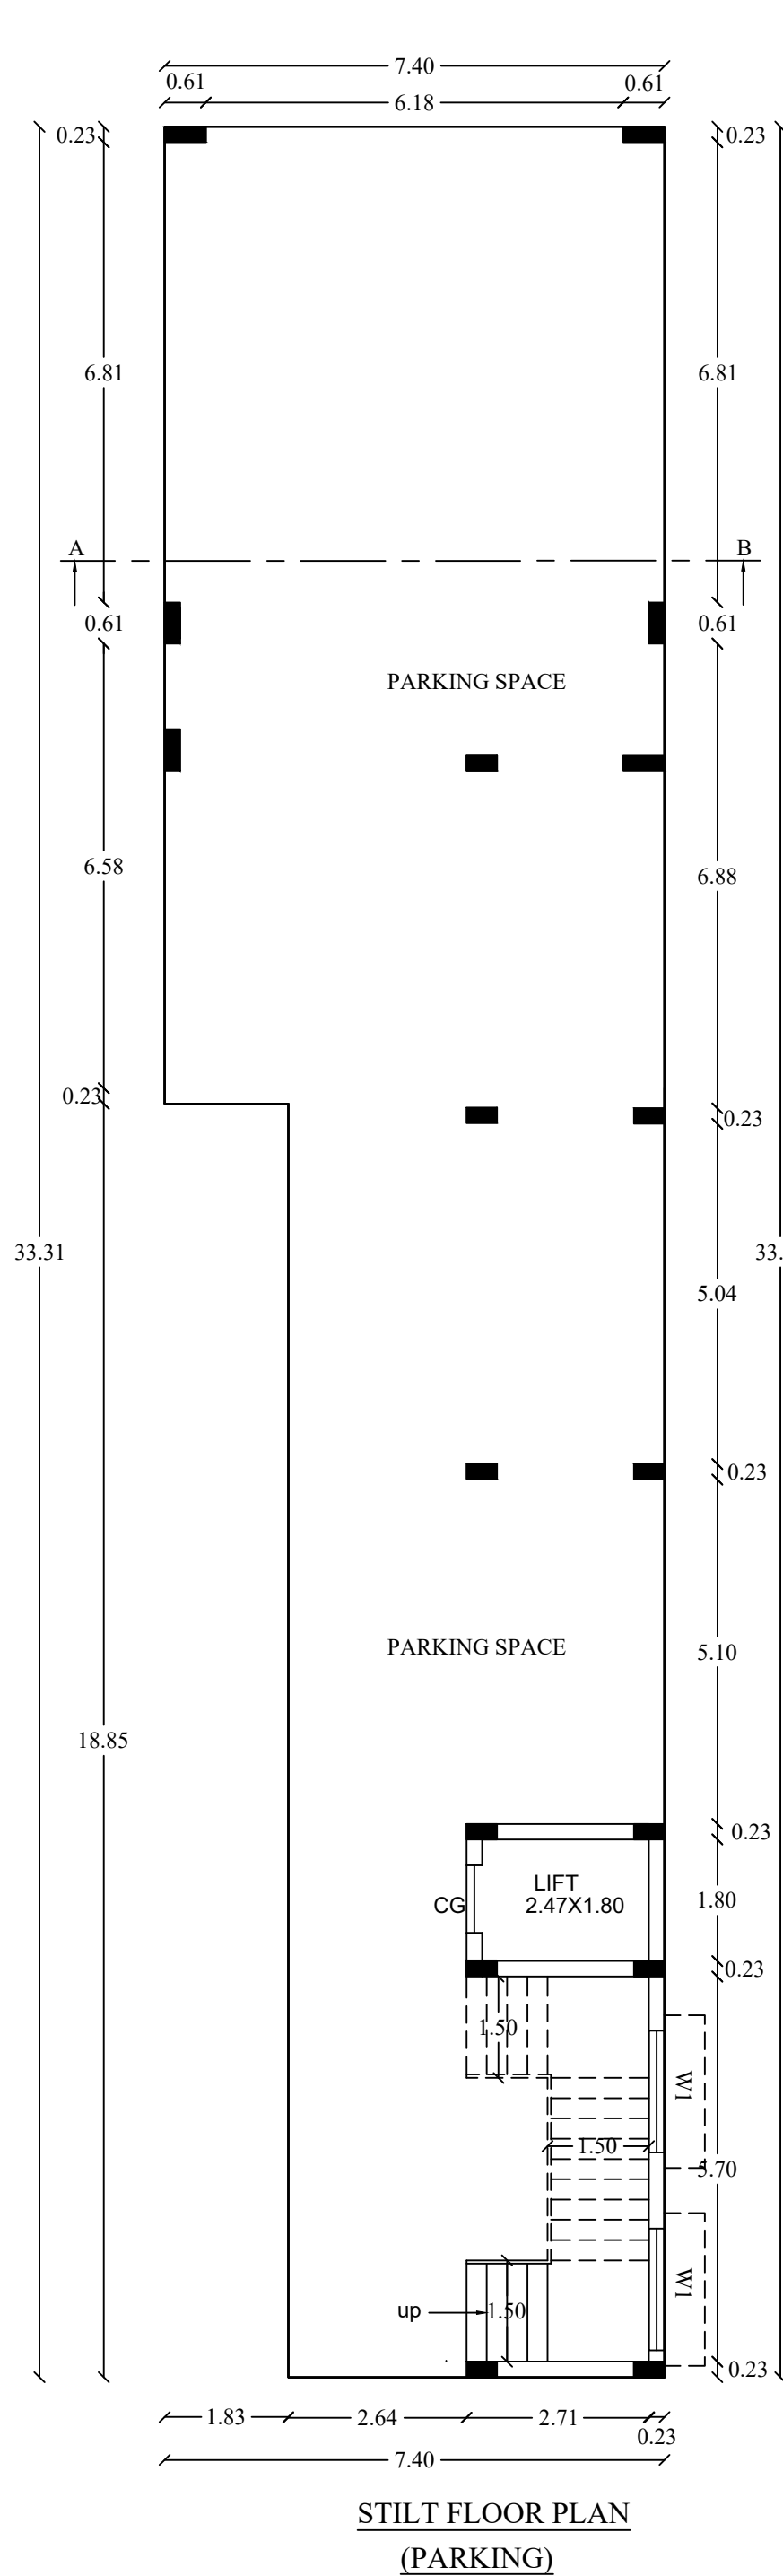


STILT FLOOR PLAN (PARKING)

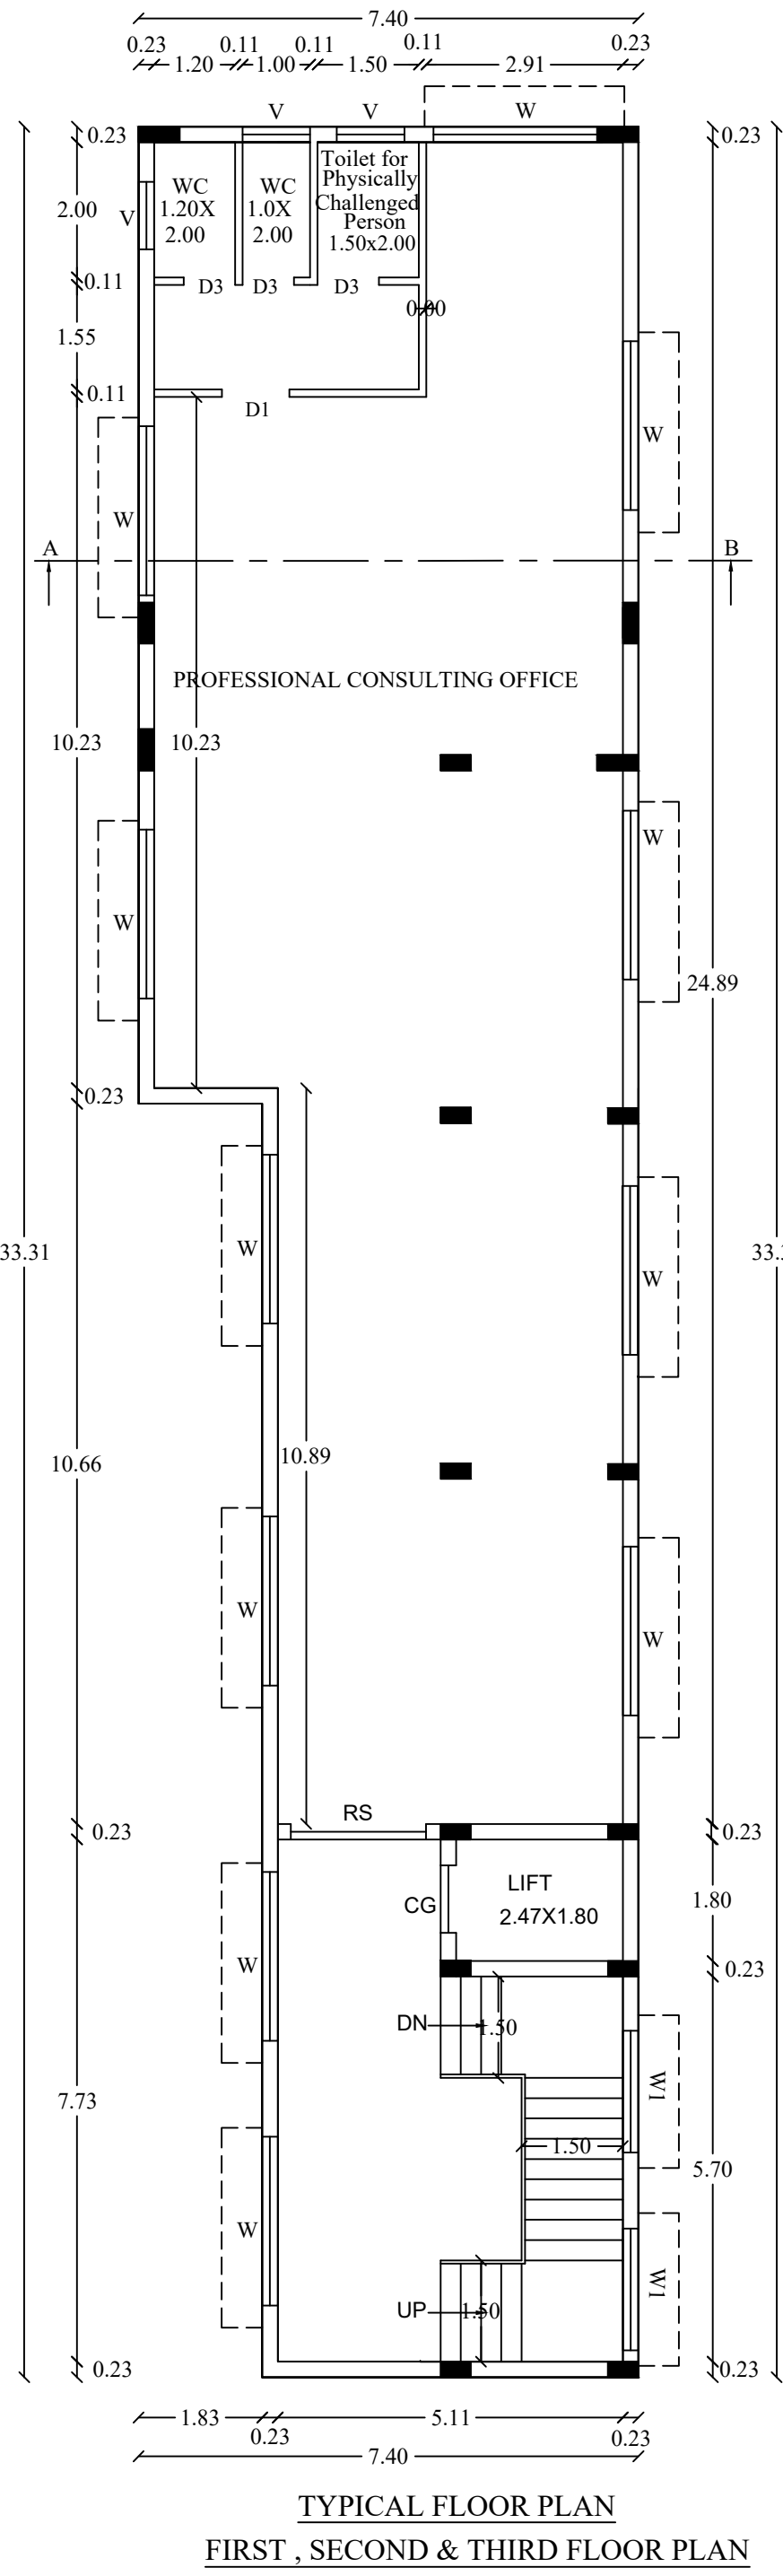

TYPICAL FLOOR PLAN FIRST, SECOND & THIRD FLOOR PLAN

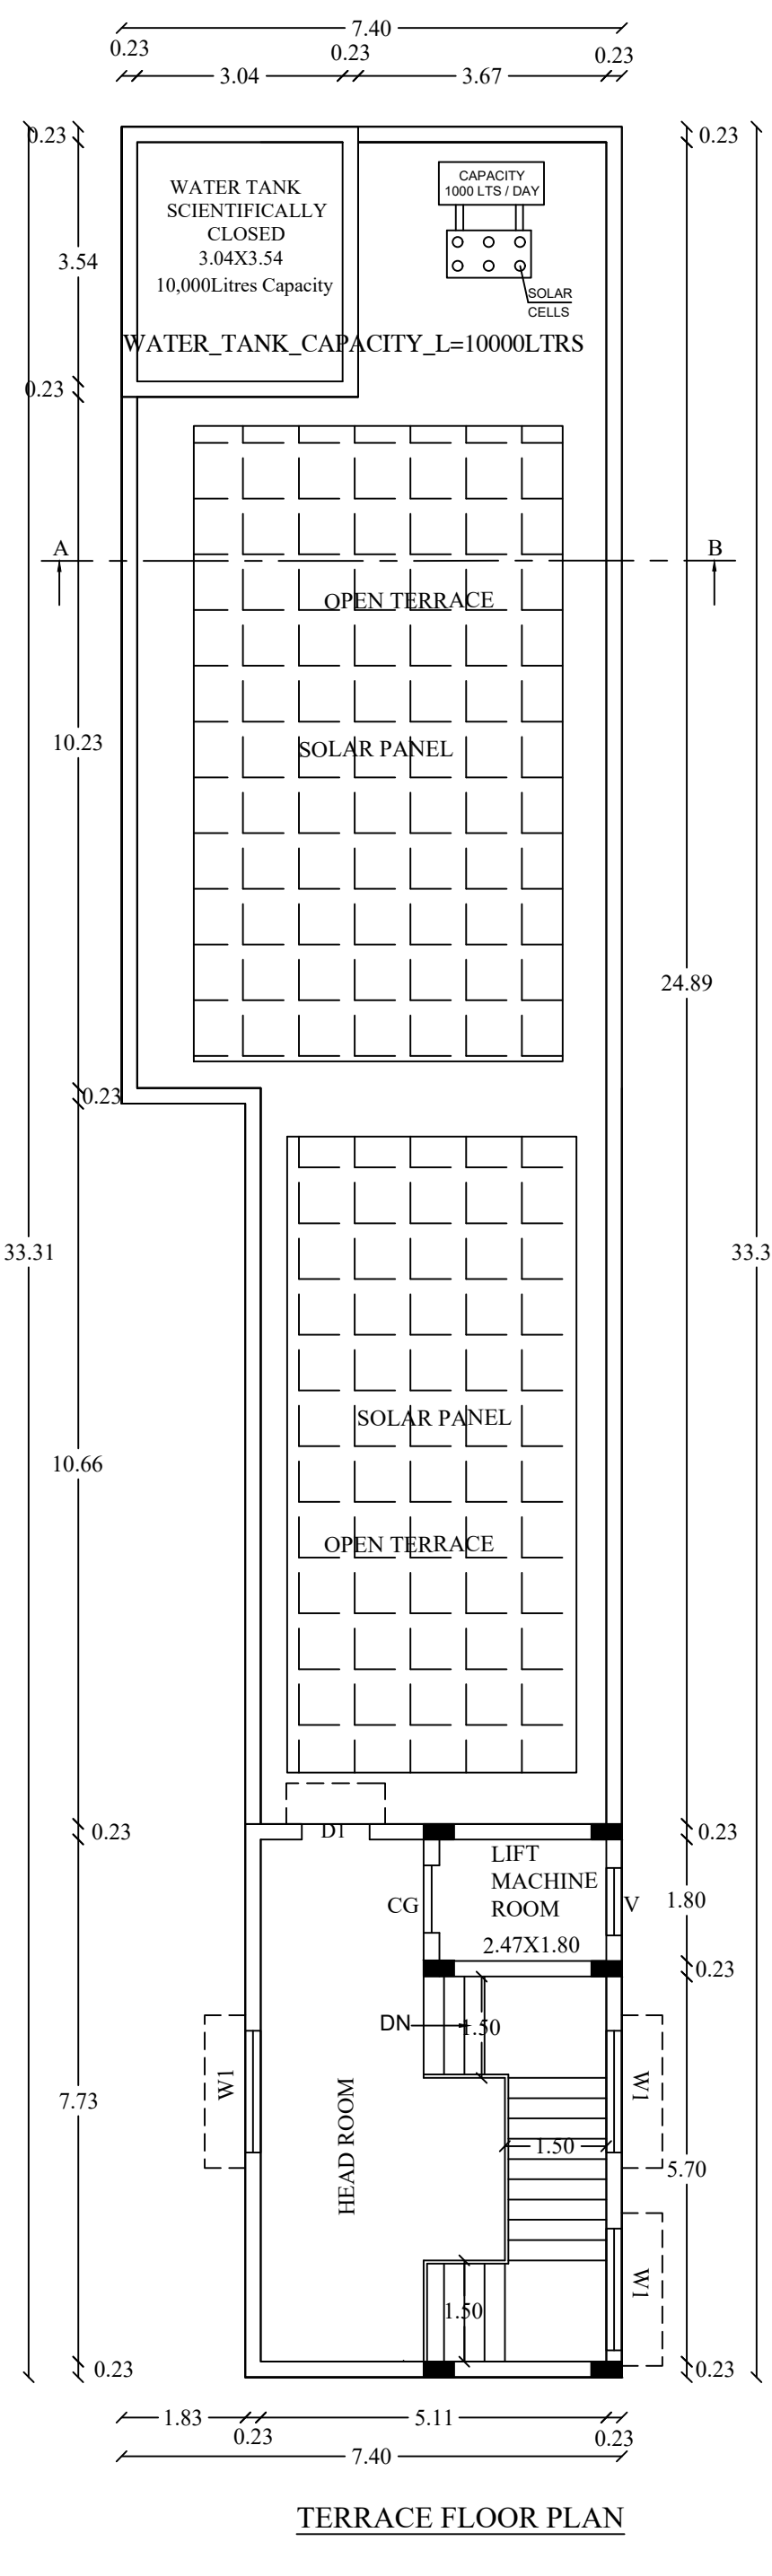

TERRACE FLOOR PLAN

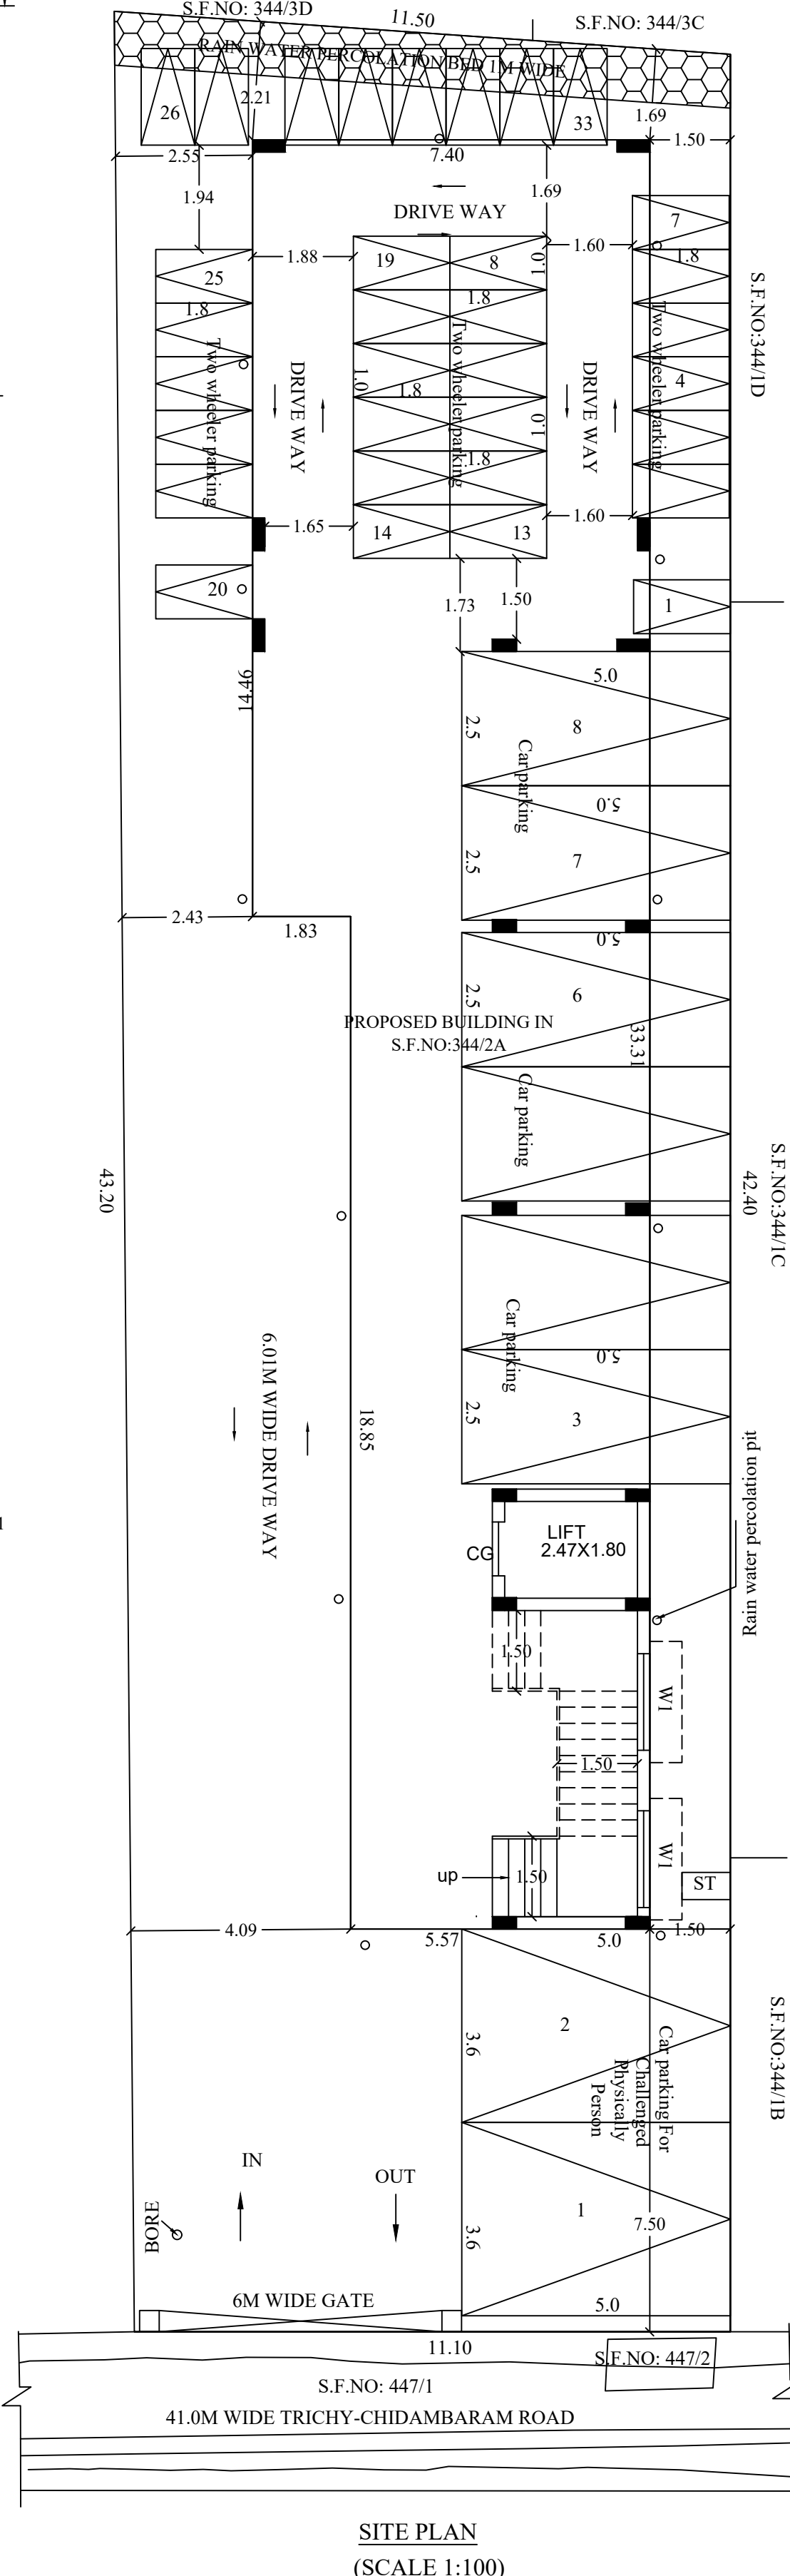

SITE PLAN (SCALE 1:100)

AREA DETAILS

DESCRIPTION	SQ.M
PLOT AREA AS PER DOCUMENT	504.00
PLOT AREA AS PER PATTA	415.00
SUPER IMPOSED PLOT AREA	475.41
MINIMUM AREA SHOULD BE TAKEN INTO ACCOUNT	

PROPOSED BUILTUP AREA

SL NO.	DESCRIPTION	F.S.I AREA (SQM)	NON F.S.I AREA (SQM)	TOTAL AREA (SQM)
1)	STILT FLOOR AREA (Parking)	-	212.00	212.00
2)	FIRST FLOOR AREA	212.00	-	212.00
3)	SECOND FLOOR AREA	212.00	-	212.00
4)	THIRD FLOOR AREA	212.00	-	212.00
5)	HEAD ROOM AREA	-	45.62	45.62
6)	TOTAL	636.00	257.62	893.62
7)	VACANT AREA	-	-	203.00

PLOT COVERAGE = 212.00/ 415.00 X 100 = 51.08 %
F.S.I = 636.00/ 415.00 = 1.53

SL NO.	PARKING	REQUIRED	PROVIDED
1	TWO WHEELER PARKING SPACE	22 NOS	23 NOS
2	CAR PARKING SPACE	6 NOS	6 NOS

BOUNDARY SHOWN IN	-	BORE WELL	-
PROPOSED AREA	-	ROAD	-
RAIN WATER PERCOLATION BED	-	PERCOLATION PIT	-
BATH & WASTE WATER LINE	-	FIRE EXTINGUISHER	-

ALL DIMENSIONS ARE IN METER.
SCALE - 1:100.

APPLICANT

ENGINEER

Er. T. ARIVANANTHAM M.Tech (Struct)
M.S.S.E., M.C.E., M.I.C.E., F.I.T.Y., C.E.O., A.M.I.E.
CHARTERED ENGINEER-AM-1853255
APPROVED VALUER (I.V India) MF-1892
D.T.C.P REGISTERED ENGINEER
REG. No: RE / PBLR / APR2019 / 081
121-C, POUND STREET, ARIYALUR - 621 704.
Mob : 96081 23260, 98423 68483