




NAME OF APPLICANT :- Mr.S.VIJAYAN , S/O. Mr.SARGUNAM.

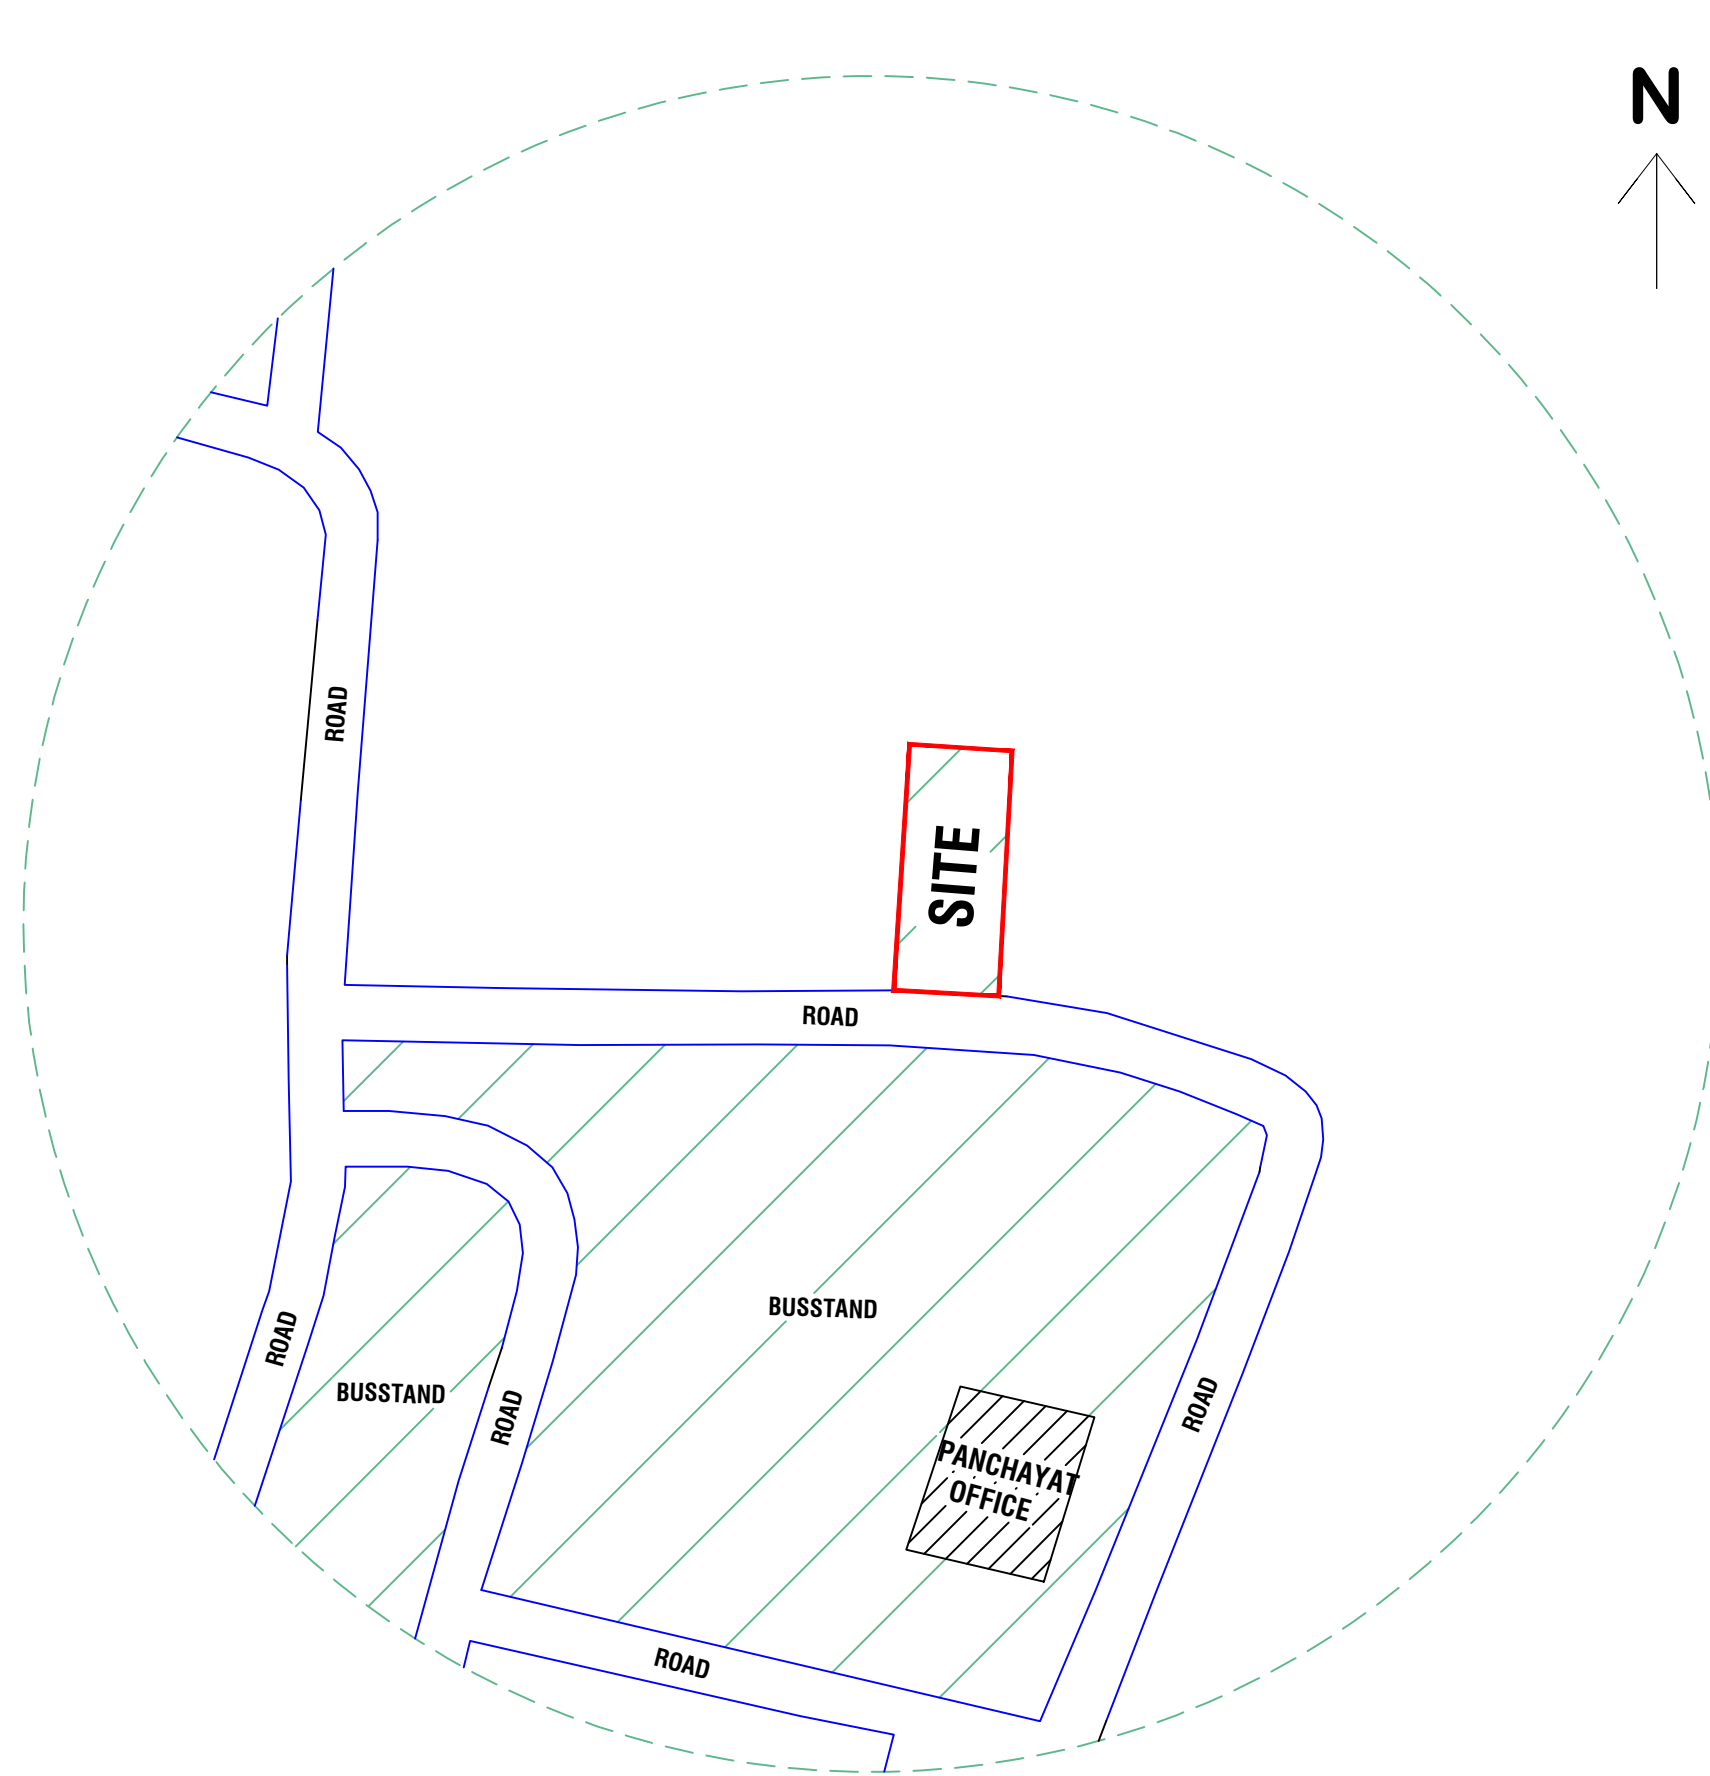


KEY PLAN (N.T.S)

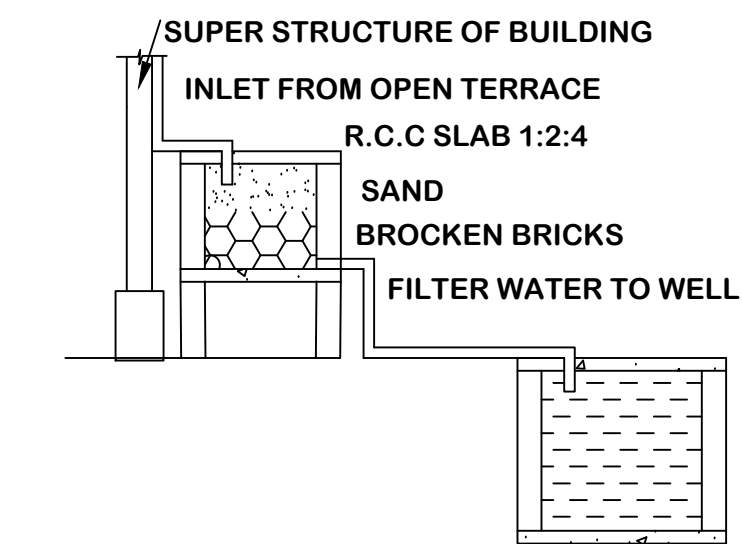

RAINWATER HARVESTING

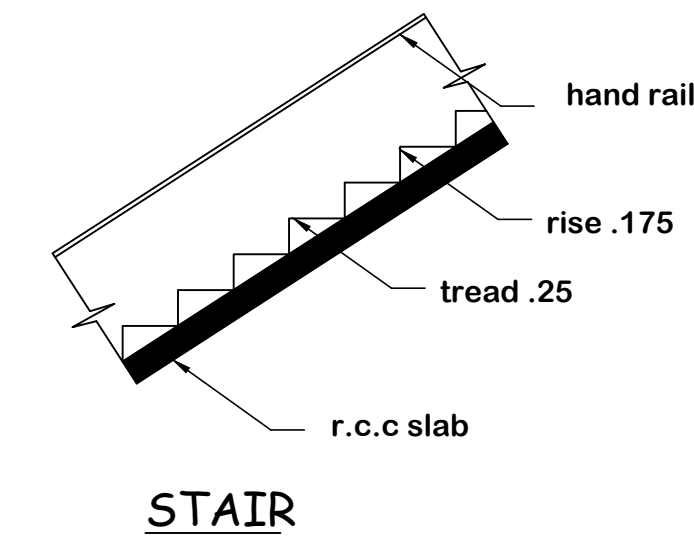


STAIR

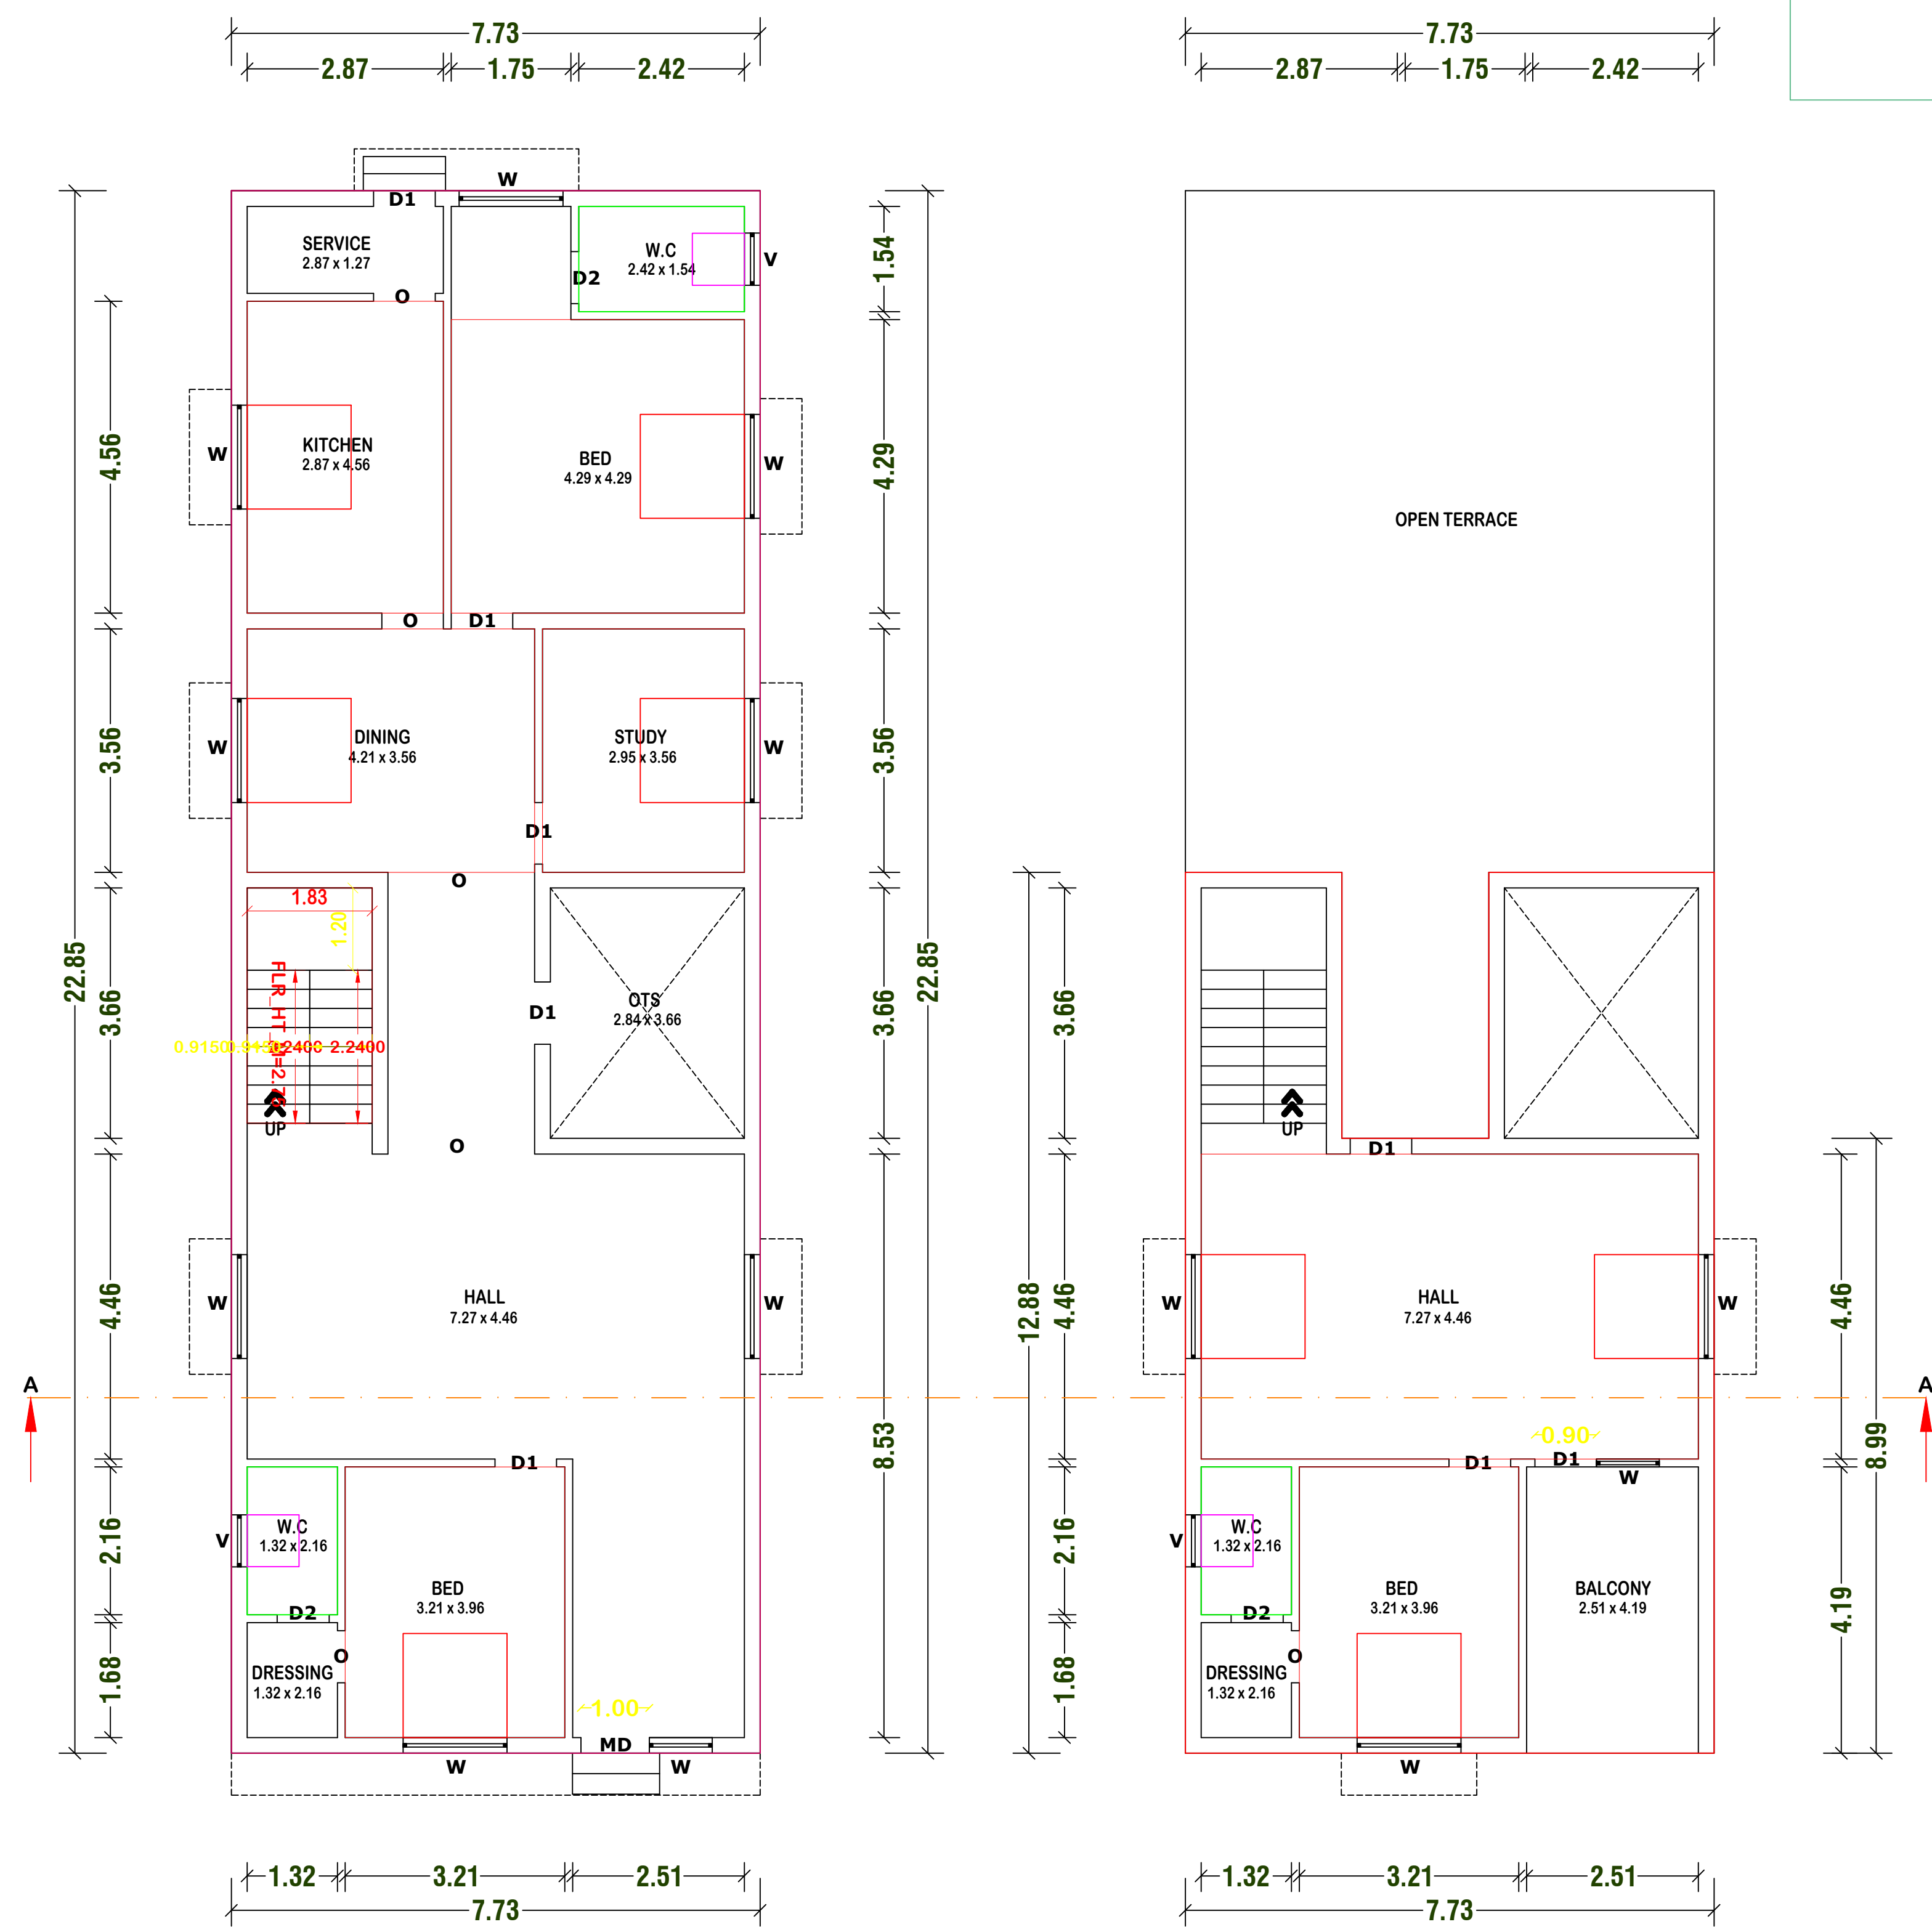


GROUND FLOOR PLAN


FIRST FLOOR PLAN

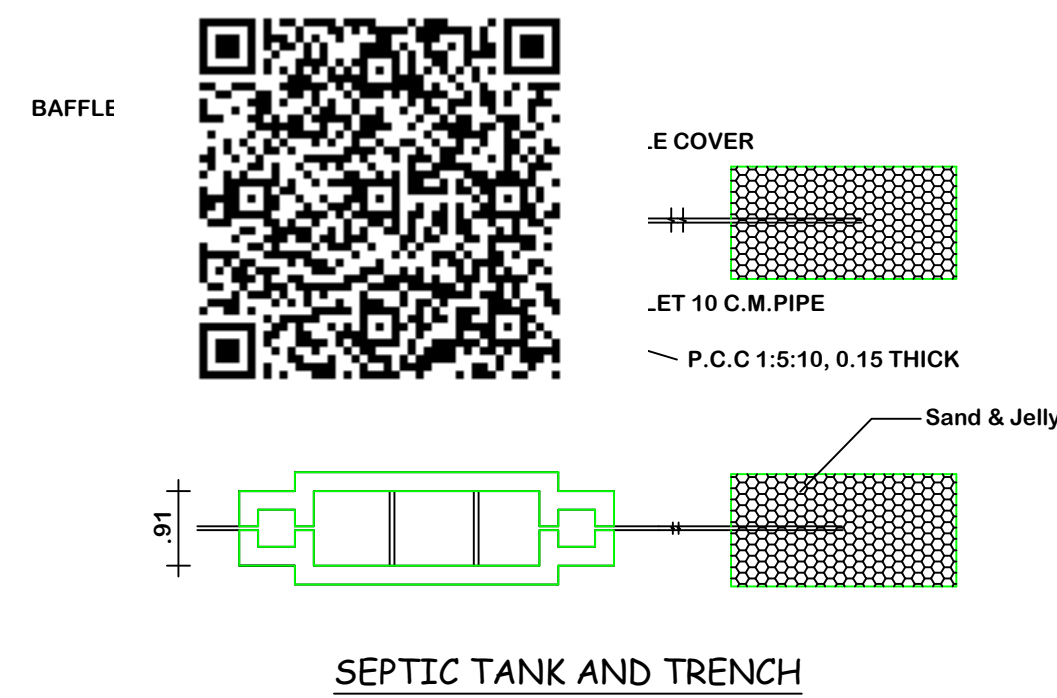

SEPTIC TANK AND TRENCH

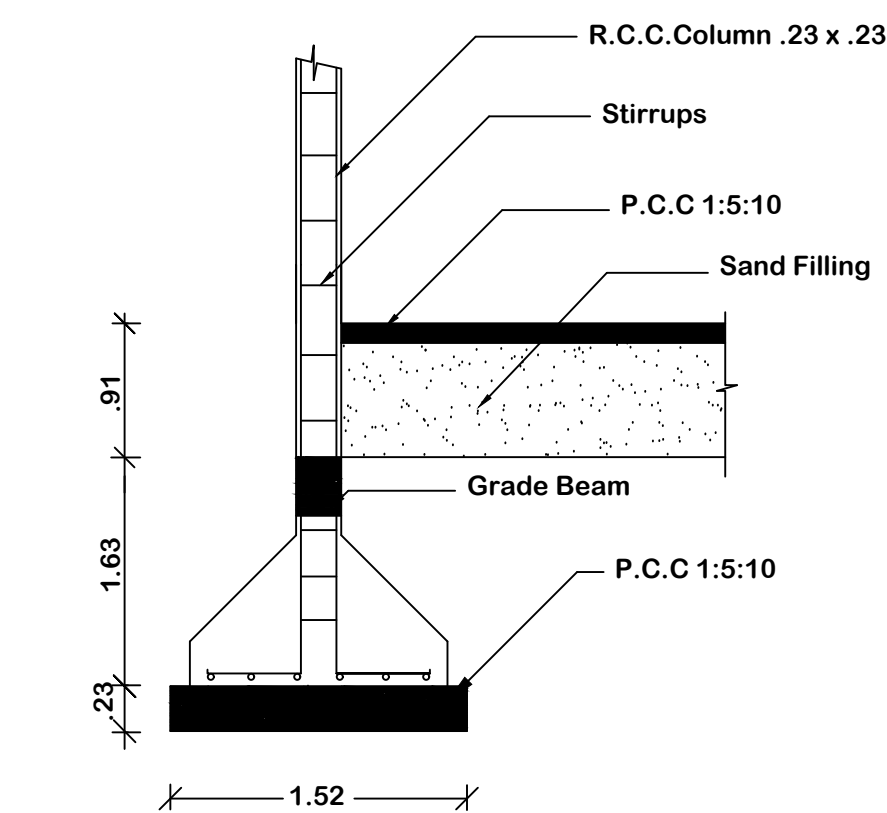


COLUMN DETAIL

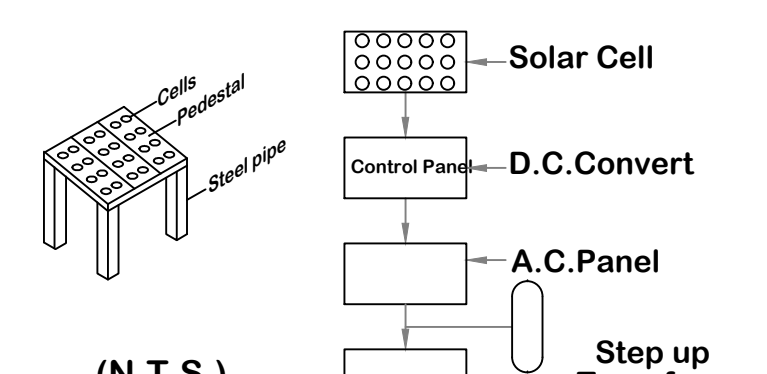

(N.T.S.)

SOLAR SYSTEM FLOW DIAGRAM

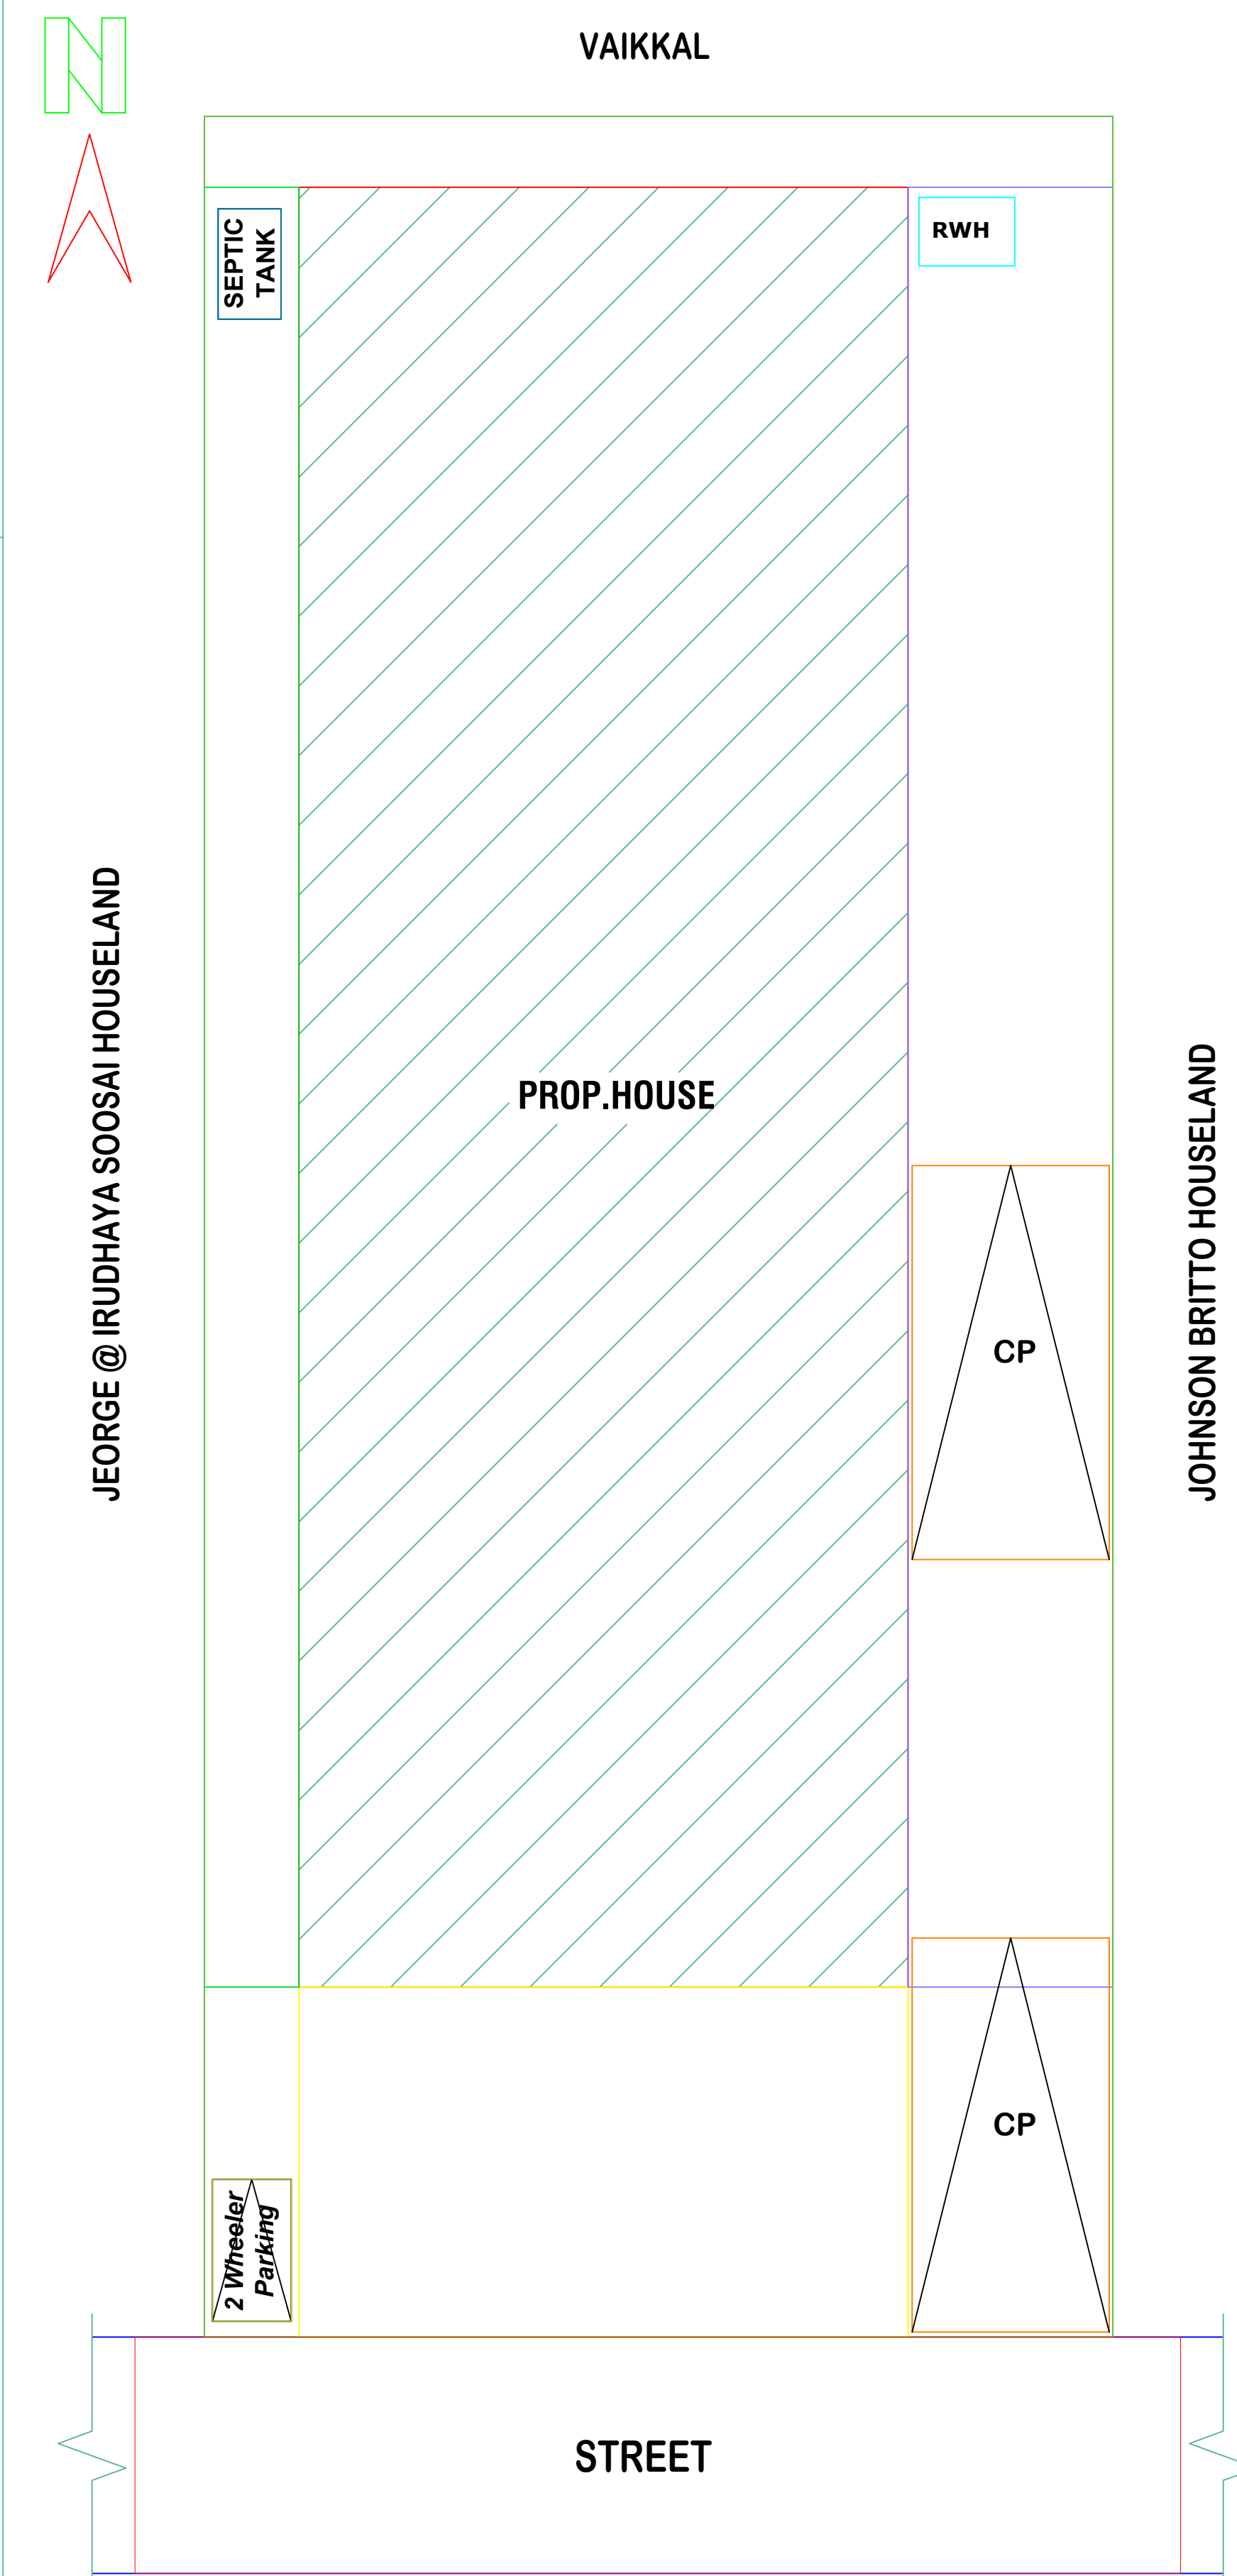

STREET

SITE PLAN
SCALE 1:100

AREA DETAILS			
REF.	DESCRIPTION	SQ.M	SQ.FT.
☐	SITE AREA	325.00	3498
☐	PRO. BUILDING AREA IN G.F	176.59	1901
☐	PRO. BUILDING AREA IN F.F	91.22	982
☐	TOTAL BUILDING AREA	267.81	2883
☐	OPEN AREA	148.41	1597
☐	F.S.I	0.82	

JOINERY DETAILS		
R.S	Rolling Shutter	2.00 x 2.10
MD	Door	1.00 x 2.10
D1	Door	0.91 x 2.10
D2	Door	0.75 x 2.10
W5	Window	1.50 x 1.50
W4	Window	1.20 x 1.50
V3	Ventilator	0.90 x 0.60

ALL DIMENSIONS ARE IN METRE, SCALE 1:100

Note:

Waste Water Used for Garden

Rain Water harvesting Details Provided

Solar System Water tank provided

Rain water harvesting tank to be provided

APPLICANT**OFFICE USE**

ENGINEER