



PLAN SHOWING THE PROPOSED CONSTRUCTION OF GROUND FLOOR AND FIRST FLOOR RCC ROOF RESIDENTIAL BUILDING IN S.NO: 70 / 8G , VELANKANNI , VELANKANNI TOWN PANCHAYAT , KILVELURI TALUK , NAGAPPATTINAM DISTRICT.


NAME OF APPLICANT :- Mr.S.KANNAIYAN , S/O. Mr.SHANMUGAM CHETTIYAR.

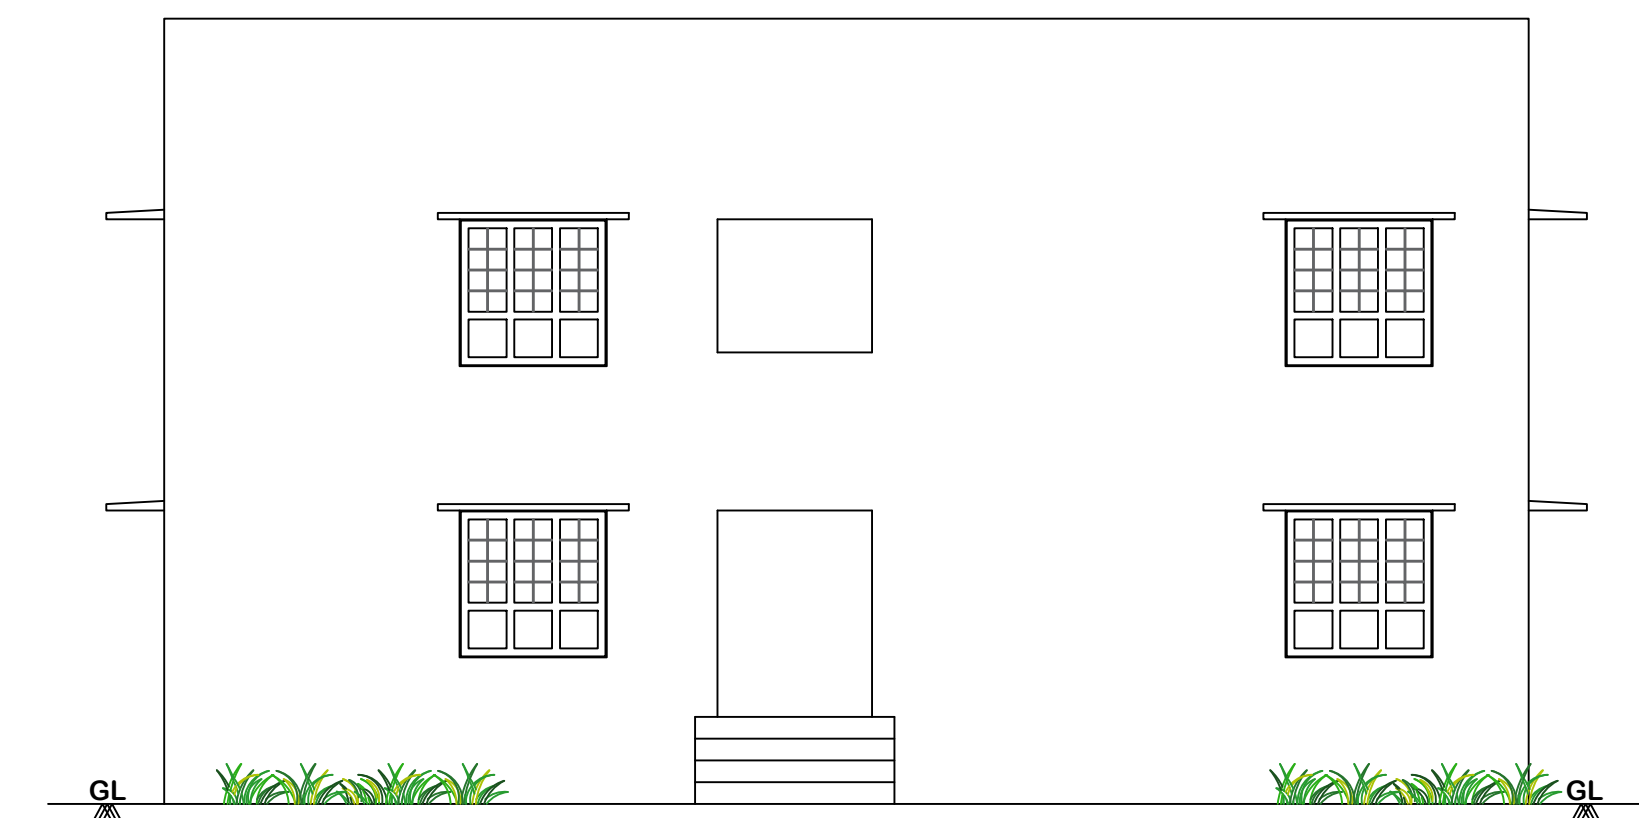


ELEVATION

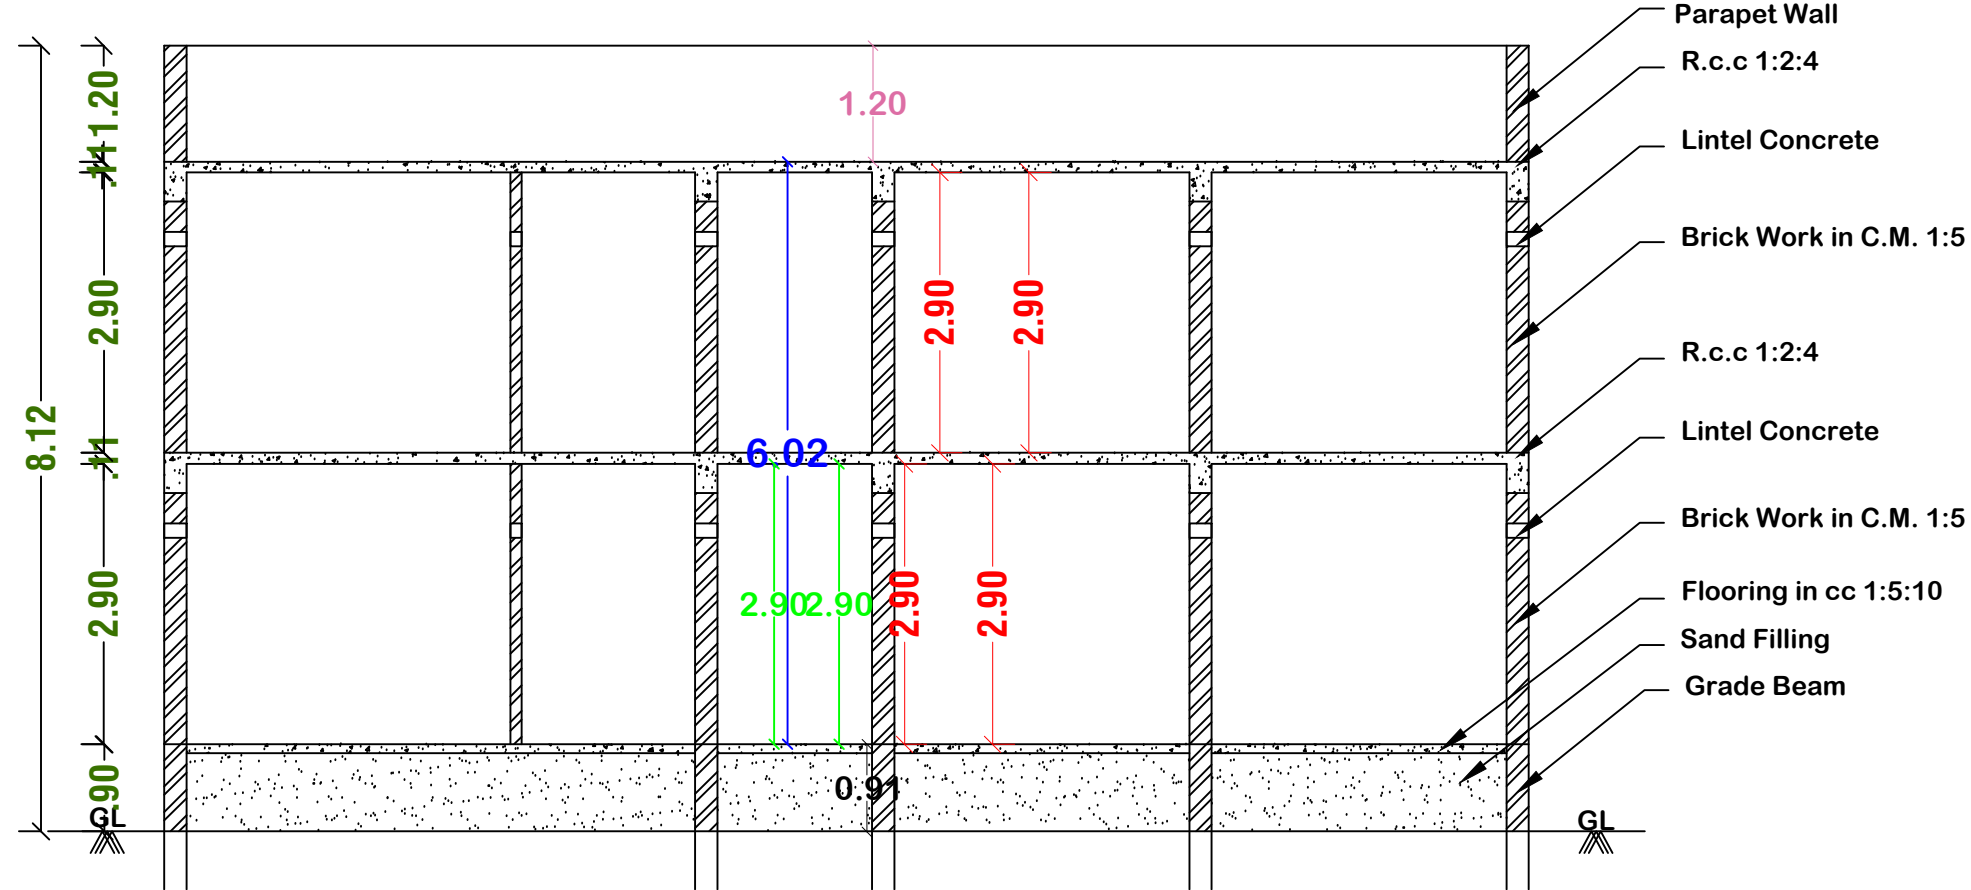


SECTION-AA

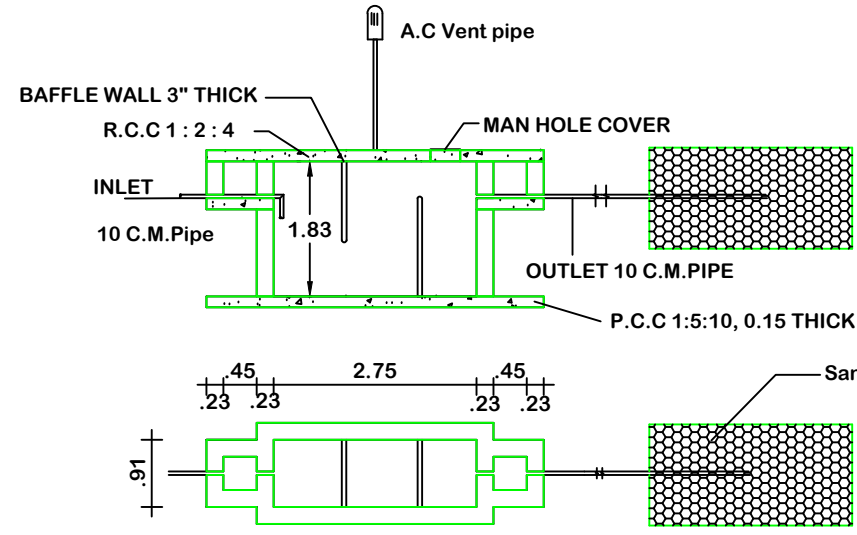


SEPTIC TANK AND TRENCH

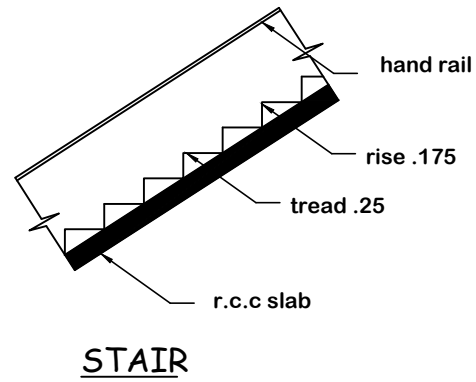

STAIR

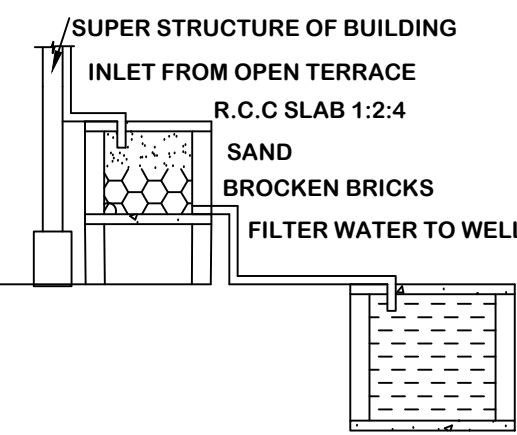

RAINWATER HARVESTING

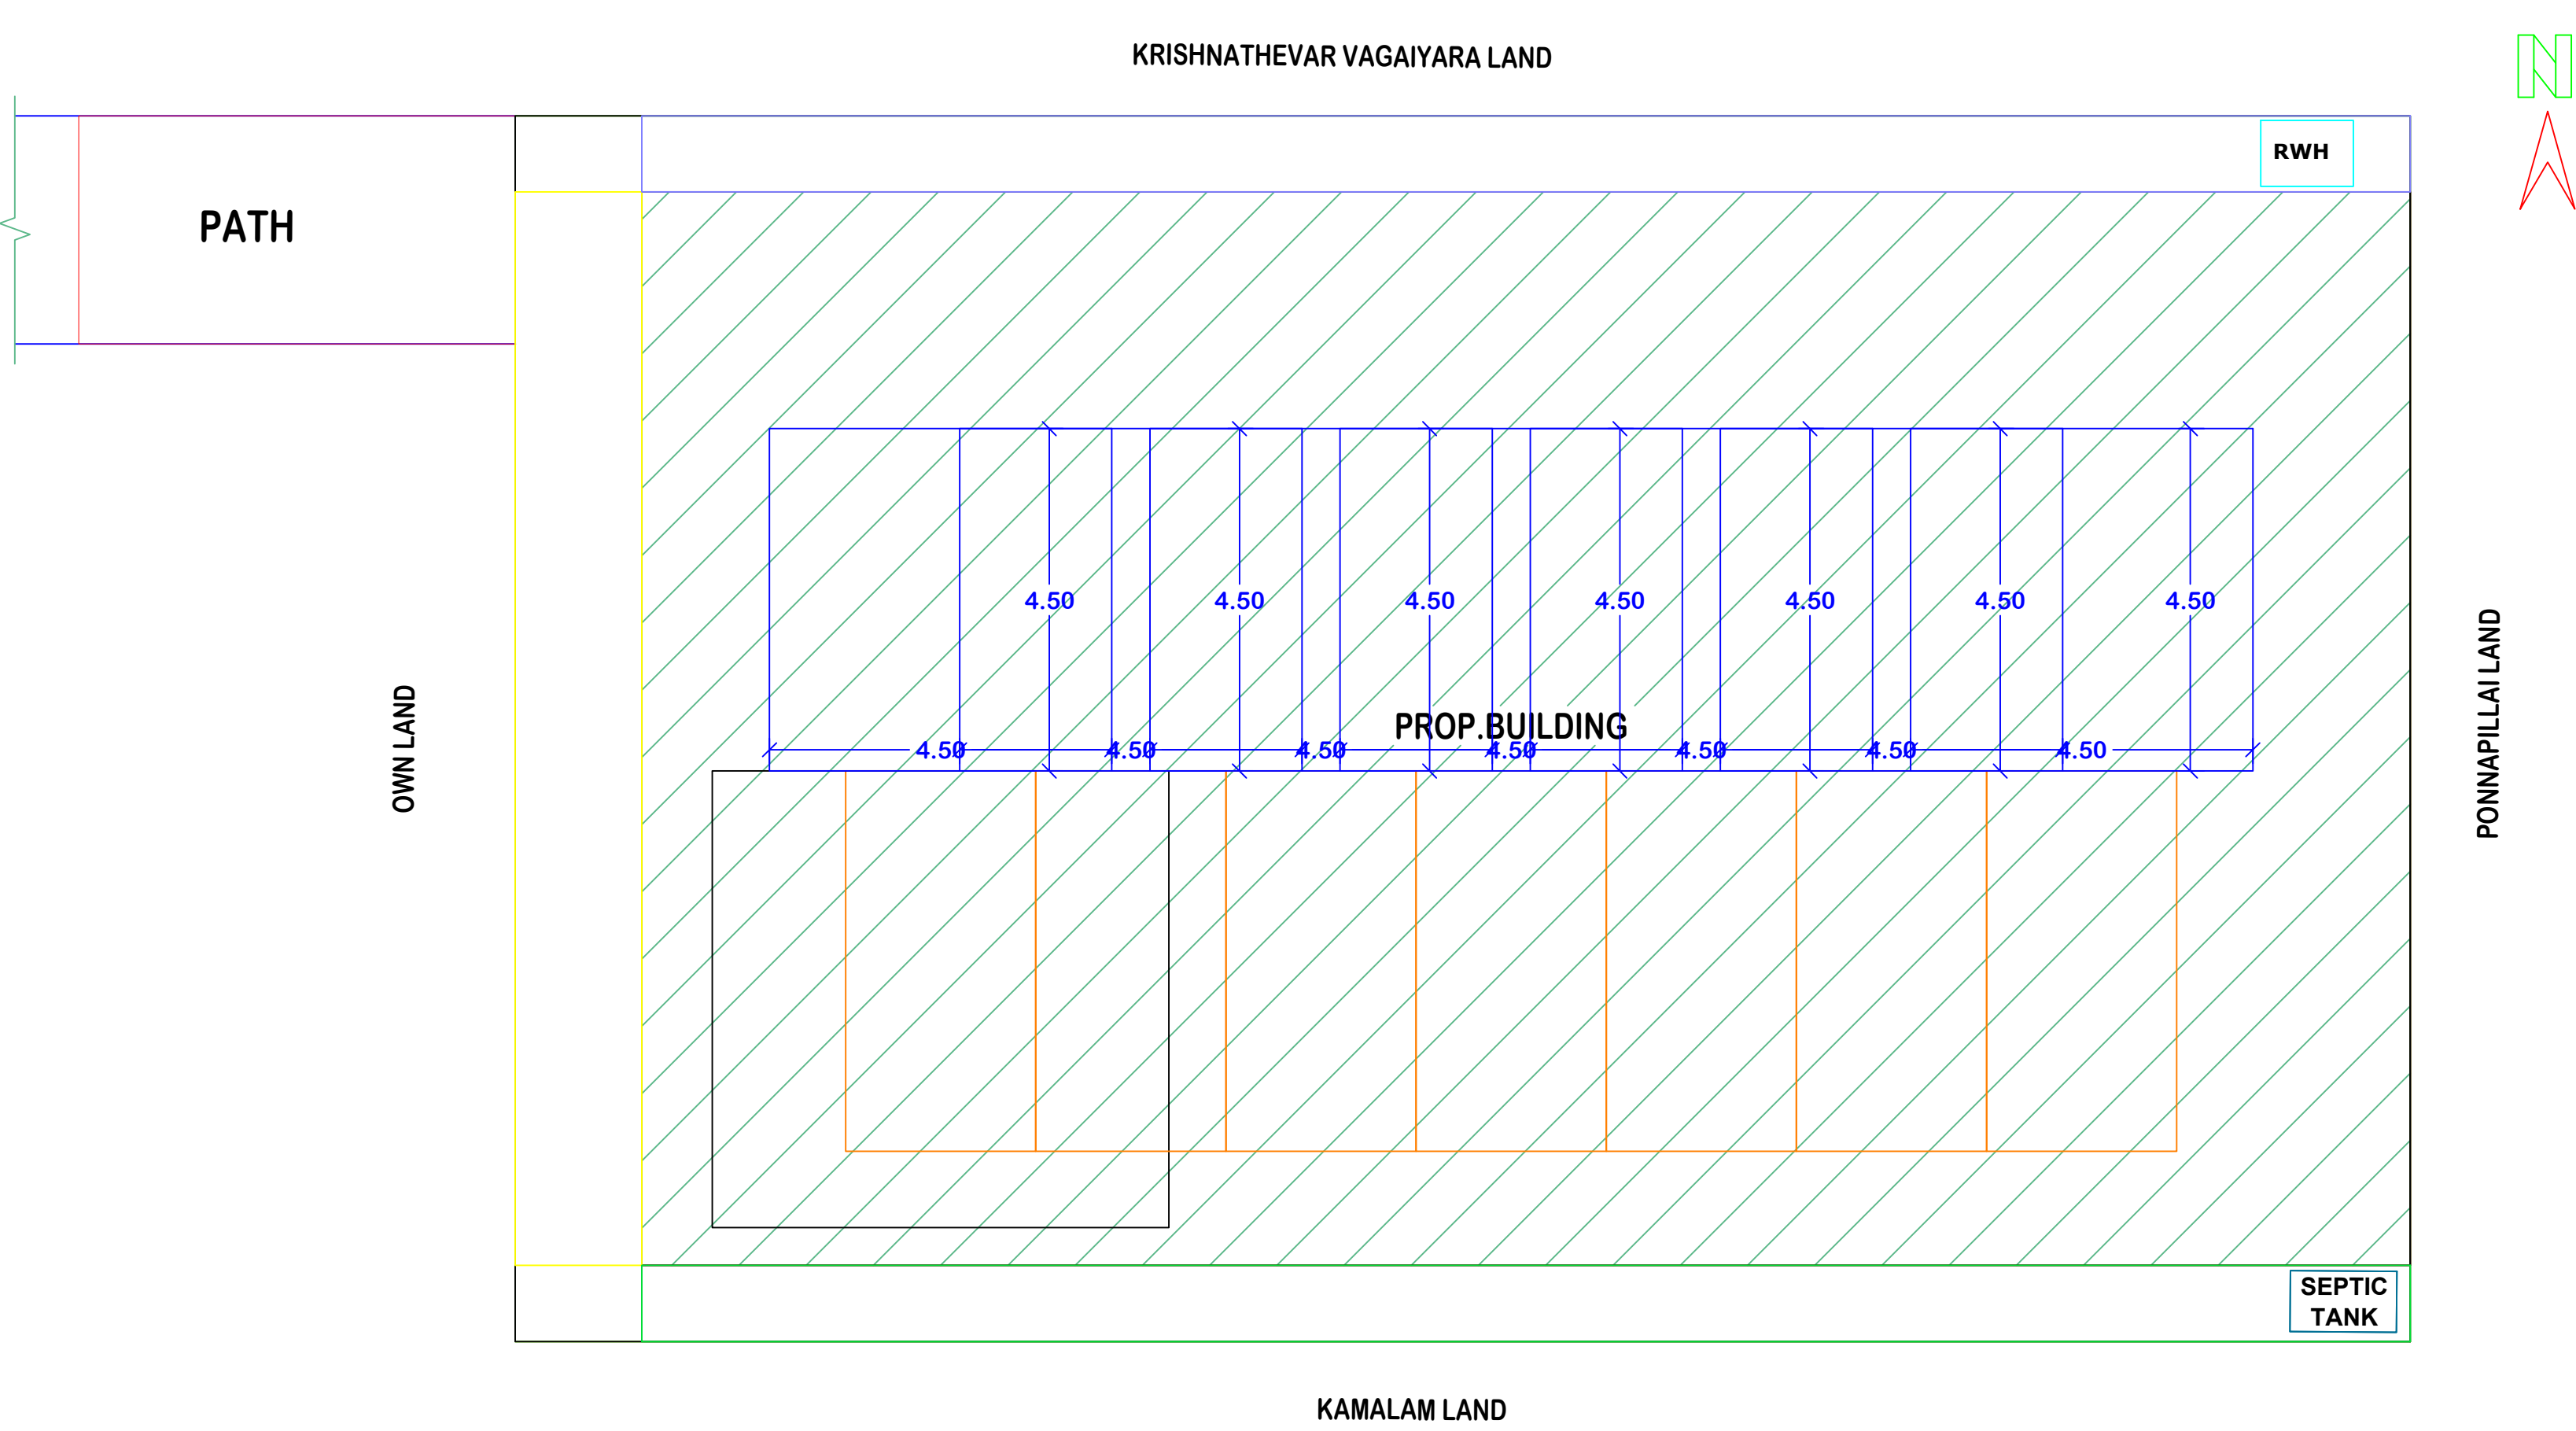

SITE PLAN
SCALE 1:100

AREA DETAILS

REF.	DESCRIPTION	SQ.M	SQ.FT
	SITE AREA	401.34	4320
	PROP. BUILDING AREA IN G.F	328.03	3531
	PROP. BUILDING AREA IN F.F	328.03	3531
	TOTAL BUILDING AREA	656.06	7062
	OPEN AREA	73.31	789
	FSI	1.63	


JOINERY DETAILS

R.S	Rolling Shutter	2.00 x 2.10
MD	Door	1.00 x 2.10
D1	Door	0.91 x 2.10
D2	Door	0.75 x 2.10
W5	Window	1.50 x 1.50
W4	Window	1.20 x 1.50
V3	Ventilator	0.90 x 0.60


ALL DIMENSIONS ARE IN METRE, SCALE 1:100

Note:

Waste Water Used for Garden
Rain Water harvesting Details Provided
Solar System Water tank provided
Rain water harvesting tank to be provided

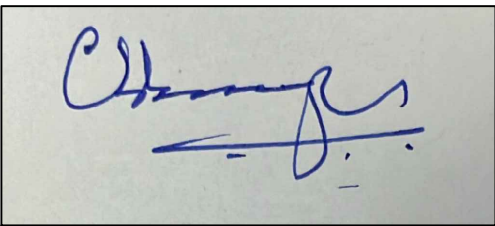


APPLICANT

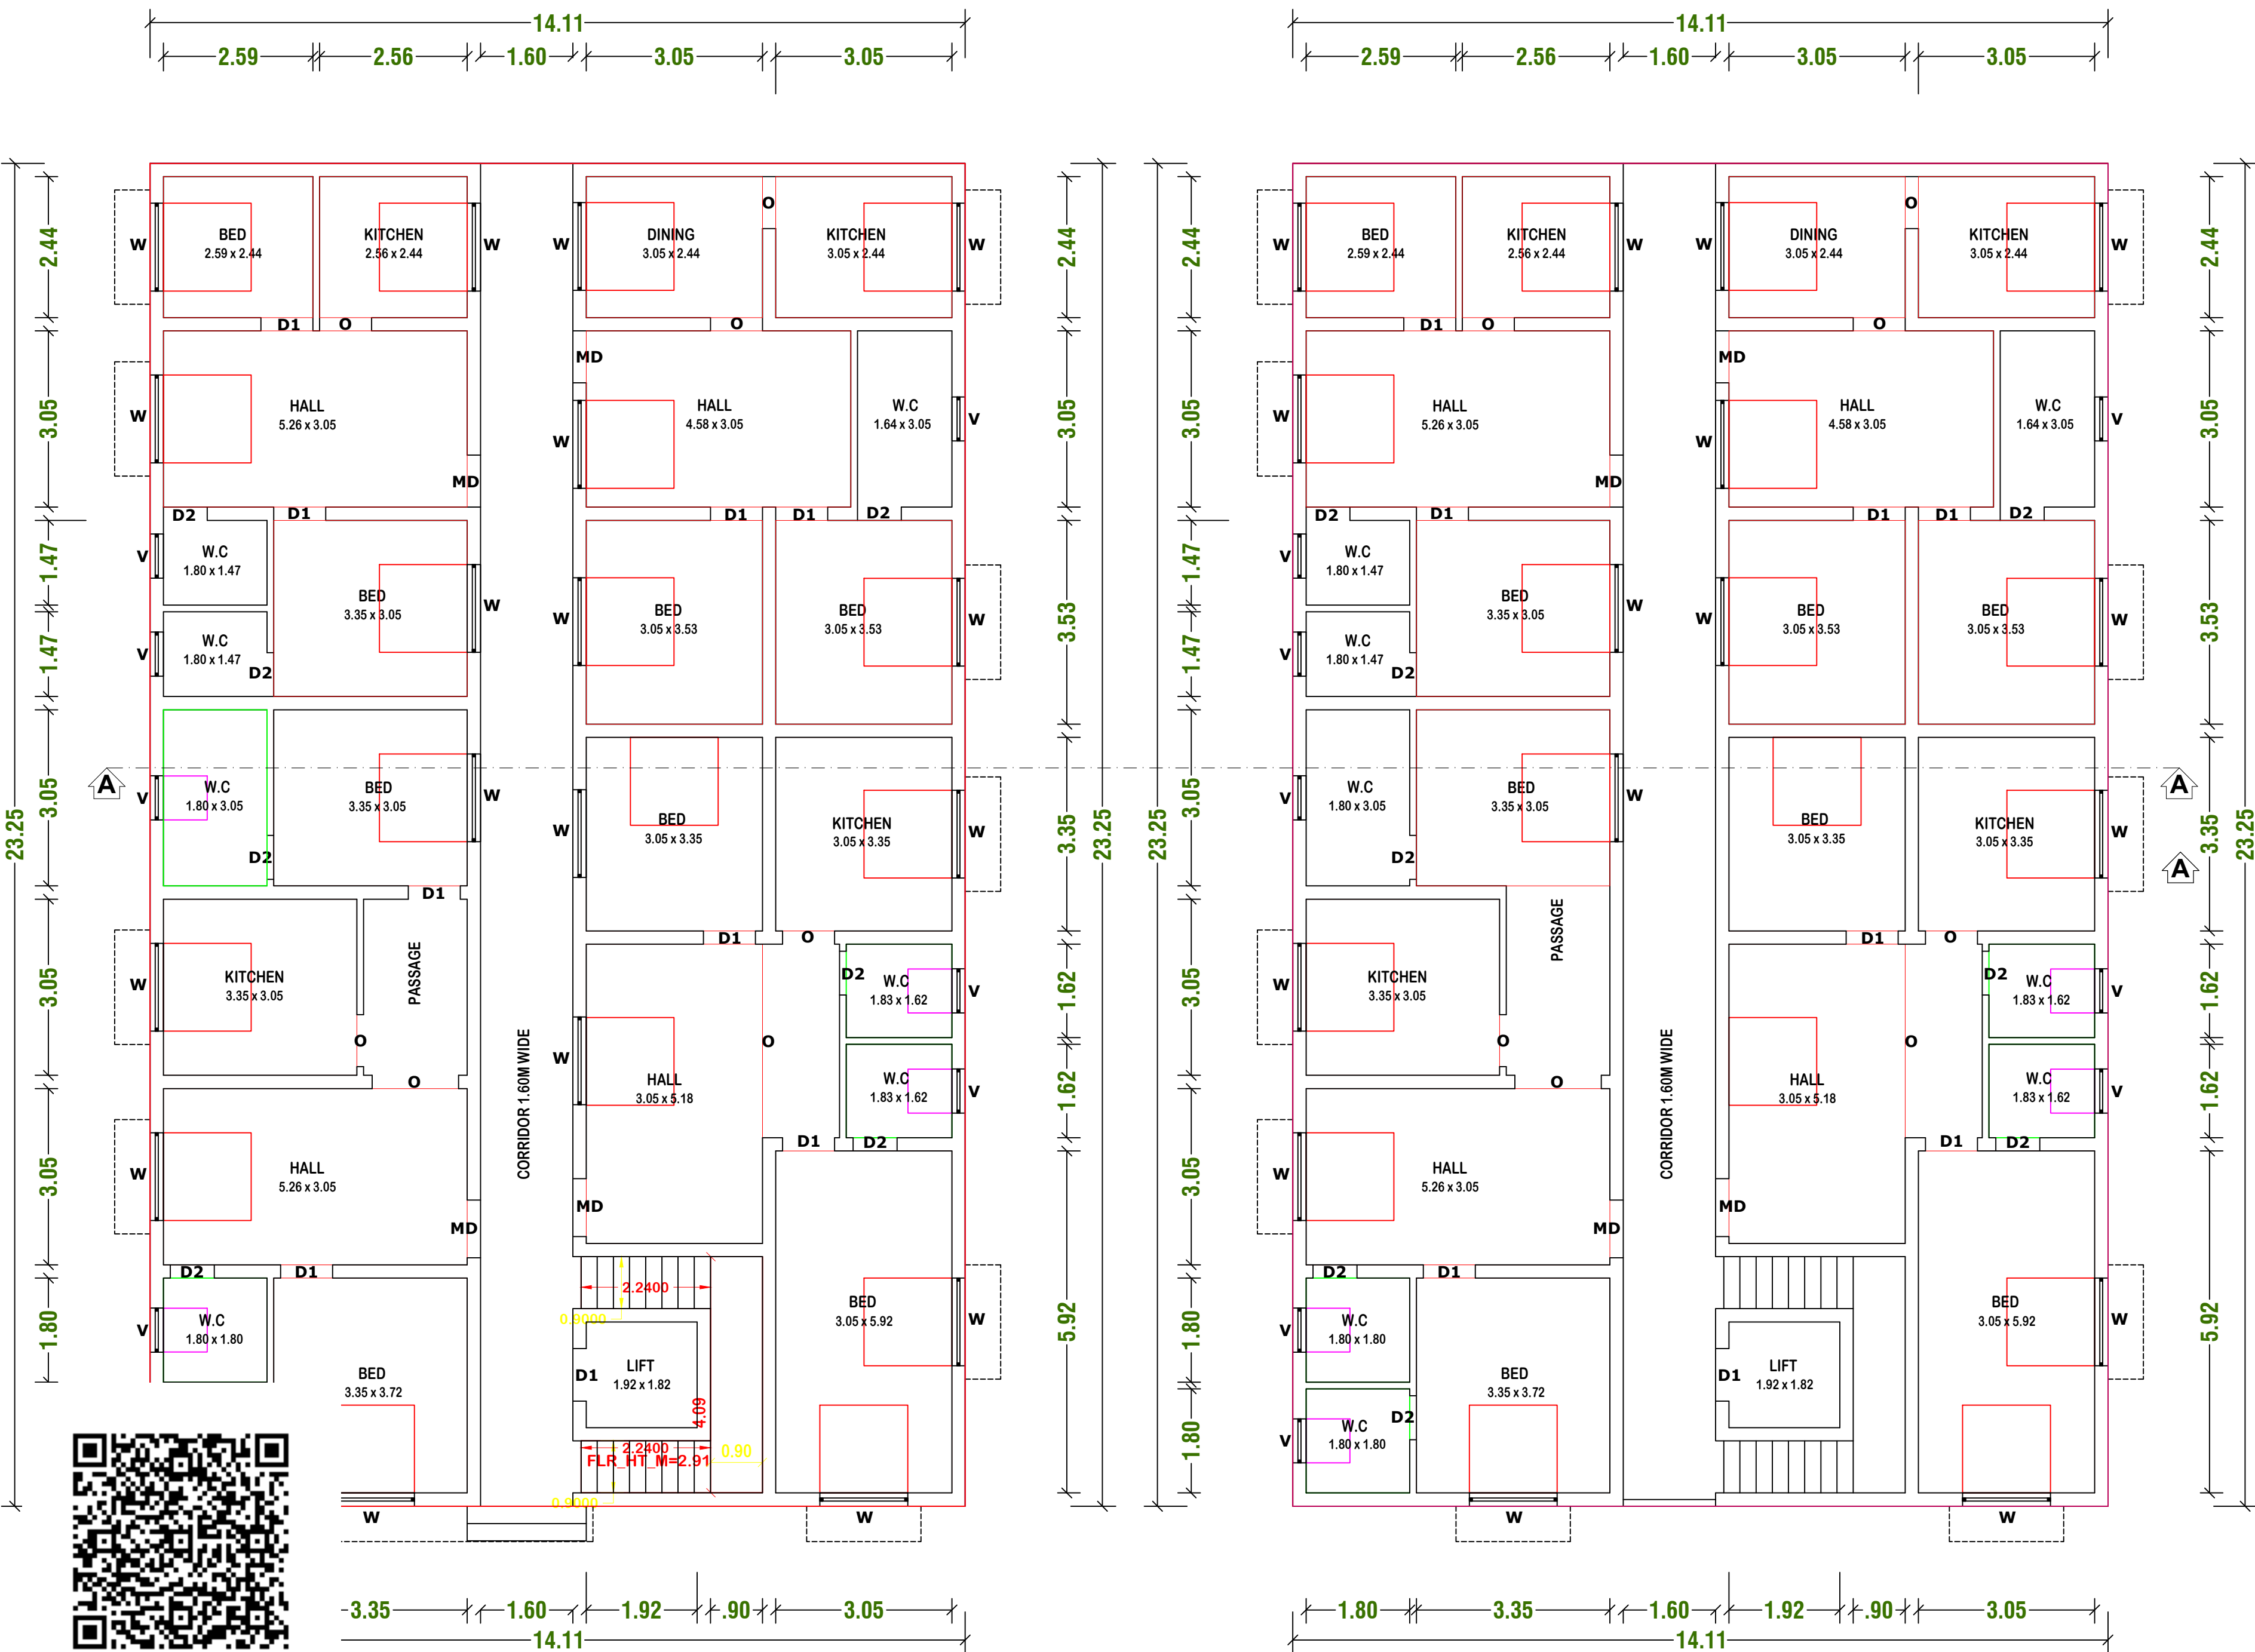


GROUND FLOOR PLAN


FIRST FLOOR PLAN

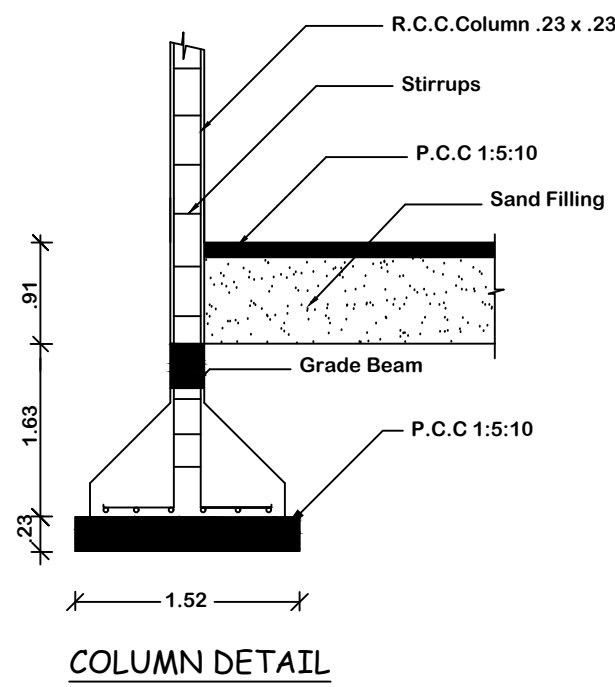


COLUMN DETAIL

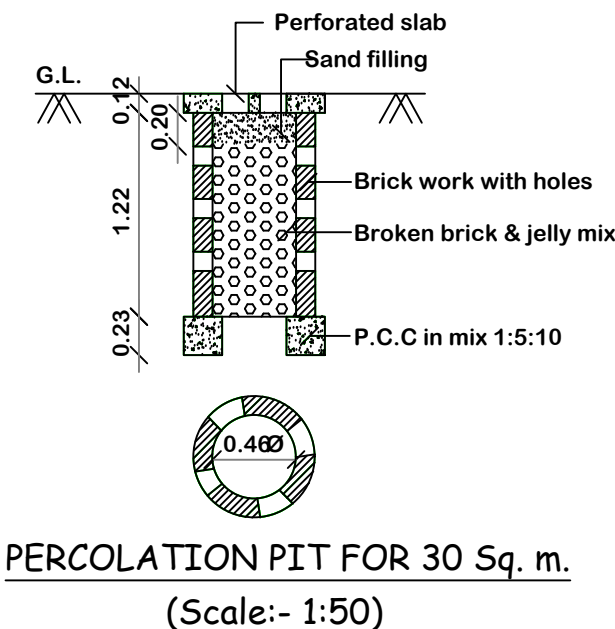

PERCOLATION PIT FOR 30 Sq. m.
(Scale:- 1:50)

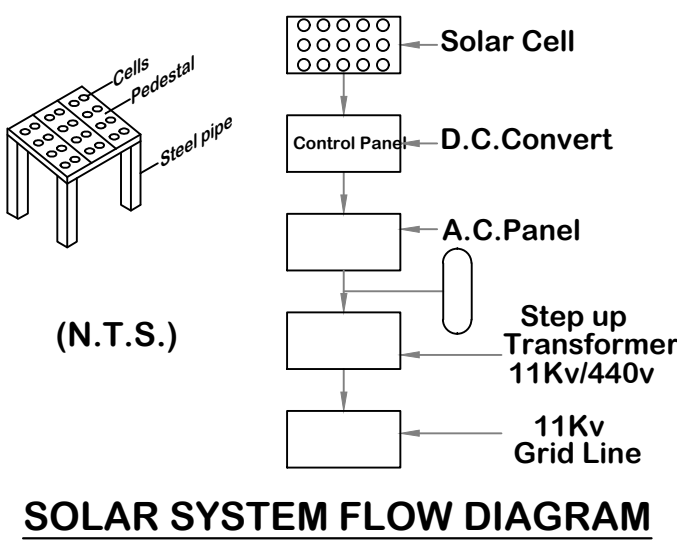

SOLAR SYSTEM FLOW DIAGRAM

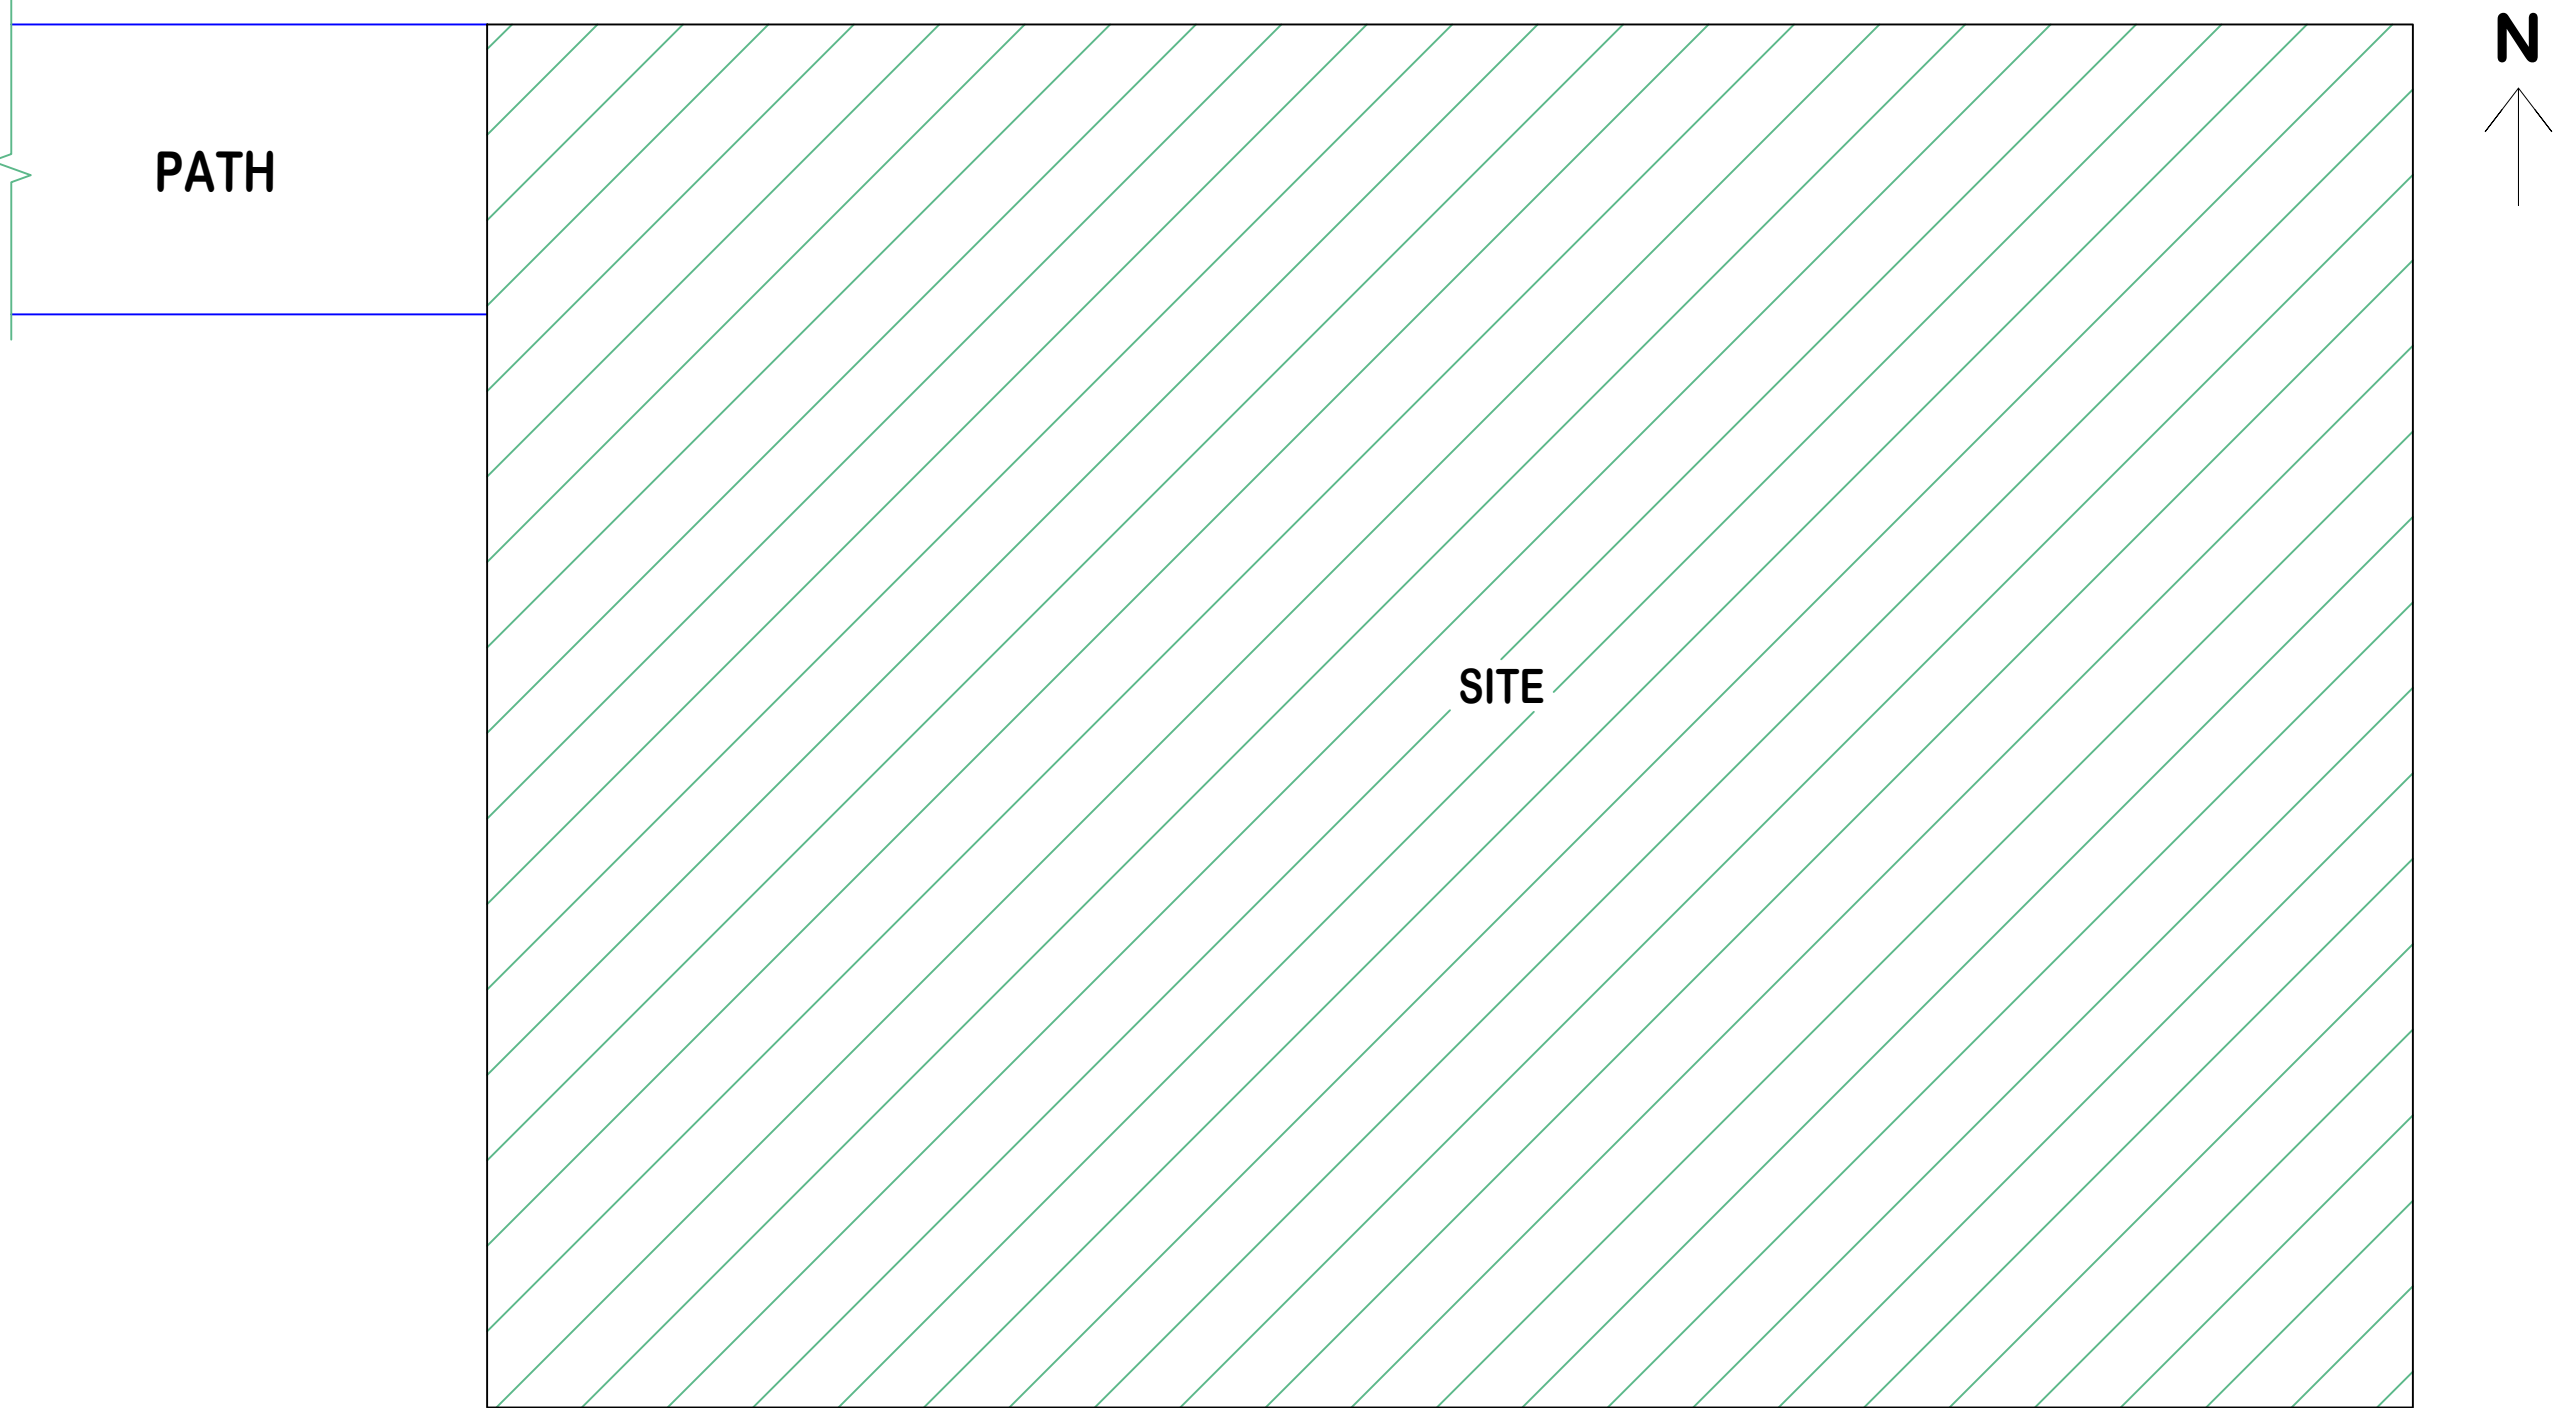

KEY PLAN (N.T.S)

OFFICE USE

Er. V.KAMALANATHAN, B.E.,
Civil Engineer
TP.R.E.No: 0003/2020
6/1400, Middle Street, Prathabaramapuram,
Nagapattinam - 611 111.
Ph: 98655 27762

ENGINEER