
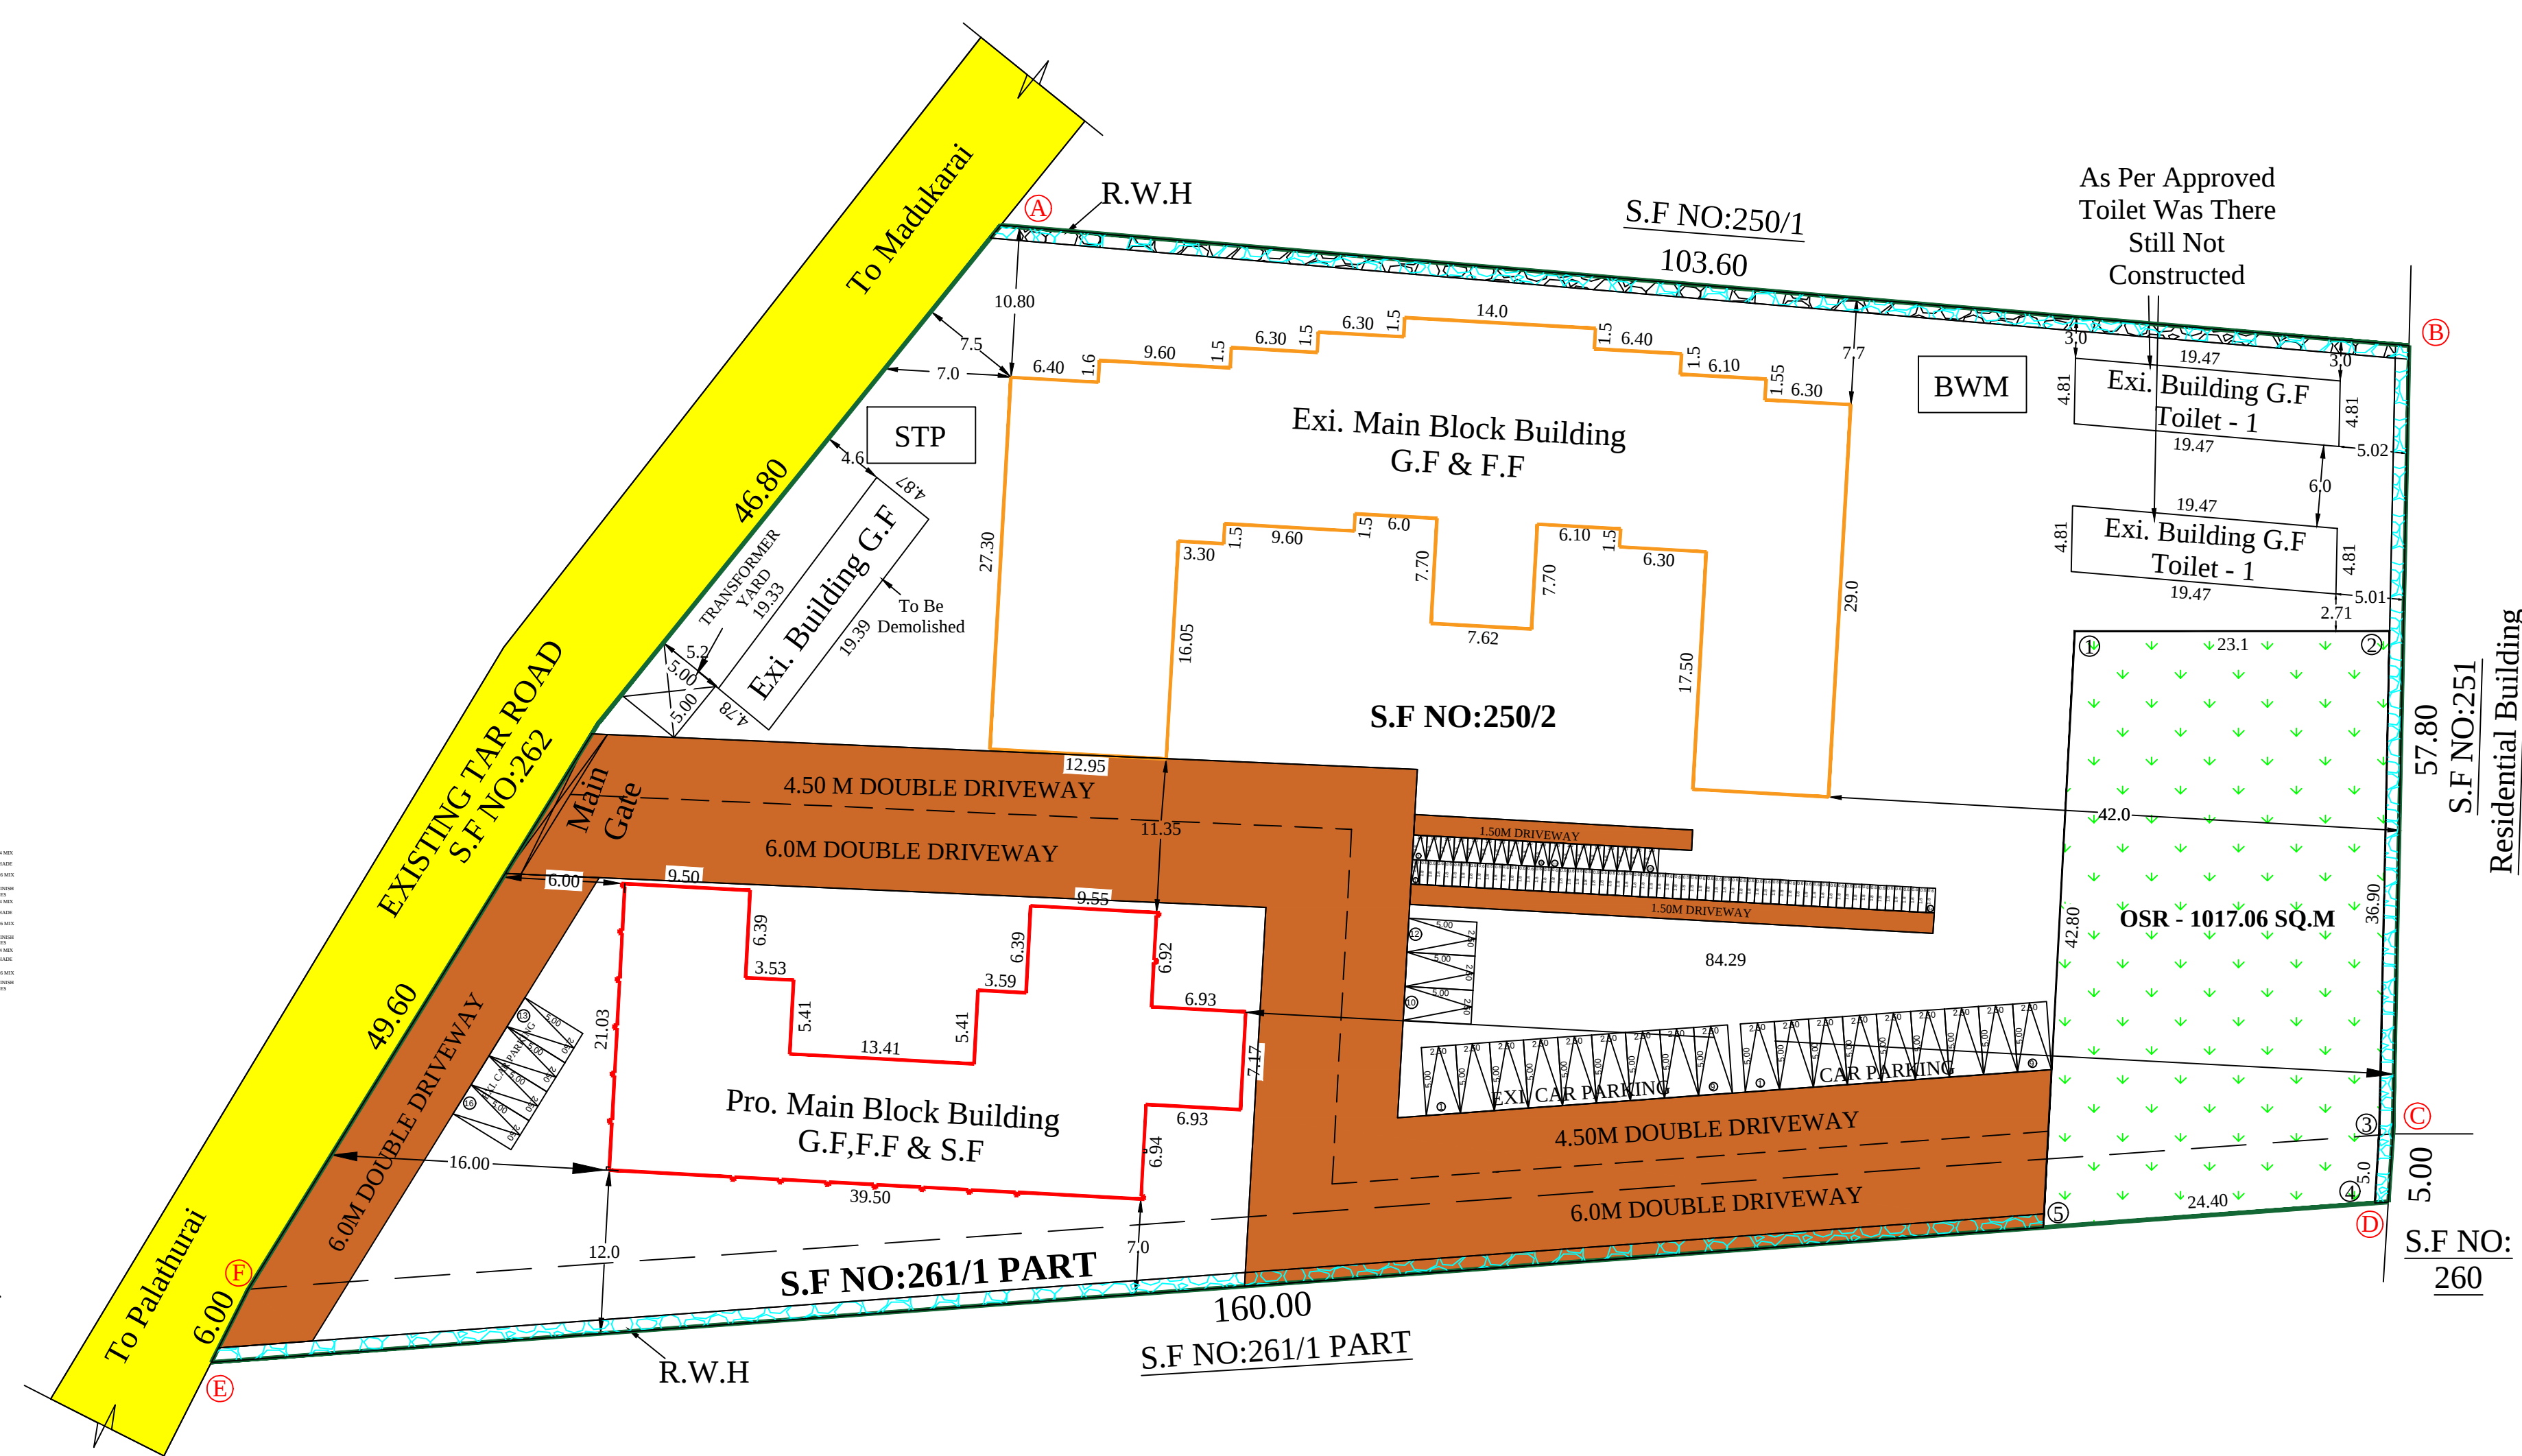


APPLICANT: M/s. KALAIVANI MODEL MATRICULATION SCHOOL.
REPRESENTED BY ITS MANAGING DIRECTOR - Mr.R.KRISHNASWAMY.

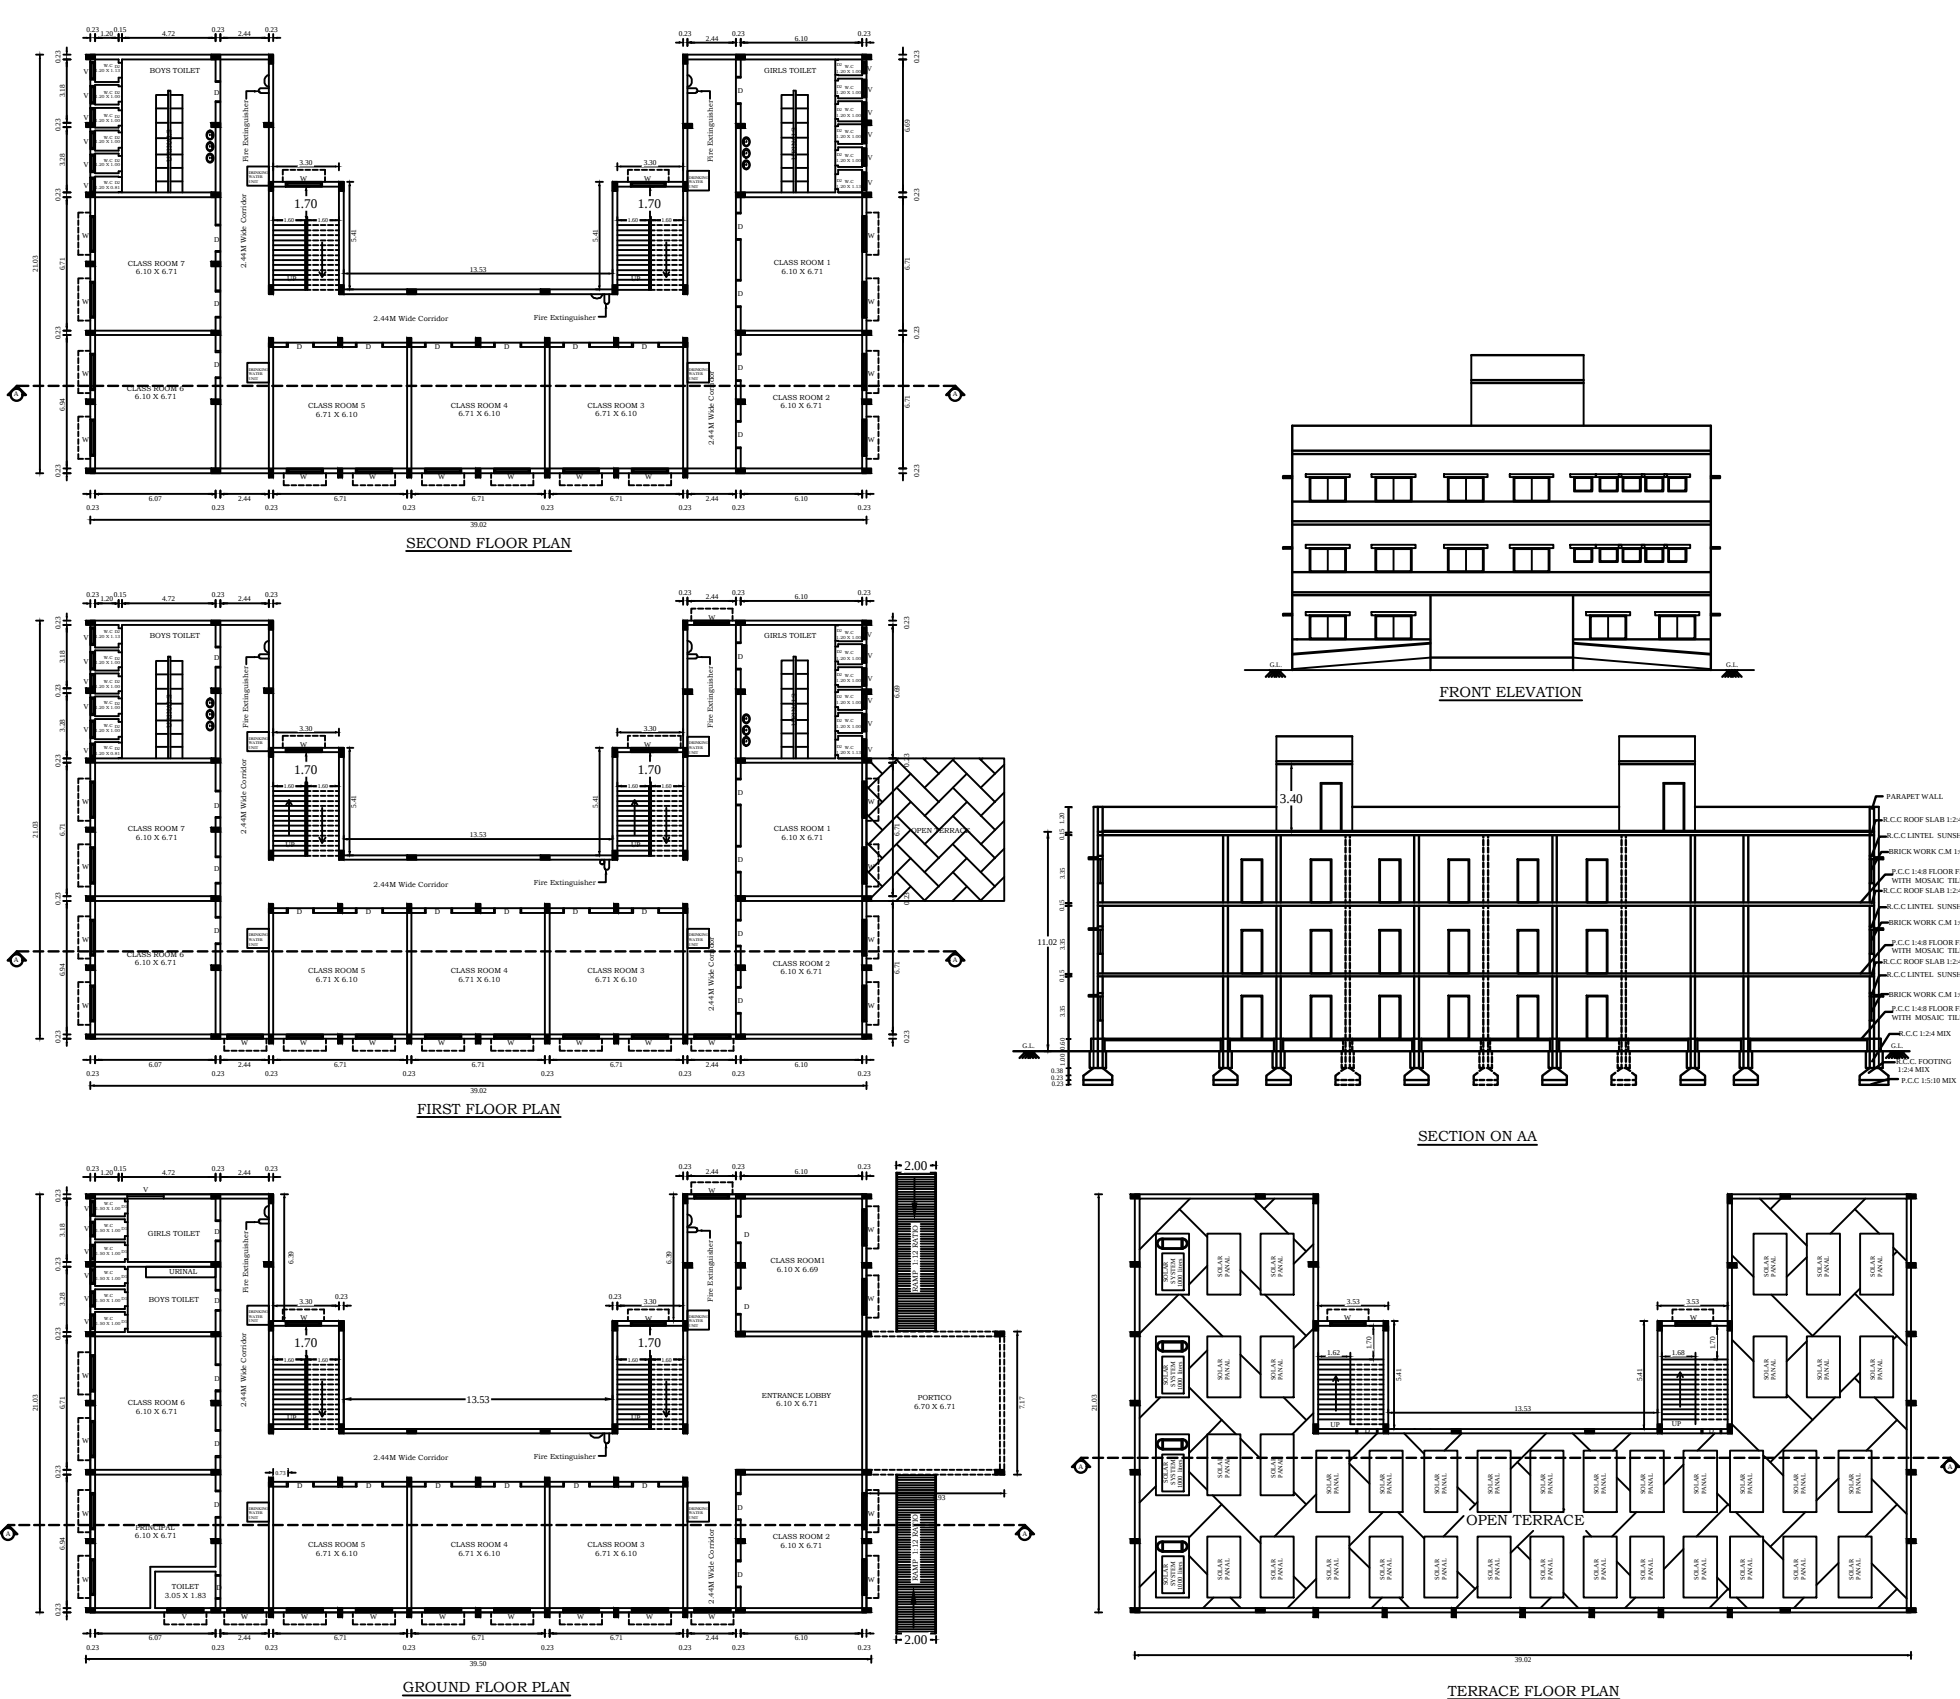

ONLINE APPLICATION NO:SWP/BP/007866/2023

SITE AREA DETAILS


AS PER DOCUMENT = 2.40 Acres.

AS PER PATTA = 9712.46 Sq.m.

AS PER SUPER IMPOSED AREA = 9712.46 Sq.m.


SCALE : 1:100

ALL DIMENSION ARE IN METRE

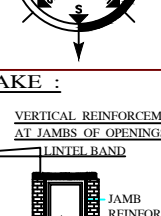

DESCRIPTION	METERS
MD MAIN DOOR	1.83 x 2.13
D1 DOOR	1.22 x 2.13
D1 DOOR	1.20 x 2.13
D2 DOOR	0.80 x 2.13
D3 DOOR	0.75 x 2.13
W WINDOW	2.11 x 1.83
W1 WINDOW	1.50 x 1.83
V VENTILATOR	0.76 x 0.61
V1 VENTILATOR	1.22 x 0.61
D1 TOILET DOOR	0.76 x 2.13

DETAILS OF EARTHQUAKE

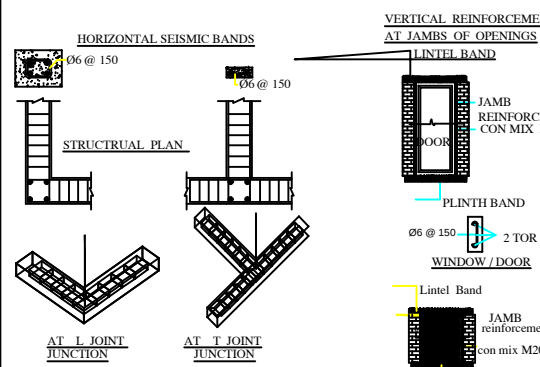

PROPOSED SITE AREA DETAILS

BUILDING AREA DETAILS	FSI (SQ.M)	NON FSI (SQ.M)	TOTAL BUILDUP AREA	AS PER FSI	AS PER PATTA
EXL GROUND FLOOR	1247.87	-----	1247.87	1239.31	
EXL FIRST FLOOR	1190.71	-----	1190.71	1182.64	
NOT CONSTRUCTED					
EXL SECOND FLOOR	1182.64	-----	1182.64	1182.64	
EXL TERRACE FLOOR	-----	42.10	42.10	42.10	
TOILET -1	EXL GROUND FLOOR	93.27	-----	93.27	93.27
TOILET -2	EXL GROUND FLOOR	93.27	-----	93.27	93.27
GRAND TOTAL		2624.82	42.10	3649.56	3833.23


FIRE FIGHTING ARRANGEMENTS:

- FIRE ALARM SYSTEM
- FIRE WATER PIPE
- FIRE FIGHTING EQUIPMENTS
- FIRE HYDRANT


PROPOSED SITE AREA DETAILS

BUILDING AREA DETAILS	FSI (SQ.M)	NON FSI (SQ.M)	TOTAL BUILDUP AREA
PRO. GROUND FLOOR	665.51	-----	665.51
PRO. FIRST FLOOR	615.82	-----	615.82
PRO. SECOND FLOOR	615.82	-----	615.82
PRO. TERRACE FLOOR	-----	38.96	38.96
GRAND TOTAL	1897.15	-----	1936.11

COLUMN POST DETAILS

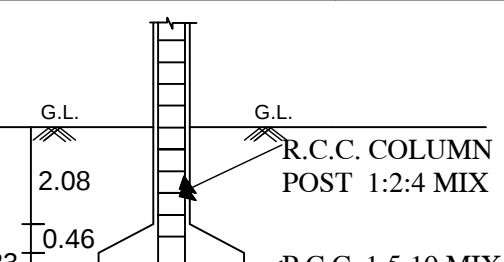

SECTION ON AA

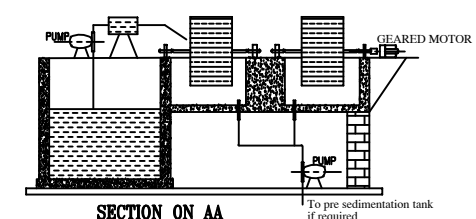


AREA OF SITE

9712.46 = 4.20 < 4.20

OPEN SPACE FOR RESERVATION = 1017.06 Sqm (10.47 %)


STAIRCASE DETAILS
(NOT TO SCALE)

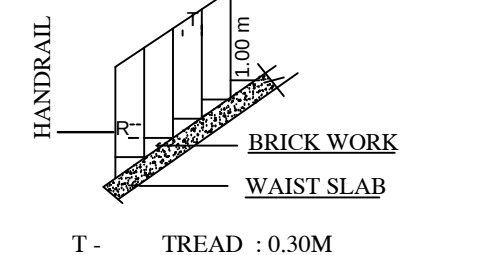

T: TREAD : 0.30M
R: RISE : 0.15 M
W: WIDTH : 1.60 M
LANDING WIDTH : 1.60 M

PLAN

SURFACE TREATMENT AREA DETAILS

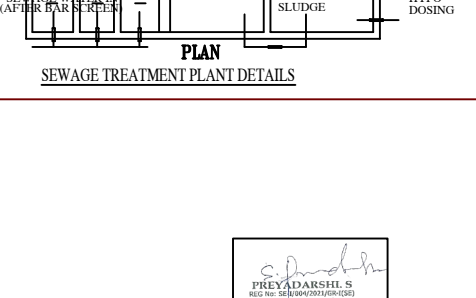


PROPOSED BUILDING PARKING DETAILS

DESCRIPTION	Required	Provided
1 Car Space for every 100 sqm., of Class Room area	16	16

CLASS ROOM 20 NOS = TOTAL 818.498 SQ.M


DESCRIPTION	Required	Provided
1 Car Space for every 100 sqm., of Class Room area	9	9
1 Two Wheeler space for every 50 sqm., of Class Room area	16	18
1 Cycle space for every 10 sqm., of Class Room area	82	84

 REGISTERED STRUCTURAL ENGINEER:



APPLICANT:

 REGISTERED ENGINEER:



EXISTING ROAD

APPLICANT SITE BOUNDARY

EXISTING BUILDING

PROPOSED BUILDING

RAIN WATER HARVESTING

OPEN SPACE RESERVATION

DRIVE WAY

