
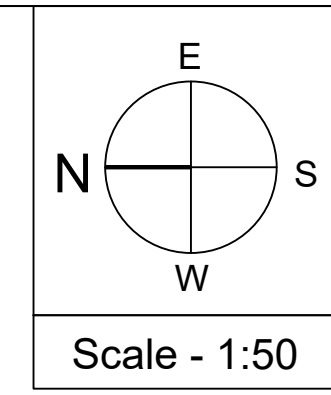
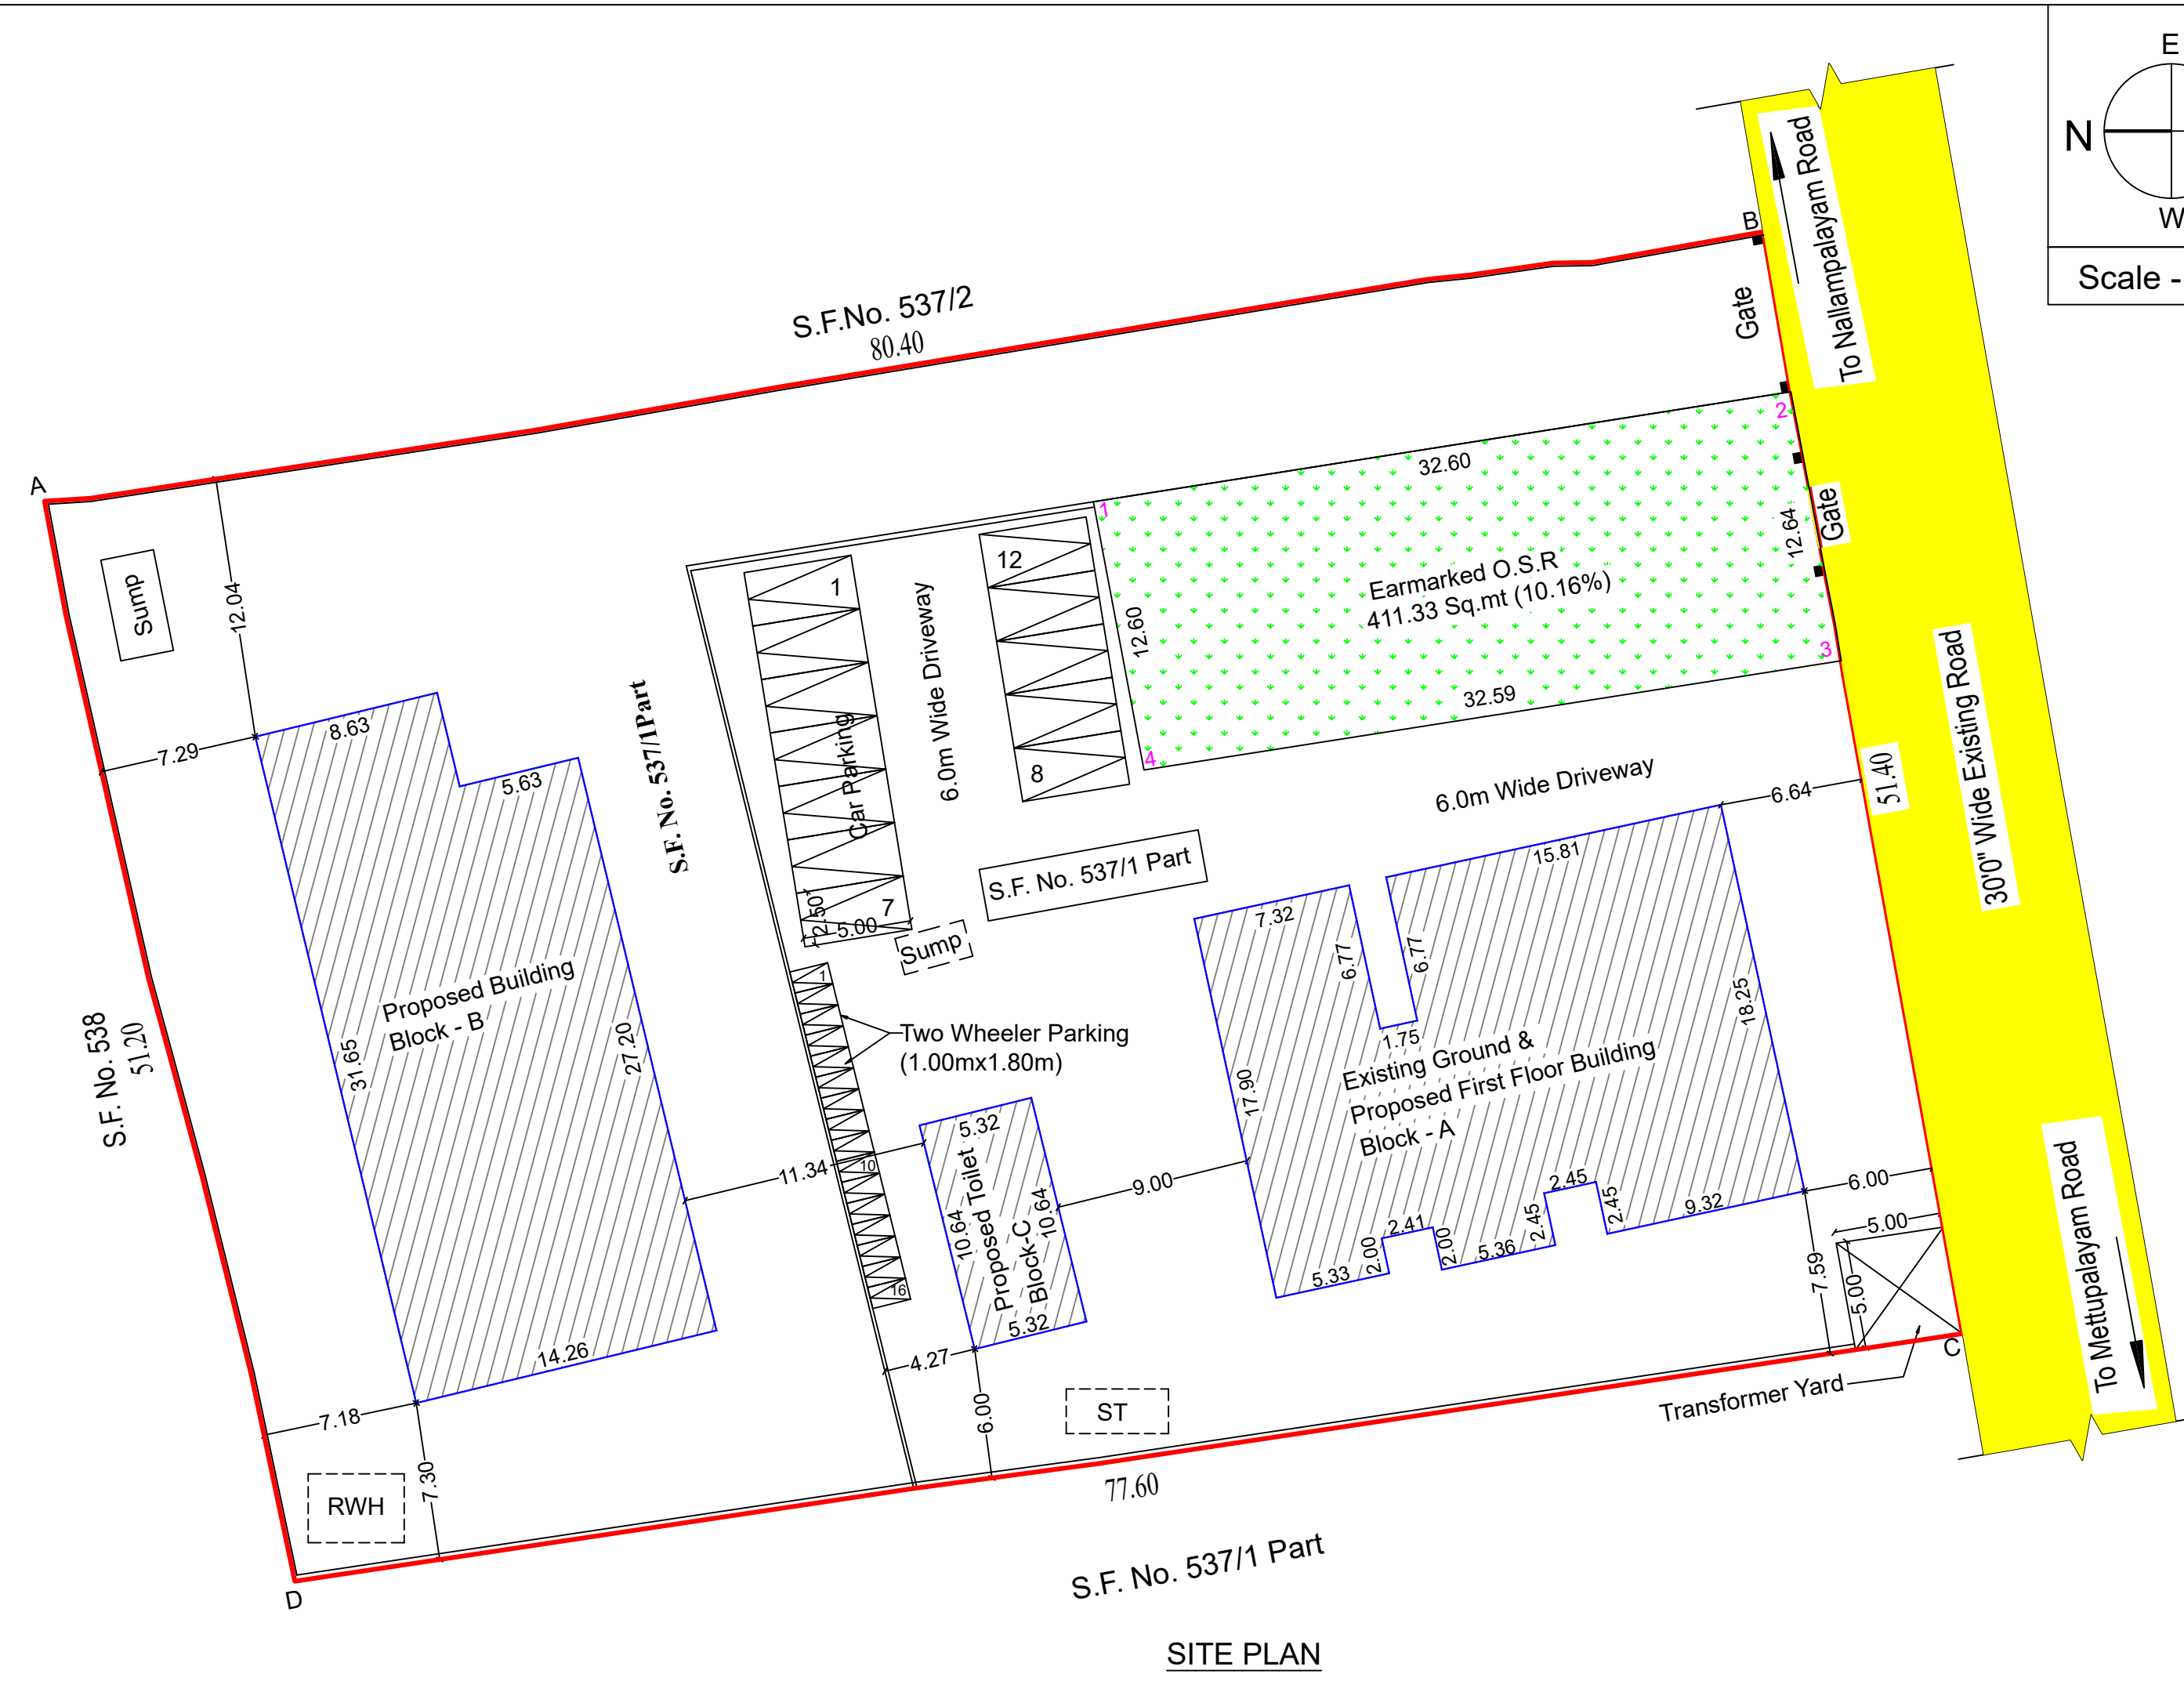
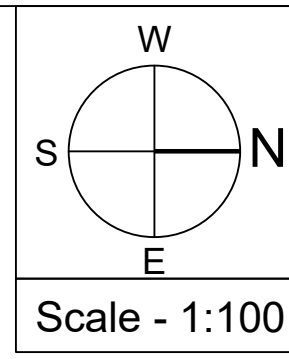
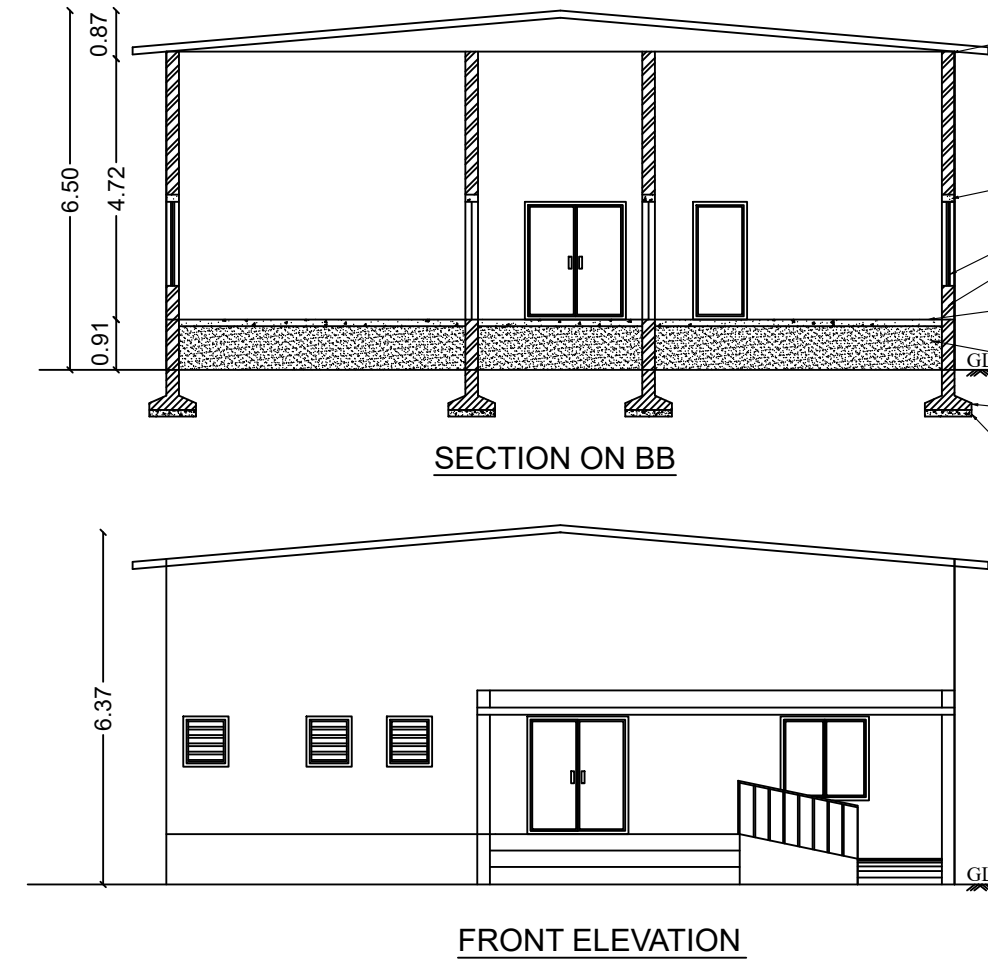


BLOCK - B

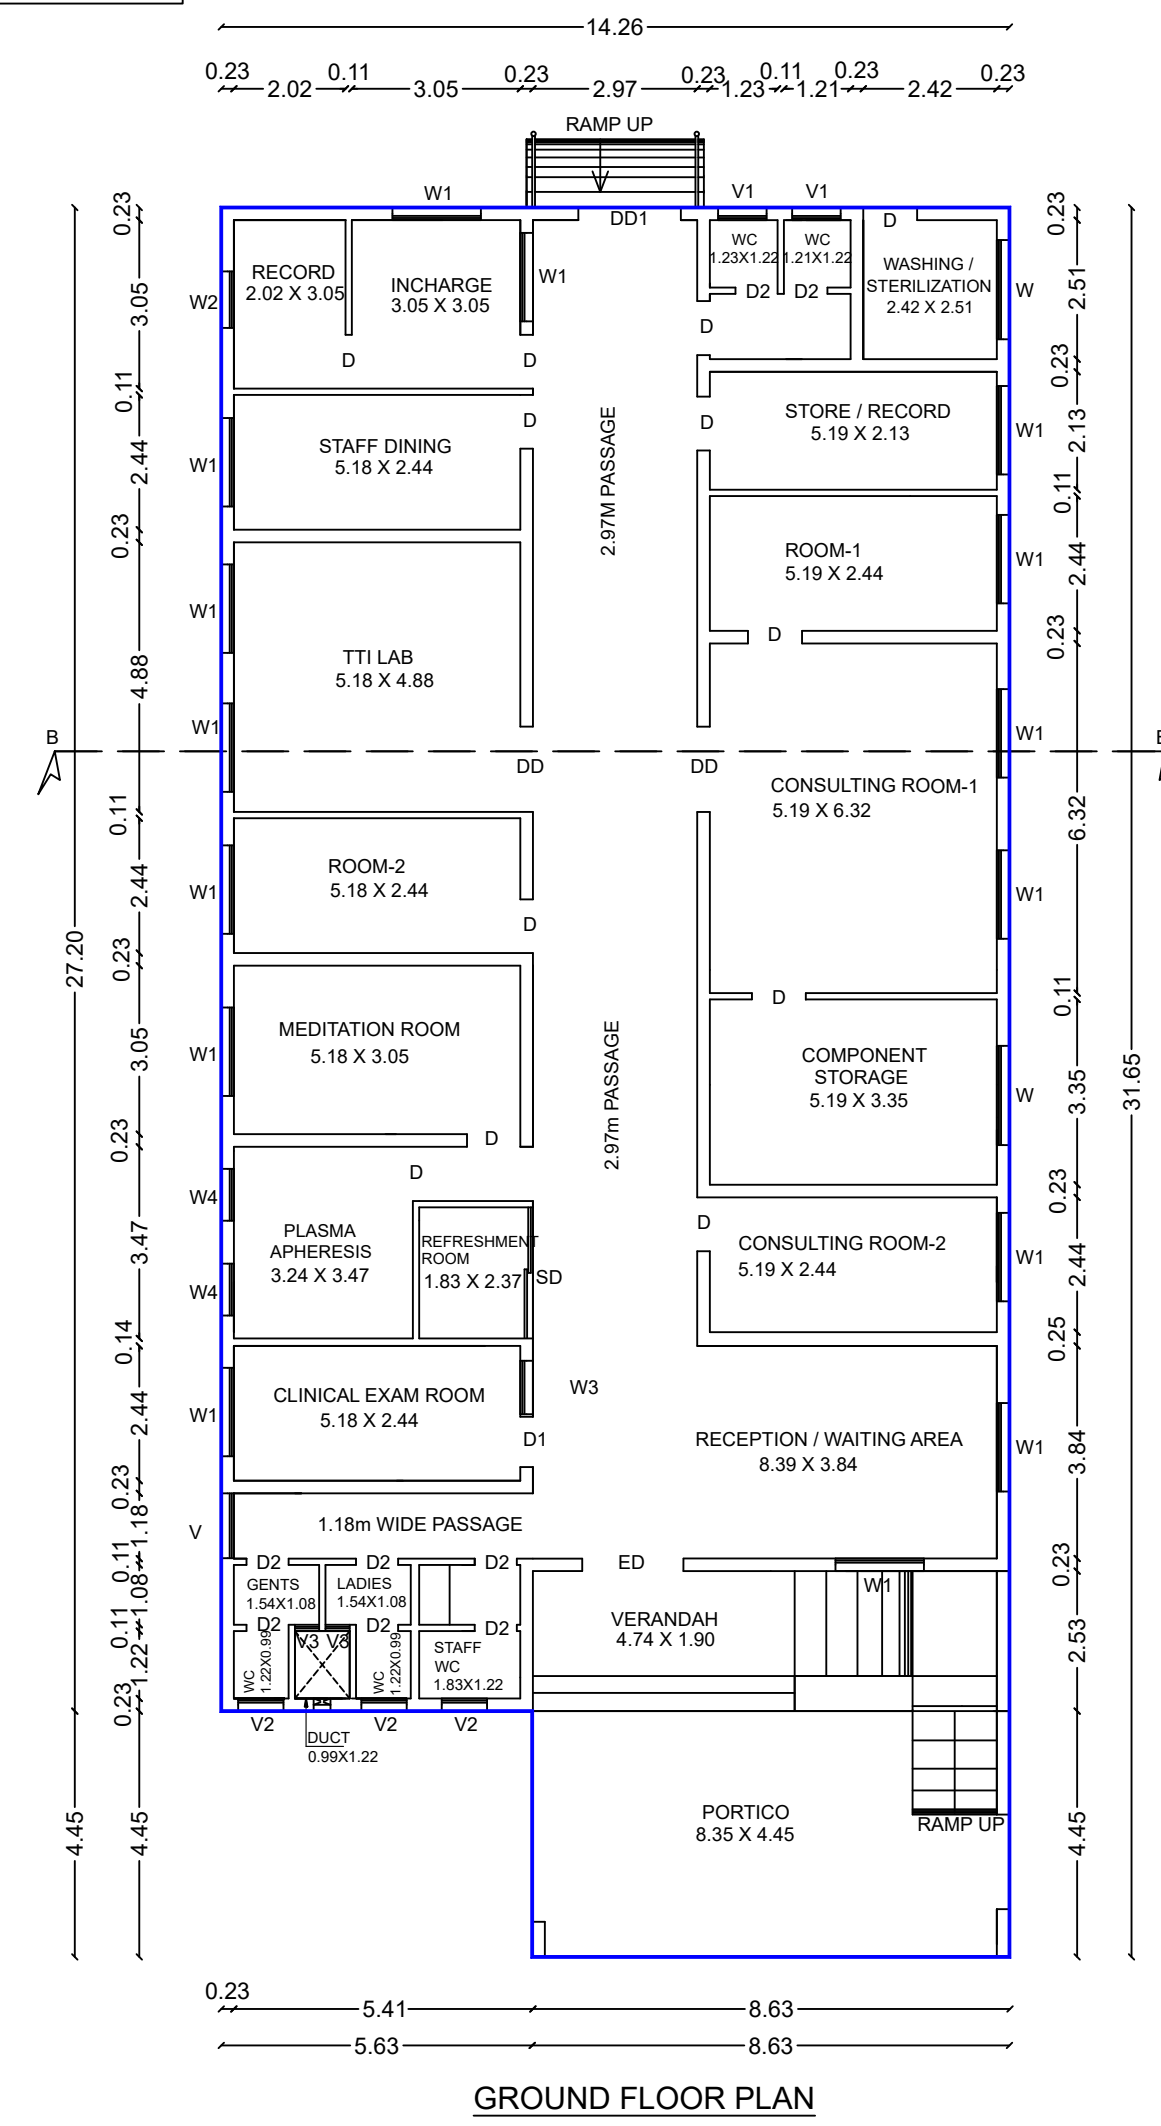

Sheet No.1/1

Site and Detailed Plan Showing the Revised & Additional Proposed Building of Indian Red Cross Society Building for sheltering and re-life training centre in S.F.No:537/1 Part of Sanganoor Village, Coimbatore District and Corporation.

Title:
Site Plan,
Block - A (Ground, First, Terrace Floor Plan, Section & Elevation)
Block - B (Ground Floor Plan, Section & Elevation)
Block - C (Ground Floor Plan, Section & Elevation)

Site Area Details:
Area as Per Document - 4046.82 Sq.mt

Building Area Details in Sq.mt					
Floor Details	F.S.I in Sq.mt		Non F.S.I in Sq.mt		Total Builtup Area
	Existing Approved	Additional Proposed	Existing Approved	Additional Proposed	

Block - A					
Ground	362.83	66.62	-	-	429.45
First	11.48	146.88	-	-	158.36
Terrace	-	-	-	21.07	21.07

Block B					
Ground	-	426.29	-	-	426.29

Block - C					
Ground	-	56.56	-	-	56.56

Total					
	374.31	696.35	--	21.07	1091.73

Parking Details			
S.No	Type of Parking	Required	Provided
1	Car Parking	5	12
2	Two Wheeler	16	10

Note:
Earmarked O.S.R Area - 407.24 Sq.mt
Proposed Earmarked O.S.R Area - 4.09 Sq.mt

PC and FSI Calculation:
Plot Coverage = $(912.30 / 4046.82) \times 100$
= 22.54%
Floor Space Index = $1070.66 / 4046.82$
= 0.265

இணையதள விண்ணப்பம் எண் : SWP/BPA/046724/2023
திட்ட அனுமதி எண் : 632/2023 (இணைய வழி ஒப்புதல்)
திட்ட அனுமதி எண் : 158/2013 (திருத்தி அமைக்கப்பட்டது)
மப / கோ.உ.திரு.எண் : 134/2013

கி.கௌதுமி
அளவளர் / உதவி வரைவாளர்

பாலமுருகன்
வரைவாளர் நிலை -3

for INDIAN RED CROSS SOCIETY

Chairperson

Applicant



M.BALASUBRAMANIAM, MSc, M.Tech, CEng,
Registered Engineer Grade-I (RE)
COLLECTOR'S PANEL ENGINEER CLASS-1A
LPA / RE / CSE - 1 / 19/06/085
103, 84-A, Sarojini Complex,
Senkadu, Kattoor Street,
Near by Women's Polytechnic College,
P.N.Palayam, Coimbatore - 641 037.
Mobile No: 98432 65083

Registered Engineer

M.BALASUBRAMANIAM, MSc, M.Tech, CEng,
Registered Engineer Grade-I (RE)
COLLECTOR'S PANEL ENGINEER CLASS-1A
LPA / SE / GR-II / 19/04/015
103, 84-A, Sarojini Complex,
Senkadu, Kattoor Street,
Near by Women's Polytechnic College,
P.N.Palayam, Coimbatore - 641 037.
Mobile No: 98432 65083

Registered Structural Engineer

BLOCK - A

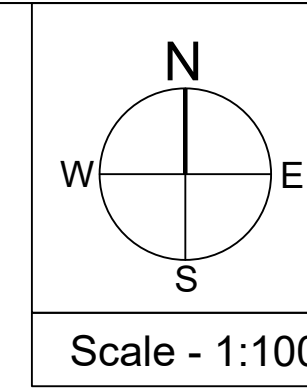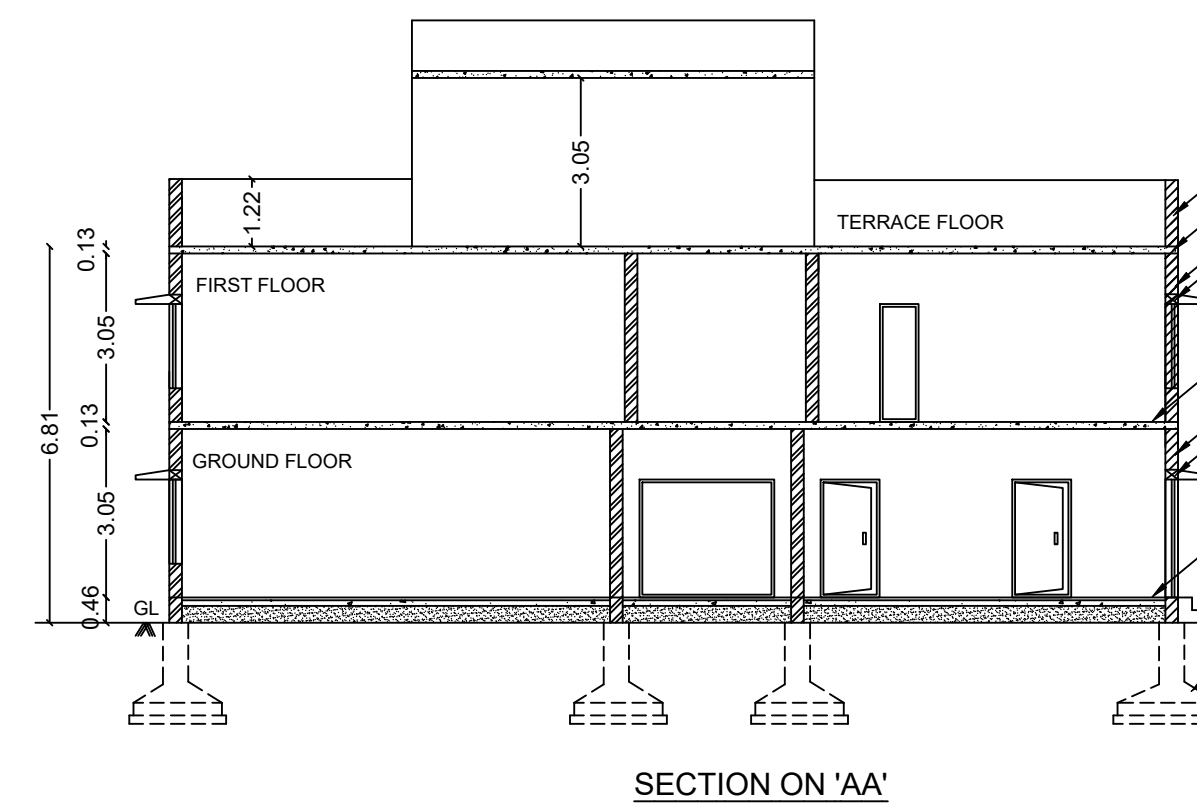

BLOCK - C

