



PLAN SHOWING THE PROPOSED CONSTRUCTION OF RCC ROOF RESIDENTIAL GROUND FLOOR, FIRST FLOOR AND SECOND FLOOR BUILDING IN S.F.NO: 260/16A1 IN GOLDEN NAGAR AT ANNAVASAL TOWN PANCHAYAT IN ILLUPPUR TALUK OF PUDUKKOTTAI DISTRICT.

SCALE 1:100


NAME OF THE OWNER: Mr. Rasu S/o Thirumalai,

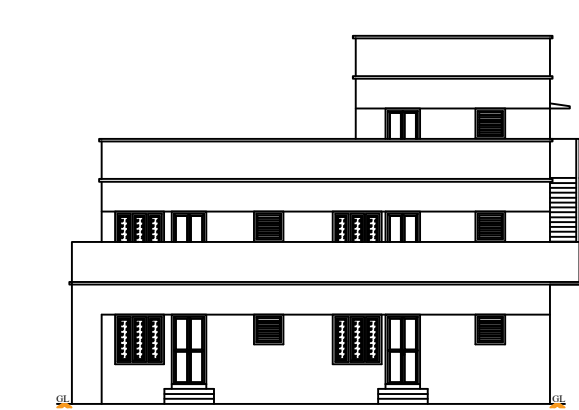


ELEVATION

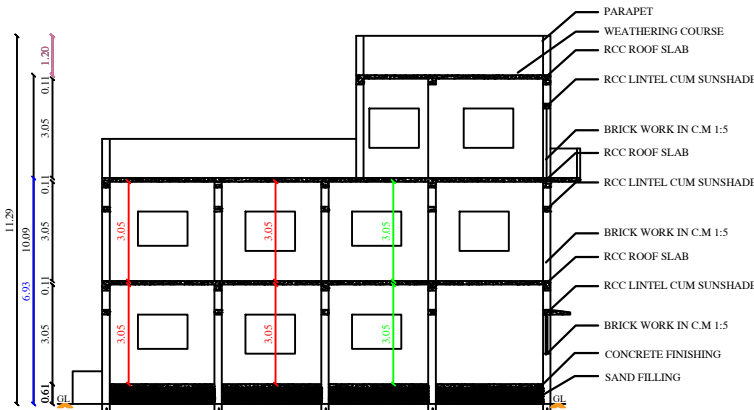


SECTION ON AB

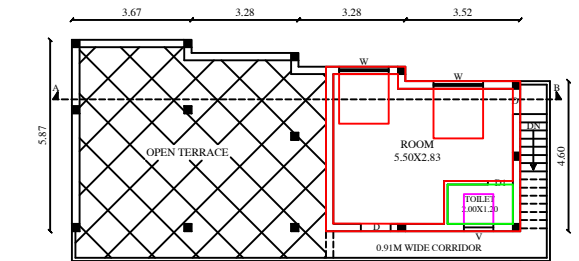


PRO. SECOND FLOOR PLAN

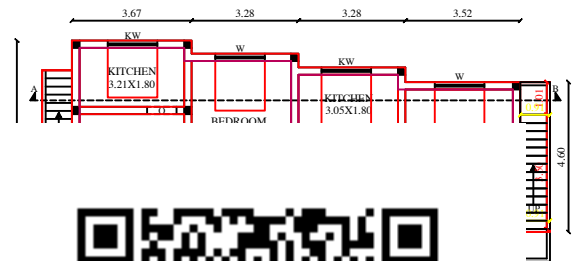


PRO. GROUND FLOOR PLAN

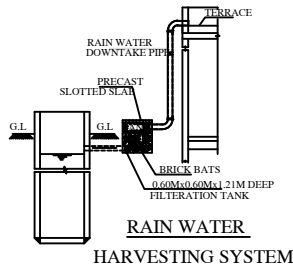


RAIN WATER HARVESTING SYSTEM

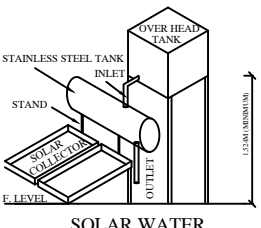


SOLAR WATER HEATING SYSTEM

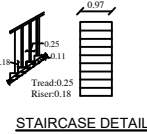


STAIRCASE DETAIL

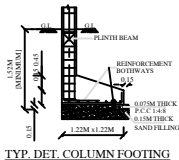


TYP. DET. COLUMN FOOTING

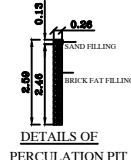

DETAILS OF PERCOLATION PIT

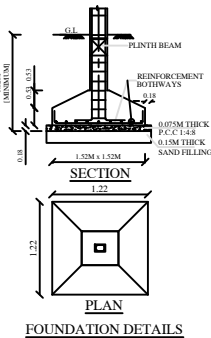


FOUNDATION DETAILS

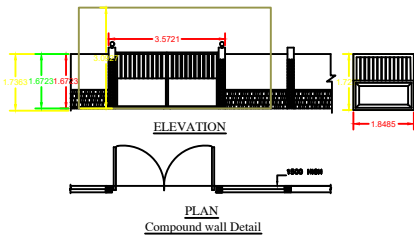

Compound wall Detail

SITE PLAN:

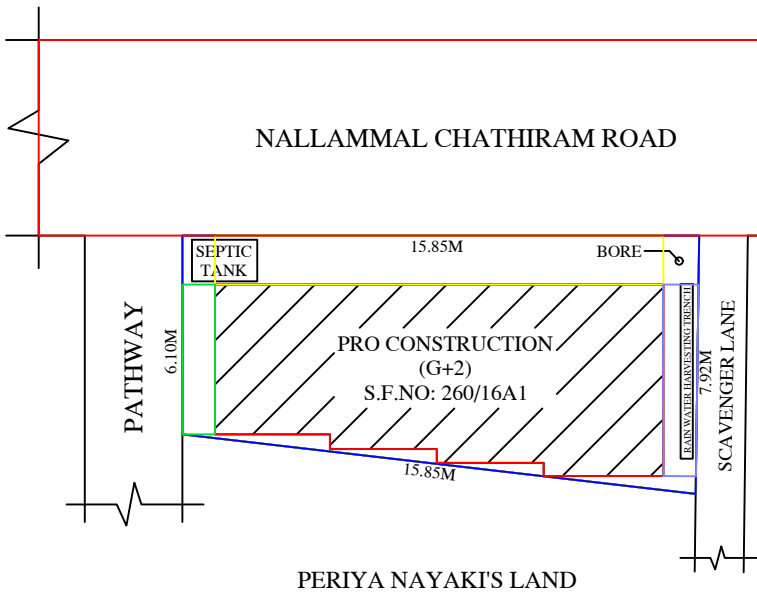

AREA STATEMENT	Sq.ft	Sq.mt
SITE AREA	1196.00	111.11
PRO. GROUND FLOOR AREA	1092.00	101.45
PRO. FIRST FLOOR AREA	1092.00	101.45
PRO. SECOND FLOOR AREA	306.00	28.47
VACANT AREA	104.00	9.66

SCHEDULE OF JOINERIES:

MD -DOOR	-	3'6" X 7'0"	OR	1.06 X 2.13M
D-DOOR	-	3'0" X 7'0"	OR	0.91 X 2.13
D1-DOOR	-	2'6" X 7'0"	OR	0.76 X 2.13
W-WINDOW	-	5'0" X 4'0"	OR	1.52 X 1.22
W1-WINDOW	-	3'0" X 4'0"	OR	0.91 X 1.22
KW-WINDOW	-	4'0" X 4'6"	OR	1.22 X 1.37
V-VENTILATOR	-	3'0" X 3'0"	OR	0.91 X 0.91

REFERENCE

- ALL DIMENSIONS ARE IN METER
- WASTE WATER COLLECT TO SOAKPIT
- SOLAR WATER HEATER SYSTEM TO BE PROVIDED
- RAIN WATER HARVESTING SYSTEM TO BE PROVIDED
- "U" TRAP SEPTIC TANK DESIGN TO BE PROVIDED

T. Rasu


Owner Signature

Er.M.SANJAI GANDHI,B.E.
Registered Engineer Grade-II,
DTCP-Pudukkottai/RE/GR-II/24/08/021
SRI MARIAMMAL CONSTRUCTIONS
Annavasal - 622 101
Pudukkottai District.
Cell: 9942260303, 7010480612


Registered Engineer Signature

Drawn by:-

Er.M. Sanjaigandhi, B.E.,
Sri Mariammal Constructions
85C, Mettu Street
Annavasal - 622101
Cell: 9942260303

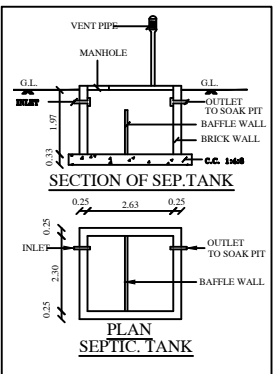

PLAN SEPTIC TANK

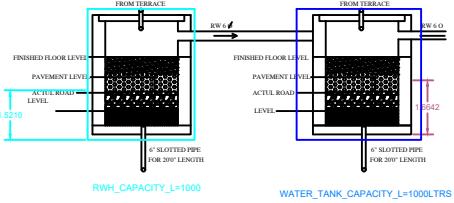

RWH_CAPACITY_L=1000

WATER_TANK_CAPACITY_L=1000LTRS