



PLAN SHOWING THE PROPOSED GROUND FLOOR & FIRST FLOOR CONSTRUCTION OF R.C.C ROOF COMMERCIAL & RESIDENTIAL BUILDING IN R.S.NO:221/1B ,PATTA NO: 3351 , WARD NO:07 AT PATTUKKOTTAI -ARANTHANGI ROAD ,KEERAMANGALAM NORTH KEERAMANGALAM TOWN PANCHAYAT ,ALANGUDI - TALUK ,PUDUKKOTTAI- DISTRICT.


OWNER NAME: Mrs.V.PRAGATHAMBAL , W/O.VIJAYAKUMARAN.

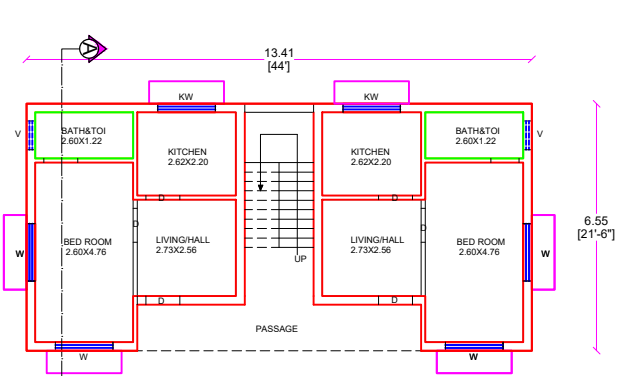


FIRST FLOOR PLAN

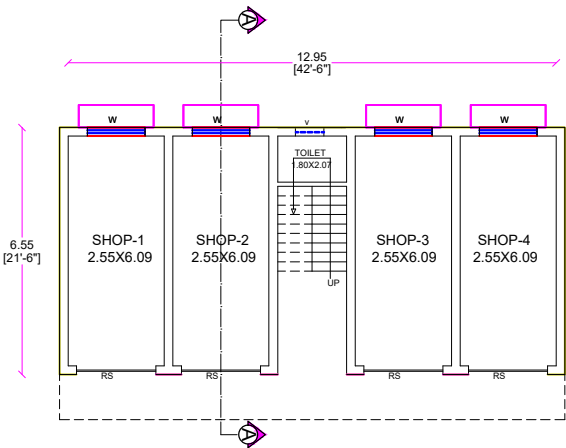

GROUND FLOOR PLAN




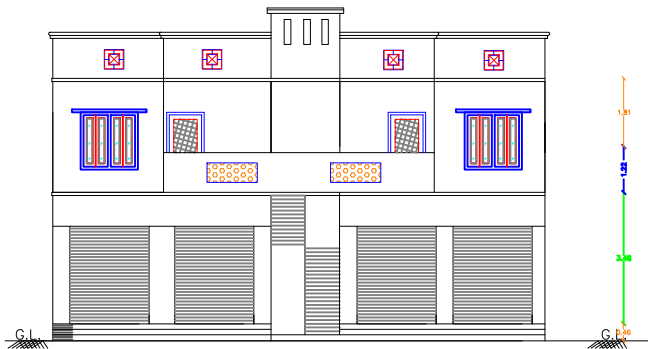


FRONT ELEVATION

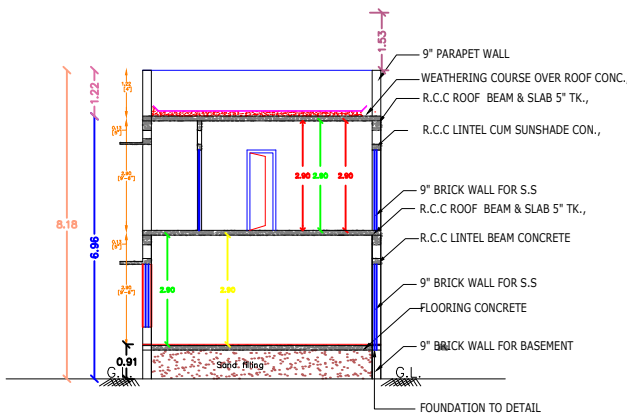


SECTION ON 'A-A'

KEY PLAN
SCALE:1"=132'0"

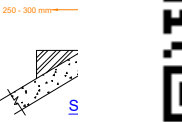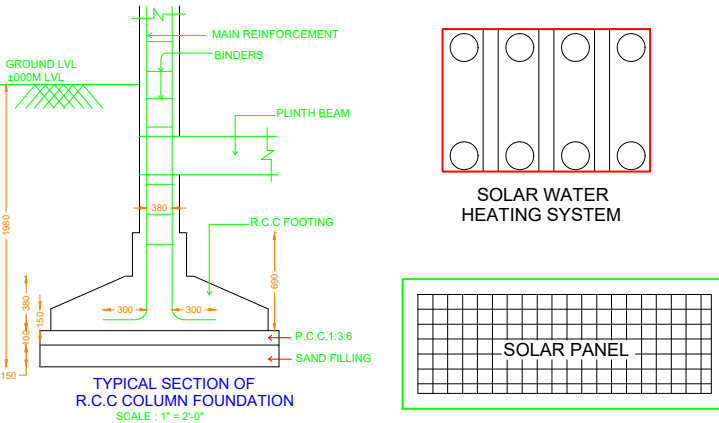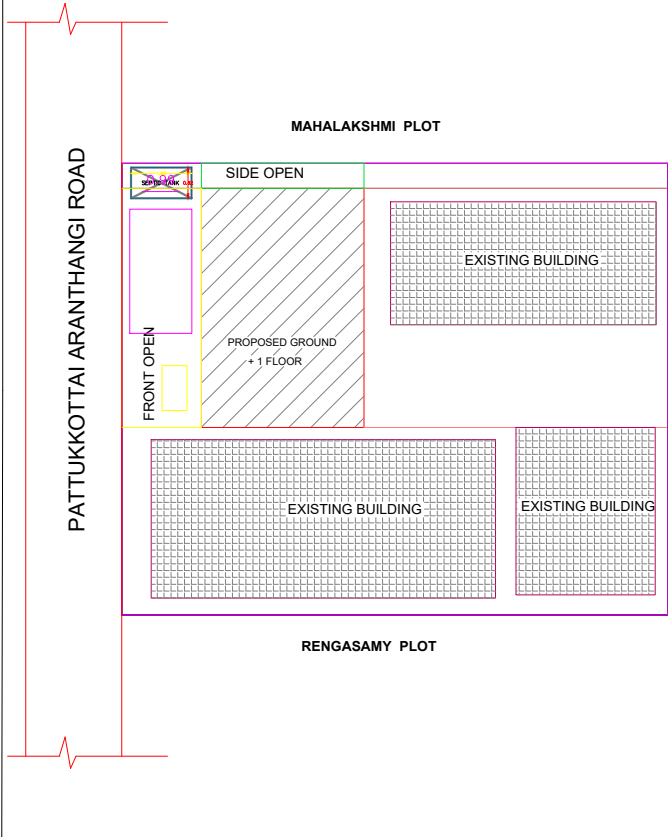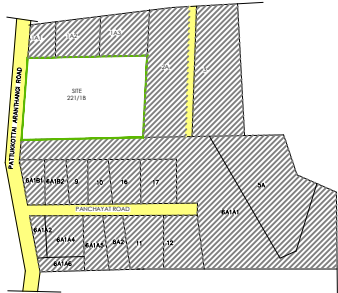


DWARF WALL SECTION
NOT TO SCALE


EXIT MAIN GATE ELEVATION

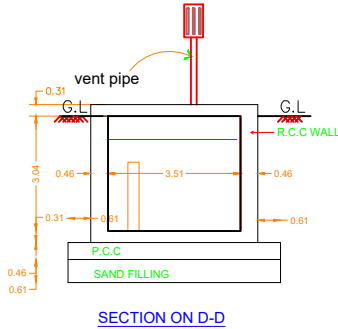

SECTION ON D-D

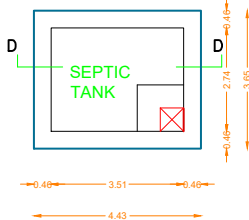

PLAN OF SEPTIC TANK

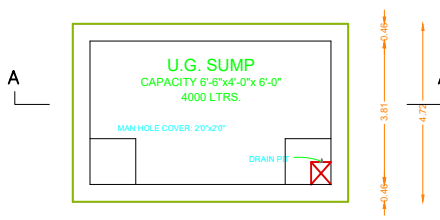

SUMP DETAIL
SCALE: 1"=4'0"

SHEET NO=01
COLOUR INDEX:

BOUNDARY - PROPOSED - ROAD -

JOINERY DETAILS :-

S.No.	Description	Feet	Meter	S.No.	Description	Feet	Meter
01	MD - MAIN DOOR	3'3" X 7'0"	1.00 X 2.13	05	W1 - WINDOW	4'0" X 4'6"	1.22 X 1.37
02	D - DOOR	3'0" X 7'0"	0.91 X 2.13	06	W2 - WINDOW	3'0" X 4'6"	0.91 X 1.37
03	D1 - DOOR	2'6" X 7'0"	0.76 X 2.13	07	KW - WINDOW	5'0" X 4'6"	1.52 X 1.37
04	RS - ROLLING SHUTTER	2'40 X 2.13	0.76 X 0.76	08	V - VENTILATOR	2'6" X 2'6"	0.76 X 0.76

--- SPECIFICATION ---

AREA DETAILS :-	In Sq.m	In Sq.ft
AS PER DOC	1550.00	16684.06
AS PER PATTA	1550.00	16684.06
AS PER DWG./SPLAY	1550.00	16684.06

--- AREA CALCULATION ---

FLOOR AREA	F.S.I AREA		NON-F.S.I AREA		TOTAL AREA	
	in Sq.m	in Sq.ft	in Sq.m	in Sq.ft	in Sq.m	in Sq.ft
GROUND FLOOR (COMMERCIAL)	87.84	945.50	---	---	87.84	945.50
FIRST FLOOR (RESIDENTIAL)	87.84	945.50	---	---	87.84	945.50
EXISTING BUILDING AREA	1295.00	13939.26	---	---	1295.00	13939.26
PROPOSED TOTAL AREA	175.68	1891.00	---	---	175.68	1891.00
VACCANT AREA	167.16	1799.29	---	---	167.16	1799.29

DWELLING AREA STATEMENT				
FLOORS	NO OF DWELLING UNITS	TYPES		
		A1	B1	
GROUND FLOOR	-	-	-	
FIRST FLOOR	02	05.76	05.76	

--- PARKING DETAILS ---

PARKING TYPE	REQUIRED	PROVIDED
CAR	01	01
TWO WHEELER	01	01

HEIGHT OF THE BUILDING : 6.96 M SCALE - 1 : 100

*All dimensions are in feet & inches,those with in brackets are in M.
*Sewage line connected to Septic Tank - main line

V. Piragathambal

(Mr.PRAGATHAMBAL.V)
APPLICANT / OWNER

Er.K.R.SUMITHRA,B.E.,
Registered Engineer (RE),
Register No: RE725/01/006.
KR BUILDERS & PLANNERS
Gandhiji Road,
Keeramangalam - 614 624.
Mob: 9092877431

REGISTERED ENGINEER

